


District Office Copy

DEPARTMENT OF PUBLIC WORKS
CITY & COUNTY OF HONOLULU

DIVISION OF ENGINEERING
JOB NO. 35 - 68R

WIDENING OF ALA MOANA BRIDGE OVER ALA WAI CANAL HONOLULU, HAWAII

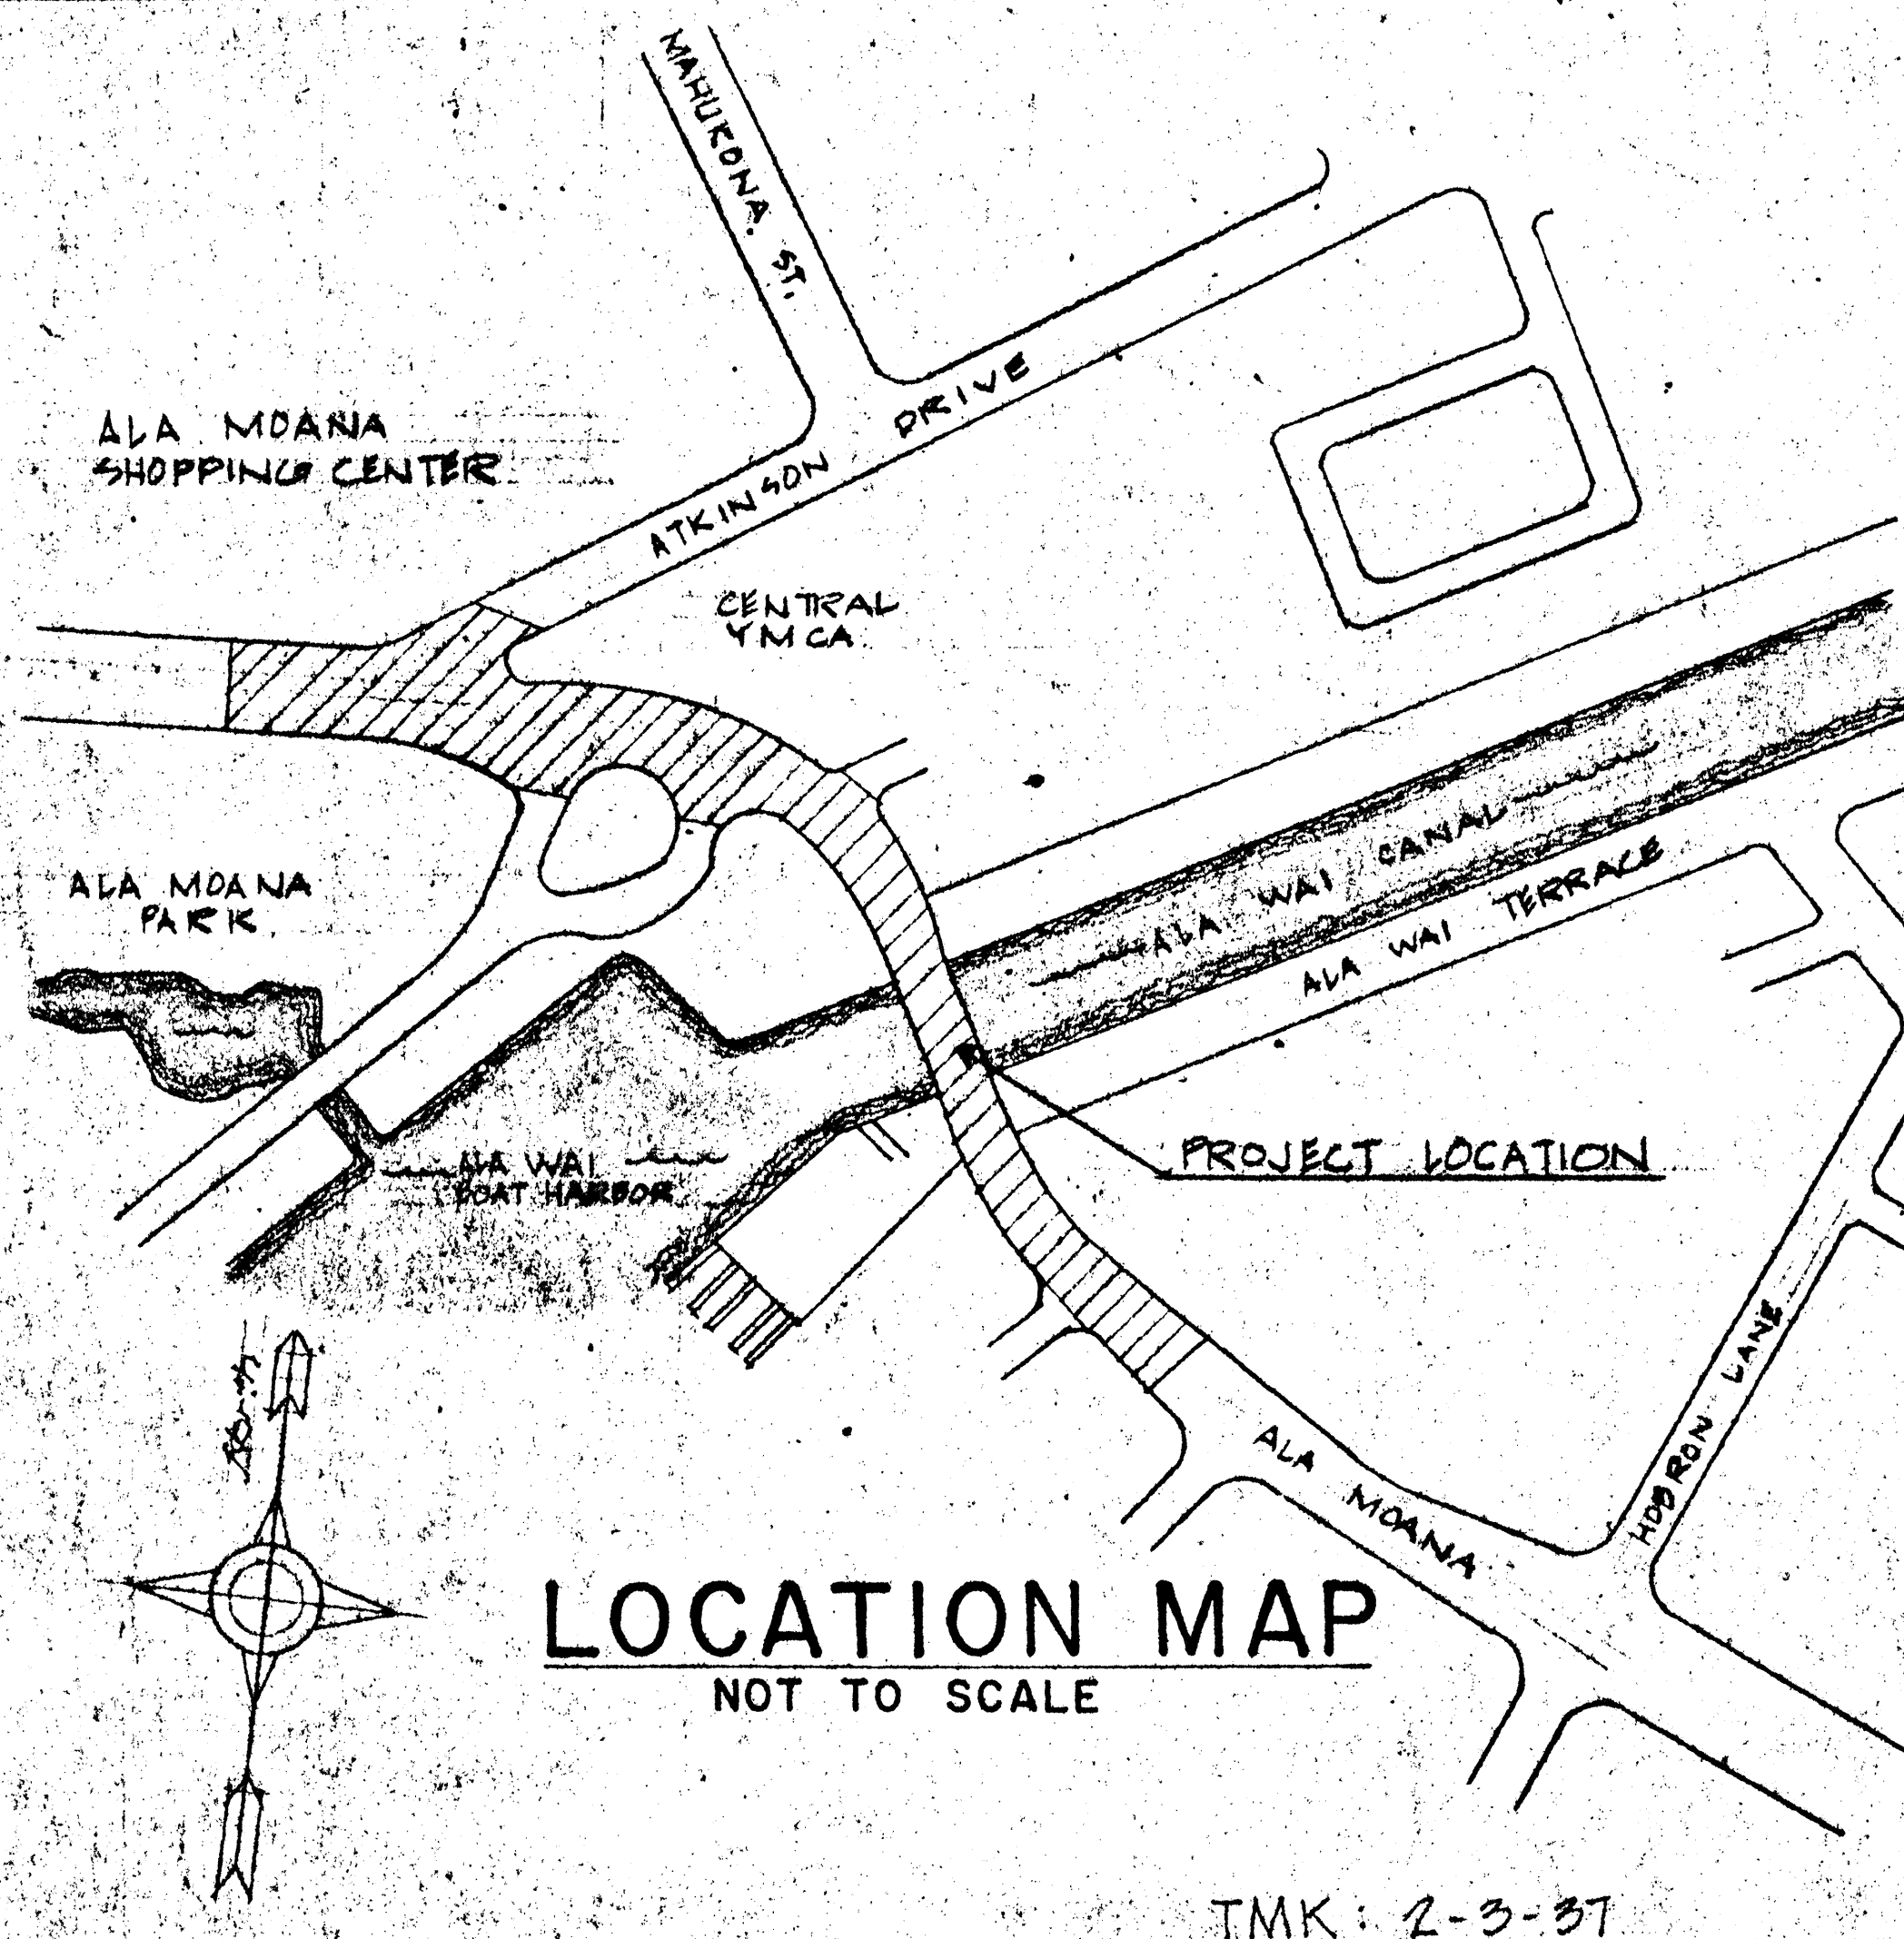

TMK: 2-3-37

TABLE OF CONTENTS

DESCRIPTION	SHEET NO.	
	BASIC BID	ALTERNATE BID
TITLE SHEET	1 R	—
ROADWAY DETAILS	2R-4R	2-4
UTILITY PLAN	5 R	5
TYPICAL SECTIONS	6 R	6
DETOUR DETAILS	7 R	7
TRAFFIC SIGNAL AND STREET LIGHTING PLAN	8 R	8
MISCELLANEOUS DETAILS	9 R	9
STANDARD DETAILS - STREET LIGHTING SYSTEMS	—	10
STANDARD DETAILS	—	11
CROSS SECTIONS	10R-11R	12-13
LAYOUT PLAN AND ELEVATION	12 R	14
ABUTMENT DETAILS	13 R	15
PIER NO. 1 DETAILS	14 R	16
PIER NO. 2 DETAILS	15 R	17
DECK FRAMING PLAN	16 R	18
TEE GIRDER LAYOUT & GENERAL NOTES	17 R	19
TRANSVERSE BEAM AT PIER	18 R	20
STAIR DETAILS	19R-20R	21-22
GIRDER DETAILS	21 R	23
STANDARD DETAILS, PRESTRESSED CONCRETE PILES	—	24
STANDARD DETAILS, METAL BRIDGE RAILING	—	25-26
STANDARD BRIDGE DETAILS	22 R	27
STANDARD GUARD RAIL DETAILS	23R-24R	—

APPROVED:

John A. Kinnear
CHIEF ENGINEER, DEPT. OF PUBLIC WORKS

10/22/68
DATE

William C. Long
TRAFFIC ENGINEER, DEPT. OF TRAFFIC

10/15/68
DATE

George C. Jones
MANAGER & CHIEF ENGR., BOARD OF WATER SUPPLY

DATE

E. Alvey Wright
DIRECTOR OF STATE TRANSPORTATION

9/27/68
DATE

REVISION APPROVED:
Robert E. Jones
DIRECTOR AND CHIEF ENGINEER, D.P.W., C&C
William C. Long
ACT. TRAFFIC ENGINEER, DEPT. OF TRAFFIC, C&C
George C. Jones
DIRECTOR OF TRANSPORTATION, STATE OF HAWAII

DATE
5/13/69
5/19/69
5/21/69

PARK ASSOCIATES, INC.
ARCHITECTS AND ENGINEERS

REVISIONS BY:
DIVISION OF ENGINEERING, D.P.W., CITY & COUNTY OF HONOLULU