


DEPARTMENT OF PUBLIC WORKS
DIVISION OF ENGINEERING

CITY & COUNTY OF HONOLULU
JOB NO. 08-71

PENSACOLA STREET
RELIEF DRAIN
UNIT II

HONOLULU · OAHU · HAWAII

LOCATION MAP

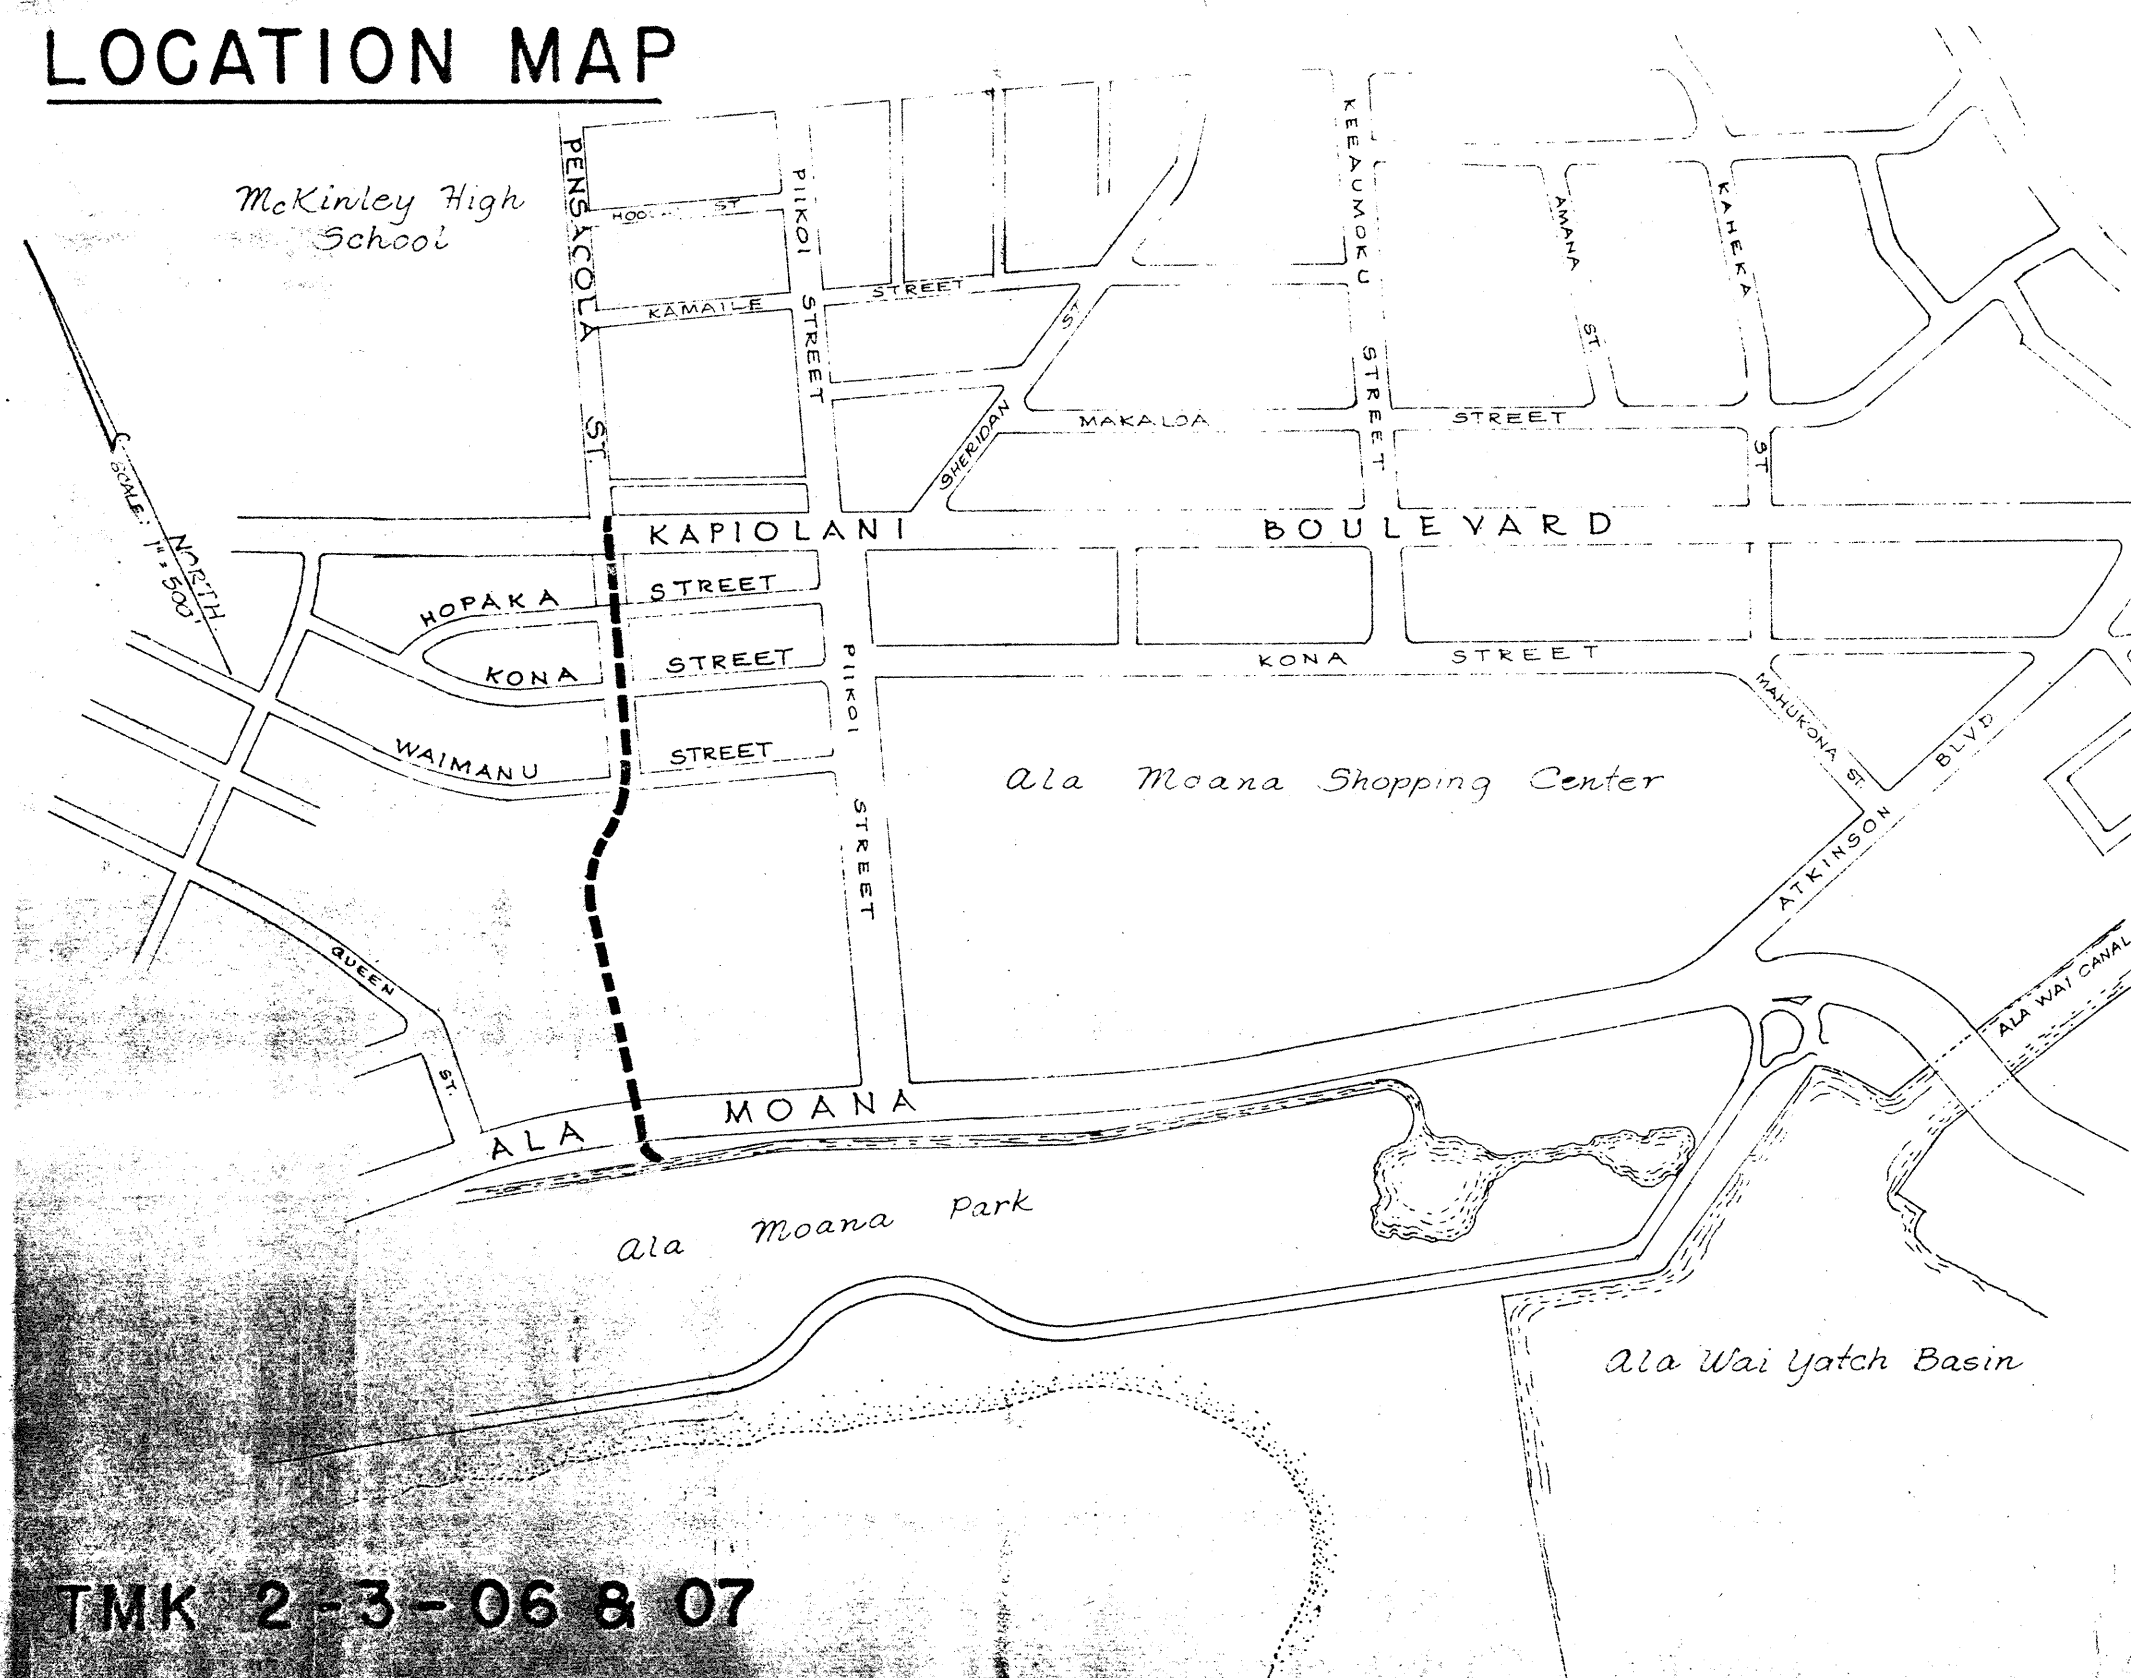

INDEX

DESCRIPTION

SHEET NO.

TITLE & LOCATION MAP
PLAN & PROFILE
WATER LOWERING DETAILS
DRAINAGE STRUCTURE DETAILS
DETOUR ROAD DETAILS
ELECTRICAL DETAILS
TELEPHONE & SIGNAL CORPS DETAILS

1
2-3
4
5-8
9-10
E1-E6
T1-T4

APPROVED

L. J. Pinto
Actg. DIRECTOR & CHIEF ENGINEER, DPW, CITY & COUNTY OF HONOLULU

5/10/71
DATE

John J. ...
CHIEF, HIGHWAYS DIVISION, STATE OF HAWAII

5/12/71
DATE

DD-092-02-89

TMK 2-3-06 & 07