
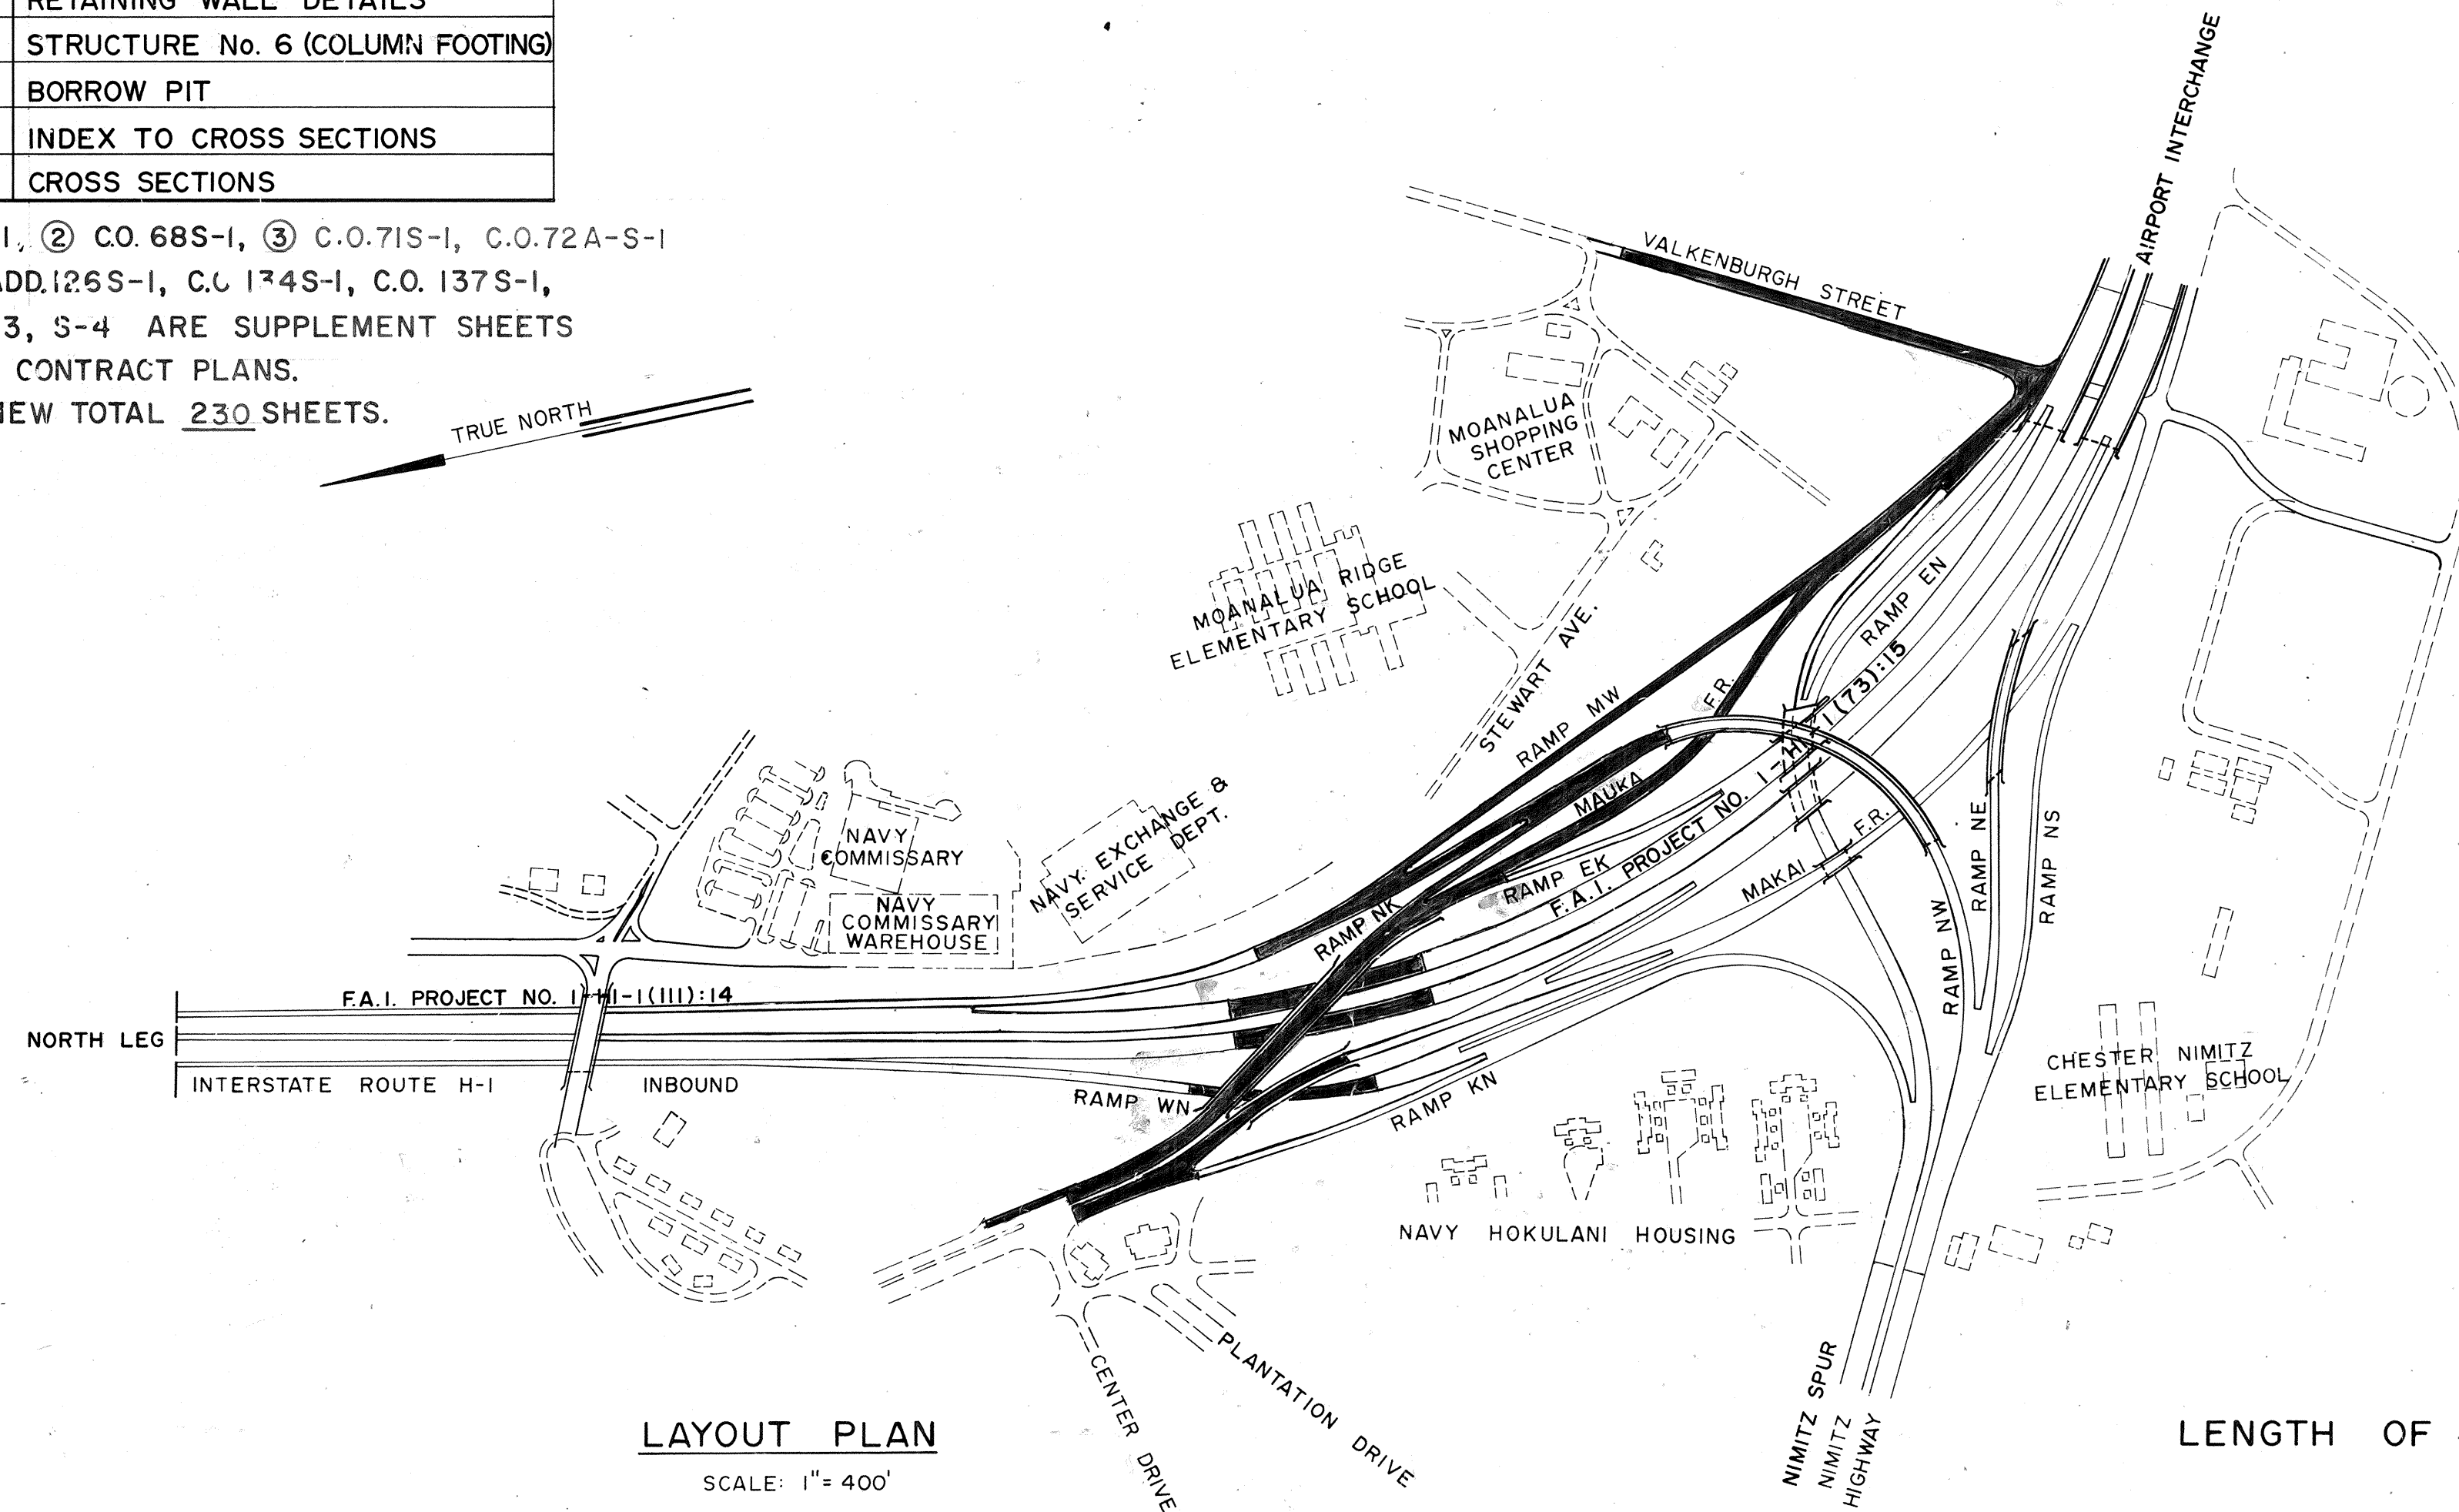


INDEX TO DRAWINGS	
SHEET NO.	DESCRIPTION
1	TITLE
2-3	BORING PLAN & LOGS
4	CONSTRUCTION PHASING
5-6	TYPICAL ROADWAY SECTIONS
7-14	PLAN & PROFILE
15	PROFILES
16-18	SUPERELEVATION DIAGRAMS
19-20	INTERSECTION DETAILS
21	MEDIAN DETAILS
22	MISCELLANEOUS DETAILS
23	FLEET WEATHER CENTRAL PARKING
24-39	STANDARD DETAILS
40-42	GRADING & DRAINAGE PLAN
43-45	DRAINAGE PROFILE
46-48	DRAINAGE SUMMARY
① 49-59	DRAINAGE DETAILS
60-63	EXISTING CONDITION PLAN
② 64-68	CIVIL UTILITY RELOCATION PLAN
③ 69-73	DETOUR PLAN
74-92	SIGNING & PAVEMENT MARKINGS
93-96	LANDSCAPING
97-109	SPRINKLER SYSTEM
110-114	REMOVAL & RELOCATION PLANS
115-119	ELECTRICAL PLANS
④ 120-137	ELECTRICAL DETAILS
138-139	STRUCTURE Nos. 2 & 3 LAYOUT PLAN
140-167	STRUCTURE No. 2
168-179	STRUCTURE No. 3
180-192	STRUCTURE DETAIL
193-194	RETAINING WALL Nos. 1 & 2
195-197	RETAINING WALL DETAILS
198	STRUCTURE No. 6 (COLUMN FOOTING)
199	BORROW PIT
200	INDEX TO CROSS SECTIONS
201-220	CROSS SECTIONS

① 59S-1, ② C.O. 68S-1, ③ C.O. 71S-1, C.O. 72A-S-1
④ C.O. ADD. 126S-1, C.O. 134S-1, C.O. 137S-1,
S-2, S-3, S-4 ARE SUPPLEMENT SHEETS
TO THE CONTRACT PLANS.

NEW TOTAL 230 SHEETS.

SLTH, Inc. &
55 F.F. Inc.
DESIGNED BY
H. INAI
P.S. & E. BY
548-5812
6/20/73
DATE

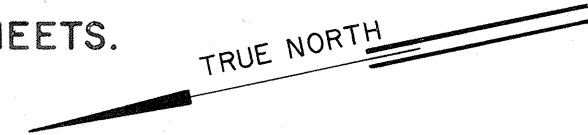


LAYOUT PLAN

SCALE: 1" = 400'

LENGTH OF PROJECT 0.17 MILE

STATE OF HAWAII
DEPARTMENT OF TRANSPORTATION
HIGHWAYS DIVISION
HONOLULU, HAWAII
"AS-BUILT"
PLANS FOR
CONSTRUCTION OF A PORTION OF
INTERSTATE ROUTE H-1
PEARL HARBOR INTERCHANGE
FEDERAL AID INTERSTATE PROJECT NO. 1-HI-1(110):15
DISTRICT OF HONOLULU
ISLAND OF OAHU

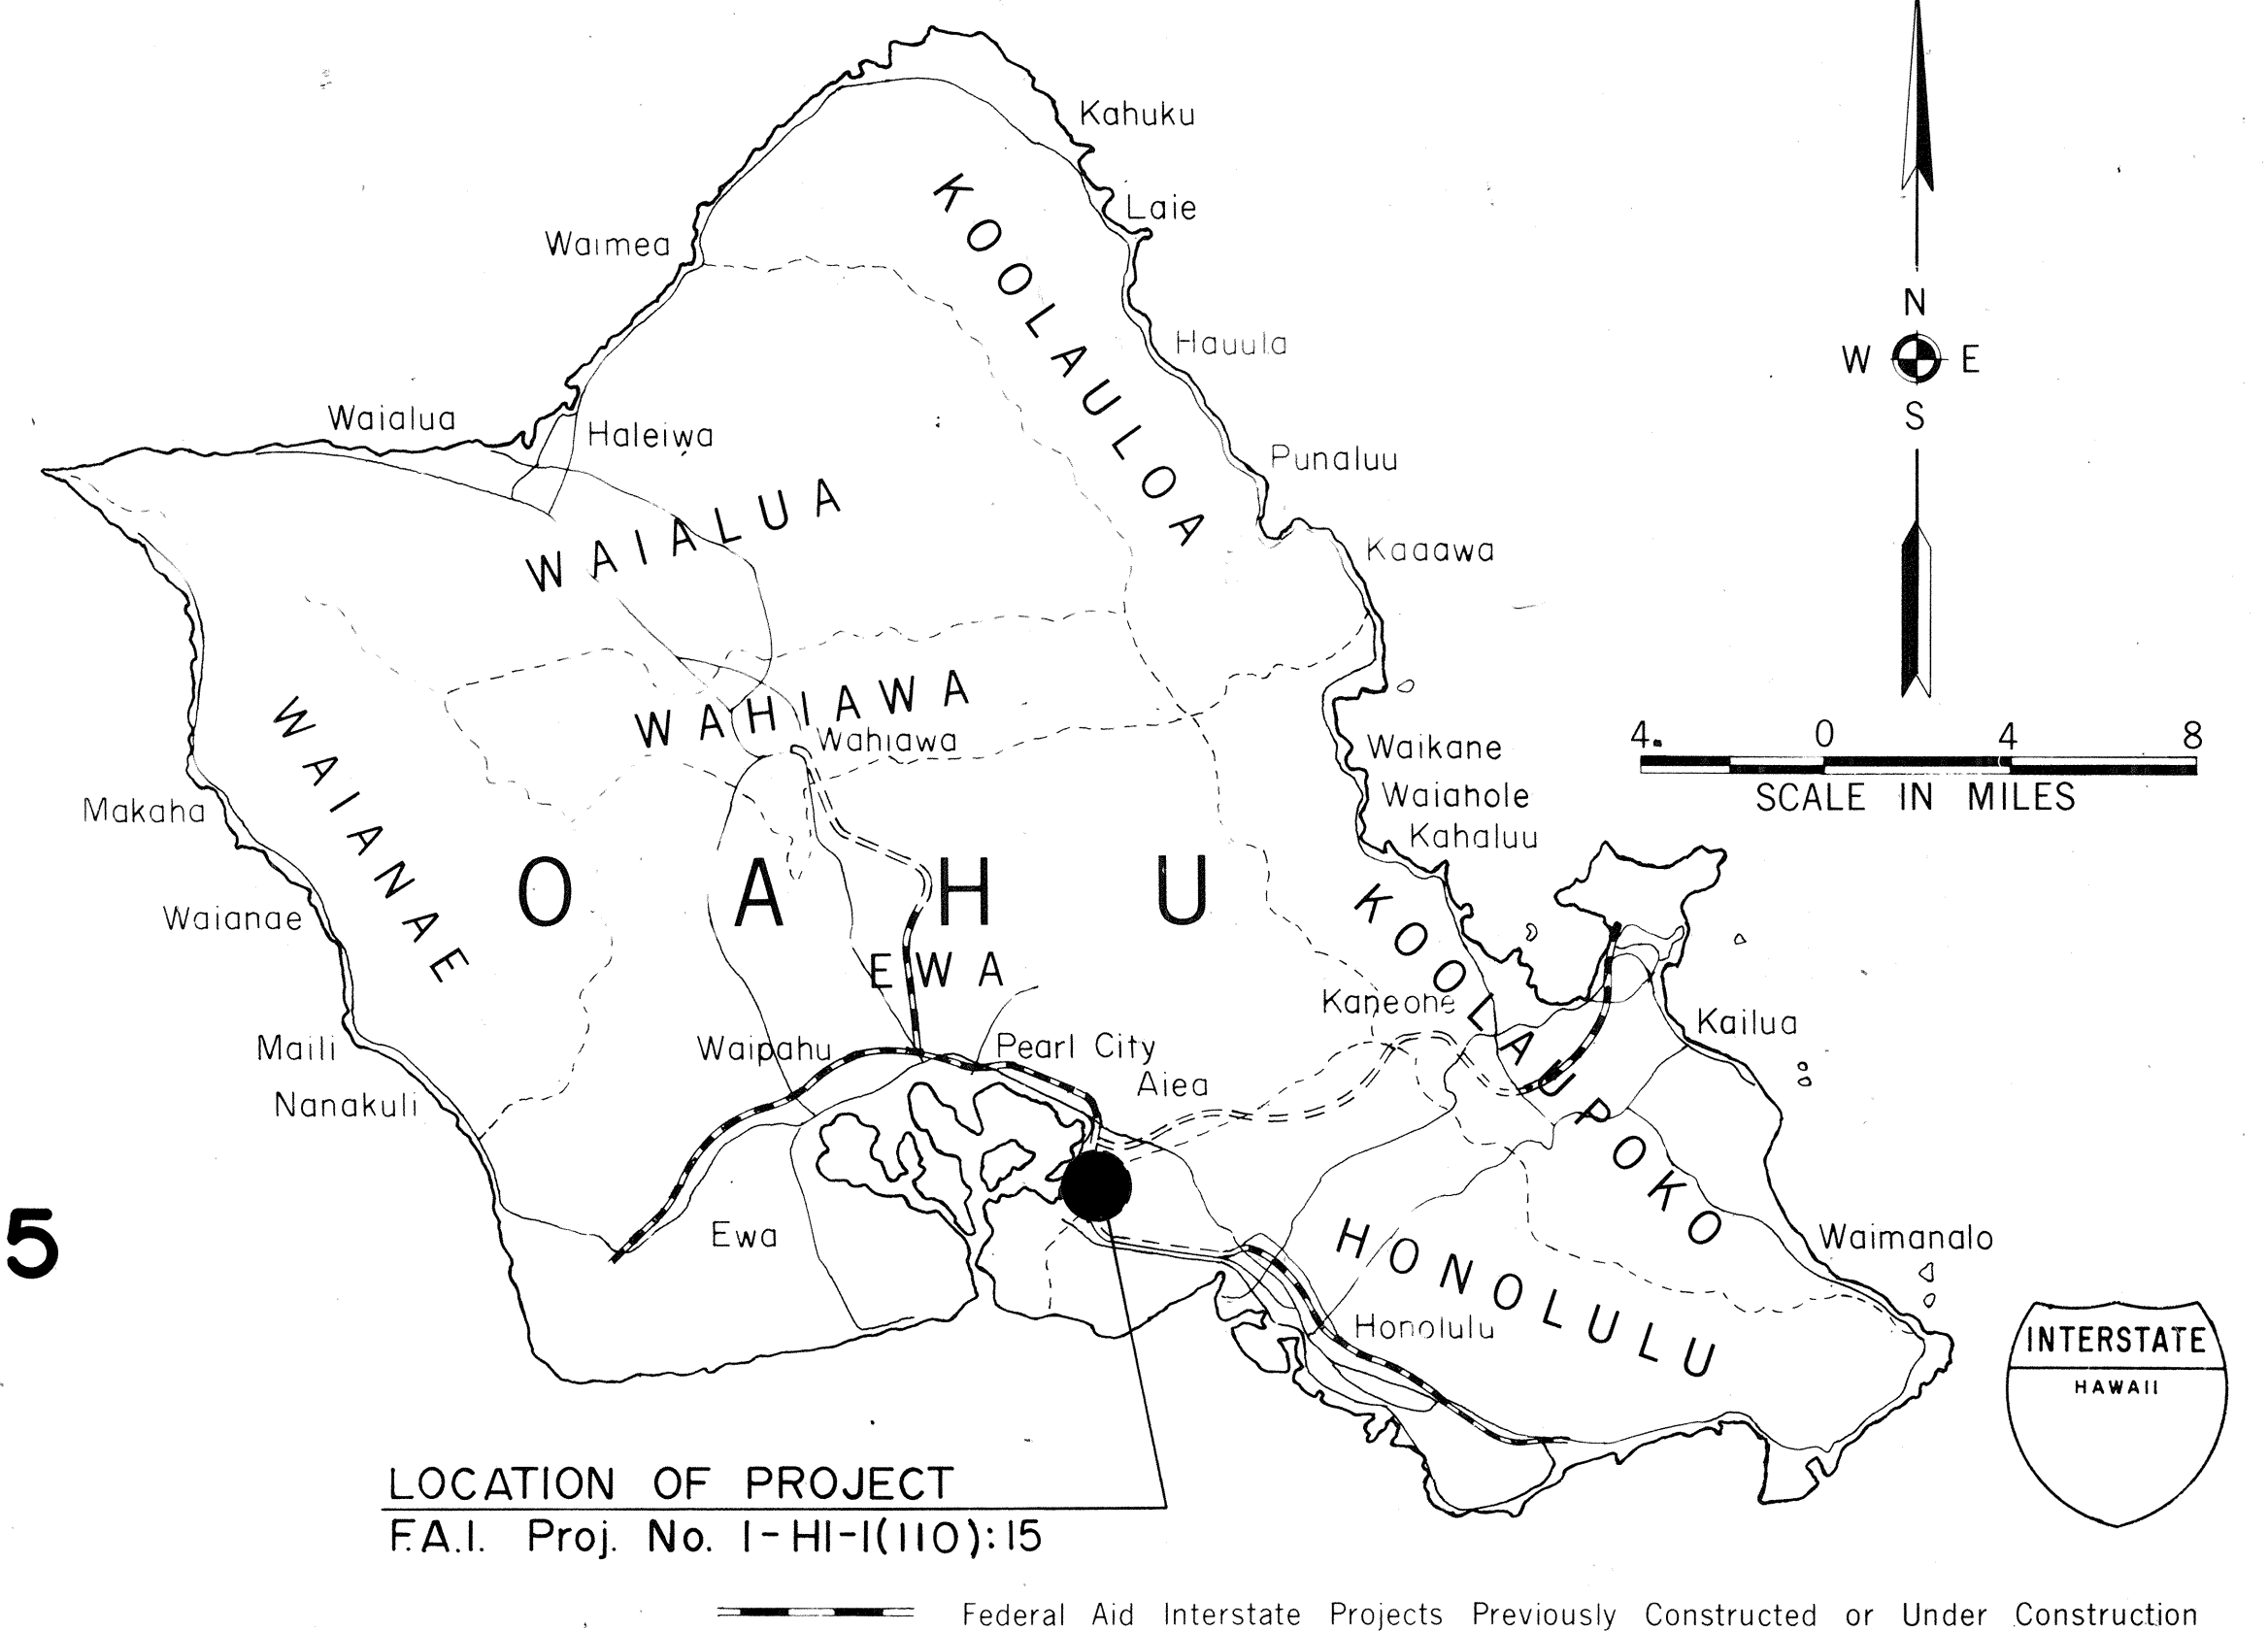

SCALES:

PLANS	HOR.	1" = 50'
PROFILES	HOR.	1" = 50'
	VER.	1" = 10'
DETAIL ROADWAY PLANS	HOR.	1" = 50'
CROSS SECTIONS	HOR.	1" = 10'
	VER.	1" = 10'
CROSS SECTIONS	HOR.	1" = 20'
	VER.	1" = 20'

DESIGN DESIGNATION

CURRENT ADT (1973)	32,800
DESIGN ADT (1994)	58,300
DHV	5,500
D	60/40
T	5 %
V	60 MPH
CONTROL OF ACCESS	FULL

ALL CHANGES MADE DURING CONSTRUCTION HAVE BEEN INCORPORATED ON THESE PLANS IN RED EXCEPT CHANGES IN THE ORIGINAL THEORETICAL QUANTITIES. FOR ACTUAL QUANTITIES, REFER TO PROJECT LEDGER AND/OR COMPUTATION BOOK.

Merton J. Shida
PROJECT ENGINEER

4/6/73
DATE

DEPARTMENT OF TRANSPORTATION
FEDERAL HIGHWAY ADMINISTRATION
APPROVED:
Leslie J. Deane
DIVISION ENGINEER
6/20/73
DATE

DEPARTMENT OF TRANSPORTATION
STATE OF HAWAII
APPROVED:
Murray Lee
FOR DIR. OF TRANSPORTATION
6/20/73
DATE