



FED. ROAD DIST. NO.	STATE	FED. AID PROJ. NO.	FISCAL YEAR	SHEET NO.	TOTAL SHEETS
HAWAII	HAW.	EH9-U-092-i(11)	1974	38	141

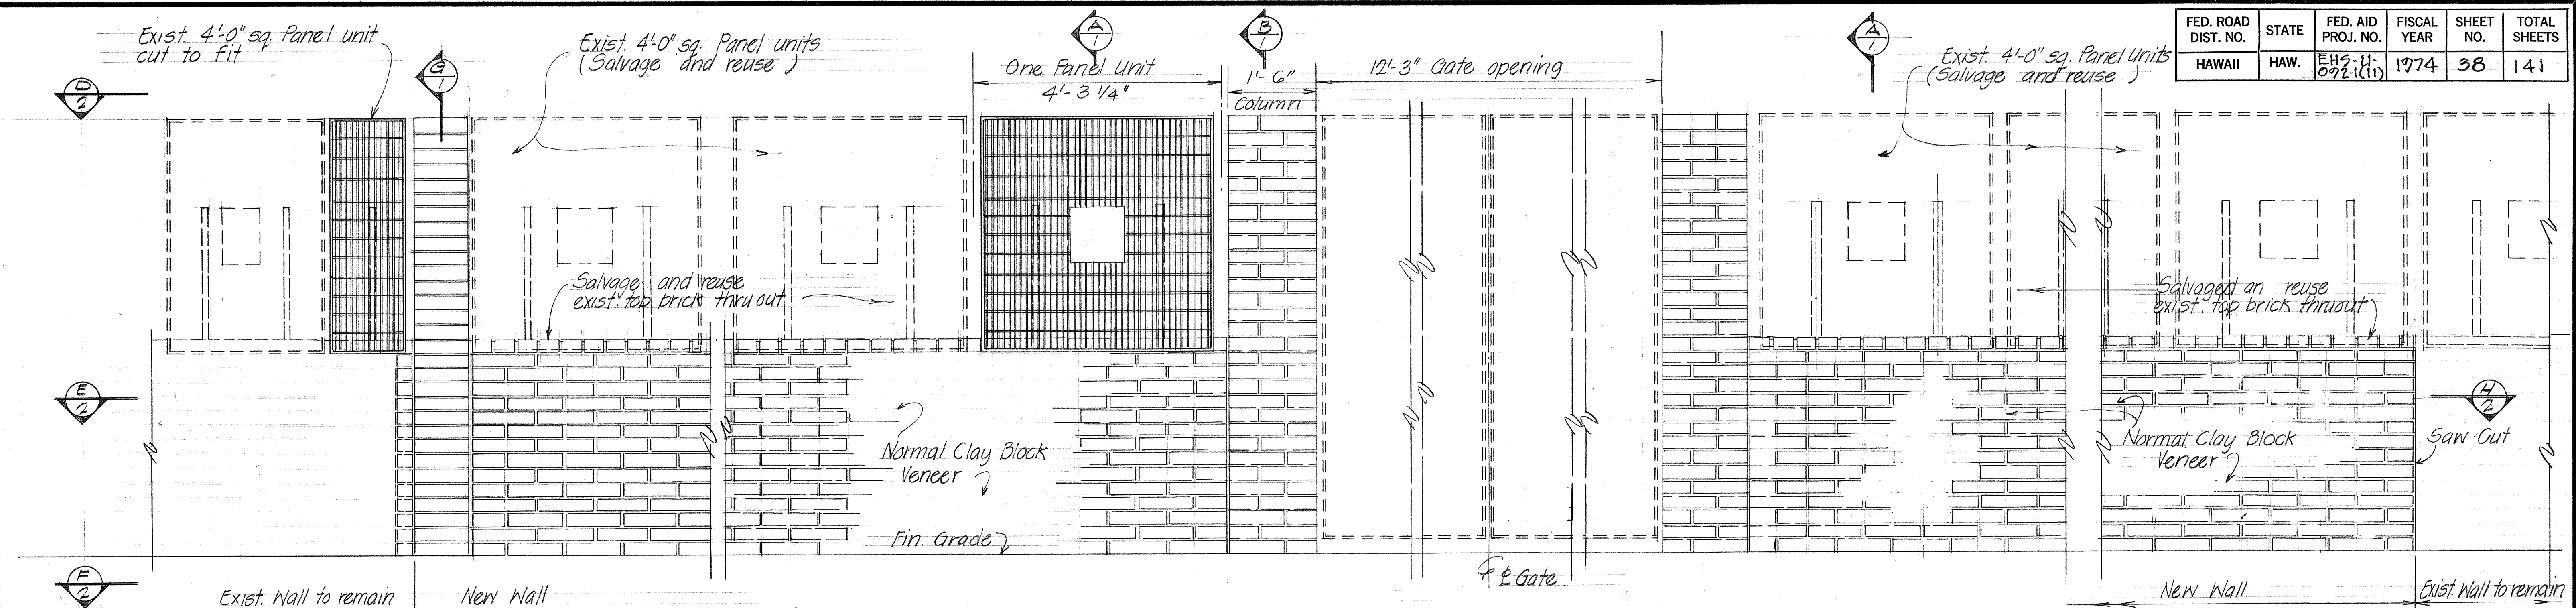


TYP WALL FENCE & GATE ELEVATION

Scale: $\frac{3}{4}" = 1'-0"$

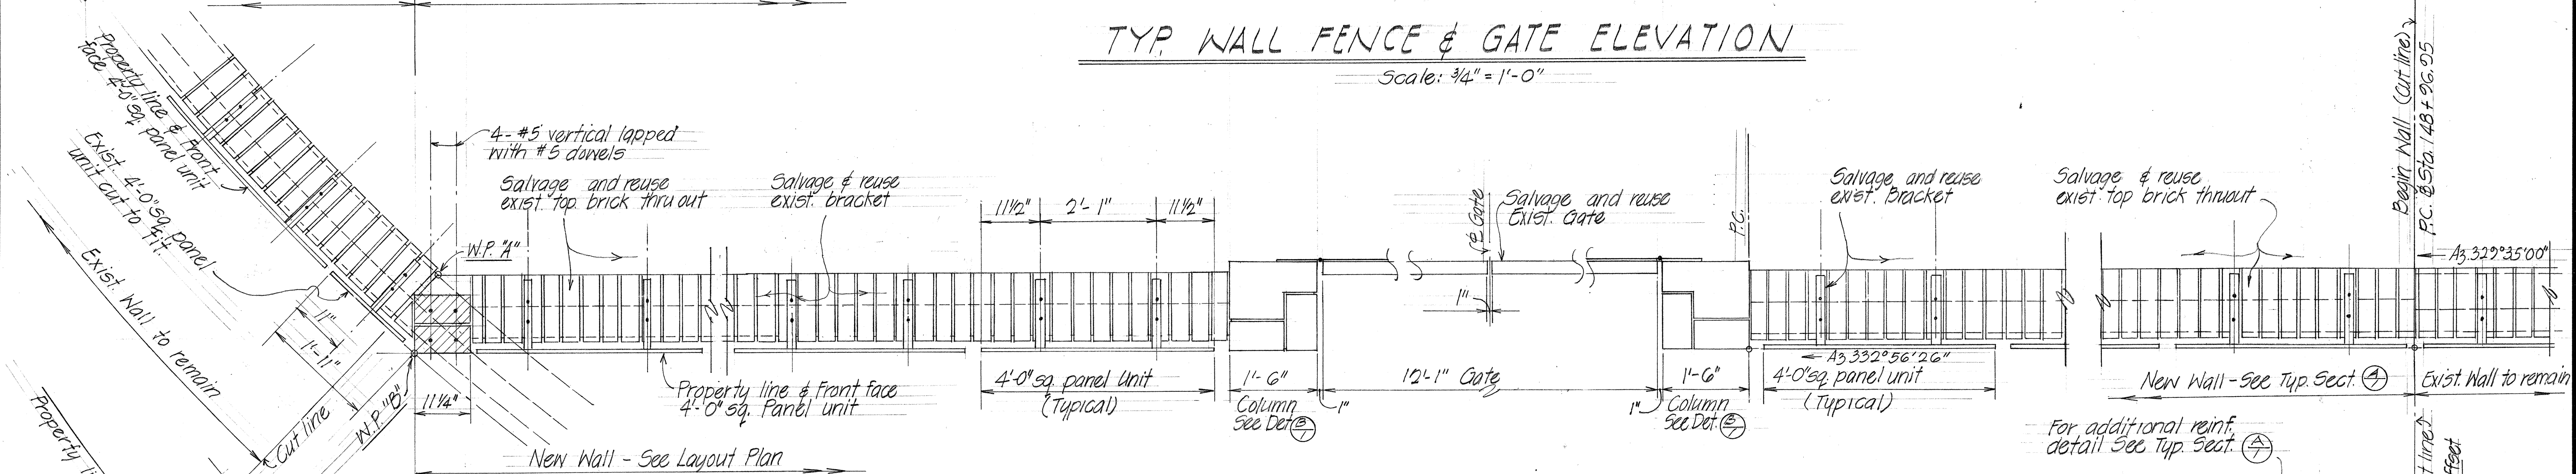

TYP WALL, FENCE & GATE PLAN

Scale: $\frac{3}{4}" = 1'-0"$

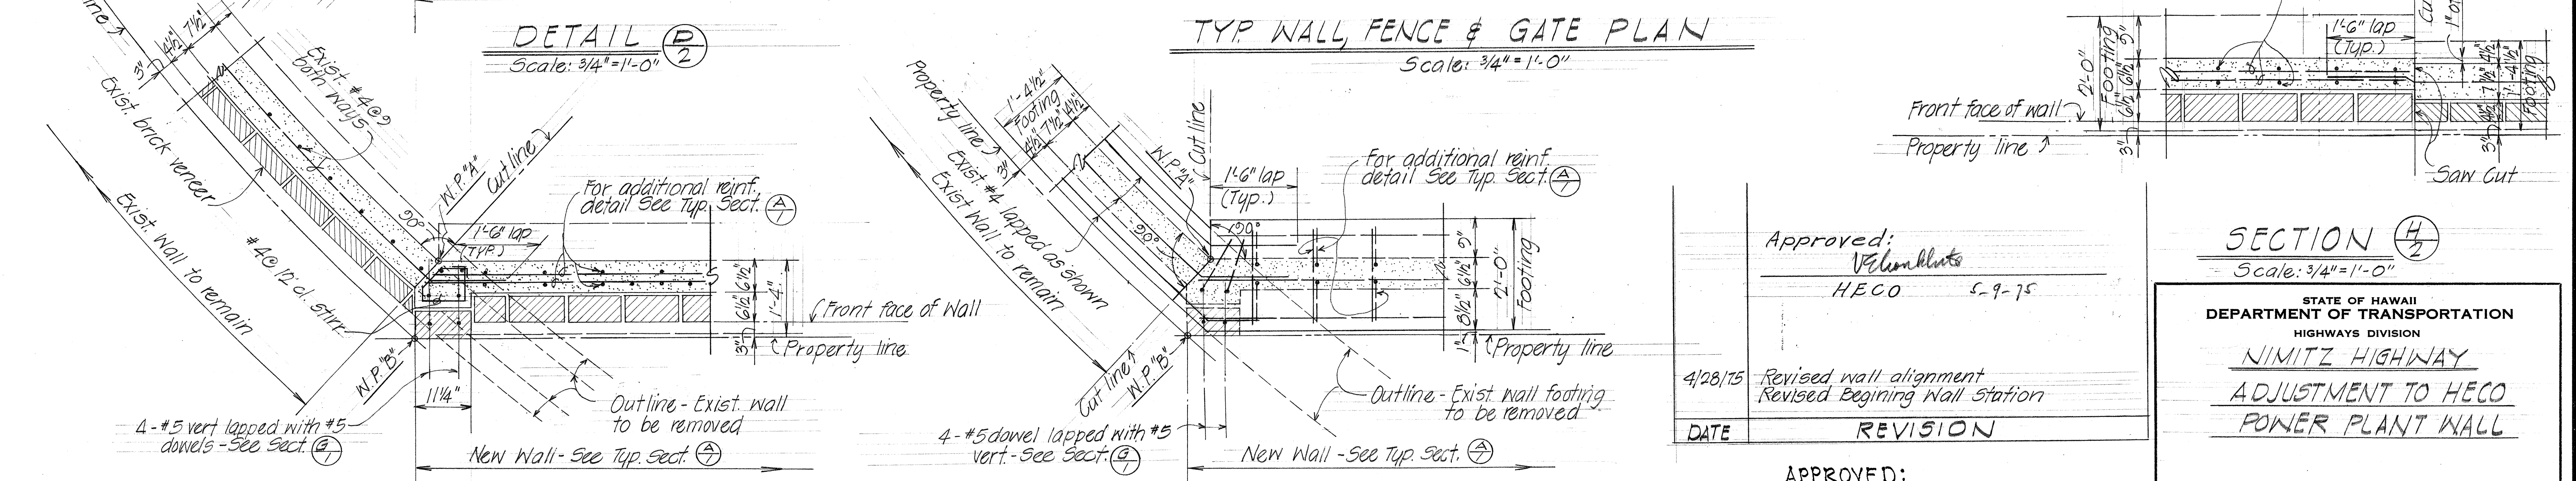SECTION $\left(\frac{E}{2}\right)$

Scale: $\frac{3}{4}" = 1'-0"$

SECTION $\left(\frac{F}{2}\right)$

Scale: $\frac{3}{4}" = 1' - 0"$

Approved: V. Chonkhar
HECO

4/28/75	Revised wall alignment Revised Beginning Wall Station
DATE	REVISION

APPROVED: W Cronkrite 3/22/77
Hawaiian Electric Co. Inc. Date

SECTION $\left(\frac{H}{2}\right)$

Scale: $\frac{3}{4}" = 1' - 0"$

STATE OF HAWAII
DEPARTMENT OF TRANSPORTATION
HIGHWAYS DIVISION
NIMITZ HIGHWAY
ADJUSTMENT TO HECO
POWER PLANT WALL

Proj. No. EHS-U-092-1(11) FEB 1974

SHEET No. 1 OF 2 SHEETS

CO 3 S

EHS-4-0921(10)

