



FED. ROAD DIST. NO.	STATE	PROJ. NO.	FISCAL YEAR	SHEET NO.	TOTAL SHEETS
HAWAII	HAW.	92A-01-00	2002	54	116

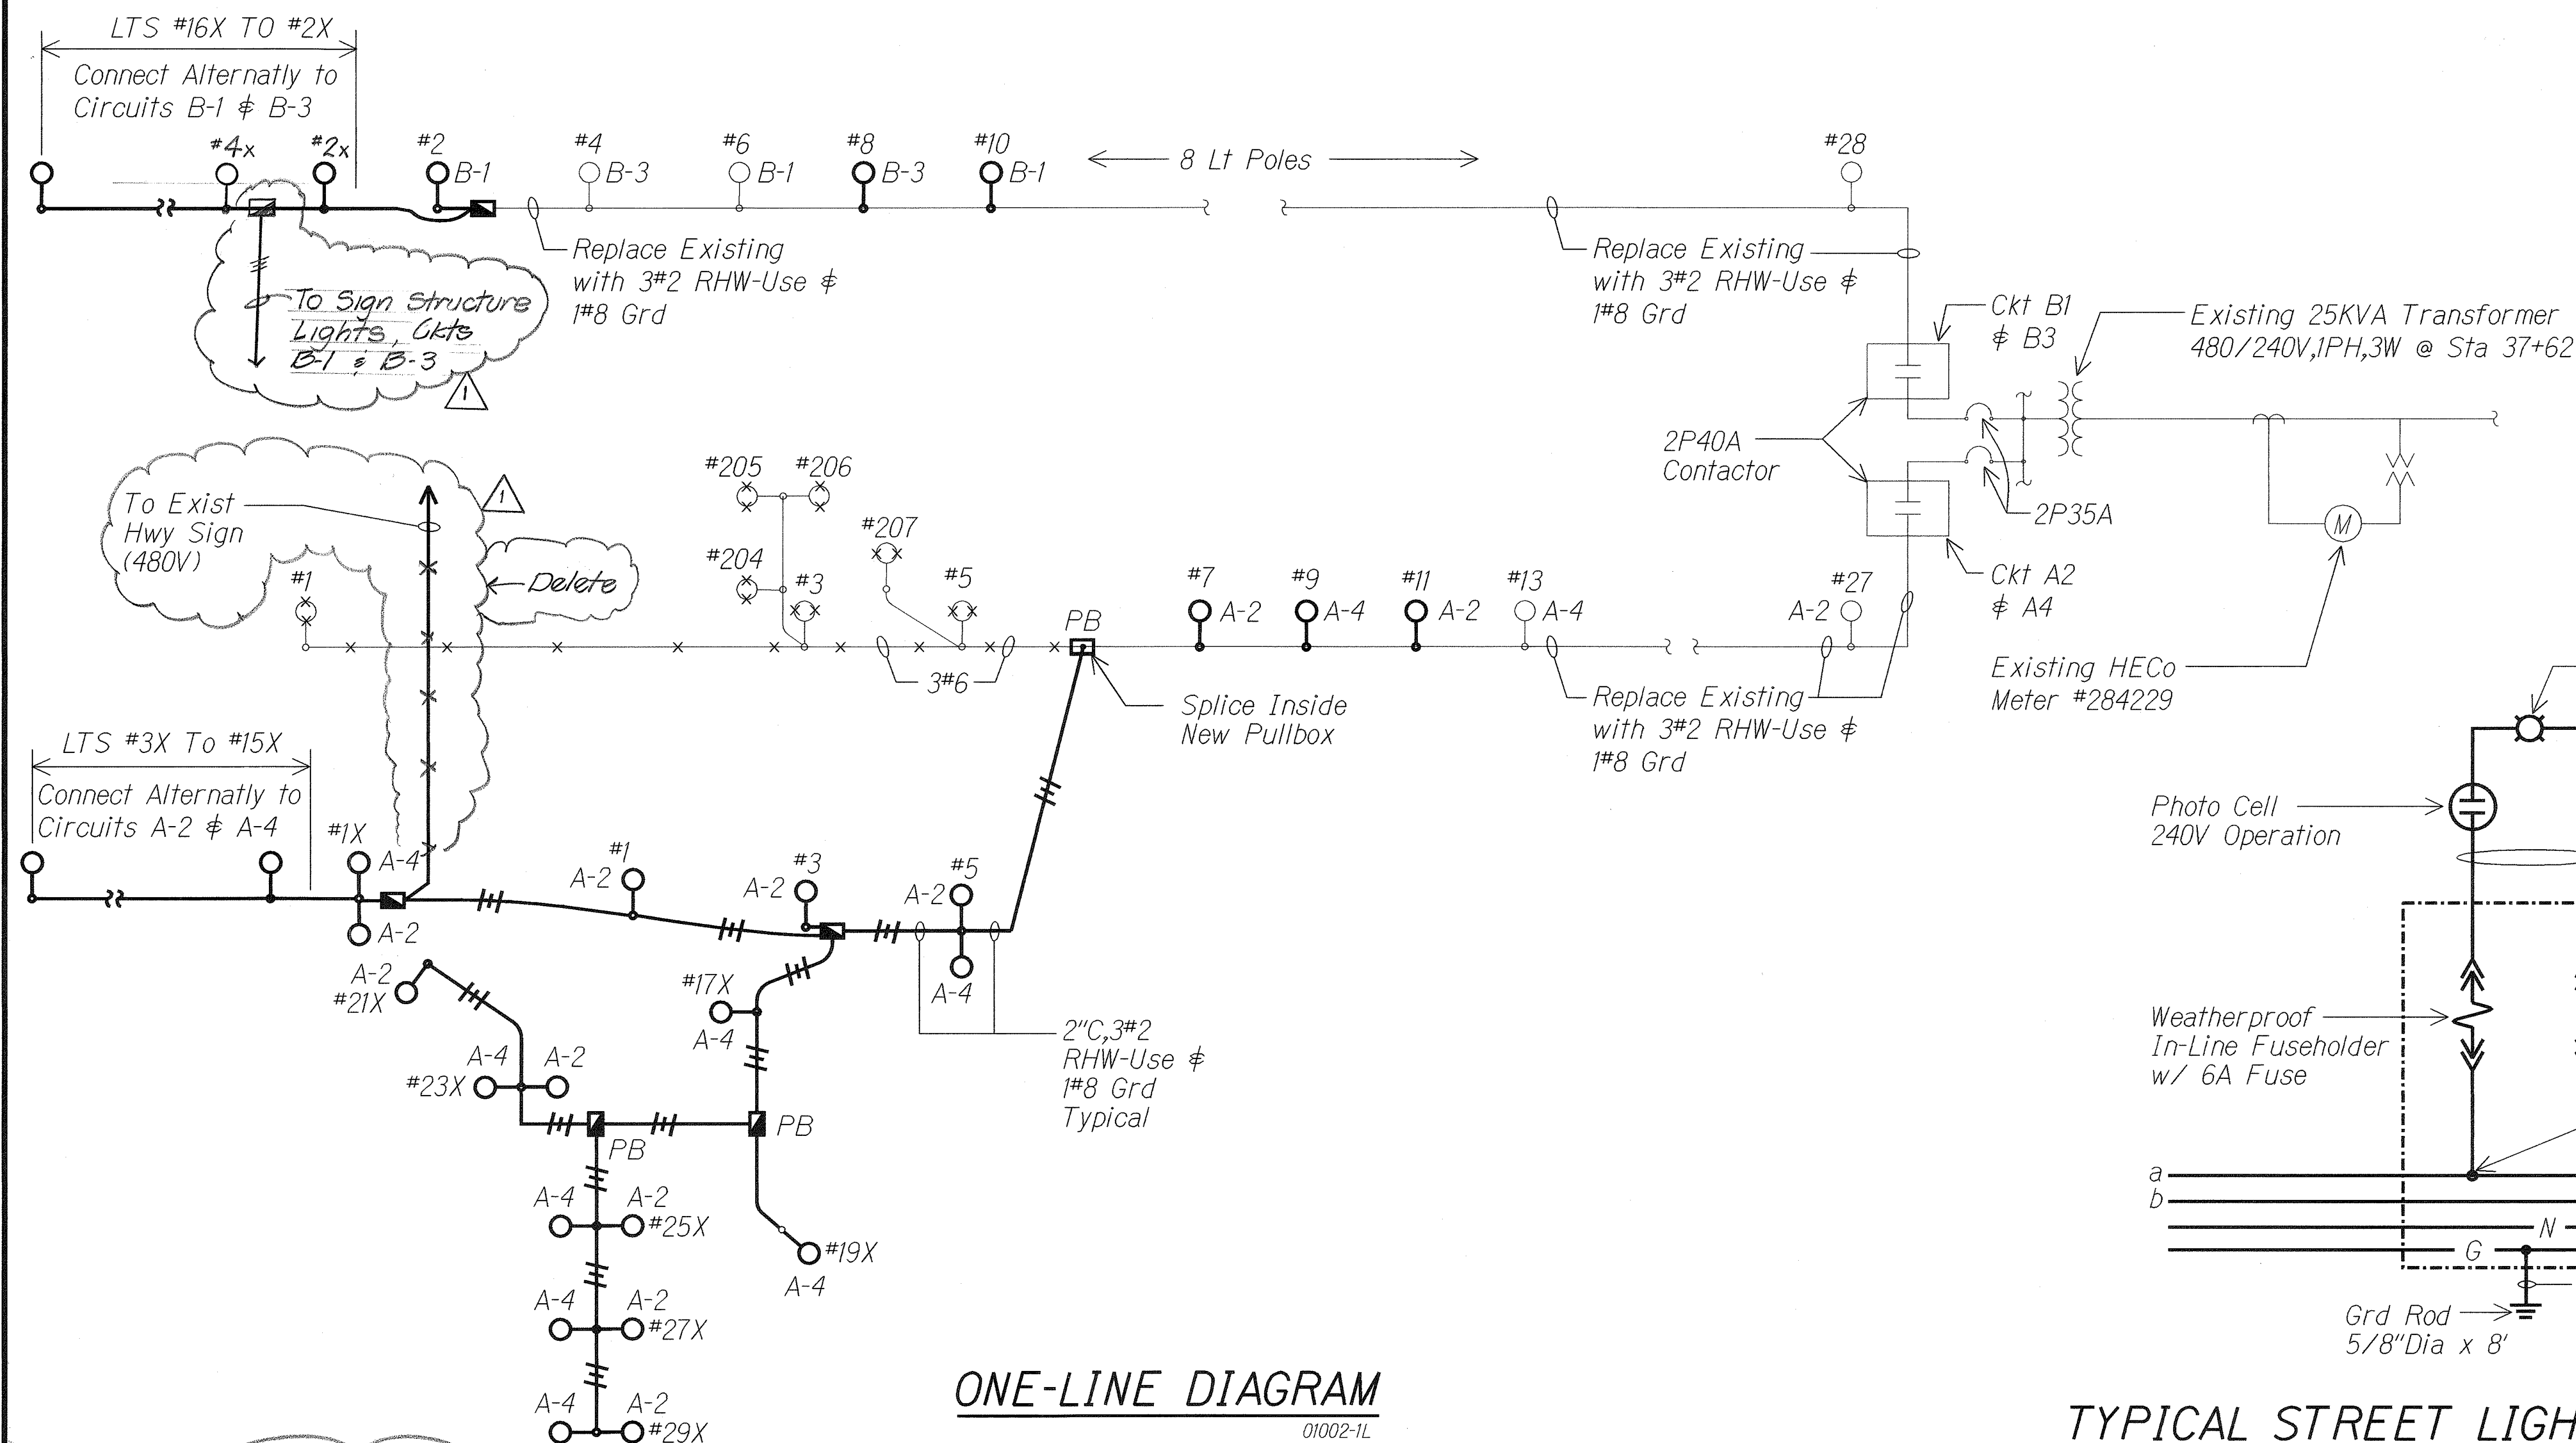


TYPICAL STREET LIGHT WIRING DIAGRAM

01002-D1

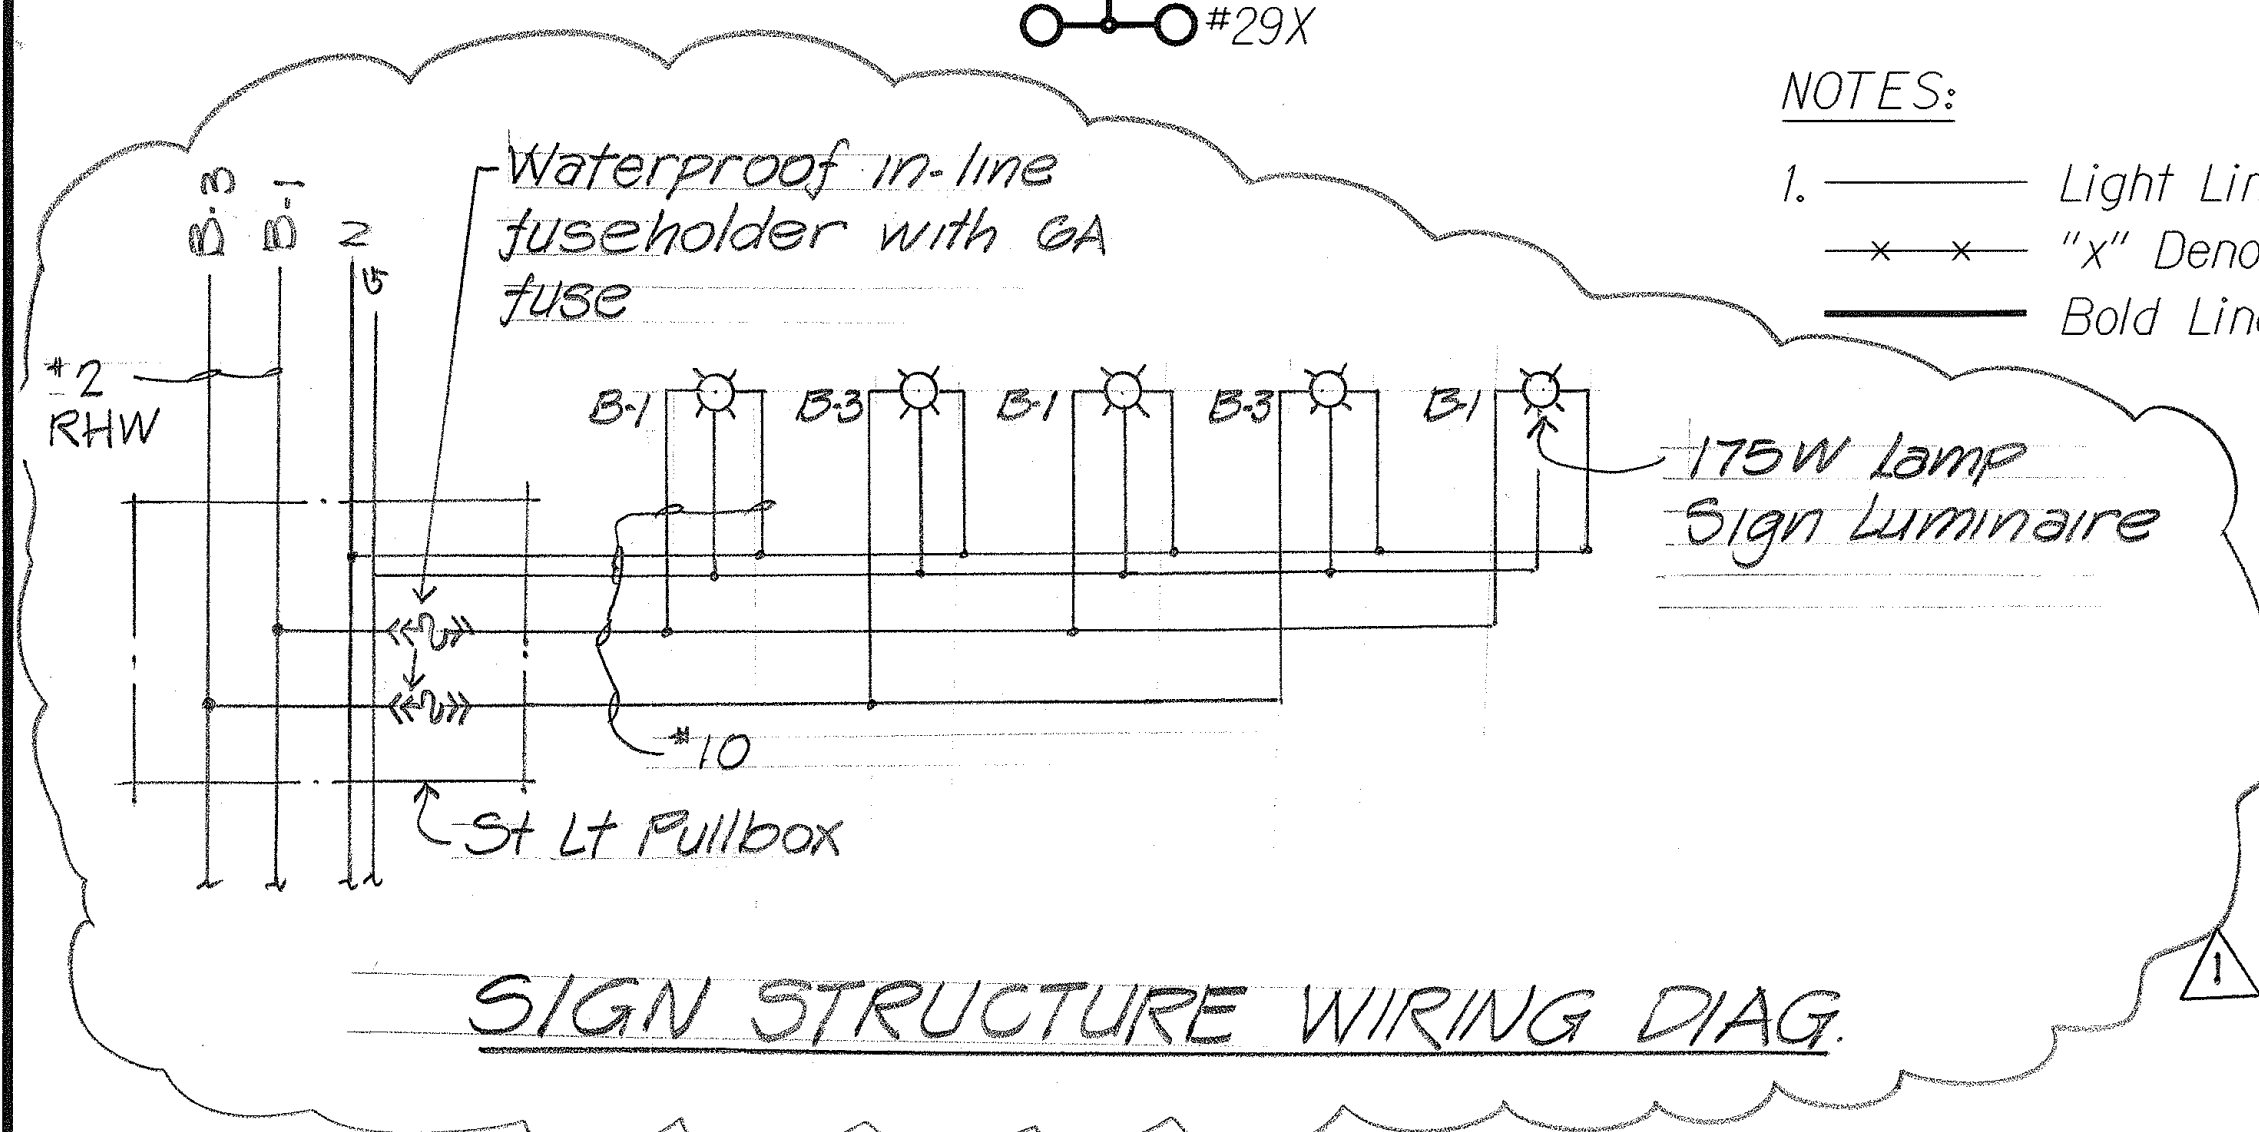

SURVEY PLOTTED BY	DATE
DRAWN BY	
TRACED BY	
NOTED BY	
QUANTITIES BY	
CHECKED BY	
ORIGINAL PLAN	
NOTE BOOK	
Nr.	

REV.	DATE	DESCRIPTION	BY
4/22/02		REVISE ONE-LINE DIAGRAM	LV

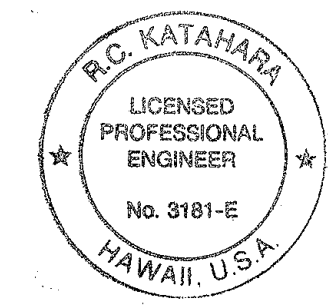

THIS WORK WAS PREPARED BY ME OR UNDER MY SUPERVISION.
Date: 5/6/02
H.K. ENGINEERS, LTD.
LICENSE EXPIRATION DATE: 4/30/04

STATE OF HAWAII
DEPARTMENT OF TRANSPORTATION
HIGHWAYS DIVISION

LIGHTING DIAGRAMS DETAILS

NIMITZ HIGHWAY INTERSECTION IMPROVEMENTS
AT SAND ISLAND ACCESS ROAD
PROJECT NO. 92A-01-00
Scale: Date: Apr 26, 2002

SHEET No. E14 OF 16 SHEETS