


FED. ROAD DIST. NO.	STATE	PROJ. NO.	FISCAL YEAR	SHEET NO.	TOTAL SHEETS
HAWAII	HAW.	92A-01-00	2002	50	116

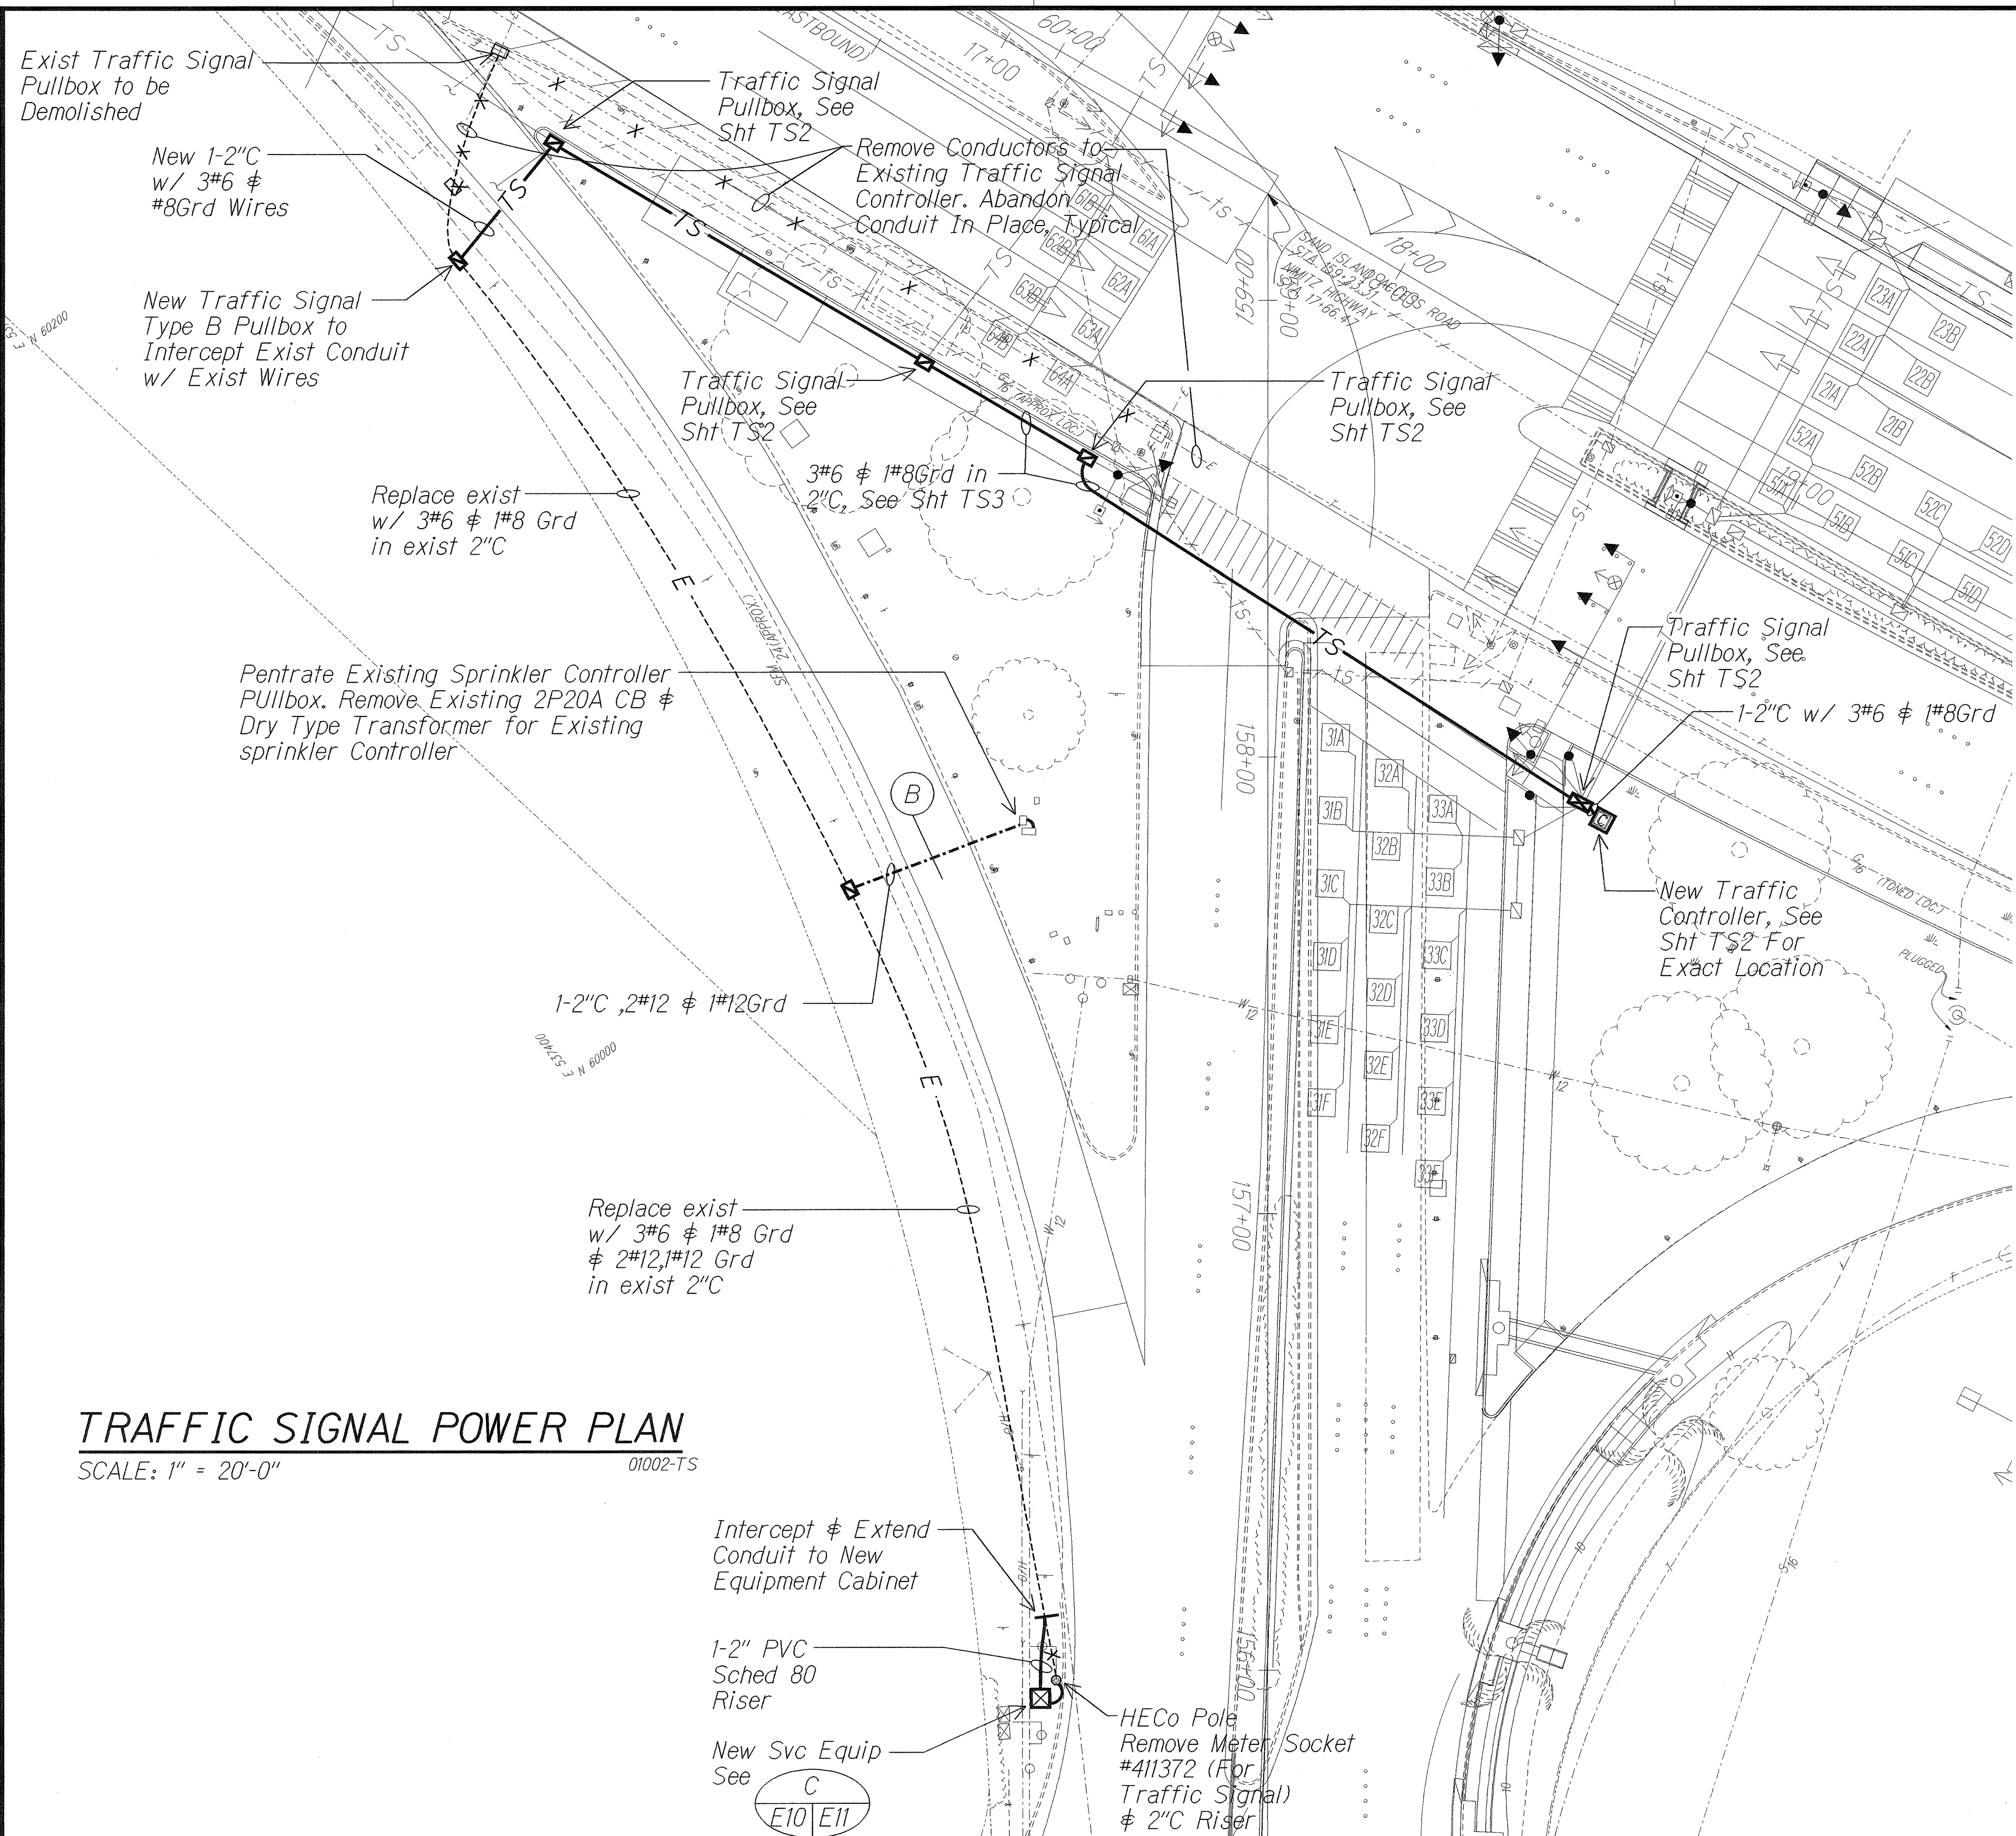

TRAFFIC SIGNAL POWER PLAN

SCALE: 1" = 20'-0"

01002-TS

SURVEY PLOTTED BY	DATE
DRAWN BY	
DESIGNED BY	
CHECKED BY	
NOTE BOOK	
QUANTITIES BY	
CHECKED BY	

THIS WORK WAS PREPARED BY ME OR UNDER MY SUPERVISION.

R.C. KATAHARA

NR ENGINEERS, LTD.
LICENSE EXPIRATION DATE: 4/30/04

STATE OF HAWAII
DEPARTMENT OF TRANSPORTATION
HIGHWAYS DIVISION

TRAFFIC SIGNAL POWER PLAN

NIMITZ HIGHWAY INTERSECTION IMPROVEMENTS
AT SAND ISLAND ACCESS ROAD
PROJECT NO. 92A-01-00

Scale: Date: Apr 26, 2002