


INDEX TO DRAWINGS	
SHEET NO.	DESCRIPTION
1	TITLE SHEET
2	GENERAL SITE and SHEET LAYOUT PLAN
3	GENERAL NOTES
4	GENERAL NOTES and MISCELLANEOUS DETAILS
5	SECTIONS "A" & "B" ELECTRICAL PLANS
6	SECTIONS "C" & "D" ELECTRICAL PLANS
7	SECTIONS "E" & "F" ELECTRICAL PLANS
8	SECTION "G" ELECTRICAL PLAN
9	SECTION "H" ELECTRICAL PLAN
△ 10	SECTIONS "I" & "J" ELECTRICAL PLANS
11	SUBSTATION & CONTROL EQUIPMENT VAULT PLANS
12	SUBSTATION VAULT ONELINE RISER DIAGRAMS
13	SUBSTATION VAULT (E STA: 37+62) ST. LT. CONNECTION DIAGRAM
14	SUBSTATION VAULT (E STA: 90+14) ST. LT. CONNECTION DIAGRAM
15	SUBSTATION VAULT (E STA: 122+48) ST. LT. CONNECTION DIAGRAM
16	SUBSTATION VAULT (E STA: 122+48) ST. LT. CONNECTION DIAGRAM
17	OVERHEAD POLELINE SYSTEM REMOVAL & NEW WORK
18	STREET LIGHT POLE and LUMINAIRE SCHEDULE
19	STREET LIGHT POLE and LUMINAIRE SCHEDULE
20	STREET LIGHT STANDARD DETAILS
21	MISCELLANEOUS DETAILS
22	MISCELLANEOUS DETAILS
IS-11	STANDARD PLANS SUMMARY

STATE OF HAWAII  
DEPARTMENT OF TRANSPORTATION  
HIGHWAYS DIVISION  
HONOLULU, HAWAII


"AS-BUILT"  
PLANS FOR  
HIGHWAY LIGHTING IMPROVEMENT  
OF  
**NIMITZ HIGHWAY**  
SAND ISLAND ACCESS RD. TO BISHOP ST.  
**PROJECT NO. 92A-03-86**

DISTRICT OF HONOLULU  
ISLAND OF OAHU

FED. ROAD DIST. NO.	STATE	PROJ. NO.	FISCAL YEAR	SHEET NO.	TOTAL SHEETS
HAWAII	HAW.	92A-03-86	1988	1	23

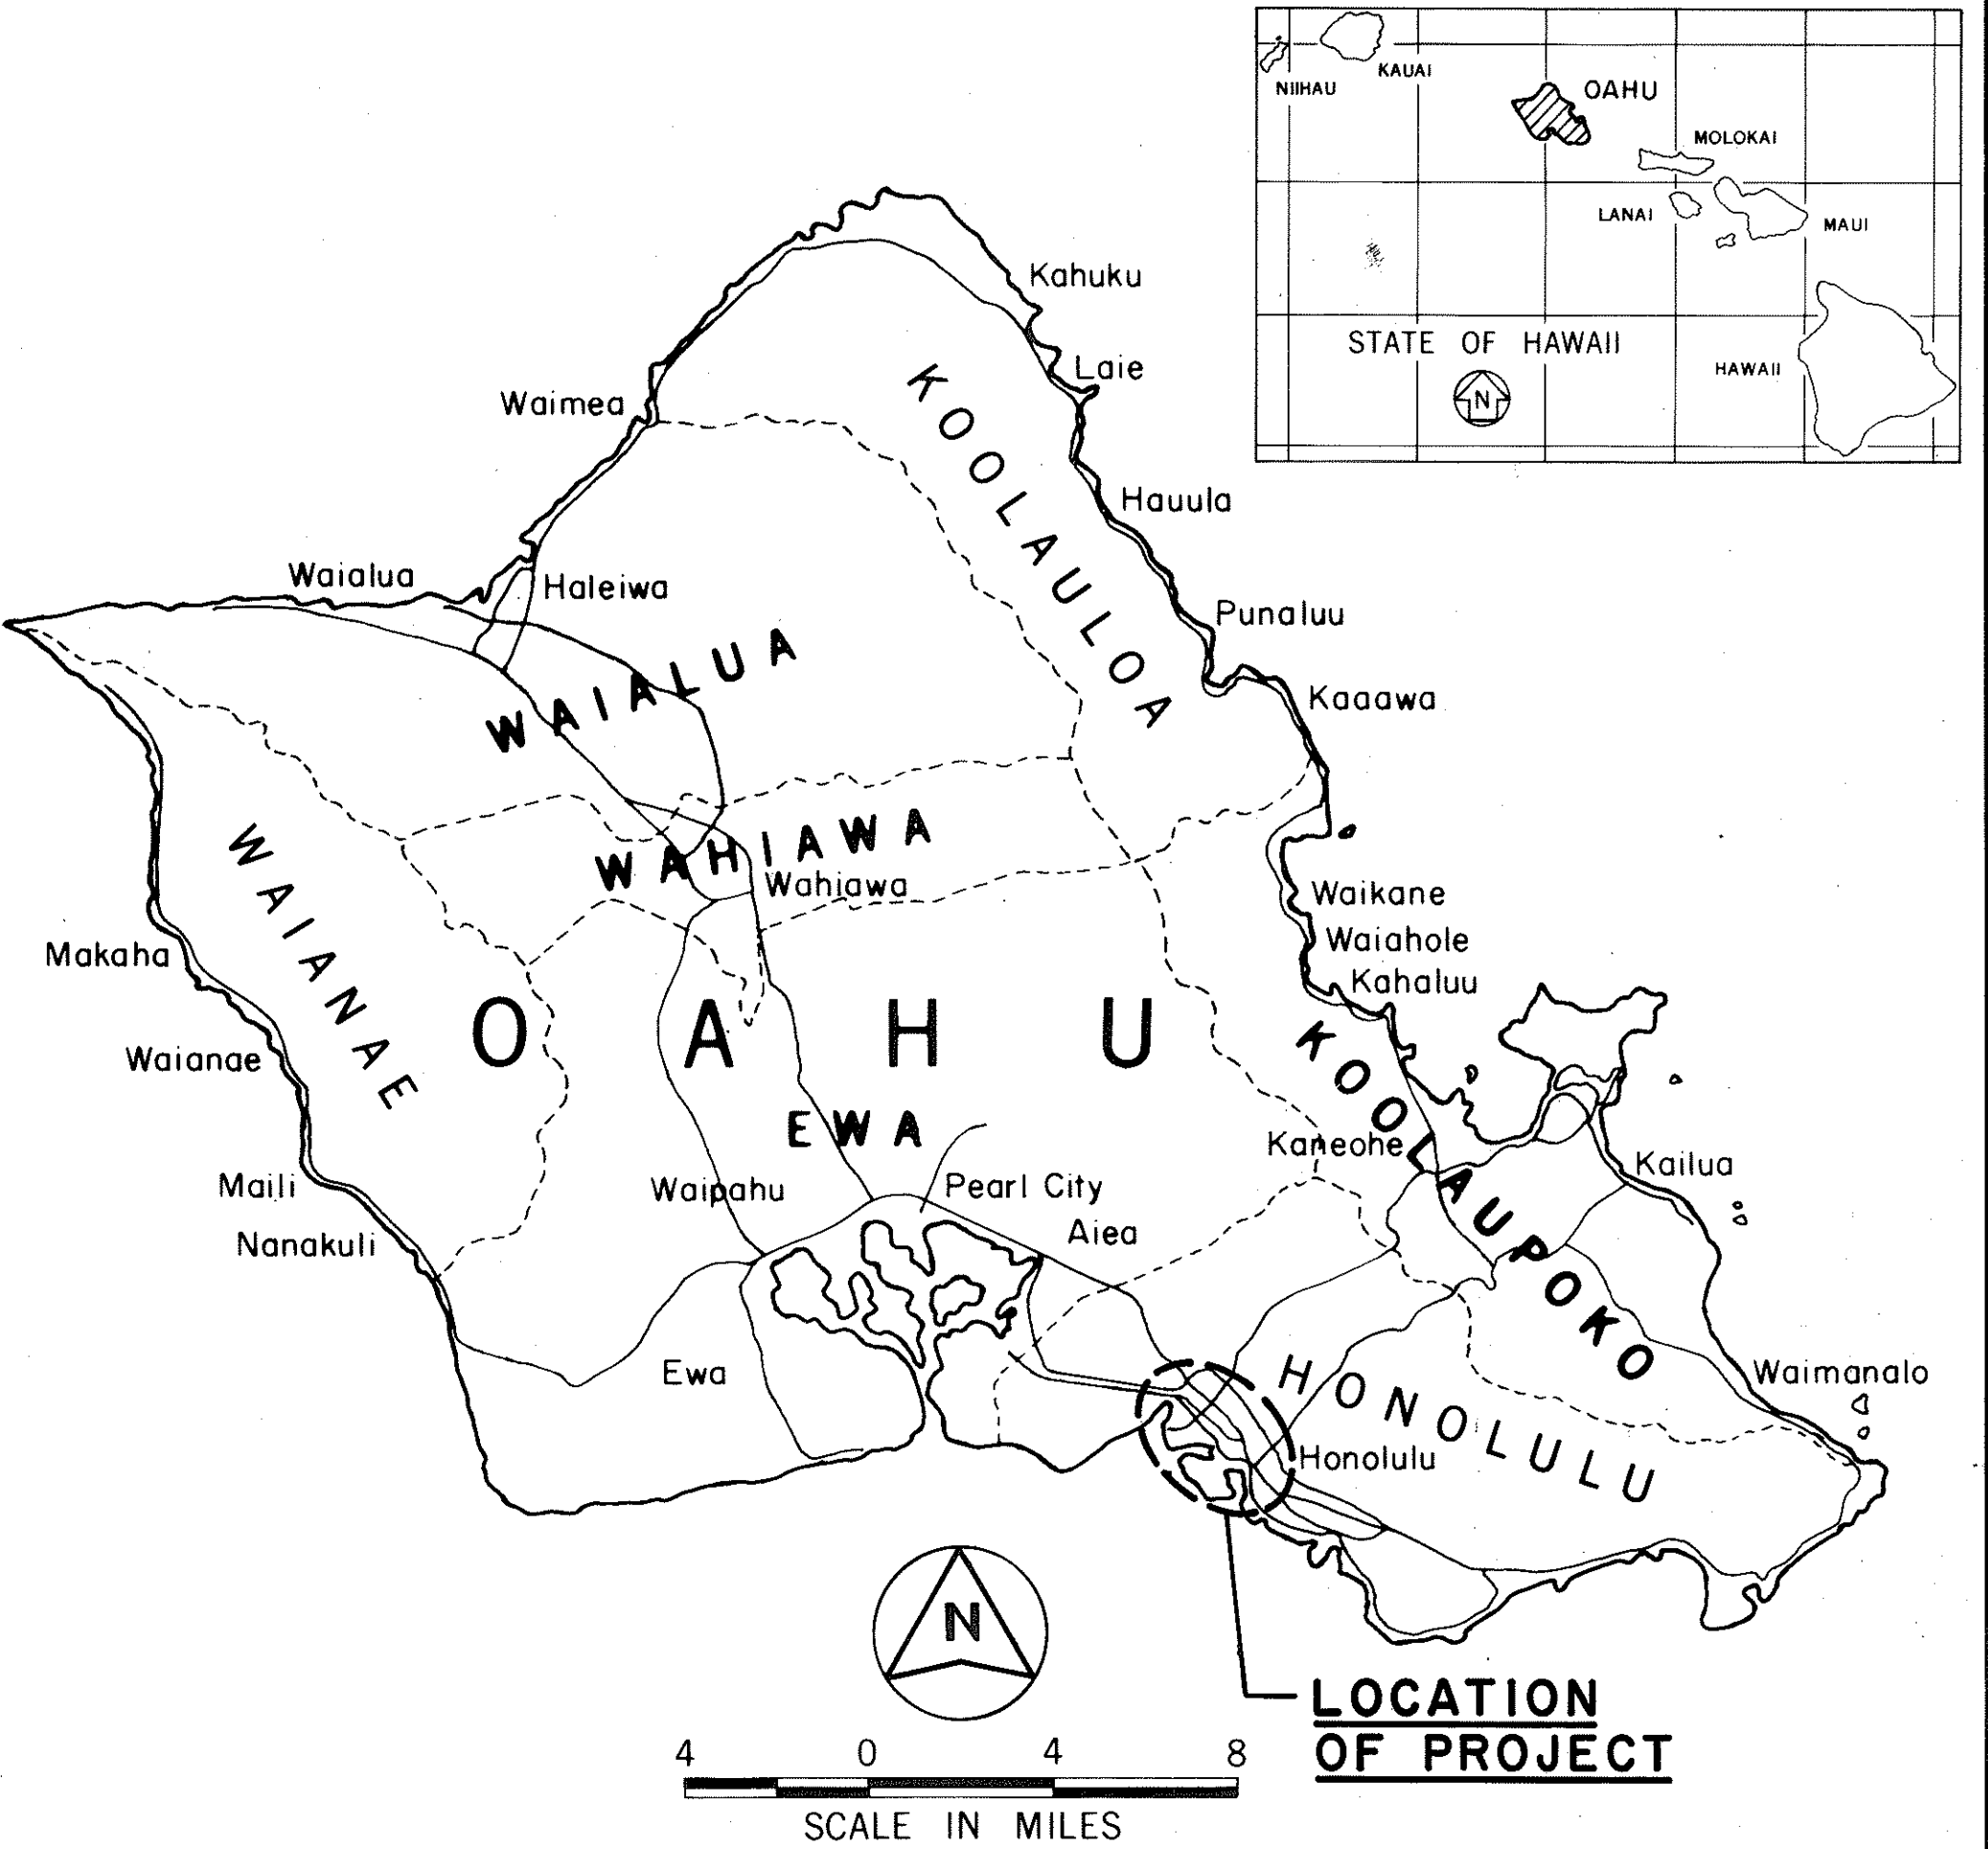

THIS IS A SUPPLEMENTAL SHEET.  
△ 10S-1  
NEW PLAN SHT. TOTAL = 24 SHTS.

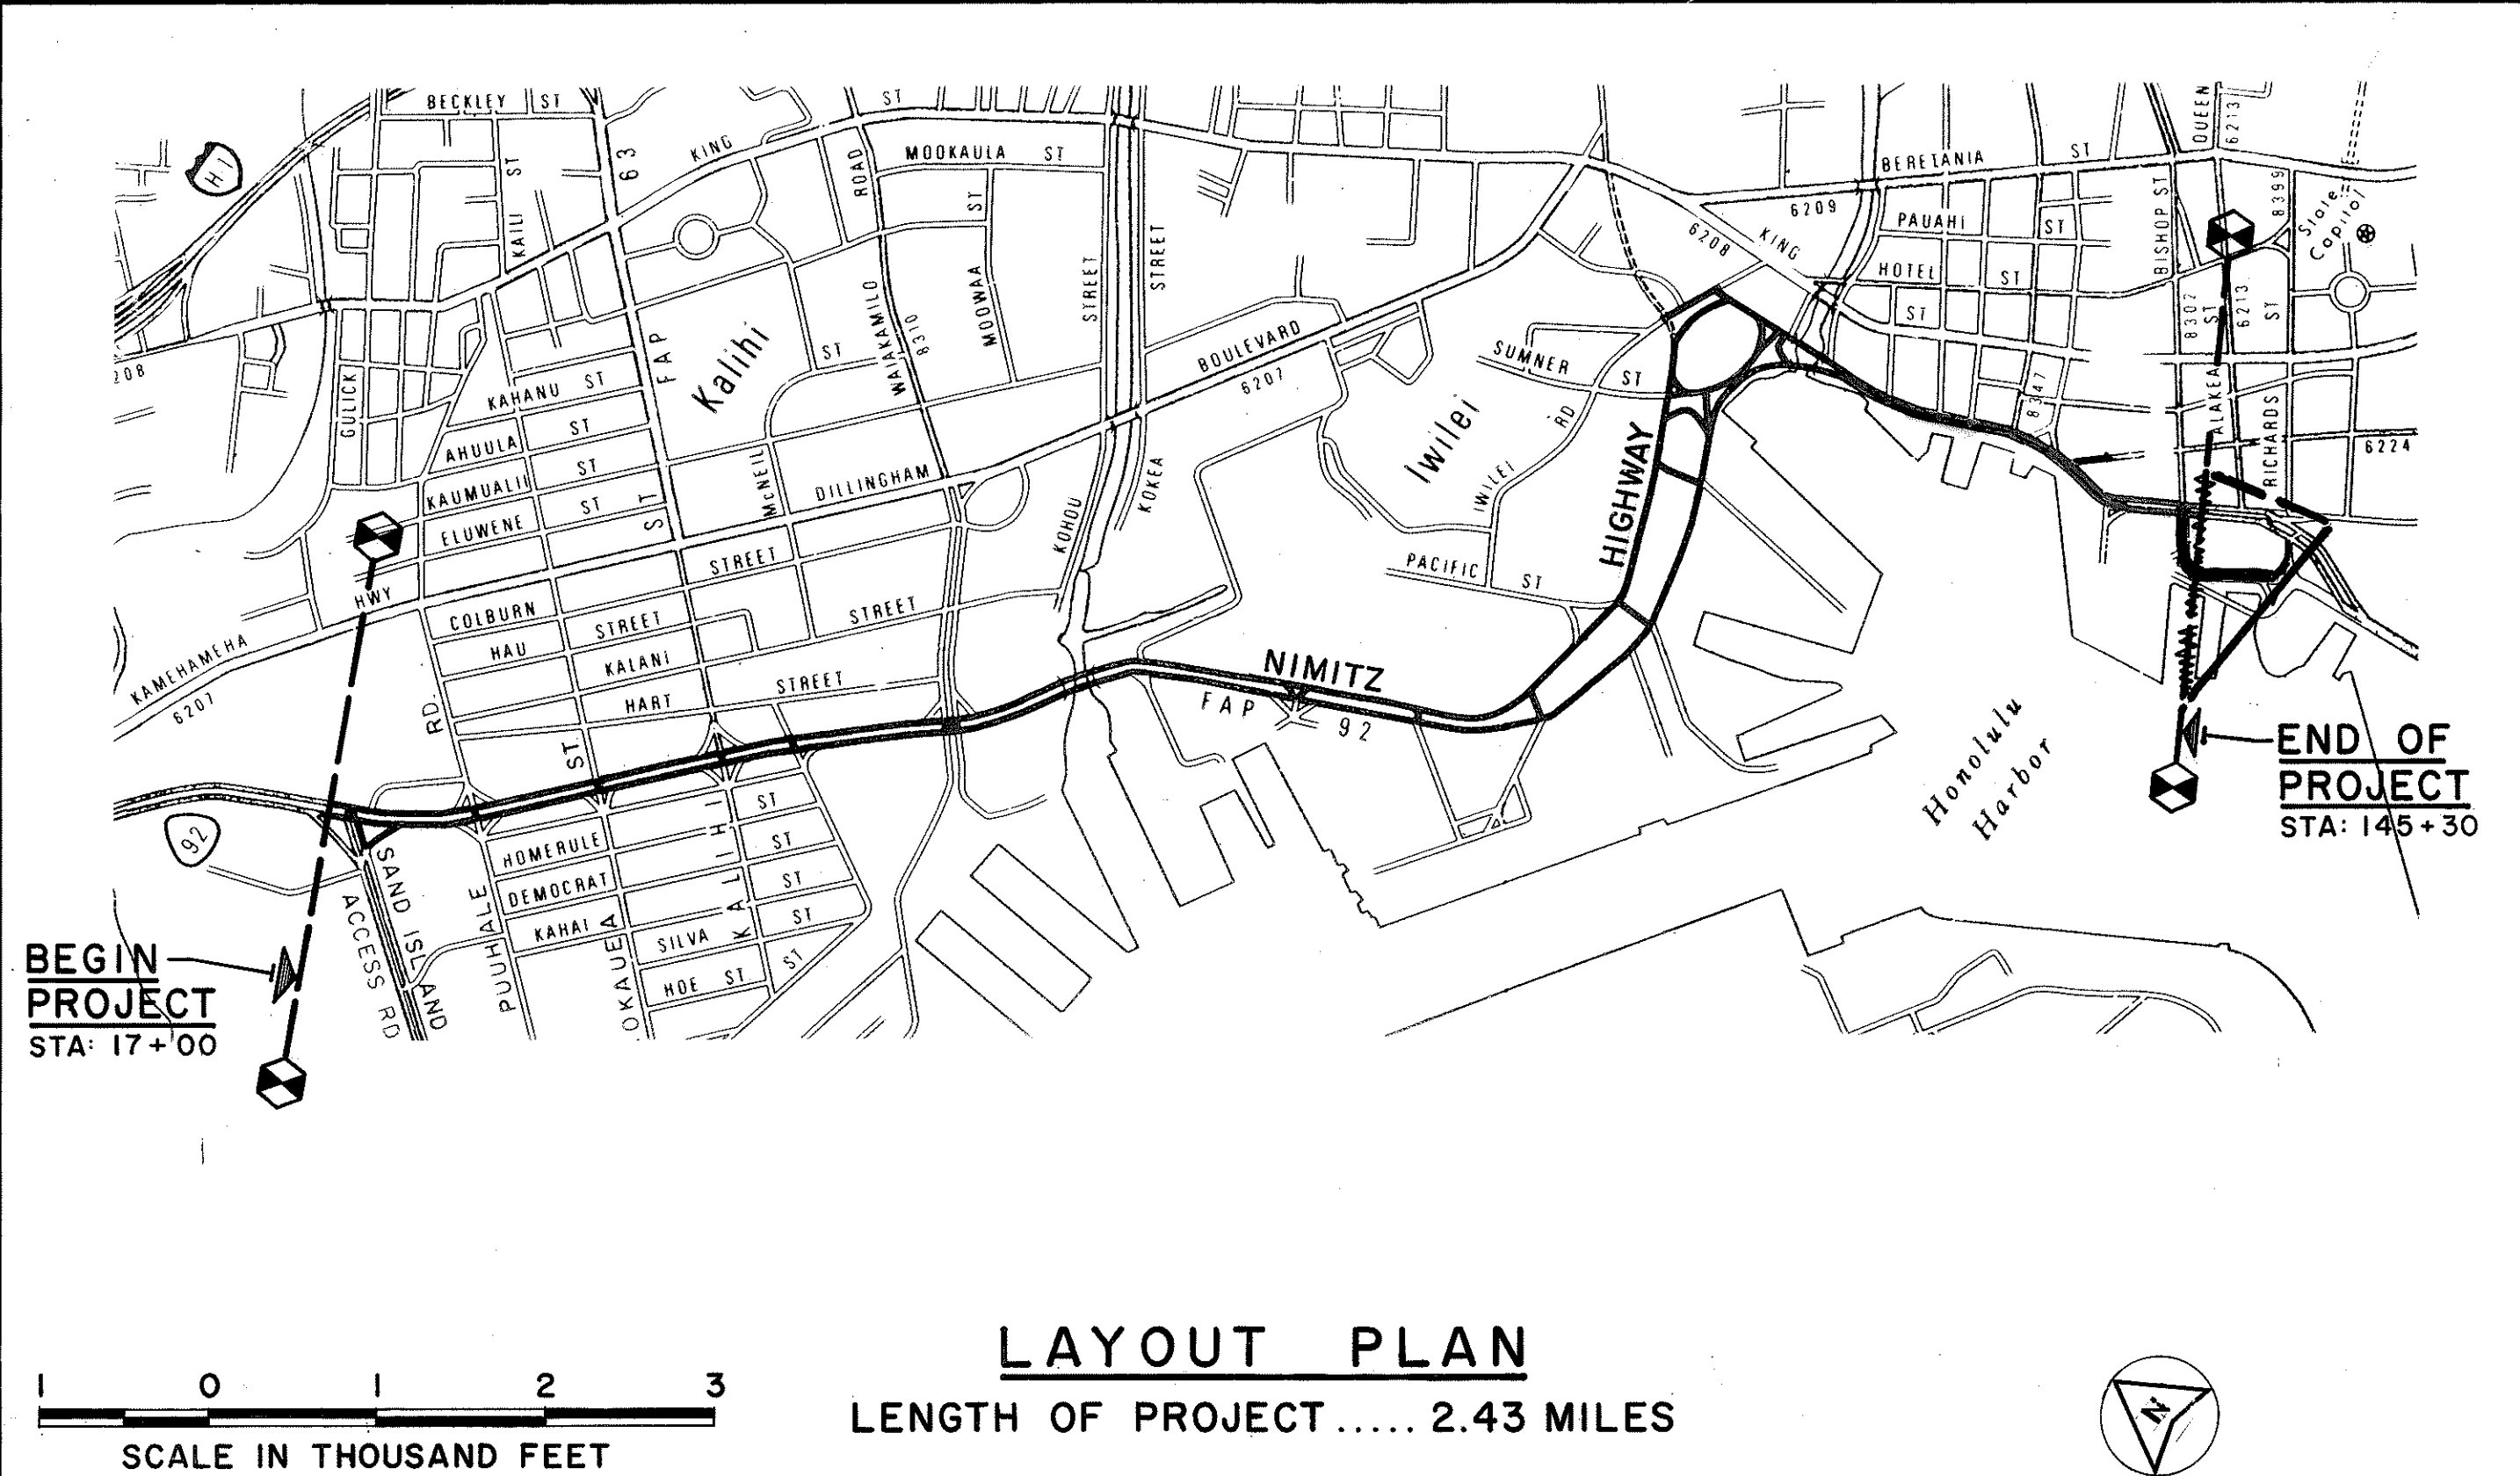

CHANGES MADE DURING CONSTRUCTION HAVE BEEN INCORPORATED ON THESE PLANS EXCEPT CHANGES IN THE ORIGINAL THEORETICAL QUANTITIES. FOR ACTUAL QUANTITIES, REFER TO PROJECT LEDGER AND/OR COMPUTATION BOOK.

*Walter B. Fournier*  
RESIDENT ENGINEER

*July 13, 1992*  
DATE

DEPARTMENT OF TRANSPORTATION  
STATE OF HAWAII  
APPROVED:  
*Elaine H.* 7/28/92  
DIR. OF TRANSPORTATION DATE

HO & OKITA, INC. DESIGNED BY  
FRED ABESHIMA  
548-4042  
7/17/87  
DATE  
P. S. & E. BY  
PHONE

DD-D-4-5