


INDEX TO DRAWINGS	
SHEET NO.	DESCRIPTION
1	TITLE SHEET, LOCATION MAP
2	ELECTRICAL SYMBOLS, SCHEDULE OF WORK, & GEN. NOTES
3	PARTIAL STREET LIGHT PLAN-PARTS I & II
4	PARTIAL STREET LIGHT PLAN-PARTS III & IV
5	PARTIAL STREET LIGHT PLAN-PARTS V & VI
6	PARTIAL STREET LIGHT PLAN-PART VII & VIII
7	STREET LIGHT DIAGRAM-PART I & 2
8	STREET LIGHT DIAGRAM-PART 3 & 4
9-10	MISCELLANEOUS DETAILS
11	MISCELLANEOUS DETAILS & SINGLE LINE DIAGRAMS

STATE OF HAWAII
DEPARTMENT OF TRANSPORTATION
HIGHWAYS DIVISION
HONOLULU, HAWAII
"AS-BUILT"
Plans For
HIGHWAY LIGHTING
IMPROVEMENTS & REHABILITATION
ALA MOANA BOULEVARD : KEAWE STREET To
ALA WAI CANAL


F.A. Project No. : NH - 092 - 1 (21)

DISTRICT of HONOLULU,
ISLAND of OAHU

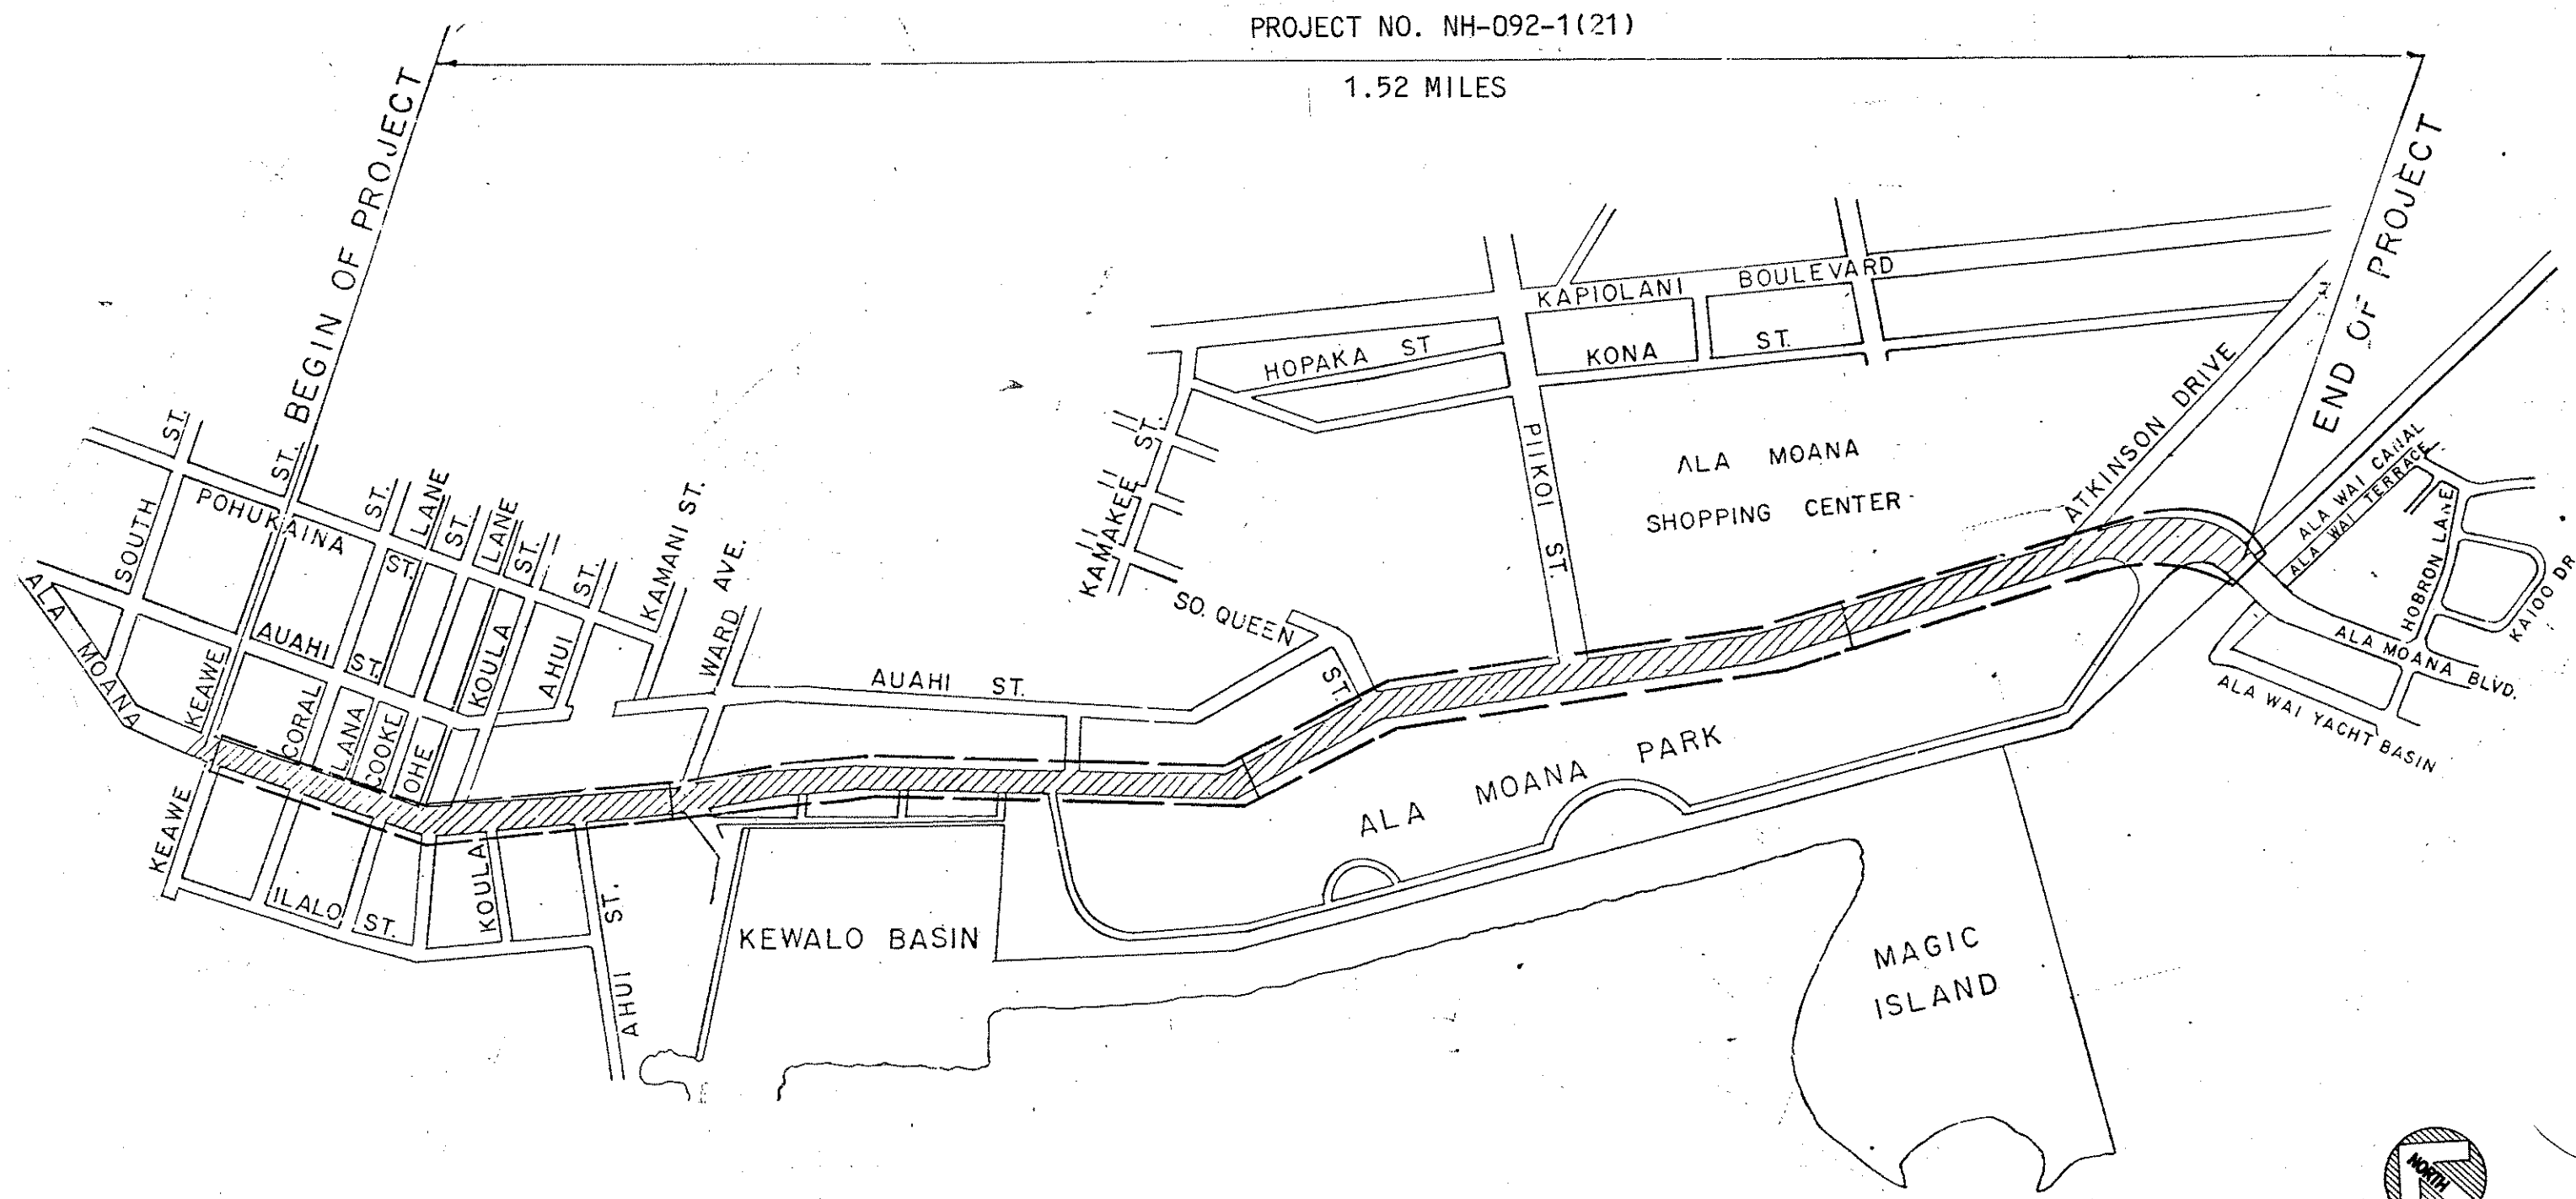

LOCATION MAP - ALA MOANA BOULEVARD
NOT TO SCALE

FED. ROAD DIST. NO.	STATE	FED. AID PROJ. NO.	FISCAL YEAR	SHEET NO.	TOTAL SHEETS
HAWAII	HAW.	NH-092-1(21)	1994	1	11

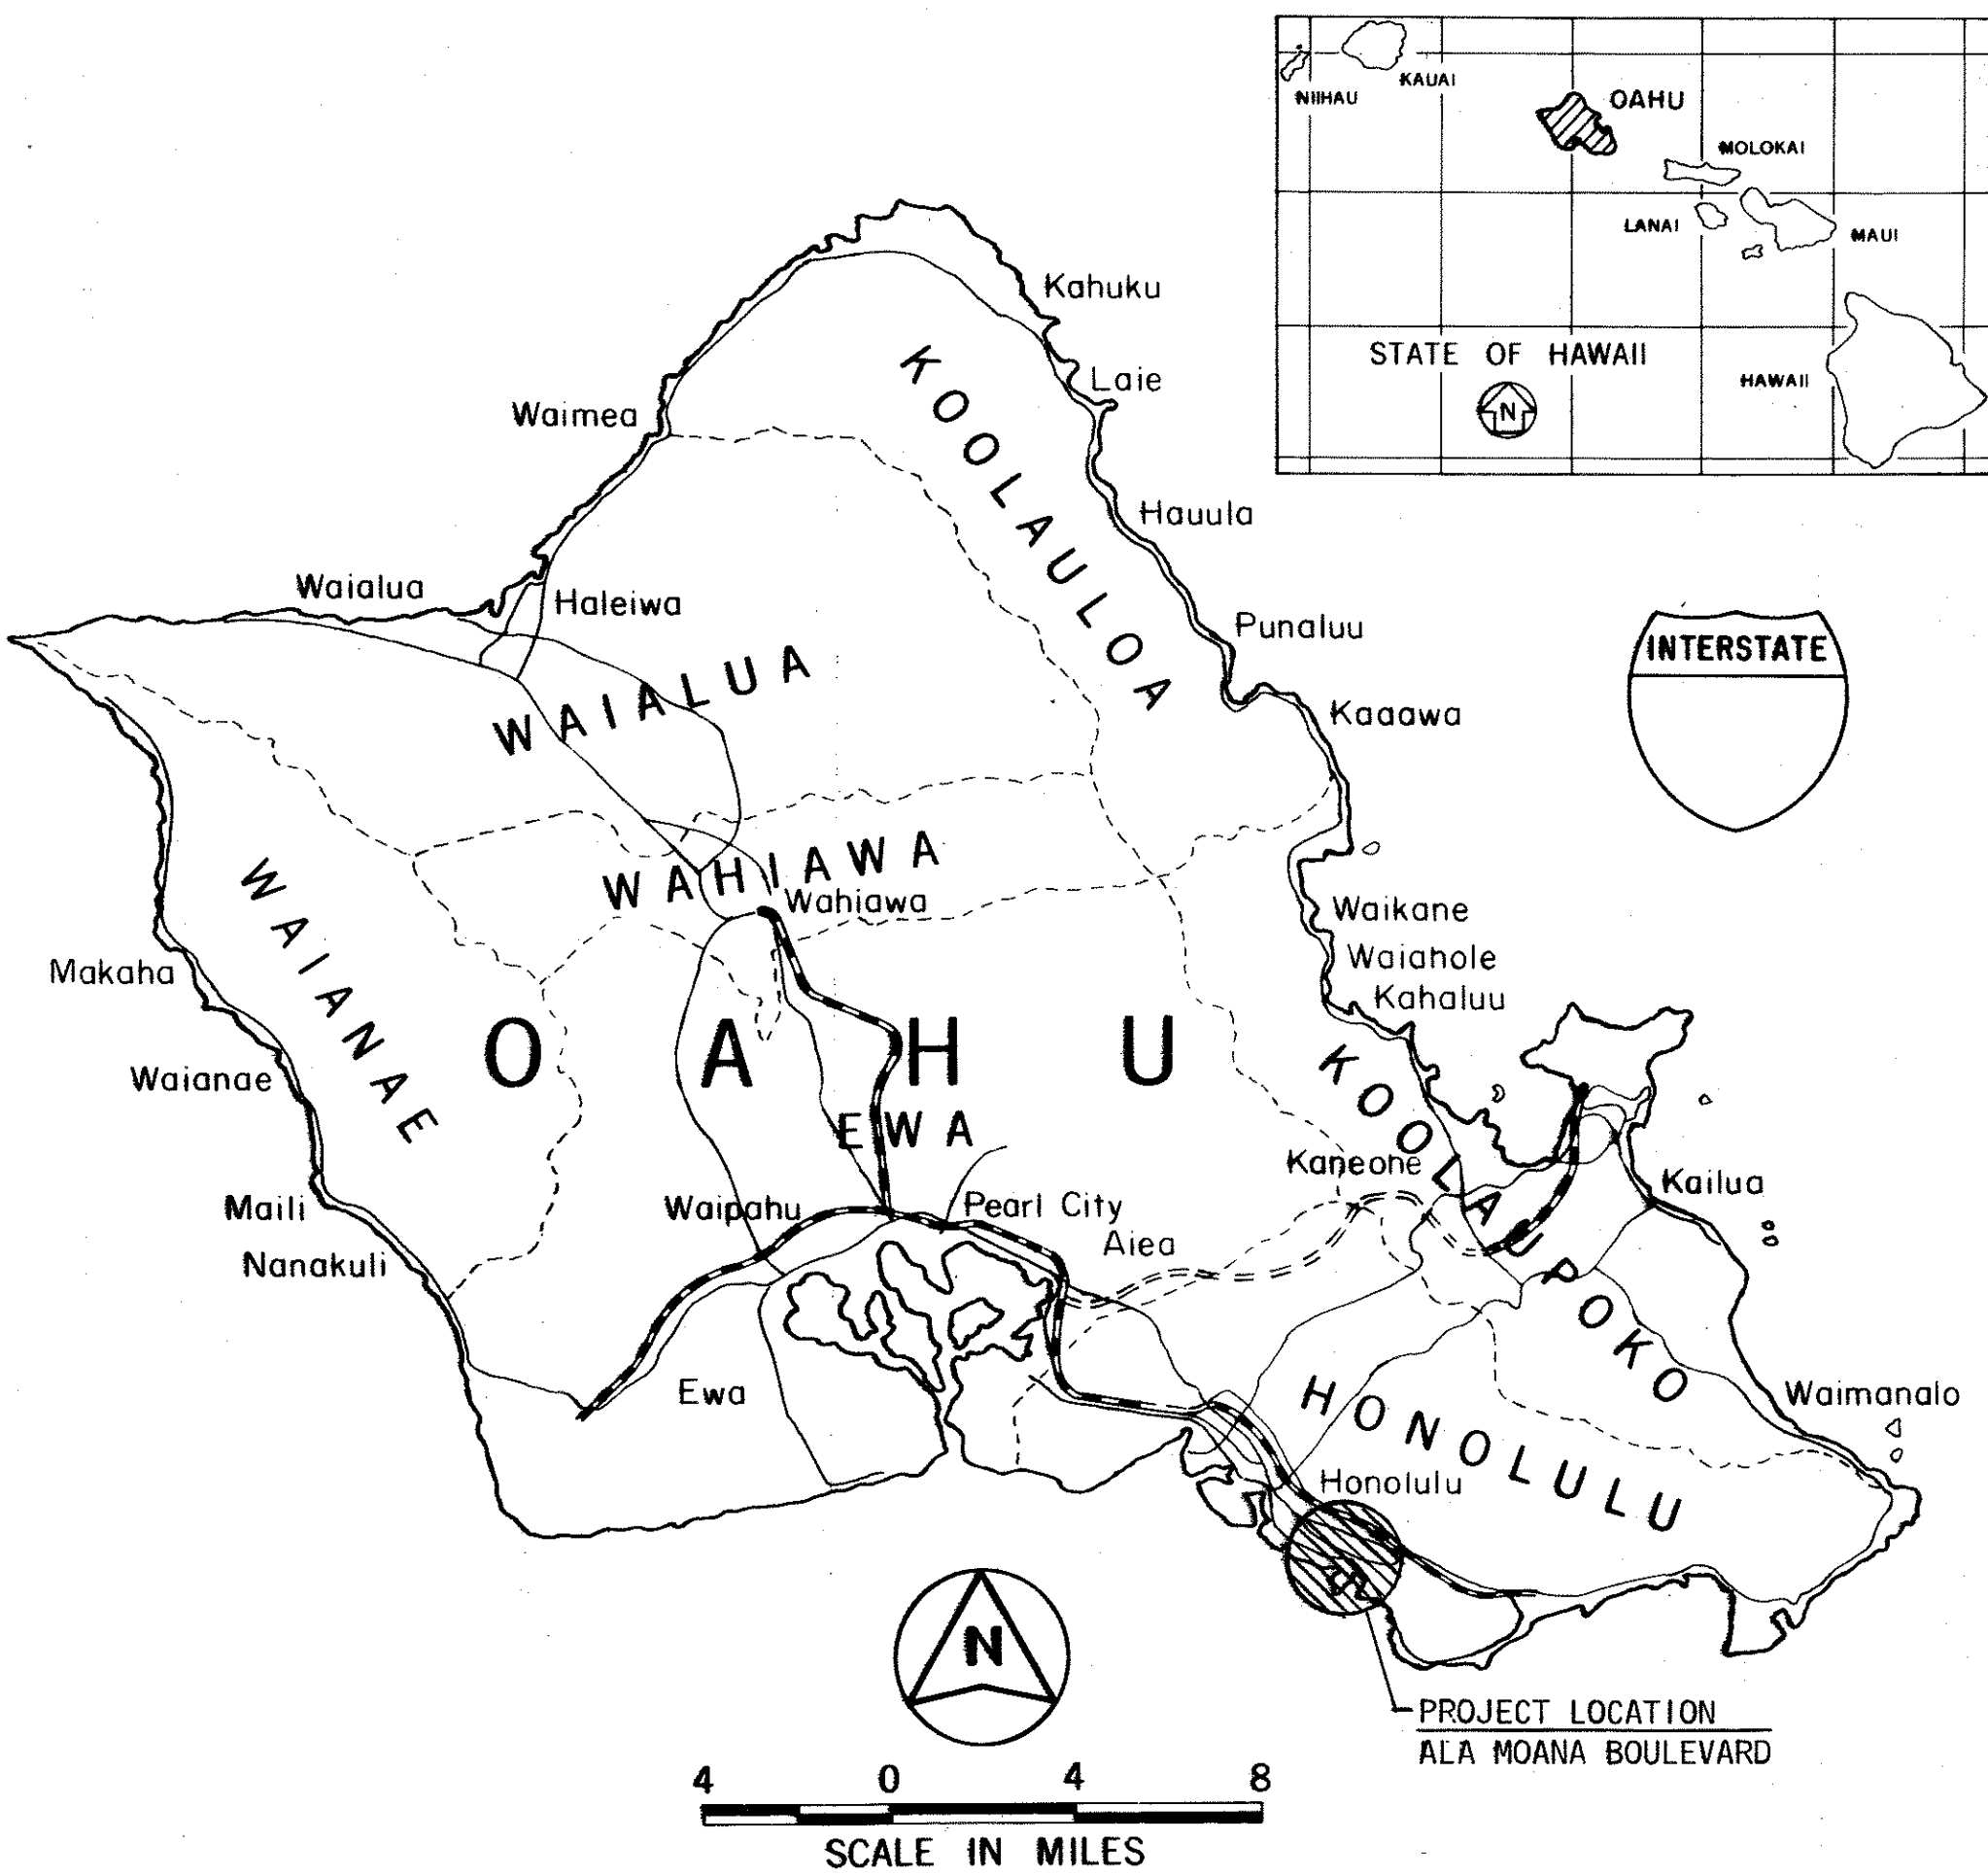

FEDERAL AID INTERSTATE PROJECTS PREVIOUSLY CONSTRUCTED OR UNDER CONSTRUCTION
MILE POST 7.00 TO MILE POST 8.52

CHANGES MADE DURING CONSTRUCTION HAVE BEEN INCORPORATED ON THESE PLANS EXCEPT CHANGES IN THE ORIGINAL THEORETICAL QUANTITIES. FOR ACTUAL QUANTITIES, REFER TO PROJECT LEDGER AND/OR COMPUTATION BOOK.

Signature 3/17/00
RESIDENT ENGINEER DATE

DEPARTMENT OF TRANSPORTATION
FEDERAL HIGHWAY ADMINISTRATION
APPROVED: *Signature* 3/23/00
DIVISION ADMINISTRATOR DATE

DEPARTMENT OF TRANSPORTATION
STATE OF HAWAII
APPROVED: *Signature* 5/23/00
FOR DIR. OF TRANSPORTATION DATE

DESIGNED BY
P. S. & E. BY
HERBERT TAO
587-2124
DATE