


INDEX TO DRAWING	
SHEET NO.	DESCRIPTION
2	TITLE SHEET
3	STANDARD PLANS SUMMARY
4 - 11	CONSTRUCTION NOTES
12	LEGEND
13 - 22	DEMOLITION PLANS
23 - 25	GENERAL PLANS
26 - 45	TYPICAL SECTIONS
46 - 55	ROADWAY PLANS
56 - 58	PAVEMENT MARKING & SIGNING PLANS
59 - 66	CURB RAMP GRADING PLANS
67 - 72	CURB RAMP DETAILS
73 - 74	DRIVEWAY GRADING PLANS
75	DRIVEWAY APRON DETAILS
76	TRAFFIC ISLAND DETAILS
77	MEDIAN DETAILS
78 - 80	ROADWAY DETAILS
81	DRAINAGE DETAILS
82	WATER DETAILS
83	IRRIGATION DETAILS
84	SEWER DETAILS
85	STRIPING DETAILS
86	MEDIAN BARRIER 4F
87 - 89	CRASH CUSHION DETAILS
90 - 91	CONSTRUCTION PHASING PLANS
92 - 109	TRAFFIC CONTROL PLANS
110	GENERAL NOTES
111	KEY MAP
112 - 114	PLAN-1 TO PLAN-6
115	HONOLULU HARBOR SLIP COVER PLAN AND ELEVATION
116 - 117	HONOLULU HARBOR SLIP COVER SECTIONS & DETAILS
118	HONOLULU HARBOR RETAINING WALL PLAN
119	HONOLULU HARBOR RETAINING WALL & ELEVATION
120 - 122	HONOLULU HARBOR RETAINING WALL SECTION AND DETAILS
123	NUUANU STREAM BRIDGE (E.B.) PLAN AND ELEVATION
124 - 126	NUUANU STREAM BRIDGE (E.B.) SECTIONS & DETAILS
127 - 128	SLIP COVER #1 - PLAN AND ELEVATION
129 - 131	SLIP COVER #1 - SECTIONS & DETAILS
132	SLIP COVER #2 - PLAN AND ELEVATION
133 - 135	SLIP COVER #2 - SECTIONS & DETAILS
136	SLIP COVER #3 - PLAN AND ELEVATION
137 - 139	SLIP COVER #3 - SECTIONS & DETAILS
140	SLIP COVER #4 - PLAN AND ELEVATION
141 - 142	SLIP COVER #4 - SECTIONS & DETAILS
143 - 144	BRIDGE RAILING SECTIONS & DETAILS
145 - 146	LIGHTING AND TRAFFIC SIGNAL POLE SUPPORT DETAILS
147	SIGN POST CONNECTIONS, TYPICAL DETAILS
148	CMU RETAINING WALL PLAN, ELEVATION AND SECTION
149	CATCH BASIN RETROFIT STA. 132+06
150 - 154	CATCH BASIN RETROFIT VARIOUS LOCATIONS
155	STANDARD SPALL REPAIR DETAILS
156 - 159	STRUCTURAL DEMOLITION PLANS
160 - 161	ELECTRICAL SITE PLAN I AND PLAN II
162	NOTES, UTILITY LEGEND, EQUIPMENT SCHEDULE
163	ELECTRICAL SYMBOLS

STATE OF HAWAII
DEPARTMENT OF TRANSPORTATION
HIGHWAYS DIVISION
HONOLULU, HAWAII
PLANS FOR
NIMITZ HIGHWAY REHABILITATION
SUMNER STREET TO QUEEN STREET
FEDERAL AID PROJECT NO. NH-092-1(25)

DISTRICT OF HONOLULU
ISLAND OF OAHU

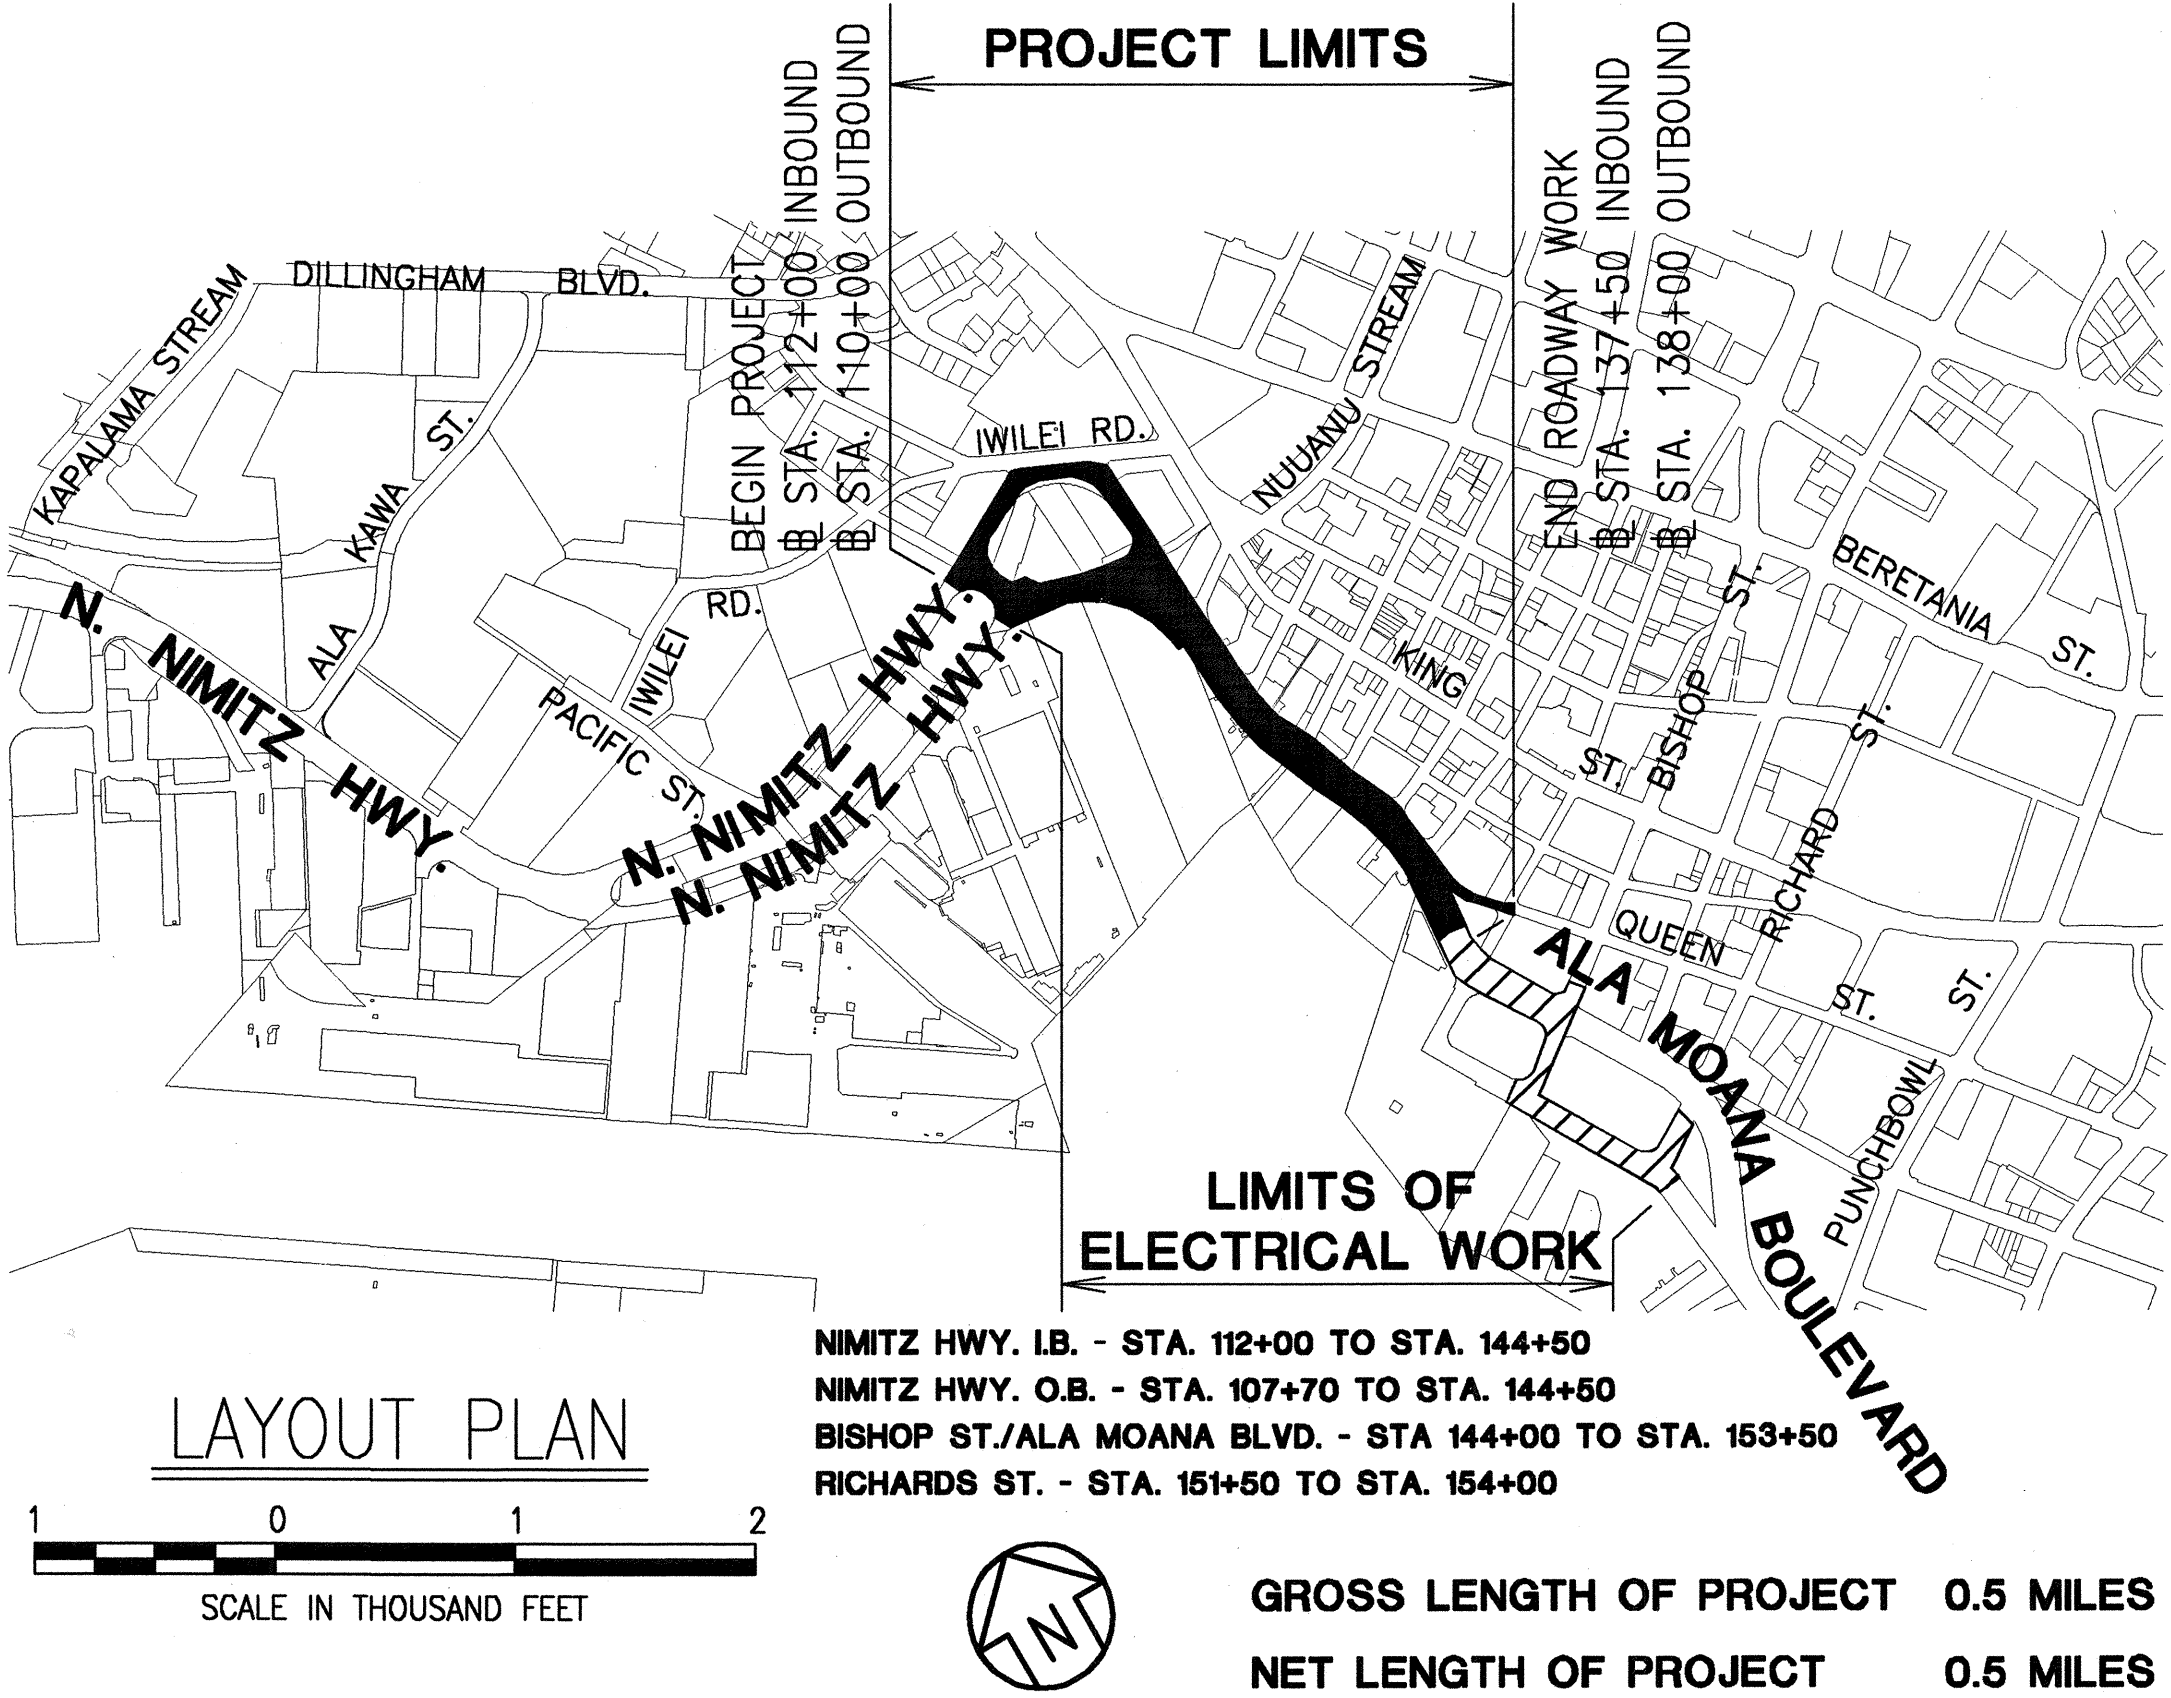

PROJECT LOCATION

Mile Post 5.8 to Mile Post 6.3




DESIGN DESIGNATION

ADT (2000)	83,000
DESIGN ADT (2020)	97,000
DHV	8,300
D	55/45
T	4.0%
T ₂₄	5.5%
V	35 M.P.H.

GROSS LENGTH OF PROJECT 0.5 MILES
NET LENGTH OF PROJECT 0.5 MILES

164 - 172	ELECTRICAL DEMOLITION PLANS	202	TYPICAL BACKFILL SECTIONS
173 - 181	ELECTRICAL DISTRIBUTION PLANS	203	SERVICE EQUIPMENT ELEVATION DETAIL & DIAGRAM
182 - 190	HIGHWAY LIGHTING & TRAFFIC SIGNAL PLAN I TO PLAN IX	204 - 207	HIGHWAY LIGHT CONNECTION DIAGRAMS
191 - 196	HIGHWAY LIGHTING PLANS	208 - 211	HIGHWAY LIGHT DETAILS
197	NIMITZ HIGHWAY/RIVER STREET TRAFFIC SIGNAL PLAN	212 - 218	TRAFFIC SIGNAL DETAILS
198	NIMITZ HIGHWAY/SMITH STREET TRAFFIC SIGNAL PLAN	219	LOOP DETECTOR DETAILS
199	NIMITZ HIGHWAY/NUUANU AVENUE AND BETHEL STREET TRAFFIC SIGNAL PLAN	220 - 221	PULLBOX DETAILS
200	TRAFFIC SIGNAL SCHEDULES AND DIAGRAMS	222 - 224	MISCELLANEOUS DETAILS
201	HIGHWAY LIGHTING VAULT DEMOLITION & ELECTRICAL PLANS	225	TYPICAL DUCT SECTIONS, CONDUIT SCHEDULE

FED. ROAD DIST. NO.	STATE	FED. AID PROJ. NO.	FISCAL YEAR	SHEET NO.	TOTAL SHEETS
HAWAII	HAW.	NH-092-1(25)	2002	2	246

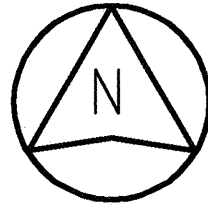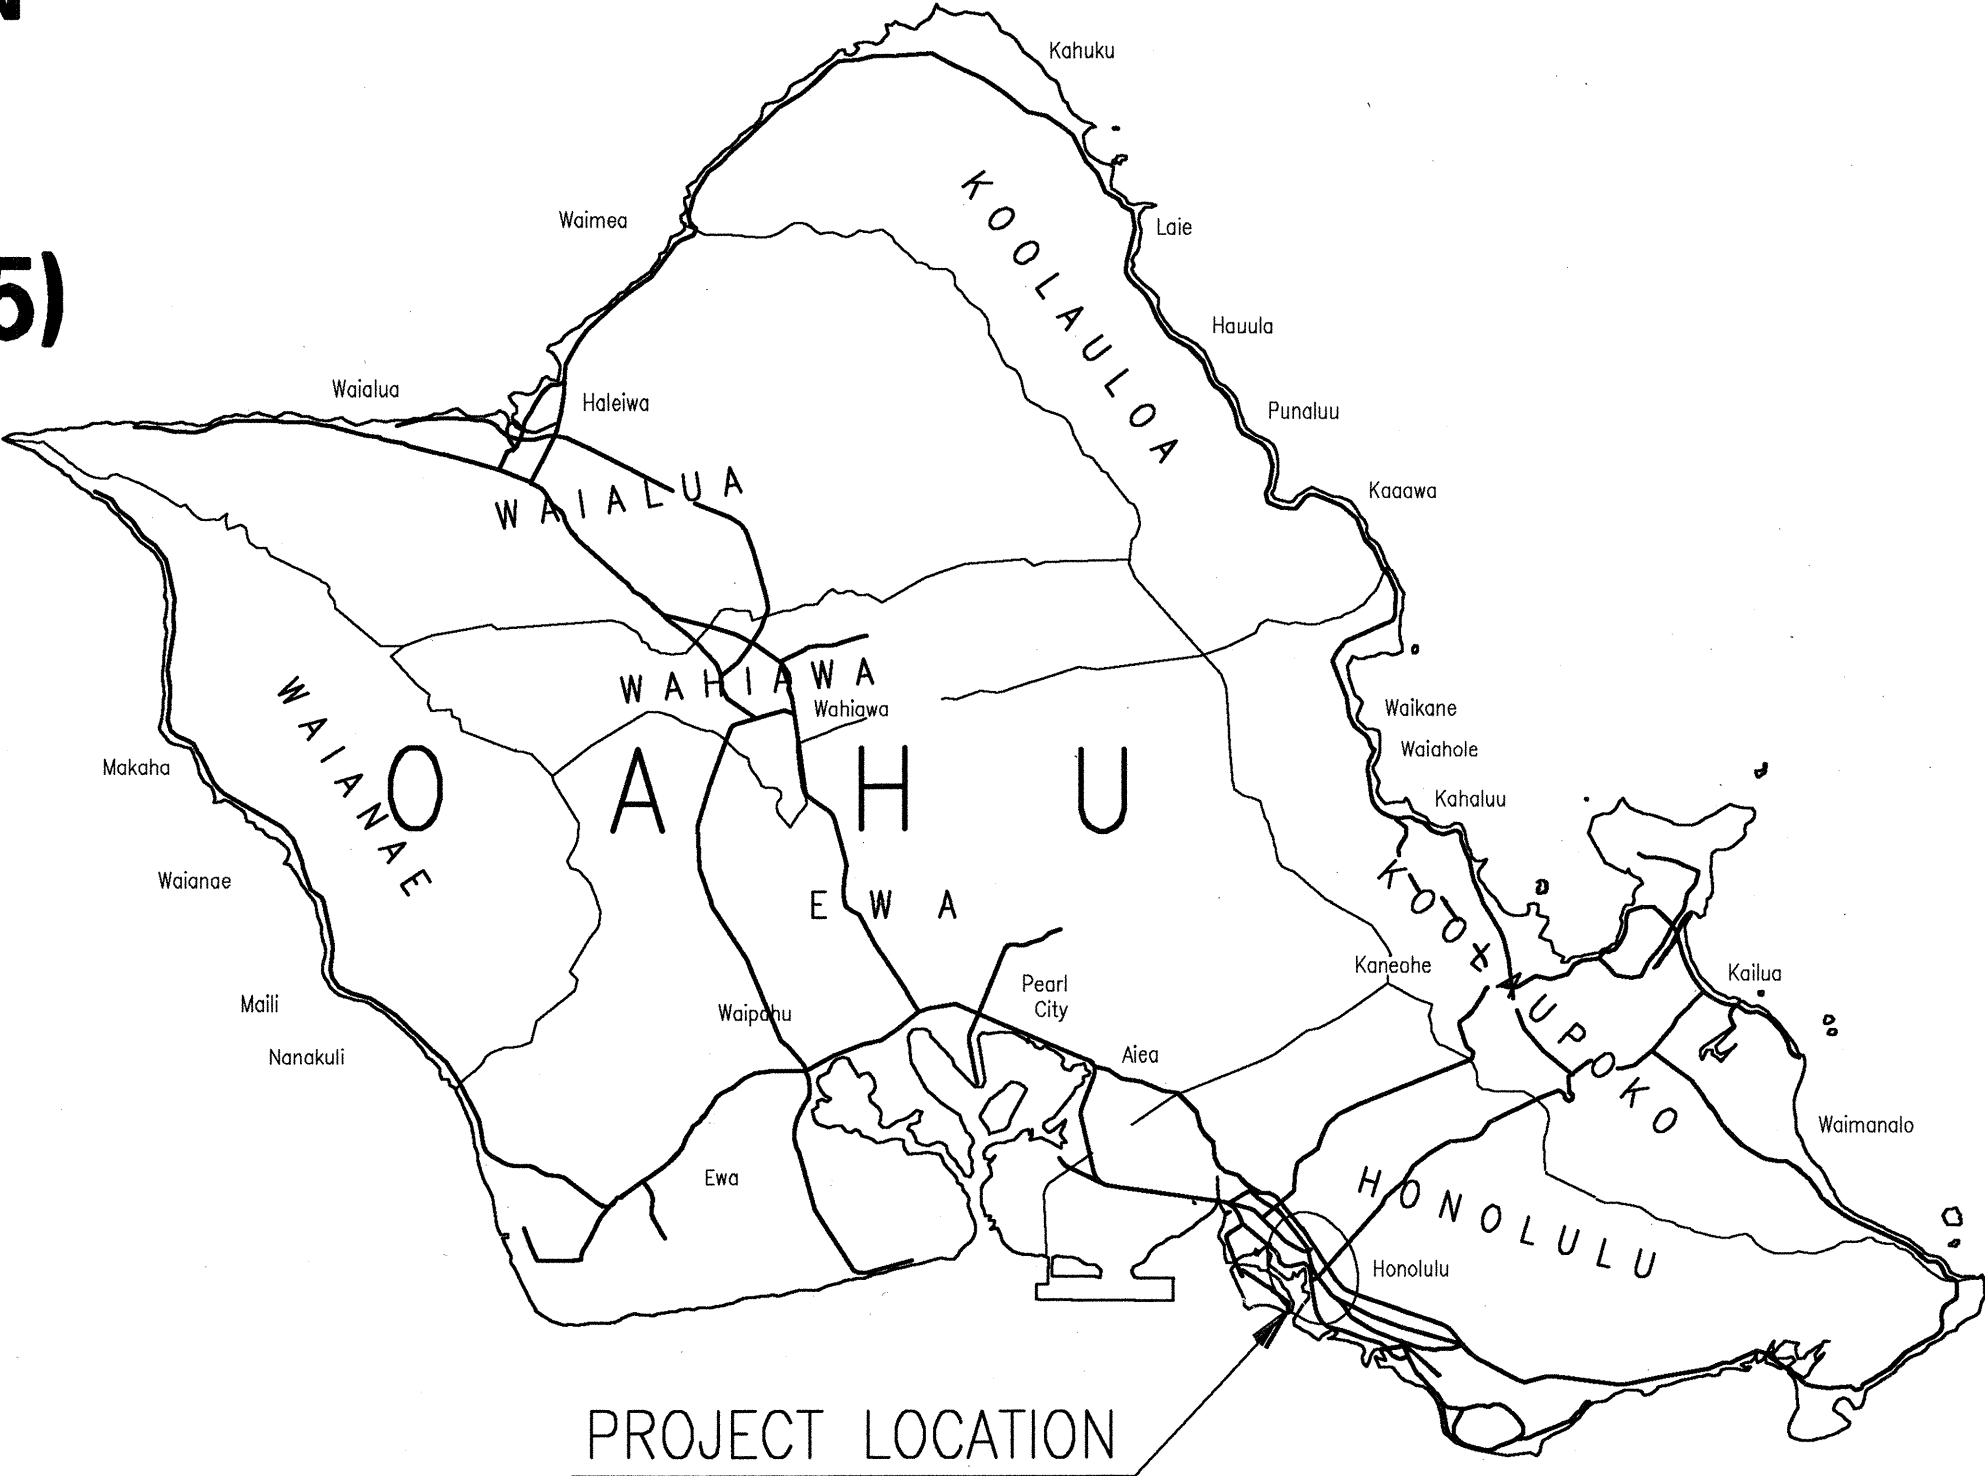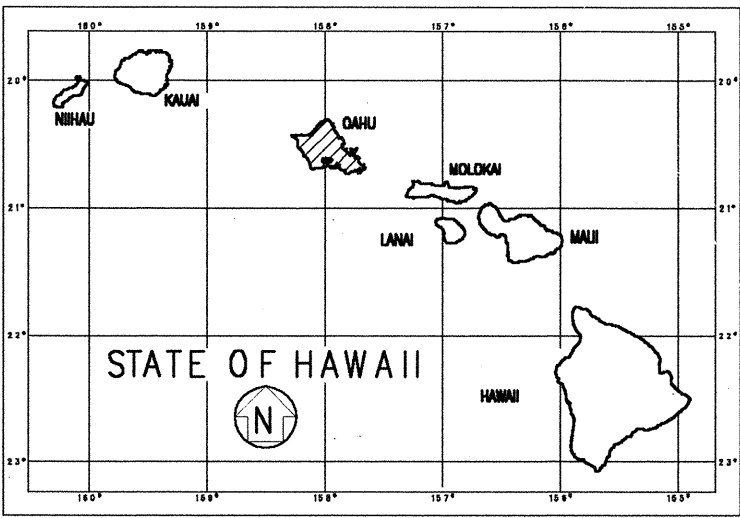

SCALE IN MILES

DEPARTMENT OF TRANSPORTATION STATE OF HAWAII	
APPROVED: <i>[Signature]</i> DIR. OF TRANSPORTATION	10/17/01 DATE

SURVEY PLOTTED BY	DATE
DRAWN BY	
NOTED BY	
CHECKED BY	

R.M. TOWILL CORP. 692-7581
DESIGNED BY Sean Hiraoka P. S. & E. BY PHONE DATE