


| FED. ROAD DIST. NO. | STATE | PROJ. NO.   | FISCAL YEAR | SHEET NO. | TOTAL SHEETS |
|---------------------|-------|-------------|-------------|-----------|--------------|
| HAWAII              | HAW.  | 92AB-01-06M | 2006        | 18R       | 74           |

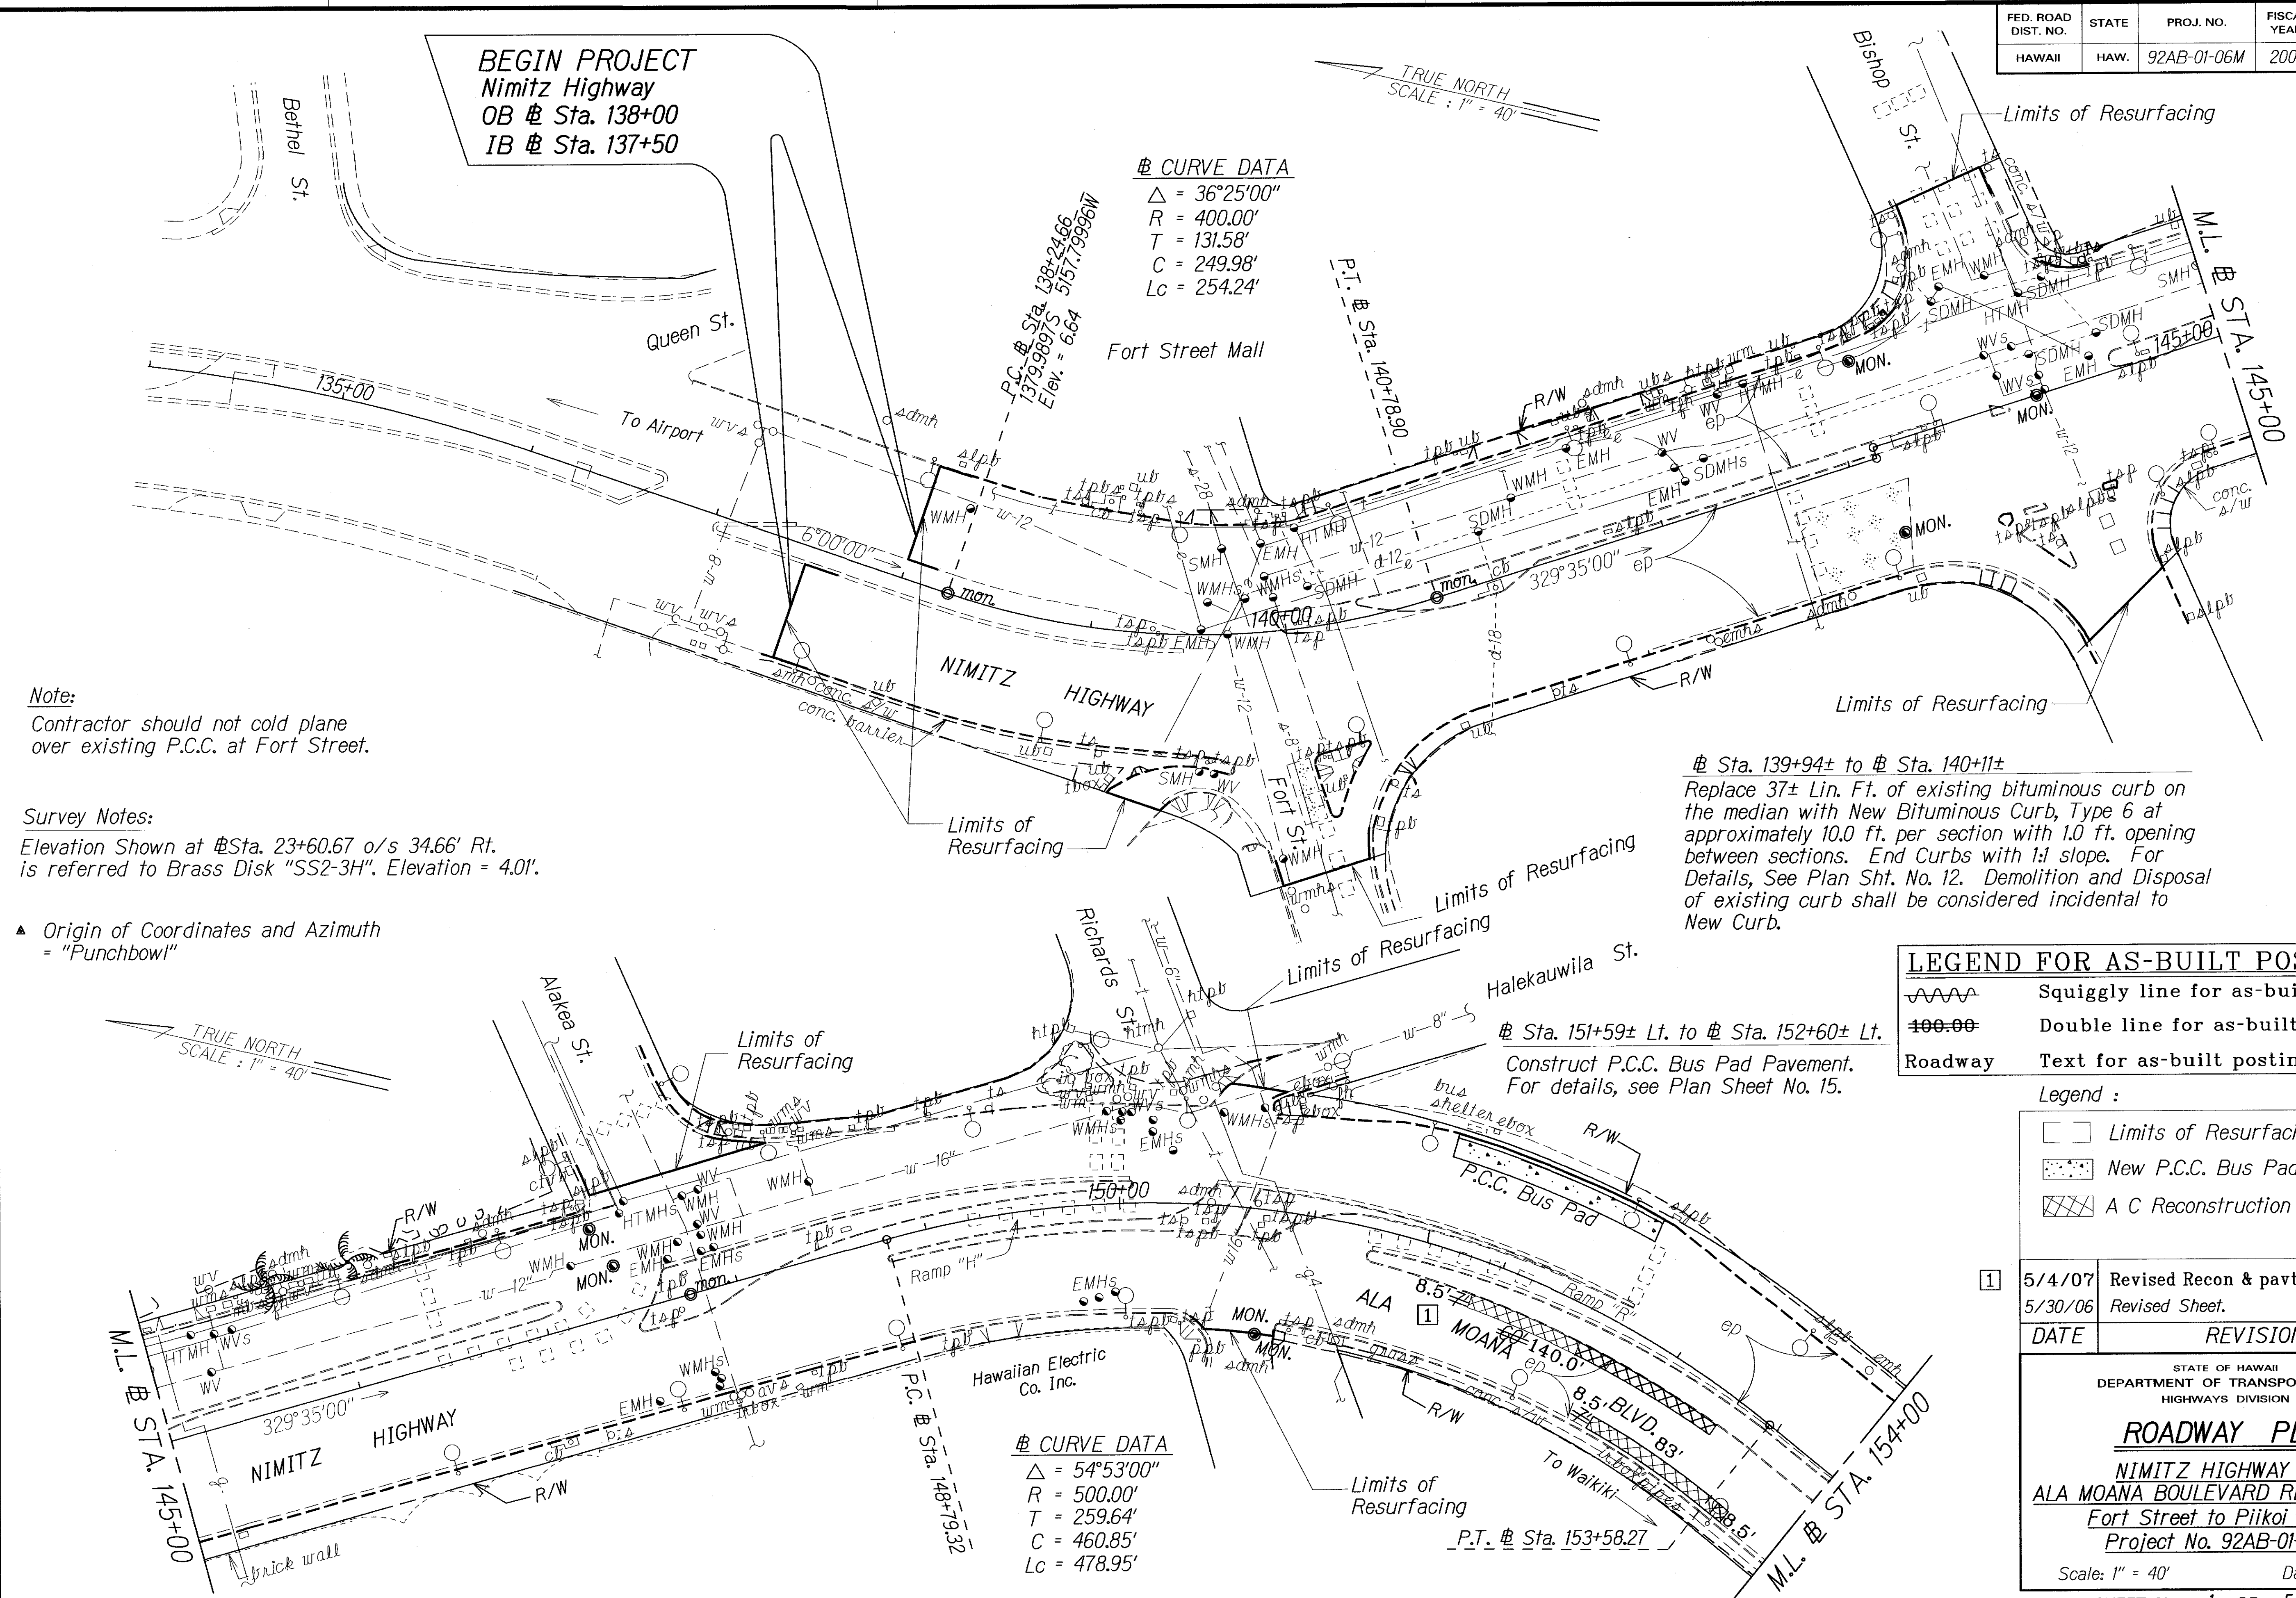

Note:  
Contractor should not cold plane over existing P.C.C. at Fort Street.

Survey Notes:  
Elevation Shown at #Sta. 23+60.67 o/s 34.66' Rt. is referred to Brass Disk "SS2-3H". Elevation = 4.01'.


▲ Origin of Coordinates and Azimuth = "Punchbowl"

# Sta. 139+94± to # Sta. 140+11±  
Replace 37± Lin. Ft. of existing bituminous curb on the median with New Bituminous Curb, Type 6 at approximately 10.0 ft. per section with 1.0 ft. opening between sections. End Curbs with 1:1 slope. For Details, See Plan Sht. No. 12. Demolition and Disposal of existing curb shall be considered incidental to New Curb.
 
# Sta. 151+59± Lt. to # Sta. 152+60± Lt.  
Construct P.C.C. Bus Pad Pavement. For details, see Plan Sheet No. 15.

|                   |        |
|-------------------|--------|
| SURVEY PLOTTED BY | DATE   |
| DRAWN BY          | 7/6/06 |
| DESIGNED BY       |        |
| CHECKED BY        |        |
| ORIGINAL PLAN     |        |
| NOTE BOOK         |        |
| DATE              |        |

"AS-BUILT"

|                                                                                                                                                                                                                                                                                                                                                                                                                                                                                                                               |                                                                                                                                                                                                                                                                                                                                                                                                                                                                                                                                    |                                                                                                                                                                                                                                                                                                                                                            |
|-------------------------------------------------------------------------------------------------------------------------------------------------------------------------------------------------------------------------------------------------------------------------------------------------------------------------------------------------------------------------------------------------------------------------------------------------------------------------------------------------------------------------------|------------------------------------------------------------------------------------------------------------------------------------------------------------------------------------------------------------------------------------------------------------------------------------------------------------------------------------------------------------------------------------------------------------------------------------------------------------------------------------------------------------------------------------|------------------------------------------------------------------------------------------------------------------------------------------------------------------------------------------------------------------------------------------------------------------------------------------------------------------------------------------------------------|
| <p>1. <del>Sta. 154+83 Rt. to Sta. 155+06± Rt.</del><br/> <del>Install traffic counting station and HECO equipment.</del><br/> <del>For details, see electrical plan sheets. For grading</del><br/> <del>and landscaping details, see Plan Sheet Nos. C.O. 74</del><br/> <del>S-1 AND C.O. 74 S-2.</del></p> <p>Sta. 159+70± Lt. to Sta. 160+40± Lt.<br/> Sta. 162+64± Rt. to Sta. 163+34± Rt.<br/> Sta. 18+41' Rt. to Sta. 19+11± Rt.</p> <p>Construct P.C.C. Bus Pad Pavement.<br/> For details, see Plan Sheet No. 15.</p> | <p>Sta. 22+69± Lt. to Sta. 23+11± Lt.<br/> Sta. 23+44± Lt. to Sta. 24+50± Lt.<br/> Sta. 162+38± Rt. to Sta. 162+64± Rt.<br/> Sta. 12+48± Rt. to Sta. 12+93± Rt.<br/> Sta. 14+69± Rt. to Sta. 18+41± Rt.<br/> Sta. 19+33± Rt. to Sta. 19+63± Rt.</p> <p>Reconstruct Gutter, Type 2A.<br/> Demolition and Disposal of existing gutter<br/> and Resetting of existing lava rock curb shall<br/> be considered incidental to New Gutter, Type 2A.<br/> For details of resetting exist. lava rock curb,<br/> see Plan Sheet No. 14.</p> | <p>Sta. 19+95± Lt. to Sta. 22+69± Lt.</p> <p>Construct New Curb and Gutter, Type 2DG.<br/> Demolition and Disposal of existing curb and gutter<br/> shall be considered incidental to New Curb and<br/> Gutter, Type 2DG.<br/> For details, see Plan Sheet No. 14.</p>  |
|-------------------------------------------------------------------------------------------------------------------------------------------------------------------------------------------------------------------------------------------------------------------------------------------------------------------------------------------------------------------------------------------------------------------------------------------------------------------------------------------------------------------------------|------------------------------------------------------------------------------------------------------------------------------------------------------------------------------------------------------------------------------------------------------------------------------------------------------------------------------------------------------------------------------------------------------------------------------------------------------------------------------------------------------------------------------------|------------------------------------------------------------------------------------------------------------------------------------------------------------------------------------------------------------------------------------------------------------------------------------------------------------------------------------------------------------|

$T = 11.44'$   
 $C = 149.88'$   
 $Lc = 151.46'$

Plan view of the bridge deck showing the layout of the bridge deck, including the centerline, lane markings, and various structures like the rock curb, bus shelter, and tile wall. The drawing includes dimensions and labels for various components.


channel

conc. wall

1

Forrest

Legend :

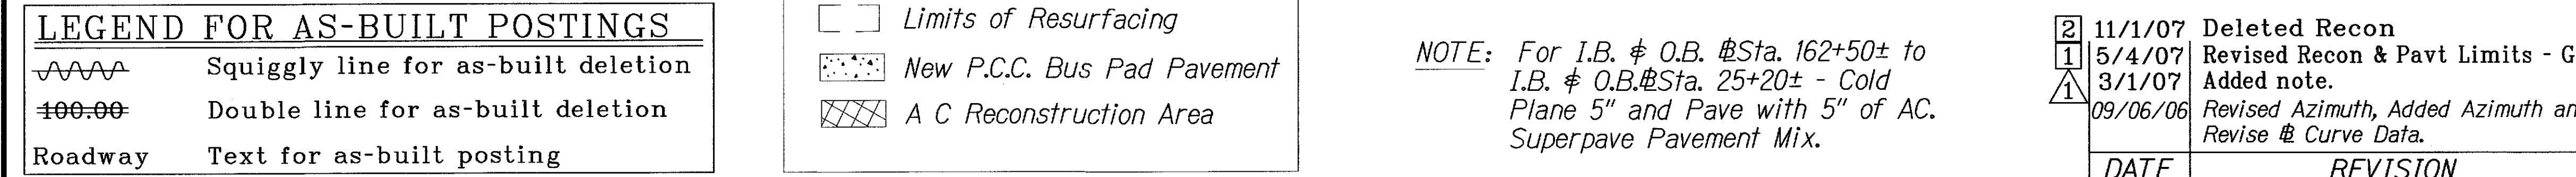


|  |  |  |            |
|--|--|--|------------|
|  |  |  | "AS-BUILT" |
|--|--|--|------------|

\_\_\_\_\_

\_\_\_\_\_

\_\_\_\_\_


| FED. ROAD DIST. NO. | STATE | PROJ. NO.   | FISCAL YEAR | SHEET NO. | TOTAL SHEETS |
|---------------------|-------|-------------|-------------|-----------|--------------|
| HAWAII              | HAW.  | 92AB-01-06M | 2006        | 20R       | 74           |

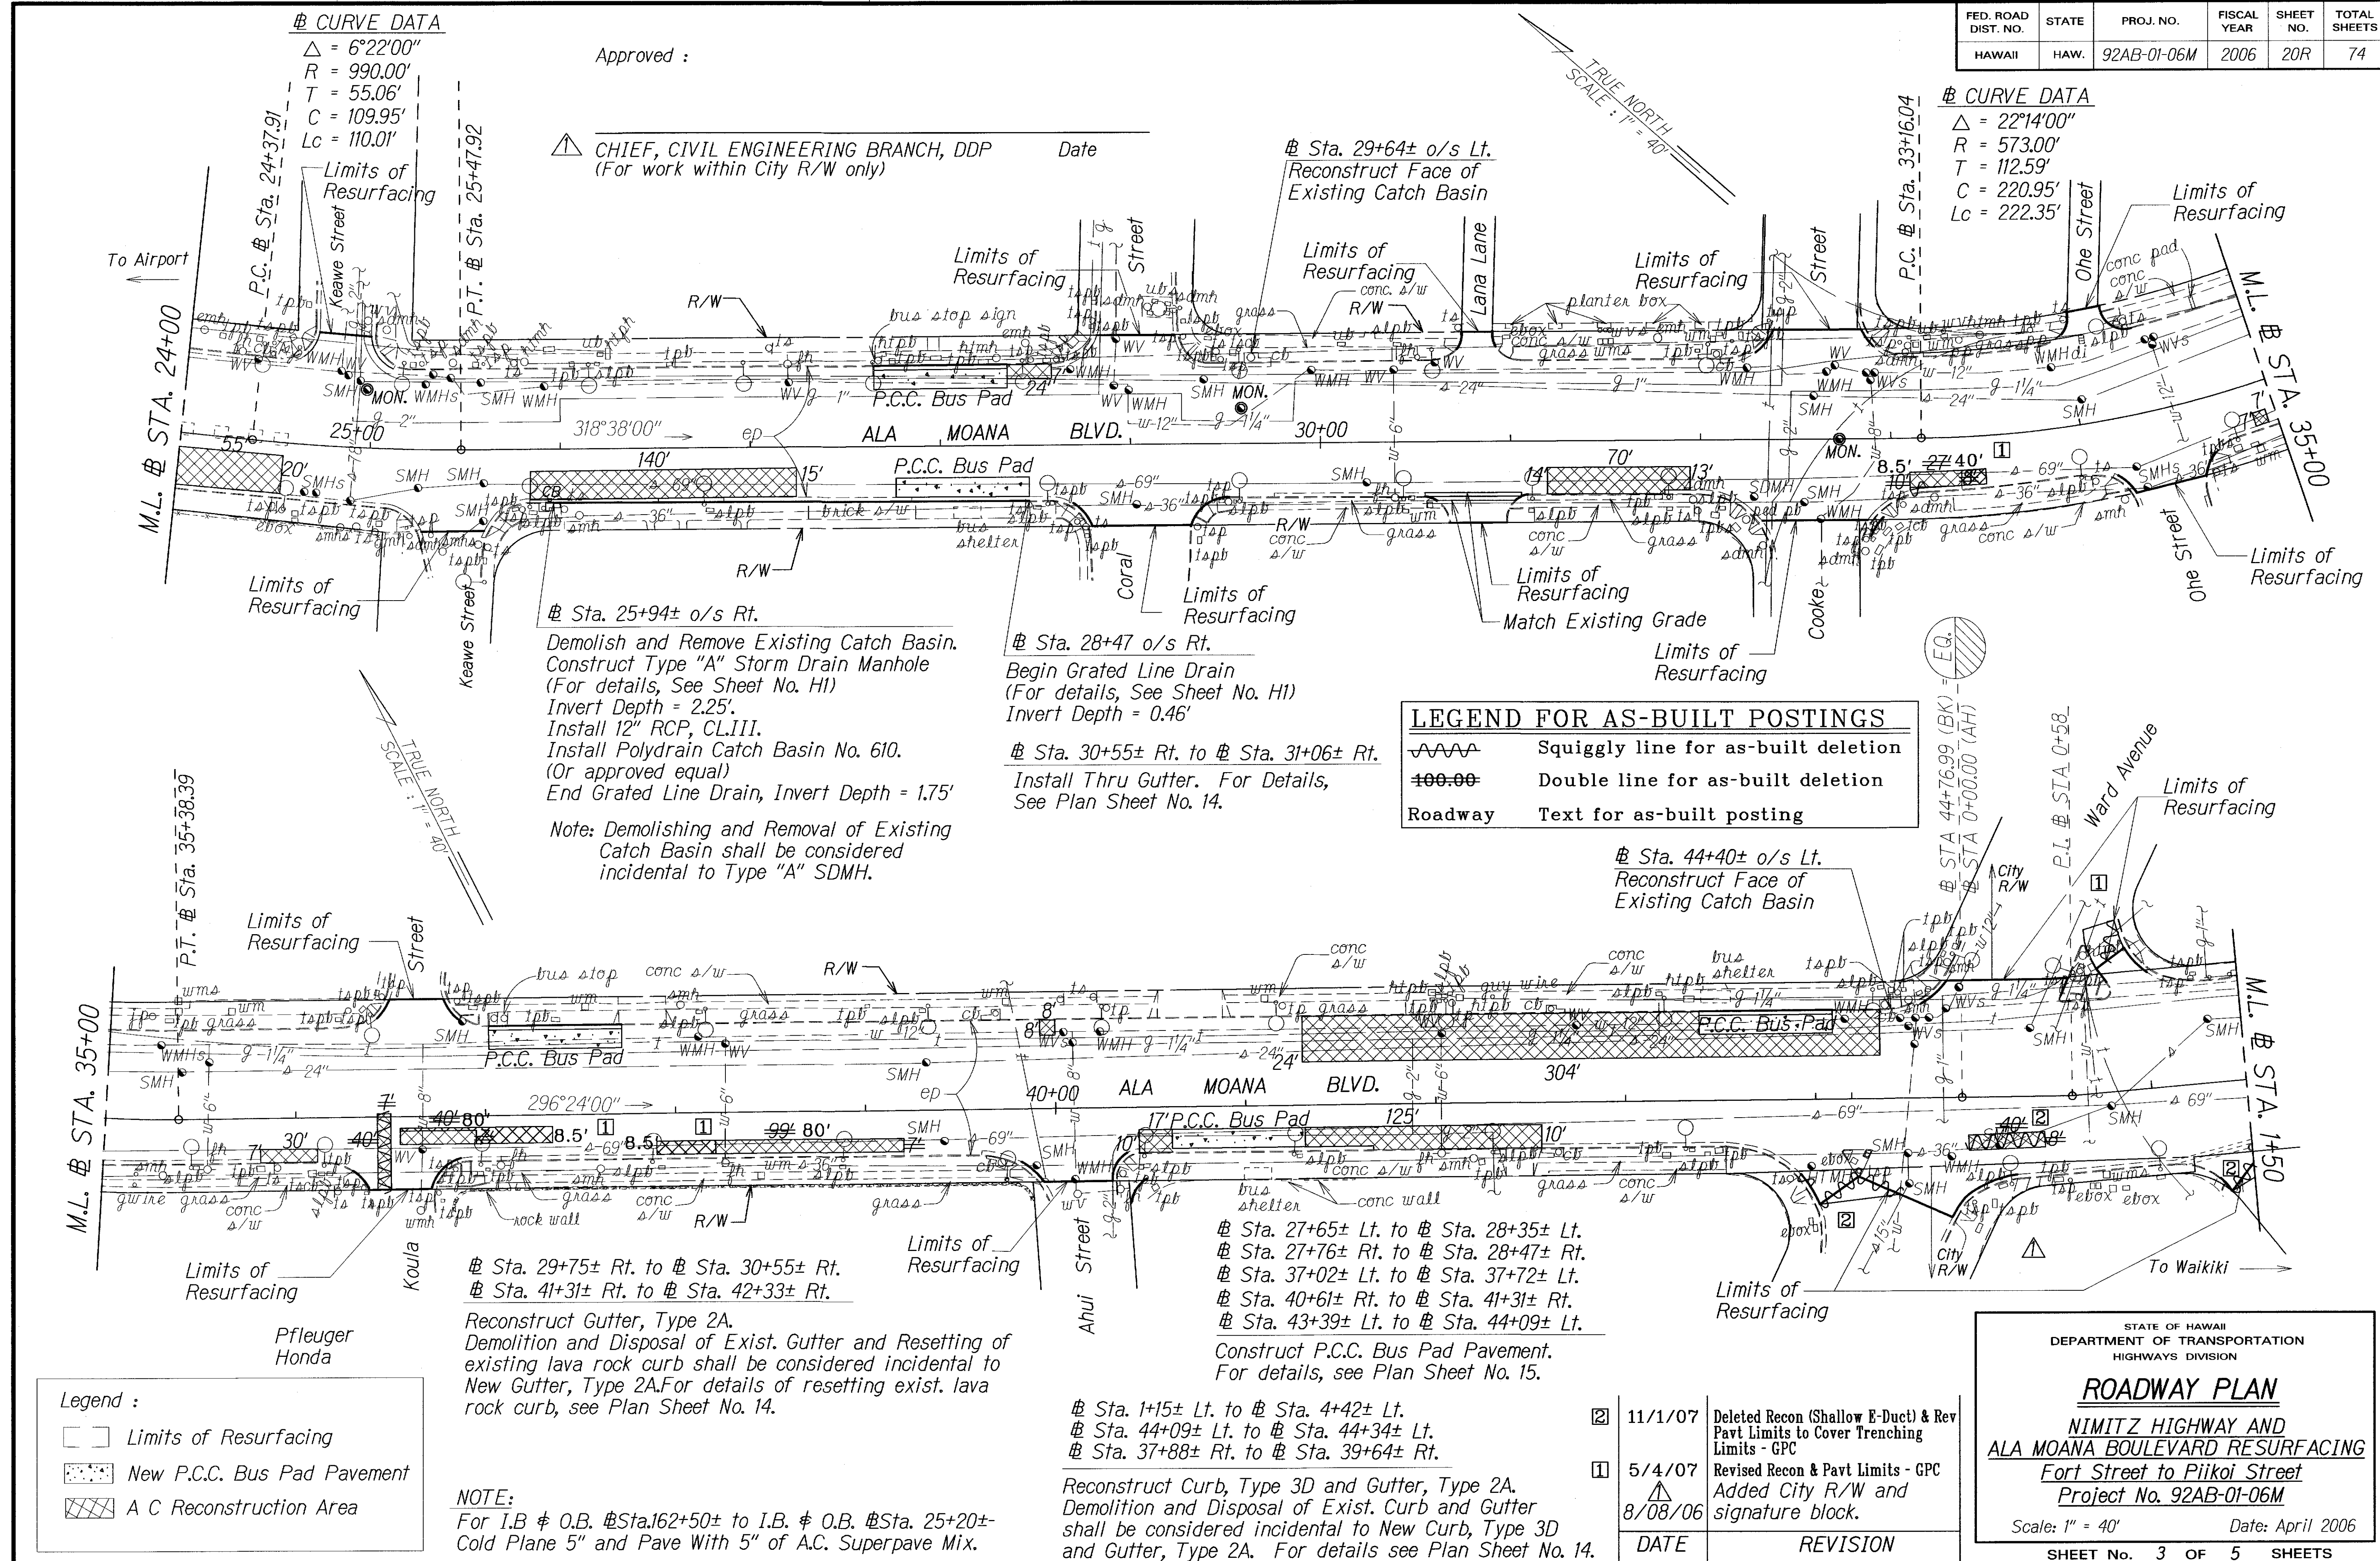

"AS-BUILT"

20R

| FED. ROAD DIST. NO. | STATE | PROJ. NO.   | FISCAL YEAR | SHEET NO. | TOTAL SHEETS |
|---------------------|-------|-------------|-------------|-----------|--------------|
| HAWAII              | HAW.  | 92AB-01-06M | 2006        | 21        | 74           |

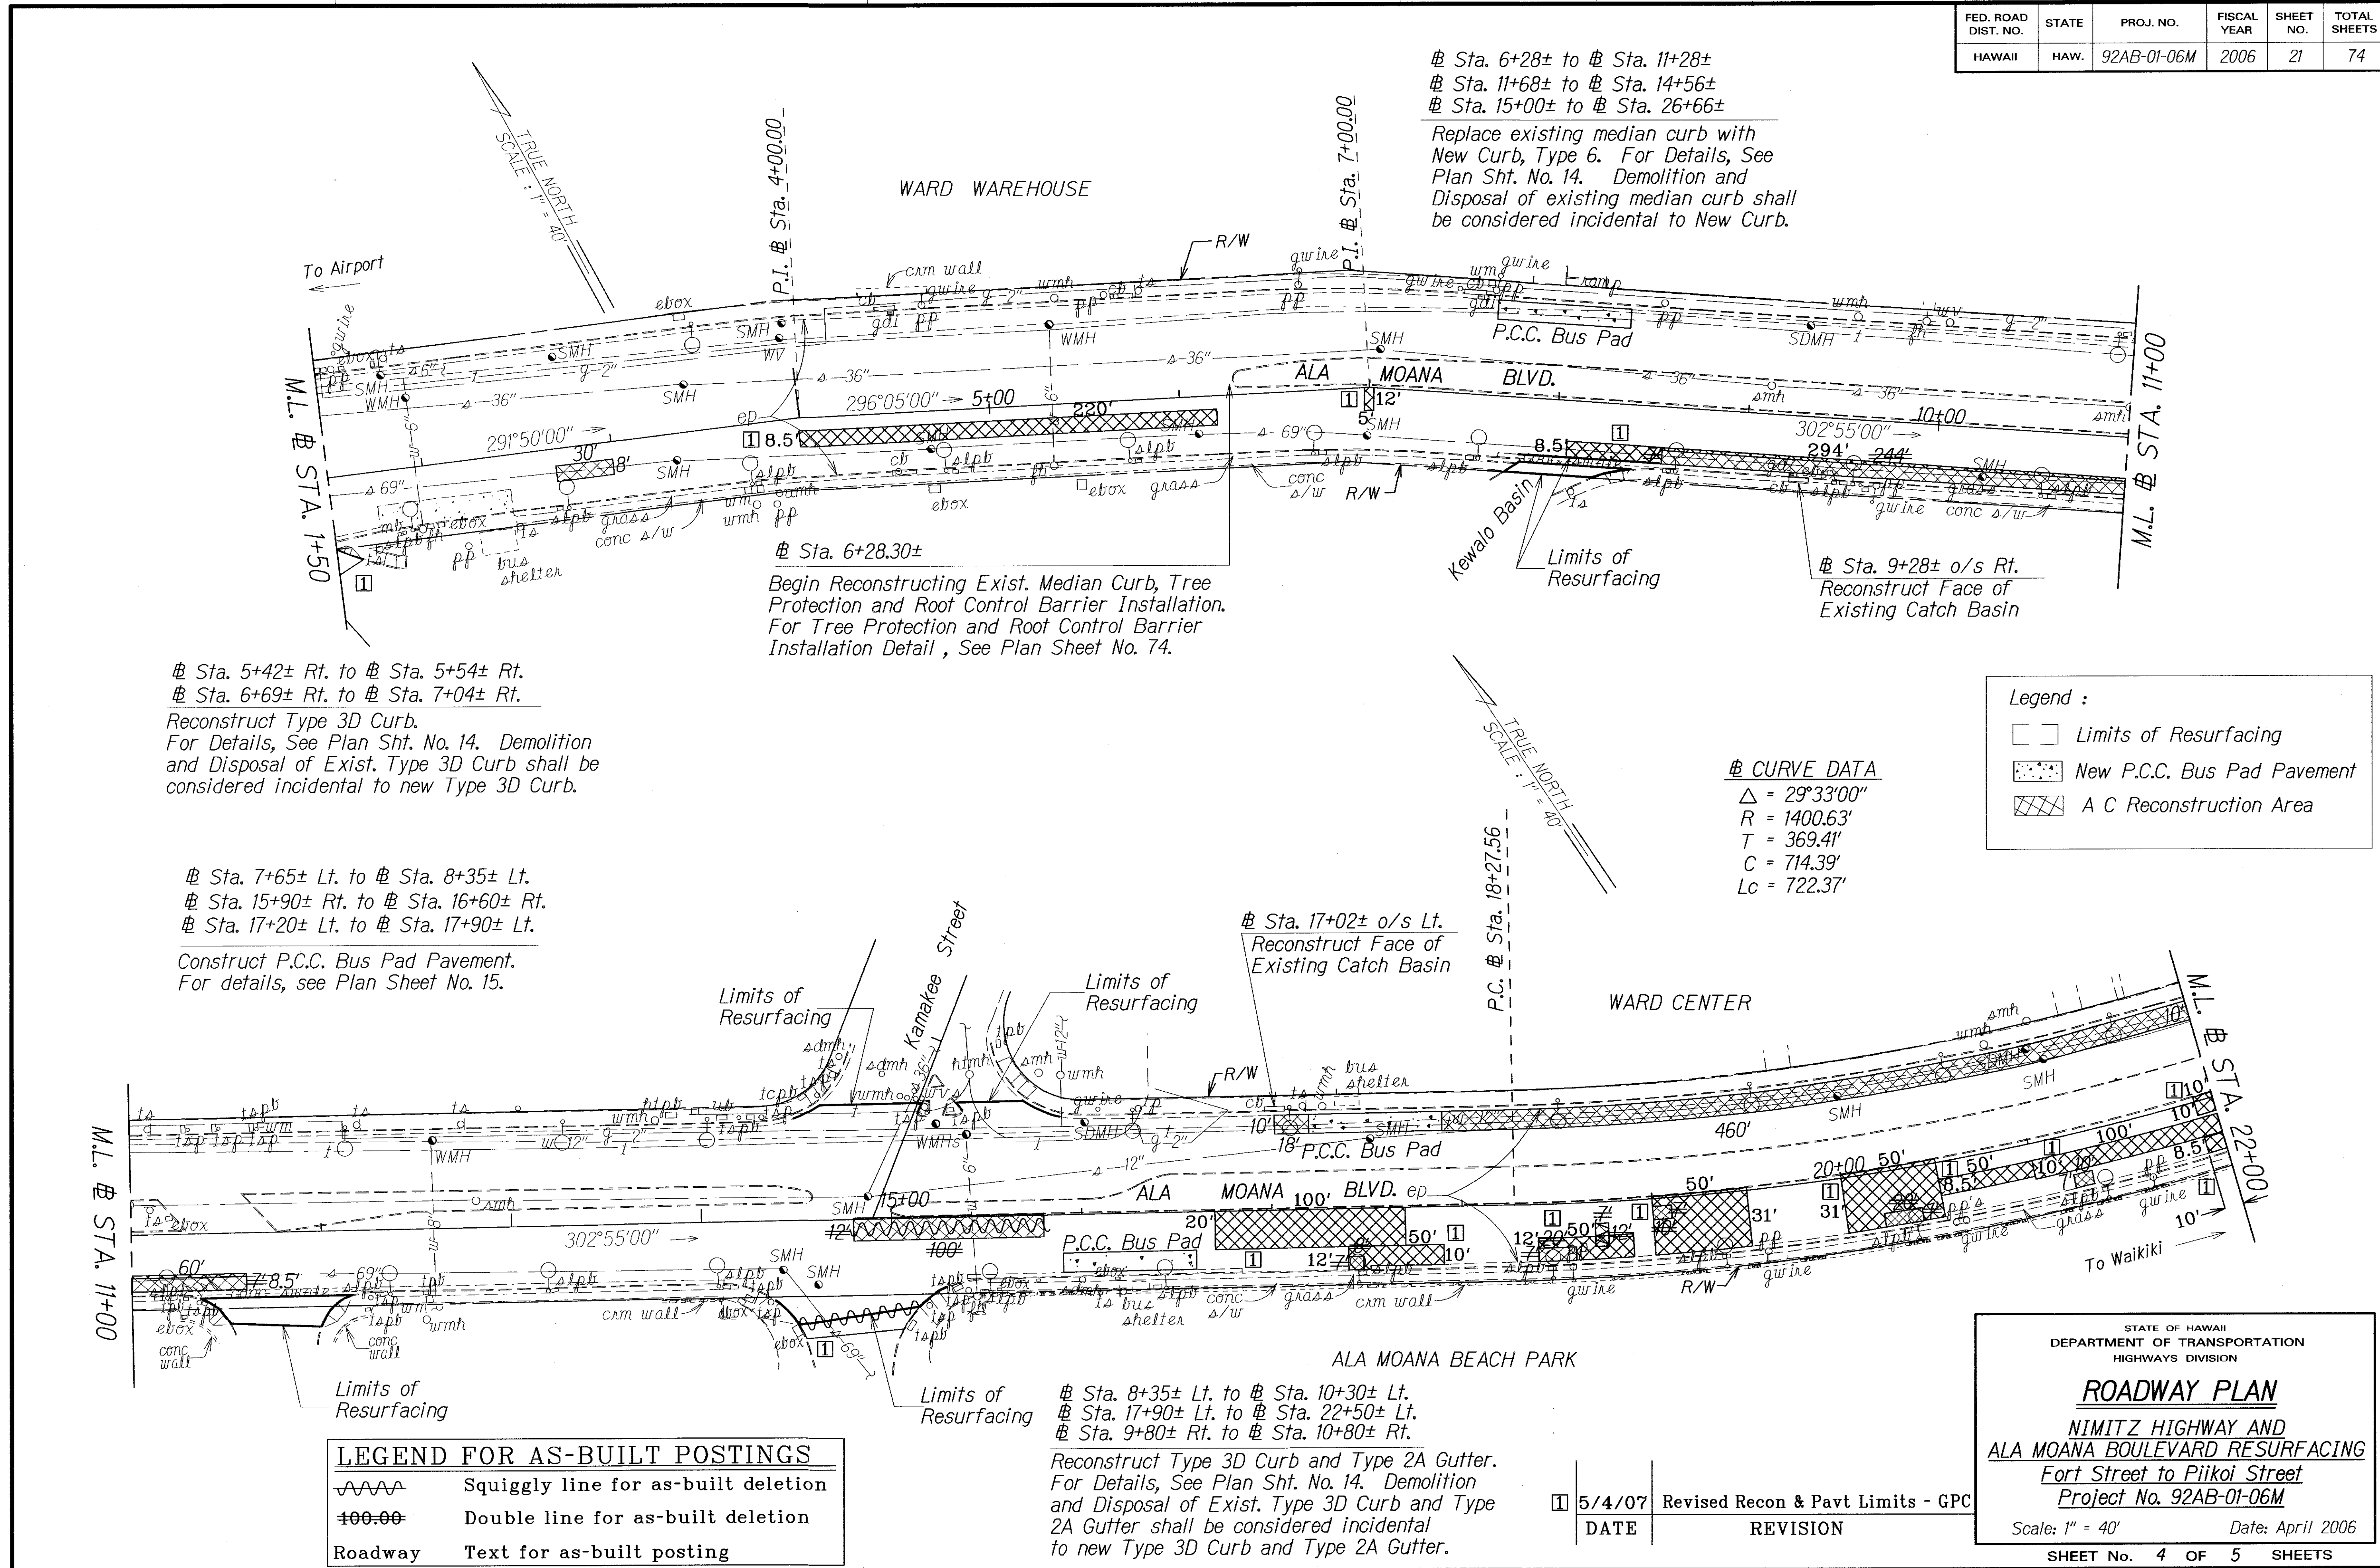

|                   |  |
|-------------------|--|
| DATE              |  |
| SURVEY PLOTTED BY |  |
| DRAWN BY          |  |
| DESIGNED BY       |  |
| CHECKED BY        |  |
| ORIGINAL PLAN     |  |
| NOTE BOOK         |  |
| QUANTITIES BY     |  |
| REVISIONS         |  |

"AS-BUILT"


| FED. ROAD DIST. NO. | STATE | PROJ. NO.   | FISCAL YEAR | SHEET NO. | TOTAL SHEETS |
|---------------------|-------|-------------|-------------|-----------|--------------|
| HAWAII              | HAW.  | 92AB-01-06M | 2006        | 22R       | 74           |

LEGEND FOR AS-BUILT POSTINGS

- ~~~~~ Squiggly line for as-built deletion  
~~100.00~~ Double line for as-built deletion  
Roadway Text for as-built posting

Legend :

- Limits of Resurfacing  
▤ New P.C.C. Bus Pad Pavement  
▨ A C Reconstruction Area

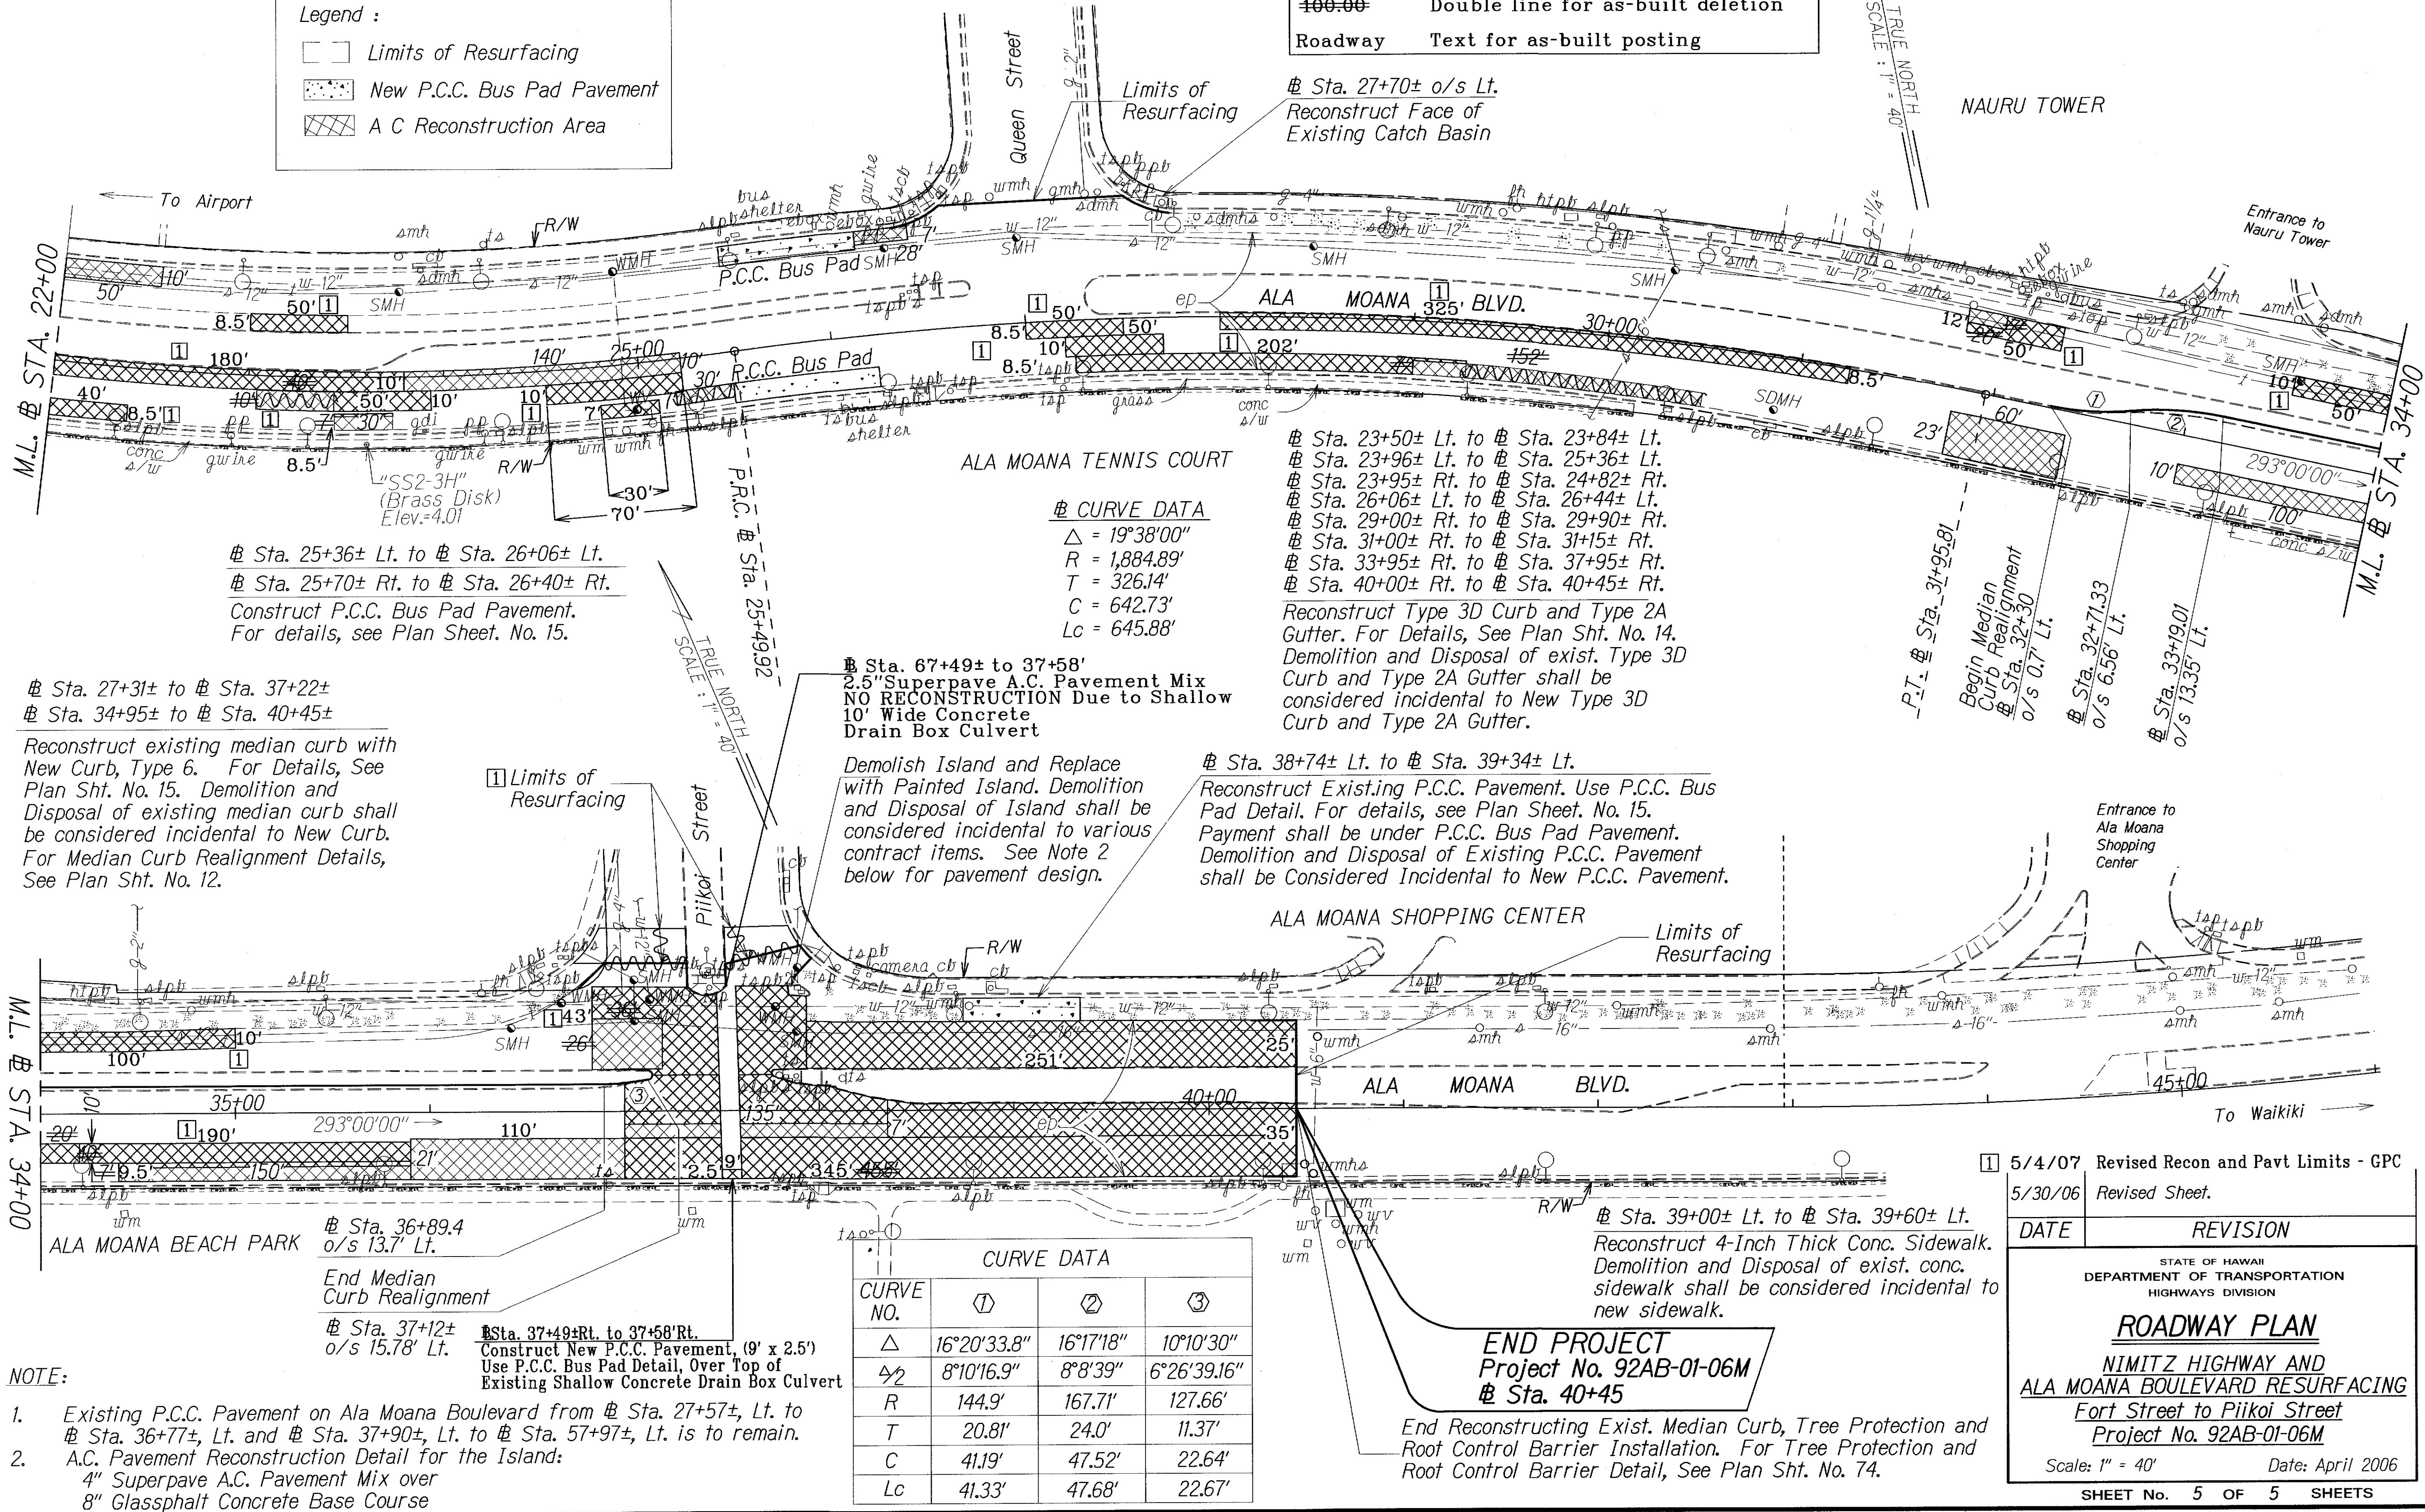

5/4/07 Revised Recon and Pavt Limits - GPC  
5/30/06 Revised Sheet.

DATE REVISION

STATE OF HAWAII  
DEPARTMENT OF TRANSPORTATION  
HIGHWAYS DIVISION

**ROADWAY PLAN**  
NIMITZ HIGHWAY AND  
ALA MOANA BOULEVARD RESURFACING  
Fort Street to Piikoi Street  
Project No. 92AB-01-06M

Scale: 1" = 40' Date: April 2006

SHEET No. 5 OF 5 SHEETS

"AS-BUILT"

22R