

INDEX TO DRAWINGS	
SHEET NO.	DESCRIPTION
1	TITLE SHEET
2	STANDARD PLANS SUMMARY
3	GENERAL NOTES AND LEGEND
4 - 5	WATER POLLUTIONS AND EROSION CONTROL NOTES
6 - 10	UTILITY NOTES
11 - 14	TYPICAL SECTIONS AND DETAILS
15	P.C.C. BUS PAD DETAILS
16 - 17	P.C.C. PAVEMENT DETAILS
18 - 22	ROADWAY PLANS
23	DRAINAGE DETAIL
24 - 67	ELECTRICAL PLANS
68	PAVEMENT MARKING DETAILS & NOTES
69 - 73	PAVEMENT MARKING & STRIPING PLAN
74	LANDSCAPE DETAILS

STATE OF HAWAII

DEPARTMENT OF TRANSPORTATION

HIGHWAYS DIVISION

HONOLULU, HAWAII

"AS-BUILT"

PLANS FOR

NIMITZ HIGHWAY AND

ALA MOANA BOULEVARD RESURFACING





FORT STREET TO PIIKOI STREET

PROJECT NO. 92AB-01-06M

DISTRICT OF HONOLULU

ISLAND OF OAHU

FED. ROAD DIST. NO.	STATE	PROJ. NO.	FISCAL YEAR	SHEET NO.	TOTAL SHEETS
HAWAII	HAW.	92AB-01-06M	2006	ADD.1	74

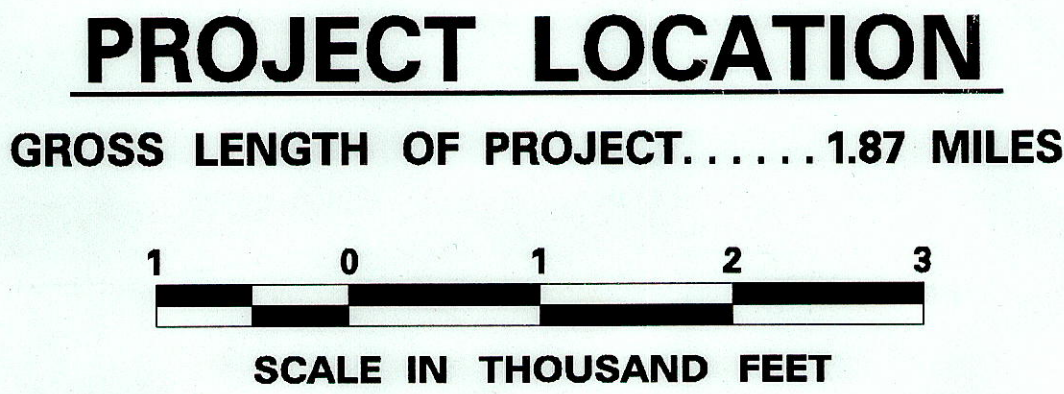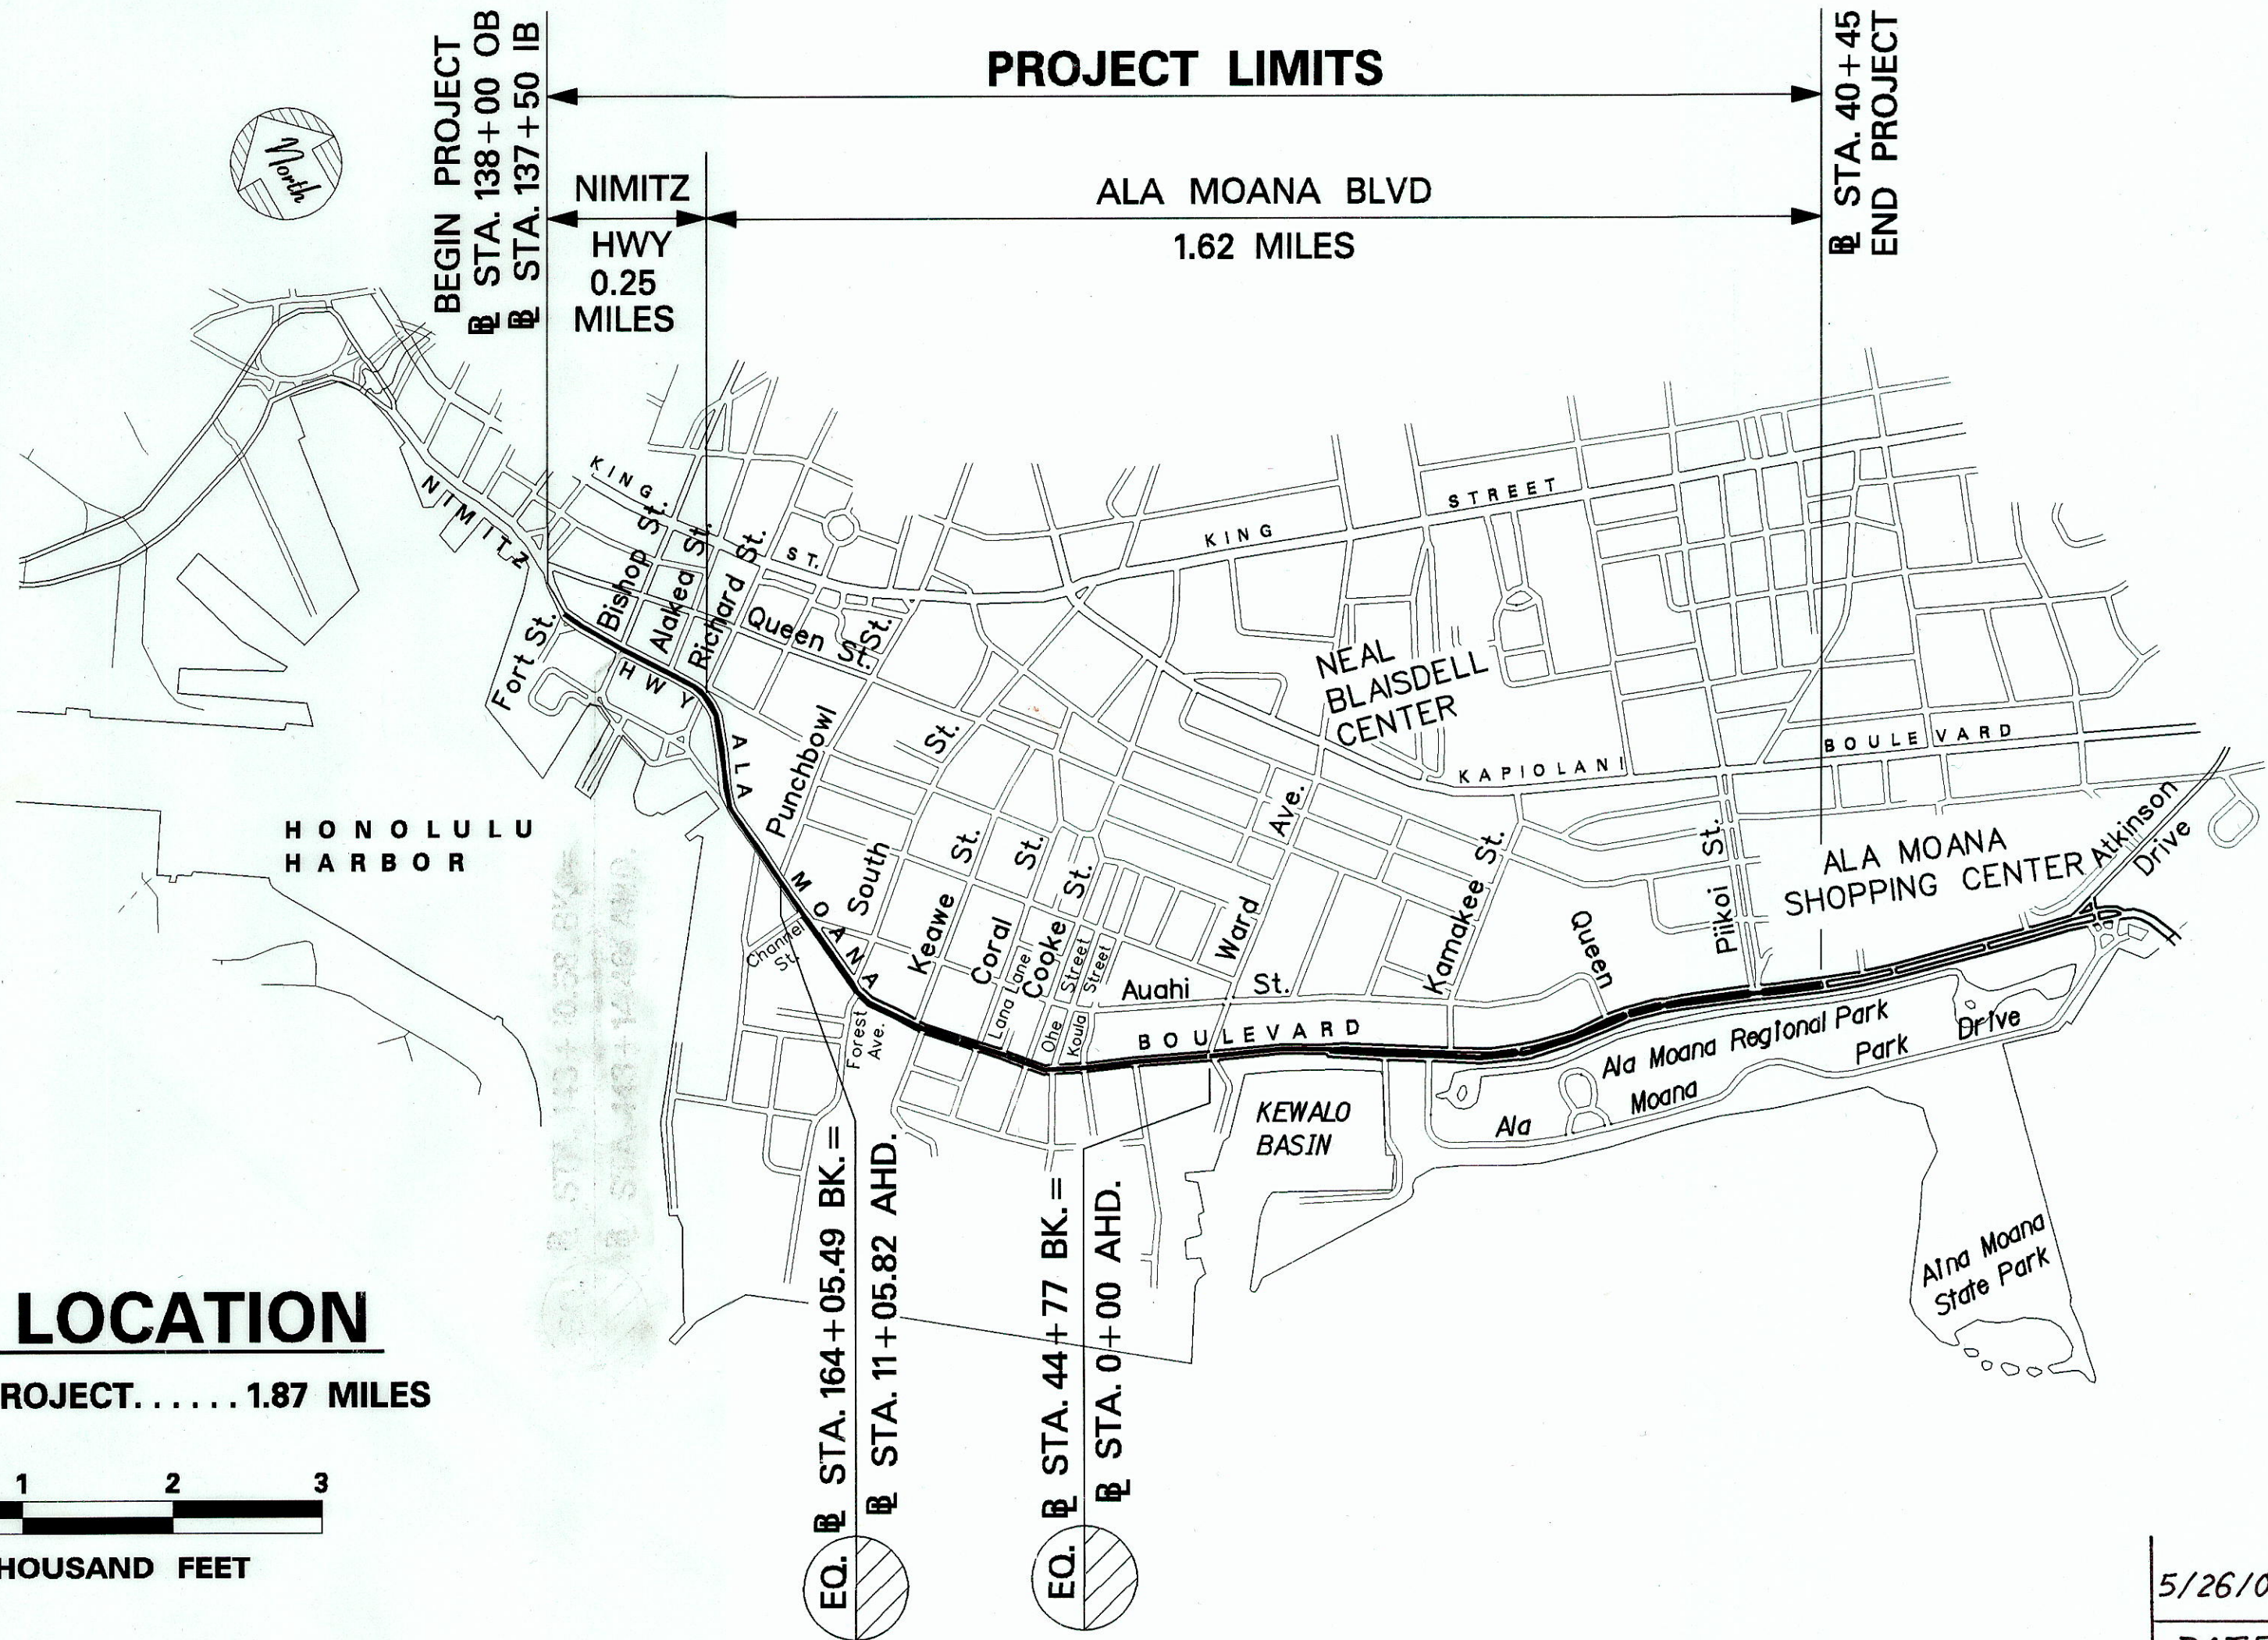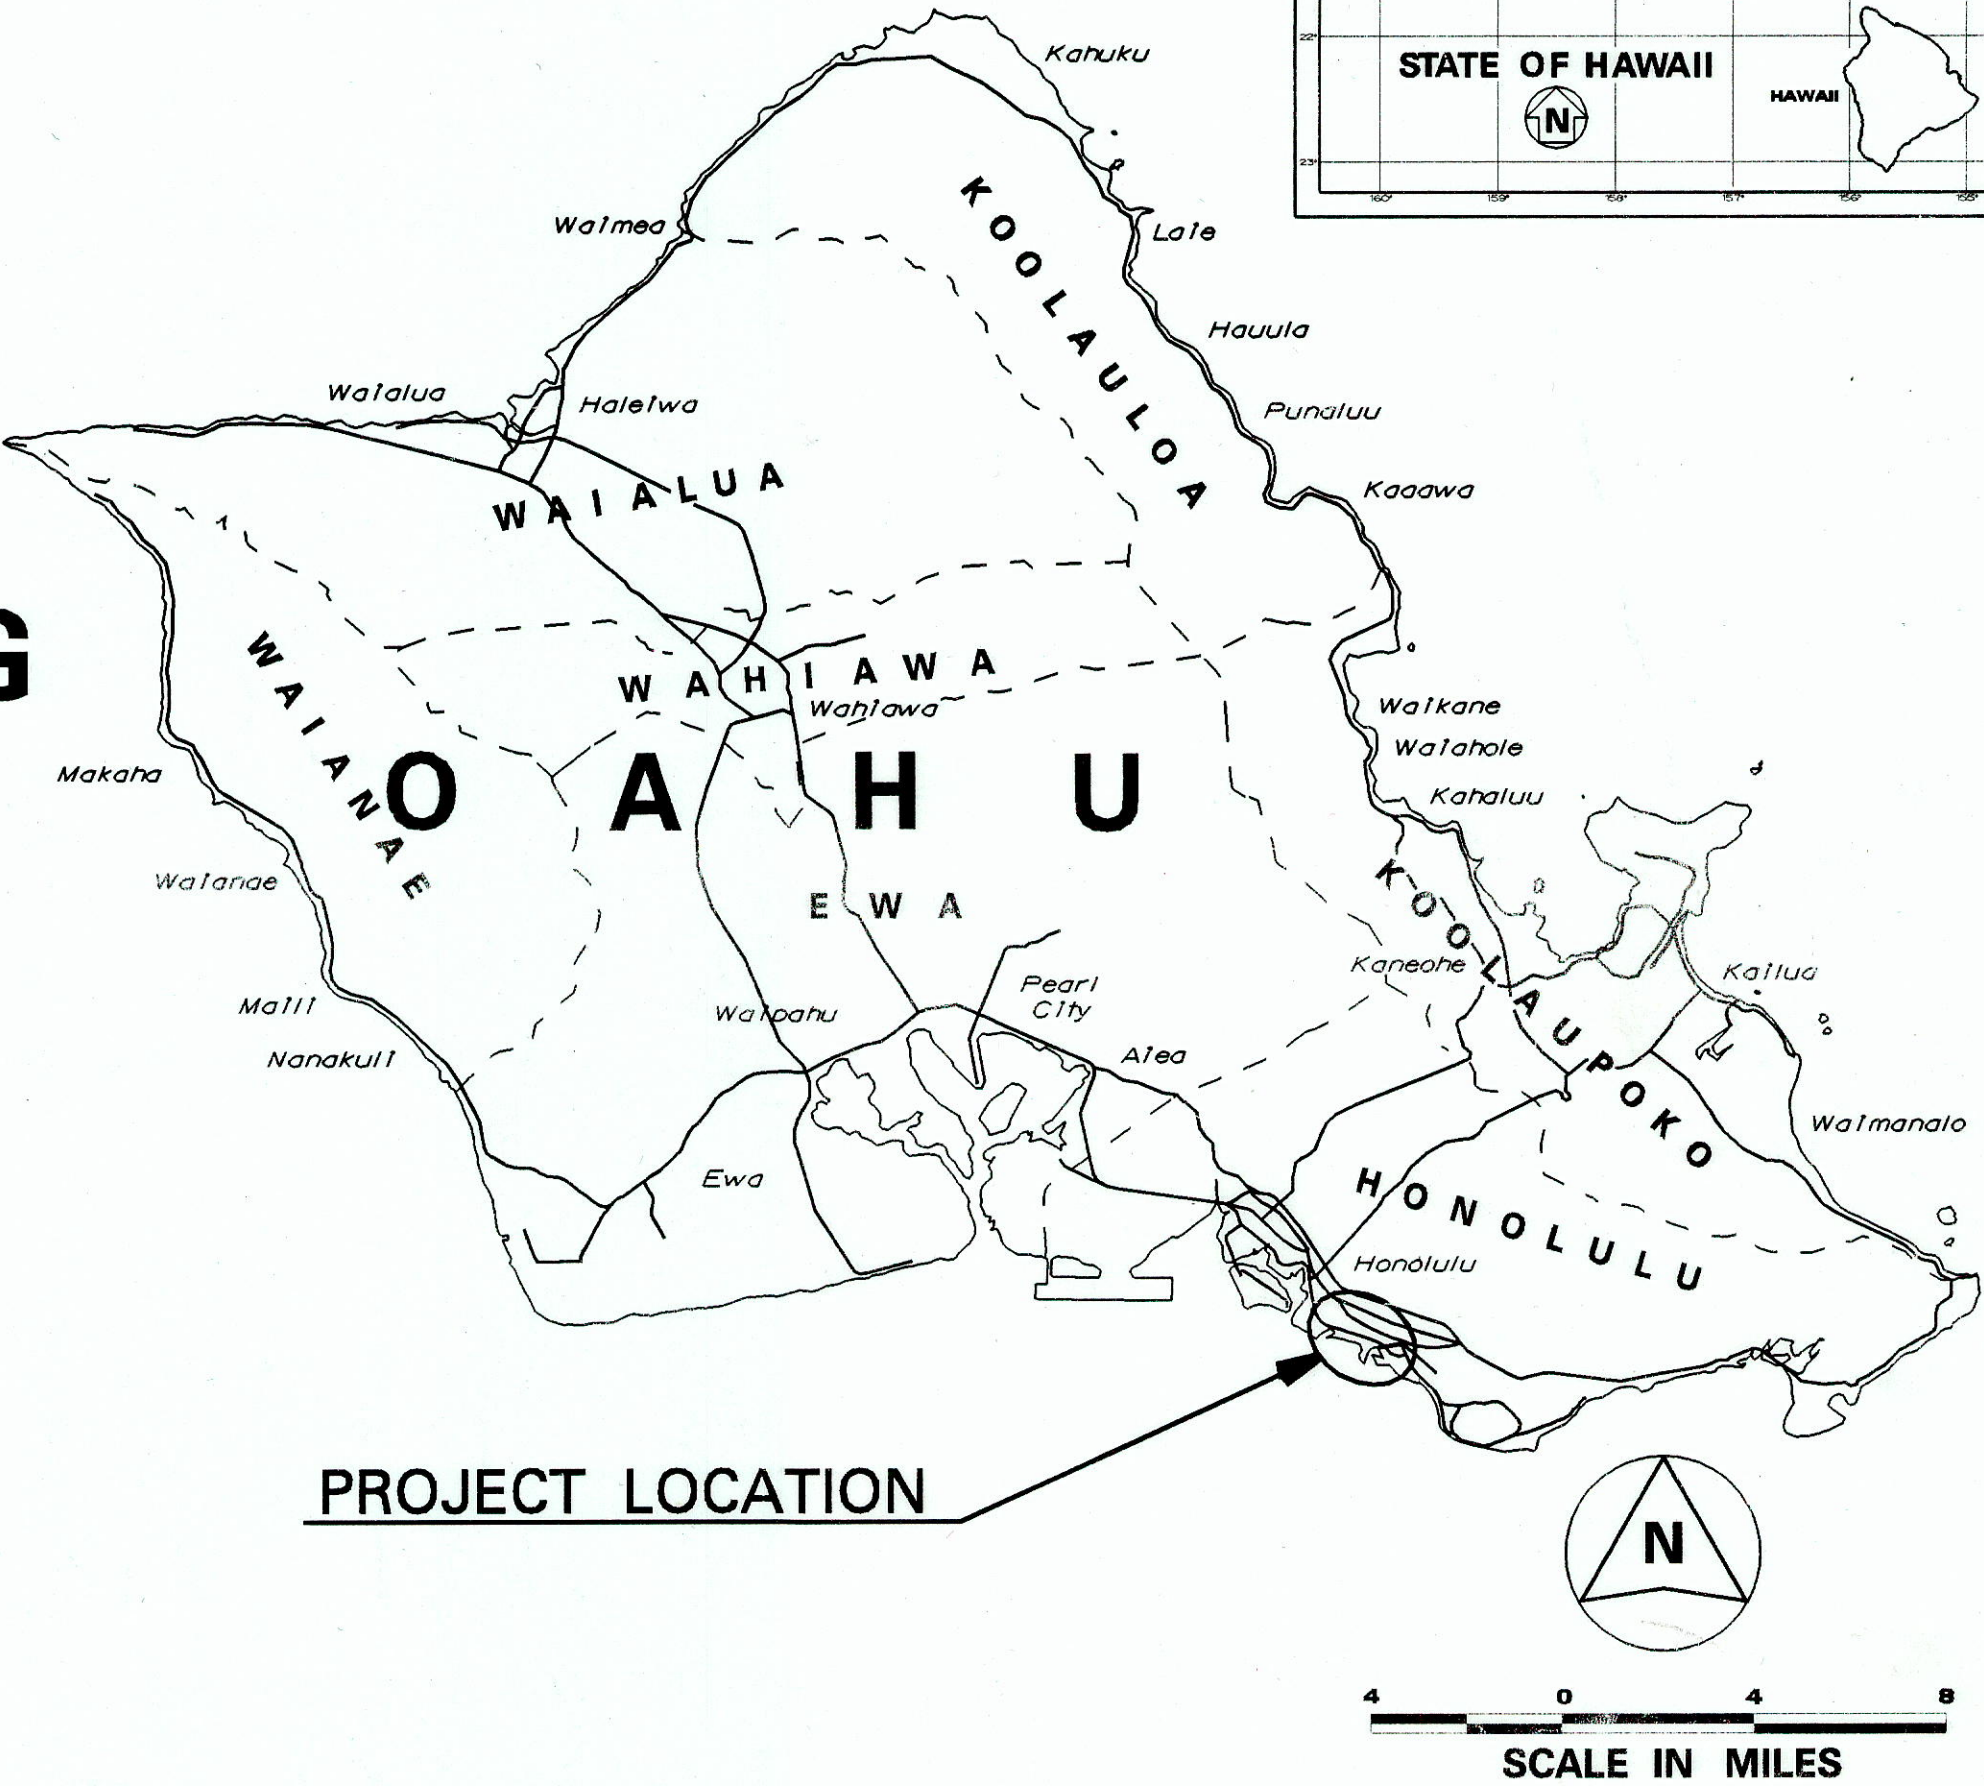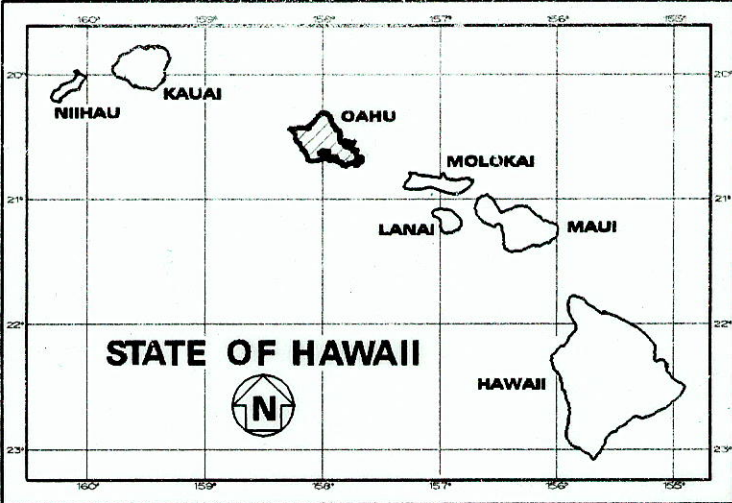

NIMITZ HWY
MILE POST 6.25 TO MILE POST 6.50
ALA MOANA BLVD
MILE POST 6.50 TO MILE POST 8.12

CHANGES MADE DURING CONSTRUCTION HAVE BEEN INCORPORATED ON THESE PLANS EXCEPT CHANGES IN THE ORIGINAL THEORETICAL QUANTITIES. FOR ACTUAL QUANTITIES, REFER TO PROJECT LEDGER AND/OR COMPUTATION BOOK.

Manoah A. Lufeld 8-20-2014
RESIDENT ENGINEER DATE

DEPARTMENT OF TRANSPORTATION STATE OF HAWAII	
APPROVED:	4.21.06
<i>Debra M. Gami</i>	DATE
DIR. OF TRANSPORTATION	

5/26/06	Deleted Equation Station.
DATE	REVISION