



NOTES:

- CONTRACTOR SHALL REMOVE EXISTING STREET LIGHTING LUMINAIRE, AND MAST ARM.
- EXISTING JOINT UTILITY POLE TO BE REPLACED BY HAWAIIAN ELECTRIC CO.
- EXISTING JOINT UTILITY POLE TO BE REMOVED BY HAWAIIAN ELECTRIC CO.
- NEW JOINT UTILITY POLE SHALL BE FURNISHED AND INSTALLED BY HAWAIIAN ELECTRIC CO.
- CONTRACTOR SHALL PROVIDE NEW ANCHOR FOR STREET LIGHTING FEEDER CIRCUIT. DEPEND. ANCHOR INSTALLER ACCORDING TO DETAIL (3).
- EXISTING OVERHEAD NEUTRAL CONDUCTOR SHALL BE RAISED BY HAWAIIAN ELECTRIC CO. FROM JPS TO JPS 22.
- EXISTING UNDERGROUND ELECTRIC SERVICE SHALL BE RELOCATED BY HAWAIIAN ELECTRIC CO. WORK SHALL INCLUDE ALL NECESSARY RACEWAYS, CABLES AND EQUIPMENT REQUIRED FOR COMPLETE RELOCATION.


- BEFORE TRENCHING, CONTRACTOR SHALL CONTACT UTILITY COMPANIES AND LOCAL AGENCIES FOR STAKE OUT OF THEIR EXISTING UNDERGROUND FACILITIES.
- CONTRACTOR SHALL STAKE OUT STREET LIGHT CIRCUIT, TRENCH ROUTE AND BASE LOCATION AND OBTAIN APPROVAL OF LOCATION FROM THE ENGINEER. WHERE POSSIBLE, TRENCH SHALL BE LOCATED IN GRASSED OR OPEN SHOULDER AREAS (WITHIN RIGHT OF WAY). TRENCH SHALL BE LOCATED TO MINIMIZE CONFLICTS WITH EXISTING UTILITIES.
- IT IS NOT THE INTENT OF THESE DRAWINGS TO IMPLY THAT ALL EXISTING UNDERGROUND UTILITIES ARE SHOWN. EXISTING UTILITIES SHOWN ARE APPROXIMATE IN LOCATION AND ARE BASED ON AVAILABLE PLANS AND VISUAL FIELD SURVEYS. NO SUBSURFACE INVESTIGATION WERE CONDUCTED TO ASCERTAIN LOCATIONS OF UNDERGROUND UTILITIES.

- CONTRACTOR SHALL ARRANGE FOR UTILITY COMPANY'S WORK AS REQUIRED BY NOTES 2, 3, 4, 6 AND 7. AND SHALL SCHEDULE HIS WORK ACCORDINGLY.
- ALL UTILITY CHARGES FOR THE REMOVAL, REPLACEMENT AND INSTALLATION OF ALL POLES, CABLES, RACEWAYS AND EQUIPMENT SHALL BE PAID BY THE CONTRACTOR TO THE RESPECTIVE UTILITY COMPANY.

FED. ROAD DIST. NO.	STATE	FED. AID PROJ. NO.	FISCAL YEAR	SHEET NO.	TOTAL SHEETS
HAWAII	HAW.				

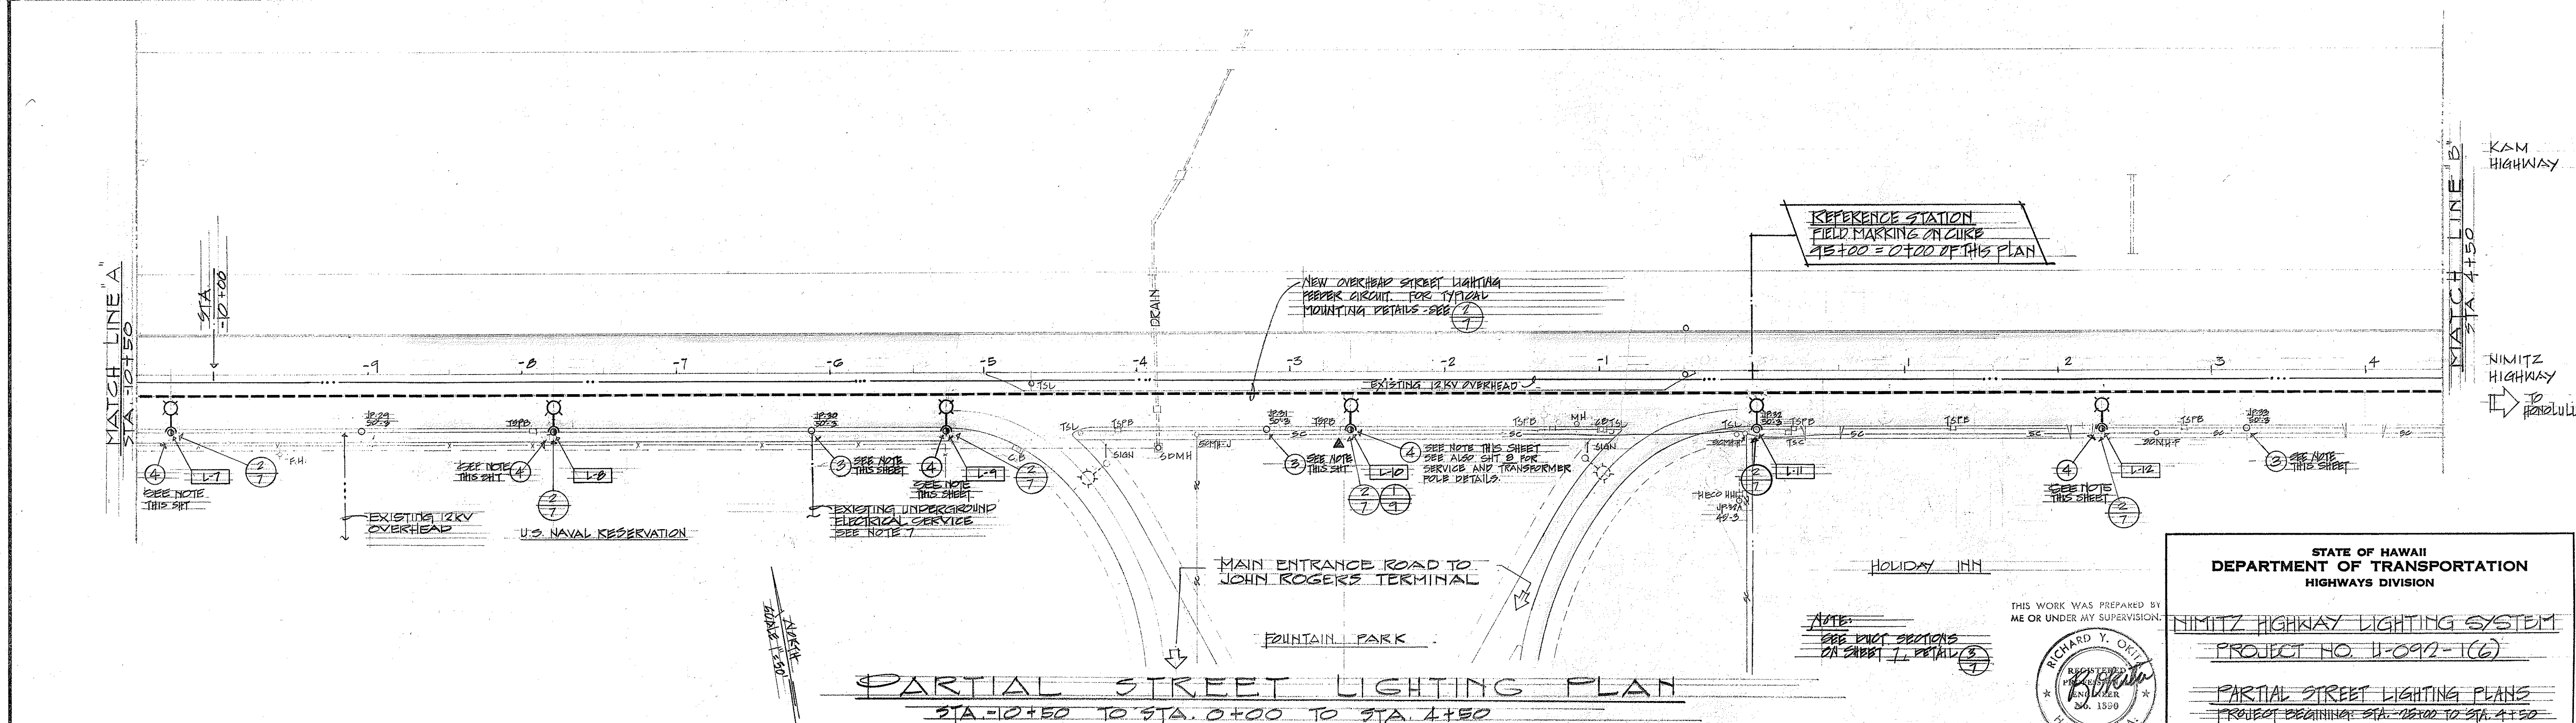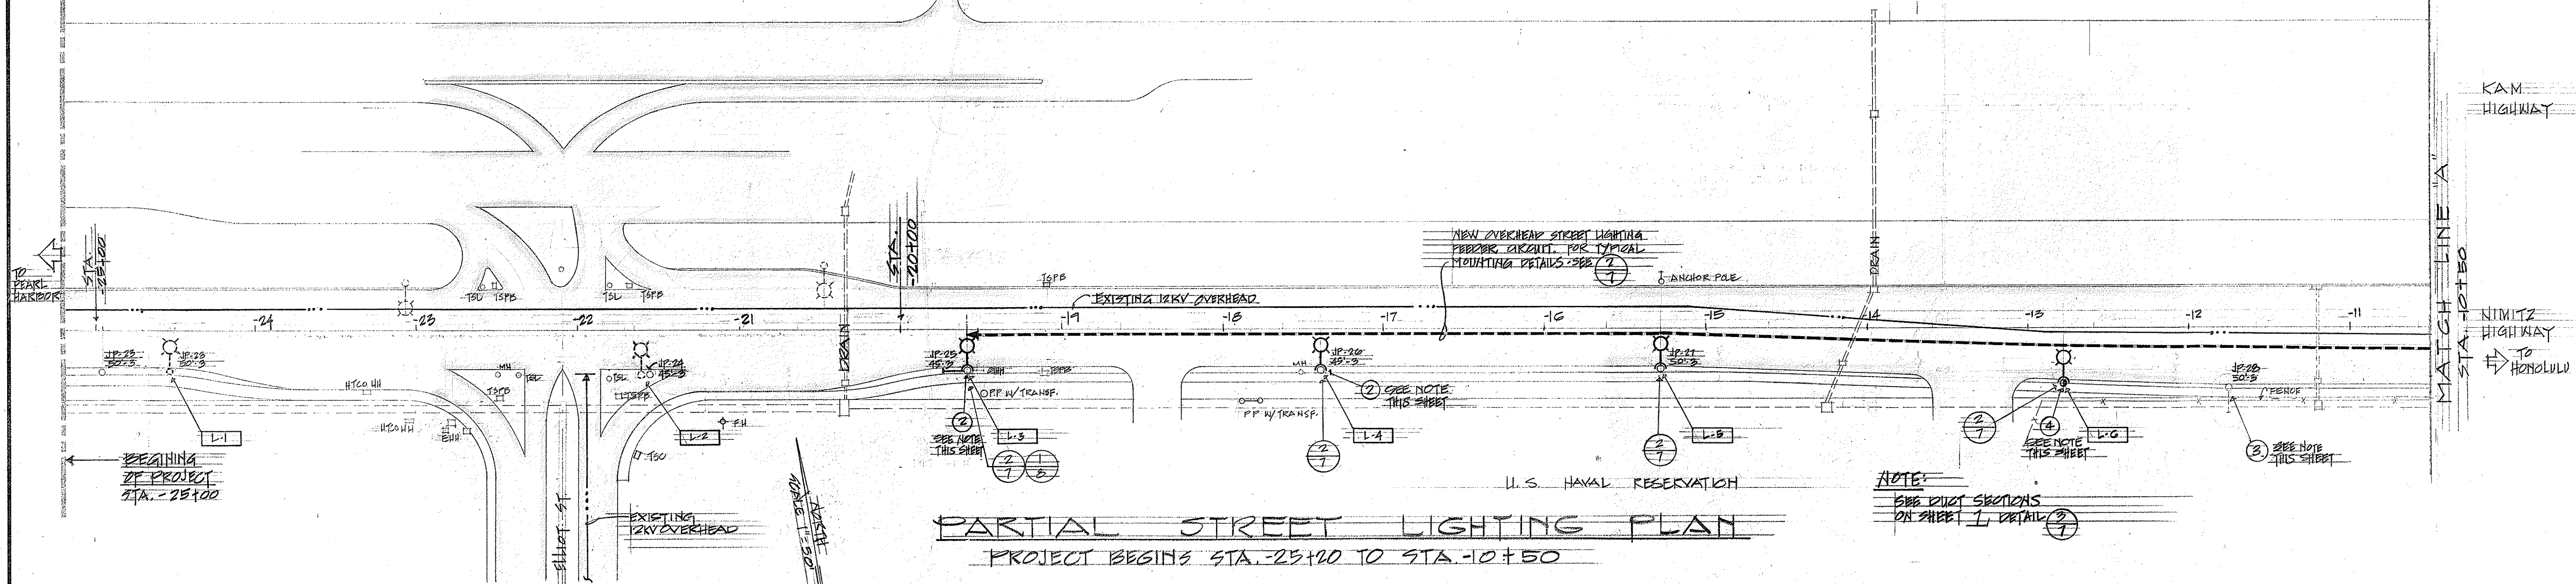



SURVEY PLOTTED BY	DATE
DESIGNED BY	
NOTED BY	
CHECKED BY	

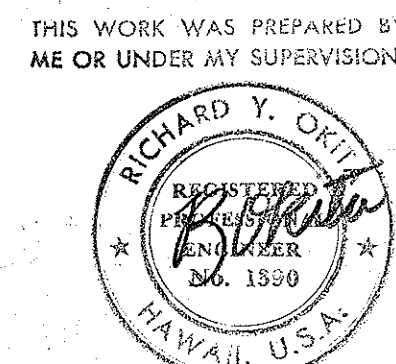


STATE OF HAWAII
DEPARTMENT OF TRANSPORTATION
HIGHWAYS DIVISION

NIMITZ HIGHWAY LIGHTING SYSTEM
PROJECT NO. U-092-1(6)
PARTIAL STREET LIGHTING PLANS
PROJECT BEGINS STA -25+00 TO STA 4+50

FED. ROAD DIST. NO.	STATE	FED. AID PROJ. NO.	FISCAL YEAR	SHEET NO.	TOTAL SHEETS
HAWAII	HAW.				

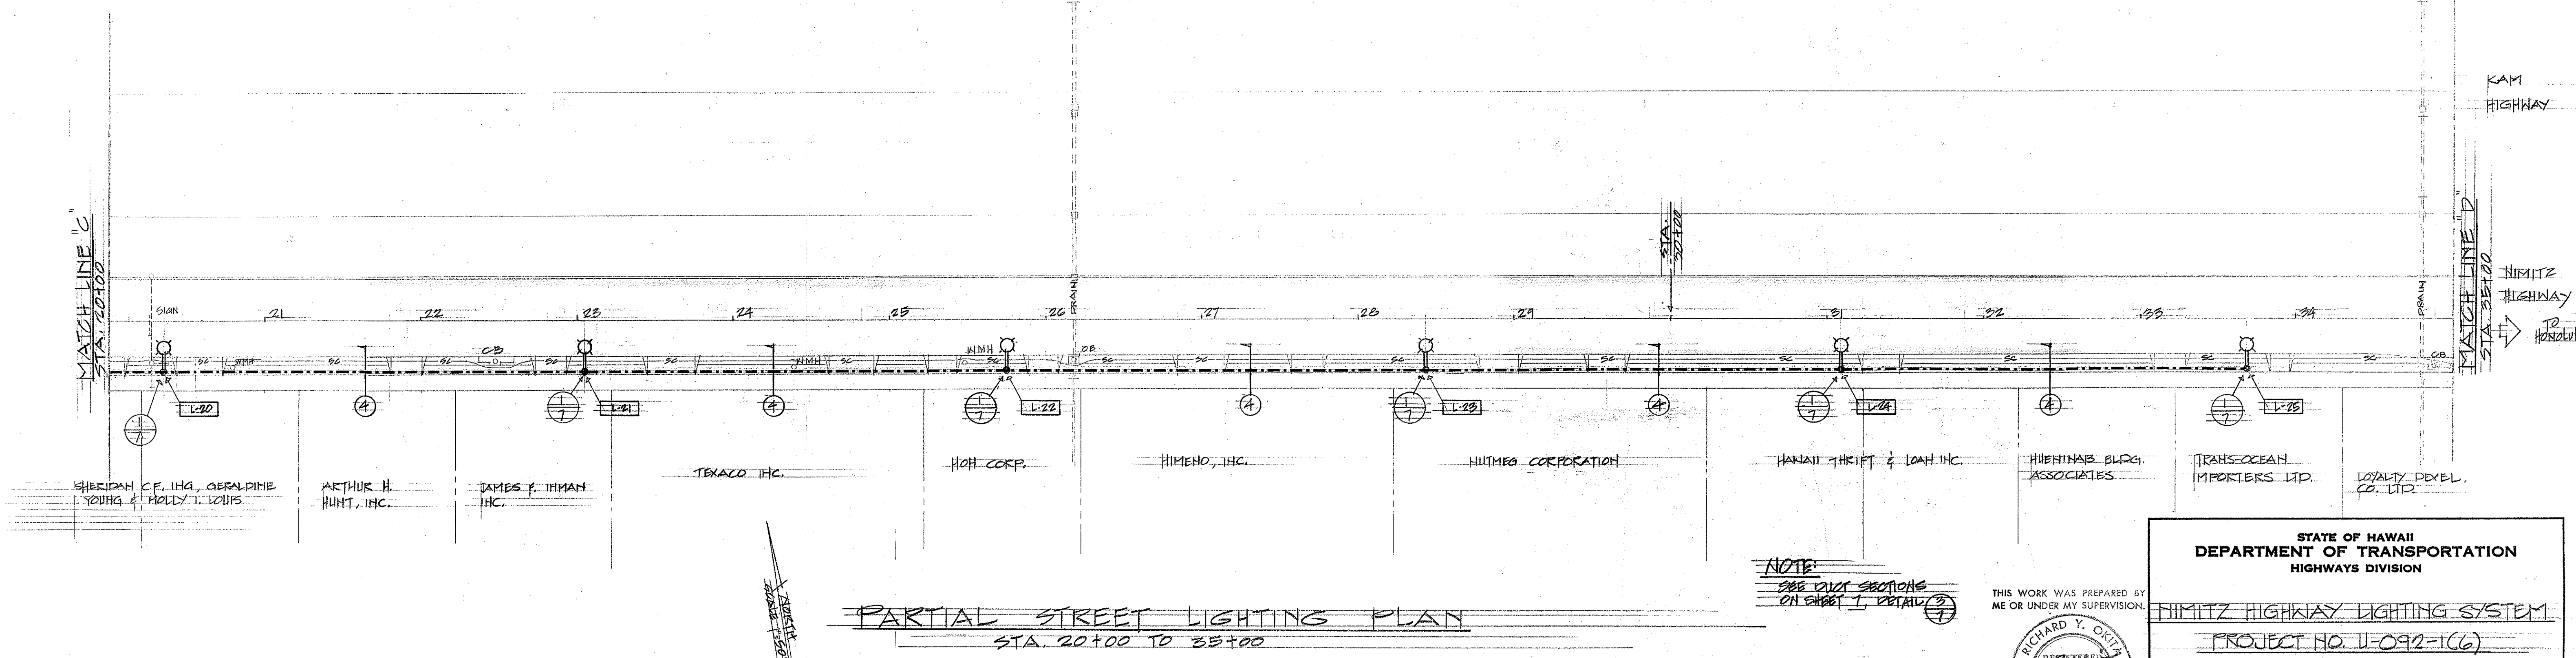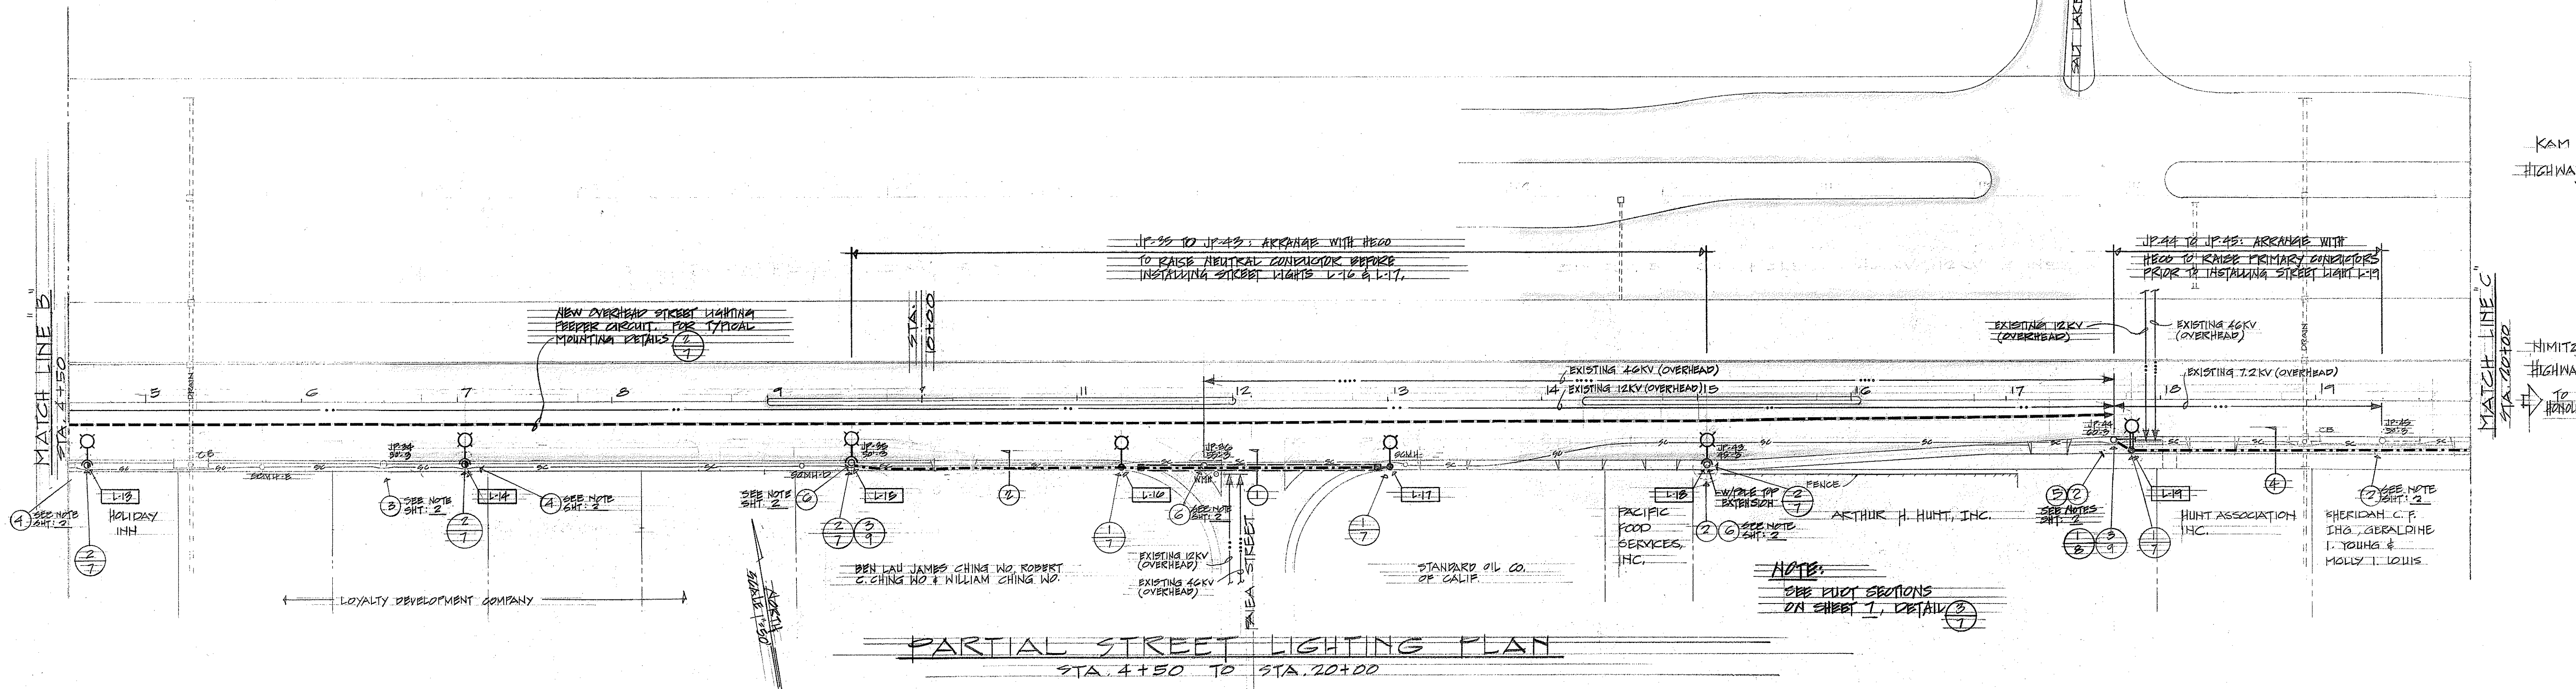

DATE	
ORIGINAL PLAN	
DRAWN BY	
TRACED BY	
NOTED BY	
CHECKED BY	
NO.	

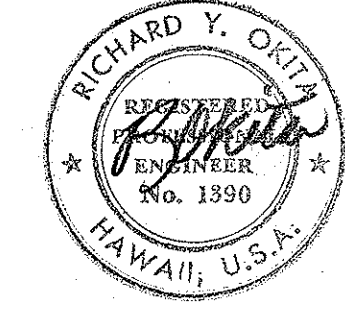

STATE OF HAWAII
DEPARTMENT OF TRANSPORTATION
HIGHWAYS DIVISION

HIMITZ HIGHWAY LIGHTING SYSTEM


PROJECT NO. U-092-1(6)

PARTIAL STREET LIGHTING PLAN
STA. 4+50 TO STA. 35+00

FED. ROAD DIST. NO.	STATE	FED. AID PROJ. NO.	FISCAL YEAR	SHEET NO.	TOTAL SHEETS
HAWAII	HAW.				


MATCH LINE "D"
STA. 35+00

MATCH LINE "E"
STA. 50+00

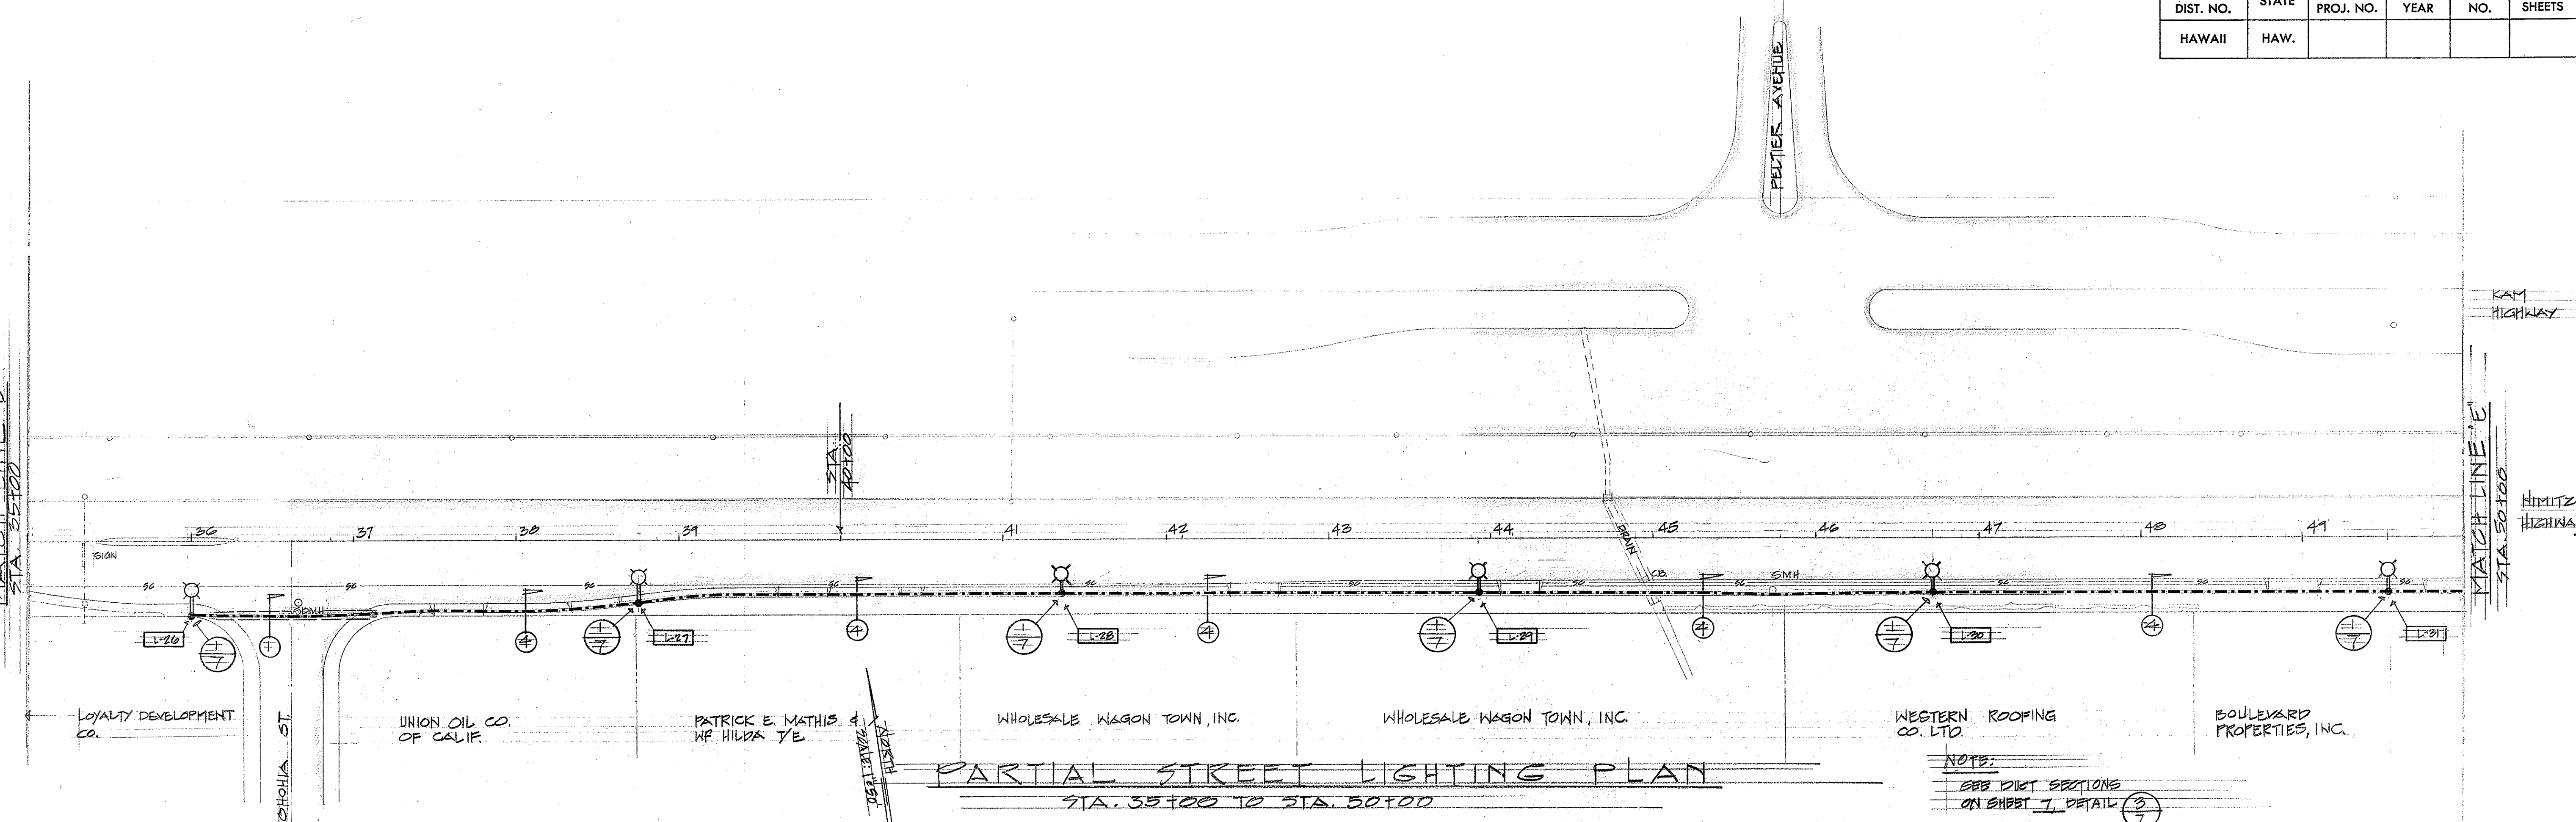

MATCH LINE "C"
STA. 50+00

MATCH LINE "F"
STA. 65+00

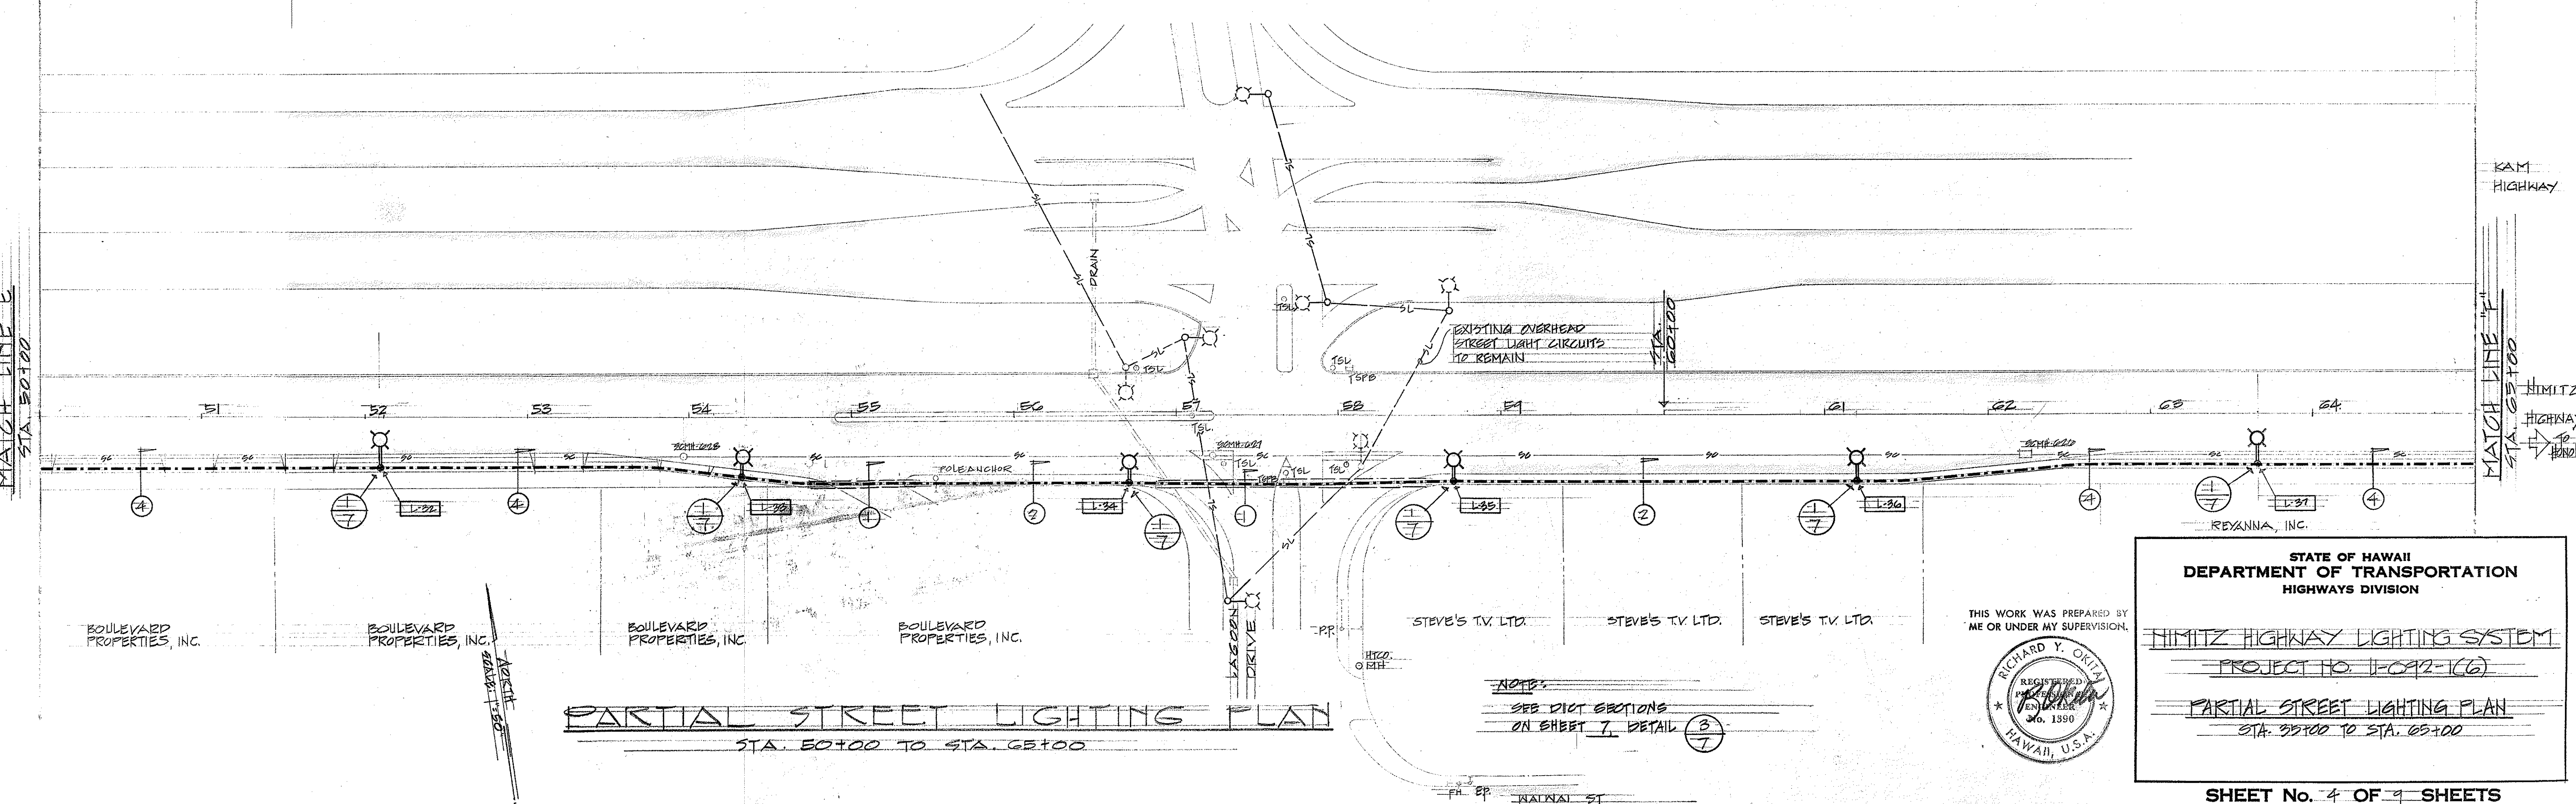


DATE	SURVEY PLOTTED BY
DATE	DRAWN BY
DATE	TRACED BY
DATE	CHECKED BY
DATE	NOTED BY

STATE OF HAWAII
DEPARTMENT OF TRANSPORTATION
HIGHWAYS DIVISION

HIMITZ HIGHWAY LIGHTING SYSTEM
PROJECT NO. H-092-106
PARTIAL STREET LIGHTING PLAN
STA. 35+00 TO STA. 65+00

SHEET No. 4 OF 9 SHEETS

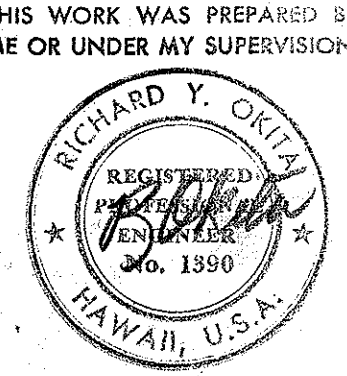

THIS WORK WAS PREPARED BY ME OR UNDER MY SUPERVISION.


NOTE:
SEE DIST. SECTIONS
ON SHEET 7, DETAIL 3/7

FED. ROAD DIST. NO.	STATE	FED. AID PROJ. NO.	FISCAL YEAR	SHEET NO.	TOTAL SHEETS
HAWAII	HAW.				

KAM
HIGHWAY

HIMITZ
HIGHWAY

MAITCH LINE "F"
STA. 65+00

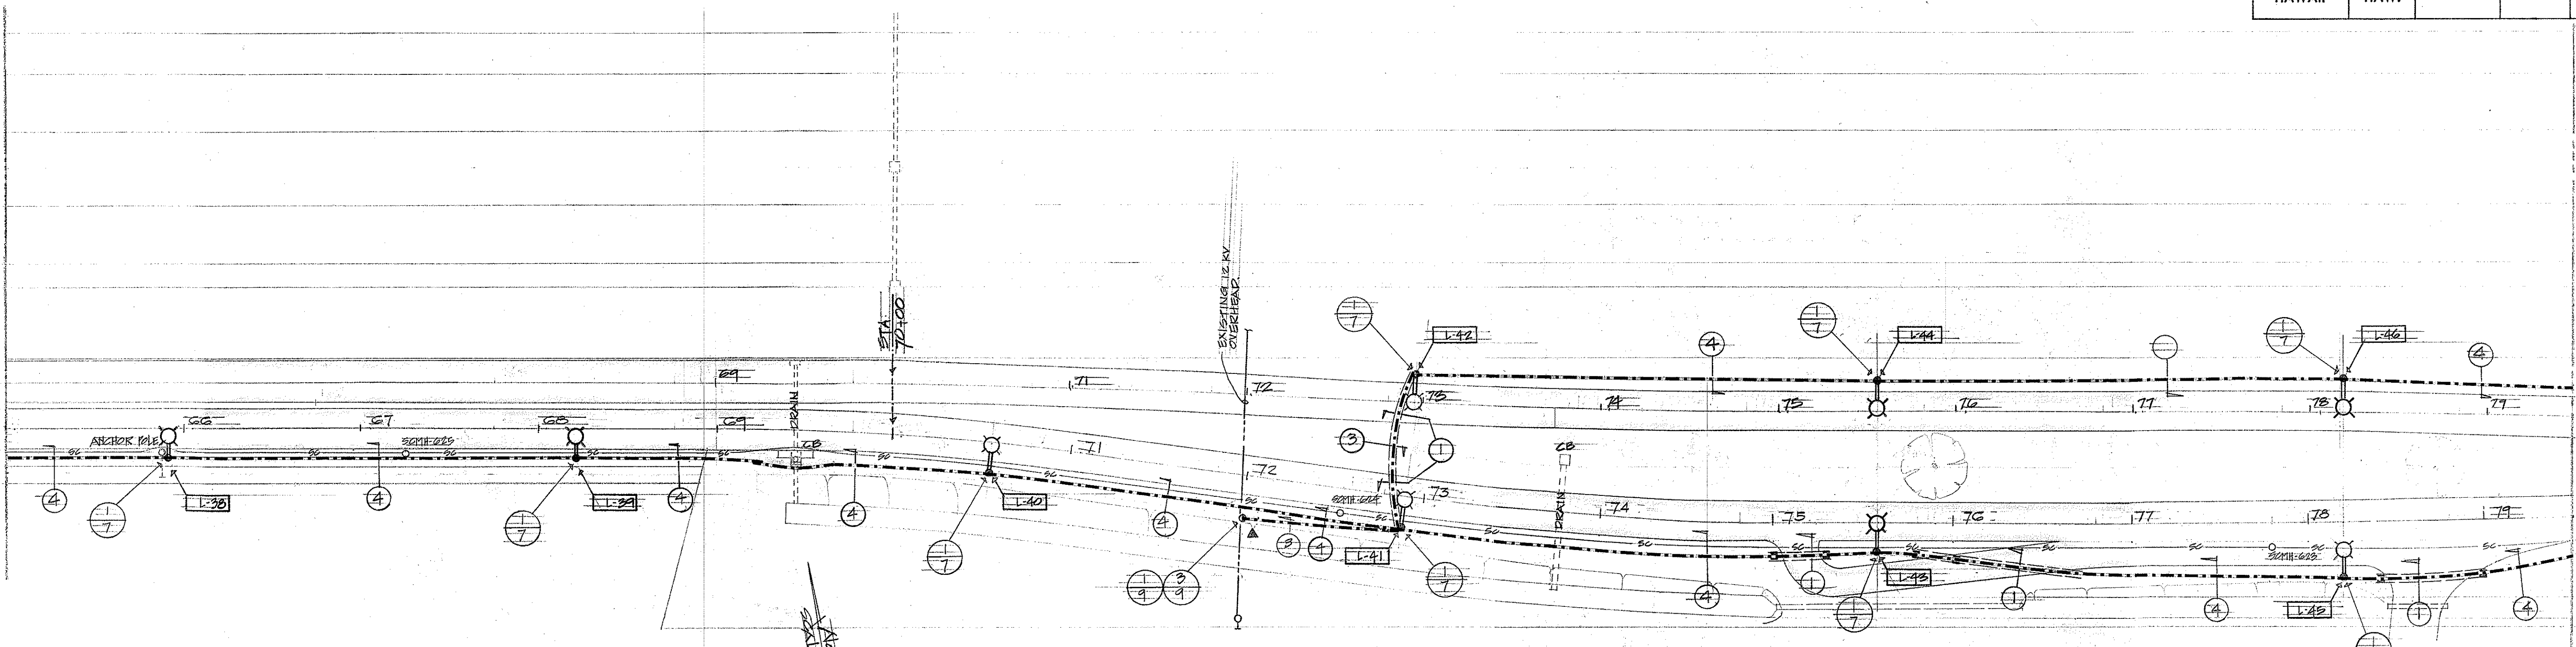

PARTIAL STREET LIGHTING PLAN
STA. 65+00 TO STA. 80+00

NOTE:
SEE DIST. SECTIONS
ON SHEET 7, DETAIL 3/7

KAM
HIGHWAY

HIMITZ
HIGHWAY


MAITCH LINE "G"
STA. 74+50

KAM
HIGHWAY

KAM
HIGHWAY

HIMITZ
HIGHWAY

MAITCH LINE "G"
STA. 74+50

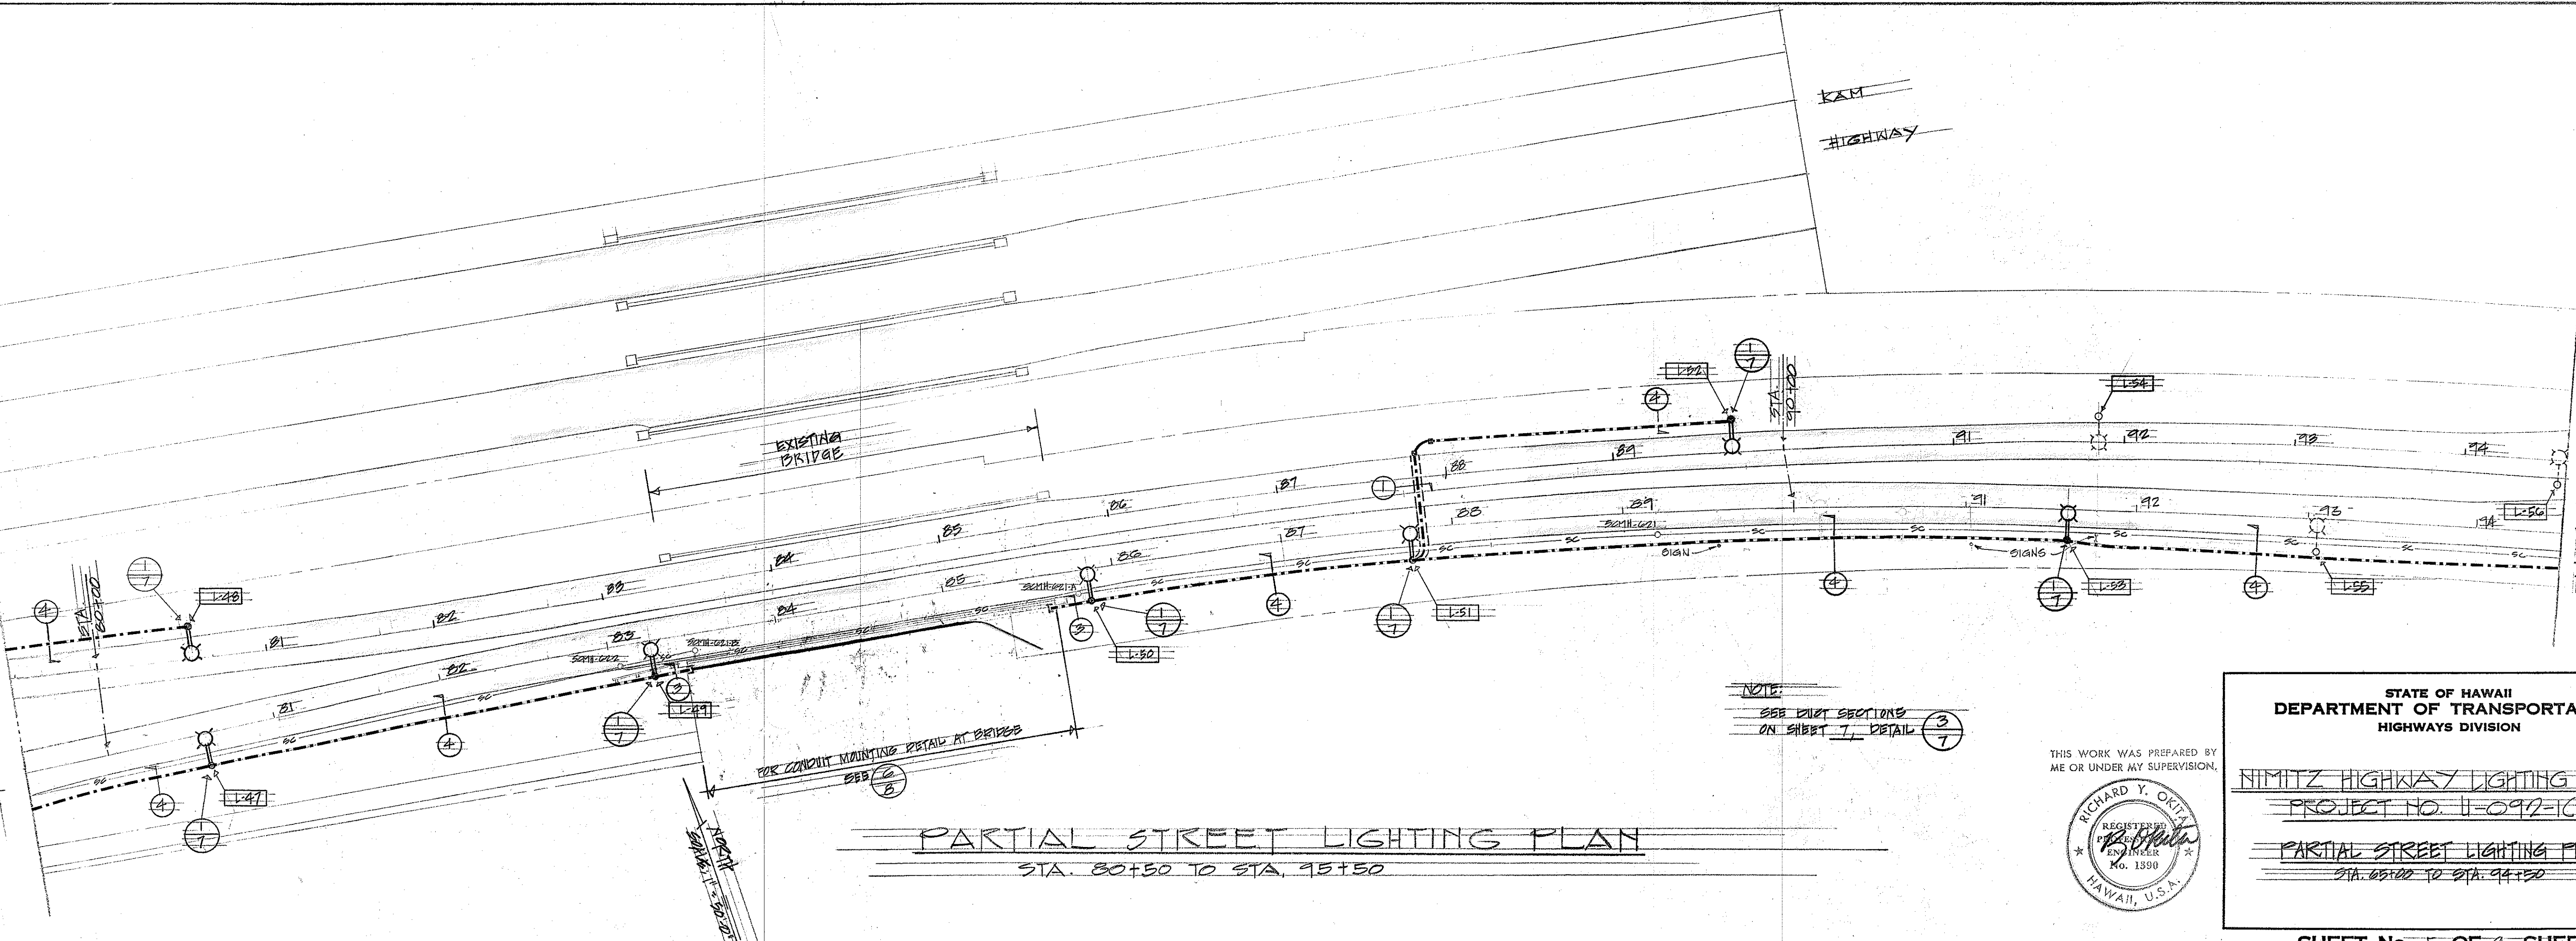

PARTIAL STREET LIGHTING PLAN
STA. 80+50 TO STA. 95+50


NOTE:
SEE DIST. SECTIONS
ON SHEET 7, DETAIL 3/7

FOR CONDUIT MOUNTING DETAIL AT BRIDGE
SEE 2/3

HIMITZ
HIGHWAY

MAITCH LINE "H"
STA. 94+50

ORIGINAL PLAN	DATE
SURVEY PLOTTED BY	
DRAWN BY	
TRACED BY	
DESIGNED BY	
CHECKED BY	
NOTE BOOK	
No.	

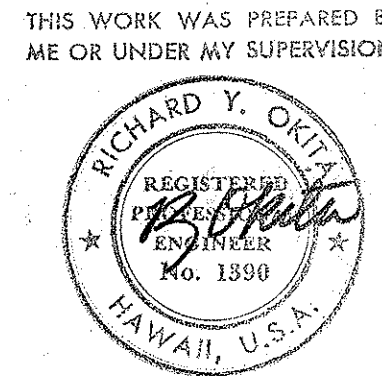

STATE OF HAWAII
DEPARTMENT OF TRANSPORTATION
HIGHWAYS DIVISION

HIMITZ HIGHWAY LIGHTING SYSTEM
PROJECT NO. H-092-(16)

PARTIAL STREET LIGHTING PLAN
STA. 65+00 TO STA. 95+50

SHEET No. 5 OF 9 SHEETS