




DATE: \_\_\_\_\_  
 SURVEY PLOTTED BY: \_\_\_\_\_  
 PLAN: \_\_\_\_\_  
 DESIGNED BY: \_\_\_\_\_  
 NOTE BOOK: \_\_\_\_\_  
 QUANTITIES BY: \_\_\_\_\_  
 CHECKED BY: \_\_\_\_\_  
 No. \_\_\_\_\_

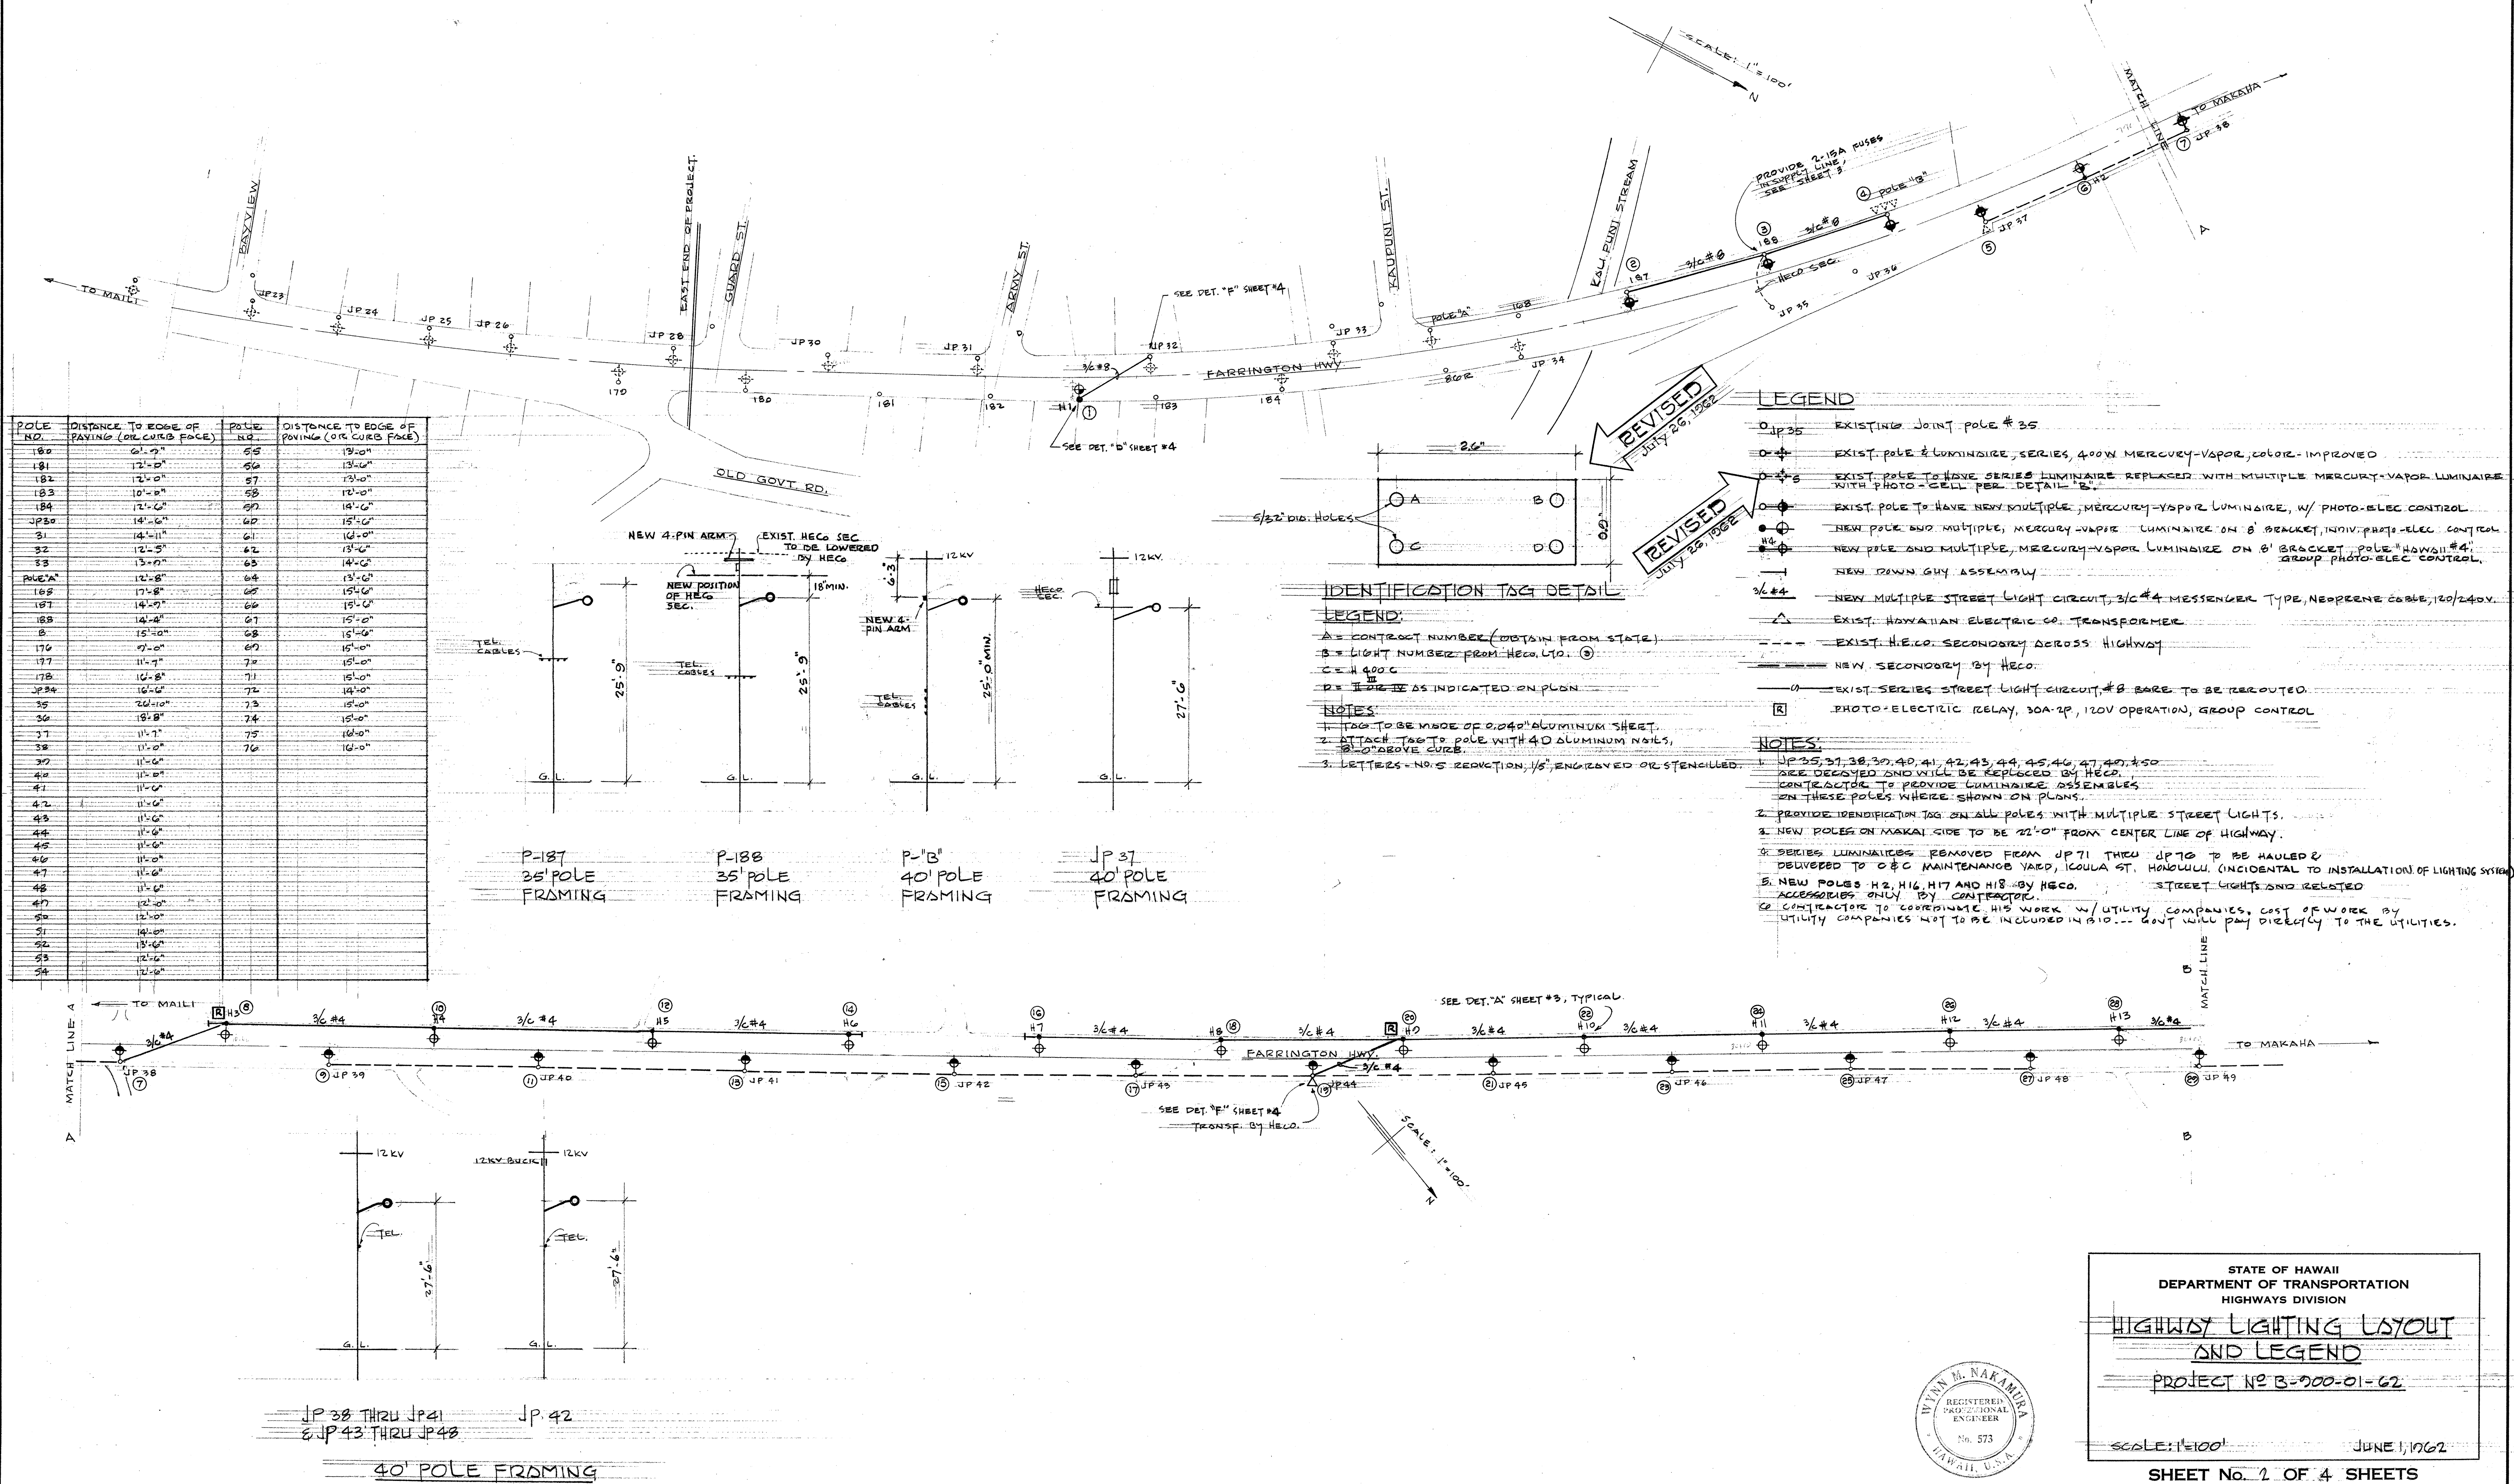

STATE OF HAWAII  
 DEPARTMENT OF TRANSPORTATION  
 HIGHWAYS DIVISION

**HIGHWAY LIGHTING LAYOUT  
 AND LEGEND**

PROJECT NO B-200-01-62

SCALE: 1"=100' JUNE 1, 1962

SHEET No. 1 OF 4 SHEETS