


ORIGINAL PLAN	SURVEY PLOTTED BY.....	DATE.....
NOTE BOOK	DRAWN BY.....	41
	TRACED BY.....	41
	DESIGNED BY.....	41
	QUANTITIES BY.....	41
No.....	CHECKED BY.....	41

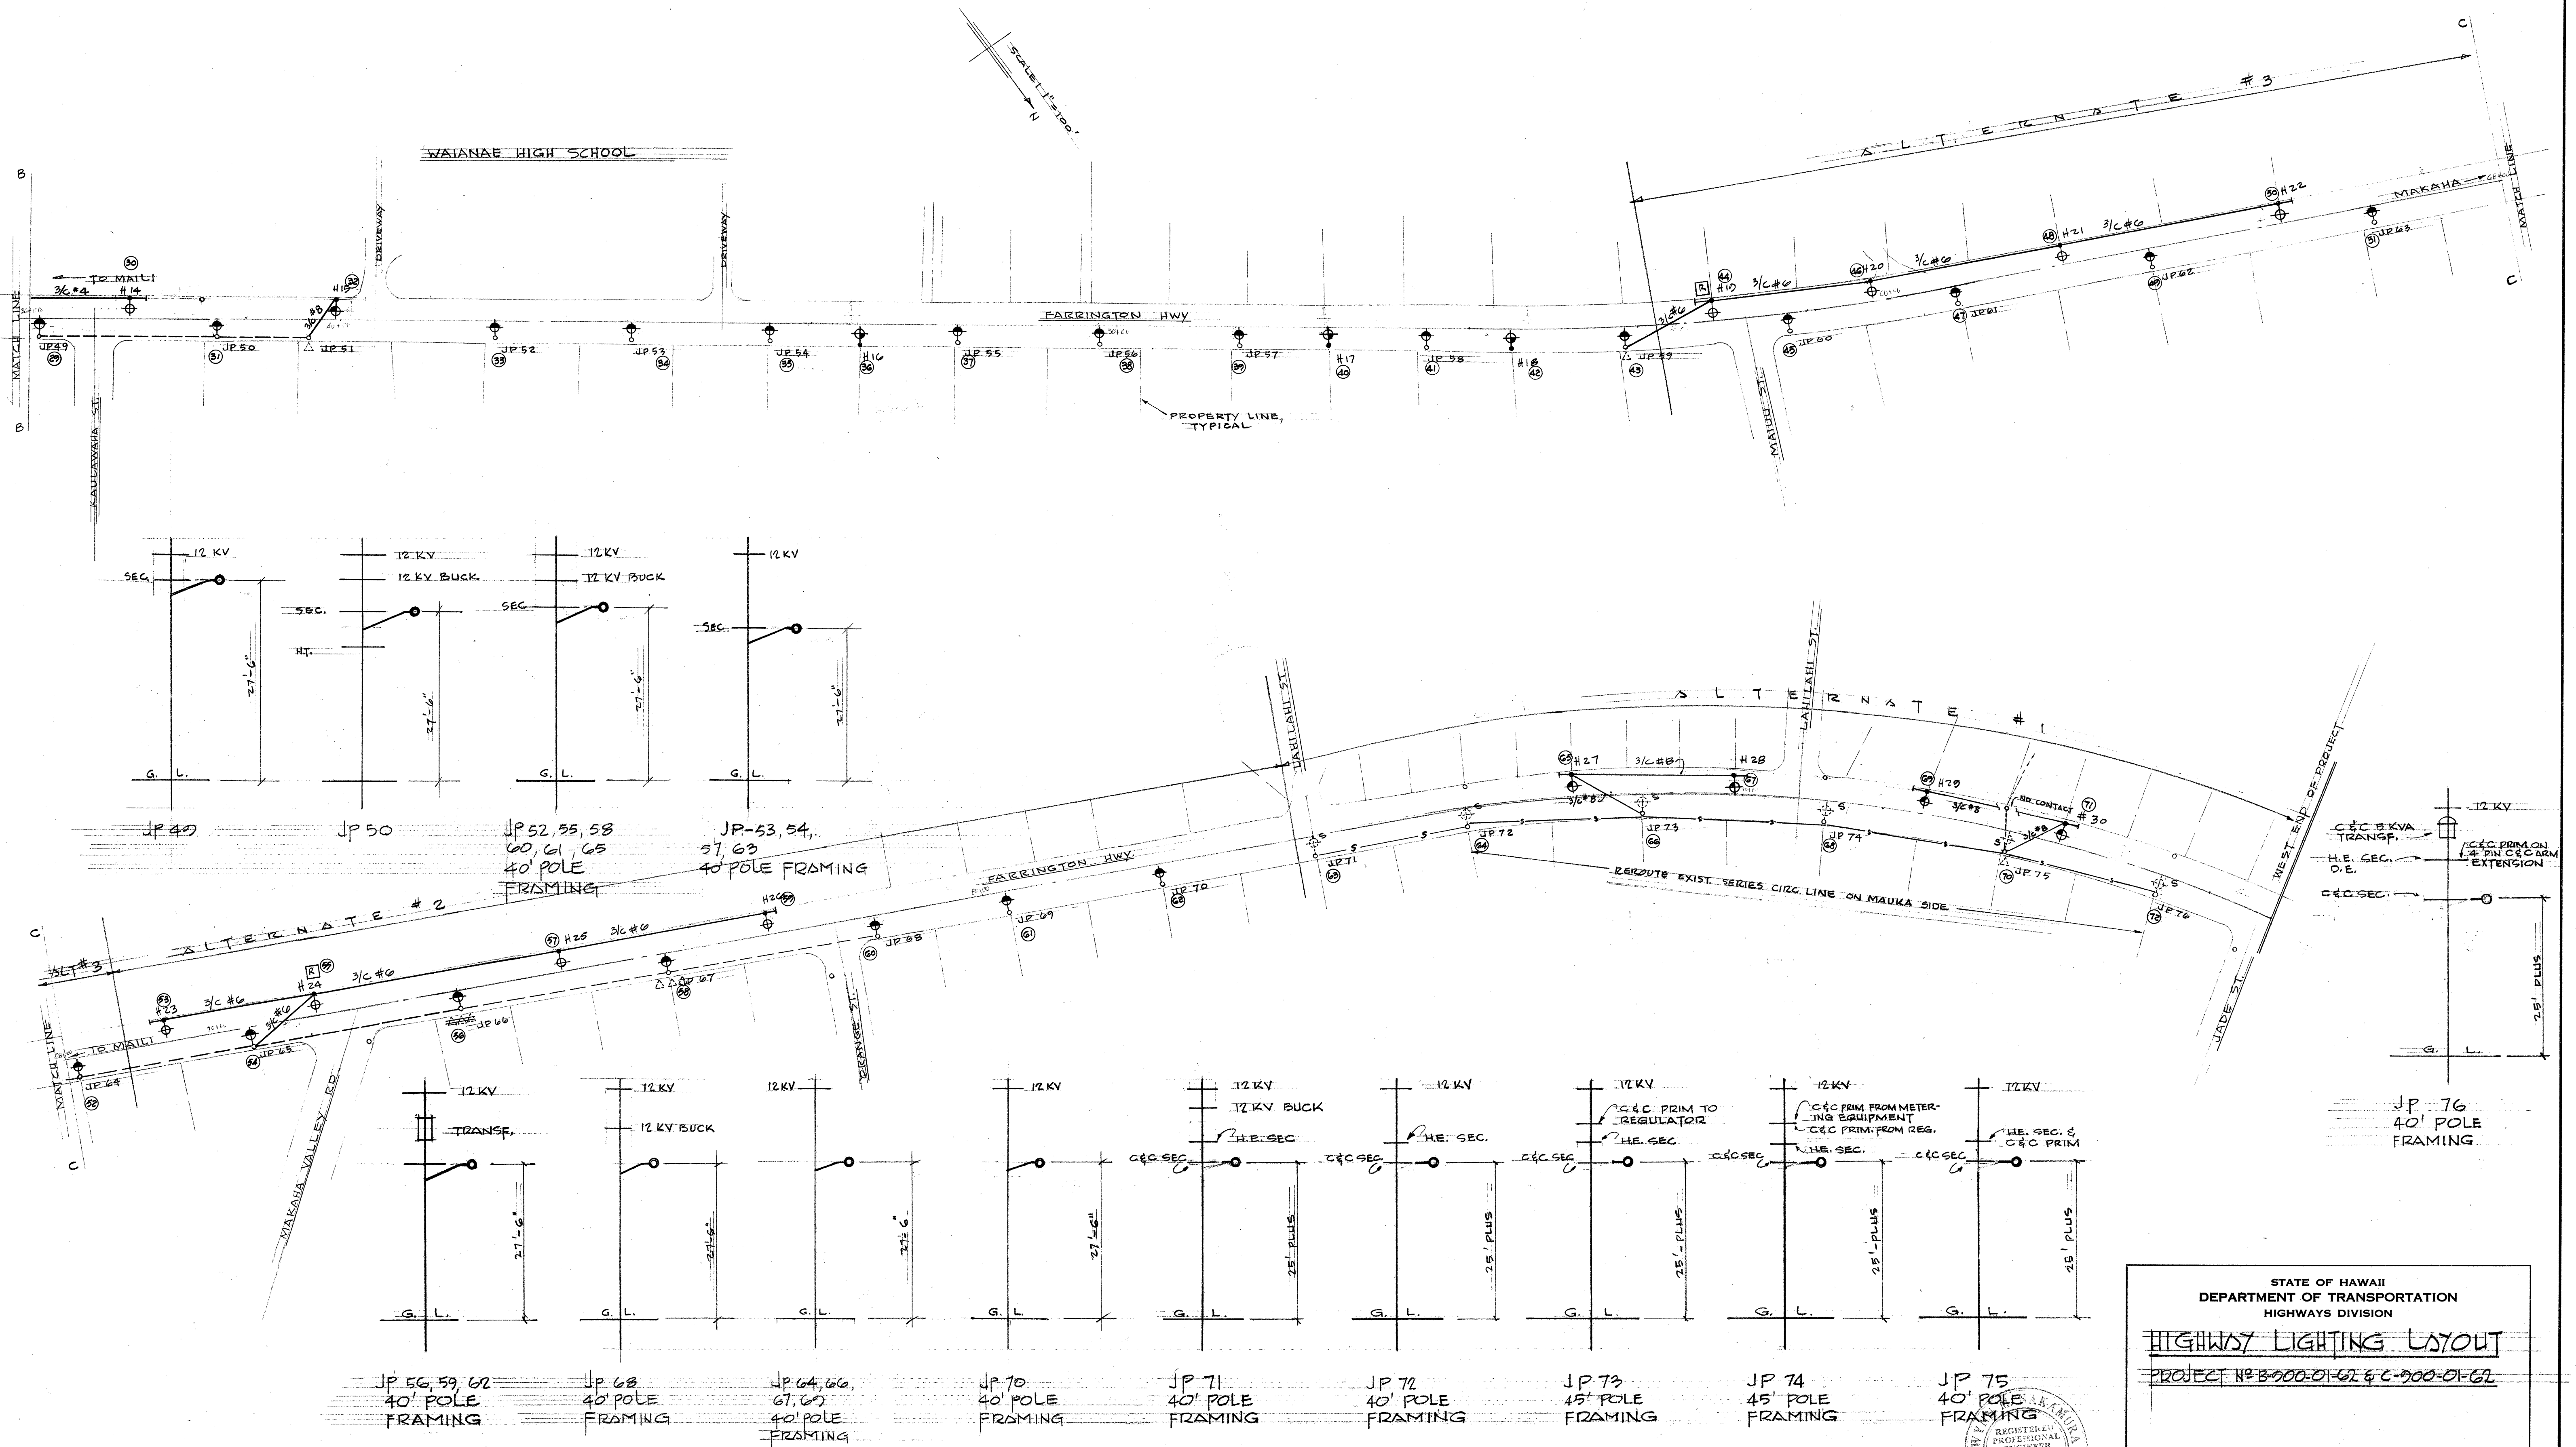

STATE OF HAWAII
DEPARTMENT OF TRANSPORTATION
HIGHWAYS DIVISION

HIGHWAY LIGHTING LAYOUT

PROJECT NO B-900-01-62 & C-900-01-62

SCALE: 1"=100' JUNE 1, 1962

SHEET No. 3 OF 4 SHEETS