

"AS BUILT"

INSTALLATION OF HIGHWAY LIGHTS

ALONG FARRINGTON HIGHWAY


FROM OLD GOVERNMENT ROAD TO JADE STREET

WAIANAE DISTRICT, HAWAII

PROJECT B-900-01-62 AND C-900-01-62

WYNN NAKAMURA LTD. CONSULTING ELECTRICAL ENGINEERS

INDEX OF DRAWINGS	
SHEET NO.	TITLE
1	VICINITY & LOCATION MAPS
2	HIGHWAY LIGHTING LAYOUT & LEGEND
3	HIGHWAY LIGHTING LAYOUT
4	HIGHWAY LIGHTING DETAILS

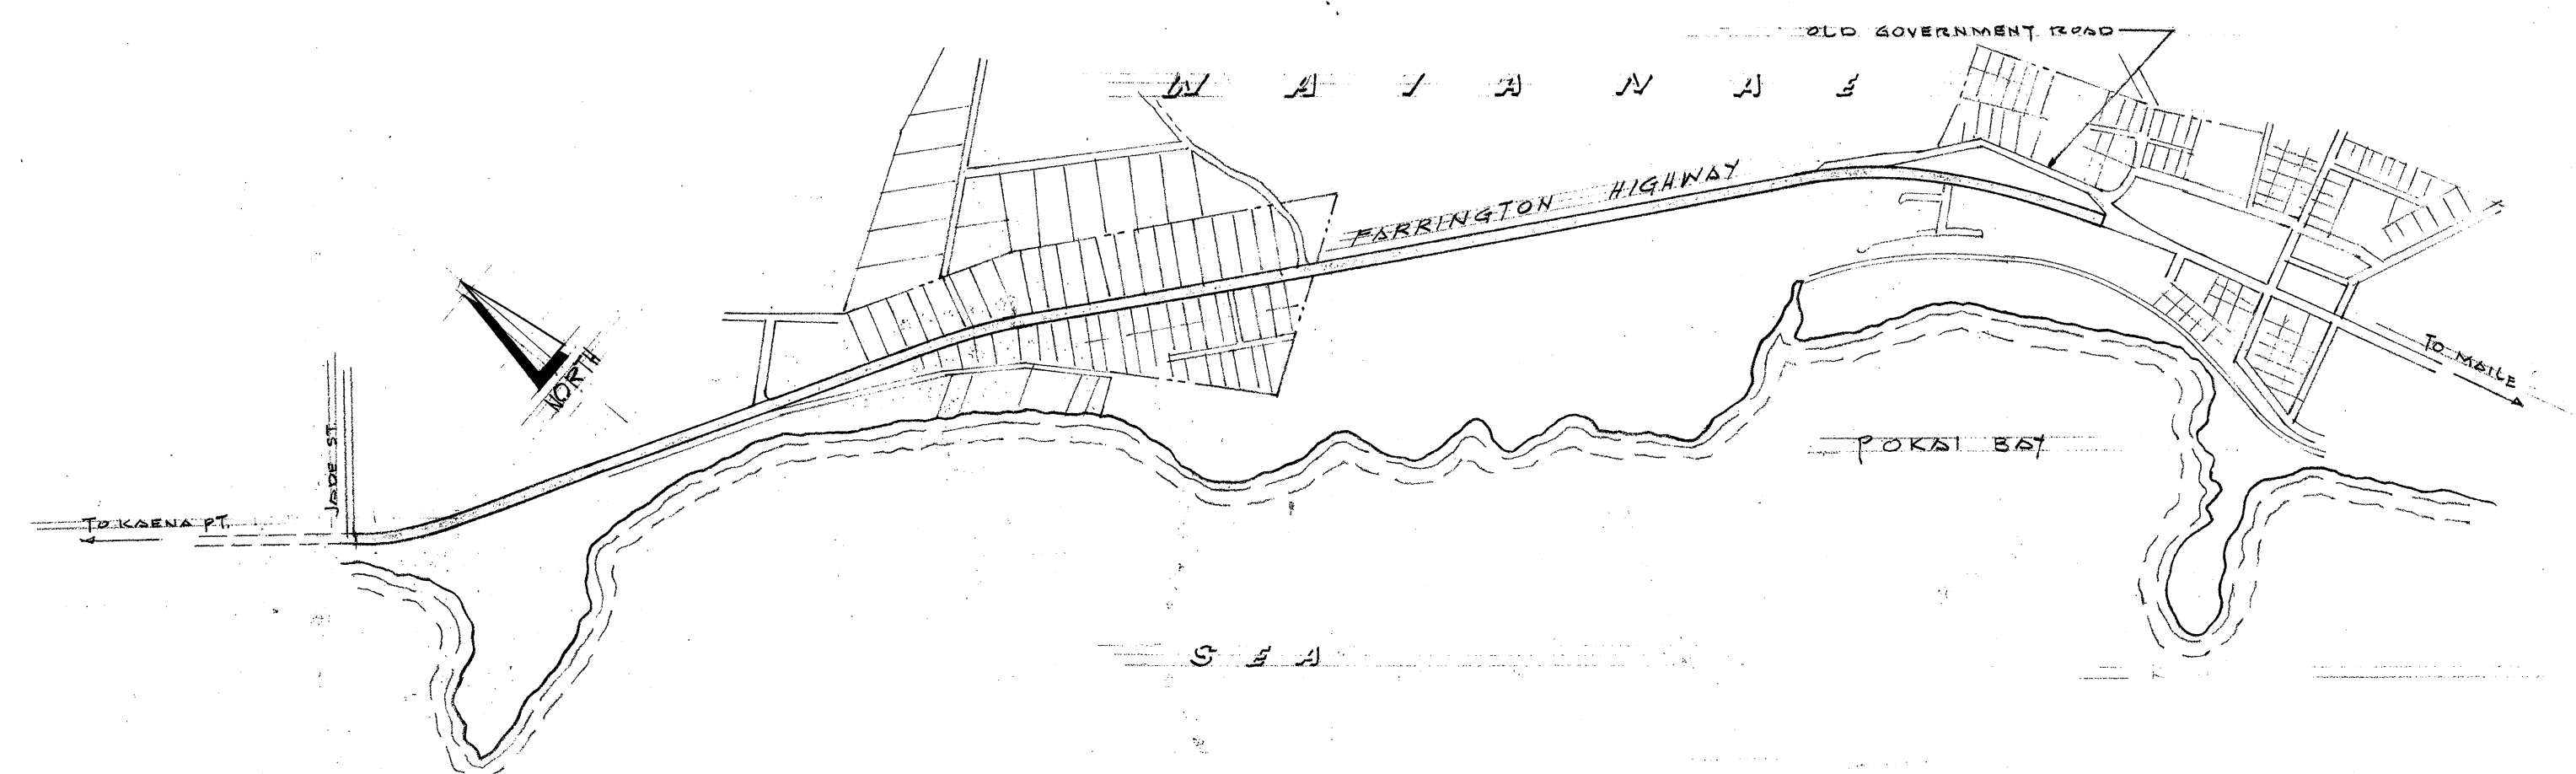

VICINITY PLAN

NOTE: ALL CHANGES MADE DURING CONSTRUCTION ARE SHOWN IN RED ON THESE TRACINGS AND CHECKED BY

G. Nakamura
for PROJECT ENGINEER (K. Nakamura)

8/5/62
DATE

APPROVED: DATE: 6/20/62
Sam O. Hirota
for DIRECTOR OF TRANSPORTATION