

INDEX TO DRAWINGS	
COMPOSITE AND SET SHT. NO.	DESCRIPTION
1	TITLE SHEET
2 - 3	TYPICAL ROADWAY SECTIONS
4 - 9	PLAN & PROFILE
10 - 11	TRANSITION DETAILS
12 - 16	INTERSECTION DETAILS
17 - 21	DRIVEWAY DETAILS
22 - 27	ORDER OF WORK & DETOURS
28 - 30	ROADWAY SIGNS
31 - 41	STD. ROADWAY SIGNS & GUARDRAILS
42	TYPICAL SWALE SECTION
43	TYPE "B" SHOULDER DROP INTAKE
44 - 46	STD. DRAINAGE DETAILS
47	CULVERT AT STA. 152 + 59
48 - 49	CULVERT AT STA. 155 + 54
50 - 54	NANAKULI BRIDGE
55 - 60	MISCELLANEOUS BRIDGE DETAILS
61 - 66	MISCELLANEOUS STD. DETAILS
67 - 68	RIGHT-OF-WAY
69 - 82	CROSS SECTIONS
83 - 85	UTILITIES
*86 - 88	UTILITY DETAILS
89 - 95	HIGHWAY LIGHTING PLANS
*CO87S	UTILITY DETAIL
*CO88S-1	PEDESTRIAN SIGNALS
CO88S-2	PLANS AND DETAILS
CO88S-3	


STATE OF HAWAII
DEPARTMENT OF TRANSPORTATION
HIGHWAYS DIVISION
HONOLULU, HAWAII
"AS BUILT"
PLANS OF
FARRINGTON HIGHWAY WIDENING
ULEHAWA STREAM TO NANAKULI BRIDGE
PROJECT B-900-01-64
UNIT II

DISTRICT OF WAIANAE
ISLAND OF OAHU

SCALES:
PLAN & PROFILE HOR. 1" = 50'
VER. 1" = 10'
CROSS SECTIONS HOR. 1" = 10'
VER. 1" = 10'


LAYOUT PLAN

GROSS LENGTH OF PROJECT 1.596 MI.
BRIDGES OVER 20'-0" SPAN 0.020 MI.
NET LENGTH OF ROADWAY 1.576 MI.

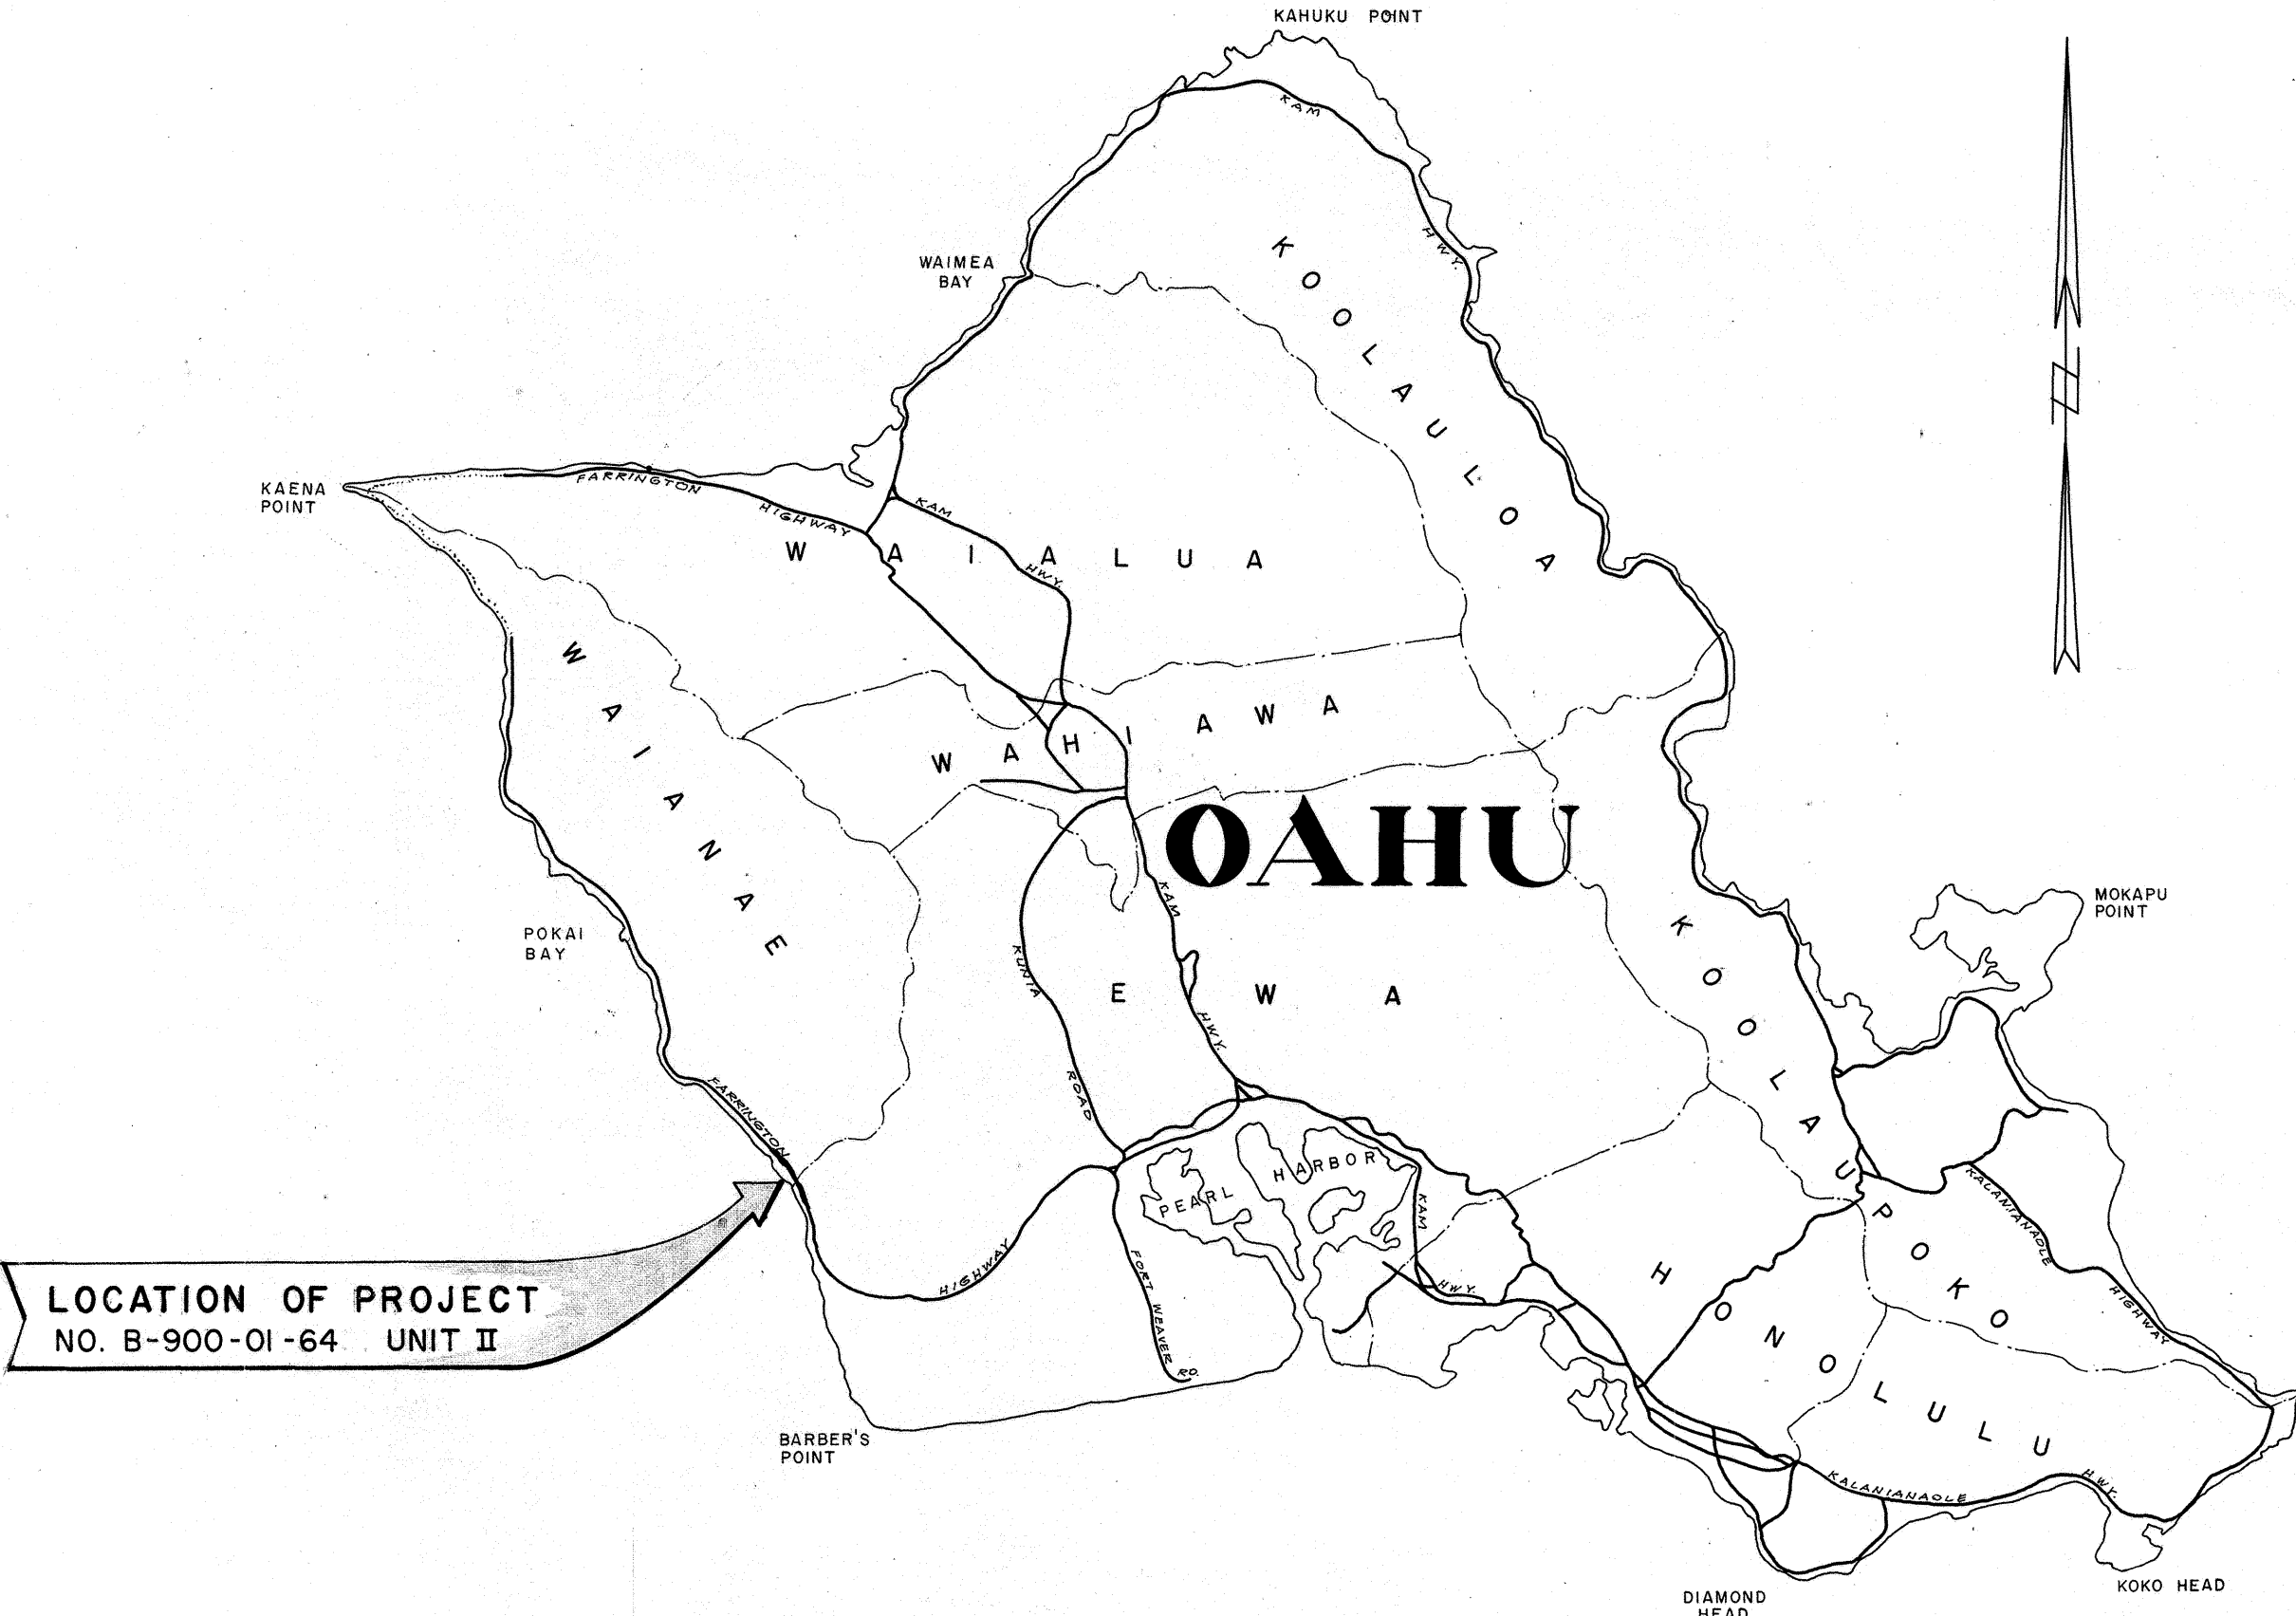


NOTE:
ALL CHANGES MADE DURING CONSTRUCTION HAVE
BEEN NOTED IN RED ON THESE TRACINGS AND
CHECKED BY
Myron Z. Kanemaru 27 July 1971
PROJECT ENGINEER DATE

Plans Prepared By,
SAM O. HIROTA, P. E.
CIVIL ENGINEERS & SURVEYORS

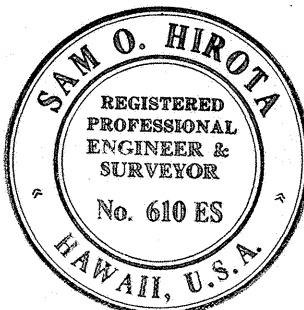

THIS WORK WAS PREPARED BY
ME OR UNDER MY SUPERVISION.
Sam O. Hirota, P.E.

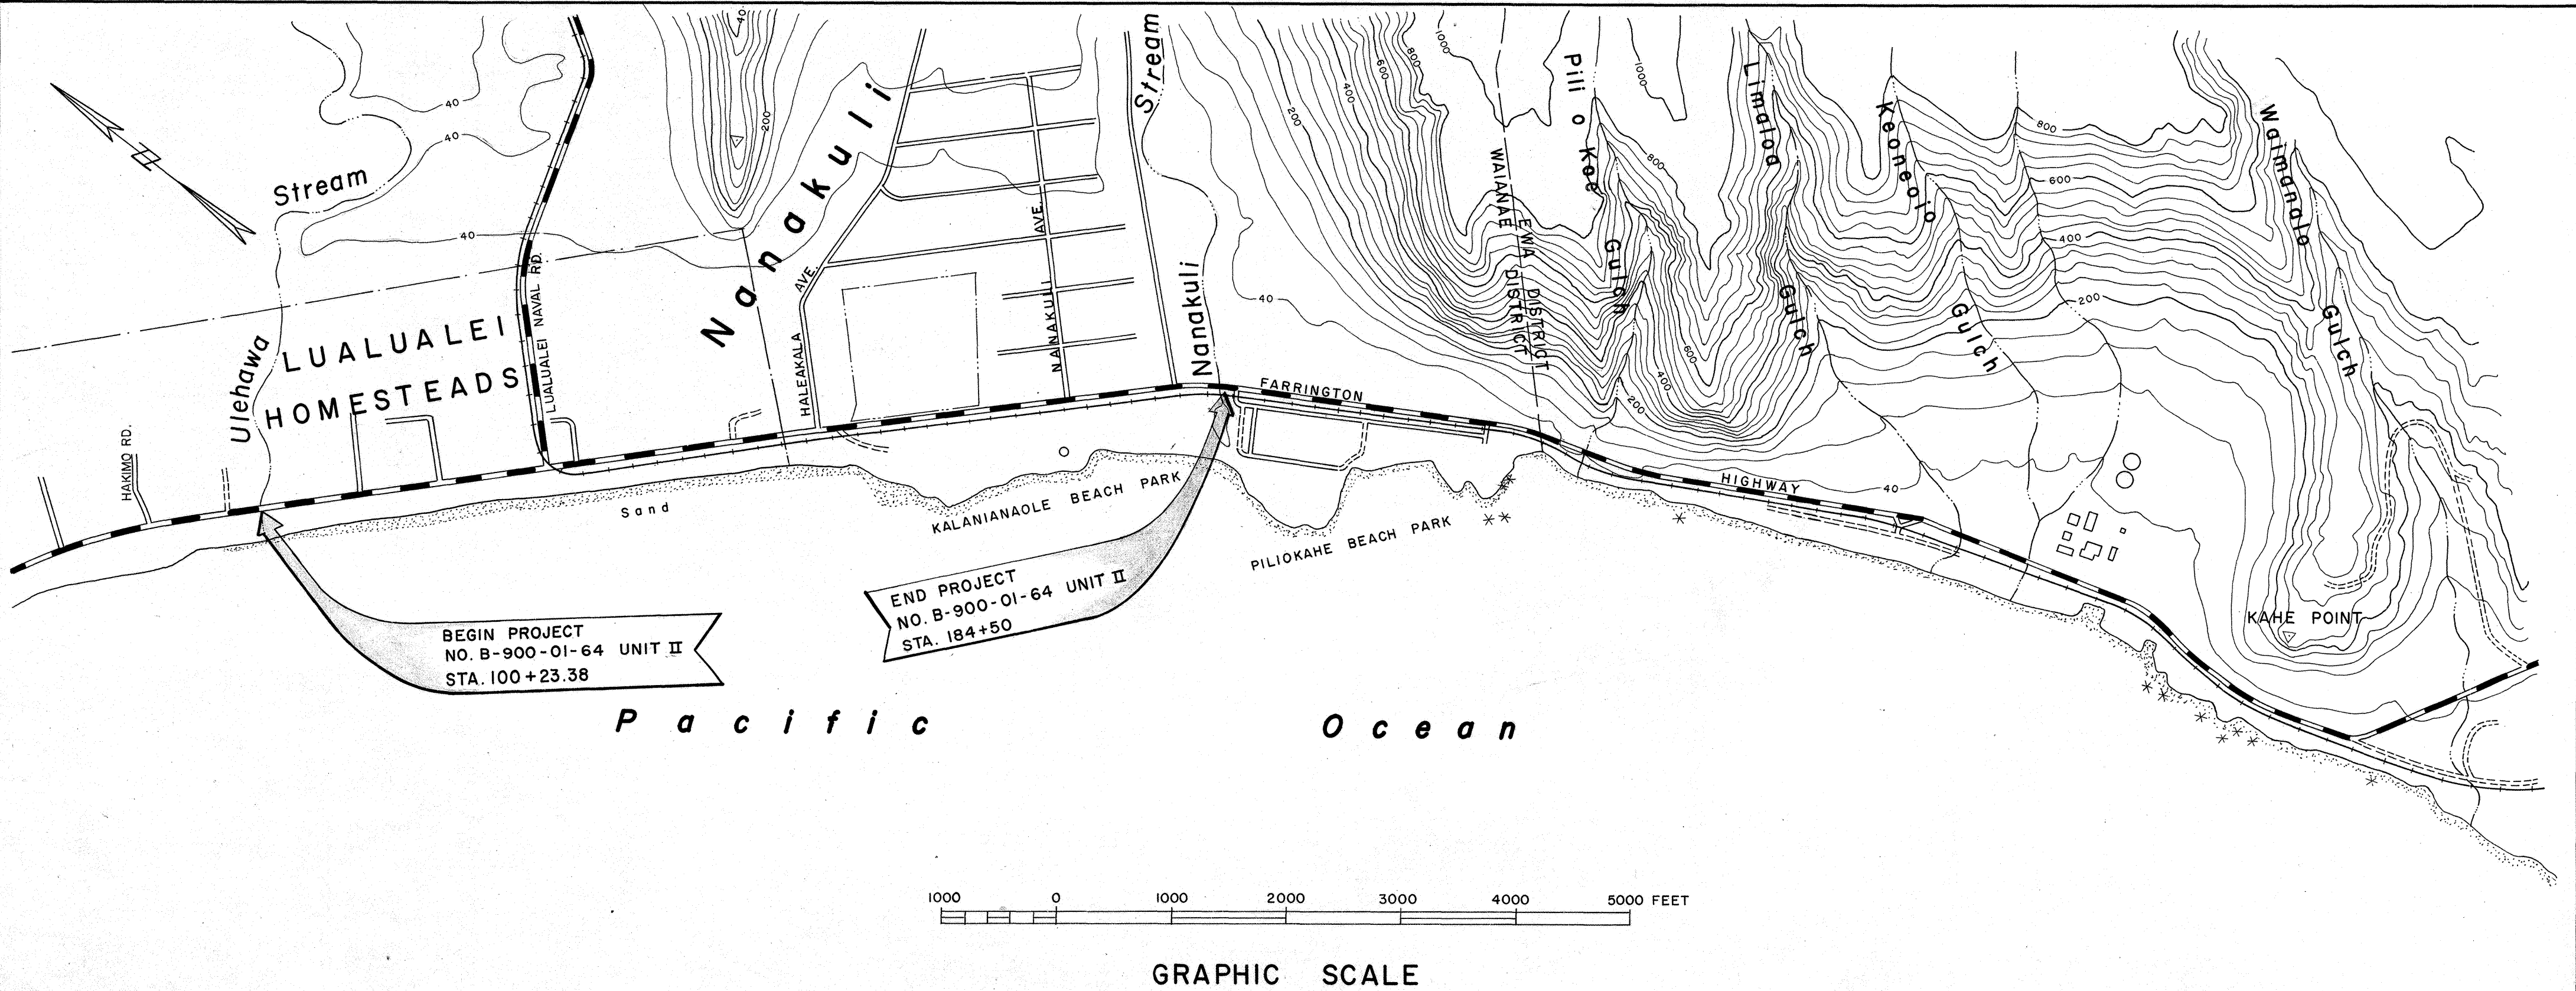

DEPARTMENT OF TRANSPORTATION
STATE OF HAWAII
APPROVED:
John H. Butcher 6/18/68
DIRECTOR OF TRANSPORTATION DATE

All the quantities shown on these plans
are original theoretical quantities. For
actual quantities, refer to project ledger
and/or computation book.