

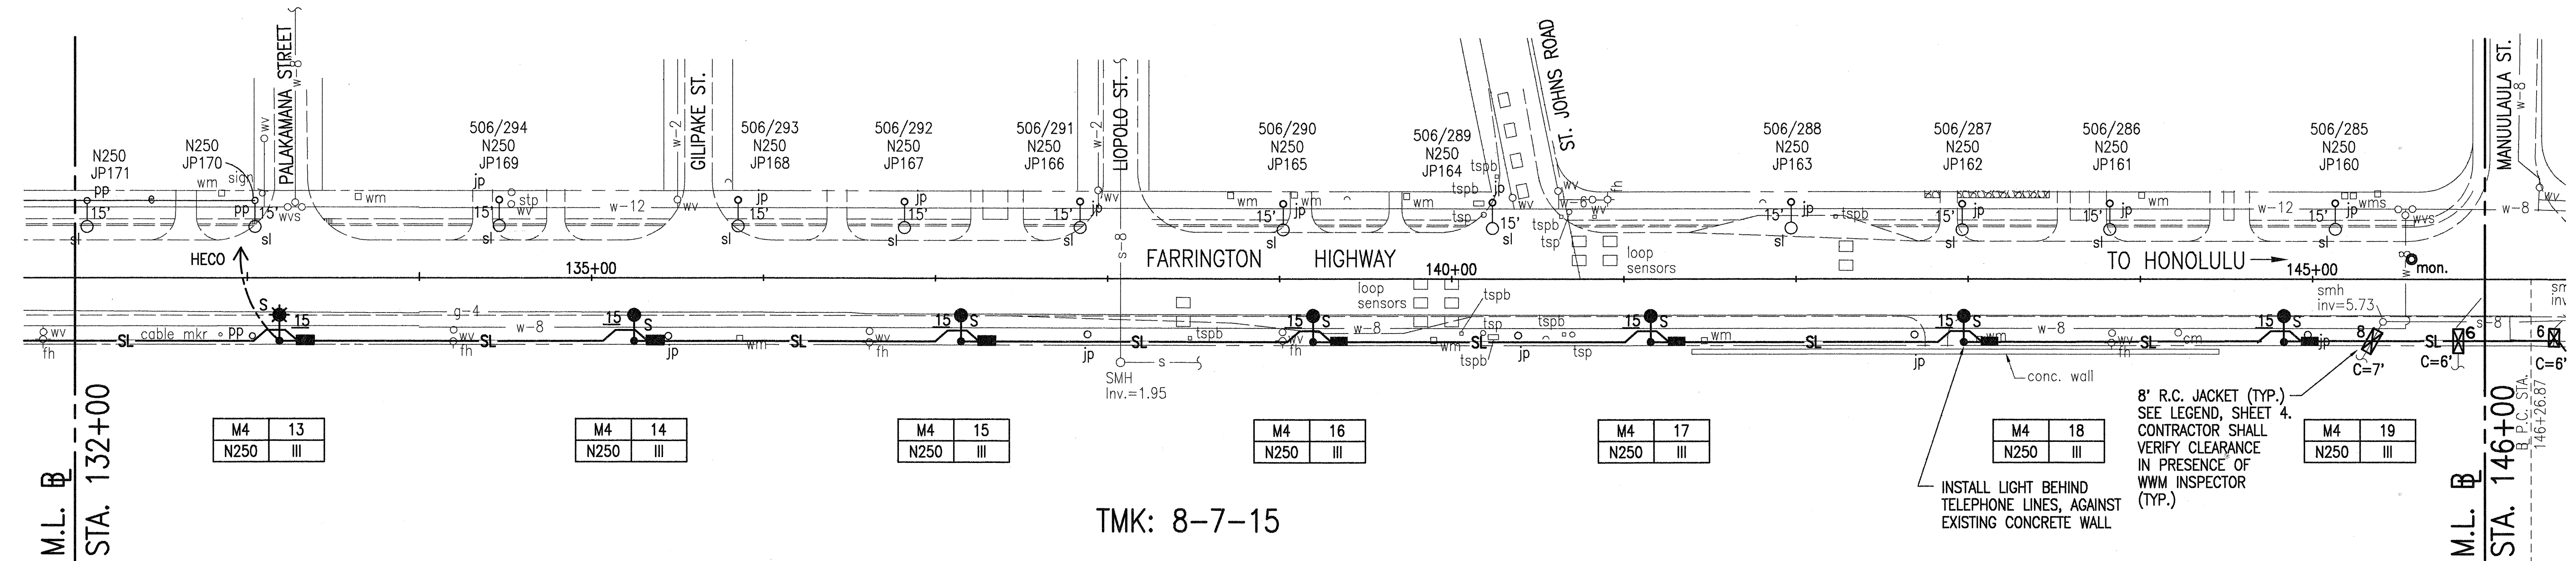


FED. ROAD DIST. NO.	STATE	PROJ. NO.	FISCAL YEAR	SHEET NO.	TOTAL SHEETS
HAWAII	HAW.	93A-02-95	1996	5	13

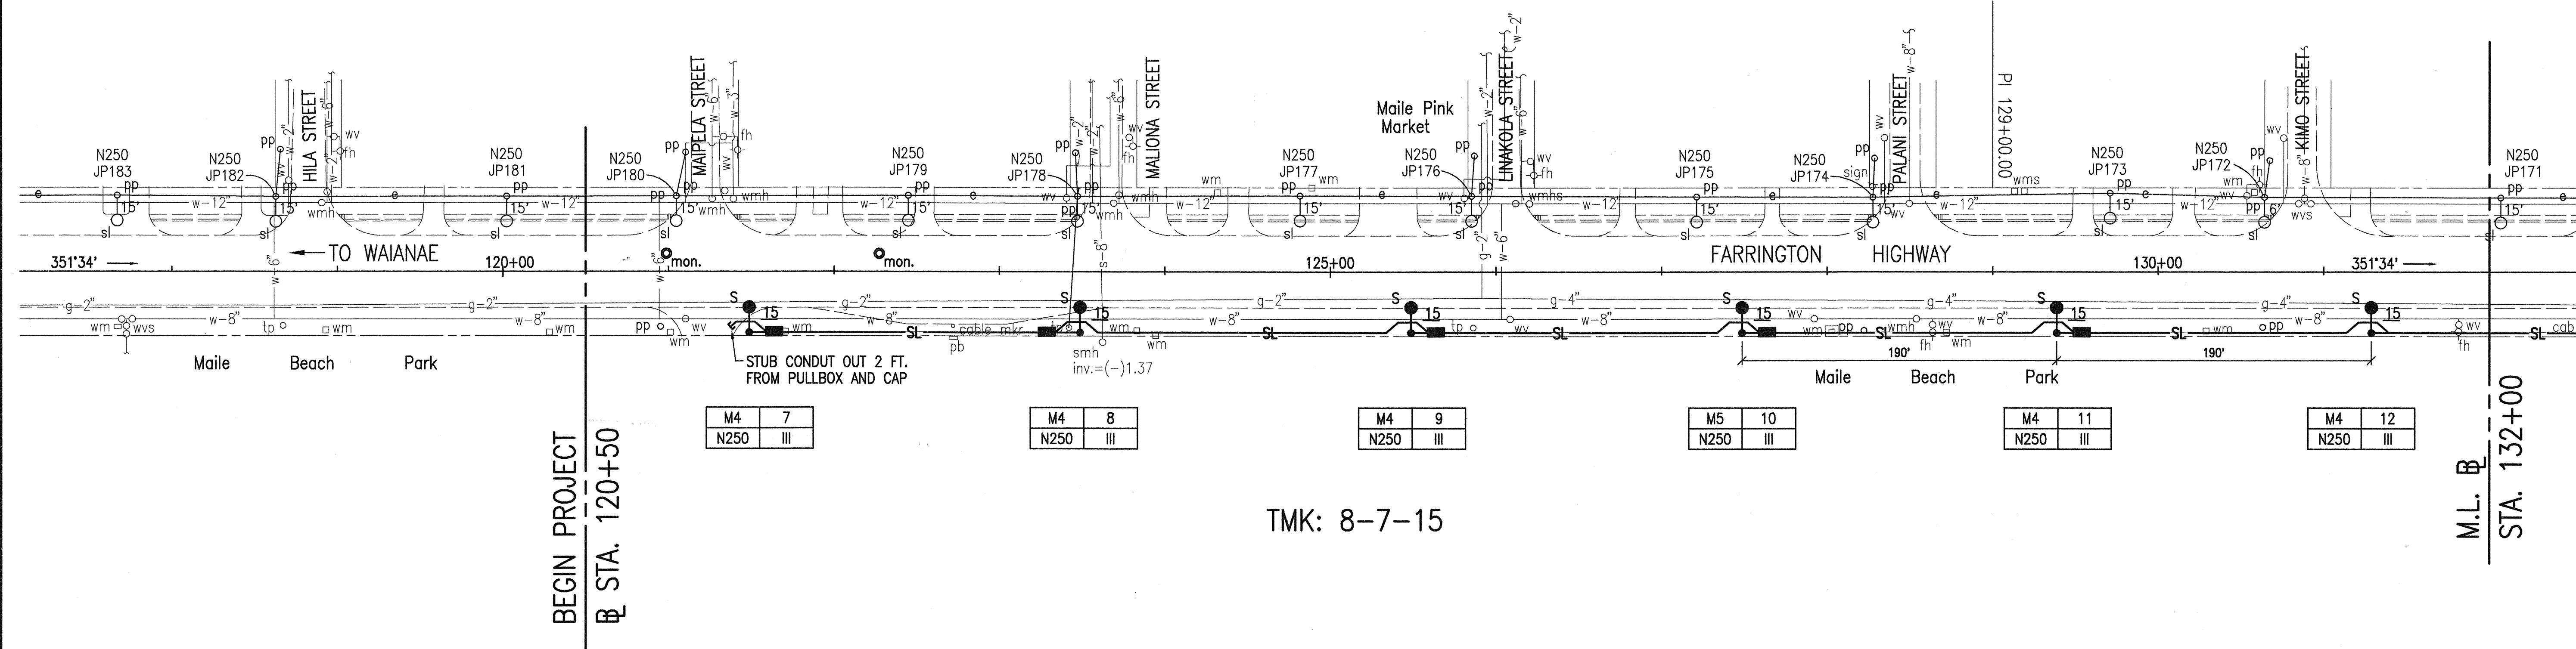

ORIGINAL PLAN	SURVEY PLOTTED BY	DATE
DESIGNED BY		
QUANTITIES BY		
CHECKED BY		
No.		

APPROVED: *[Signature]* 5/15/96
 CHIEF, DIV. OF PLANNING & SERVICE CONTROL, WWM
 (FOR SEWER WORK WITHIN PUBLIC R/W & EASEMENT ONLY)

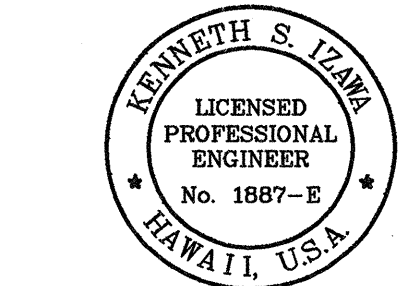

THIS WORK WAS PREPARED BY ME OR UNDER MY SUPERVISION AND CONSTRUCTION OF THIS PROJECT WILL BE UNDER MY OBSERVATION

[Signature]

STATE OF HAWAII
DEPARTMENT OF TRANSPORTATION
HIGHWAYS DIVISION

HIGHWAY LIGHTING PLAN
STA. 120+50 TO 146+00
FARRINGTON HIGHWAY LIGHTING IMPROVEMENTS
MAIPELA ST. TO LUAEI PLACE
PROJECT NO. 93A - 02 - 95
SCALE: 1" = 50'
May, 1996

SHEET No. 5 OF 13 SHEETS

TRUE NORTH
1" = 50'

MANUNU ST.

506/280 N250 JP155
506/279 N250 JP154
506/278 N250 JP153
506/277 N250 JP152
506/276 N250 JP151
506/275 N250 JP150

506/281 N250 JP156
506/282 N250 JP157
506/283 N250 JP158
506/284 N250 JP159

TO WAIANAE

FARRINGTON HIGHWAY


150+00 155+00 160+00

16' FROM PAVEMENT TO ALLOW 5' MIN. CLEARANCE TO S-8



TMK: 8-7-28

M.L. B. STA. 146+00
M.L. B. STA. 161+00

FED. ROAD DIST. NO.	STATE	PROJ. NO.	FISCAL YEAR	SHEET NO.
HAWAII	HAW.	93A-02-95	1996	6

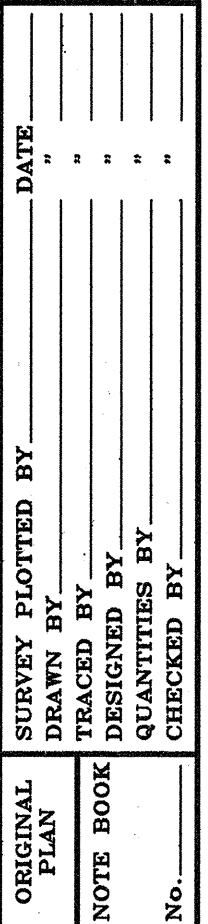

FED. ROAD DIST. NO.	STATE	PROJ. NO.	FISCAL YEAR	SHEET NO.	TOTAL SHEETS
HAWAII	HAW.	93A-02-95	1996	7	13

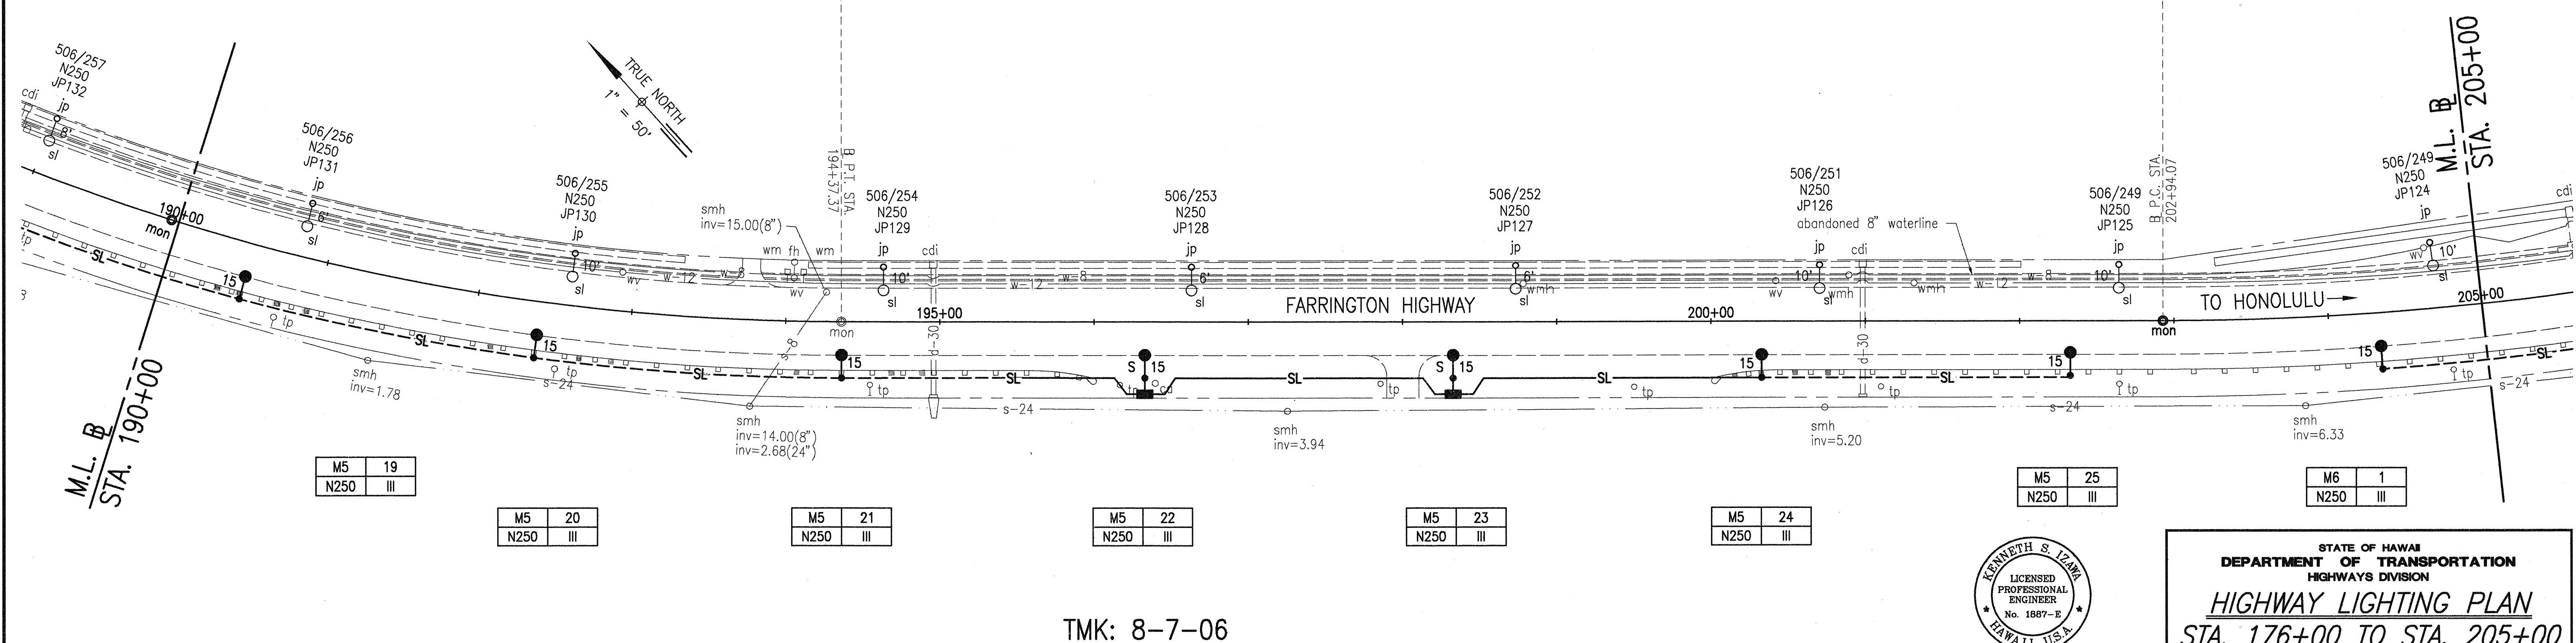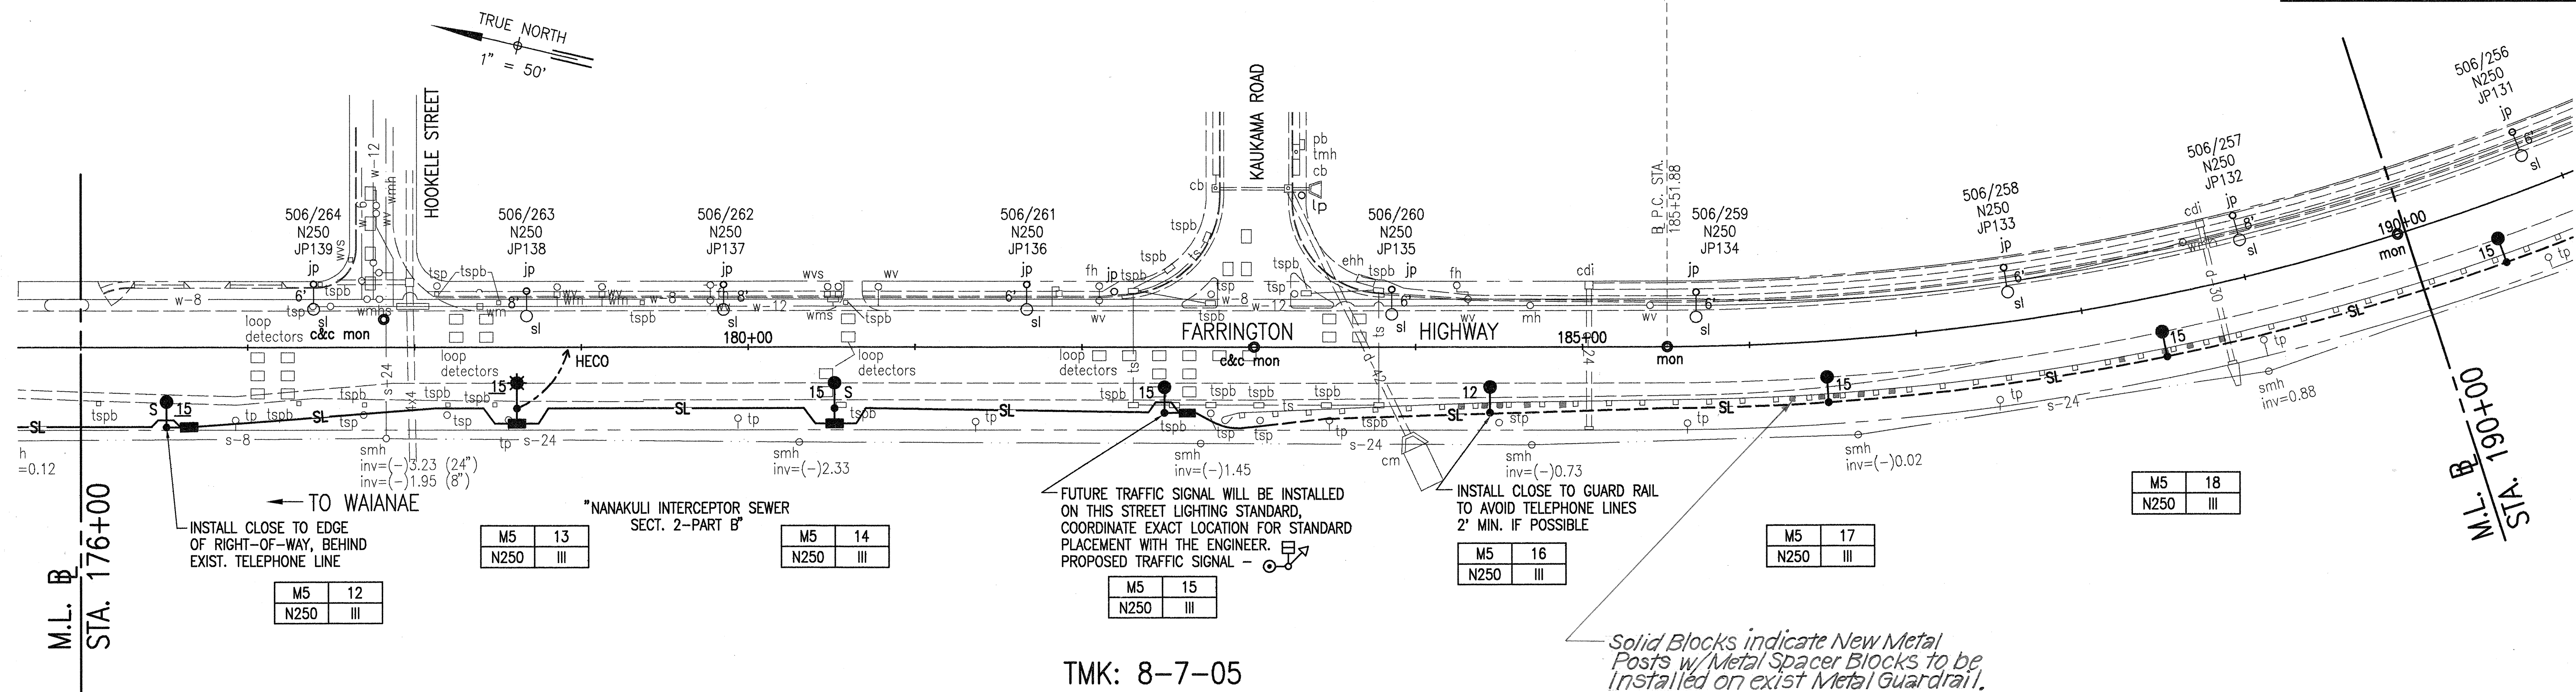

ORIGINAL PLAN	DATE
DRAWN BY	
DESIGNED BY	
CHECKED BY	
NO.	


APPROVED:

[Signature]
CHIEF, DIV. OF PLANNING & SERVICE CONTROL, WWM
(FOR SEWER WORK WITHIN PUBLIC R/W & EASEMENT ONLY)

5/15/96
DATE



THIS WORK WAS PREPARED BY ME OR UNDER MY SUPERVISION AND CONSTRUCTION OF THIS PROJECT WILL BE UNDER MY OBSERVATION

[Signature]

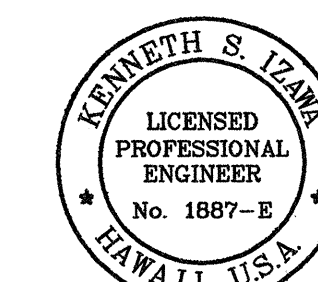


STATE OF HAWAII
DEPARTMENT OF TRANSPORTATION
HIGHWAYS DIVISION
HIGHWAY LIGHTING PLAN
STA. 176+00 TO STA. 205+00
FARRINGTON HIGHWAY LIGHTING IMPROVEMENTS
MAIPELA ST. TO LUALEI PLACE
PROJECT NO. 93A - 02 - 95
SCALE: 1" = 50'
SHEET No. 7 OF 13 SHEETS

FED. ROAD DIST. NO.	STATE	PROJ. NO.	FISCAL YEAR	SHEET NO.	TOTAL SHEETS
HAWAII	HAW.	93A-02-95	1996	8	13

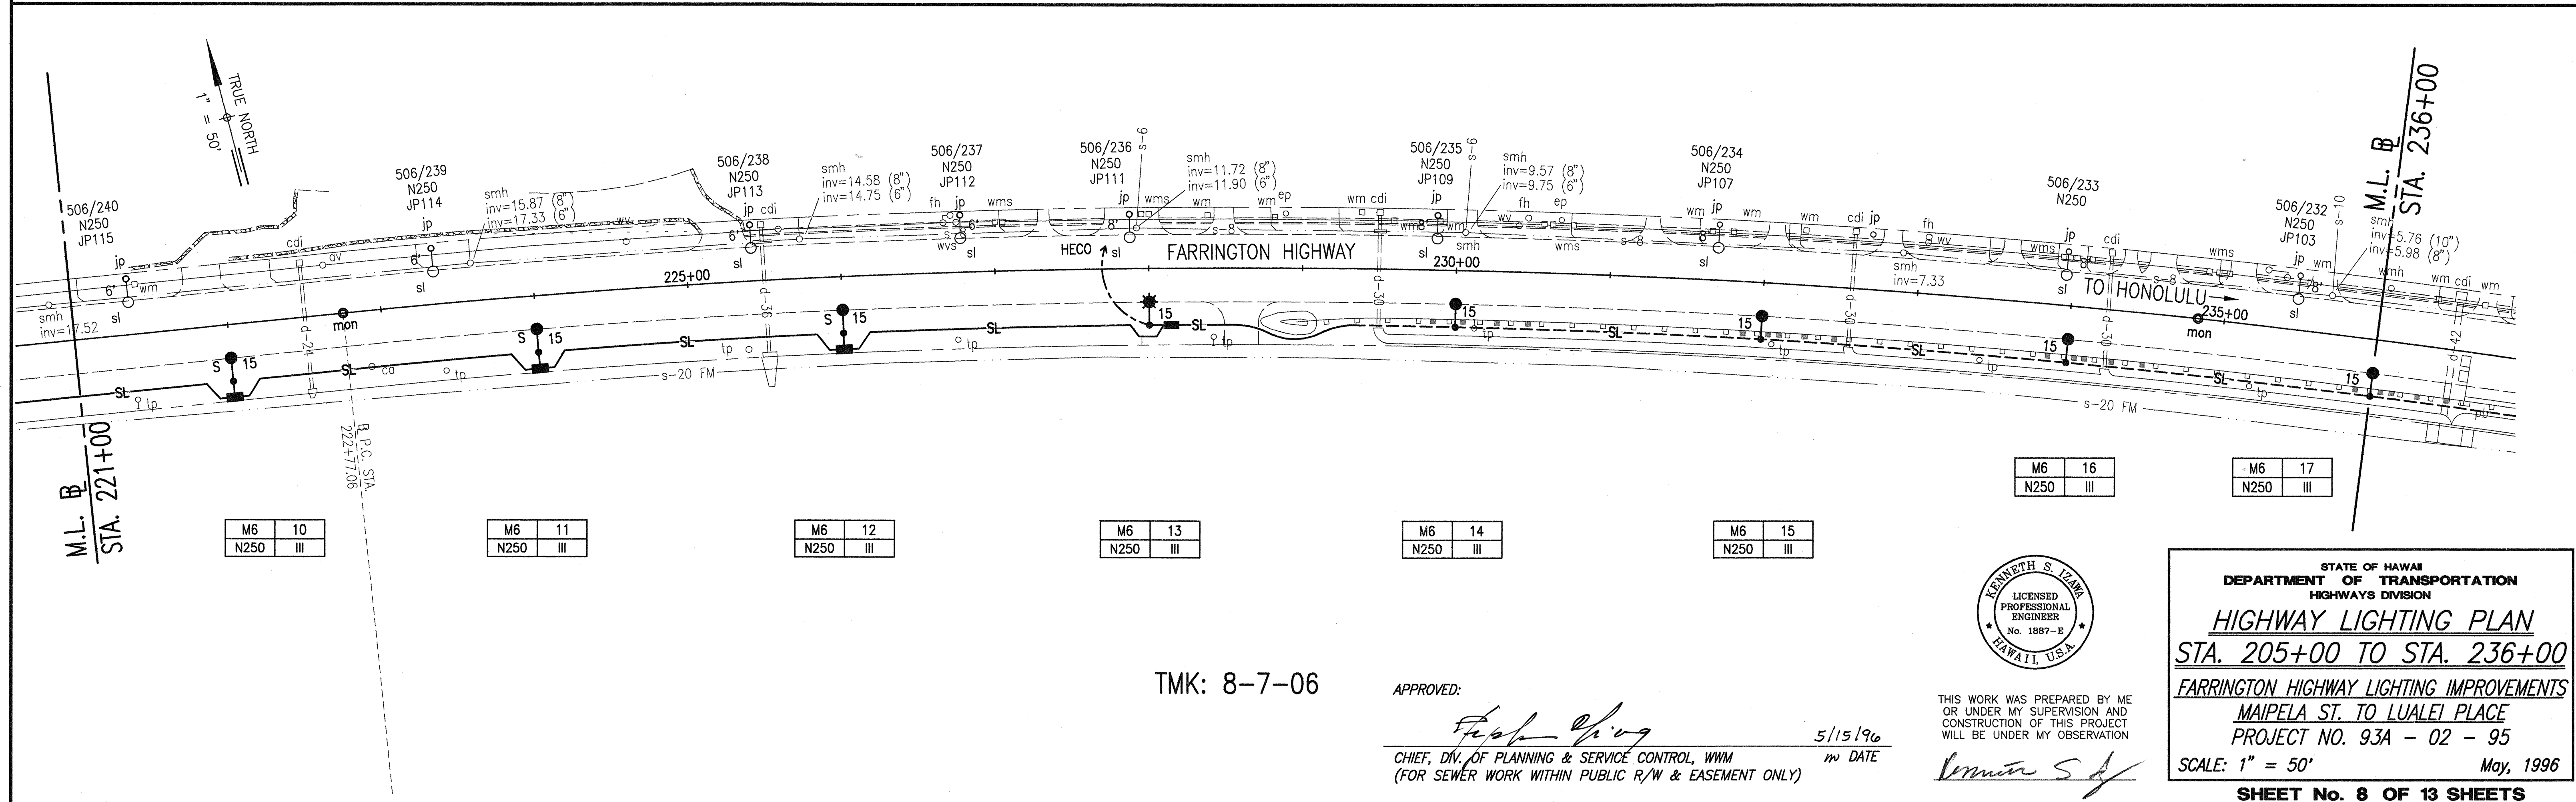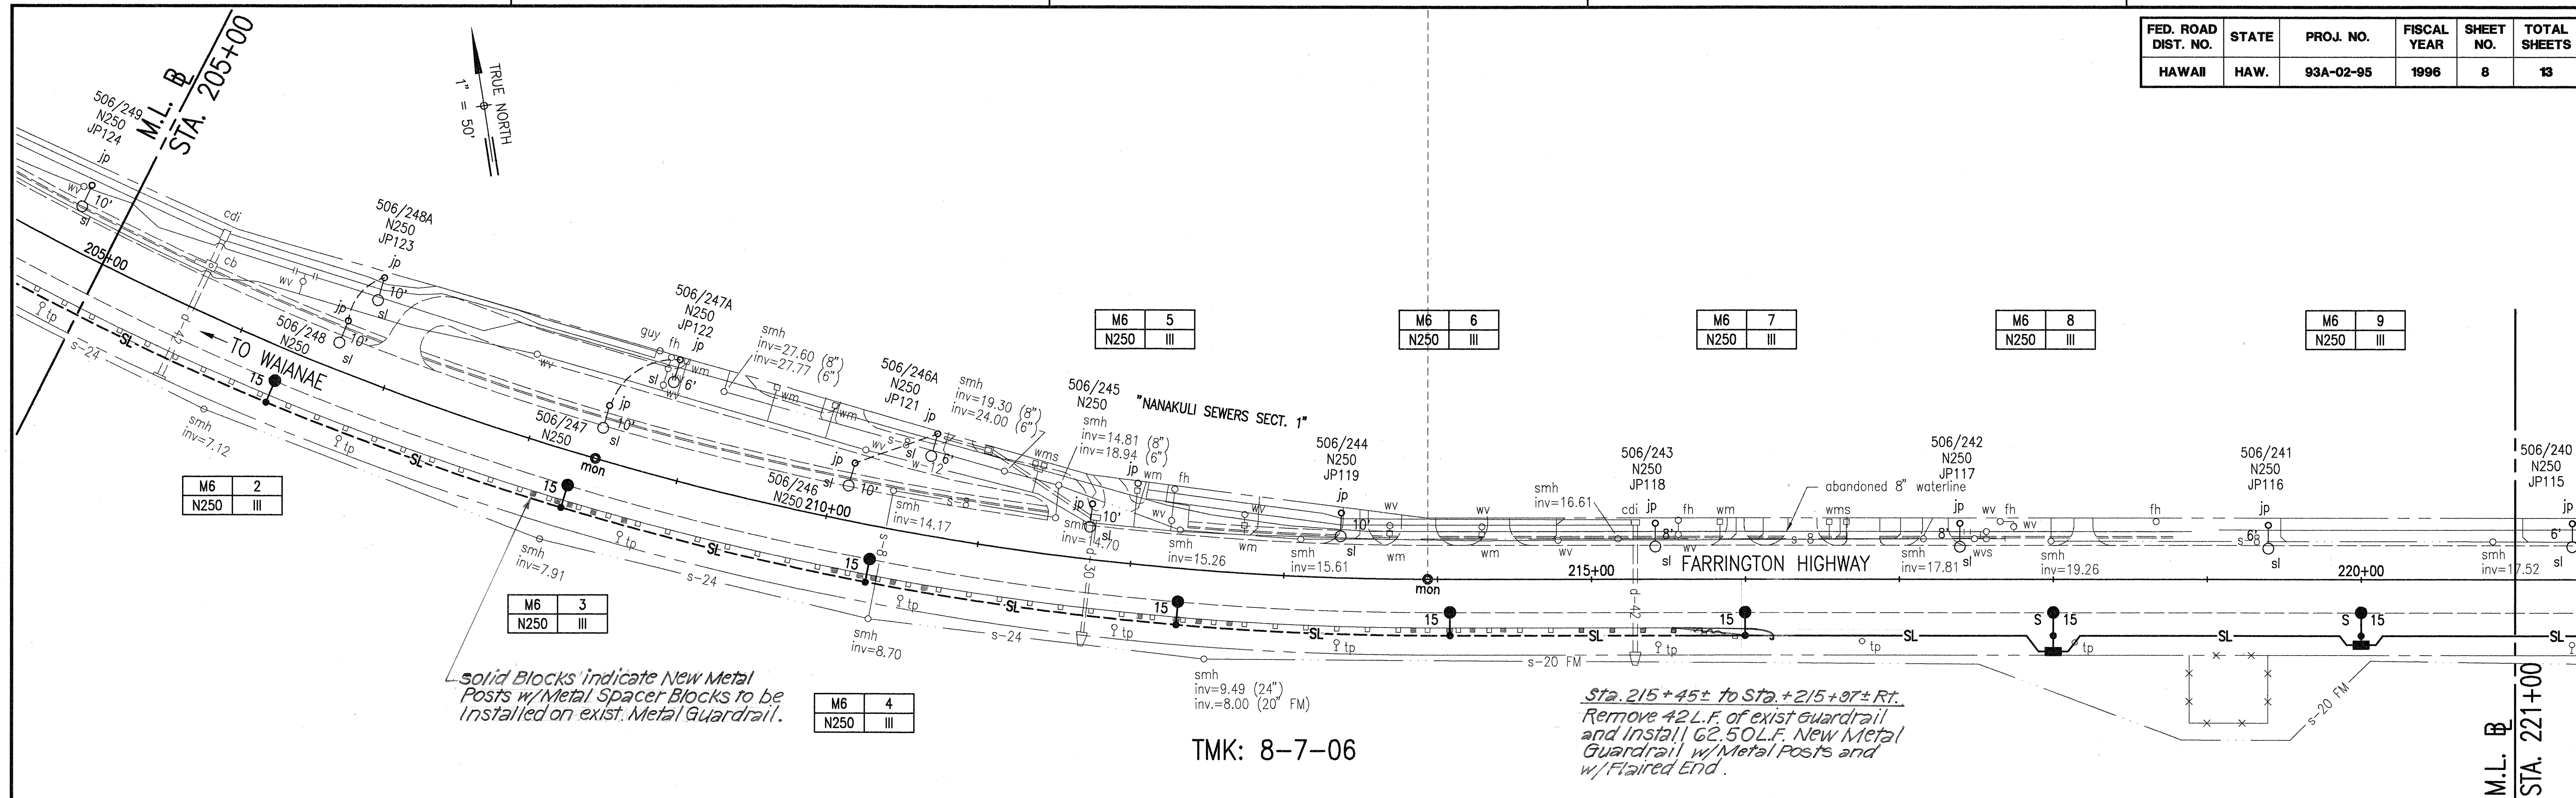

SURVEY PLOTTED BY	DATE
DRAWN BY	
CHECKED BY	
NOTE BOOK	
NO.	

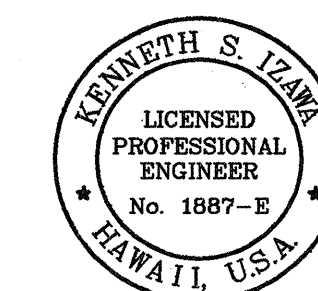

STATE OF HAWAII
DEPARTMENT OF TRANSPORTATION
HIGHWAYS DIVISION

HIGHWAY LIGHTING PLAN
STA. 205+00 TO STA. 236+00
FARRINGTON HIGHWAY LIGHTING IMPROVEMENTS
MAIPELA ST. TO LUAELI PLACE
PROJECT NO. 93A - 02 - 95
SCALE: 1" = 50'
May, 1996

SHEET No. 8 OF 13 SHEETS

APPROVED:

Frank Ching

5/15/96


CHIEF, DIV. OF PLANNING & SERVICE CONTROL, WWM
(FOR SEWER WORK WITHIN PUBLIC R/W & EASEMENT ONLY)

DATE

THIS WORK WAS PREPARED BY ME
OR UNDER MY SUPERVISION AND
CONSTRUCTION OF THIS PROJECT
WILL BE UNDER MY OBSERVATION

Ken S. Izumi

FED. ROAD DIST. NO.	STATE	PROJ. NO.	FISCAL YEAR	SHEET NO.	TOTAL SHEETS
HAWAII	HAW.	93A-02-95	1996	9	13

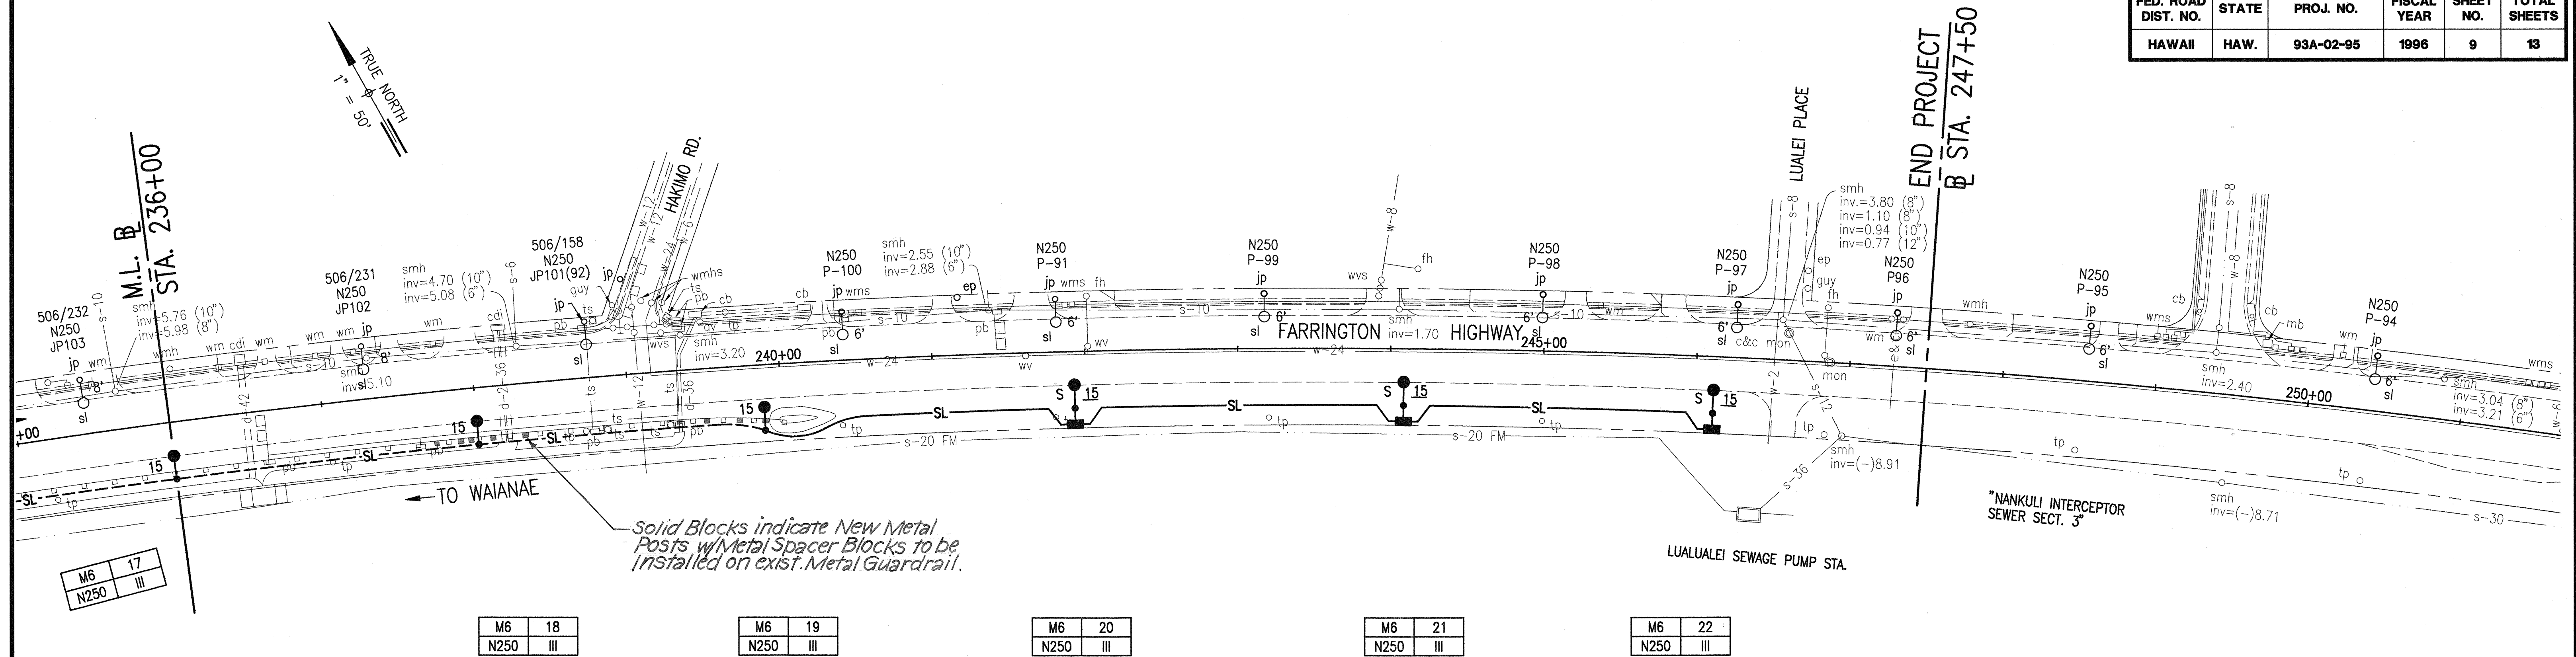


TMK: 8-7-07

ORIGINAL PLAN	SURVEY PLOTTED BY	DATE
DRAWN BY		
DESIGNED BY		
CHECKED BY		
NOTE BOOK		
No.		

APPROVED:

Steph P. ...
 CHIEF, DIV. OF PLANNING & SERVICE CONTROL, WWM
 (FOR SEWER WORK WITHIN PUBLIC R/W & EASEMENT ONLY)
 5/15/96
 DATE

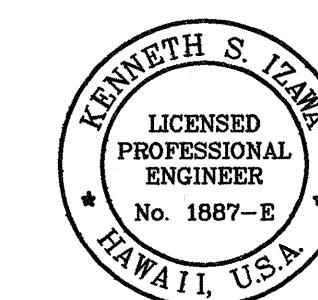

THIS WORK WAS PREPARED BY ME OR UNDER MY SUPERVISION AND CONSTRUCTION OF THIS PROJECT WILL BE UNDER MY OBSERVATION

Kenneth S. Izumi

STATE OF HAWAII
 DEPARTMENT OF TRANSPORTATION
 HIGHWAYS DIVISION

HIGHWAY LIGHTING PLAN
STA. 236+00 TO STA. 247+50
FARRINGTON HIGHWAY LIGHTING IMPROVEMENTS
MAIPELA ST. TO LUALEI PLACE
 PROJECT NO. 93A - 02 - 95
 SCALE: 1" = 50' May, 1996
SHEET No. 9 OF 13 SHEETS