



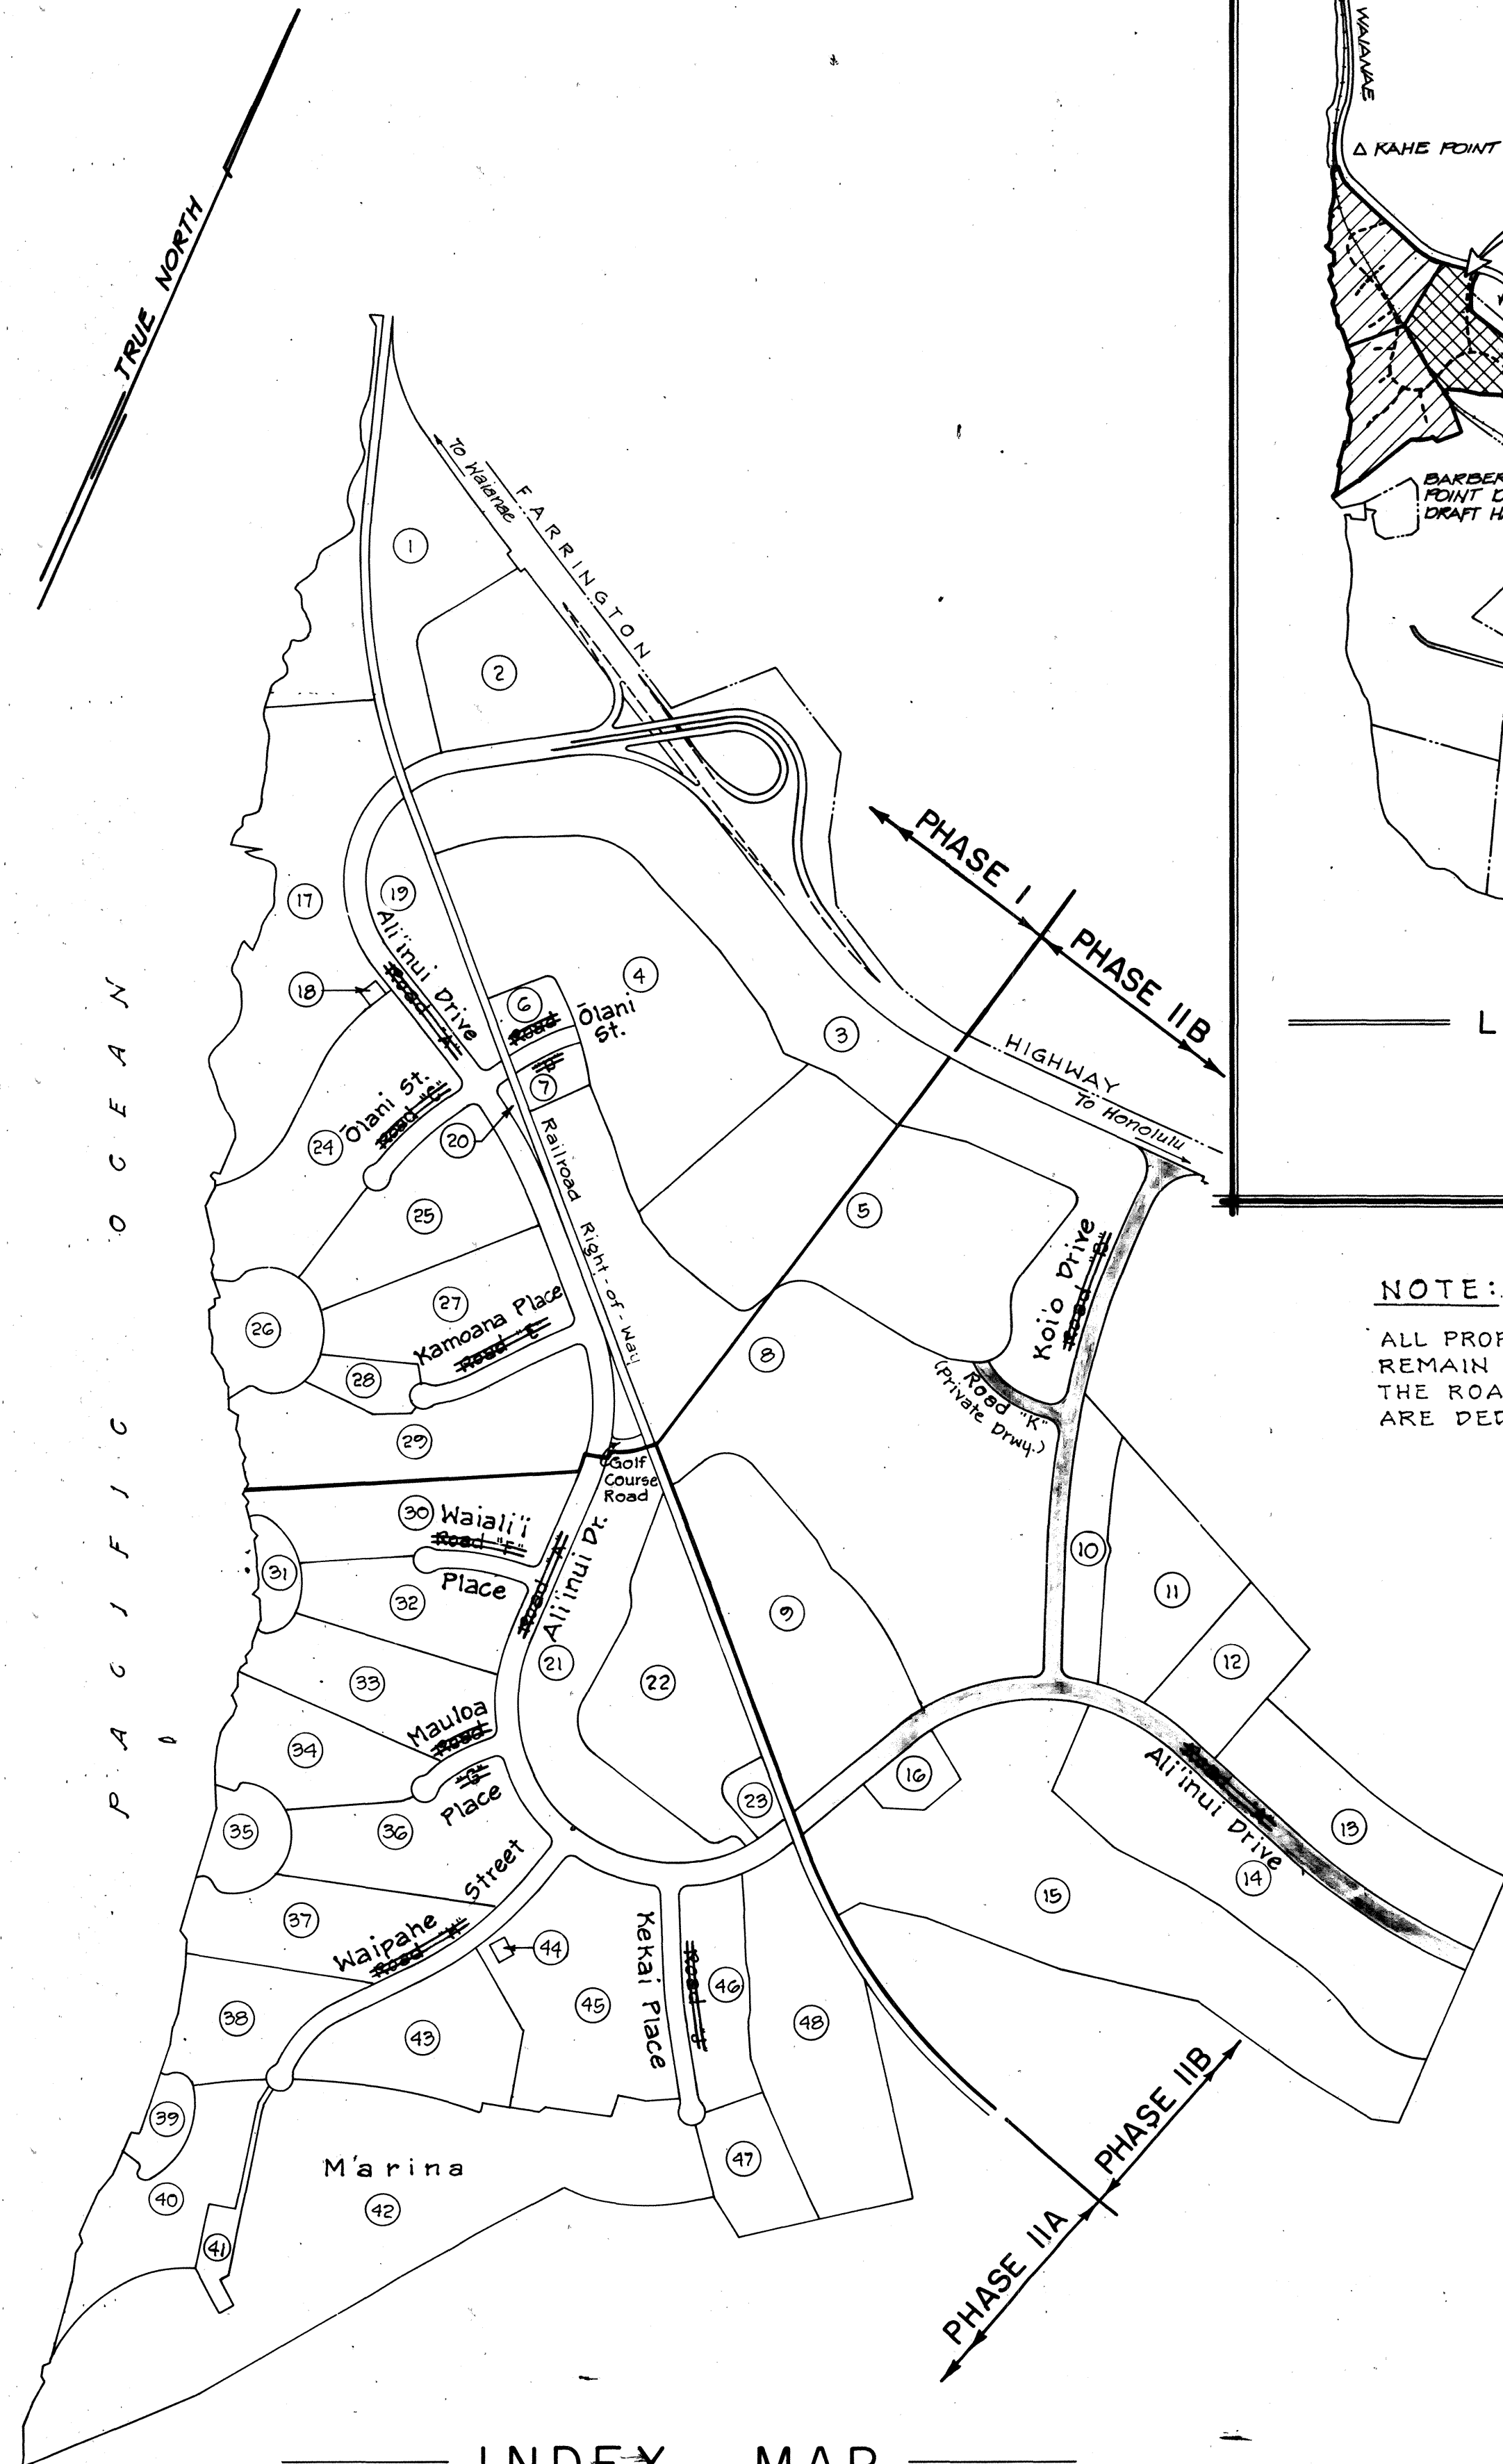

INDEX MAP
SCALE: 1" = 600'

TAX MAP KEY: 9-1-15: PORS. 3 & 4

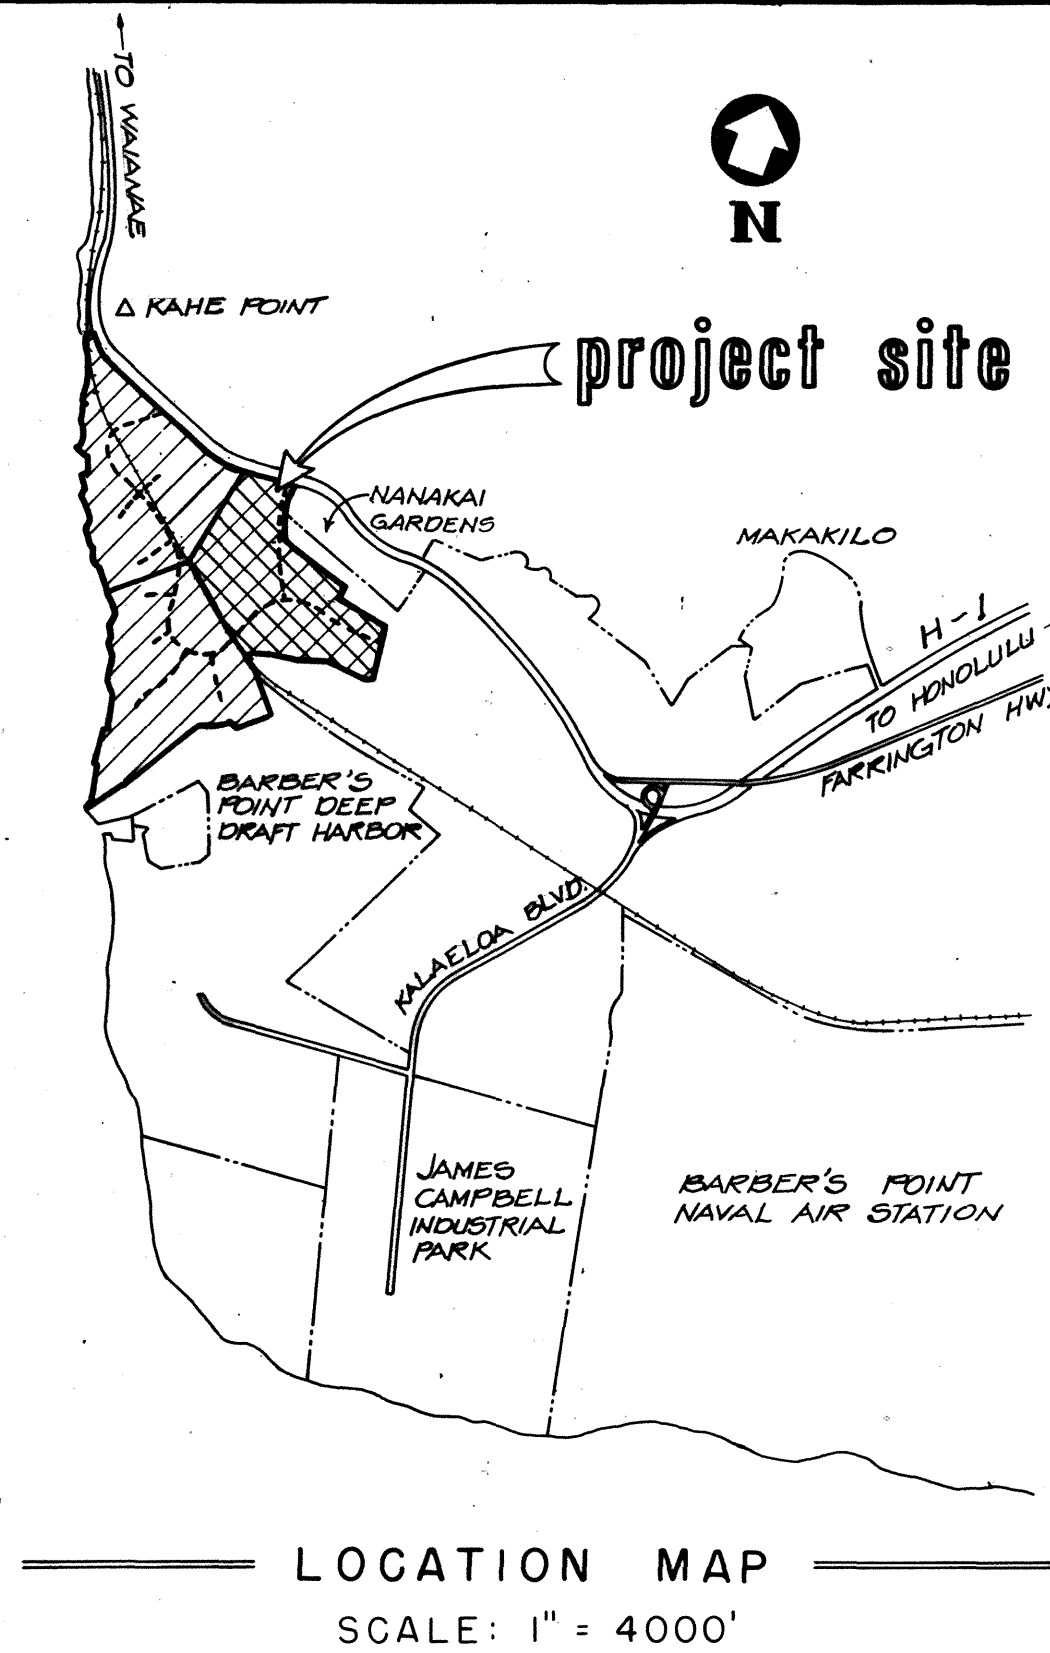

LOCATION MAP
SCALE: 1" = 4000'

NOTE:

ALL PROPOSED PUBLIC ROADS ARE TO REMAIN PRIVATE UNTIL SUCH TIME AS THE ROADWAYS AND IMPROVEMENTS ARE DEDICATED TO THE CITY.

CONSTRUCTION PLANS FOR WEST BEACH RESORT PHASE IIB


Honouliuli, Ewa, Oahu, Hawaii

Developer: WEST BEACH ESTATES

COMMUNITY PLANNING, INC.

CIVIL ENGINEERS - SURVEYORS - CONSULTANT PLANNERS

700 BISHOP ST., HONOLULU, HAWAII

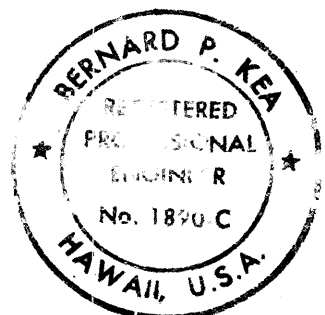

THIS WORK WAS PREPARED BY ME OR UNDER MY SUPERVISION
Bernard P. Kea

INDEX

DESCRIPTION	SHEET NO.
TITLE	1 ✓
GENERAL NOTES	2
TYPICAL ROAD SECTIONS	3
GENERAL PLANS	4 & 5
PLAN AND PROFILE	6 - 15
ROAD "A" ALI'INUI DRIVE	6 - 9
ROAD "B" KOLOA DRIVE	10 - 12
ROAD "K" (PRIVATE ROAD)	12
FARRINGTON HIGHWAY	13 & 13a ✓
SEWER LINE "L"	14
UTILITY CORRIDOR (PRIVATE DRIVEWAY)	15
DRAIN STRUCTURE NO. 1	16
DRAIN DETAILS	17
MISCELLANEOUS DETAILS AND WATER LATERAL PROFILES	18, 19 & 19a
STRUCTURAL PLANS (S-1 TO S-5)	20 - 24
GENERAL NOTES AND TYPICAL DETAILS (S-1)	20
UNDERPASS PLAN, SECTIONS AND DETAILS (S-2)	21
ELEVATIONS OF WINGWALL (S-3)	22
FARRINGTON HIGHWAY CHANNEL IMPROVEMENTS (S-4 TO S-6)	23, 24 & 24a ✓
ELECTRICAL PLANS (E-1 TO E-24)	25 - 48 ✓
TRAFFIC CONTROL, ST. TREE AND PLANTING PLAN (L-1 TO L-6)	49 - 54
LANDSCAPE PLANS (L-7 TO L-14)	55 - 62
FARRINGTON HIGHWAY	63 - 68
ACCESS ROAD PROFILE & SUPERELEVATION DIAGRAM	63 ✓
TRAFFIC CONTROL AND STRIPING PLAN	64 ✓
CROSS SECTIONS	65 - 68 ✓

APPROVED

Bernard P. Kea
DIRECTOR, DEPT. OF LAND UTILIZATION

21 MAR 88
DATE

Samuel A. Kelly
DIRECTOR & CHIEF ENGINEER, DEPT. OF PUBLIC WORKS

10-2-87
DATE

John D. 2
CHIEF, ENVIRONMENTAL PROTECTION & HEALTH SERVICE DIV.
DEPT. OF HEALTH, STATE OF HAWAII

6/24/86
DATE

Forrest Hayes
MGR. & CHIEF ENGINEER, BOARD OF WATER SUPPLY

8/10/87
DATE

John D. 2
CHIEF, HIGHWAYS DIVISION
STATE DEPARTMENT OF TRANSPORTATION
(APPROVAL GRANTED FOR WORK WITHIN STATE RIGHT-OF-WAY ONLY.
I.D. NO. 0-86-2 (RD. "B") LETTER OF APPROVAL NO. HWY-CM 2.1177,
DATED JUNE 6, 1988.)

DATE

John D. 2
DIRECTOR, DEPT. OF TRANSPORTATION SERVICES

DATE

John D. 2
DIRECTOR, DEPT. OF PARKS AND RECREATION

7/12/87
DATE