

INDEX TO DRAWINGS	
SHEET NO.	DESCRIPTION
1	TITLE SHEET
1A	TITLE SHEET
2	STANDARD PLANS SUMMARY
3	GENERAL PLAN
4-5	TYPICAL SECTIONS
6-9	ALIGNMENT PLANS
10-13	GRADING PLANS
14	ROAD "A" C PROFILE
15-18	RAMP PROFILES & SUPERELEVATION DIAGRAMS
19-22	RAMP TERMINAL DETAILS
23-25	DRAINAGE & CONSTRUCTION PLANS
26	DRAINAGE PROFILES
27-32	DRAINAGE DETAILS
33-38	TRAFFIC CONTROL PLANS
39-41	SIGNING & STRIPING PLANS
42	CROSS SECTION KEY MAP
43-69	CROSS SECTIONS
70-80	STRUCTURAL PLANS & DETAILS (S-1 TO S-11)
81-90	ELECTRICAL PLANS & DETAILS (E-1 TO E-10)
KO'O DRIVE PLANS	
91	TITLE SHEET
92-93	PLAN AND PROFILE
94-96	CHANNEL IMPROVEMENTS
97-103	ELECTRICAL PLANS
104	ACCESS ROAD PROFILE & SUPERELEVATION DIAGRAM
105	TRAFFIC CONTROL & STRIPING PLAN
106-109	CROSS SECTIONS


STATE OF HAWAII
DEPARTMENT OF TRANSPORTATION
HIGHWAYS DIVISION
HONOLULU, HAWAII

PLANS FOR
FARRINGTON HIGHWAY
KO'OLINA INTERCHANGE


PROJECT NO. 93A-02-91

DISTRICT OF EWA
ISLAND OF OAHU



PROPOSED
FARRINGTON HIGHWAY
KO'OLINA INTERCHANGE
PROJECT NO. 93A-02-91

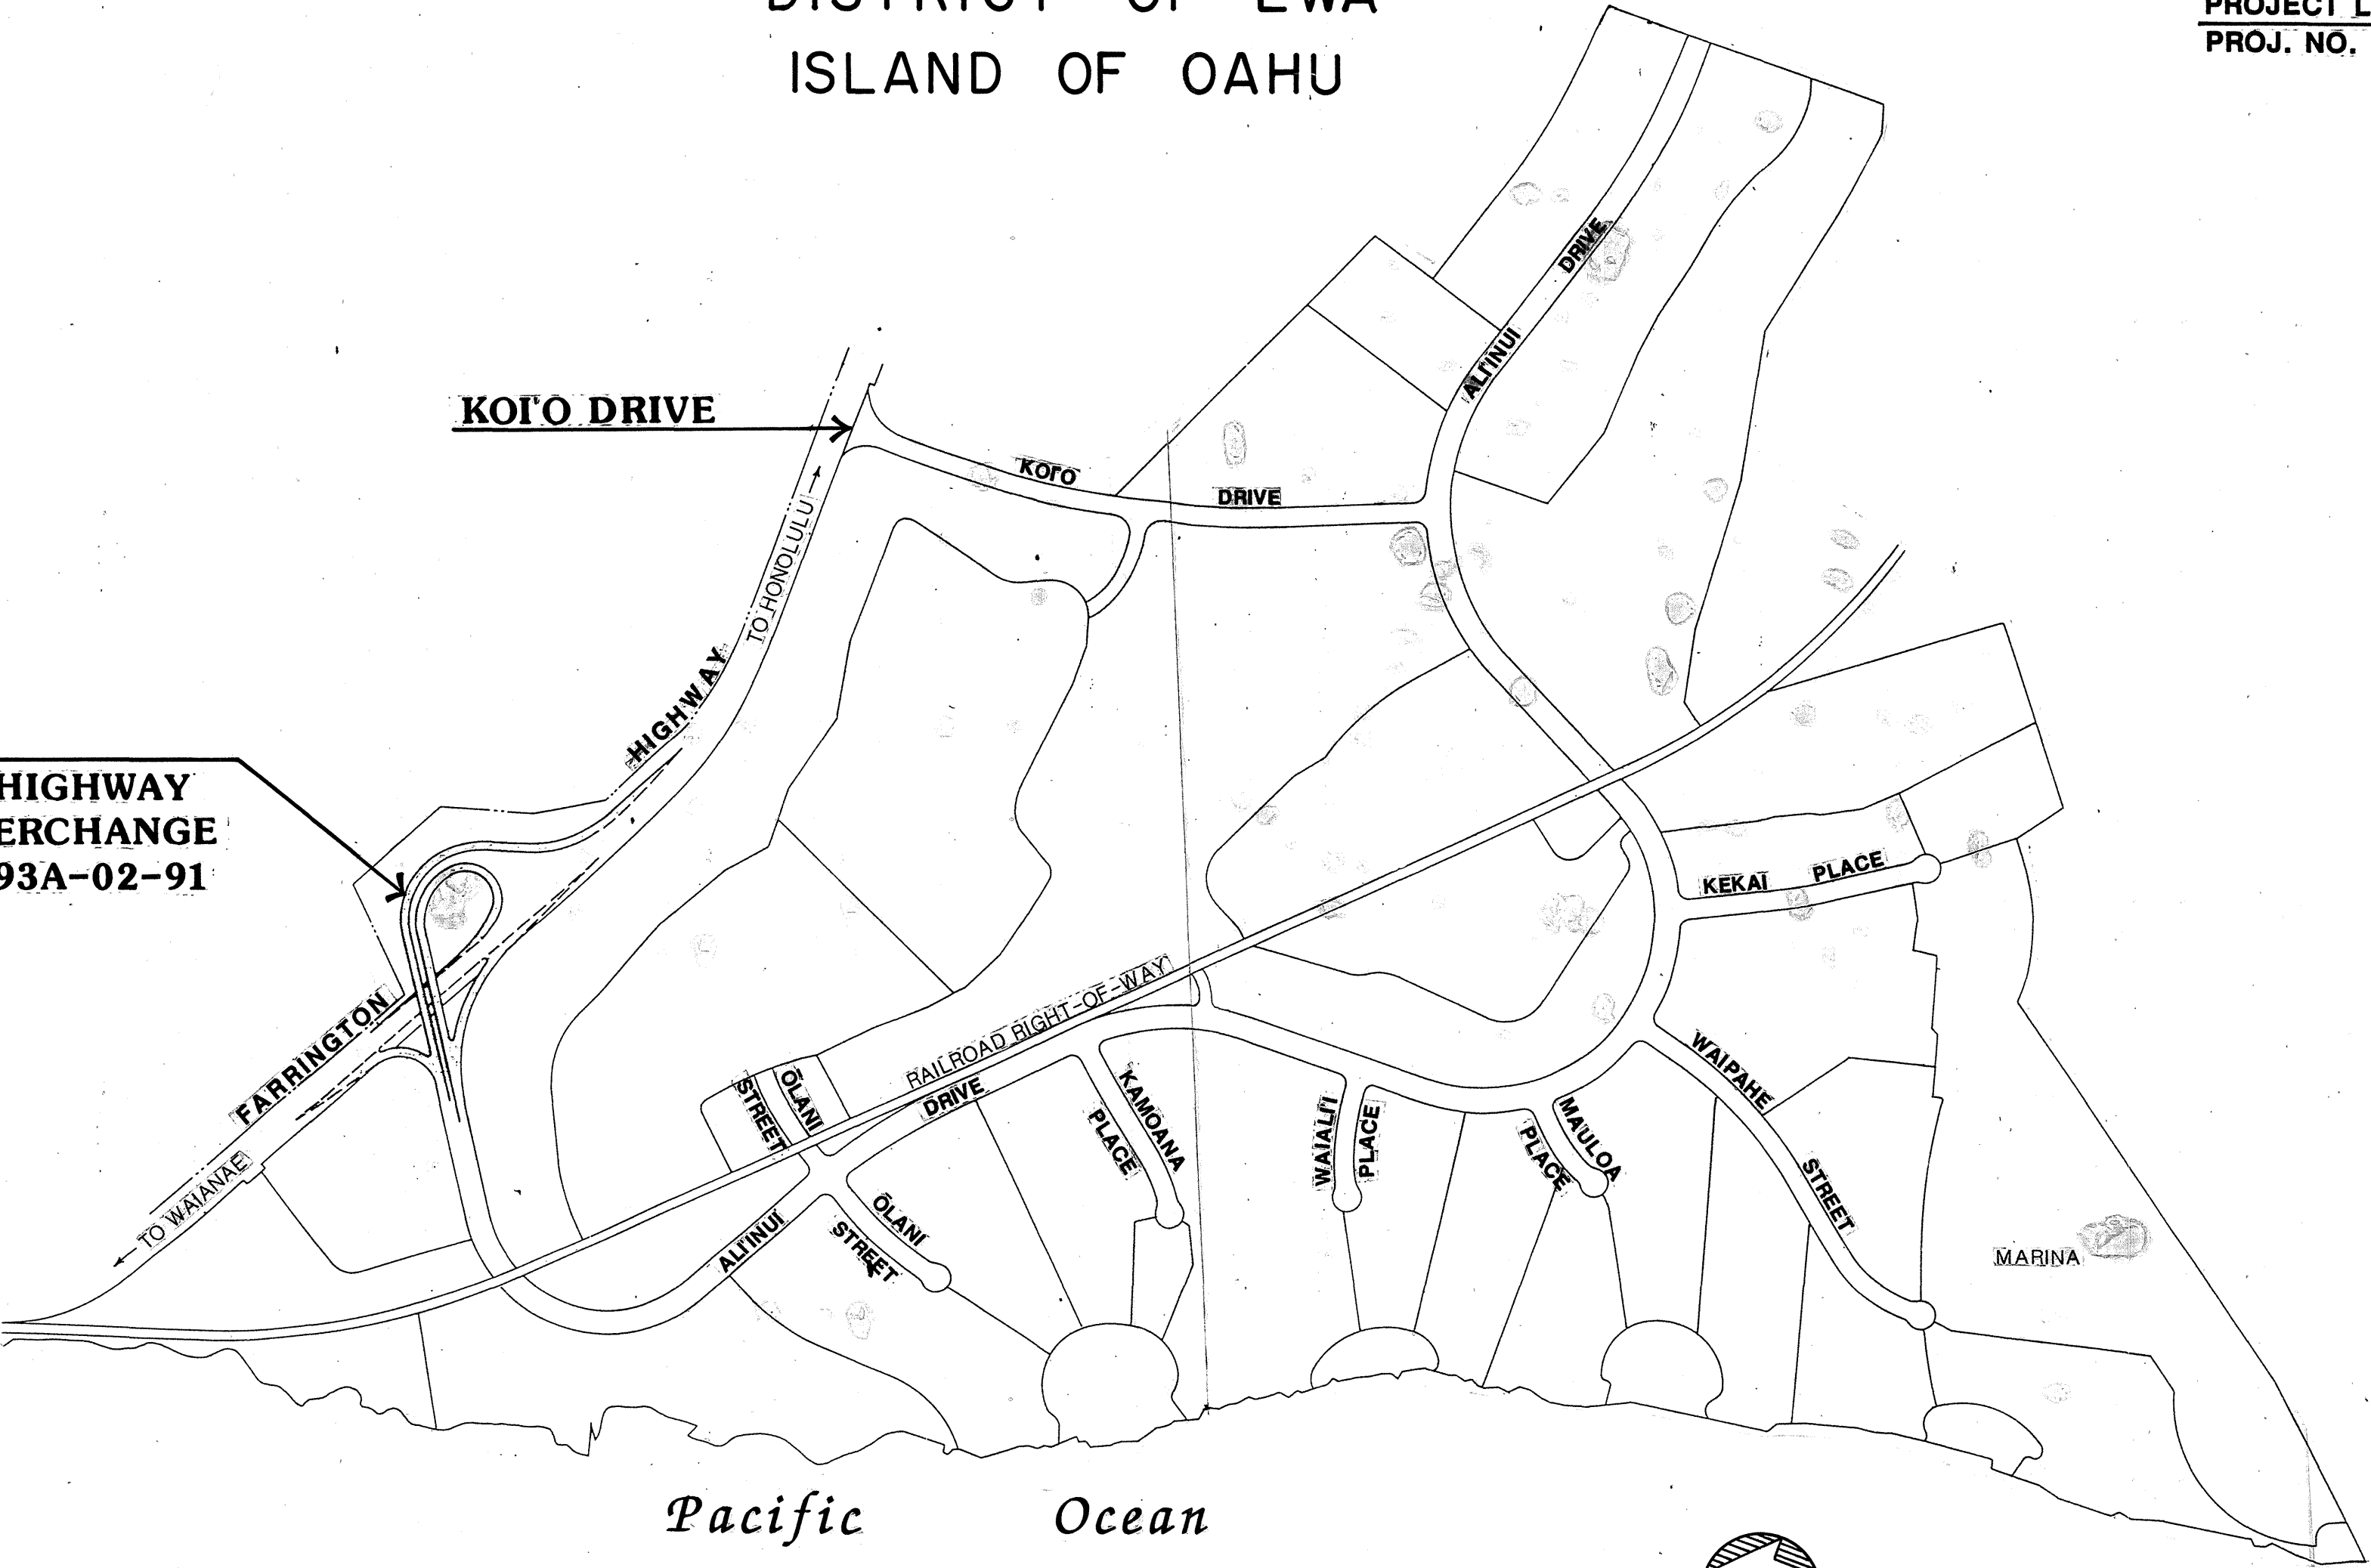


LOCATION PLAN

 

FED. ROAD DIST. NO.	STATE	PROJ. NO.	FISCAL YEAR	SHEET NO.	TOTAL SHEETS
HAWAII	HAW.	93A-02-91	1992	1	110

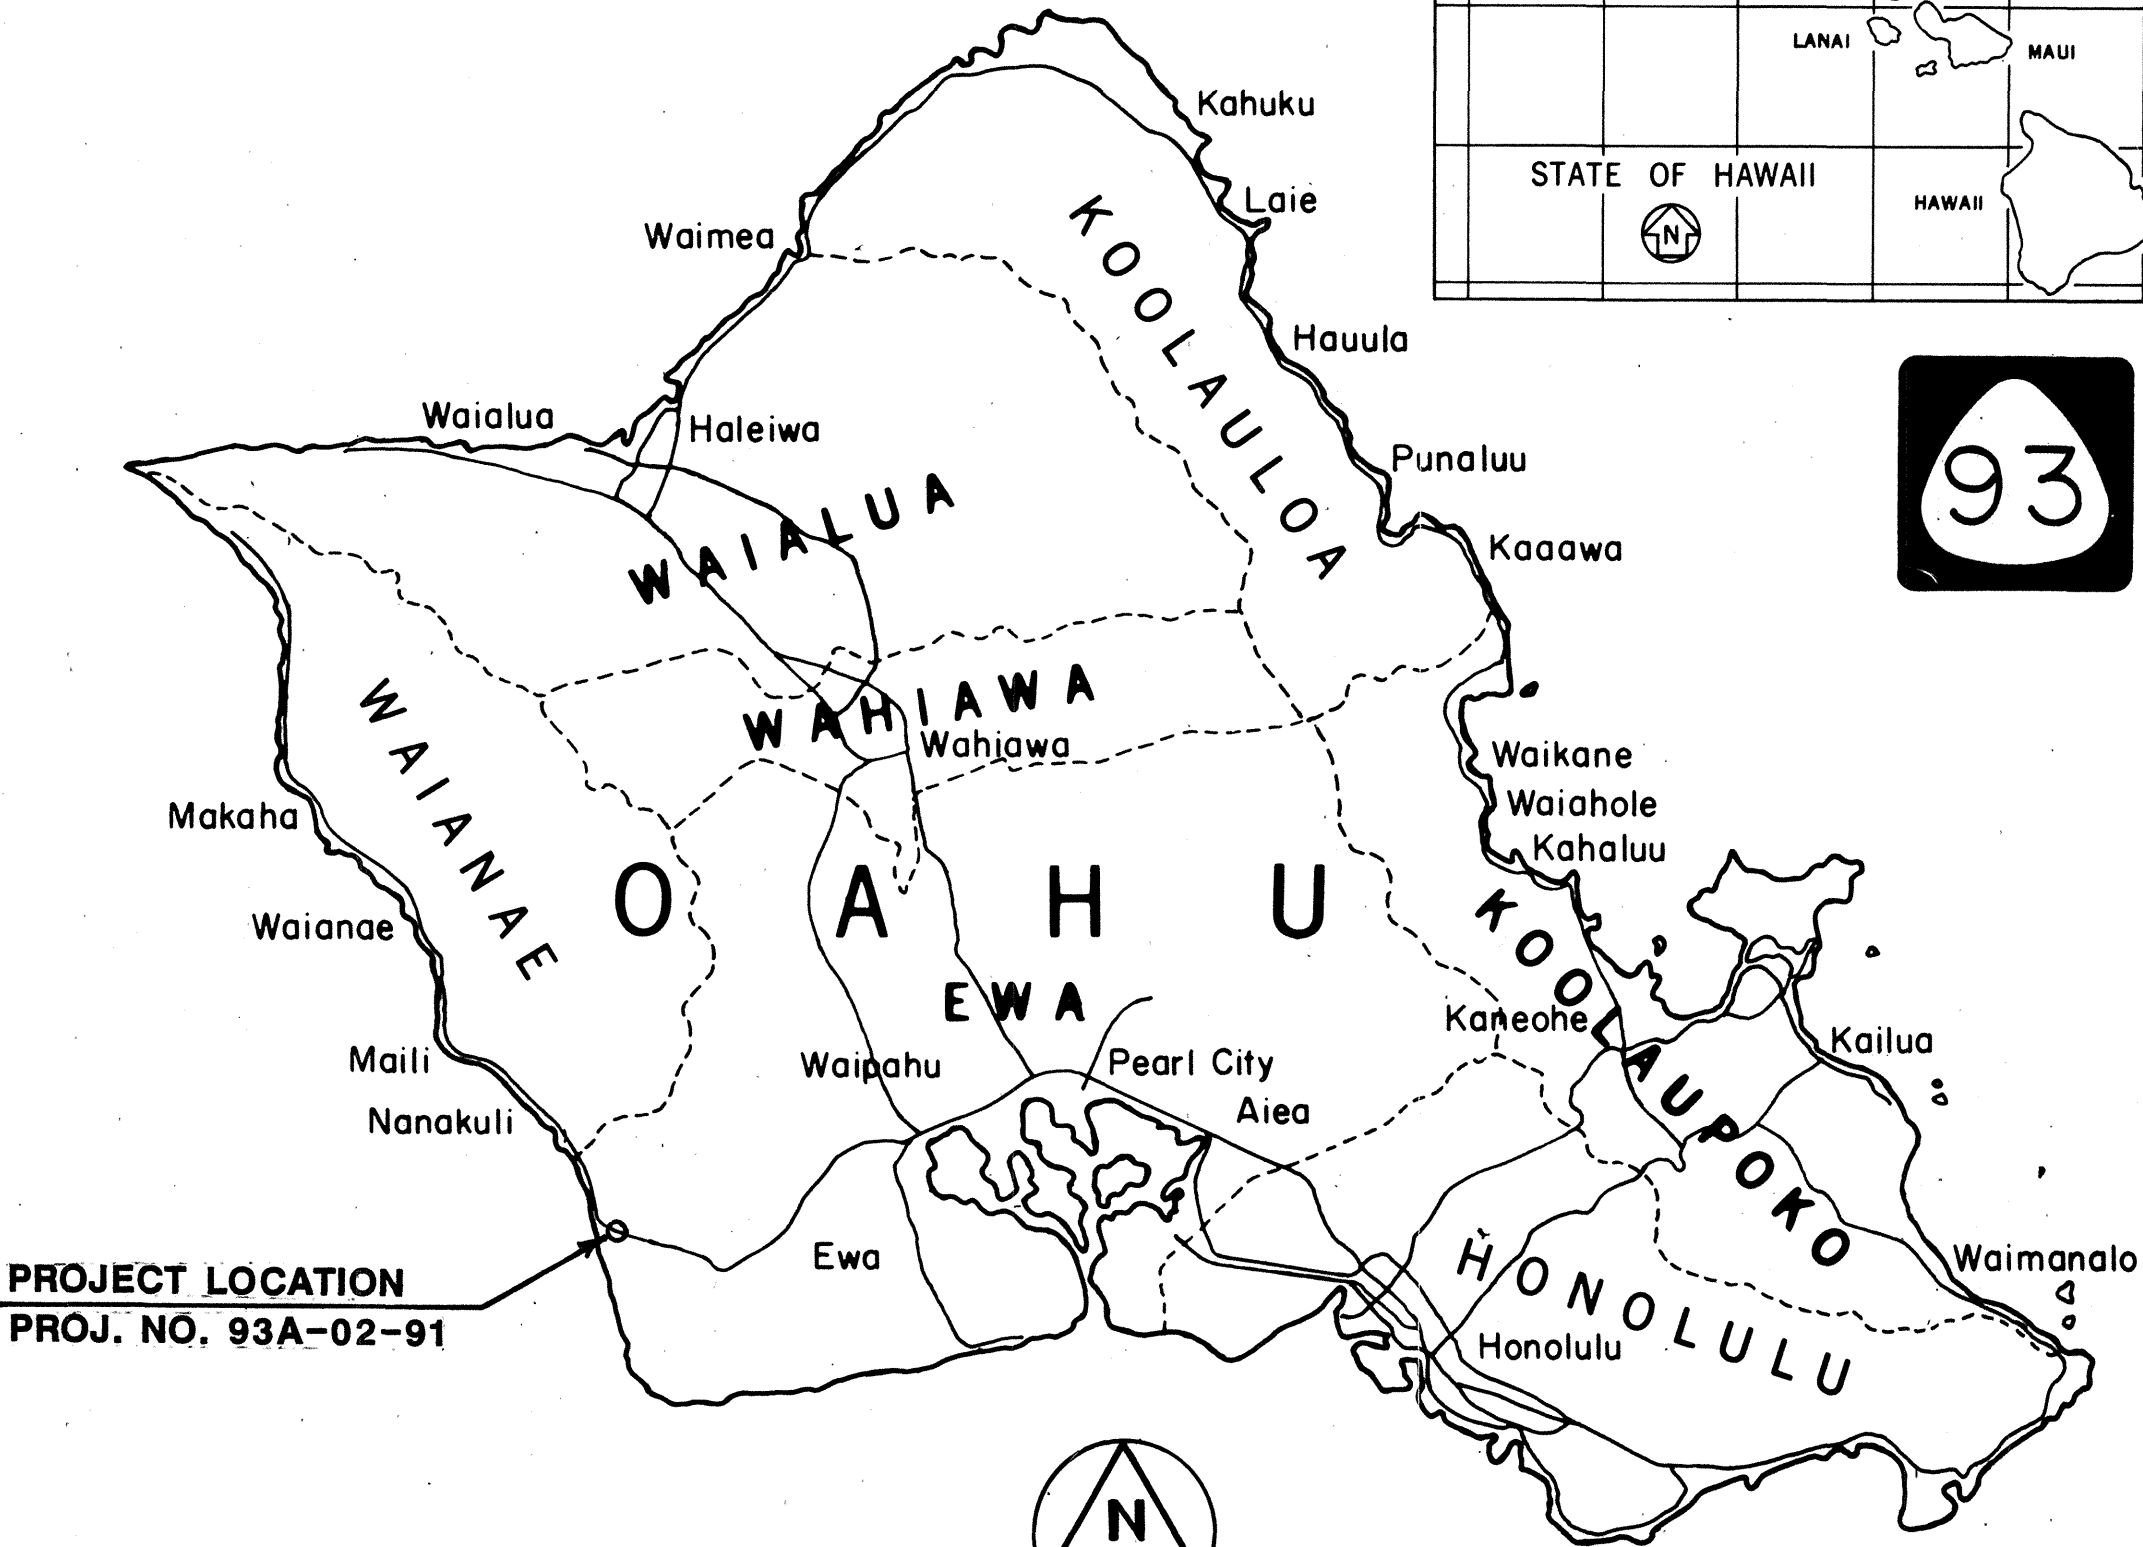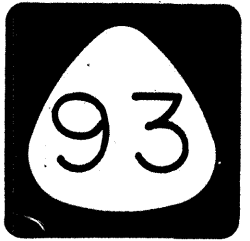


PROJECT LOCATION
PROJ. NO. 93A-02-91

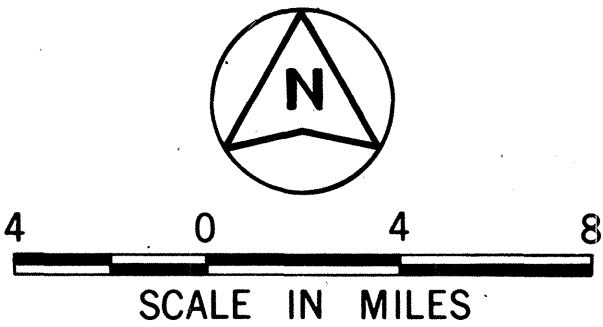

MILE POST ——— TO MILE POST ———


DEPARTMENT OF TRANSPORTATION STATE OF HAWAII	
APPROVED:	
DIR. OF TRANSPORTATION	DATE

COMMUNITY PLANNING, INC. A. YAMAGUCHI
DESIGNED BY P. S. & E. BY
548-7468
AUG., 1991
DATE

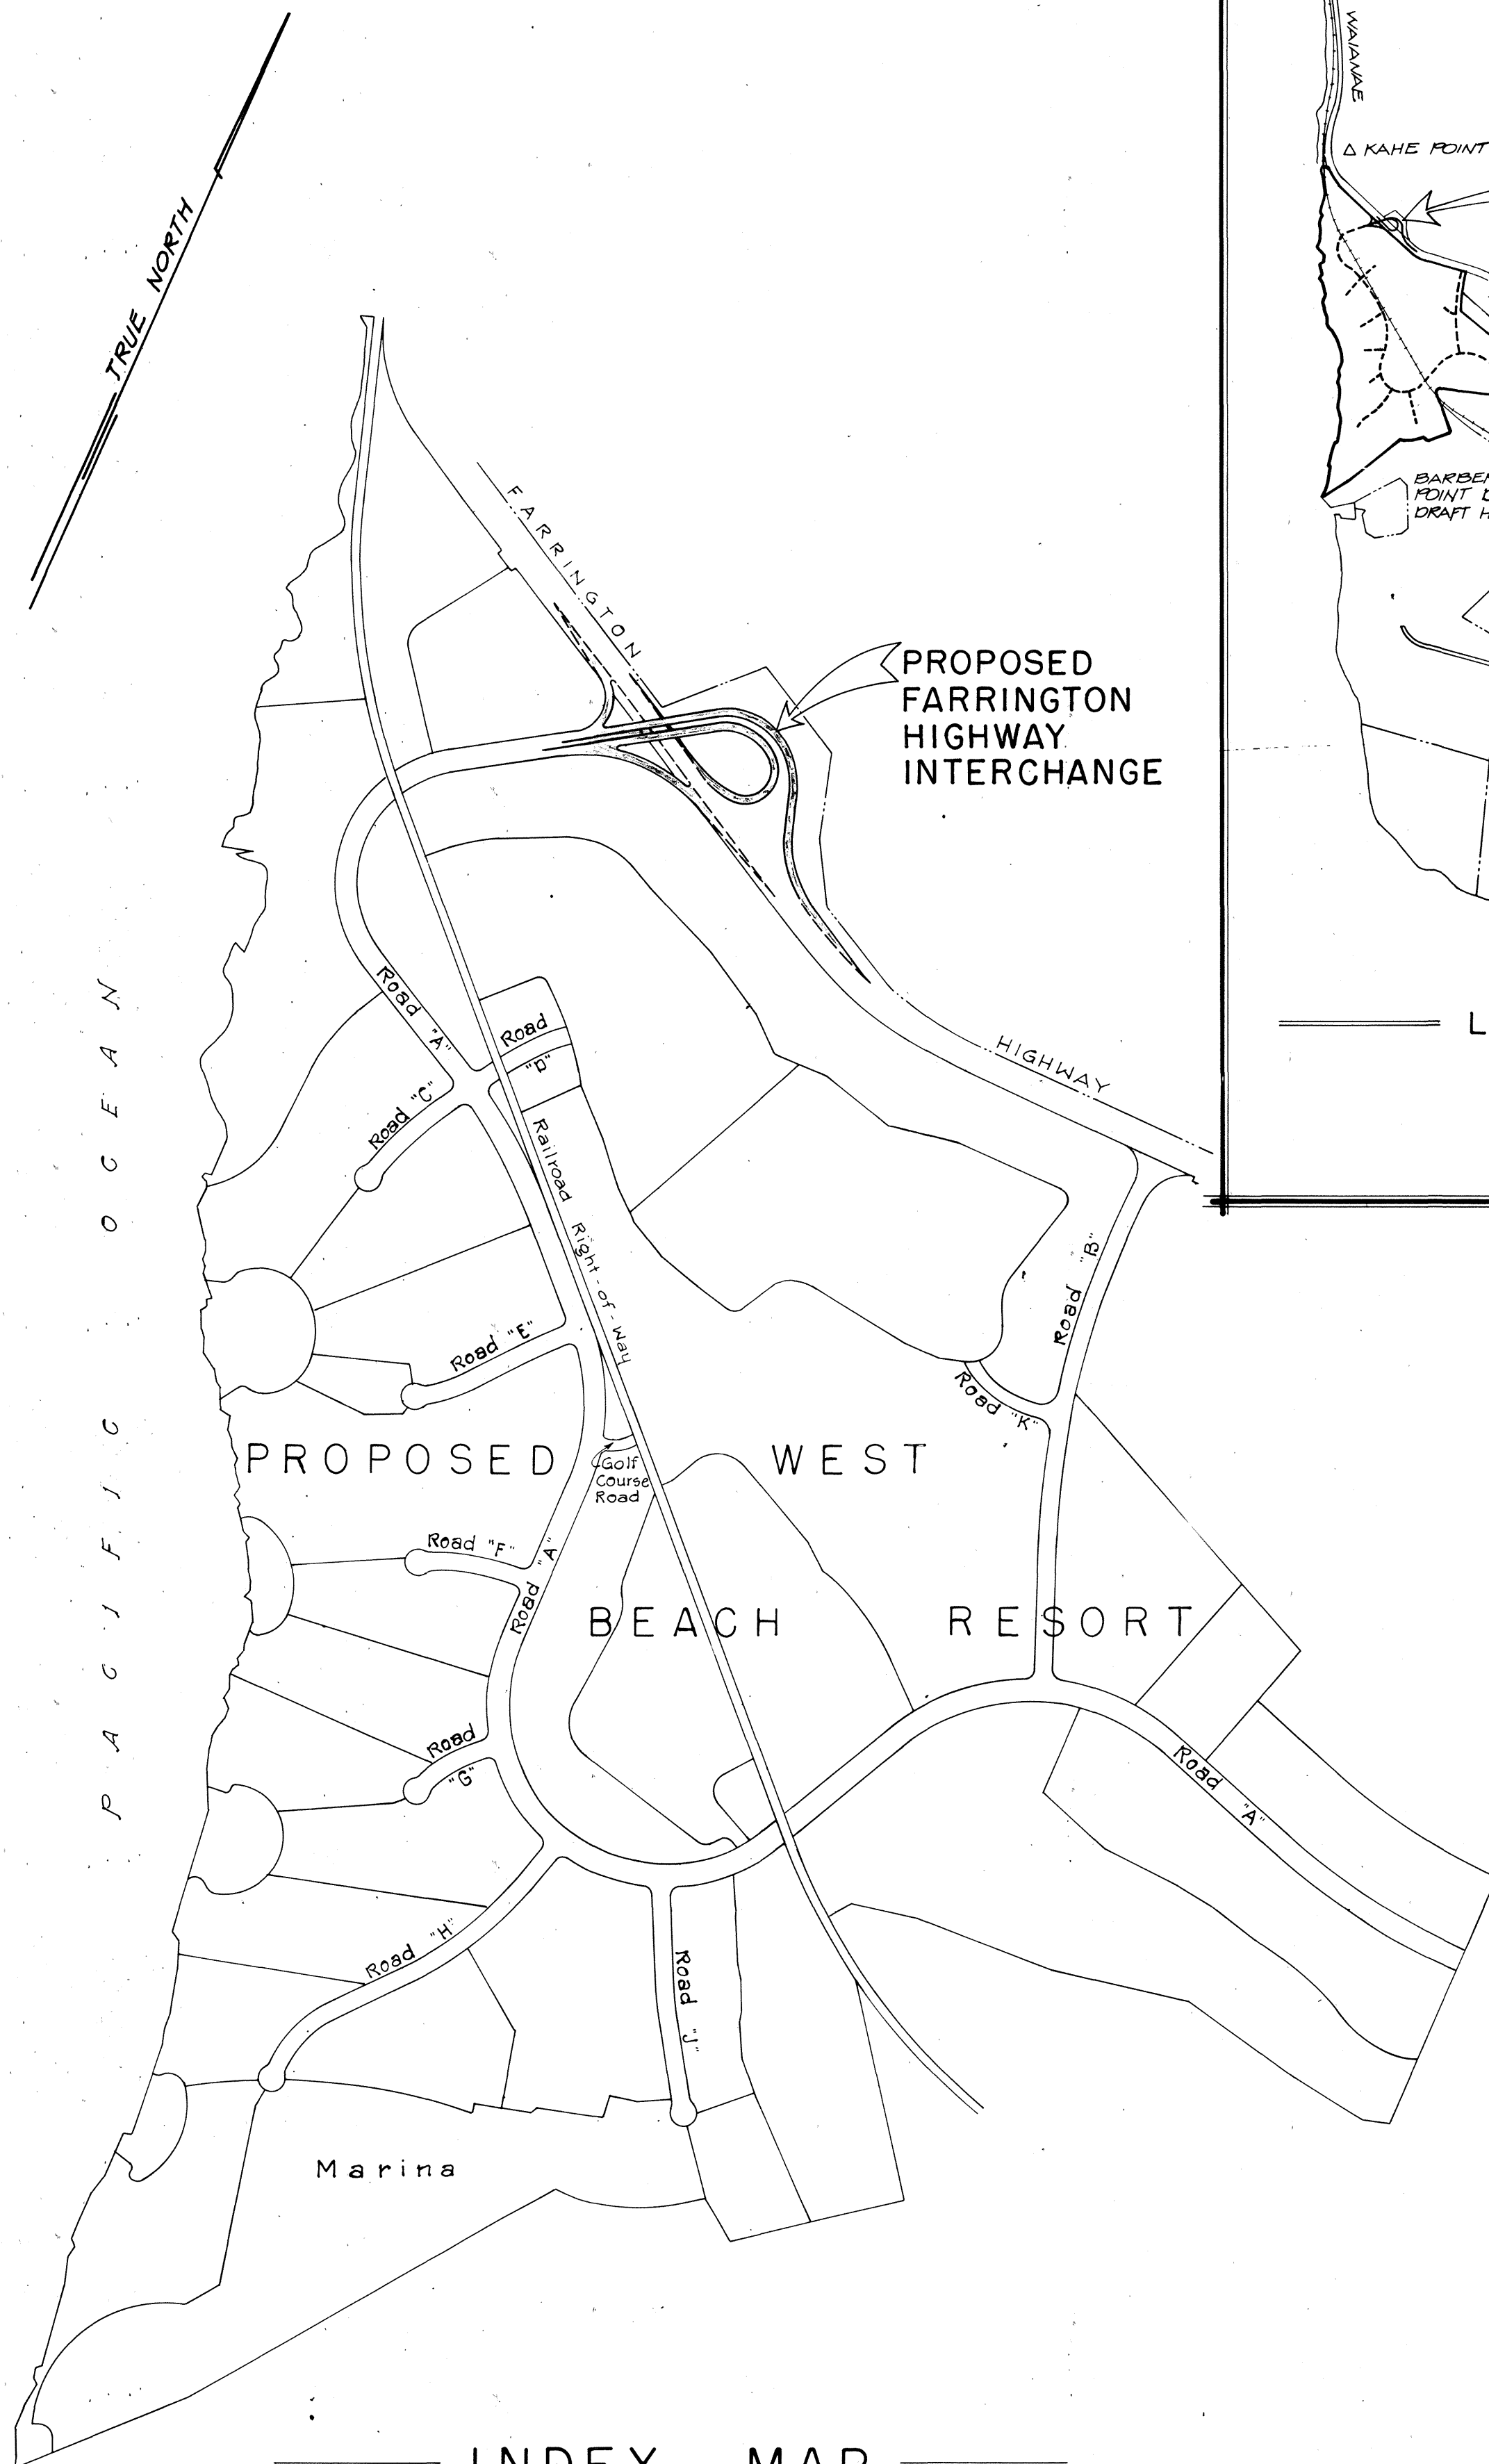

INDEX MAP
SCALE: 1" = 600'

TAX MAP KEY: 9-1-15: POR. 3
9-2-03: POR. 2 & 69

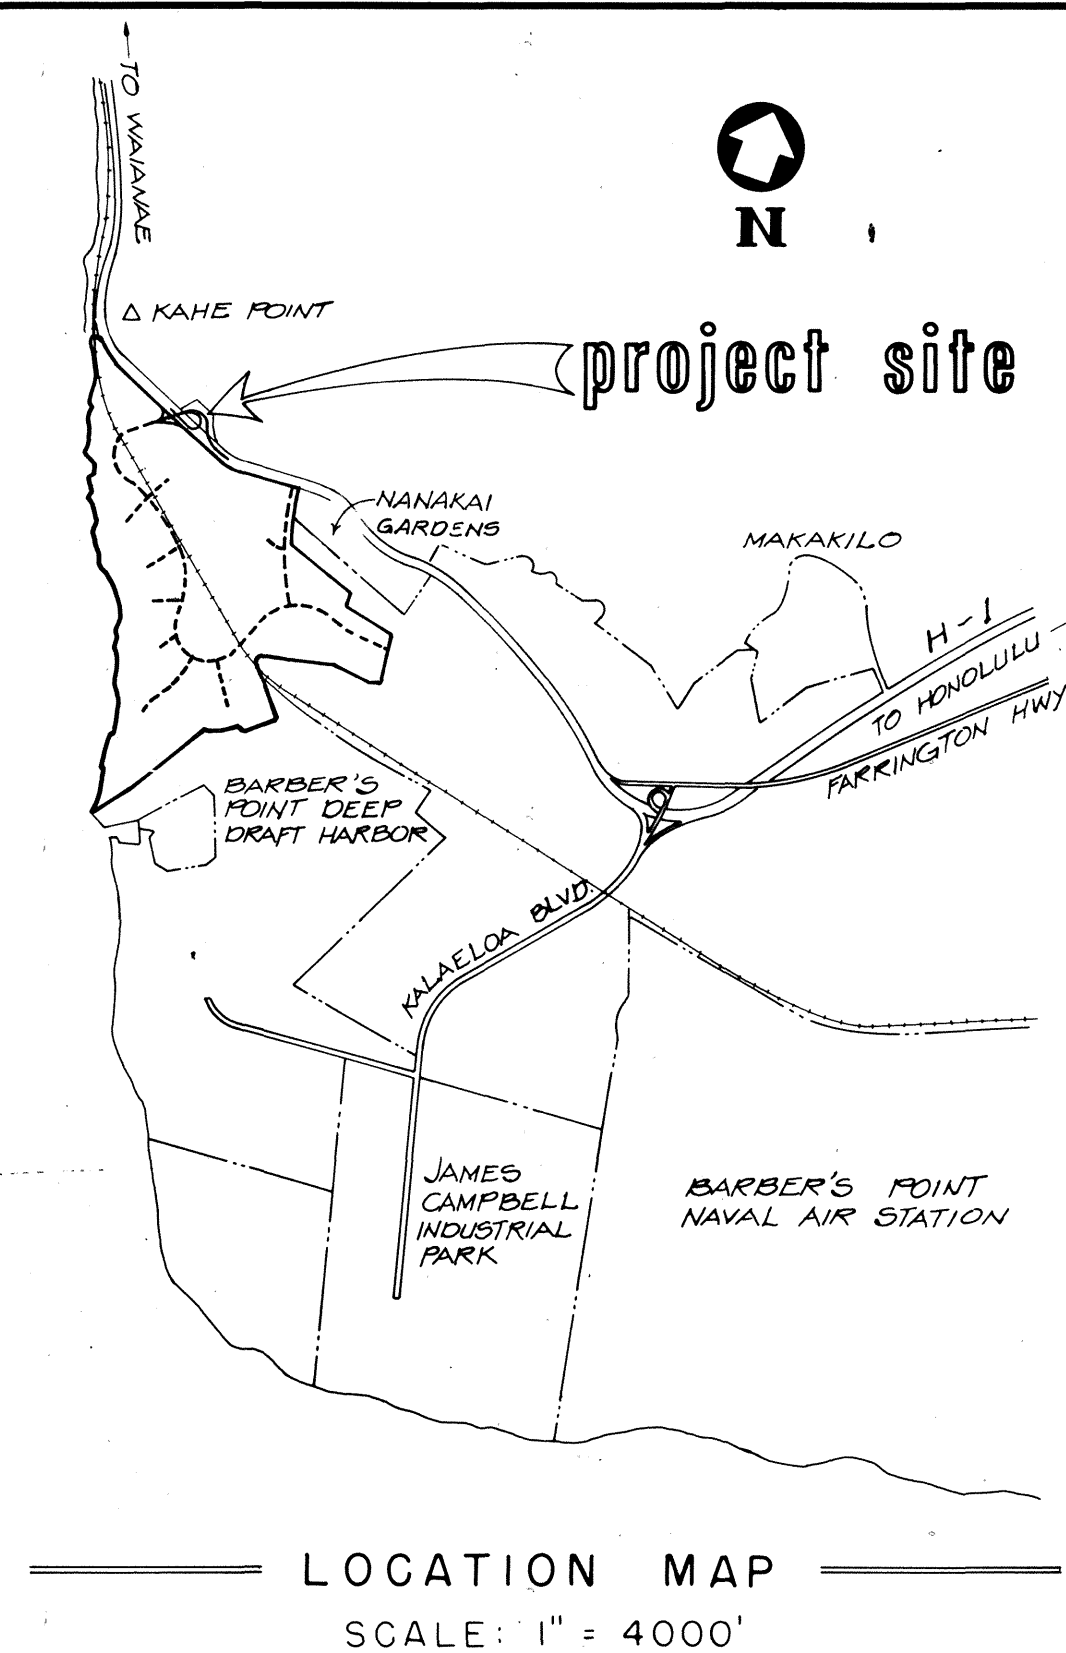

LOCATION MAP
SCALE: 1" = 4000'

CONSTRUCTION PLANS FOR WEST BEACH RESORT FARRINGTON HIGHWAY INTERCHANGE

Honouliuli, Ewa, Oahu, Hawaii

Developer: WEST BEACH ESTATES

COMMUNITY PLANNING, INC.

CIVIL ENGINEERS - SURVEYORS - CONSULTANT PLANNERS

700 BISHOP ST., HONOLULU, HAWAII



THIS WORK WAS PREPARED BY
ME OR UNDER MY SUPERVISION
Bernard P. Lee

INDEX

DESCRIPTION	SHEET NO.
TITLE	1
GENERAL PLAN	2
TYPICAL SECTIONS	3 & 4
ALIGNMENT PLANS	5 - 8
GRADING PLANS	9 - 12
ROAD "A" & PROFILE	13
RAMP PROFILES & SUPERELEVATION DIAGRAMS	14 - 17
RAMP TERMINAL DETAILS	18 - 21
DRAINAGE & CONSTRUCTION PLANS	22 - 24
DRAINAGE PROFILES	25
DRAINAGE DETAILS	26 - 31
TRAFFIC CONTROL PLAN	32 - 37
SIGNING AND STRIPING PLANS	38 - 40
CROSS SECTION KEY MAP	41
CROSS SECTIONS	42 - 68
STRUCTURAL PLANS AND DETAILS (S-I TO S-II)	69 - 79
ELECTRICAL PLANS AND DETAILS (E-I TO E-10)	80 - 89

APPROVED

Bernard P. Lee
DIRECTOR, DEPT. OF LAND UTILIZATION

19 Feb 88
DATE

CHIEF, HIGHWAYS DIVISION
STATE DEPARTMENT OF TRANSPORTATION
(APPROVAL GRANTED FOR WORK WITHIN STATE RIGHT-OF-WAY
ONLY, I.D. NO. 0-86-2 (1) LETTER OF APPROVAL NO.
HWY-CM 2.99165 DATED JANUARY 28, 1988)

2/11/88
DATE

APPROVED FOR GRADING ONLY:

DIRECTOR & CHIEF ENGINEER, DEPT. OF PUBLIC WORKS

5/1/87
DATE

APPROVED FOR GRADING ONLY:

CHIEF, HIGHWAYS DIVISION
STATE DEPARTMENT OF TRANSPORTATION
(APPROVAL GRANTED FOR WORK WITHIN STATE RIGHT-OF-WAY
ONLY, I.D. NO. 0-86-2 (1) ADVANCE GRADING LETTER OF
APPROVAL NO. HWY-CM 2.96953 DATED AUGUST 24, 1987)

7/1/87
DATE

