

FED. ROAD DIST. NO.	STATE	PROJ. NO.	FISCAL YEAR	SHEET NO.	TOTAL SHEETS
HAWAII	HAW.	93A-03-97	1998	7	18


STA. 119+30 TO STA. 120+98, RT., WIDEN EXIST. SHOULDER AREA PAVEMENT. WIDTH=2' FOR NEW A.C. PAVEMENT SECTION.

STA. 118+93 TO STA. 121+00, LT., WIDEN EXIST. BUS TURNOUT AREA. RECONSTRUCT EXIST. SHOULDER AREA PAVEMENT, WIDTH=2', AND CONSTRUCT NEW A.C. PAVEMENT, WIDTH VARIES. CONSTRUCT NEW A.C. SIDEWALK AND A.C. DRIVEWAY. CONSTRUCT NEW ACCESSIBLE LOADING PAD. SEE DETAIL PLAN, SHT. 5.

STA. 121+57 TO STA. 122+58 AND STA. 122+80 TO STA. 123+57, RT., RECONSTRUCT EXIST. BUS TURNOUT TAPER AREAS. WIDTH VARIES. WIDEN EXIST. BUS TURNOUT TAPER AREAS. CONSTRUCT NEW A.C. PAVT. WITH EDGE TAPERS. WIDTH VARIES. RECONSTRUCT EXIST. TURNOUT TO SATISFY THE AMERICANS WITH DISABILITY ACT ACCESSIBILITY GUIDELINES (ADAAG). SEE DETAIL PLAN, SHT. 6.

STA. 123+57 TO 125+60, RT. WIDEN EXIST. SHOULDER AREA PAVT., WIDTH=2' FOR NEW A.C. PAVEMENT SECTION.


TRUE NORTH
SCALE: 1"=40'

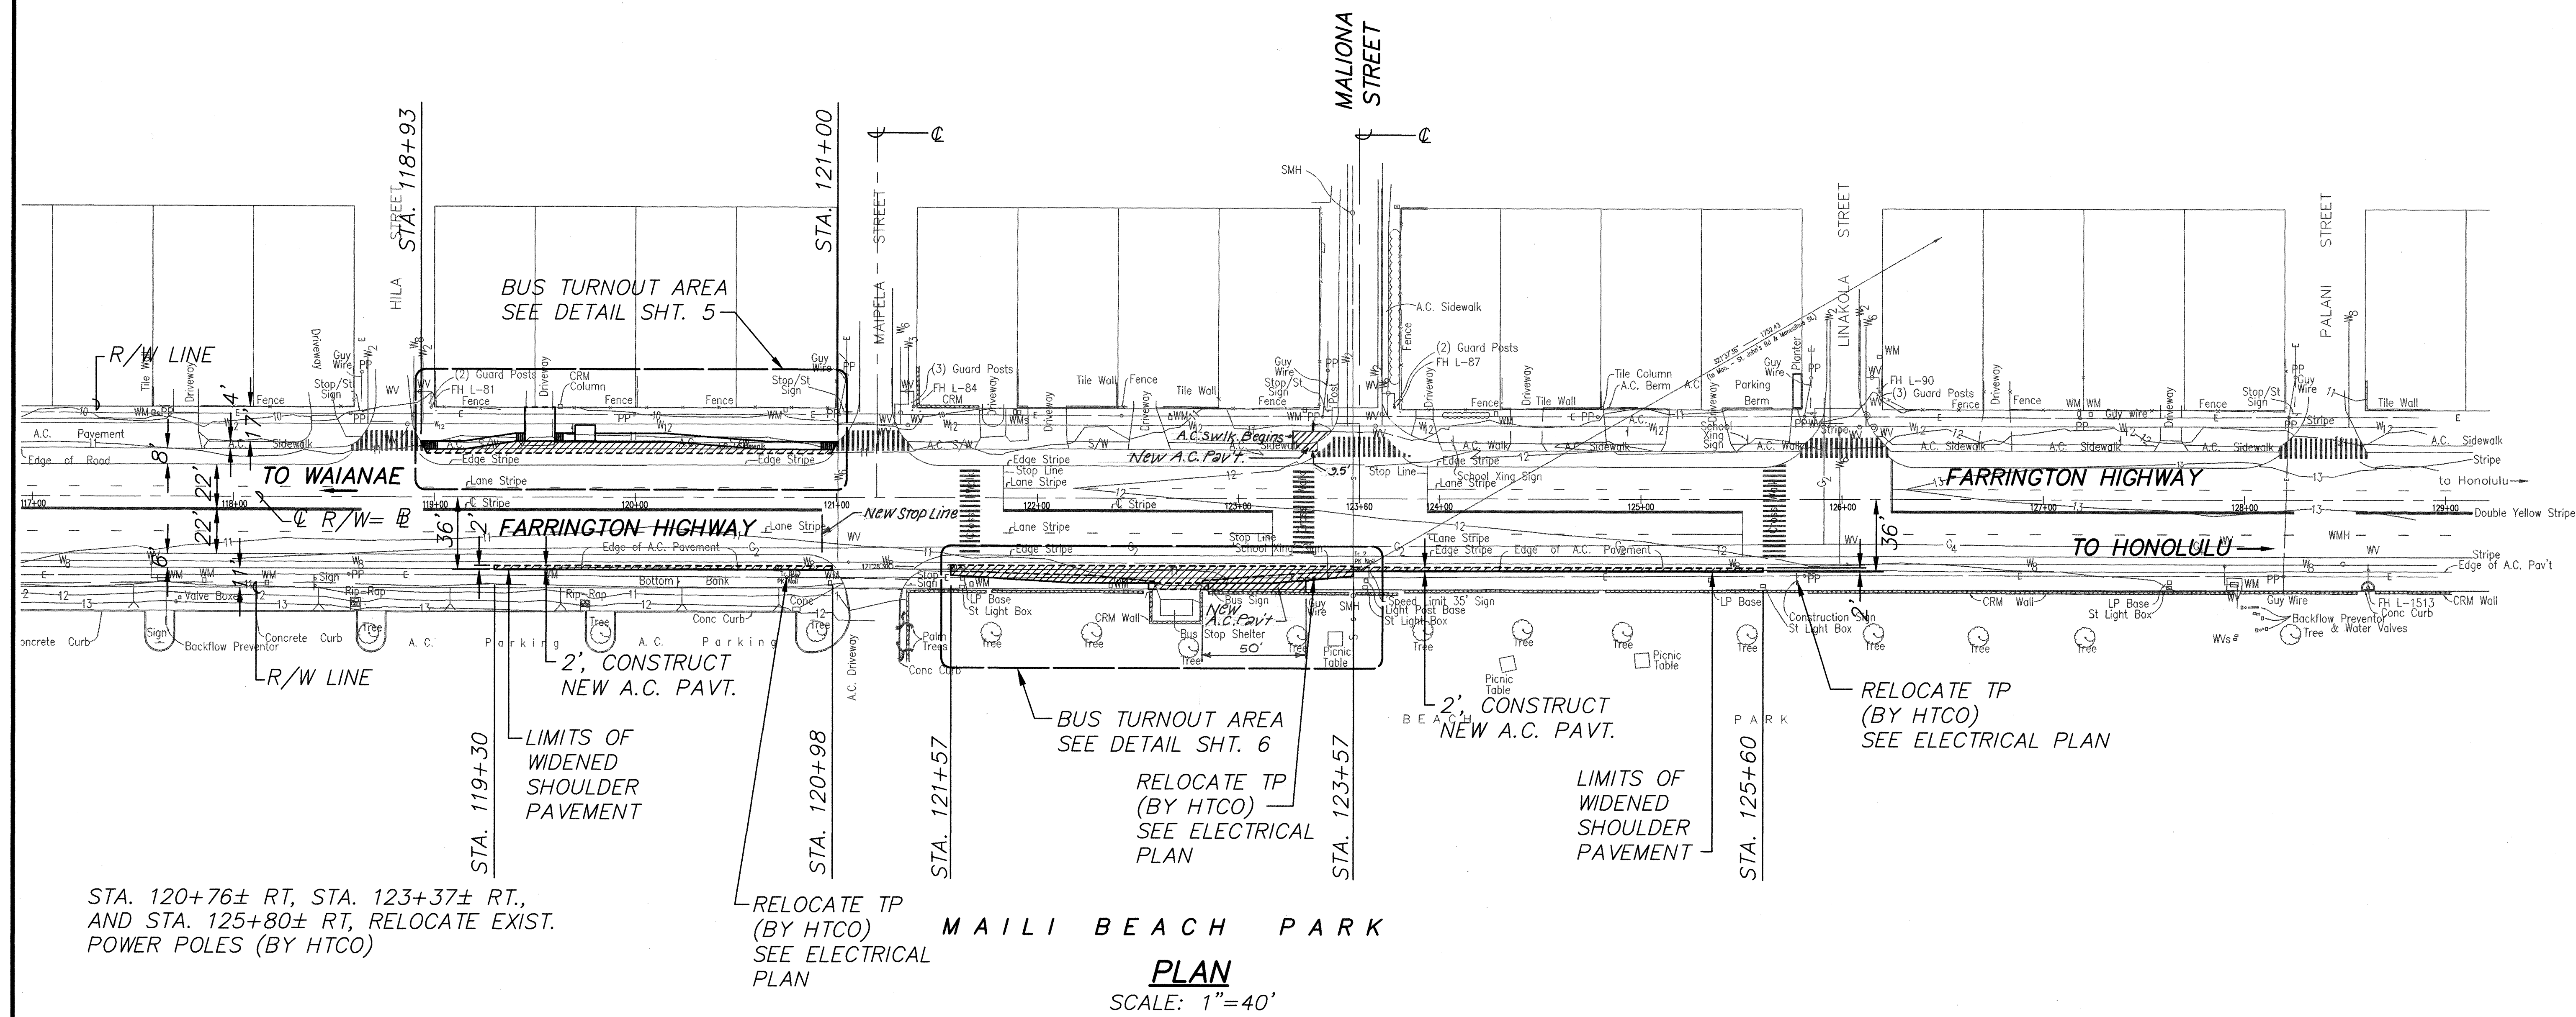

STA. 120+76± RT, STA. 123+37± RT., AND STA. 125+80± RT, RELOCATE EXIST. POWER POLES (BY HTCO)

RELOCATE TP (BY HTCO) SEE ELECTRICAL PLAN

MAILI BEACH PARK
PLAN
SCALE: 1"=40'

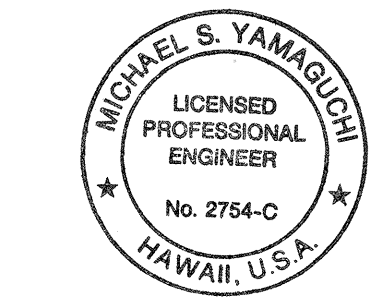

THIS WORK WAS PREPARED BY ME OR UNDER MY SUPERVISION
By: *Michael S. Yamaguchi*
FUJITA & ASSOCIATES

STATE OF HAWAII
DEPARTMENT OF TRANSPORTATION
HIGHWAYS DIVISION

ROADWAY PLAN

FARRINGTON HIGHWAY
Intersection Improvements at Maliona St.

Project No. 93A-03-97

Scale: 1"=40' Date: Apr. 1998

SHEET No. 1 OF 1 SHEETS