


Fujita & Assoc., Inc. DESIGNED BY K. KUNISHIGE 587-2173 4-2-98 P. S. & E. BY PHONE DATE

INDEX TO DRAWINGS	
SHT. NO.	DESCRIPTION
1	TITLE SHEET
2	STANDARD PLANS SUMMARY
3	LEGEND AND GENERAL NOTES
4	TYPICAL SECTION AND DETAILS
5	BUS TURNOUT DETAILS-1
6	BUS TURNOUT DETAILS-2
7	ROADWAY PLAN
8	PAVEMENT MARKING LEGEND, NOTES, AND DETAILS
9	SIGNING AND PAVEMENT MARKINGS
10	SWING BRACKET DETAIL
11	TRAFFIC SUMMARIES AND DETAILS
ELECTRICAL DRAWINGS	
12	E-1 SITE ELECTRICAL PLAN AND ELECTRICAL SYMBOL LIST
13	E-2 SITE ELECTRICAL PLAN AND SIGNAL ASSEMBLY DETAILS
14	E-3 ELEC. PLAN-TRAFFIC SIGNAL EQUIP. EQUIP. AND HANDHOLE/DUCTLINES
15	E-4 TRAFFIC SIGNAL STANDARD AND FOUNDATION DETAILS
16	E-5 MISCELLANEOUS DETAILS
17	E-6 TRAFFIC SIGNAL DETAILS
18	E-7 PULLBOX AND COVER DETAILS





STATE OF HAWAII
DEPARTMENT OF TRANSPORTATION
HIGHWAYS DIVISION
HONOLULU, HAWAII
"AS-BUILT"
PLANS FOR
FARRINGTON HIGHWAY
INTERSECTION IMPROVEMENTS AT MALIONA STREET
PROJ. NO. 93A-03-97

DISTRICT OF WAIANAE
ISLAND OF OAHU

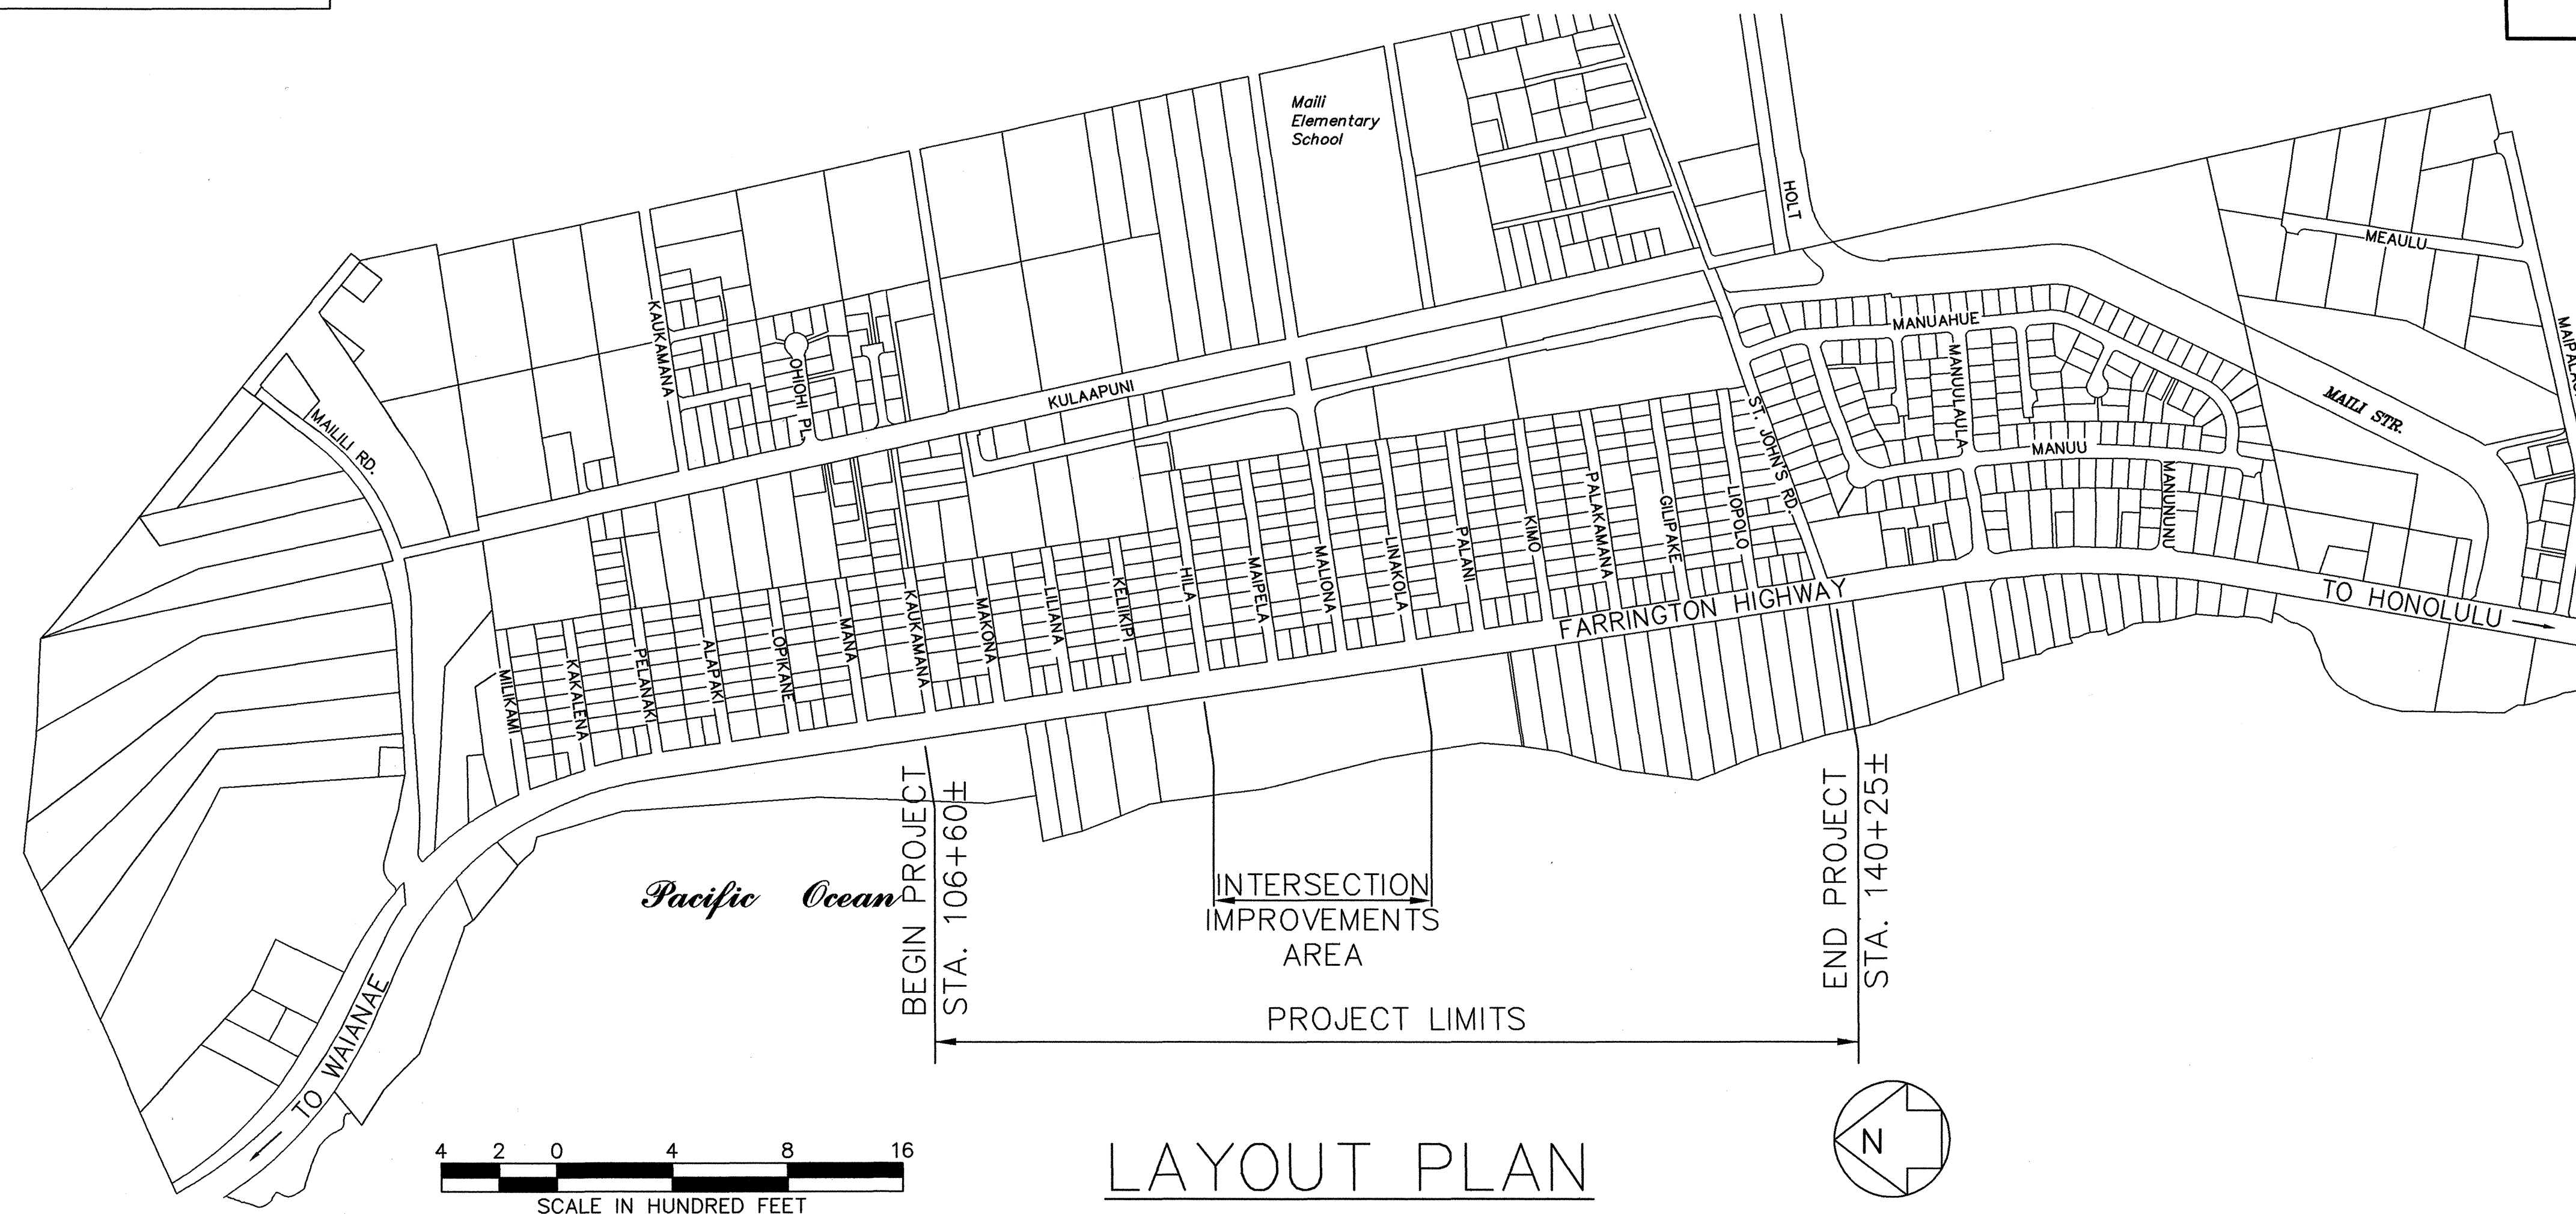

LAYOUT PLAN
LENGTH OF PROJECT....0.64 MILES

FED. ROAD DIST. NO.	STATE	PROJ. NO.	FISCAL YEAR	SHEET NO.	TOTAL SHEETS
HAWAII	HAW.	93A-03-97	1998	1	18

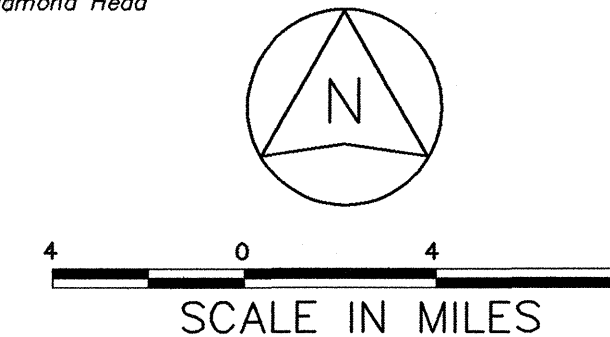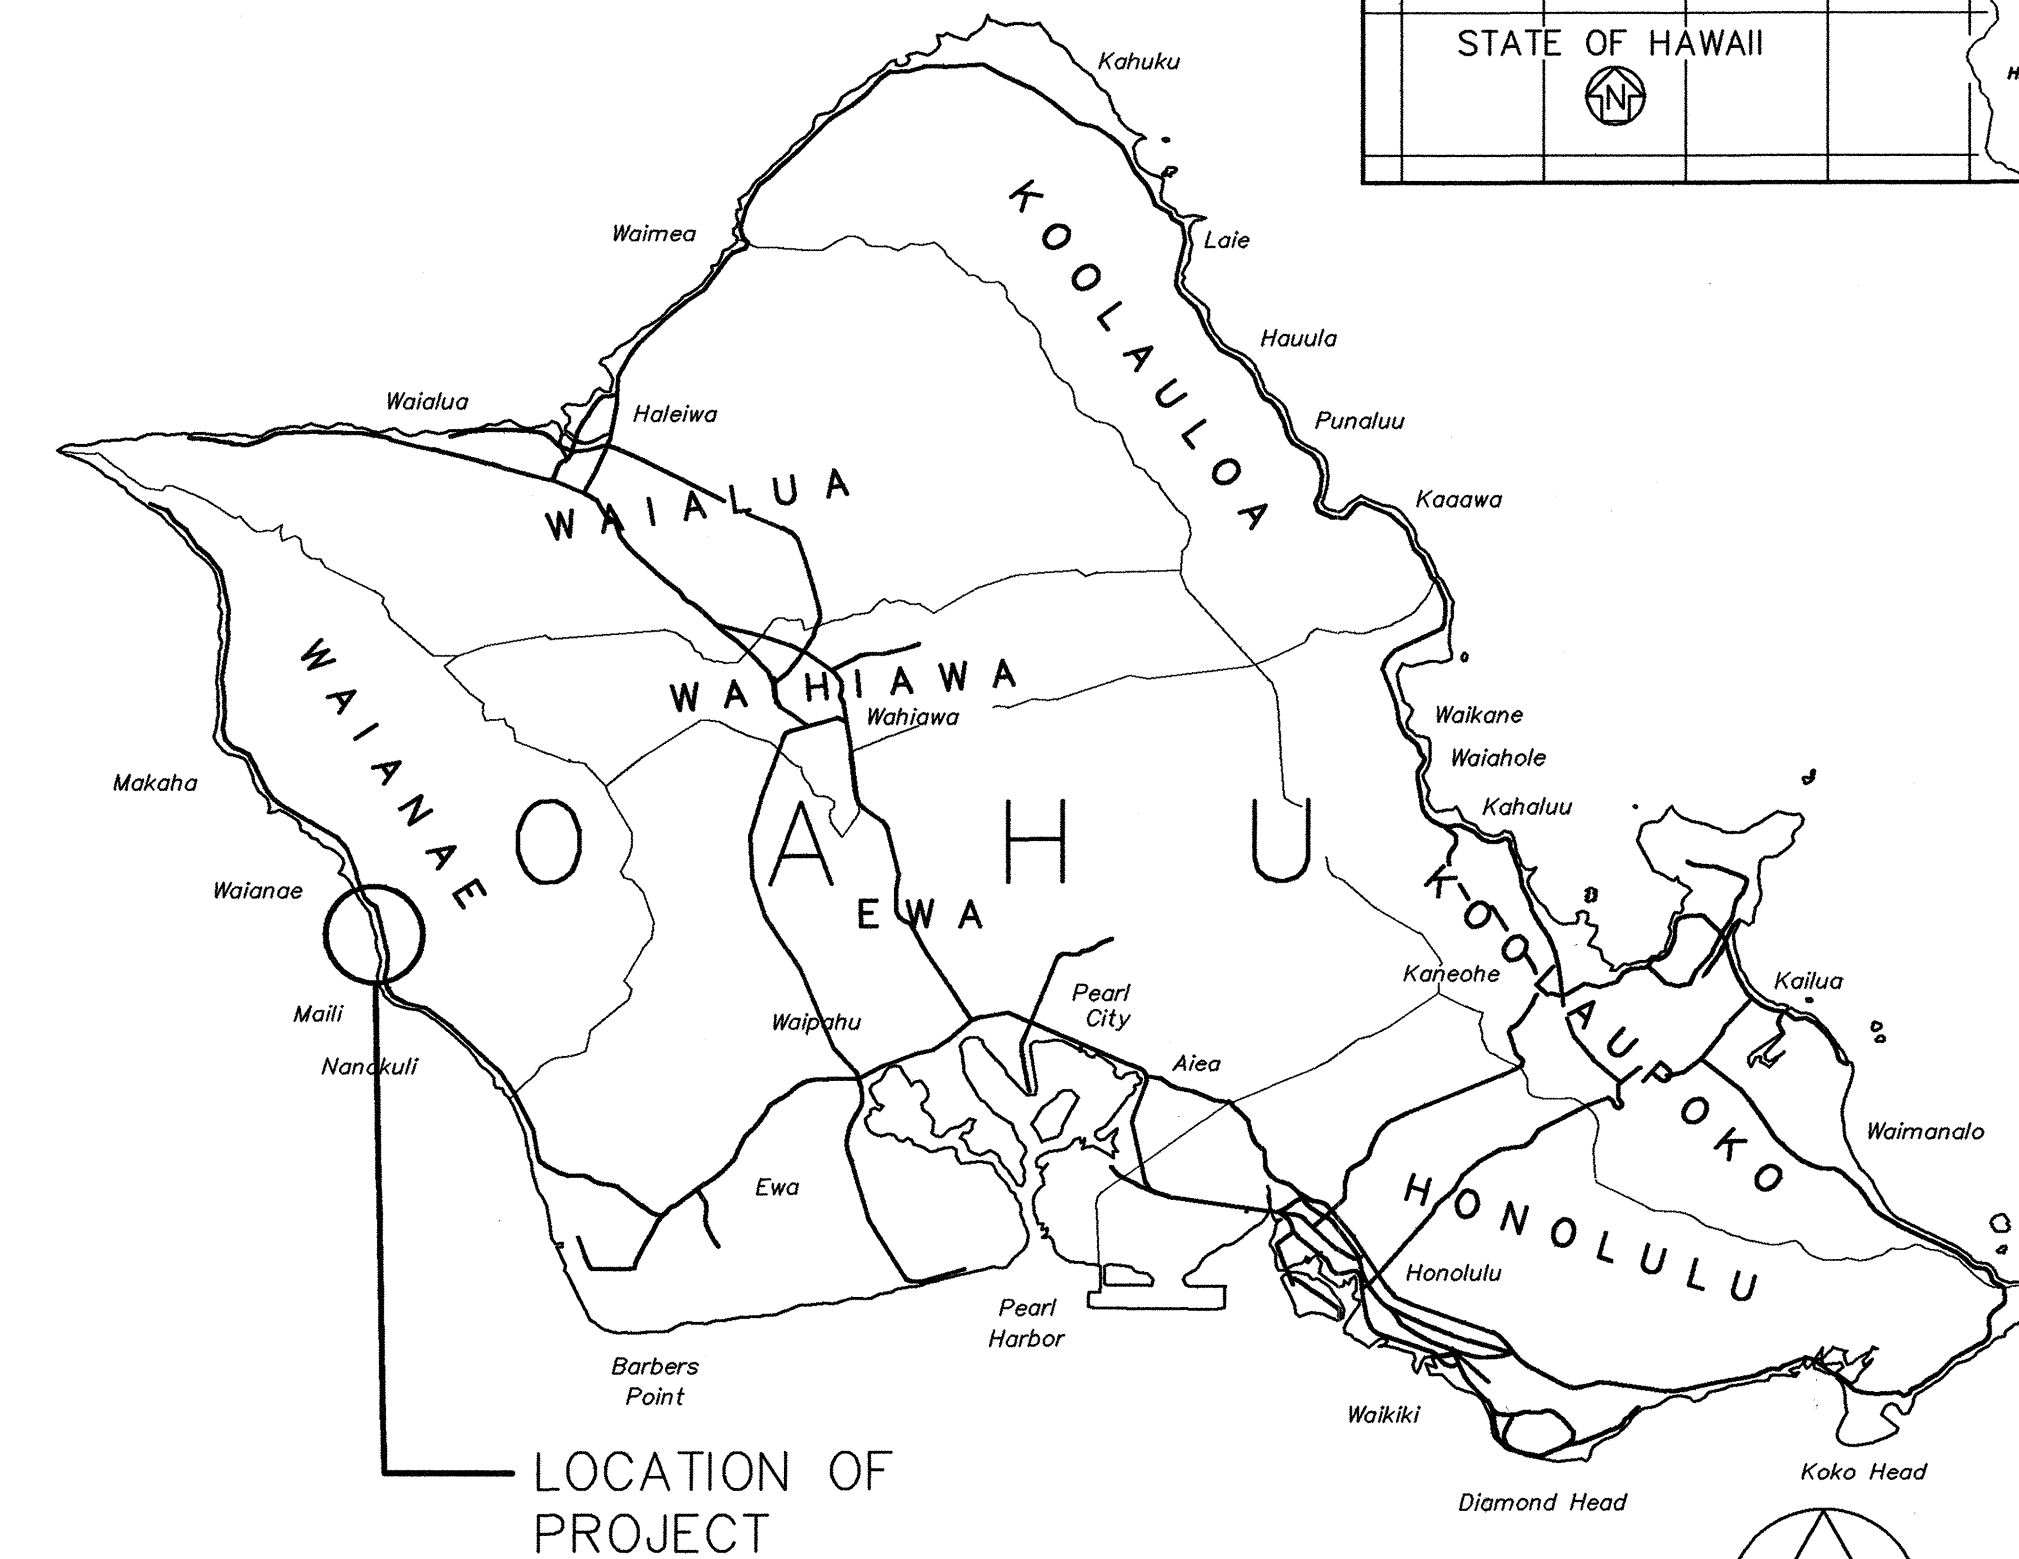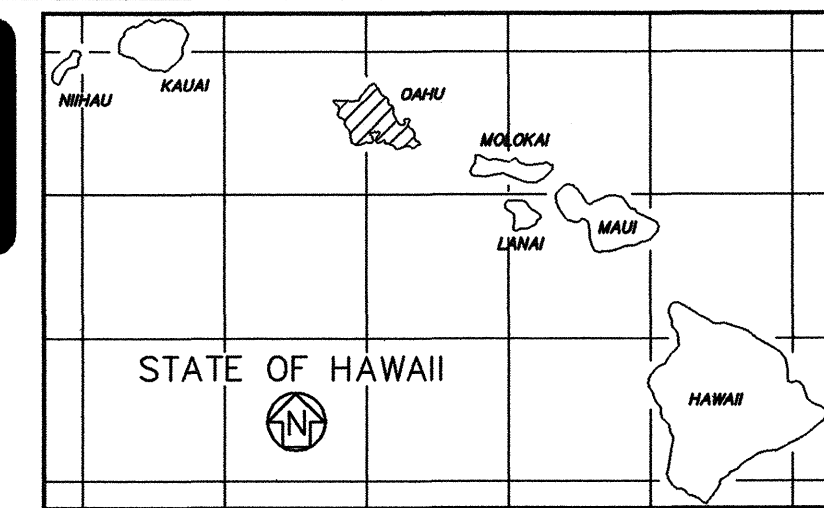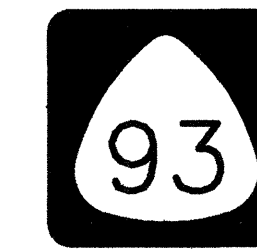

MILE POST 9.36 TO MILE POST 8.72

CHANGES MADE DURING CONSTRUCTION HAVE BEEN INCORPORATED ON THESE PLANS EXCEPT CHANGES IN THE ORIGINAL THEORETICAL QUANTITIES. FOR ACTUAL QUANTITIES, REFER TO PROJECT LEDGER AND/OR COMPLETION BOOK.

1/10/00

DEPARTMENT OF TRANSPORTATION
STATE OF HAWAII
APPROVED: *Kay K. Kishida* 5/7/98
DIR. OF TRANSPORTATION DATE