

INDEX TO DRAWINGS	
SHEET NO.	DESCRIPTION
1	TITLE SHEET
2	STANDARD PLANS SUMMARY
3 - 12	GENERAL AND UTILITY NOTES
13 - 15	TYPICAL SECTIONS
16 - 26	PLAN ①
27 - 36	SPOT ELEVATION PLAN ②
37 - 44	ROADWAY DETAILS
45 - 58	CURB RAMP PLAN AND DETAILS
59 - 73	DRAINAGE PLANS AND PROFILES
74 - 86	EROSION CONTROL PLAN,
	NOTES AND DETAILS
87 - 99	TRAFFIC SIGNAL PLAN AND DETAILS ③
100 - 107	UTILITY PLAN
108 - 120	UTILITY RELOCATION PLAN AND PROFILE ④
121 - 145	ELECTRICAL PLAN AND DETAILS ⑤
146 - 155	SIGNING AND PAVEMENT MARKING
	PLAN, NOTES AND LEGEND
156 - 168	TRAFFIC CONTROL PLAN AND DETAILS
169 - 200	STRUCTURAL PLAN, NOTES AND DETAILS
201 - 210	BORING LOGS
211 - 230	CROSS SECTIONS




Sheet Nos. ①C.O.20S-1;②C.O. 28S-1 & C.O. 29S-1; C.O 33S-1;③C.O. 91S-1 & C.O. 92S-2; C.O. 94S-1 thru S-6; ④C.O. 110S-1; C.O. 112S-1 thru S-3; C.O. 120S-1; ⑤C.O. 145S-3, are Supplementary Sheets to this Project. Total Sheet Count After "As-Built" Posting 248 Sheets.

STATE OF HAWAII
DEPARTMENT OF TRANSPORTATION
HIGHWAYS DIVISION
HONOLULU, HAWAII
AS-BUILT
PLANS FOR
**FARRINGTON HIGHWAY
INTERSECTION IMPROVEMENTS
AT NANAKULI AVENUE
AND HALEAKALA AVENUE**
FEDERAL-AID PROJECT NO. STP-093-1(22)

DISTRICT OF WAIANAE
ISLAND OF OAHU

PROJECT LOCATION

FED. ROAD DIST. NO.	STATE	FEDERAL AID PROJ. NO.	FISCAL YEAR	SHEET NO.	TOTAL SHEETS
HAWAII	HAW.	STP-093-1(22)	2013	1	230

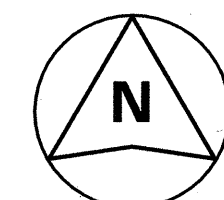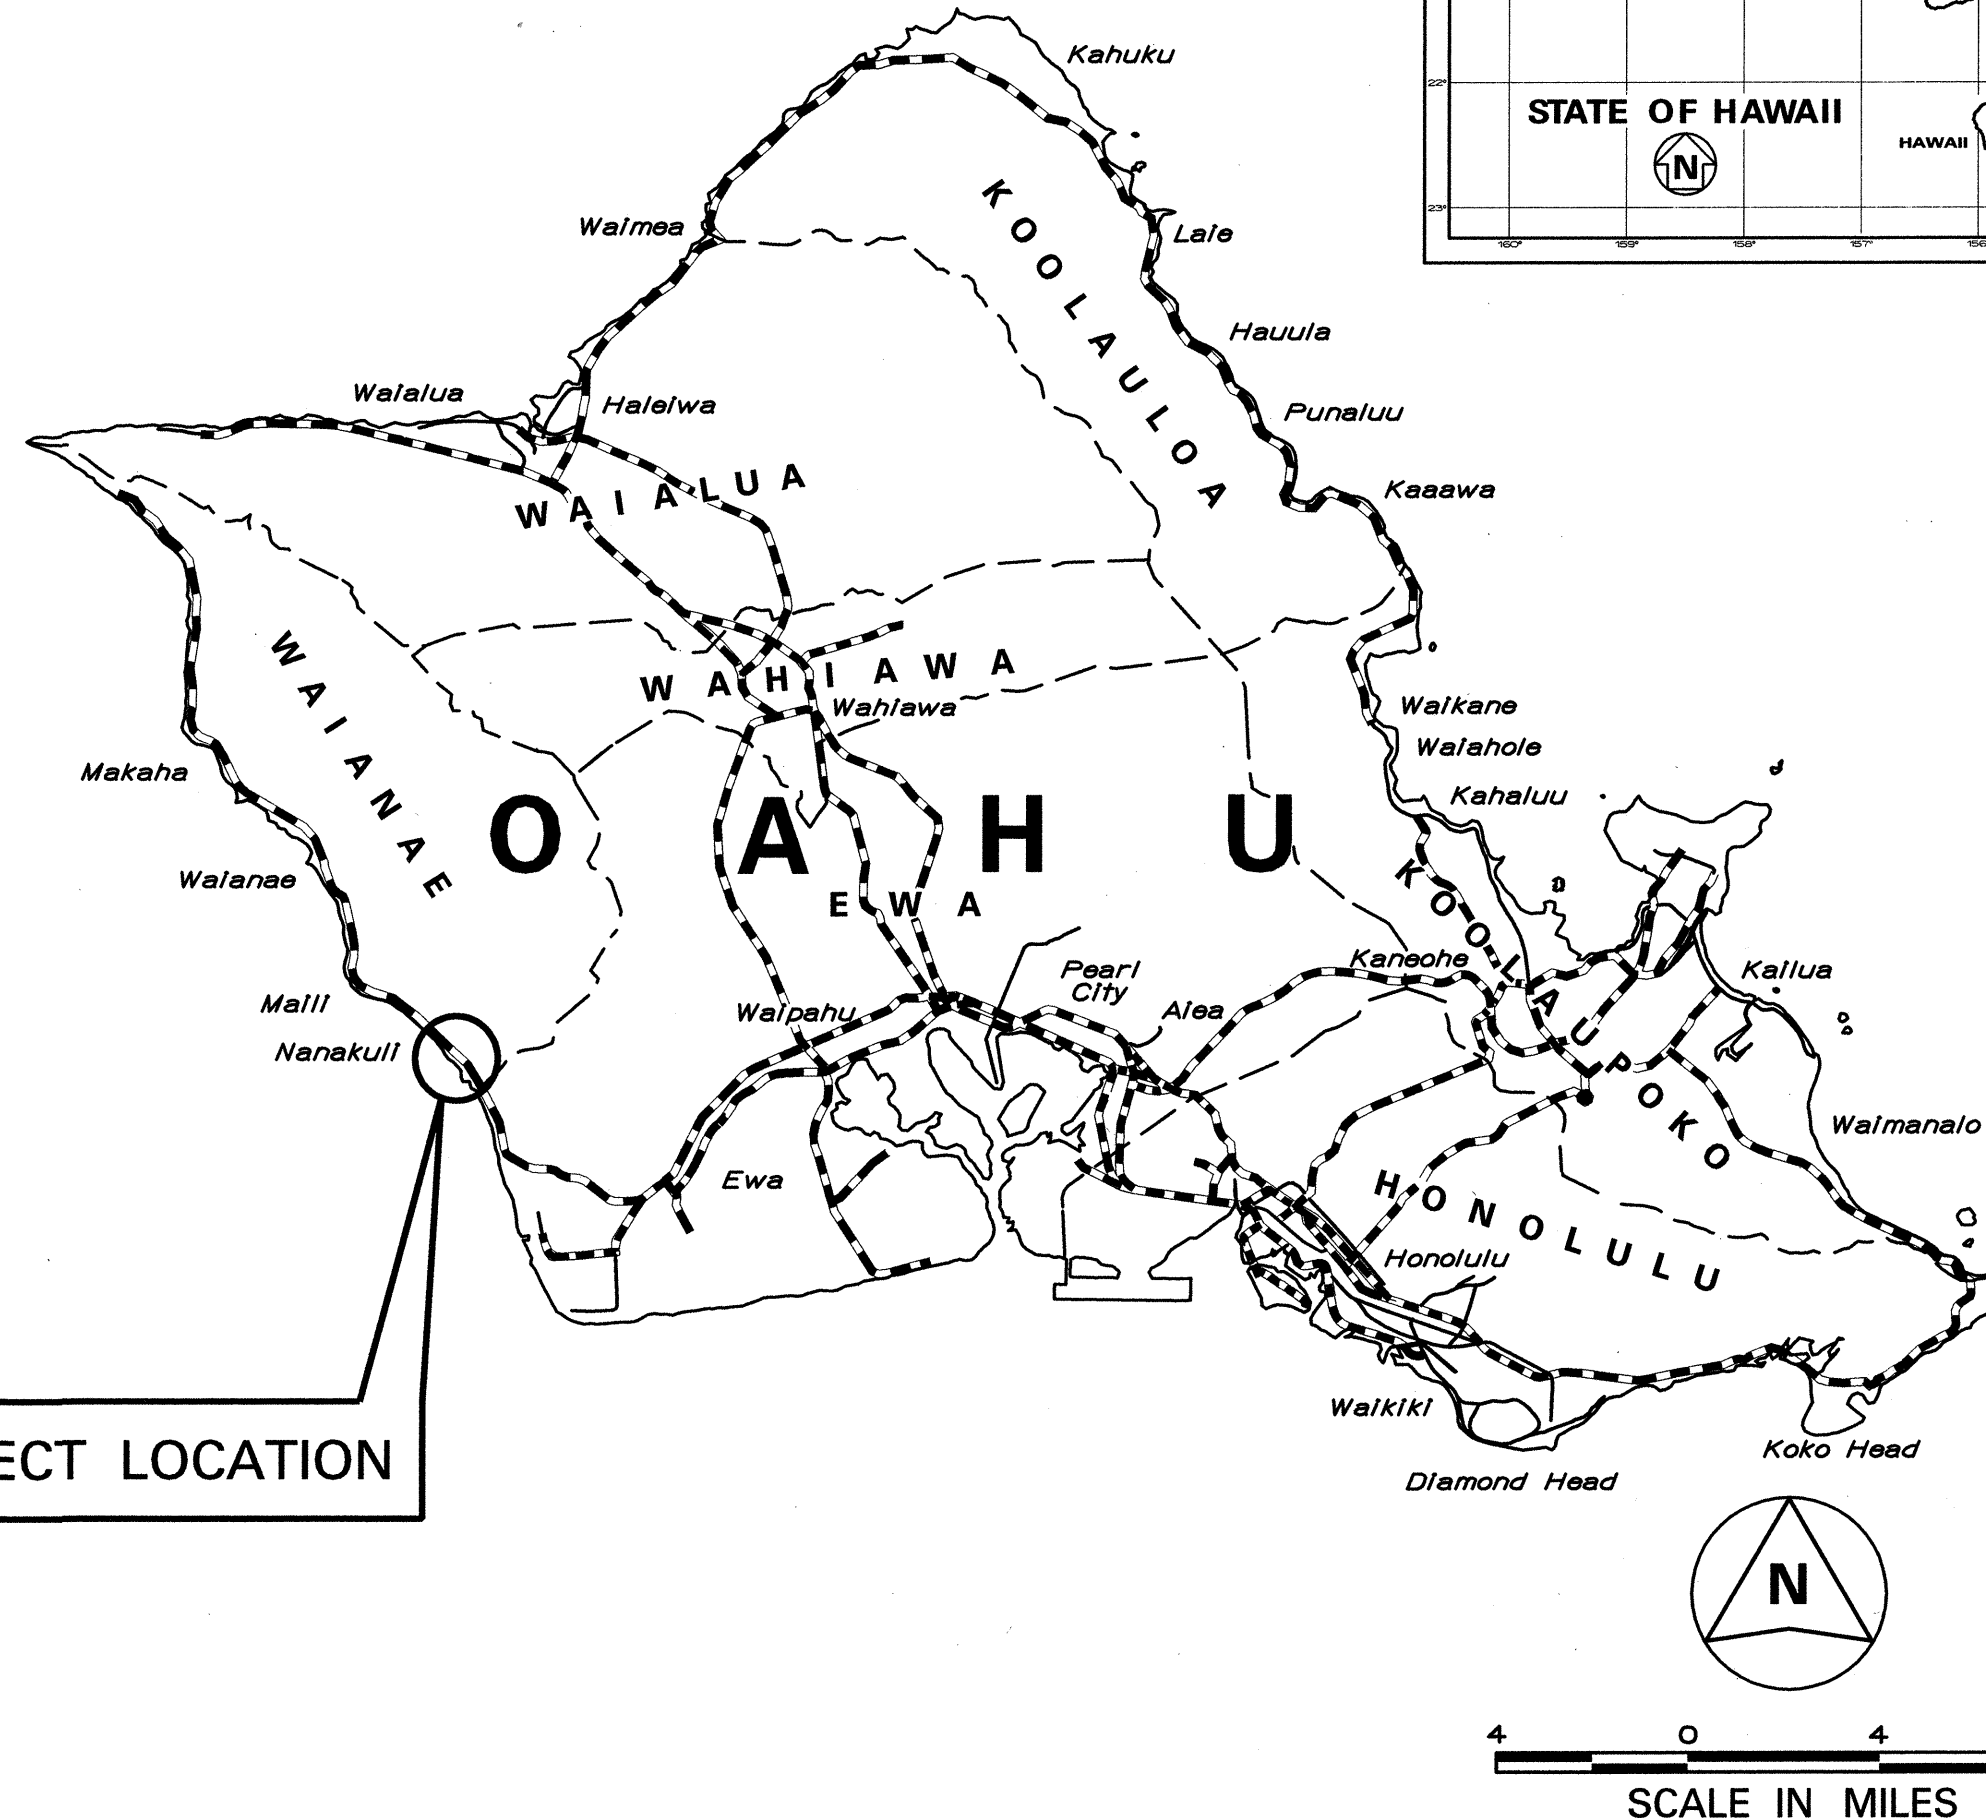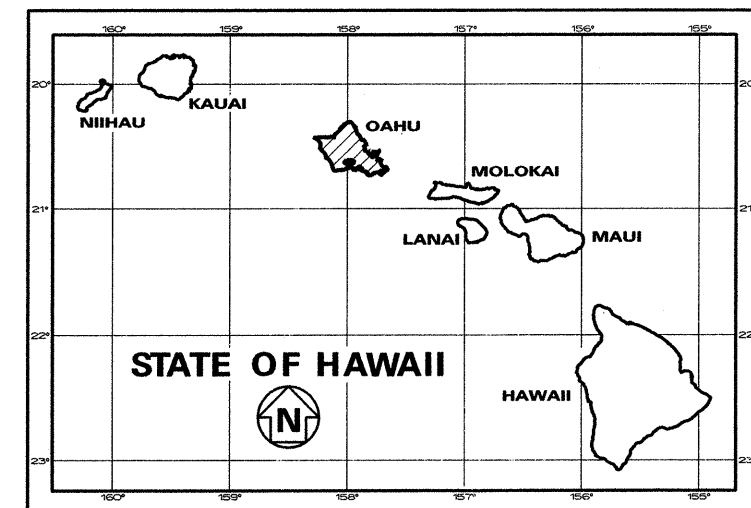


SCALE IN MILES

FEDERAL AID PROJECTS PREVIOUSLY CONSTRUCTED OR UNDER CONSTRUCTION


MILE POST 4.85 TO MILE POST 5.64

DESIGN DESIGNATION

ADT (2010)	39977
ADT (2030)	50533
DHV (2030)	3537
D	48/52
T	4.99
T ₂₄	4.78
V	45 MPH

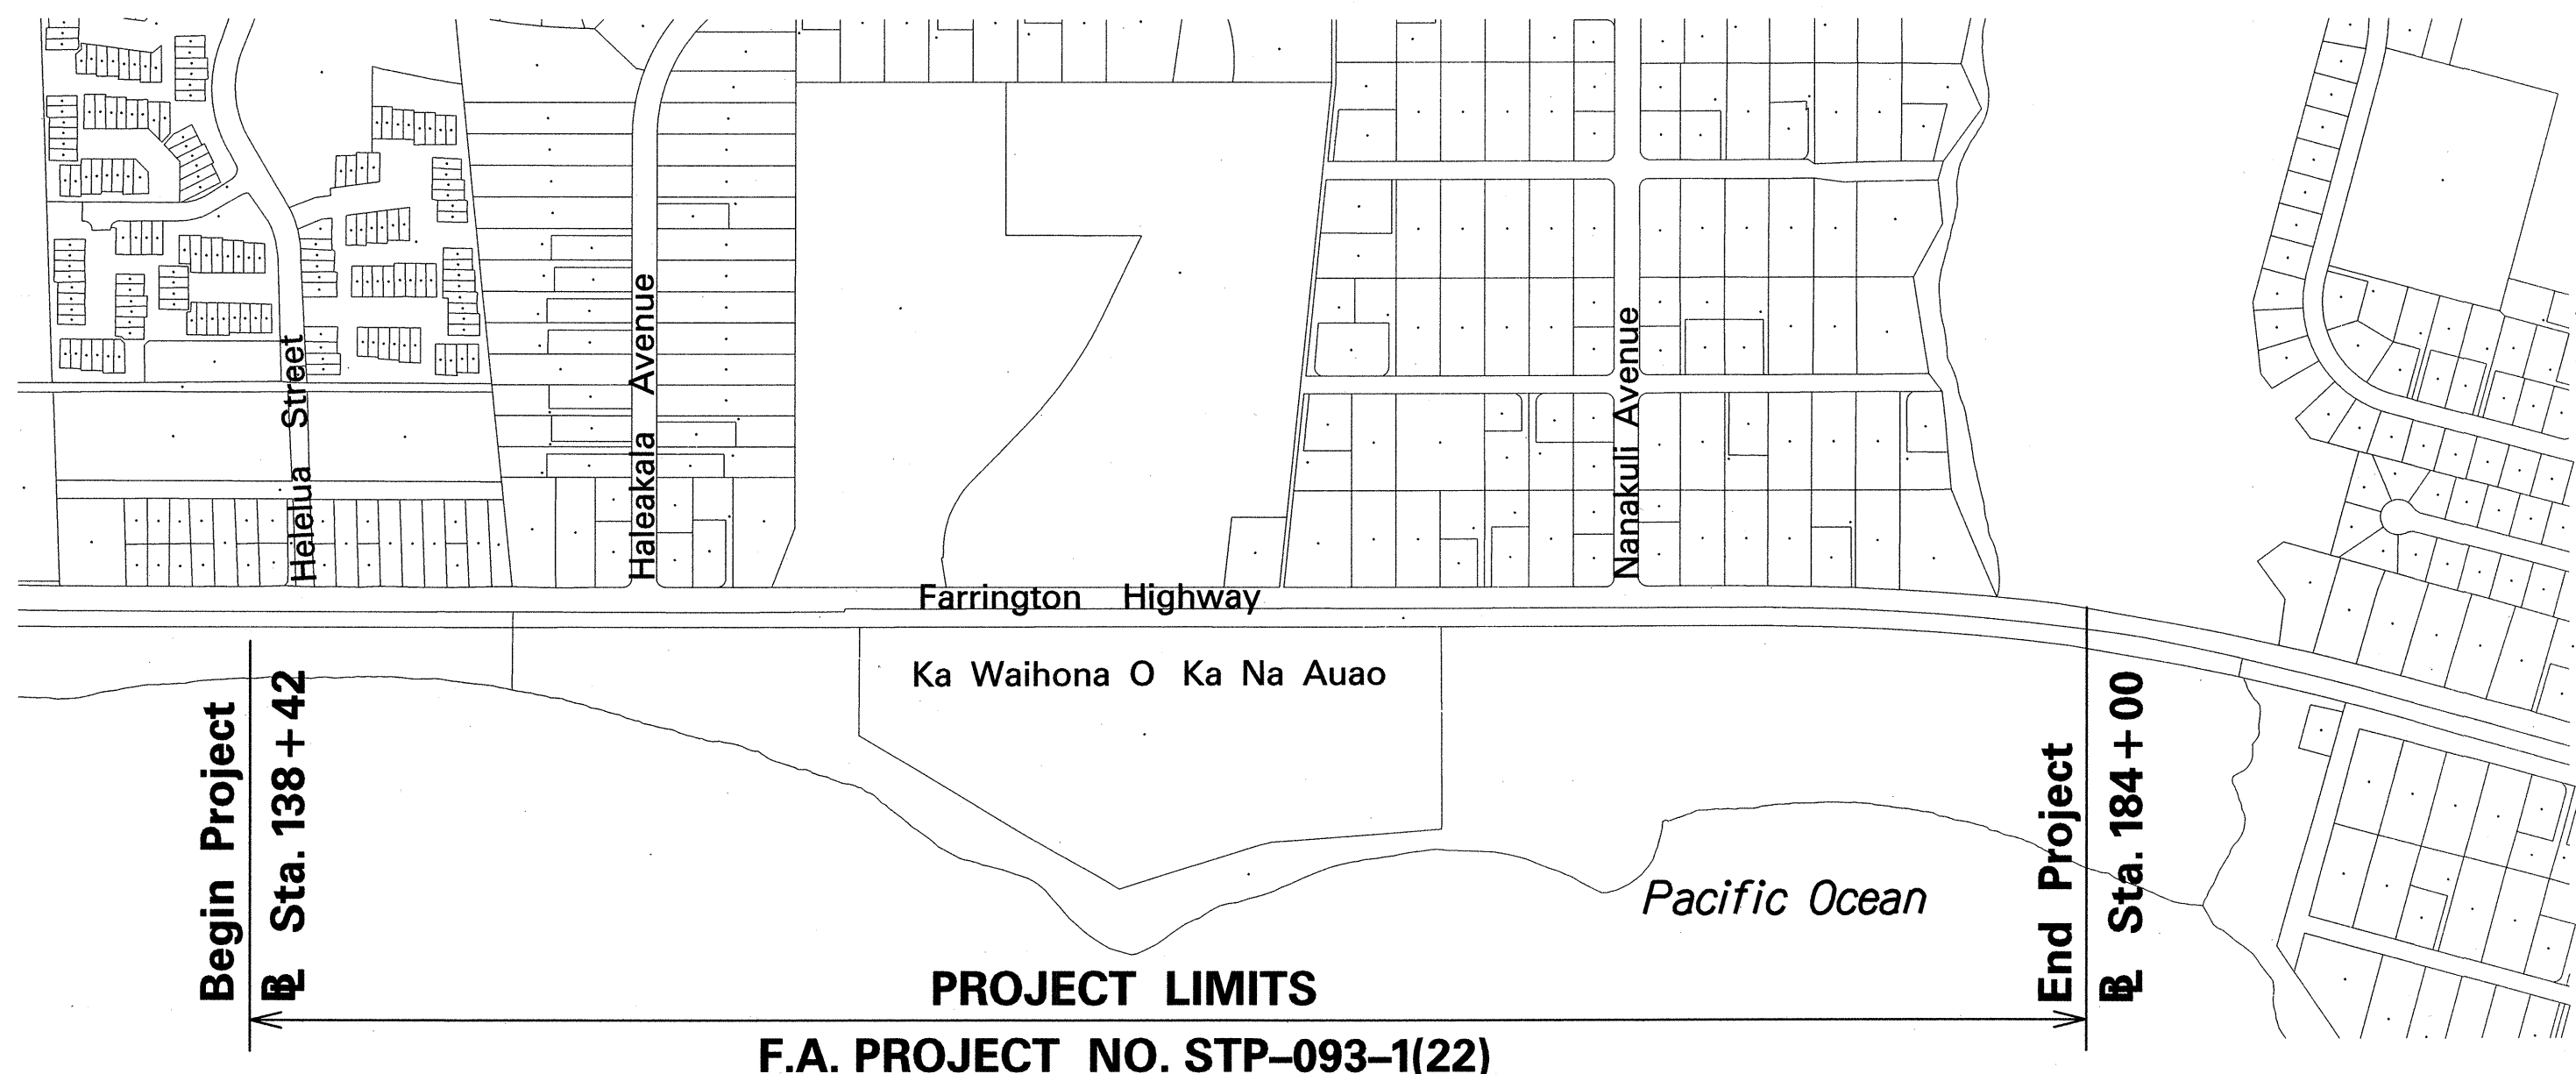

PROJECT LIMITS
F.A. PROJECT NO. STP-093-1(22)

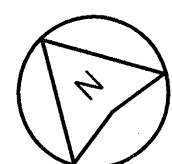

LAYOUT PLAN
NOT TO SCALE

CHANGES MADE DURING CONSTRUCTION HAVE BEEN INCORPORATED ON THESE PLANS EXCEPT CHANGES IN THE ORIGINAL THEORETICAL QUANTITIES. FOR ACTUAL QUANTITIES, REFER TO PROJECT LEDGER AND/OR COMPUTATION BOOK.

Samuel P. Rembert
RESIDENT ENGINEER

Jul 18, 2022
DATE

DEPARTMENT OF TRANSPORTATION STATE OF HAWAII	
APPROVED:	
<i>Samuel L. Y. Yeh</i>	7/24/13
for DIR. OF TRANSPORTATION	DATE