


FED. ROAD DIST. NO.	STATE	PROJ. NO.	FISCAL YEAR	SHEET NO.	TOTAL SHEETS
HAWAII	HAW.	93A-01-12	2016	10	29

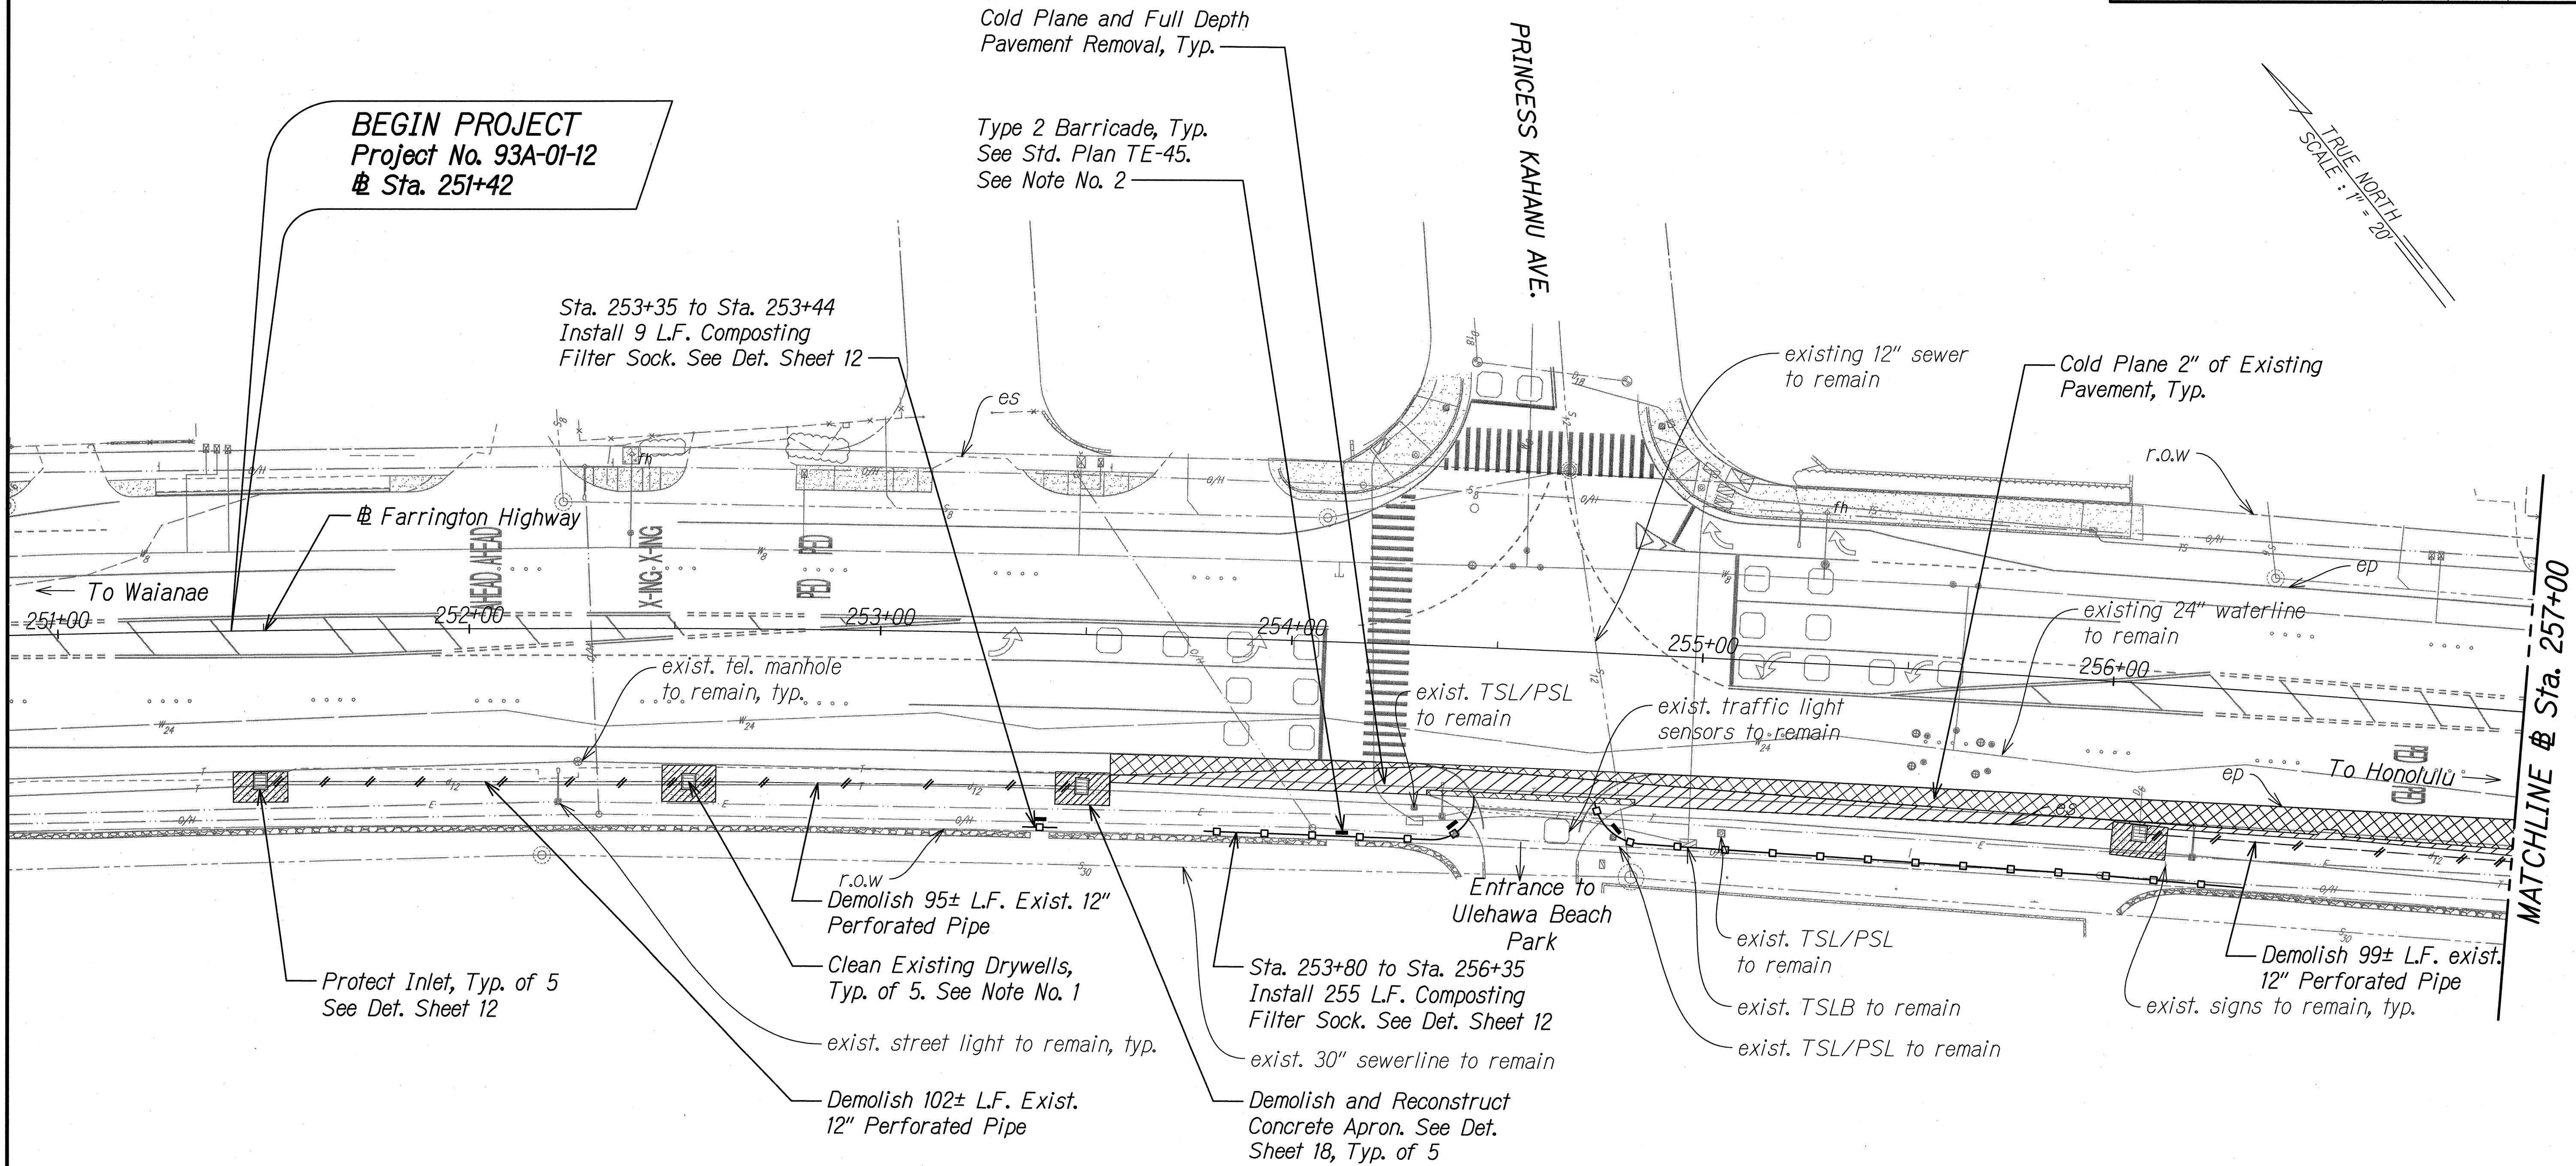


LEGEND:

- Cold Plane and Full Depth Pavement Removal
- Cold Plane Exist. Pavement
- Composting Filter Sock
- Demolish Existing Perforated Pipe
- Type 2 Barricade

NOTE:

- "Clean Existing Drywells" shall be paid for under Contract Item No. 603.0300-Clean Existing Culverts.
- If Filter Socks are to remain in place during nonworking hours, place Type 2 Barricades where tripping hazards may occur. Type 2 Barricades shall be incidental to Contract Item No. 645.0100-Traffic Control.
- During nonworking hours, reverse filter sock to align with driveway flare at entrance to Ulehawa Beach Park.

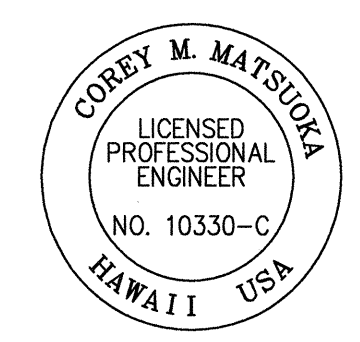

THIS WORK WAS PREPARED BY ME OR UNDER MY SUPERVISION

SIGNATURE: *Corey Matsuda* 4/30/16
EXPIRATION DATE OF THE LICENSE

STATE OF HAWAII
DEPARTMENT OF TRANSPORTATION
HIGHWAYS DIVISION

**EXISTING CONDITION, DEMOLITION
AND EROSION CONTROL PLAN**
FARRINGTON HIGHWAY DRAINAGE IMPROVEMENTS
Vicinity of Princess Kahanu Avenue
Project No. 93A-01-12

Scale: 1" = 20' Date: Oct. 2015

SHEET No. 1 OF 2 SHEETS

SURVEY PLOTTED BY	DATE
DRAWN BY	
DESIGNED BY	
NOTED BY	
CHECKED BY	
ORIGINAL PLAN	
NOTE BOOK	
No.	

FED. ROAD DIST. NO.	STATE	PROJ. NO.	FISCAL YEAR	SHEET NO.	TOTAL SHEETS
HAWAII	HAW.	93A-01-12	2016	11	29

- Cold Plane and Full Depth Pavement Removal

Cold Plane Exist. Pavement

Composting Filter Sock

Temporary Slope Protection

Type 2 Barricade
-
-
- NOTE:

1. "Clean Existing Drywells" shall be paid for under Contract Item No. 603.0300-Clean Existing Culverts.

2. Contractor shall stabilize TSL/SL poles as necessary with respect to nearby trenching.

3. If Filter Socks are to remain in place during nonworking hours, place Type 2 barricades where tripping hazards may occur.

4. Type 2 Barricades shall be incidental to Contract Item No. 645.0100-Traffic Control.
- | | |
|-------------------|------|
| SURVEY PLOTTED BY | DATE |
| DRAWN BY | |
| CHECKED BY | |
| NOTED BY | |
| NO. | |
- APPROVED:

MANAGER AND CHIEF ENGINEER, BWS

(For work Affecting BWS Facilities in City/State R/W & BWS Easements only)

DATE
- COREY M. MATSUOKA

LICENSED PROFESSIONAL ENGINEER

NO. 10330-C

HAWAII USA

THIS WORK WAS PREPARED BY ME OR UNDER MY SUPERVISION

SIGNATURE

DATE

EXPIRATION DATE OF THE LICENSE

4/30/16
- STATE OF HAWAII

DEPARTMENT OF TRANSPORTATION

HIGHWAYS DIVISION

EXISTING CONDITION, DEMOLITION AND EROSION CONTROL PLAN

FARRINGTON HIGHWAY DRAINAGE IMPROVEMENTS

Vicinity of Princess Kahanu Avenue

Project No. 93A-01-12

Scale: 1" = 20'

Date: Oct. 2015

SHEET No. 2 OF 2 SHEETS
- 11