



| FED. ROAD DIST. NO. | STATE | FED-AID PROJ. NO. | FISCAL YEAR | SHEET NO. | TOTAL SHEETS |
|---------------------|-------|-------------------|-------------|-----------|--------------|
| HAWAII              | HAW.  | HSIP-093-1(031)   | 2022        | 48        | 62           |

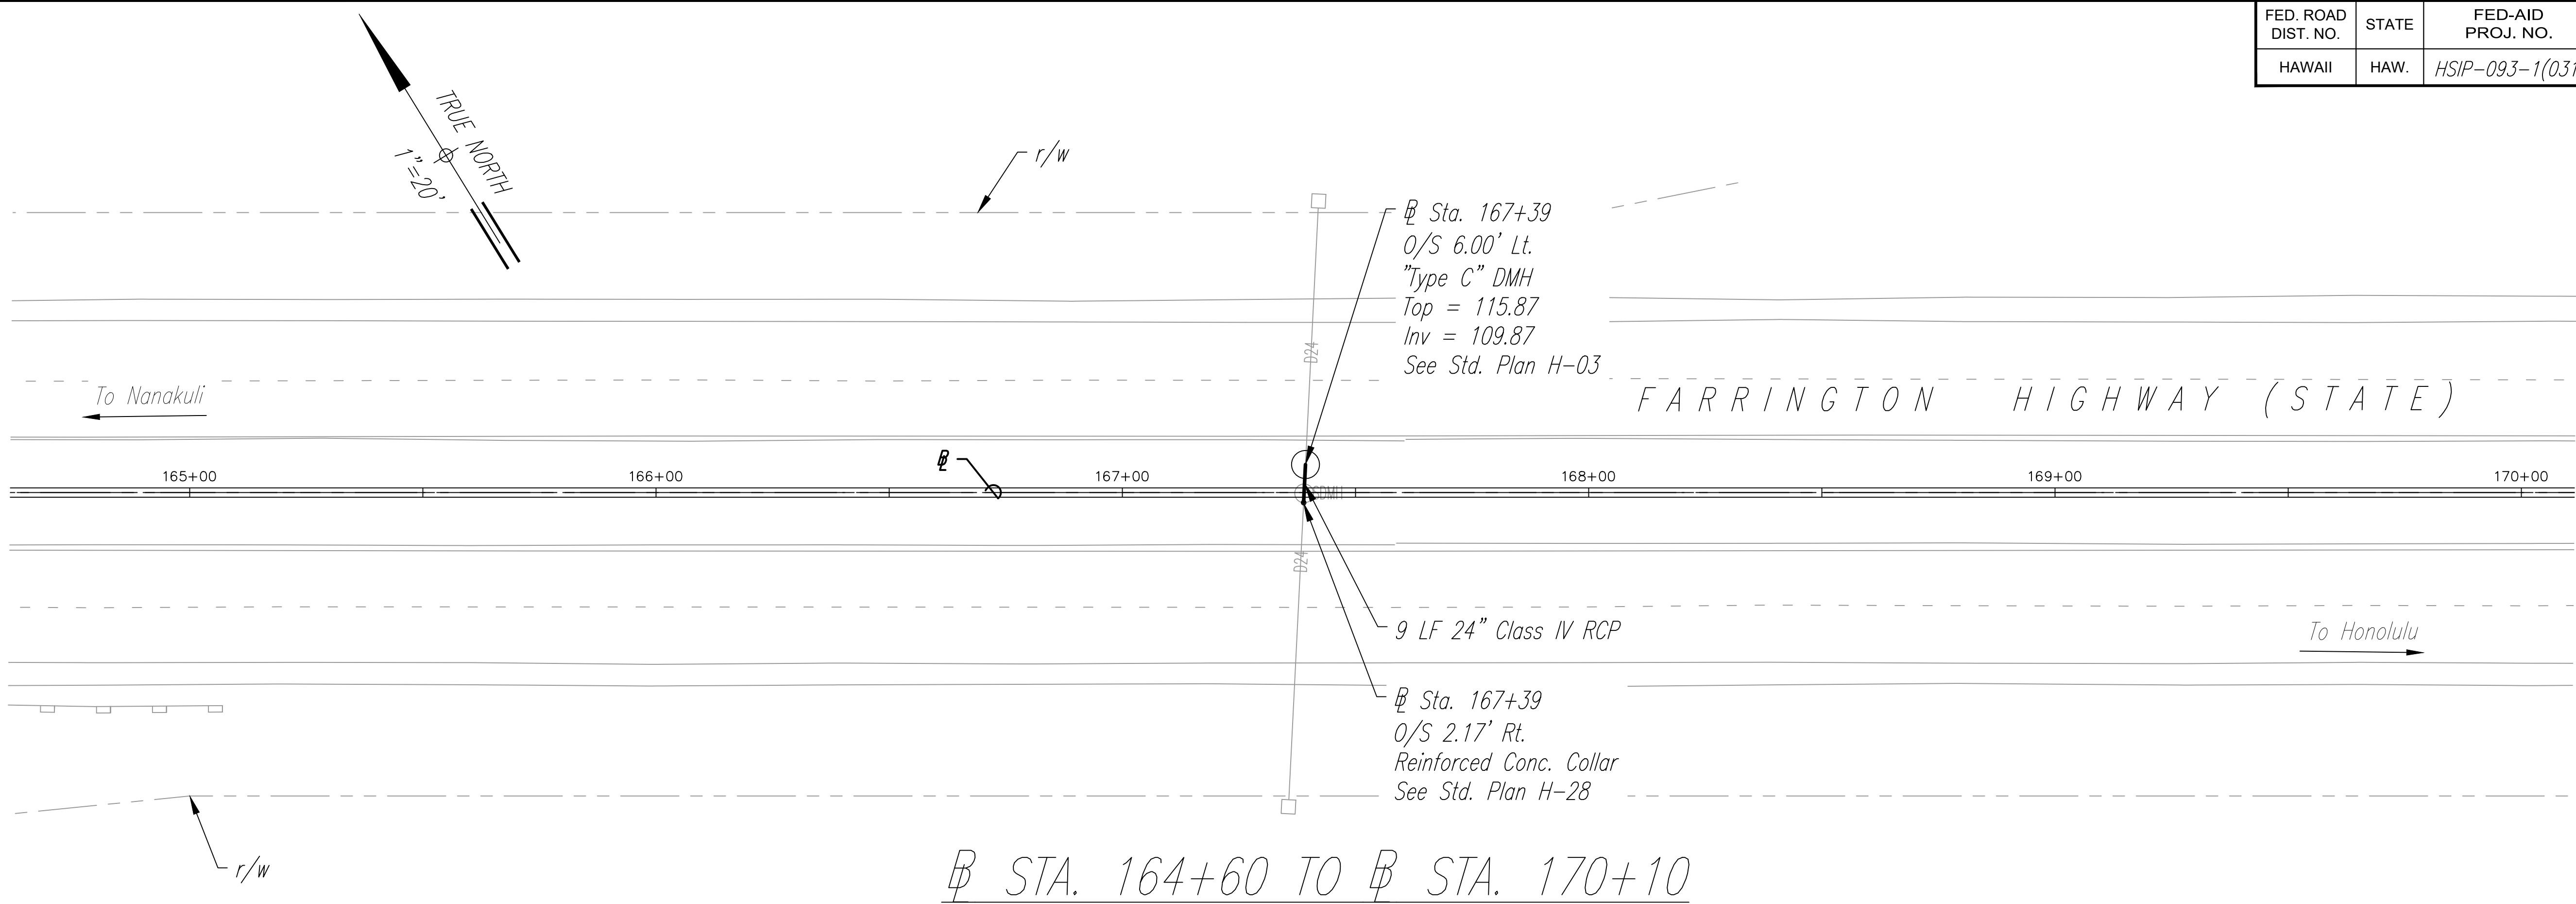


Sta. 164+60 TO Sta. 170+10  
Scale: 1" = 20'

- Note:
1. Drain manholes shall be Type C with Type P cast iron frame and cover.
  2. Location of existing drainage facilities are from as-built drawings. Contractor shall verify prior to construction.

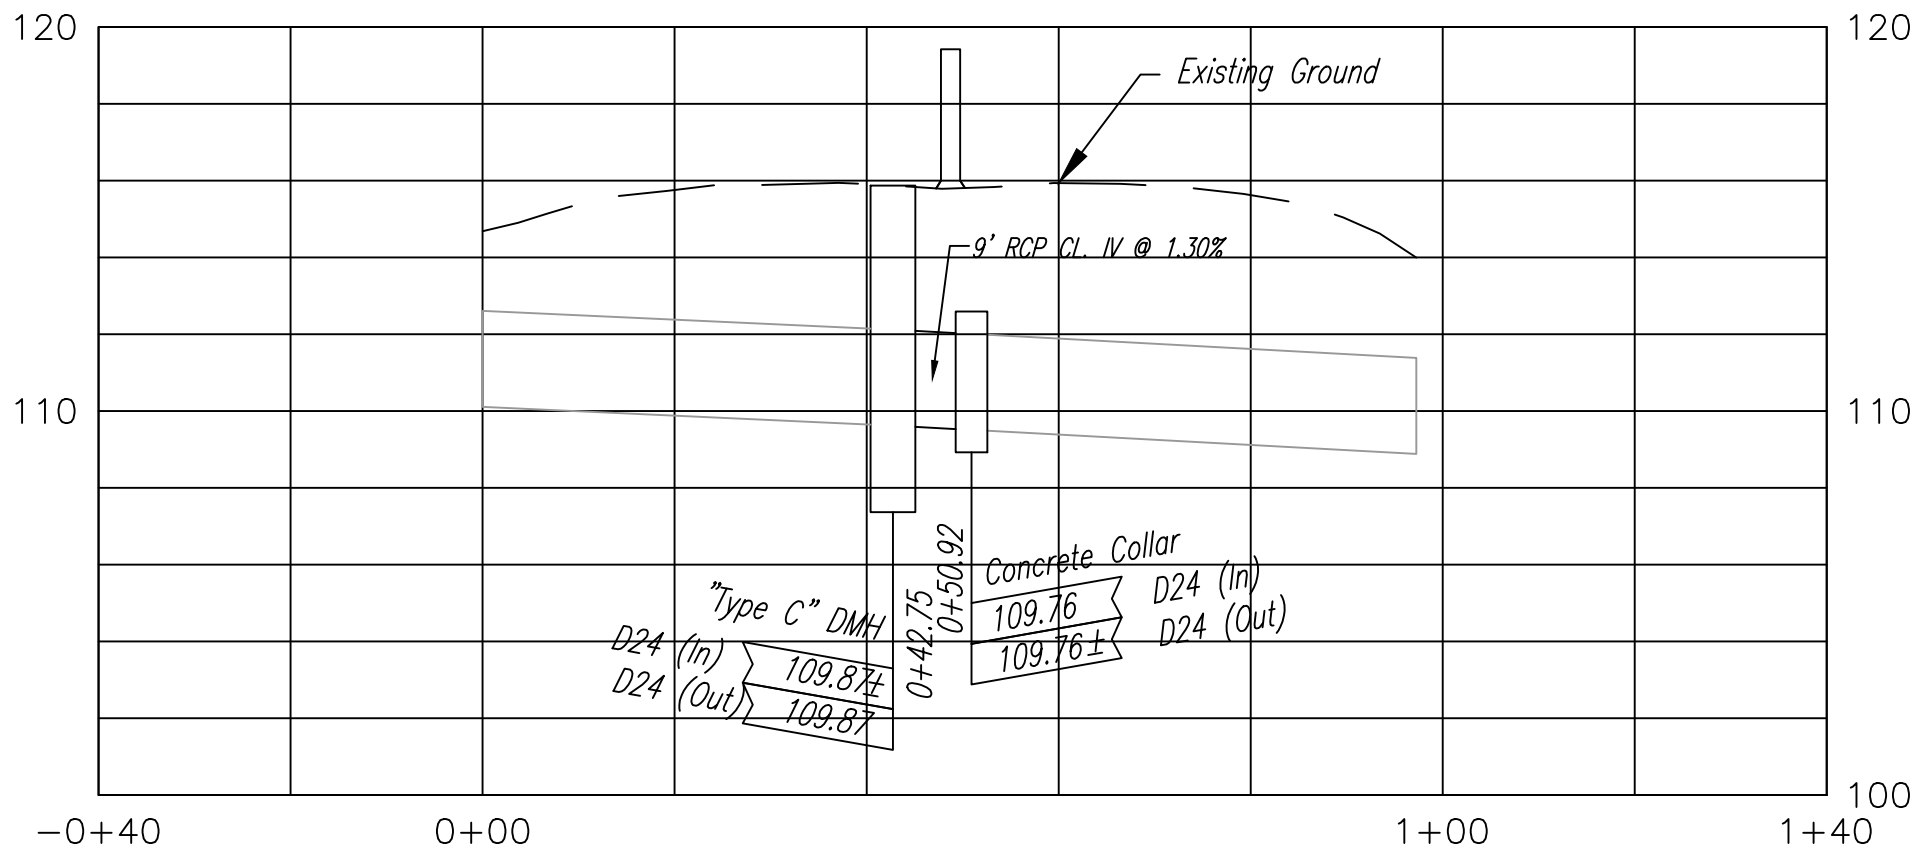

Profile Drain Line Sta. 167+39  
Scale: Hor. 1" = 20'  
Ver. 1" = 5'

|               |                   |      |
|---------------|-------------------|------|
| ORIGINAL PLAN | SURVEY PLOTTED BY | DATE |
| NOTE BOOK     | DRAWN BY          |      |
| No.           | DESIGNED BY       |      |
|               | QUANTITIES BY     |      |
|               | CHECKED BY        |      |

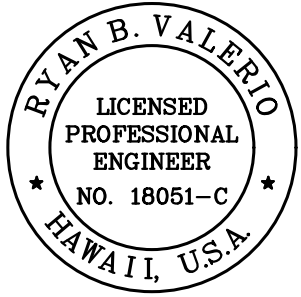

THIS WORK WAS PREPARED BY ME OR UNDER MY SUPERVISION.

Signature: R. B. Valero

EXPIRATION DATE OF LICENSE: 4/30/24

STATE OF HAWAII  
DEPARTMENT OF TRANSPORTATION  
HIGHWAYS DIVISION

DRAINAGE PLAN

FARRINGTON HIGHWAY  
SAFETY IMPROVEMENTS

Pohakunui Avenue to Interstate H-1  
Federal Aid Project No. HSIP-093-1(031)

Date: November 2021