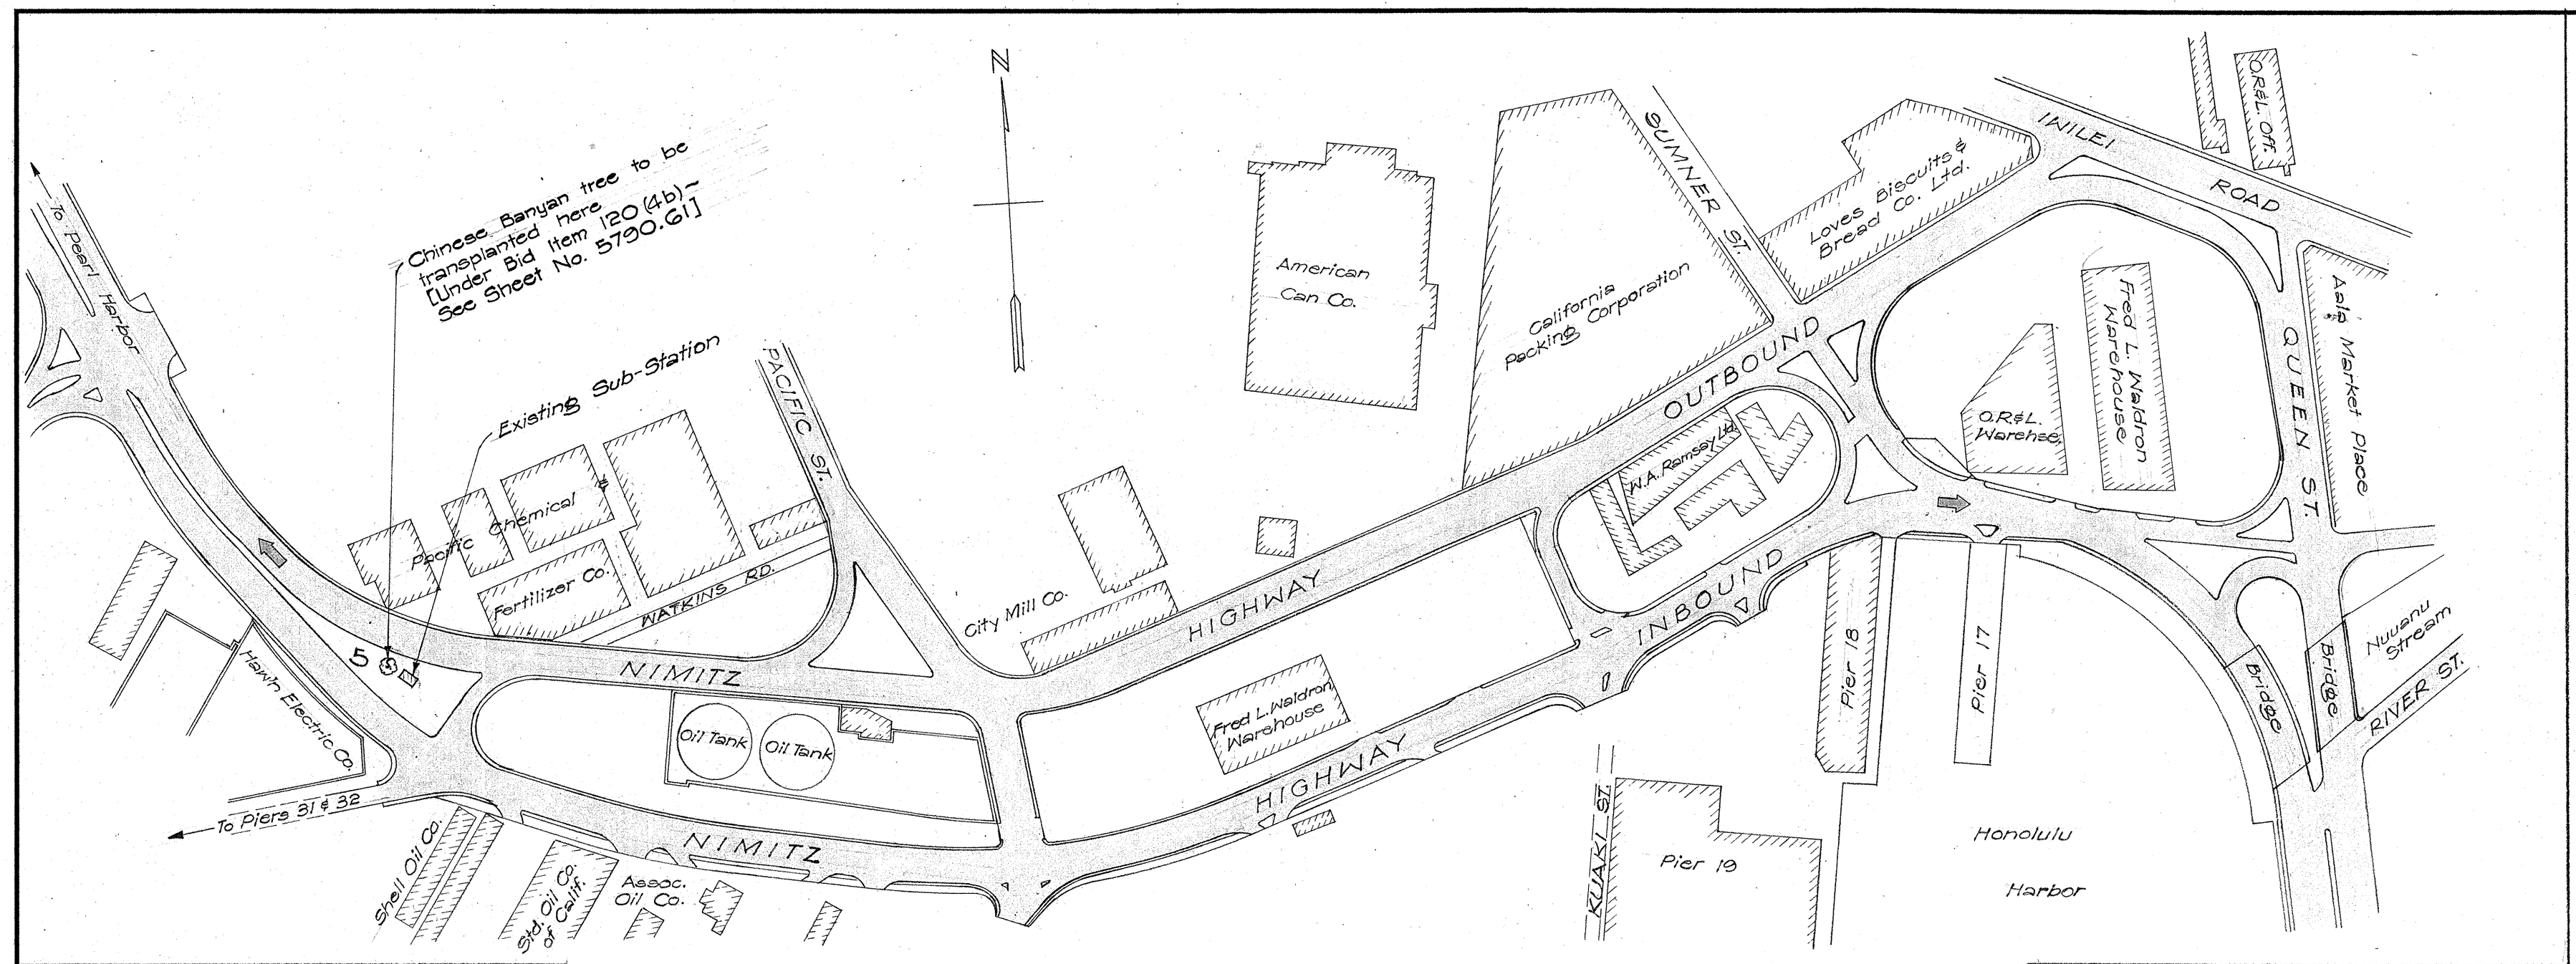
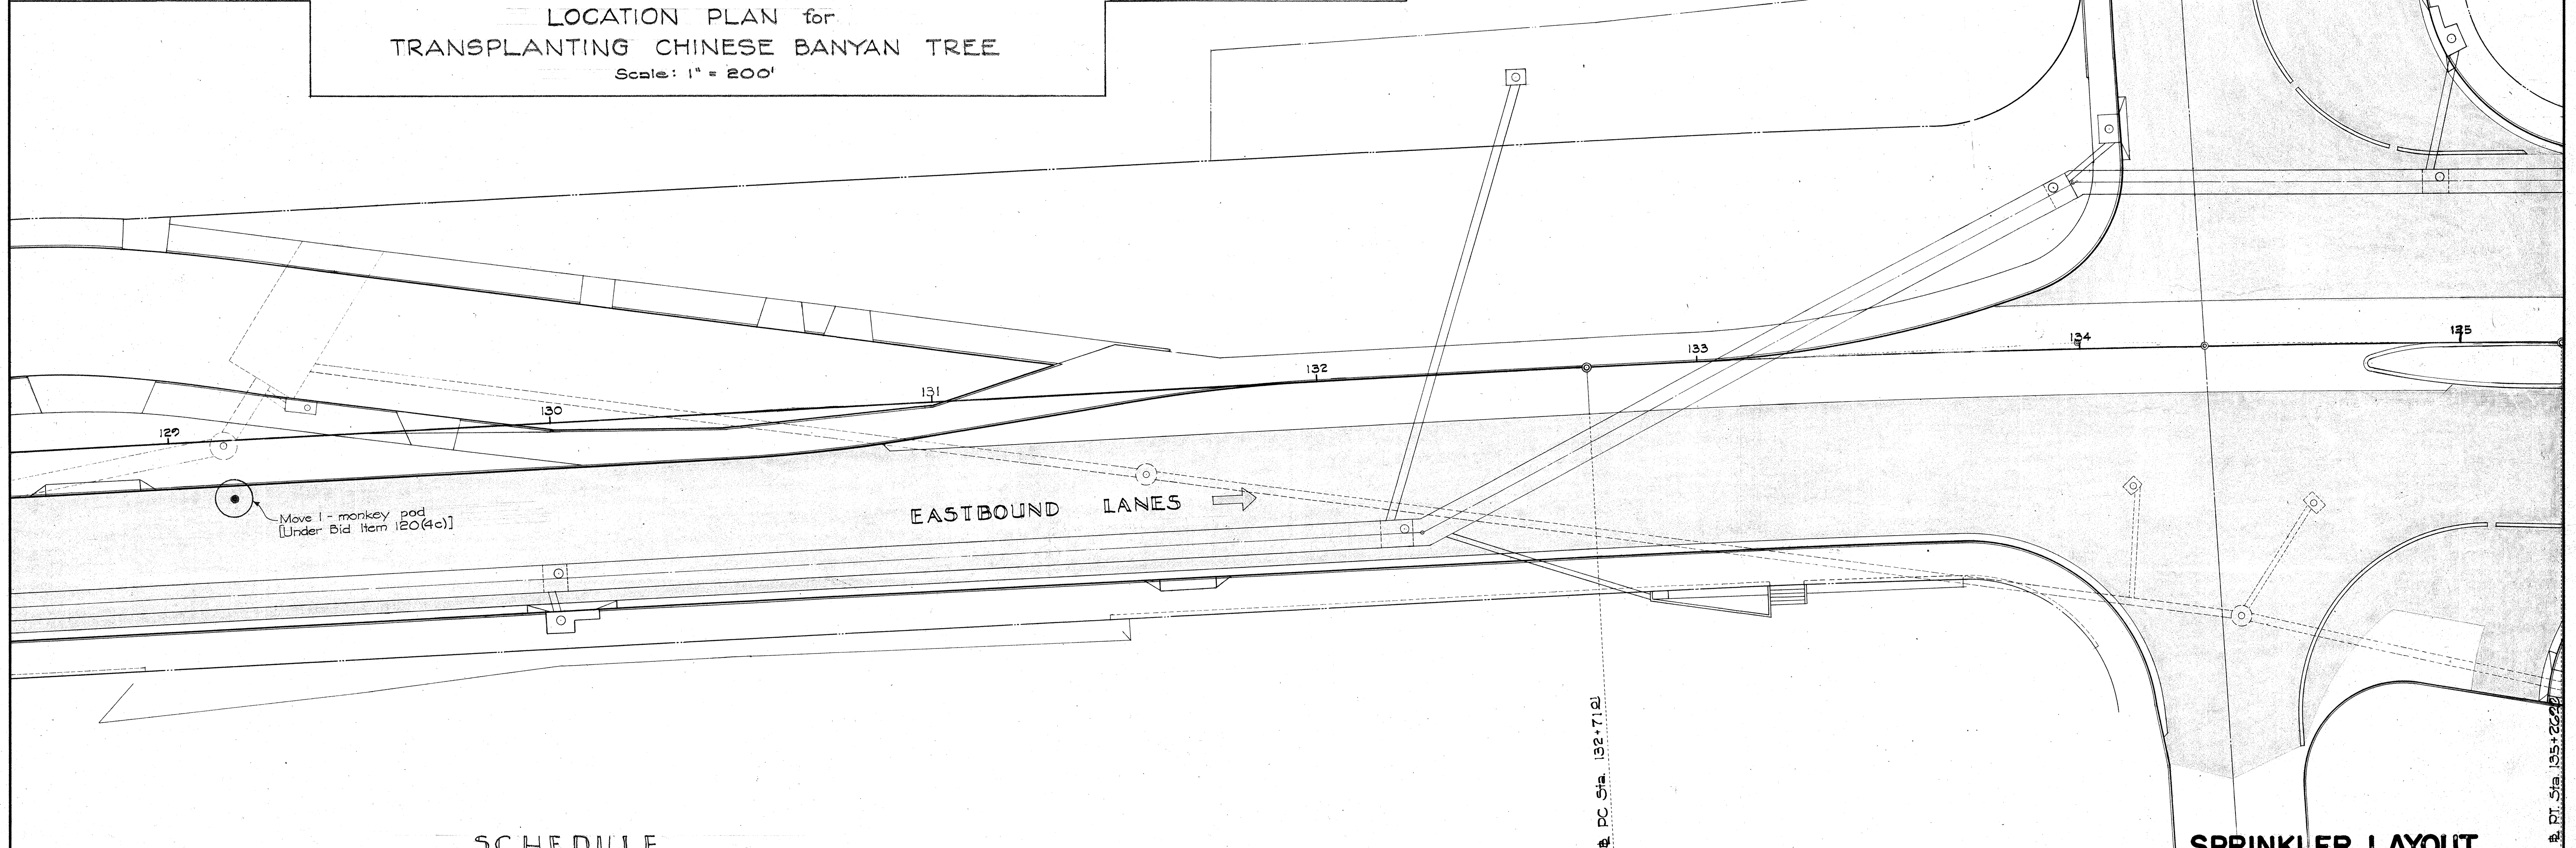




LOCATION PLAN for
TRANSPLANTING CHINESE BANYAN TREE
Scale: 1" = 200'



SCHEDULE

NO	BOTANICAL	COMMON	SPACE	SIZE	PLANT	MOVE	TRANSPLANT
3	SAManea SAMAN	MONKEY POD				1	
5	FICUS RETUSA	CHINESE BANYAN					1

SPRINKLER LAYOUT

TERRITORIAL HIGHWAY DEPARTMENT
TERRITORY OF HAWAII

LANDSCAPE PLAN
VINEYARD THOROUGHFARE
NUUANU AVE. TO LUSITANA ST.
PROJECT NO F-098-1(1)
UNIT 2

Scale: 1" = 20' May 1956

SHEET NO 1 OF 4 SHEETS

GENERAL NOTES

All water service installations from main to water meter including outlet valve are to be made by the C&C Board of Water Supply and paid for by the Contractor.

Discharge piping to sprinklers including control valves shall be installed by the Contractor.

For pavement crossings, Copper Pipes of sizes shown are to be used.

All pipes in pavement area shall be placed at least 2'-0" below pavement grade.

All copper pipes shall be connected with solder type fittings of bronze casting or wrought copper. Solder type fittings and copper pipes shall be "Streamline" or approved equal.

In Water Piping Diagrams (Details 3A to 4-B inclusive) solder type fittings of "Streamline" products manufactured by Mueller Brass Co. and illustrated in its catalog No. 5,352 are shown. Pipes not noted "Copper" are to be Galvanized Iron Screw Pipes, and fittings not noted as "Streamline" are to be Galvanized Malleable Iron Fittings.

After complete installation of the sprinkler system, each sprinkler head shall be adjusted to the satisfaction of the Engineer.

Unless otherwise stipulated or directed by the Engineer, feeder lines shall be located 12" from its E. to the back of conc. curb at the median strip and the shoulder.

DETAIL 2-A

2 1/2" SERVICE AND METER INSTALLATION INCLUDING OUTLET VALVE BY E.A.I.S. AND PAID FOR BY CONTRACTOR. (See WATER SYSTEM PLAN - SHT. NO. 5790.28)

WESTBOUND LANES DETAIL 2-A

EASTBOUND LANES

NOTE

Transplanting of 16 coconut trees shall be paid for under Bid Item 120(4).

SCHEDULE

NO	BOTANICAL	COMMON	SPACE	SIZE	PLANT	MOVE	TRANSPLANT
2	COCOS-NUCIFERA	COCONUT				1	
3	SAManea-SAMAN	MONKEY POD	As shown			2	2
GRASS-to be "CENTIPEDE" - EREMOCHLOA-OPHIUROIDES							

LEGEND

- Type III Meter Box
- × Angle Control Valve
- Outlet Valve
- Full Circle Sprinkler Head Thompson No.171-B
- Half Circle Sprinkler Head Thompson No.176-2
- Quarter Circle Sprinkler Head Thompson No.176 1/4-2

SPRINKLER LAYOUT

TERRITORIAL HIGHWAY DEPARTMENT
TERRITORY OF HAWAII

LANDSCAPE PLAN
VINEYARD THOROUGHFARE
NUUANU AVE. TO LUSITANA ST.
PROJECT NO F-098-1(1)
UNIT 2

Scale: 1"=20'







May 1956

SHEET NO 2 OF 4 SHEETS

No As-Built Changes on this Sheet.

5790.59

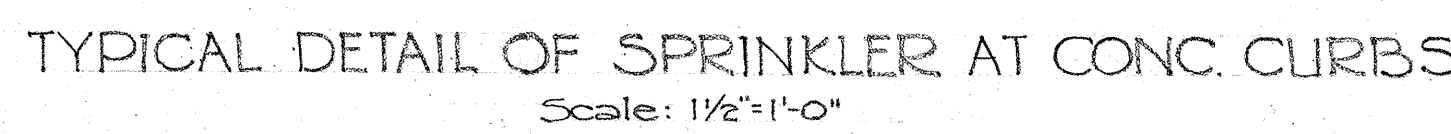  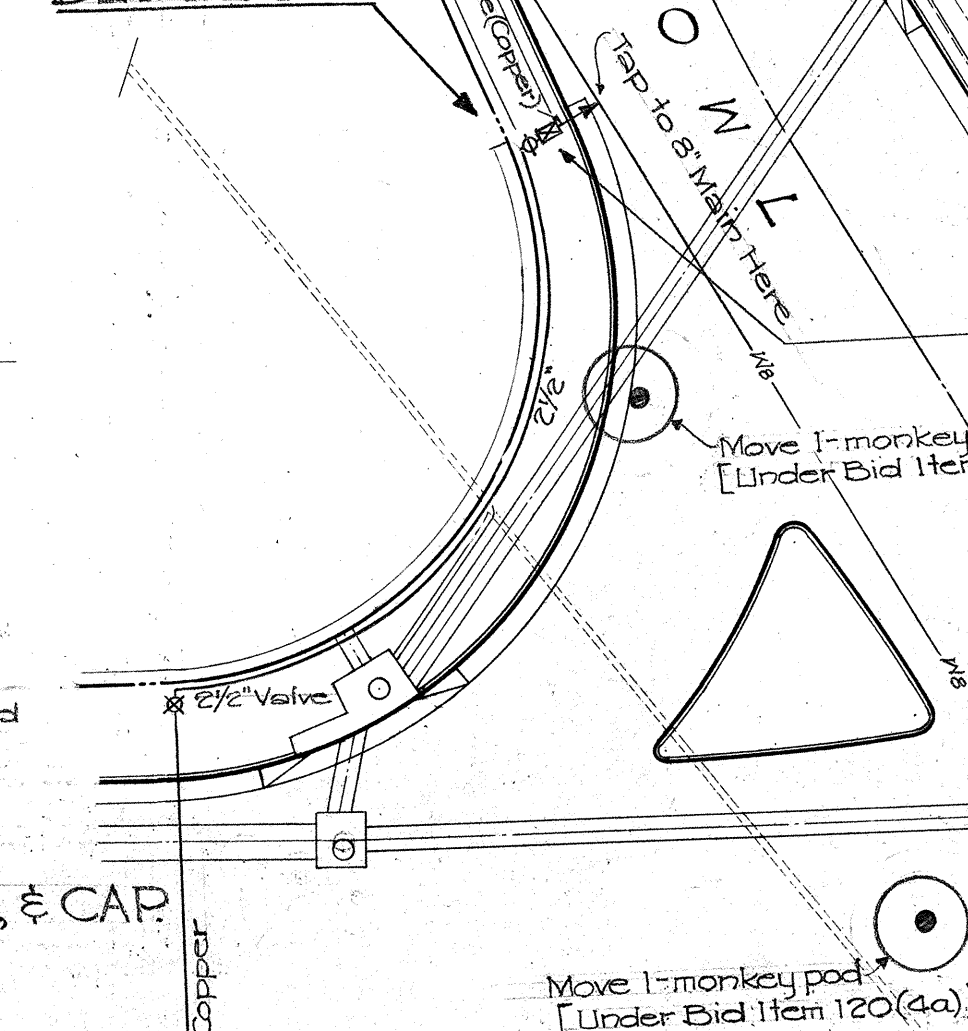  Sep't 18, 195

$$-c + 147 + 1232$$


GRASS-to be "CENTIPEDE" - EREMOCHLOA-OPHIUROIDES



2 1/2" SERVICE AND METER INSTALLATION INCLUDING
OUTLET VALVE BY BWS AND PAID FOR BY CONTRACTOR
(SEE WATER SYSTEM PLAN - Sht. No. 5790.28)

PROJECT NO F-098-1(1)

UNIT 2

Scale: 1" = 20' May

SHEET No 3 OF 4 SHEETS

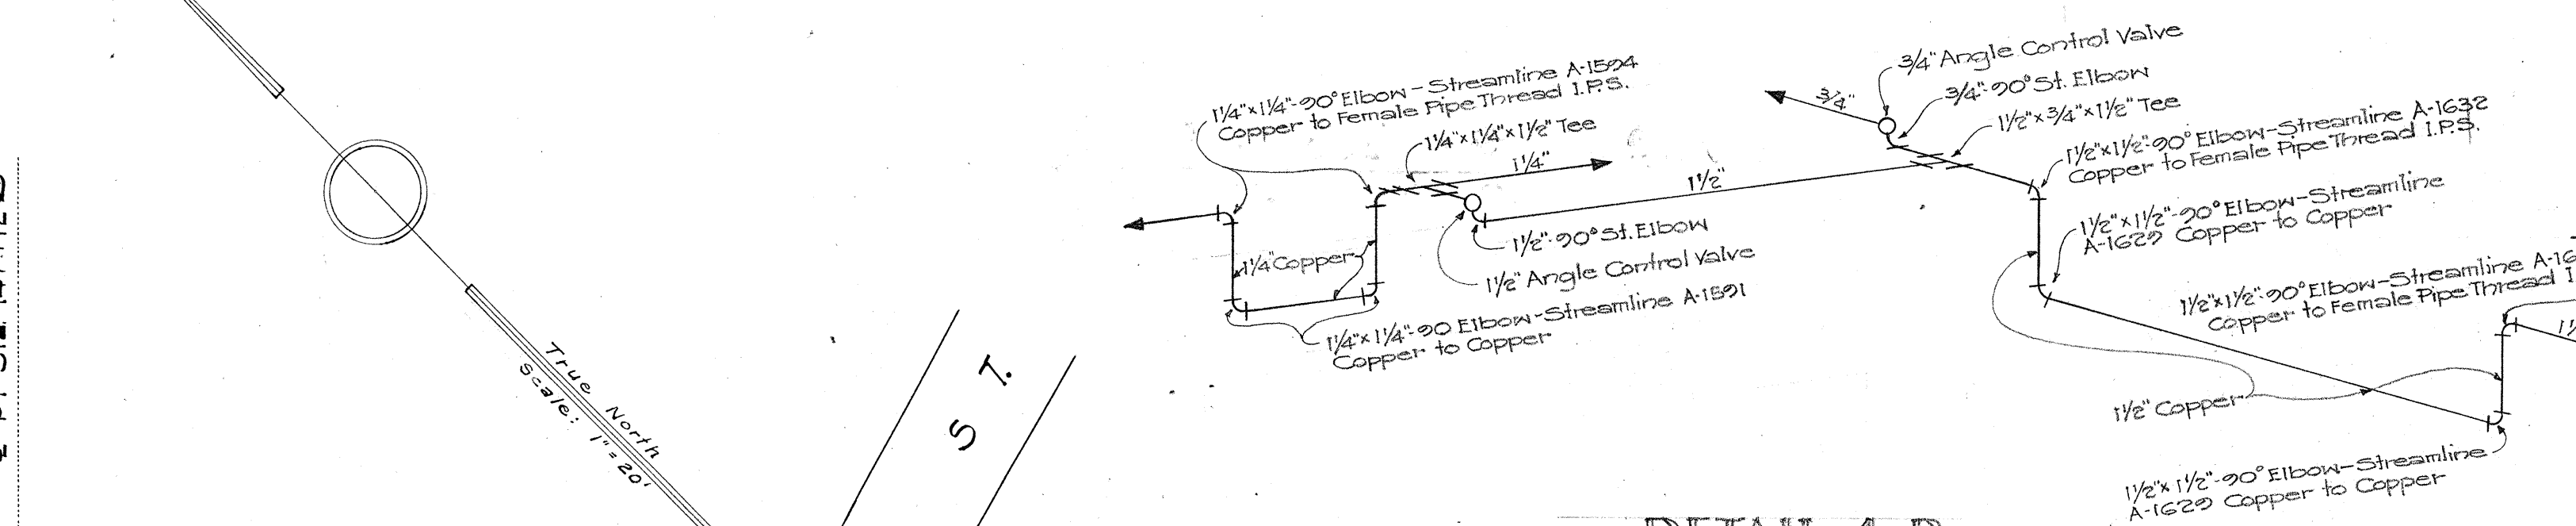
9000

2004.600

No As-Built Changes on this Sheet.

5790.60


PT Sta 147+12.32



END PROJECT NO F-098-1(1) UNIT 2
STA. 151+75

WESTBOUND LANES

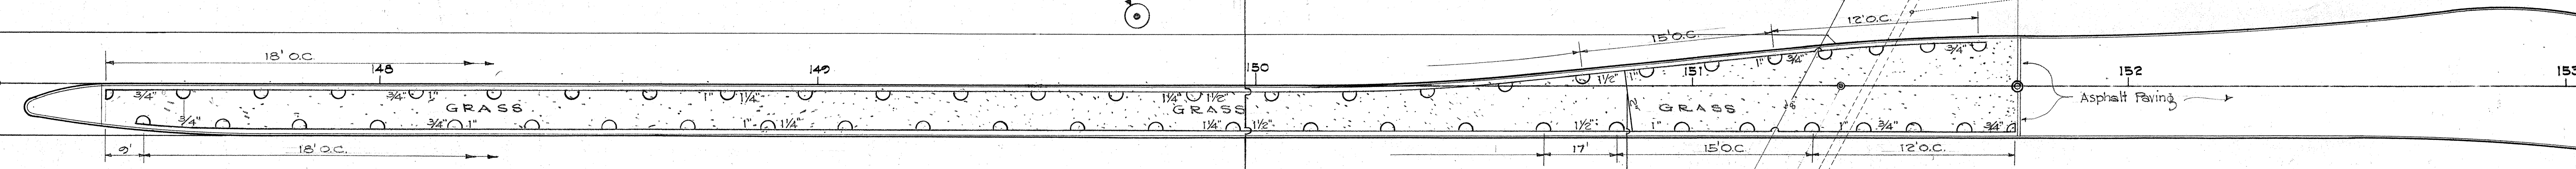
EASTBOUND LANES



Move 1-Chinese Banyan
[Under Bid Item 120(4b)]
(for location of this tree to be
transplanted, see Sht. No. 5790.58)

DETAIL 4-A

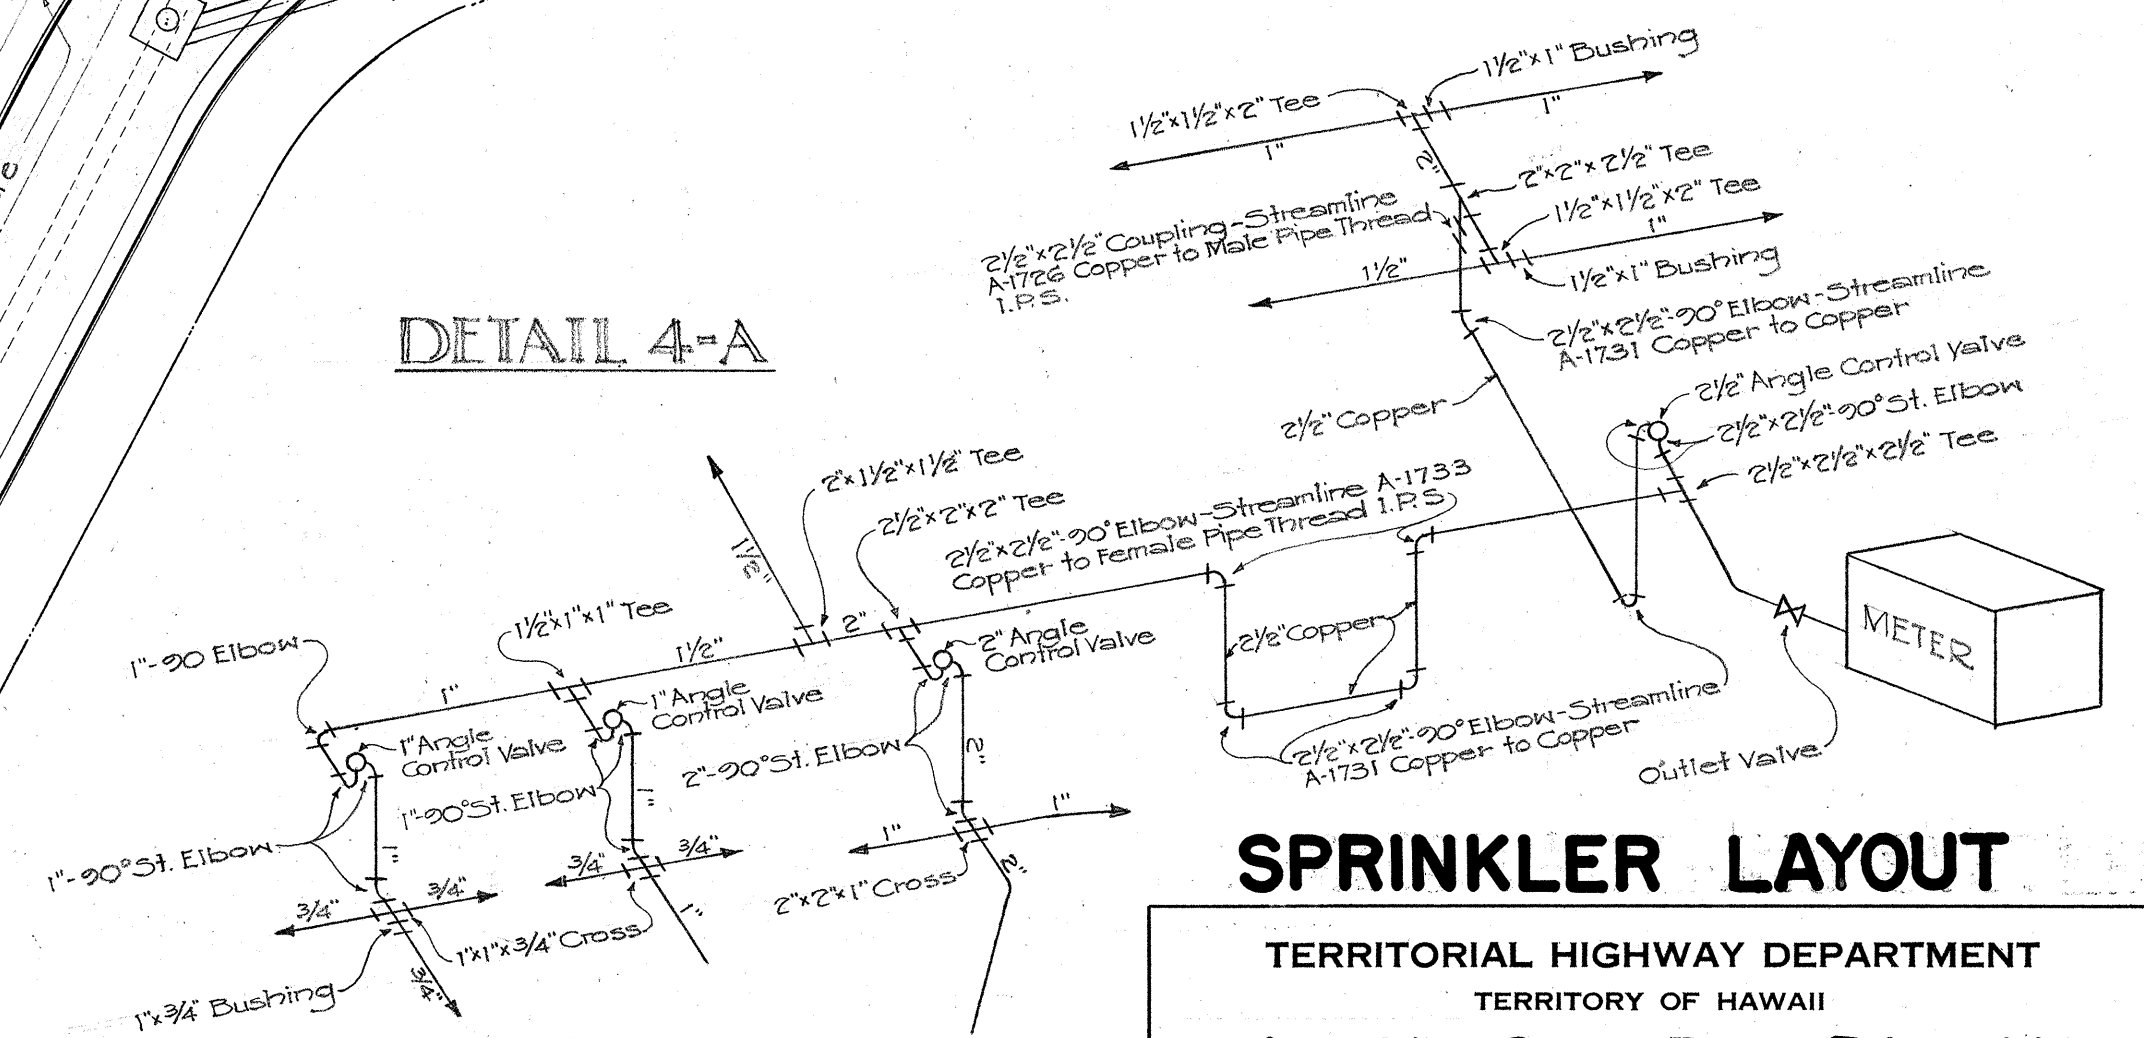2 1/2\"/>



SCHEDULE

NO	BOTANICAL	COMMON	SPACE	SIZE	PLANT	MOVE	TRANSPLANT
1	HIBISCUS-ROSA-SINENSIS	COMMON-SINGLE-RED	1' Apart	1 Gal. Can	571		
2	COCOS NUCIFERA	COCONUT				1	
4	CASSIA FISTULA	GOLDEN SHOWERS	As shown	1 gal. Can	7		
5	FICUS RETUSA	CHINESE BANYAN				1	

GRASS- to be "CENTIPEDE" ~ EREMOCHLOA-OPHIUROIDES

SPRINKLER LAYOUT

TERRITORIAL HIGHWAY DEPARTMENT
TERRITORY OF HAWAII
LANDSCAPE PLAN
VINEYARD THOROUGHFARE
NUUANU AVE. TO LUSITANA ST.
PROJECT NO F-098-1(1)
UNIT 2
Scale: 1"=20'
May 1956
SHEET NO 4 OF 4 SHEETS

No As-Built Changes on this Sheet.

5790.61

DESIGNED BY: S.E.C.
DRAWN BY: S.E.C.
CHECKED BY: S.E.C.
NOTE BOOK: S.E.C.
No.: