

INDEX TO DRAWINGS	
SHEET NO.	DESCRIPTION
1	Title Sheet
2-4	Typical Sections
5-7	Plan and Profile
8-13	Detail Plan of Roadway
14-20	R/W and Miscellaneous Details
21-26	Utilities and Sewer Standard Details
27-31	Water System and C & C Std Details
32-35	Underground Facilities for Highway
	Lighting System
36	Underground Facilities for Traffic
	Signal System
37-38	Traffic Signs and Pav't Markings
39-50	Retaining Walls and Drainage Structures
51-57	Pedestrian Overcrossing
58-61	Landscape Plans and Sprinkler Layout
62-70	Cross Sections

TERRITORY OF HAWAII
TERRITORIAL HIGHWAY DEPARTMENT
HONOLULU, OAHU, T. H.

PLANS OF
VINEYARD THOROUGHFARE
FEDERAL AID PROJECT NO. F-098-1(I) UNIT 2
DISTRICT OF HONOLULU
ISLAND OF OAHU

SCALE

PLAN

1" = 50'

PROFILE



HOR.....1" = 50'

VER.....1" = 5'

CROSS SECTION.....

HOR.....1" = 10'

VER.....1" = 5'

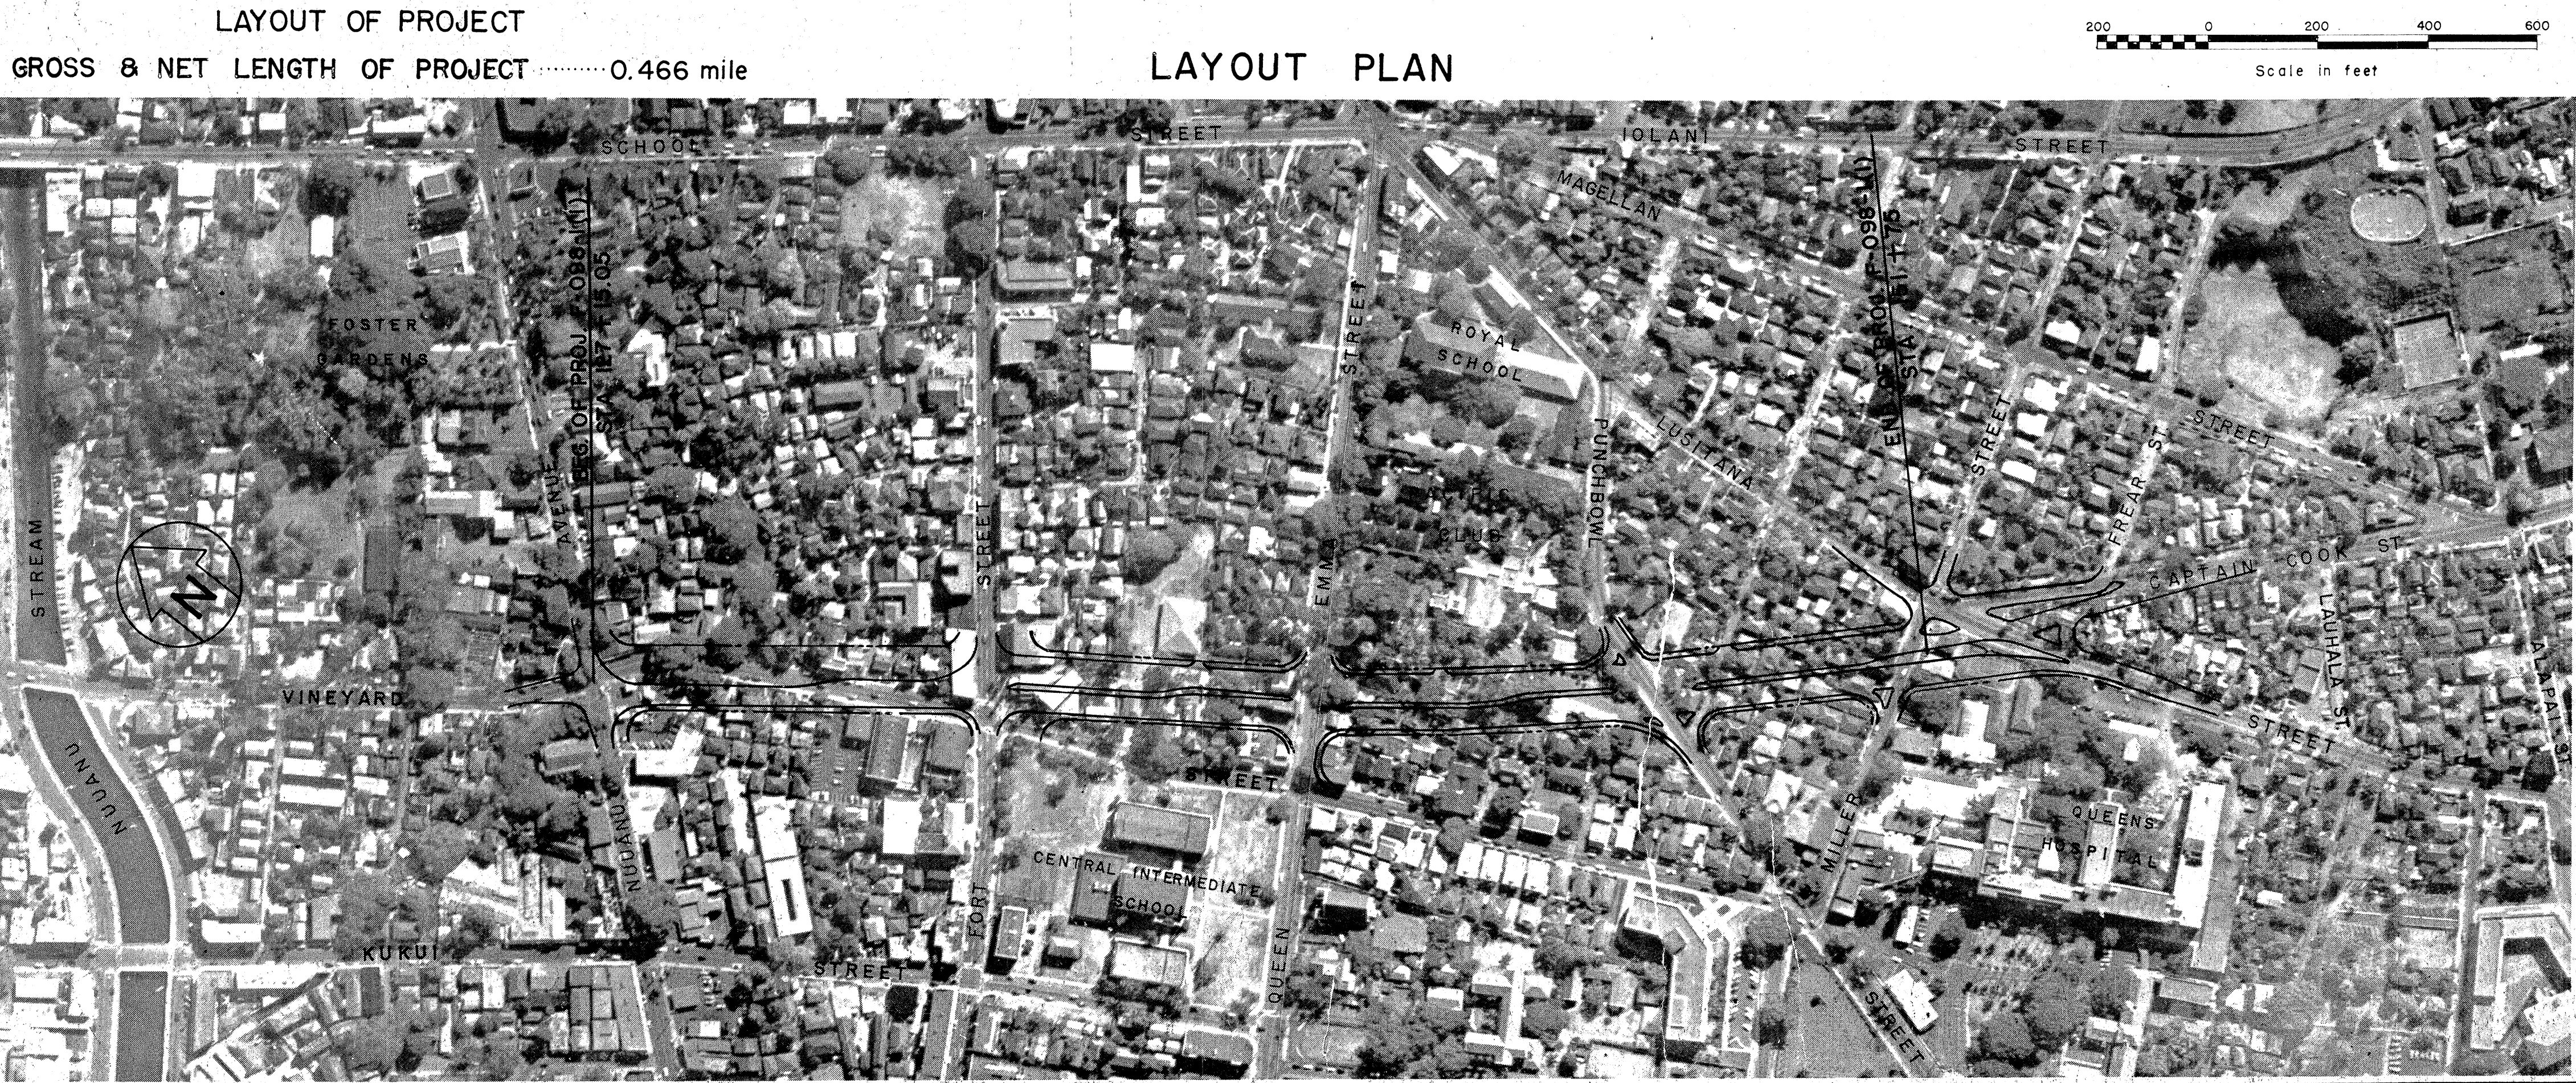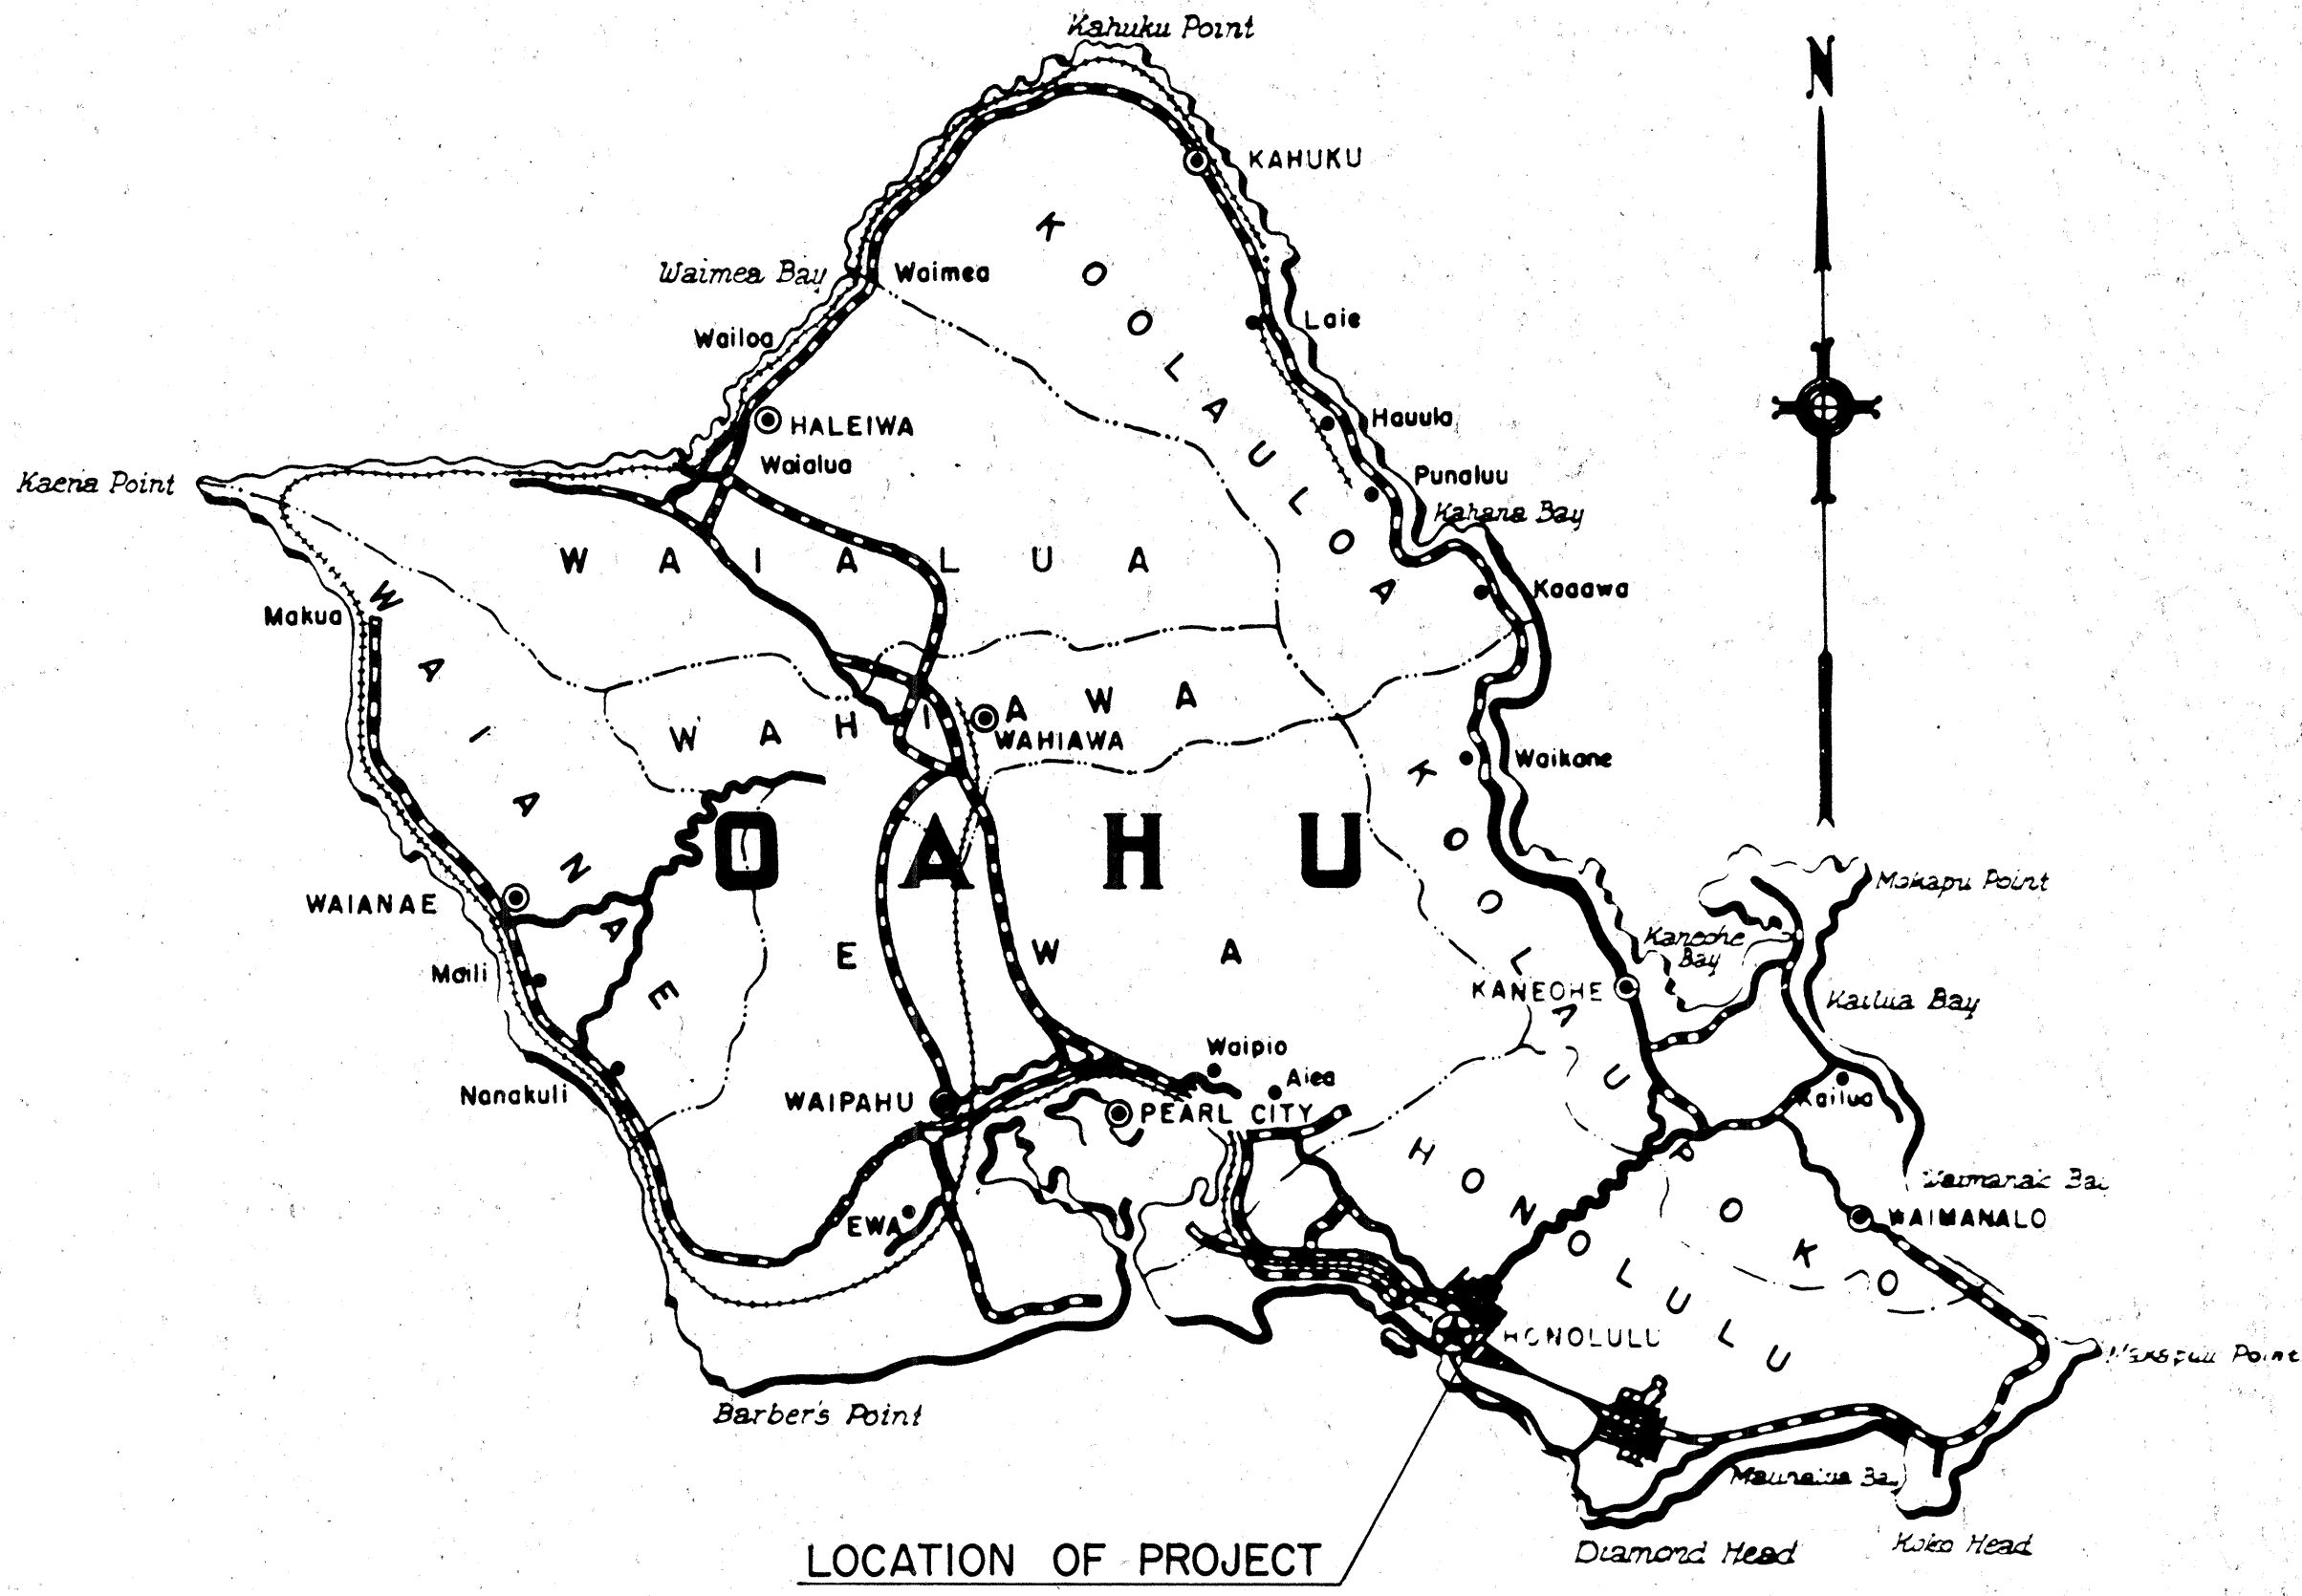

"AS BUILT" PLANS

NOTE: ALL CHANGES MADE DURING CONSTRUCTION HAVE BEEN NOTED IN RED ON THESE TRACINGS AND CHECKED BY:

Charles L. Schuster
DISTRICT ENGINEER

12/16/59
DATE

APPROVED: *Ben E. Rutter*
TERRITORIAL HIGHWAY ENGINEER

DATE: 8/27/56

DEPARTMENT OF COMMERCE
BUREAU OF PUBLIC ROADS

APPROVED: _____
DISTRICT ENGINEER

DATE: _____

ORIGINAL PLAN
NOTED BY: _____

DATE: 7-56
DESIGNED BY: HS
DRAWN BY: HS
CHECKED BY: HS
QUANTITIES CHECKED BY: HS