

INDEX TO DRAWINGS	
SHEET NO.	DESCRIPTION
1	Title Sheet
2 - 3	Typical Sections
4 - 7	Plan and Profile
8 - 16	Detail Plan of Roadway
17	Traffic Routing Plan
18 - 29	Concrete Retaining Walls
30	Miscellaneous Details
31 - 35	Detail of Drainage Structures
36 - 42	Rehabilitation of Certain Buildings
43 - 49	Utilities - Sewer and Gas
50 - 56	Utilities - Water
57 - 68	Utilities - Electric and Telephone
69 - 73	Highway Lighting
74 - 80	Traffic Signal System (Sheet No 78 Deleted)
81 - 82	Traffic Signs and Pavement Markings
83 - 91	Landscape Plans- Sprinkler Layout
92- 102	Cross Sections
103- 115	Nuuanu Stream Bridge


TERRITORY OF HAWAII
TERRITORIAL HIGHWAY DEPARTMENT
HONOLULU, OAHU, T. H.

AS-BUILT
PLANS OF
VINEYARD THOROUGHFARE
PALAMA ST. TO FORT ST.
FEDERAL AID PROJECT NO. DF-098-1(5)


DISTRICT OF HONOLULU

ISLAND OF OAHU

SCALES			
PLAN-PROFILE	HOR.	1" = 50'	
	VER.	1" = 5'	
DETAIL PLAN		1" = 20'	
	CROSS SECTION	HOR. 1" = 10'	
		VER. 1" = 5'	

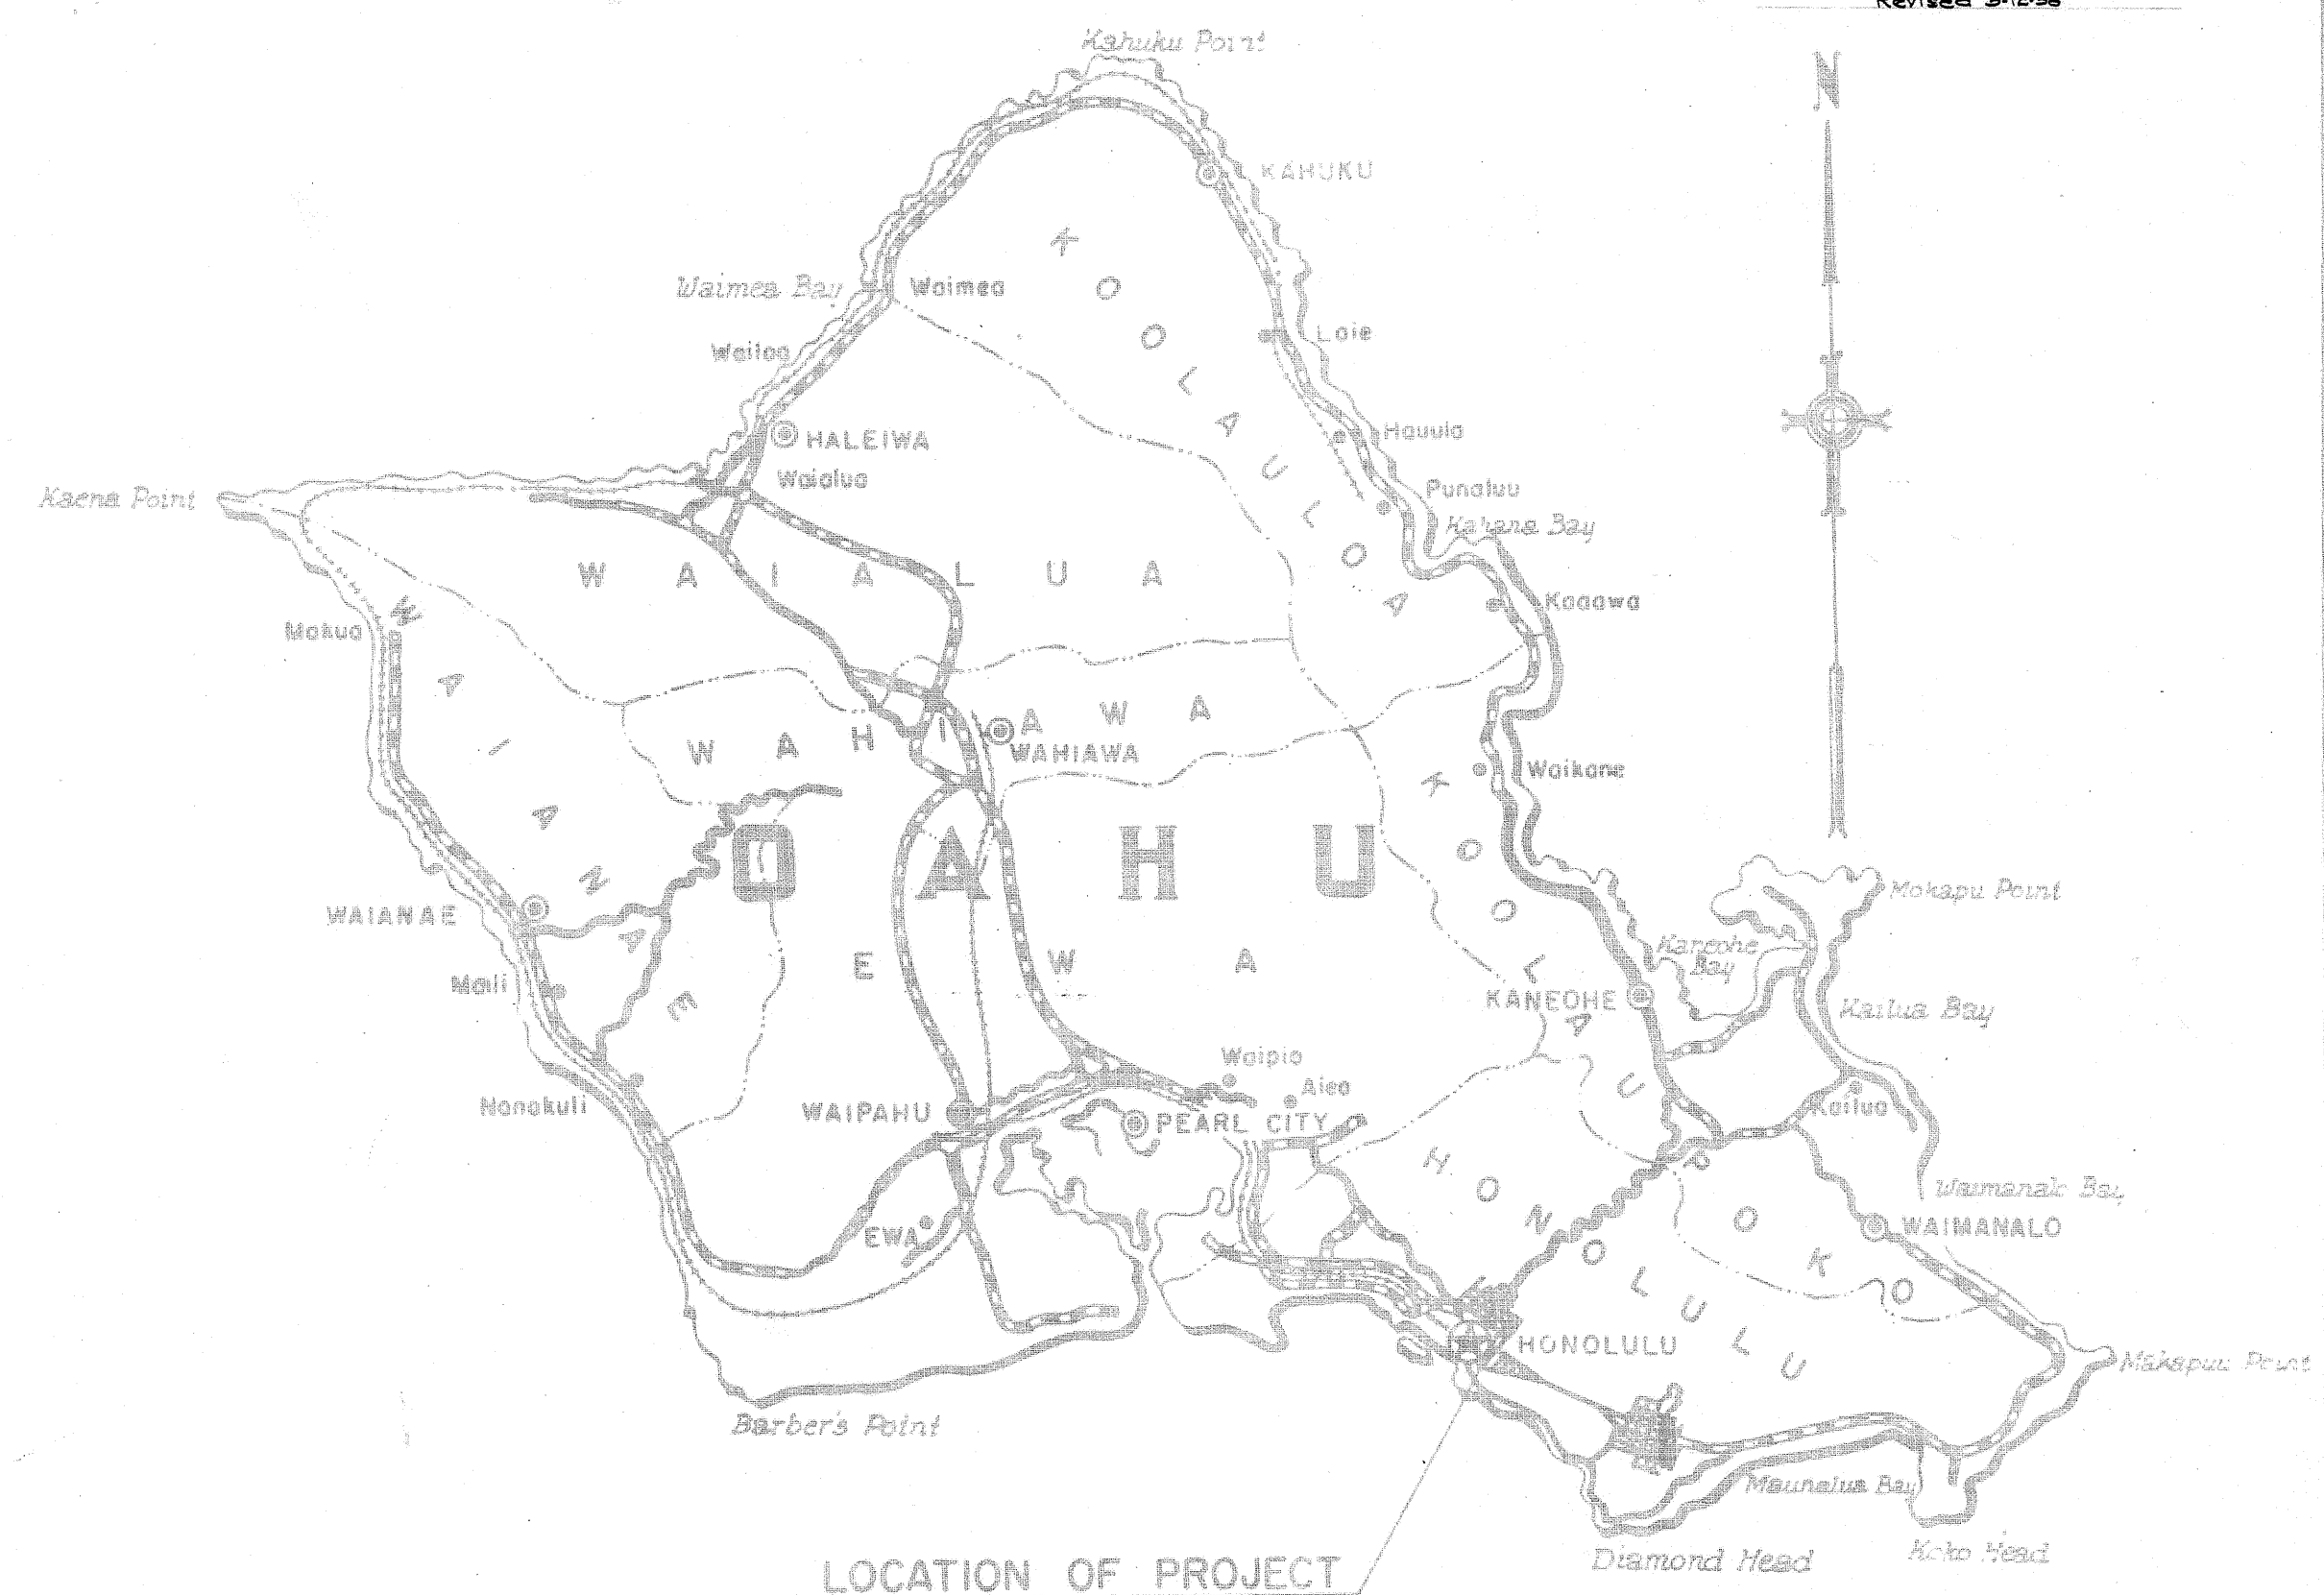

Federal Aid Projects Previously Constructed Or Under Construction

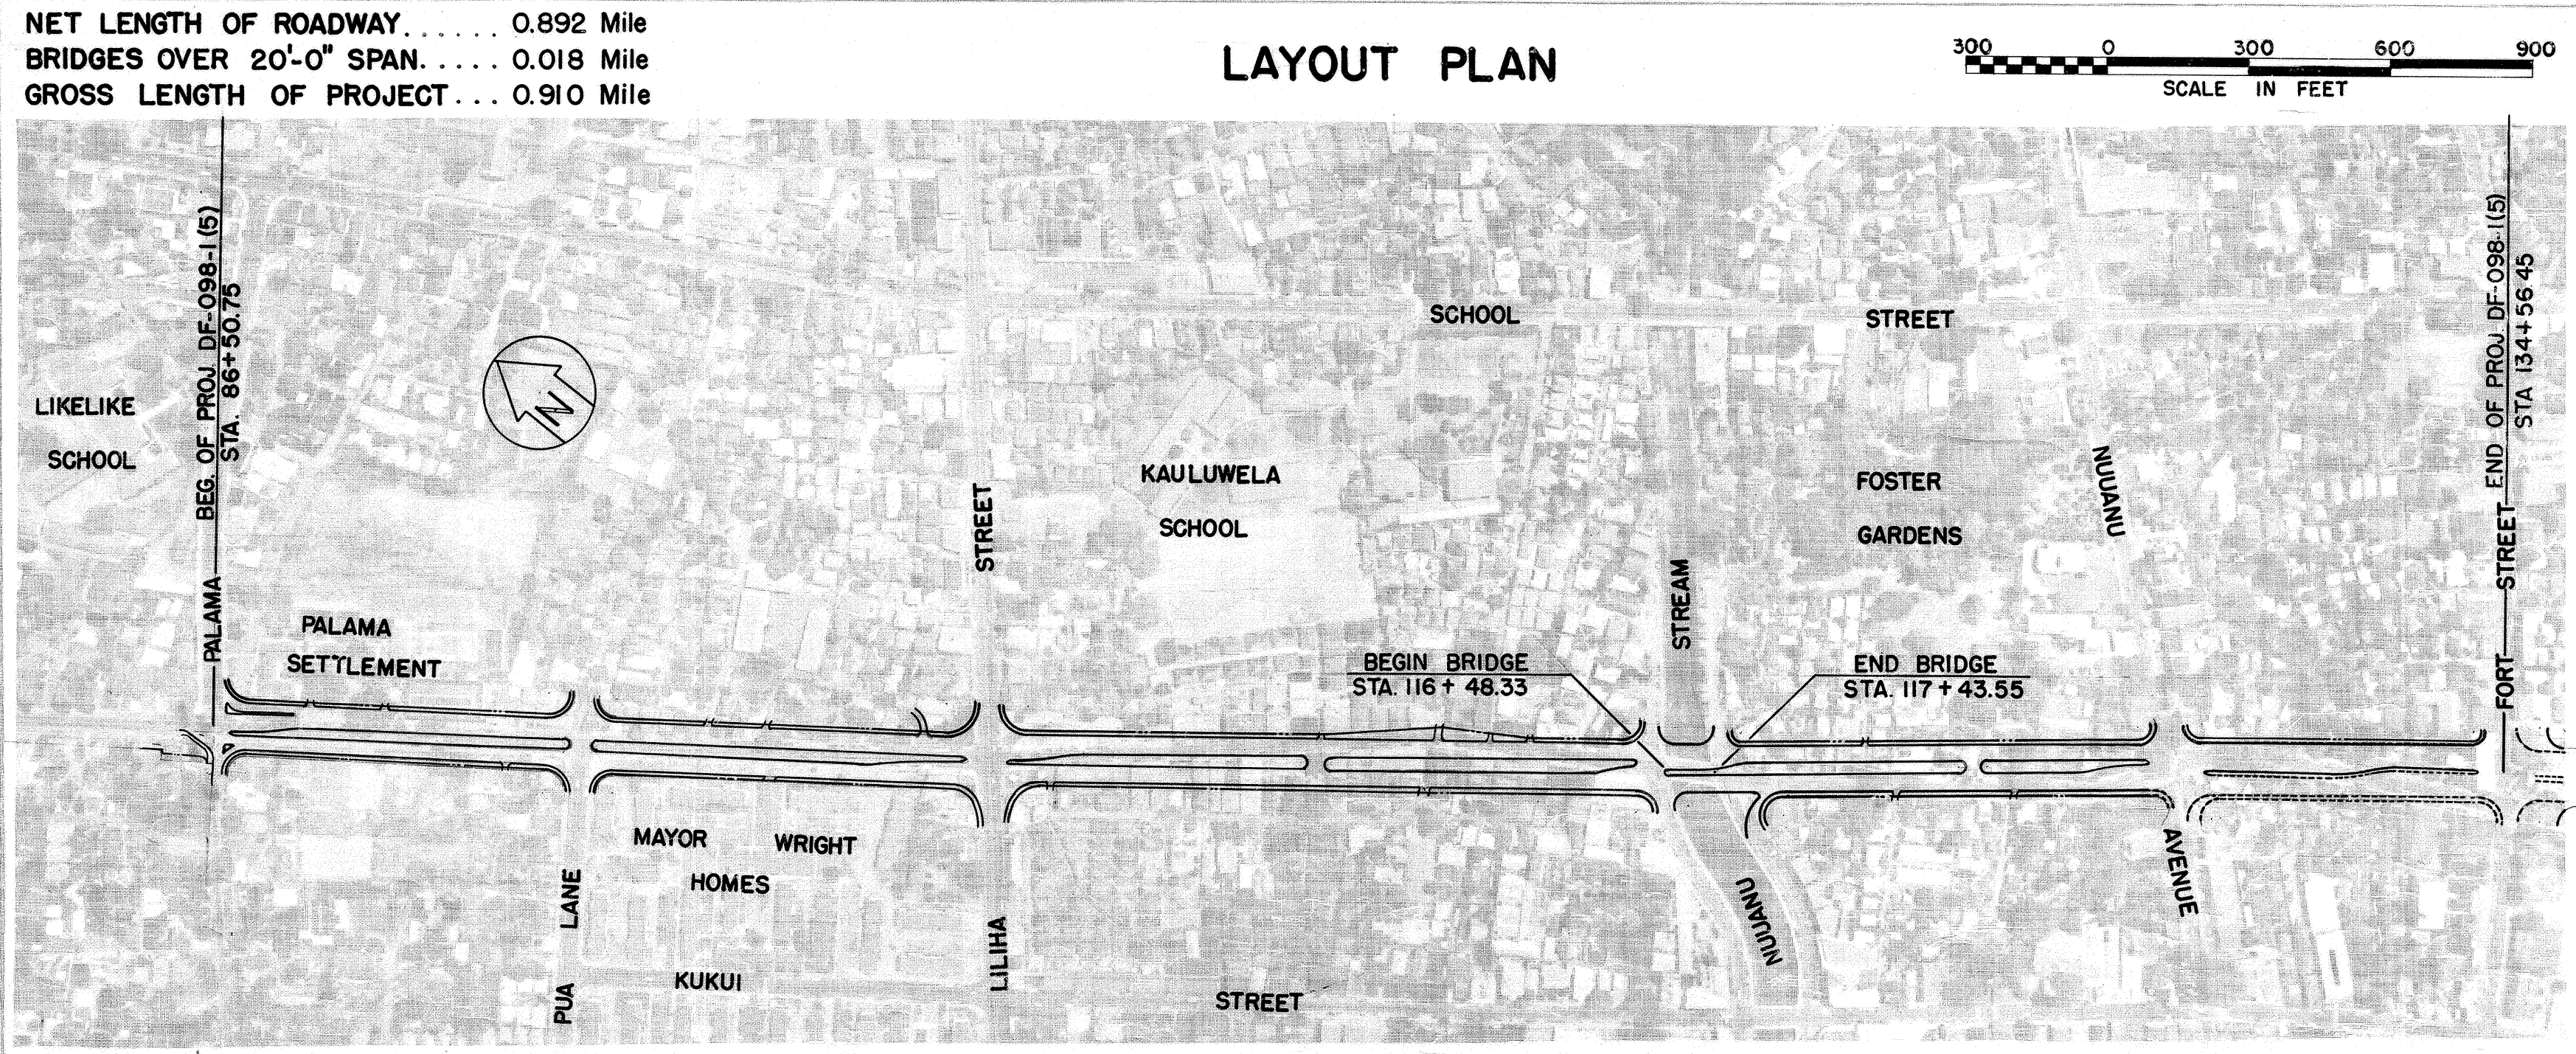

ALL CHANGES MADE DURING CONSTRUCTION

HAVE BEEN NOTED IN RED IN THESE TRACINGS

AND CHECKED BY:

B. W. Hendry

DISTRICT ENGINEER

DATE *October 21, 1961*

APPROVED: DATE *May 6, 1958*

Wm. Wachtler

TERRITORIAL HIGHWAY ENGINEER

DEPARTMENT OF COMMERCE

BUREAU OF PUBLIC ROADS

APPROVED:

DIVISION ENGINEER

DATE

5882.01