

INDEX TO DRAWINGS	
SHEET NO.	DESCRIPTION
1	TITLE SHEET
2	STANDARD PLANS SUMMARY
3	TYPICAL SECTIONS & WATER NOTES
4-7	DETAIL PLAN OF ROADWAY
①8-10	MISCELLANEOUS DETAILS
11-12	SIGNING & STRIPING PLAN
13-14	TRAFFIC CONTROL PLAN
15-16	ELECTRICAL PLAN
17	ELECTRICAL SYMBOLS & MISC. DET.
18-19	MISCELLANEOUS DETAILS
20-22	LANDSCAPE IRR. & PLANTING PLAN
23	LANDSCAPE IRRIGATION LIST, LEGEND, NOTE AND DETAILS
24	LANDSCAPE IRRIGATION PLAN
25-28	CROSS SECTIONS

Plan Sht. Nos. ①C08S-1,C08S-2,&C010S-1 are supplementary sheets to this project.
TOTAL SHEET COUNT after "AS BUILT" postings.
31 Sheets.

STATE OF HAWAII

DEPARTMENT OF TRANSPORTATION


HIGHWAYS DIVISION

"AS-BUILT"



VINEYARD - PUNCHBOWL

TRAFFIC IMPROVEMENT PROJECT

PROJECT NO. 98A-01-89

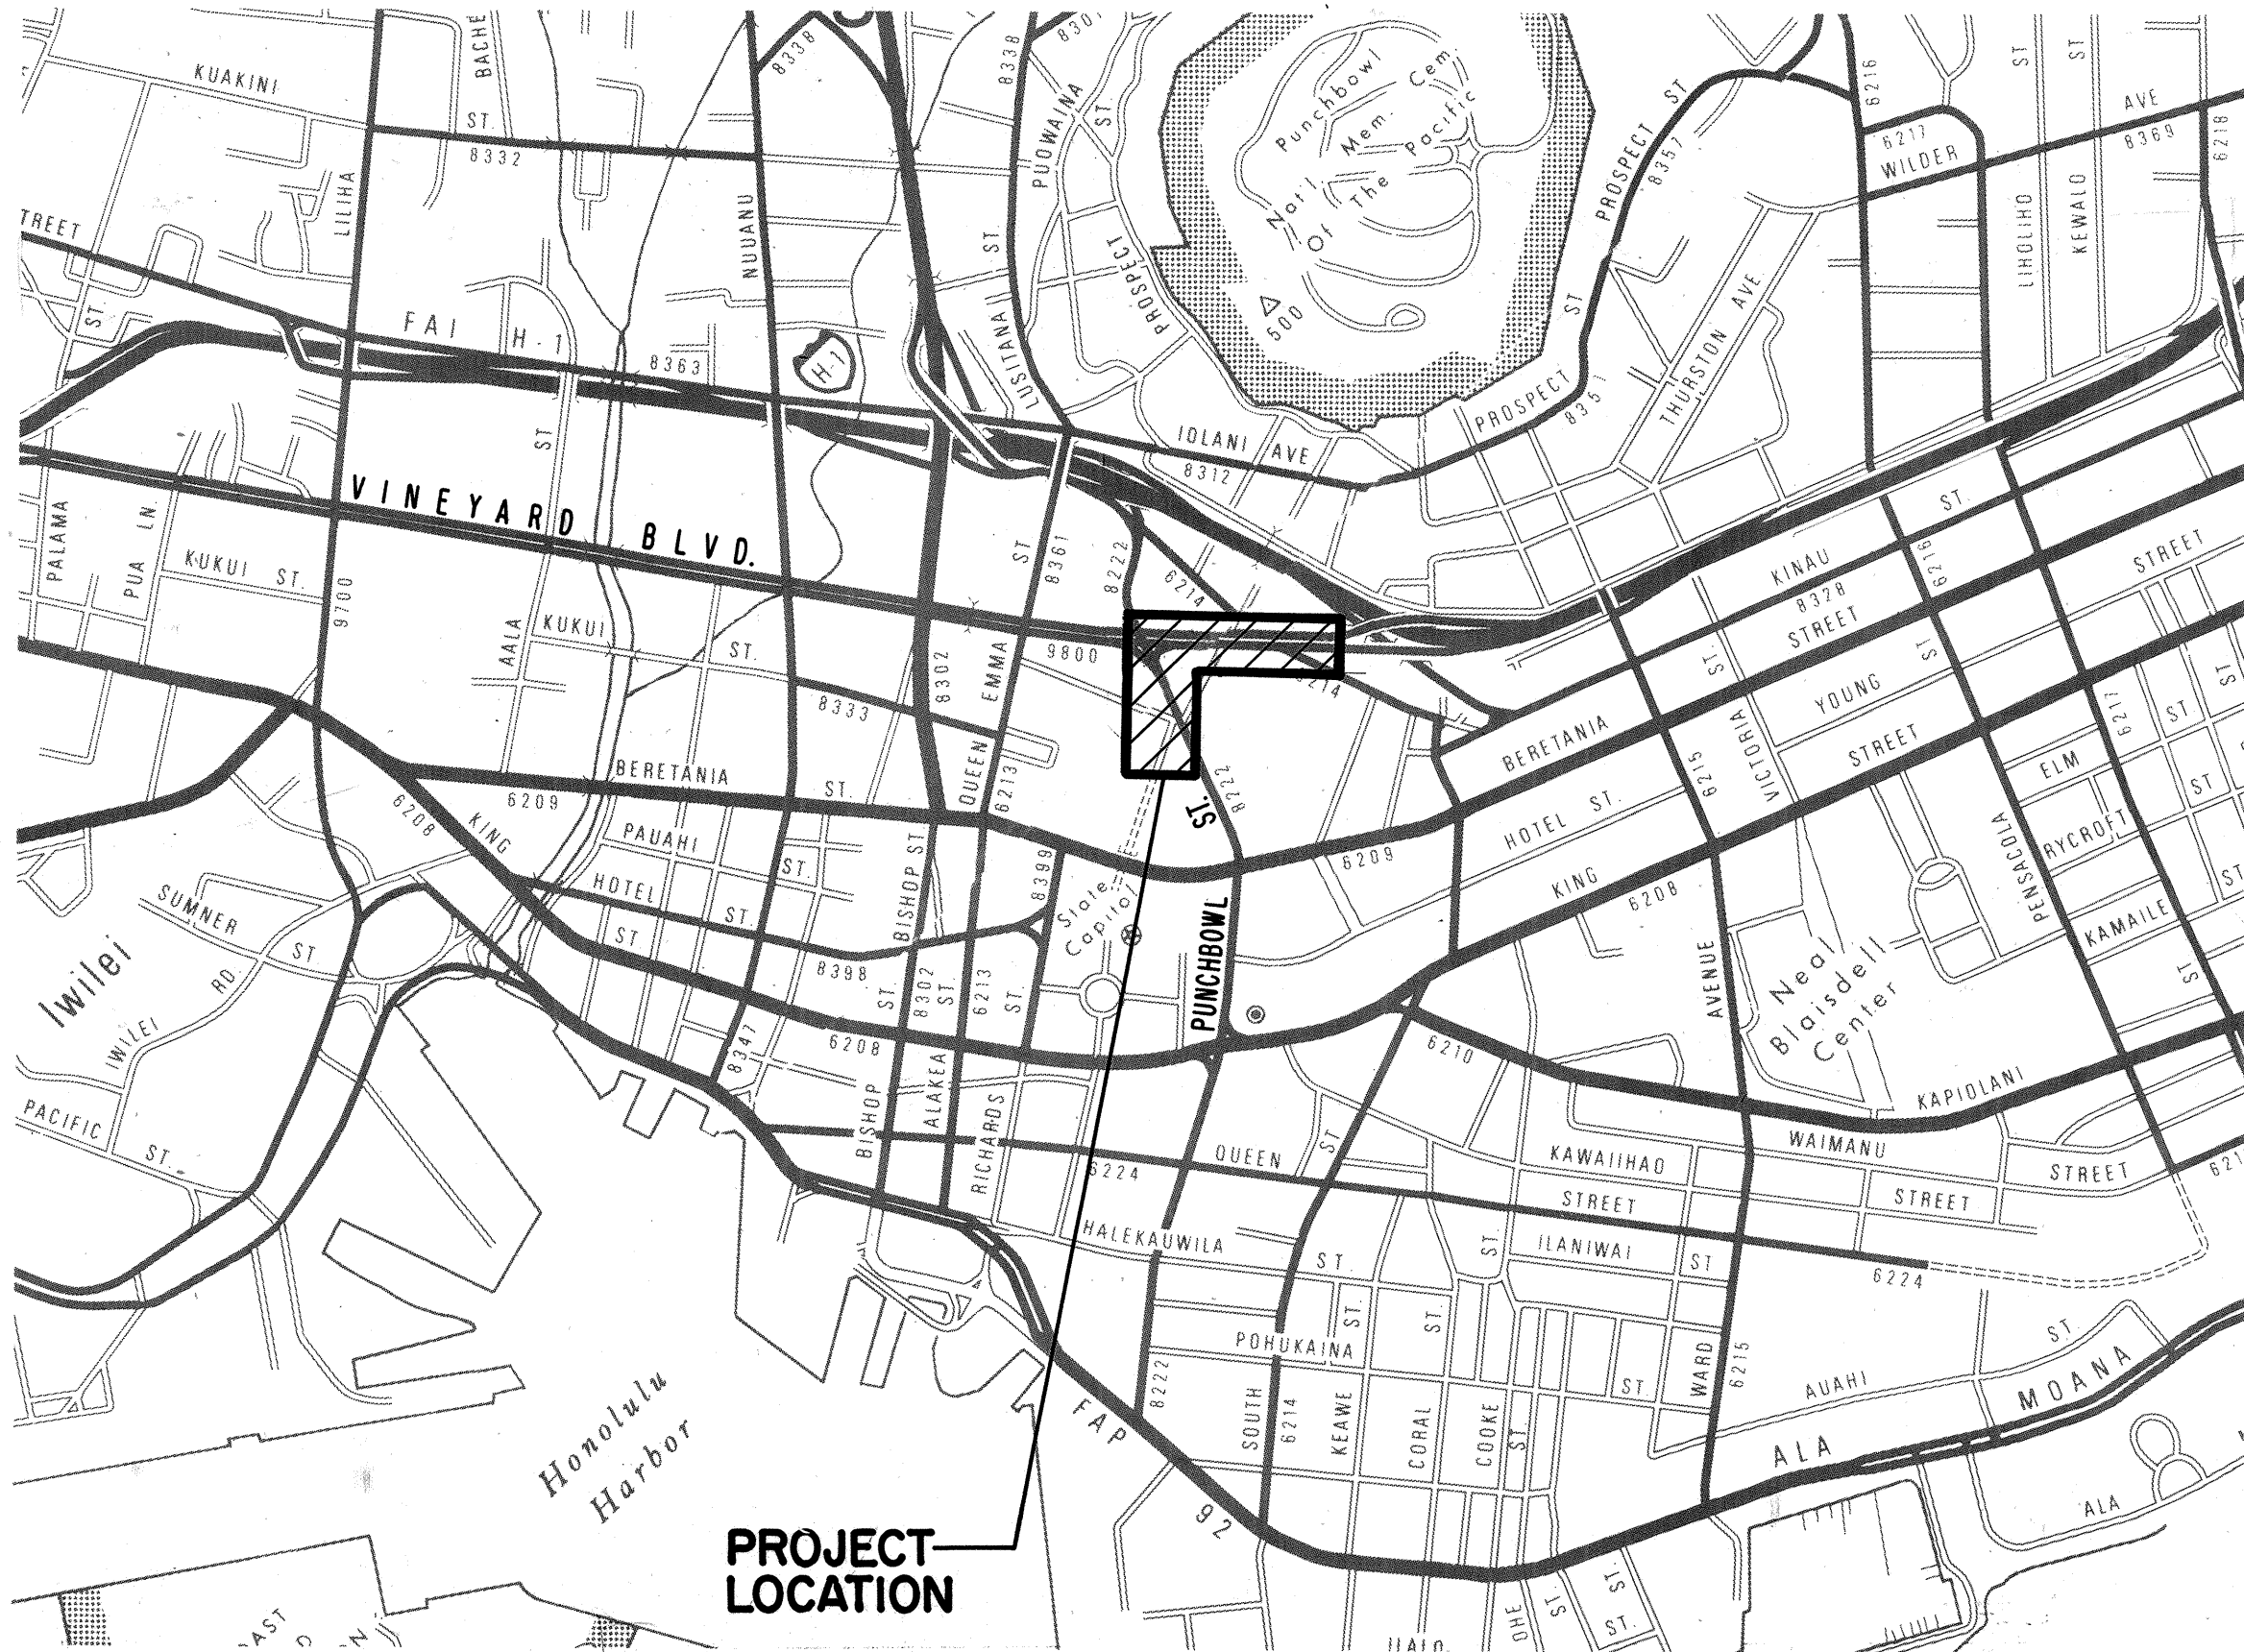

LOCATION MAP
TMK: 2-1-18, 2-1-22

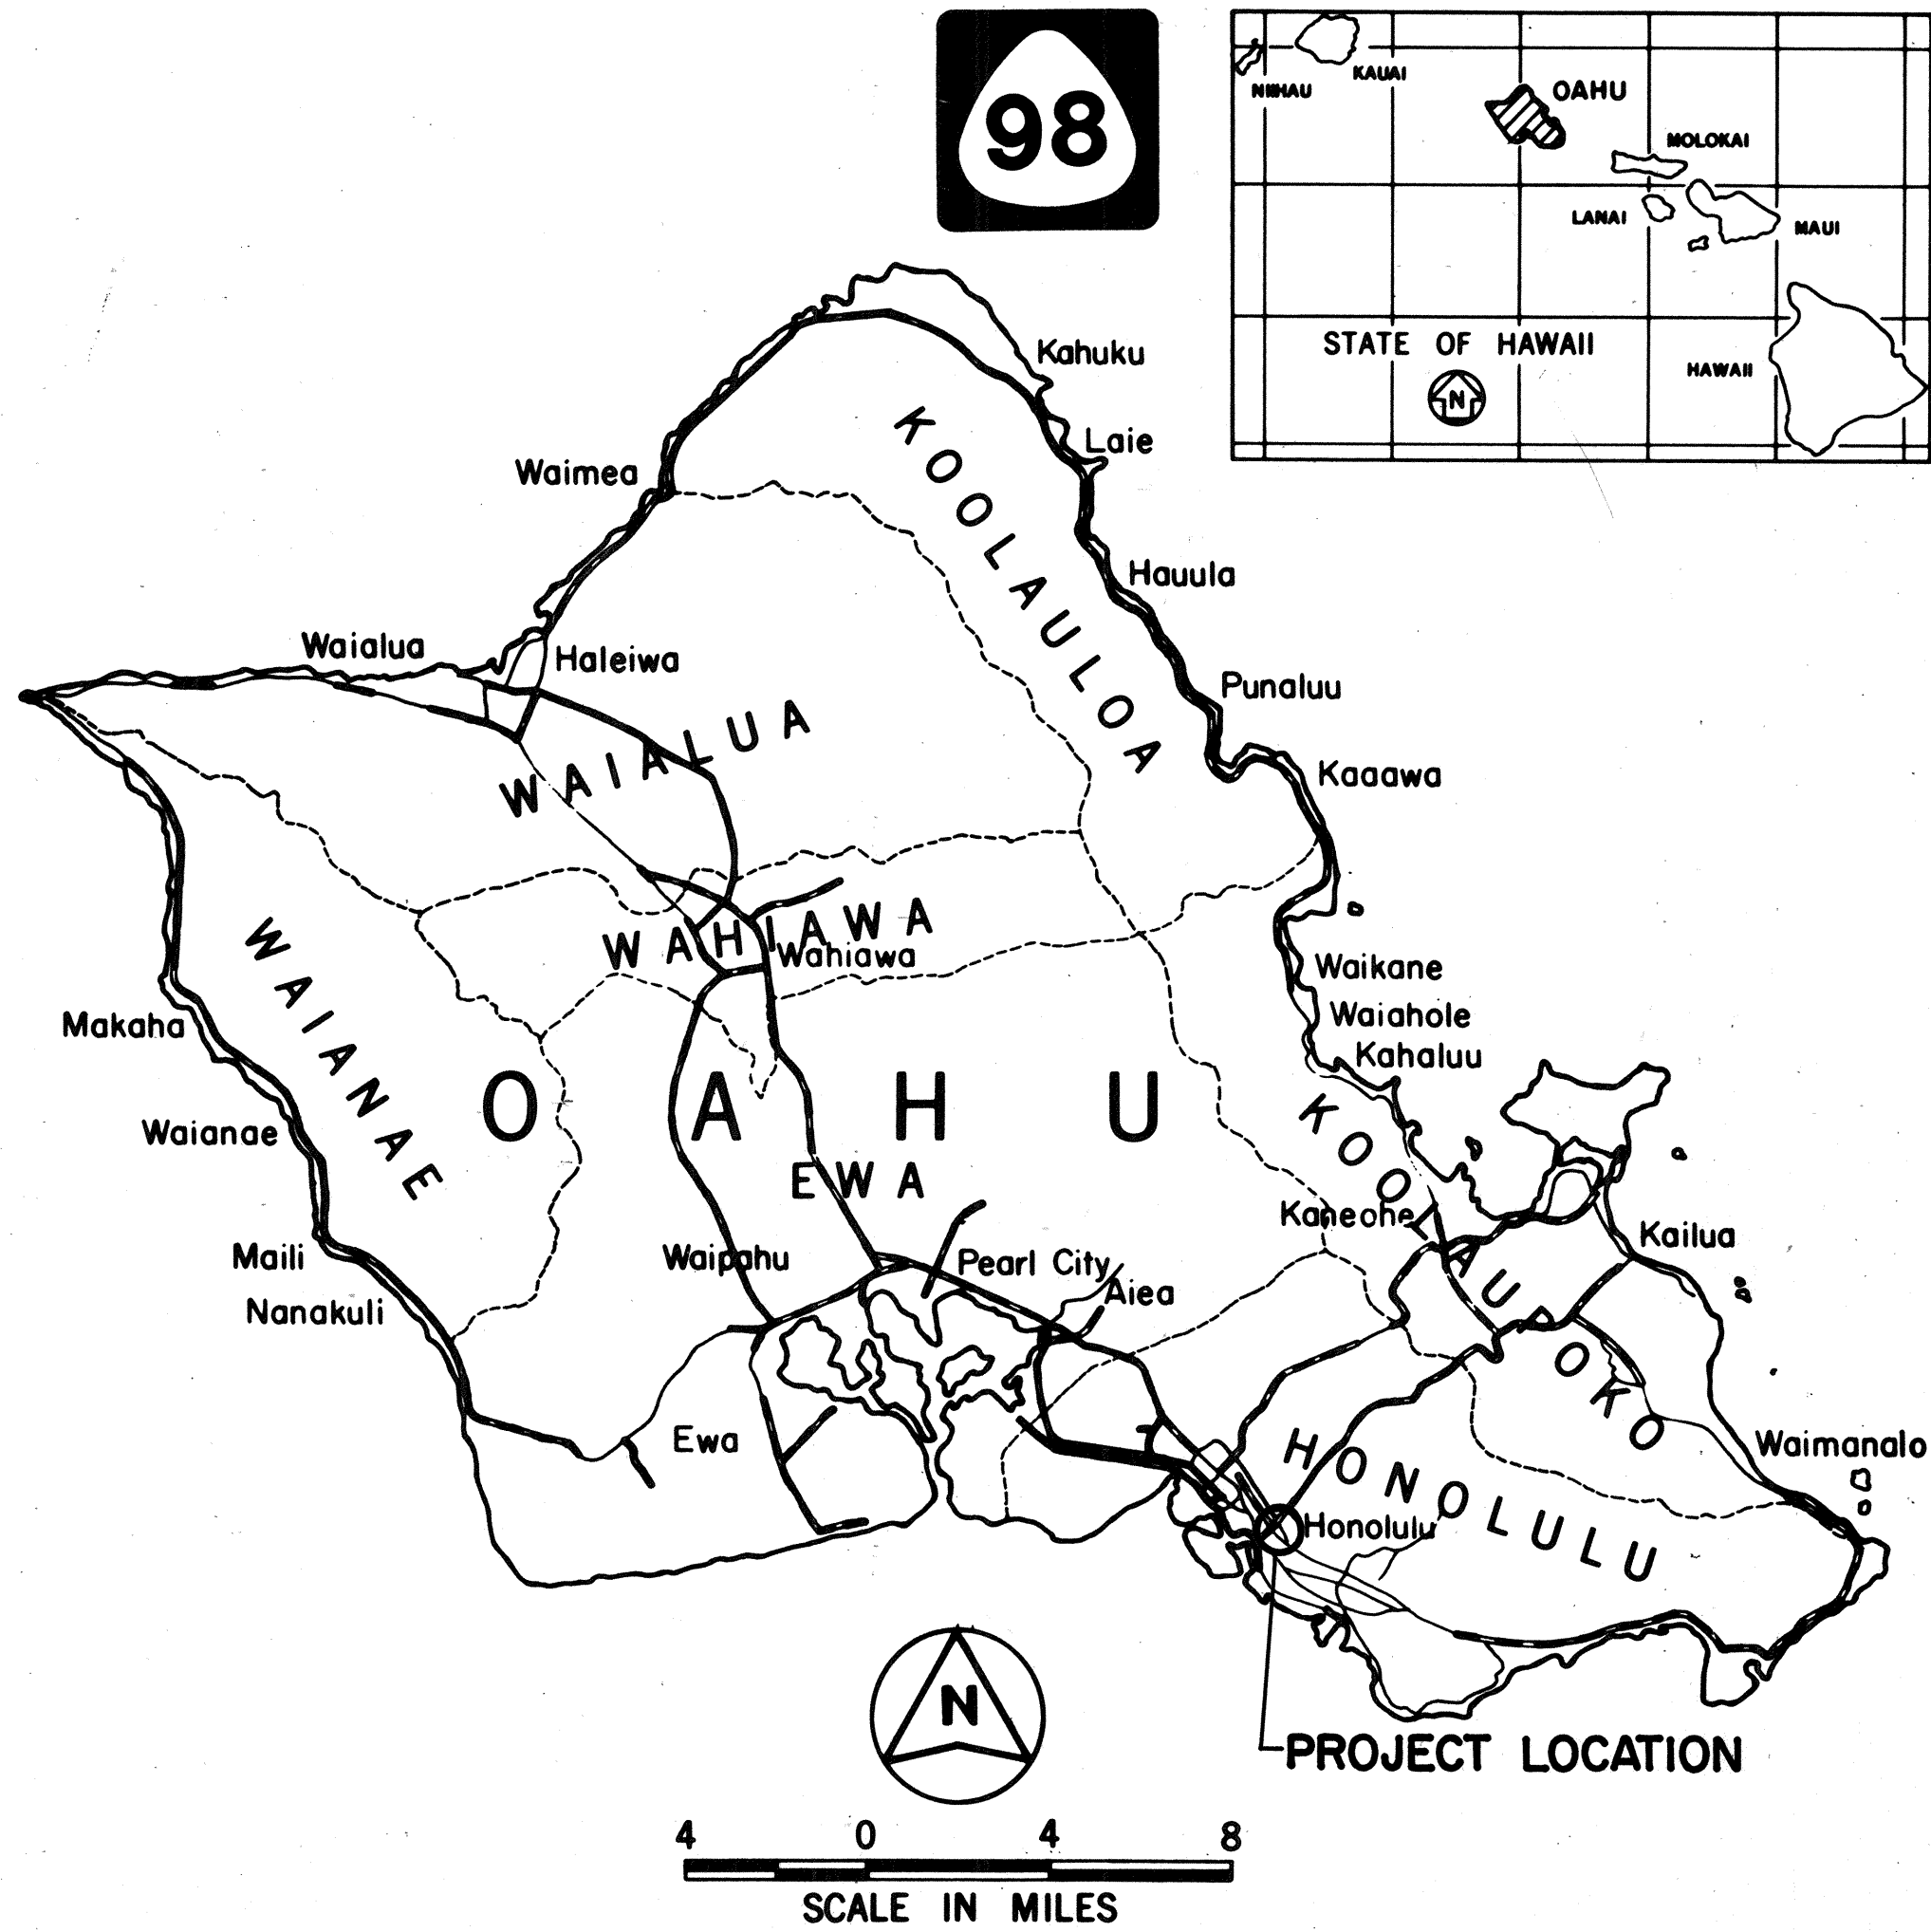 

FEDERAL AID PROJECTS PREVIOUSLY CONSTRUCTED OR UNDER CONSTRUCTION

CHANGES MADE DURING CONSTRUCTION HAVE BEEN INCORPORATED ON THESE PLANS EXCEPT CHANGES IN THE ORIGINAL THEORETICAL QUANTITIES. FOR ACTUAL QUANTITIES, REFER TO PROJECT LEDGER AND/OR COMPUTATION BOOK.

Howard C. Young
RESIDENT ENGINEER

12/9/93
DATE

APPROVED:

G. Young
DIRECTOR & CHIEF ENGINEER, DPW MF

6-20-89
DATE

DEPARTMENT OF TRANSPORTATION
STATE OF HAWAII

APPROVED:

Edward J. Jones
DIR. OF TRANSPORTATION

9/19/92
DATE