

INDEX TO DRAWINGS	
SHEET NO.	DESCRIPTION
1	TITLE SHEET
2	STANDARD PLANS SUMMARY
3	GENERAL NOTES
4	LEGEND
5-7	WATER POLLUTION & EROSION CONTROL NOTES
8	TEMPORARY WATER POLLUTION, DUST & EROSION CONTROL
9	SITE PLAN
10	CURB RAMP DETAILS
11-13	TYPICAL CURB RAMP NOTES & DETAILS
14	PEDESTRIAN PUSH BUTTON DETAILS
15	DETECTABLE WARNING DETAILS
16	PAVEMENT MARKING NOTES
17	SIGNING AND STRIPING PLAN
18	LOW SPEED DIVIDED HIGHWAY WORK ZONE SIGNING PLAN, NOTES & DETAILS
19	DEPARTMENT OF PARKS & RECREATION NOTES
20-21	TREE PROTECTION ZONE DETAIL
22	WATER AND HECO NOTES
23-24	TRAFFIC SIGNAL NOTES & PLAN
25	PROFILE DETAILS
26	TYPE II POLE & FOOTING DETAIL
27	MISC. DETAILS
28-34	TRAFFIC CONTROL NOTES & PLANS
35	ELECTRICAL SYMBOLS AND DETAILS
36-37	HECO NOTES
38-39	ELECTRICAL PLANS
40	MISCELLANEOUS DETAILS

STATE OF HAWAII

DEPARTMENT OF TRANSPORTATION

HIGHWAYS DIVISION

HONOLULU, HAWAII

PLANS FOR


VINEYARD BOULEVARD

INSTALLATION OF TRAFFIC SIGNALS AT RIVER STREET

PROJECT NO. 98A-01-15

DISTRICT OF HONOLULU



ISLAND OF OAHU

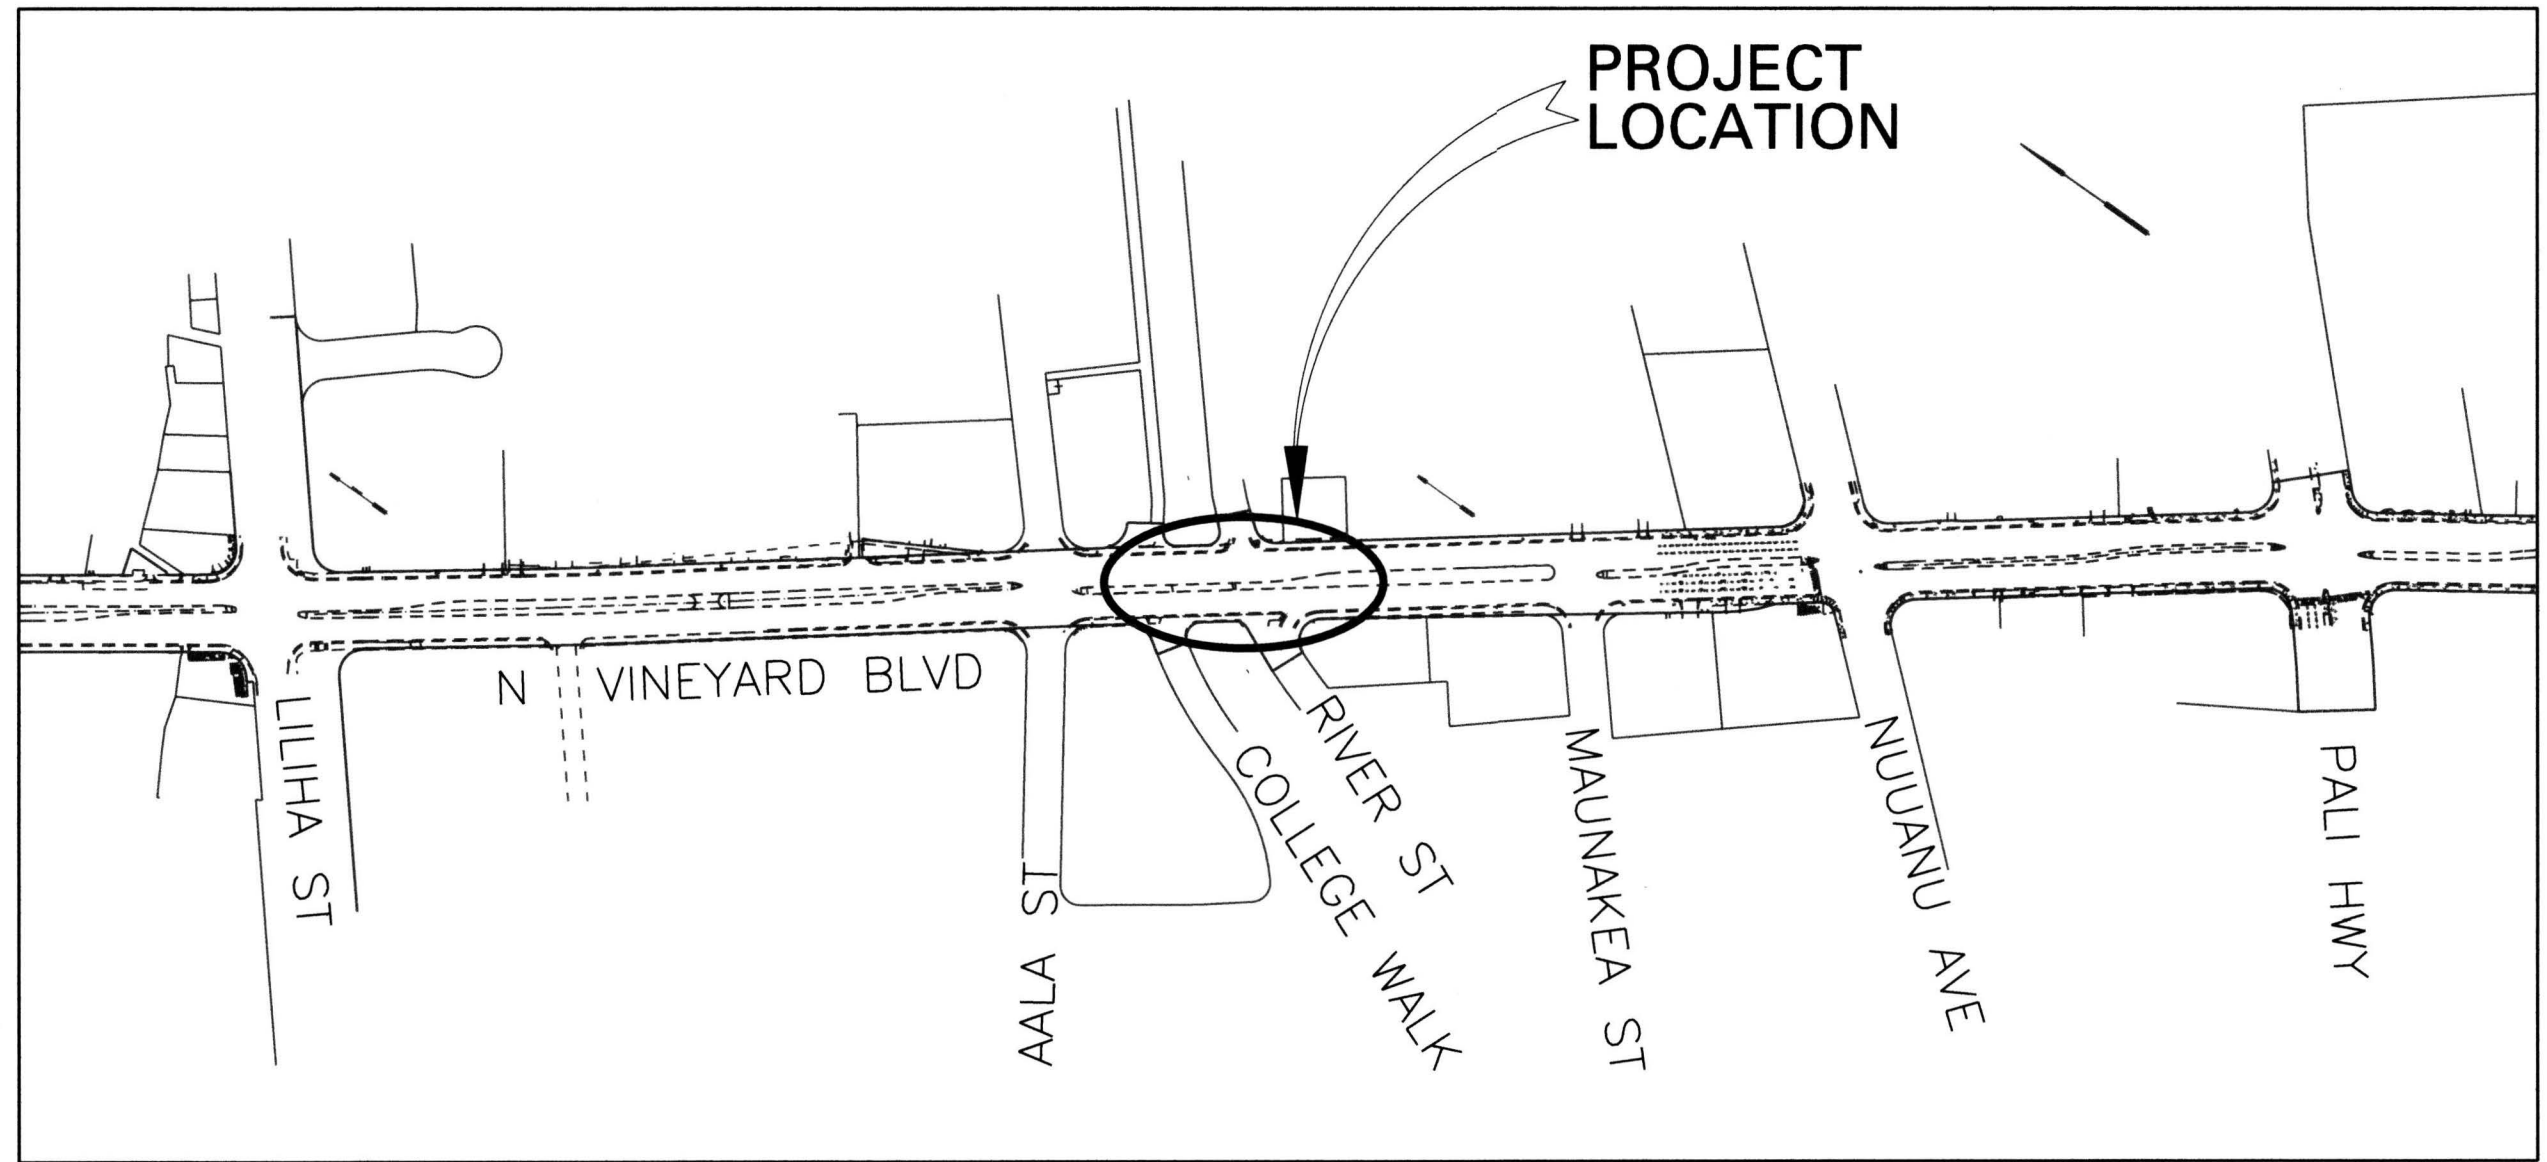

 **LOCATION MAP**

SCALE: 1" = 300'

FED. ROAD DIST. NO.	STATE	FED. AID PROJ. NO.	FISCAL YEAR	SHEET NO.	TOTAL SHEETS
HAWAII	HAW.	98A-01-15	2017	1	40

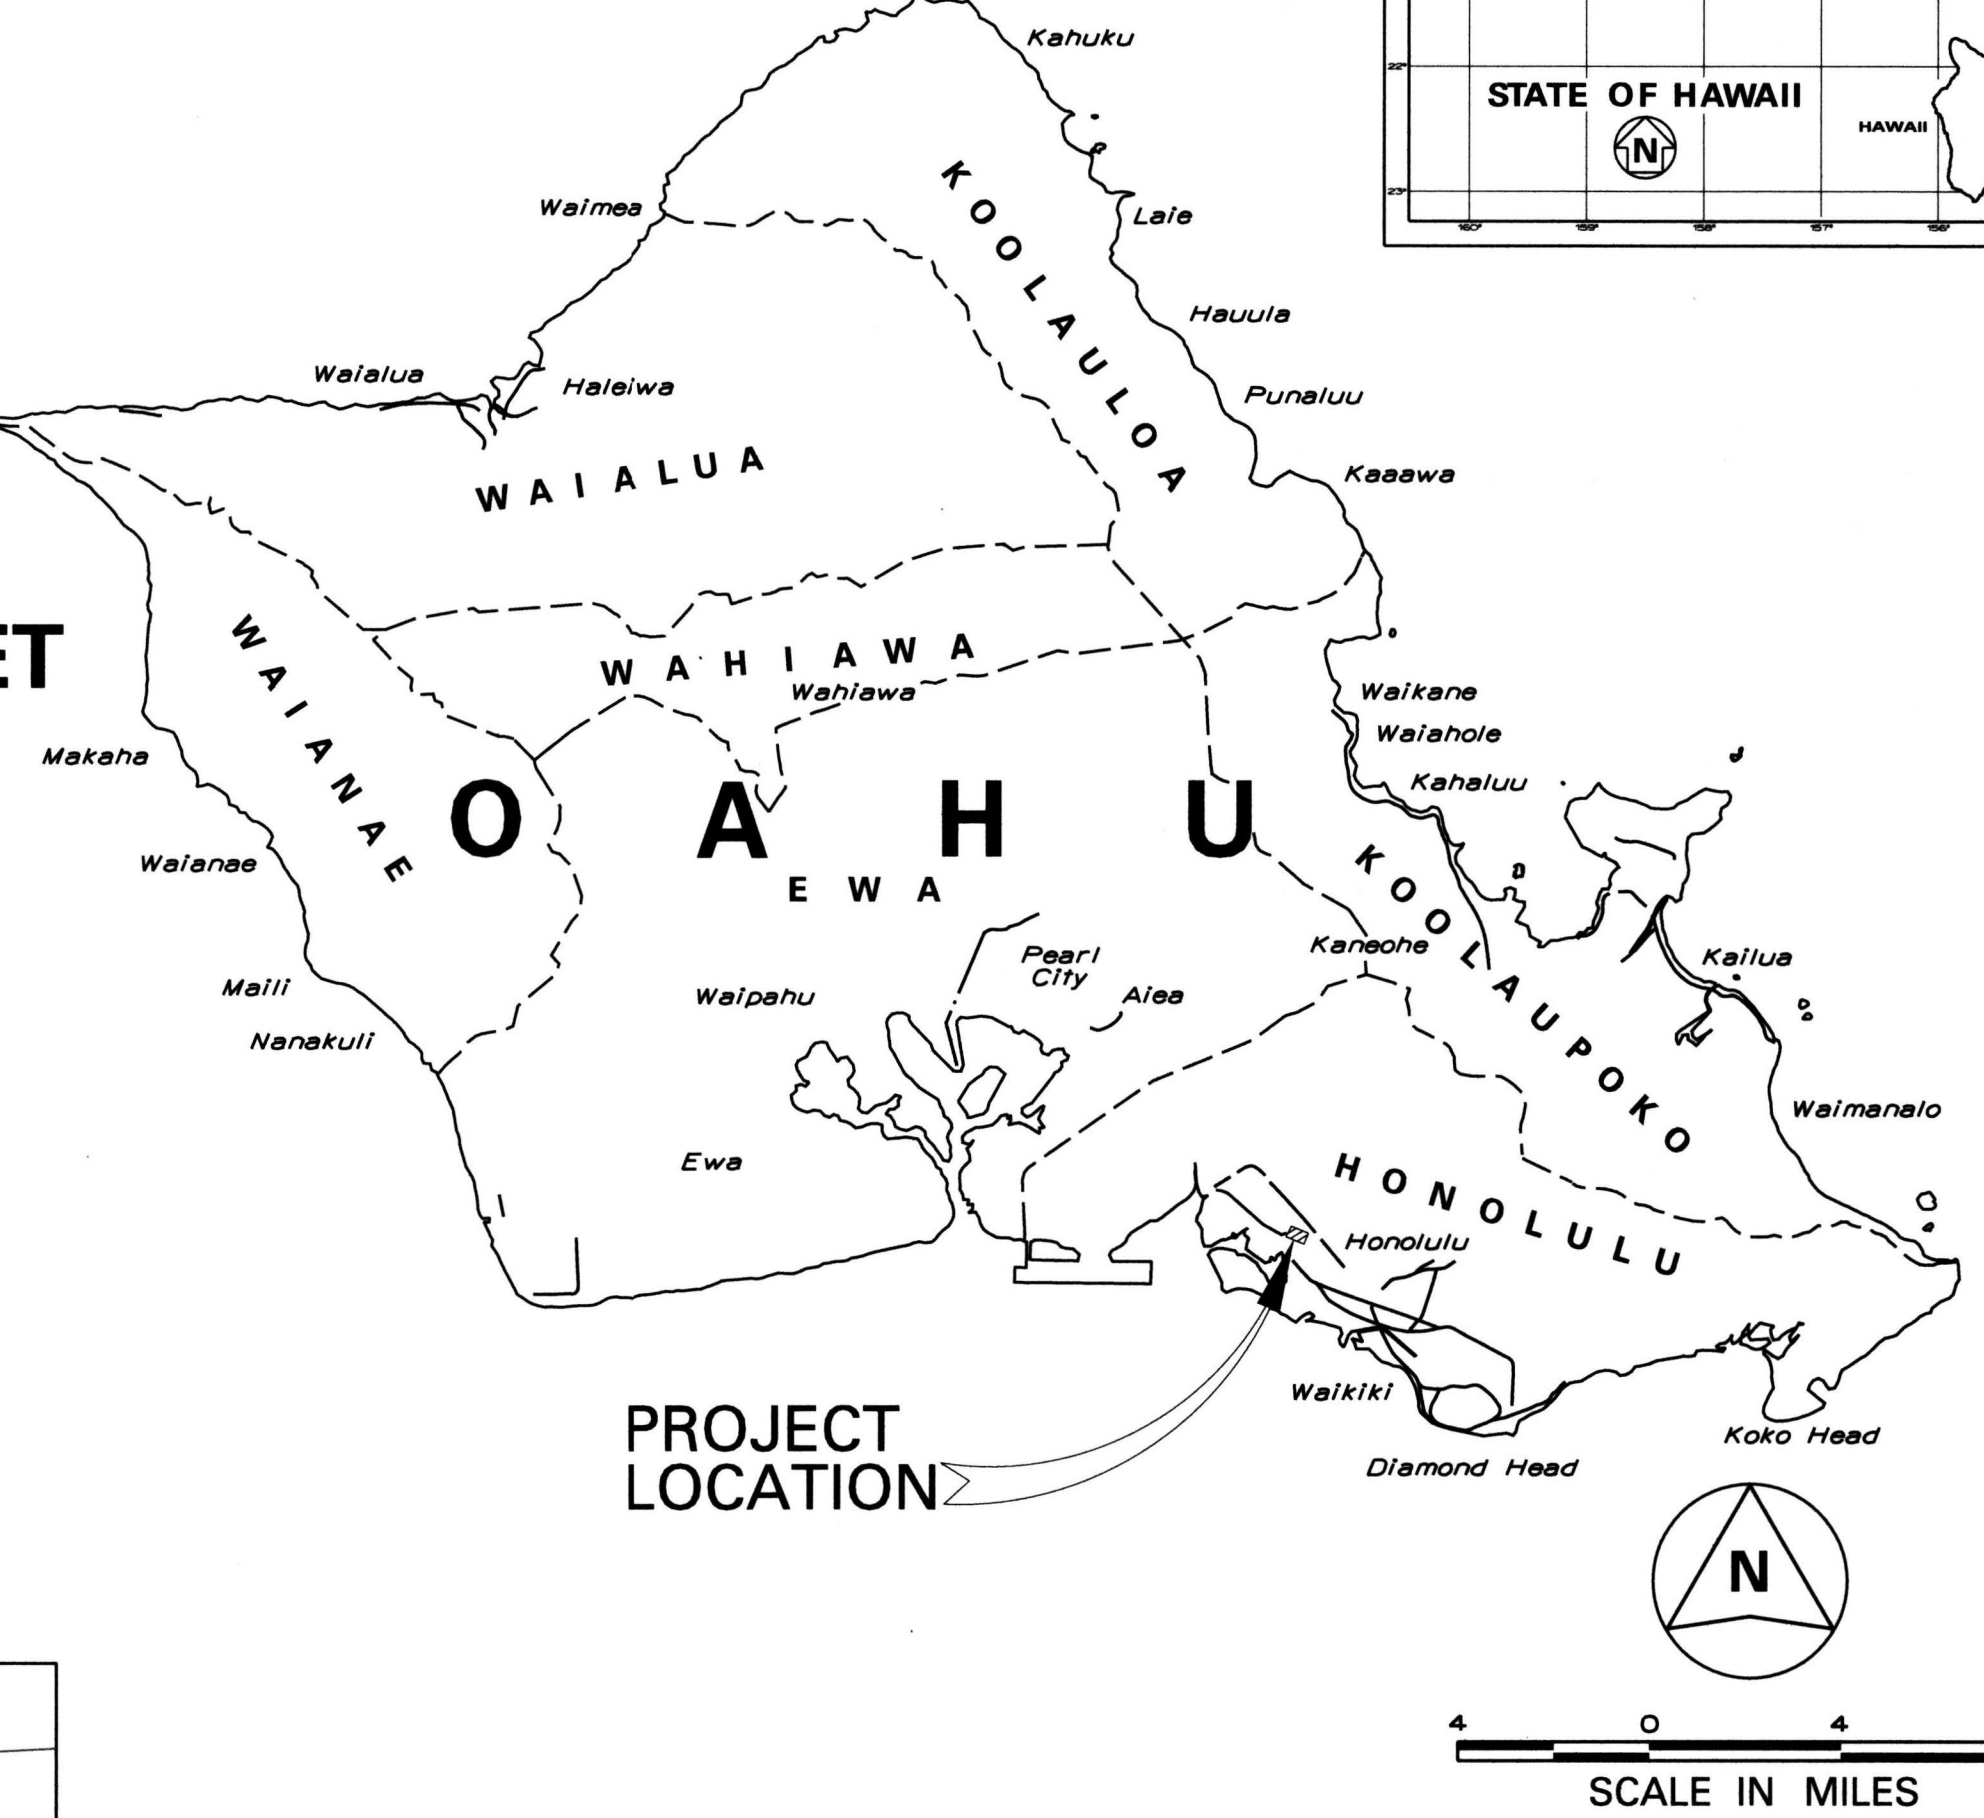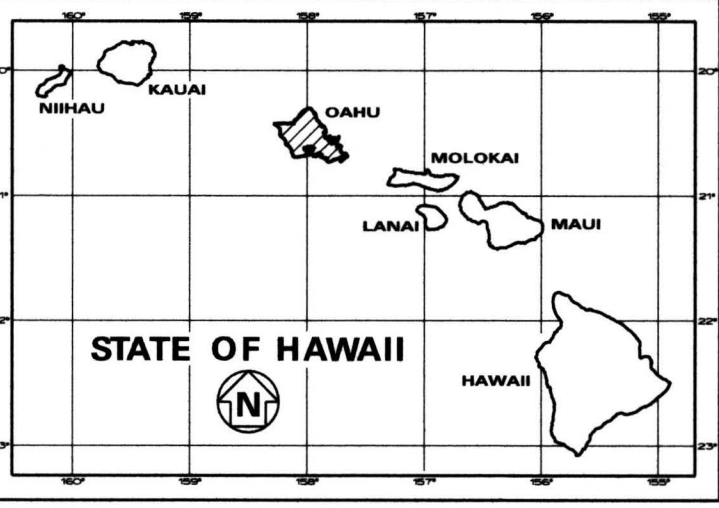

MILE POST 0.73 TO MILE POST 0.88

CH2M
DESIGNED BY
HWY-T
692-7679
August 2017
PHONE
DATE

DEPARTMENT OF TRANSPORTATION STATE OF HAWAII	
APPROVED:  DIR. OF TRANSPORTATION	8/23/17 DATE