




FED. ROAD DIST. NO.	STATE	PROJ. NO.	FISCAL YEAR	SHEET NO.	TOTAL SHEETS
HAWAII	HAW.	98A-01-70	1970	19	19

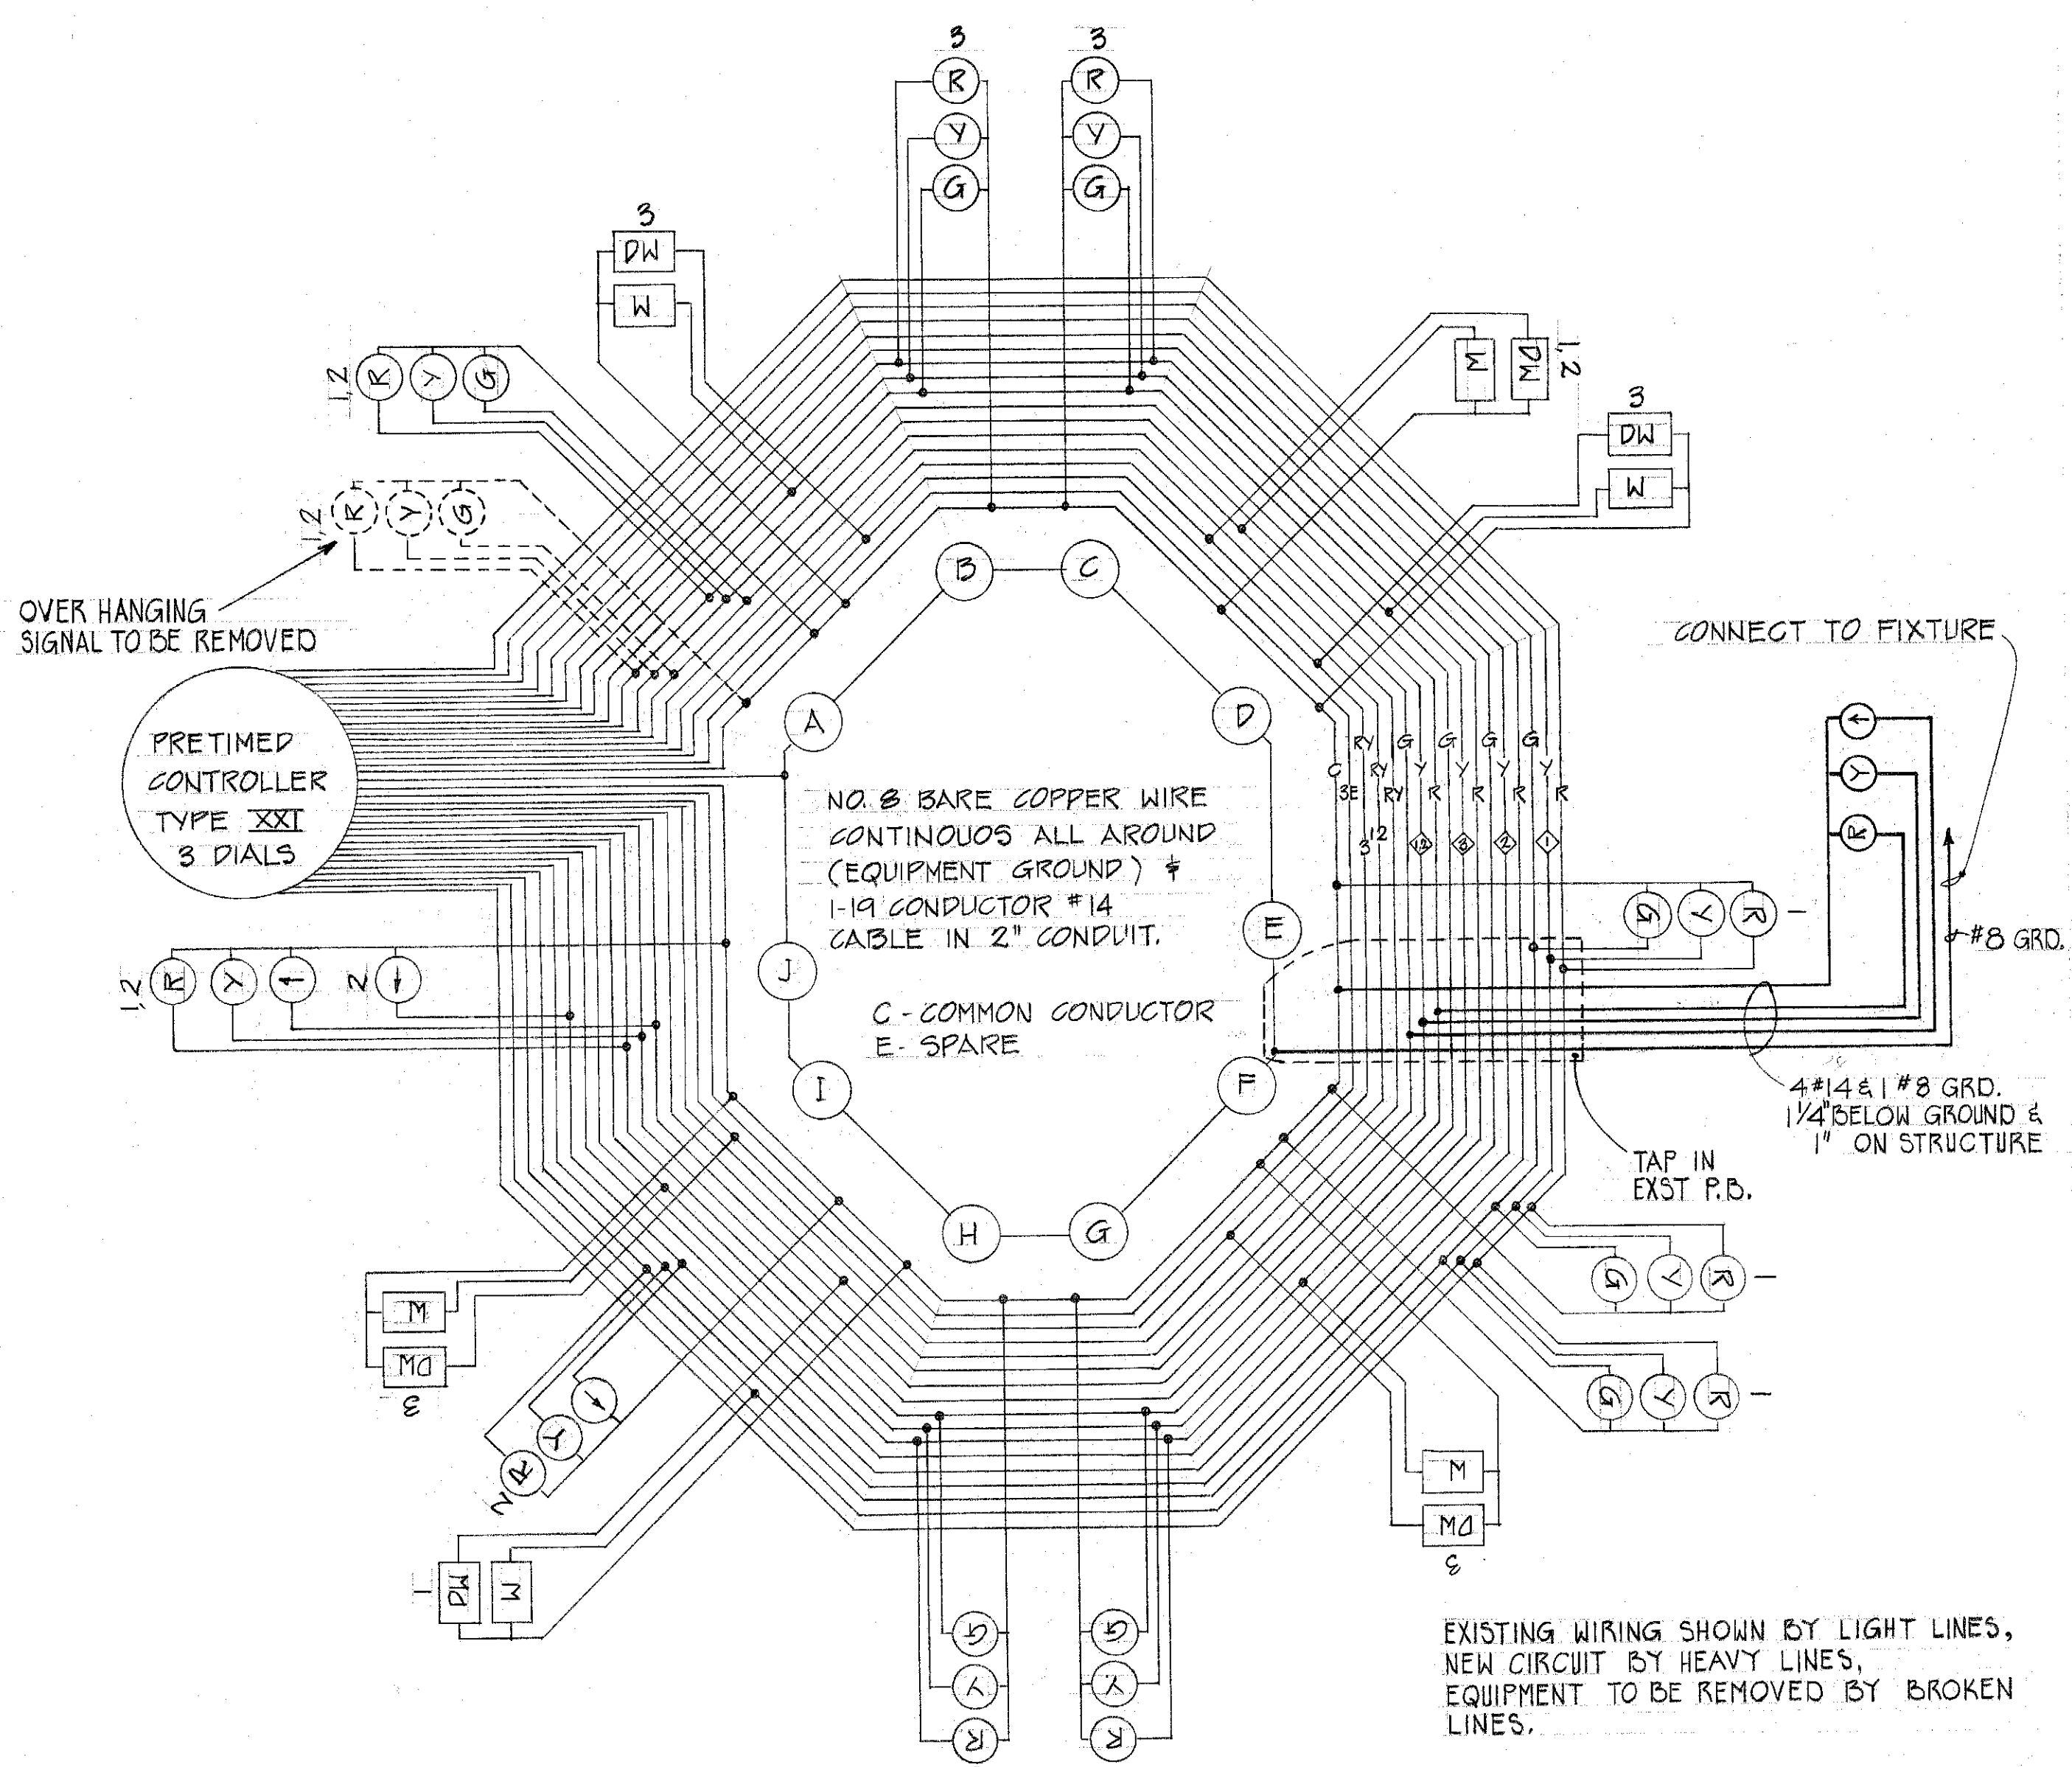


(A) TRAFFIC SIGNAL WIRING DIAGRAM

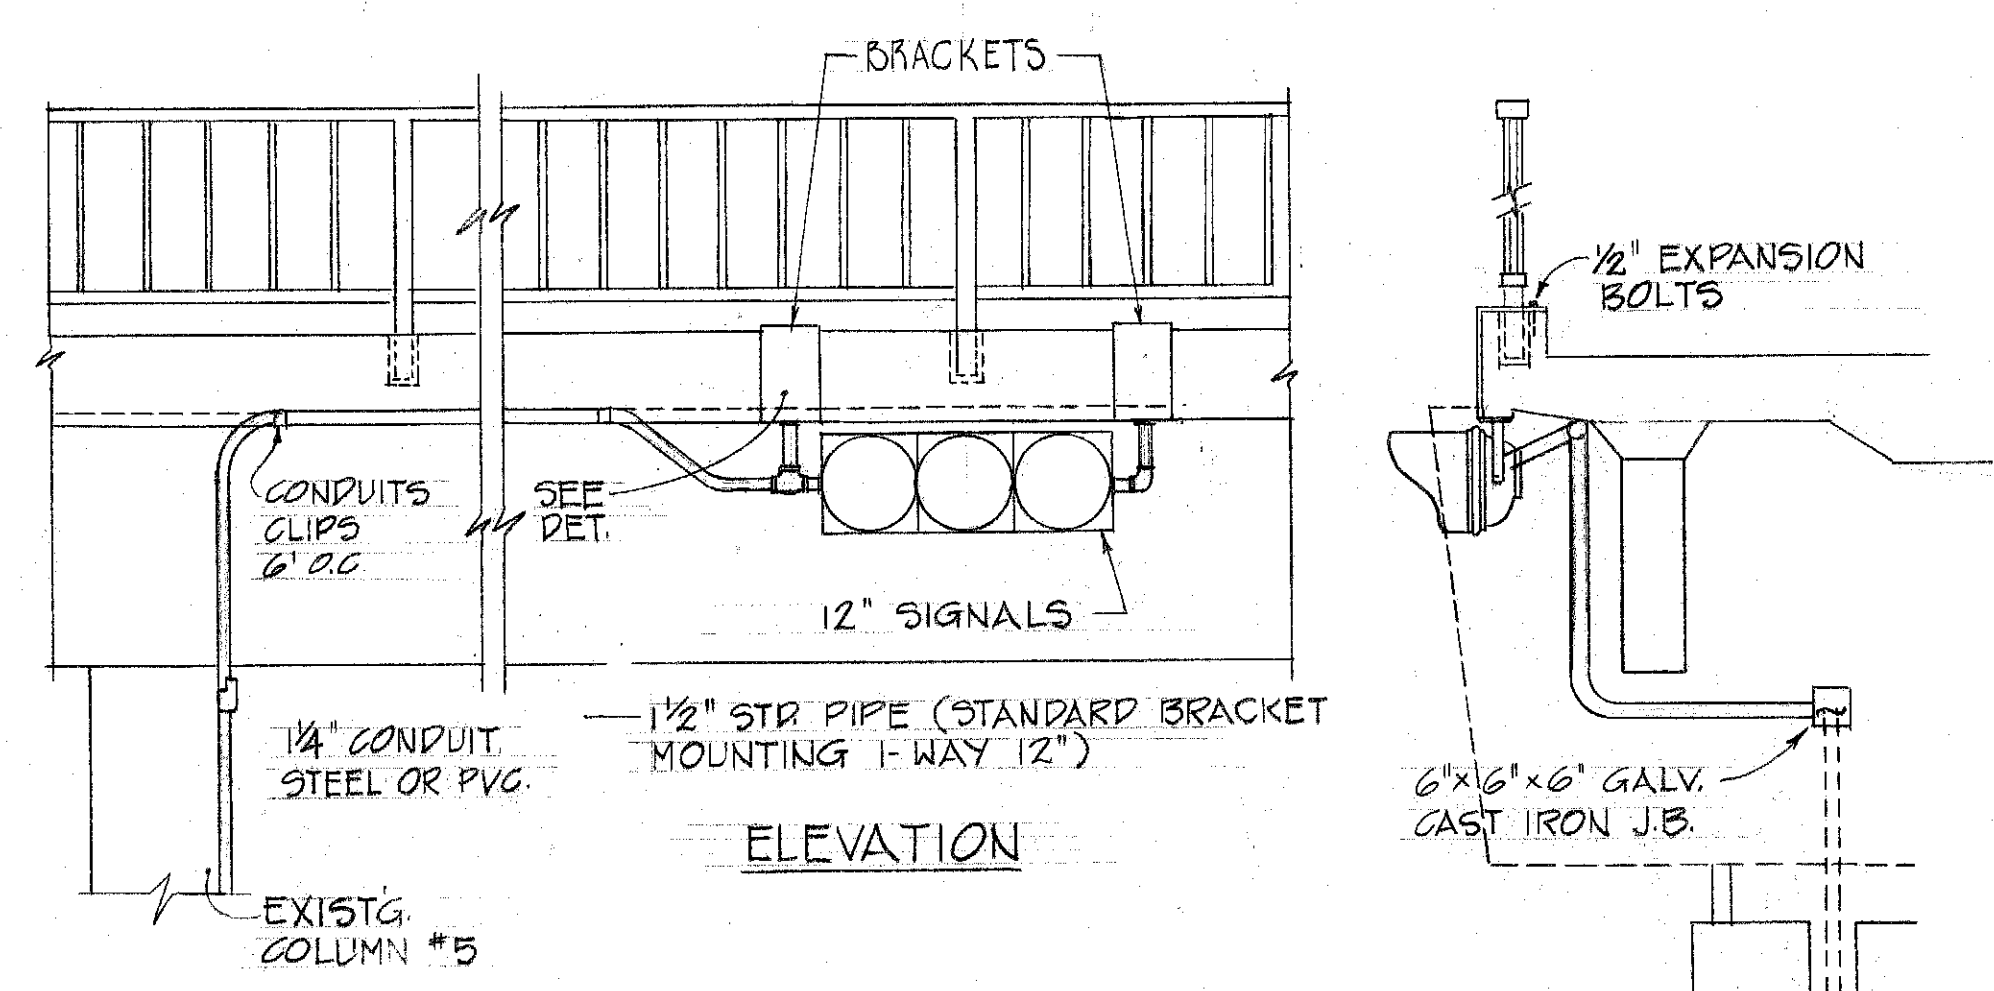


TRAFFIC SIGNAL MOUNTED ON PEDESTRIAN OVERPASS
SCALE: 1/2" = 1'-0"

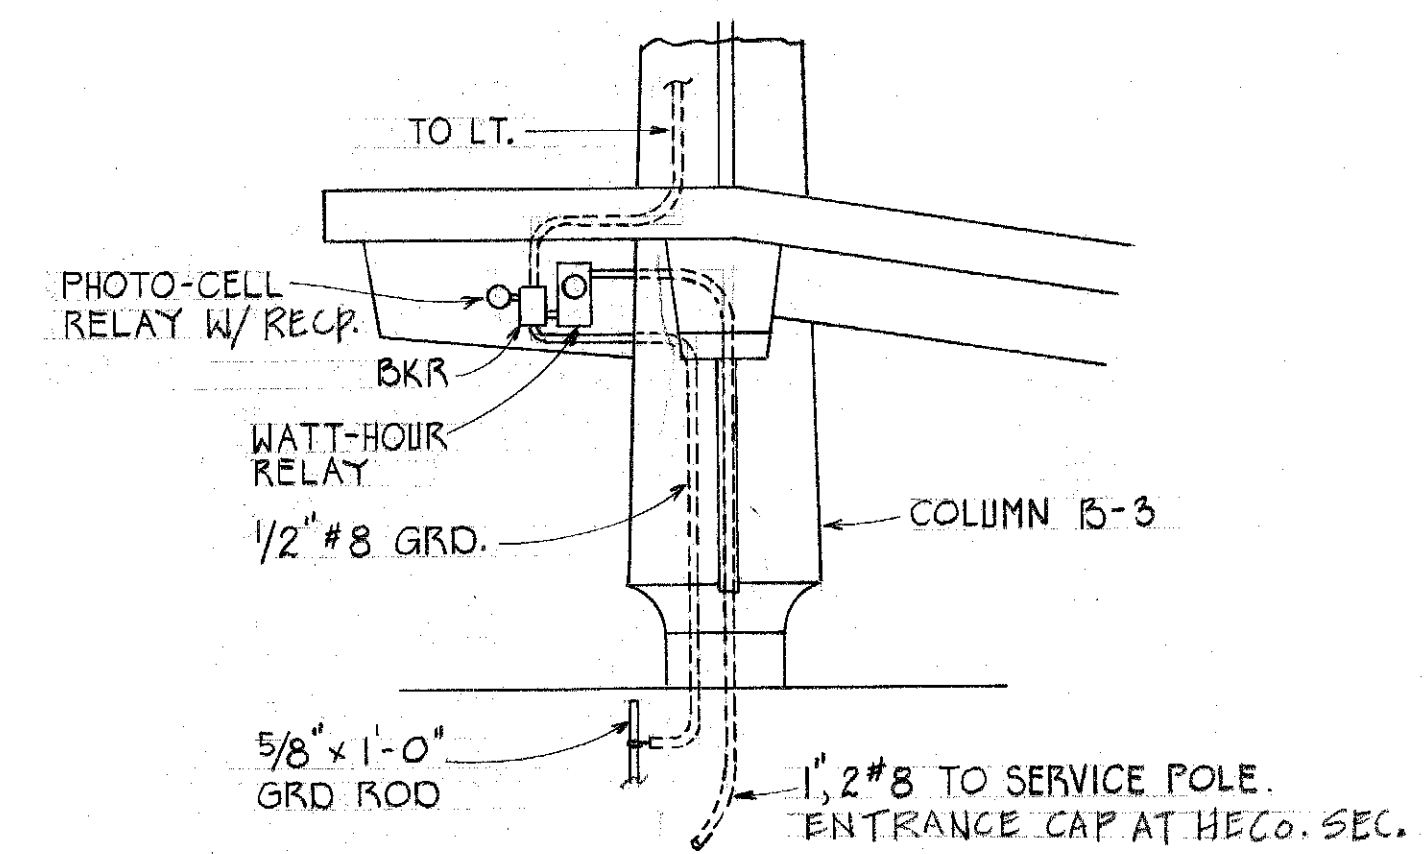

ELEVATION AT SERVICE EQUIPMENT
SCALE: 1/4" = 1'-0"

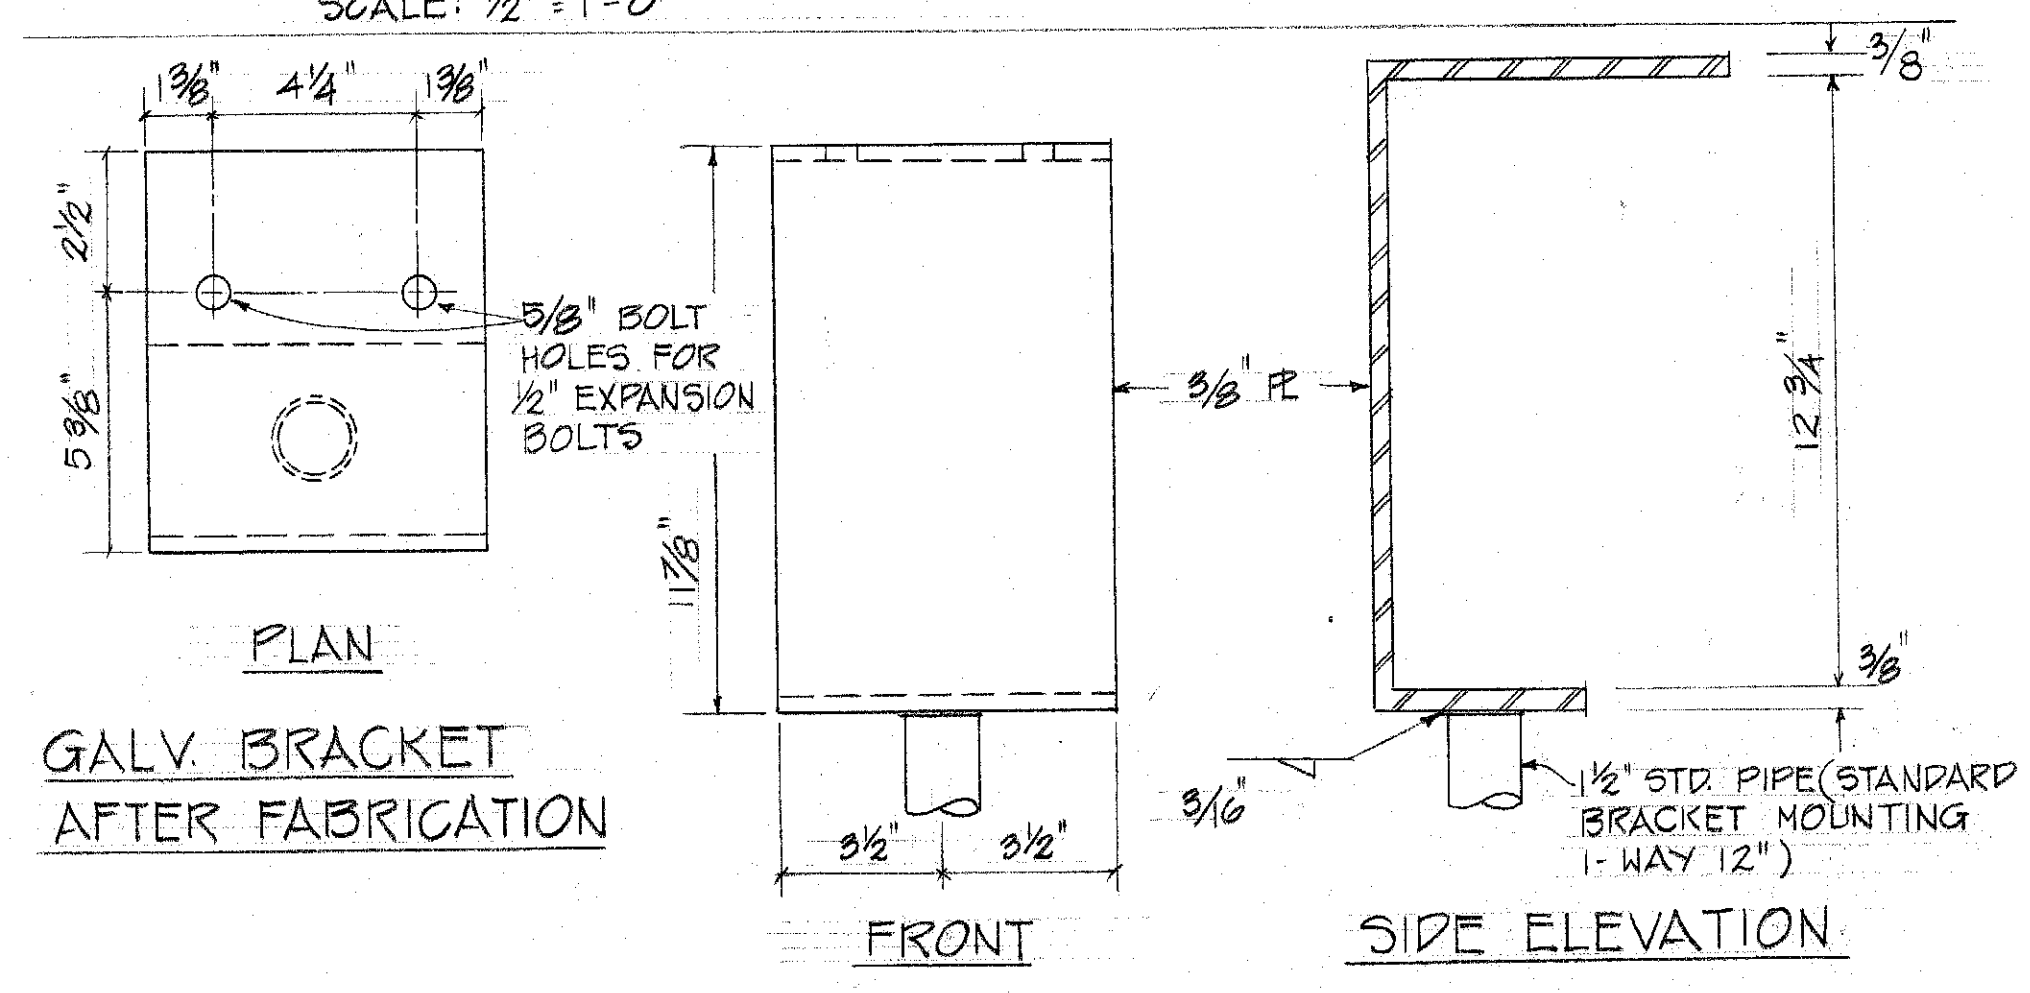


BRACKET MOUNTING DETAIL
SCALE: 3" = 1'-0"

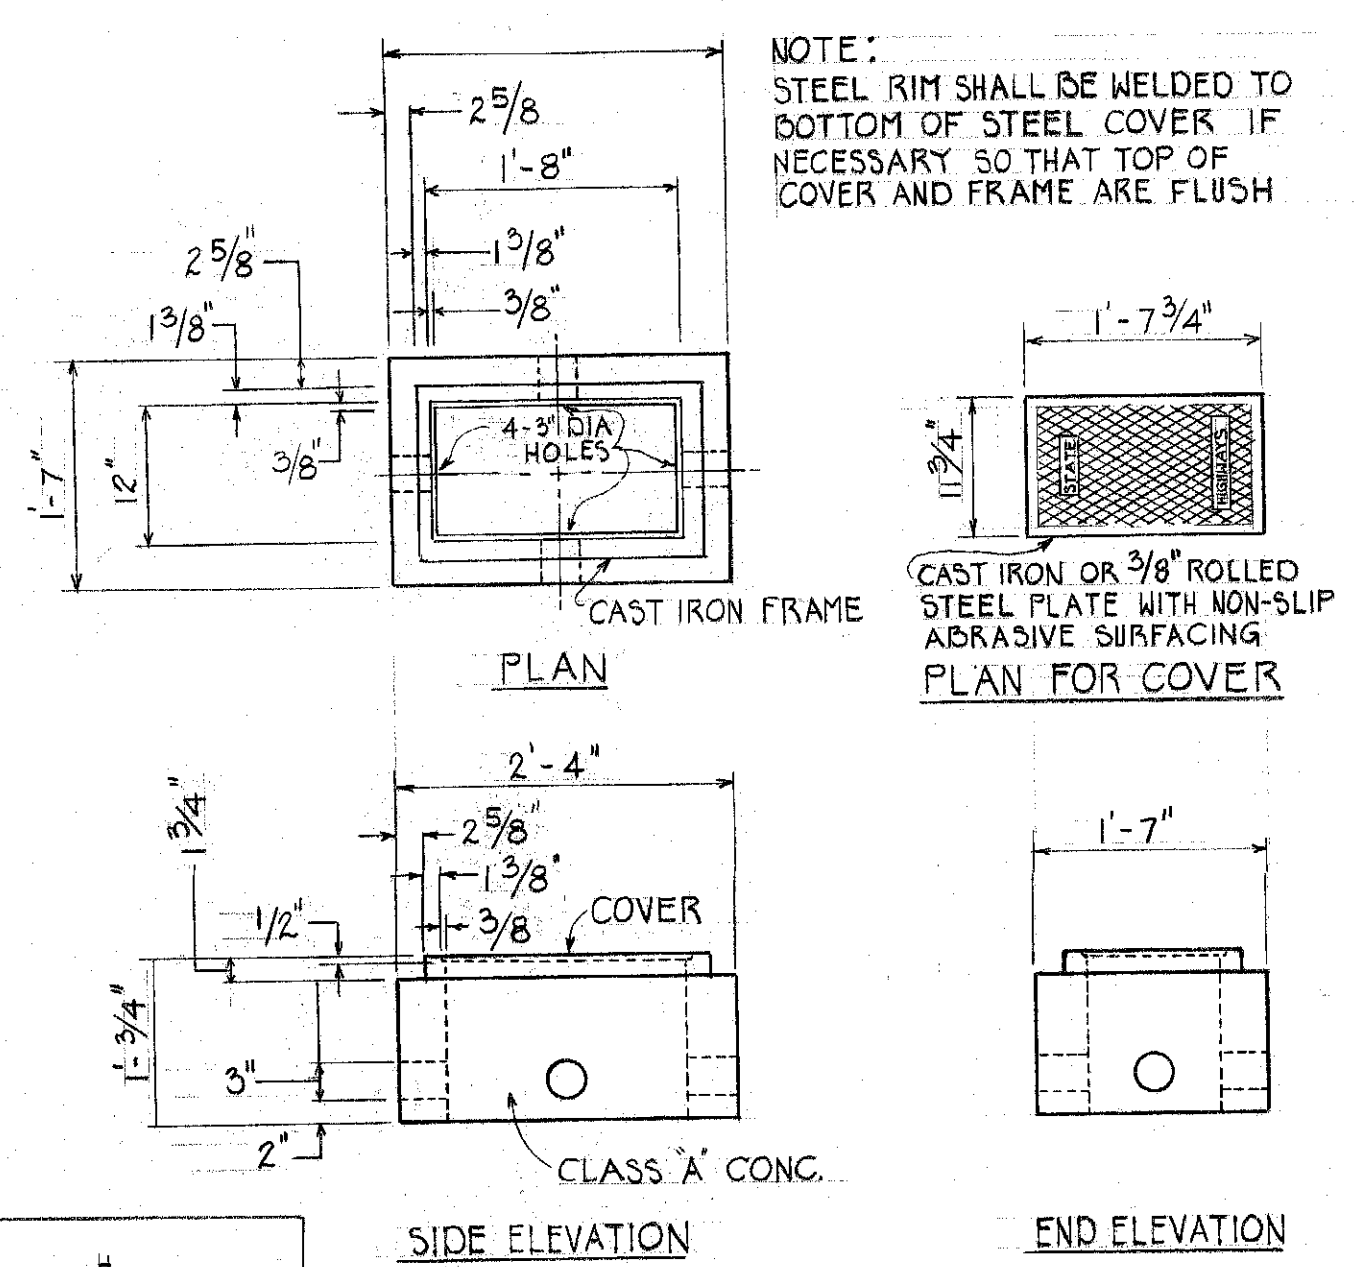


TYPE "B" PULLBOX
SCALE: 3/4" = 1'-0"

FIXTURE SCHEDULE			
TYPE	LAMP SIZE OR WATTAGE	DESCRIPTION	MANUFACTURER OR APPROVED EQUAL
A	100 WATT LAMP	RECESSED INCAND. UNIT, CAST ALUMINUM HOUSING, TEMPERED GLASS DIFFUSER, ANODIZED ALUMINUM FRAME AND GUARD	DEVINE-FG10-V2 G OR MCPHILBEN, MOLDCAST EQUIVALENT
B	100 WATT LAMP	INCAND. WALL BRACKET, CAST ALUMINUM BODY, ANODIZED, OPAL GLOBE & GUARD, WITH CAST METAL BOX.	DEVINE-B-200V TG. OR MCPHILBEN, MOLDCAST EQUIVALENT

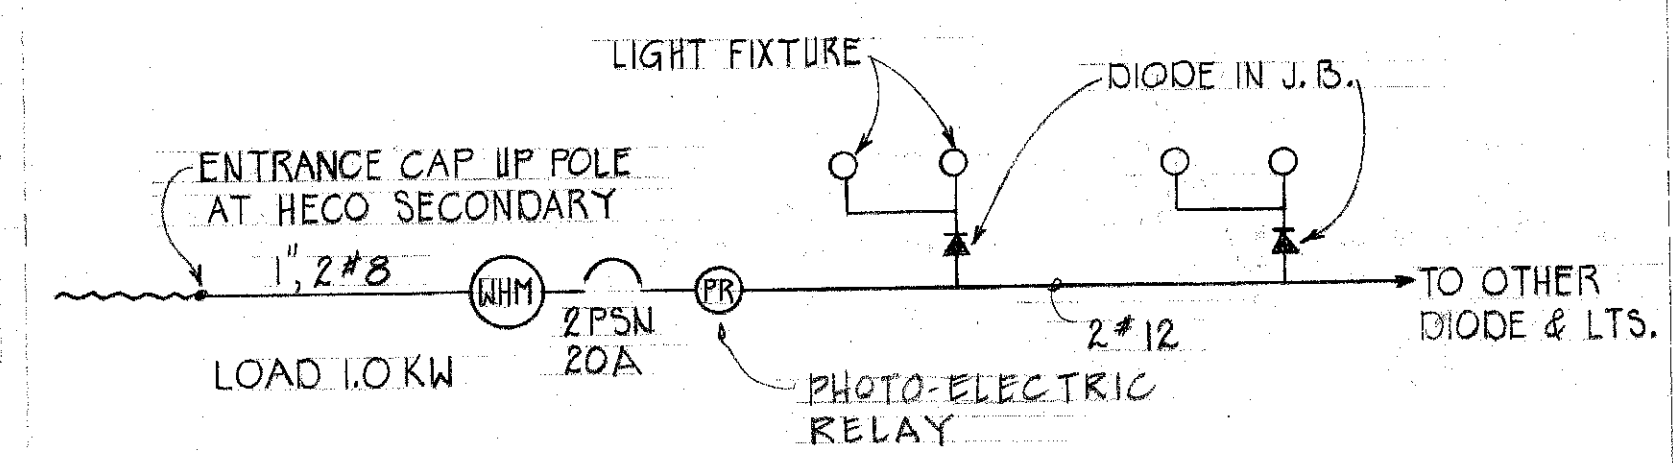

ONE LINE DIAGRAM

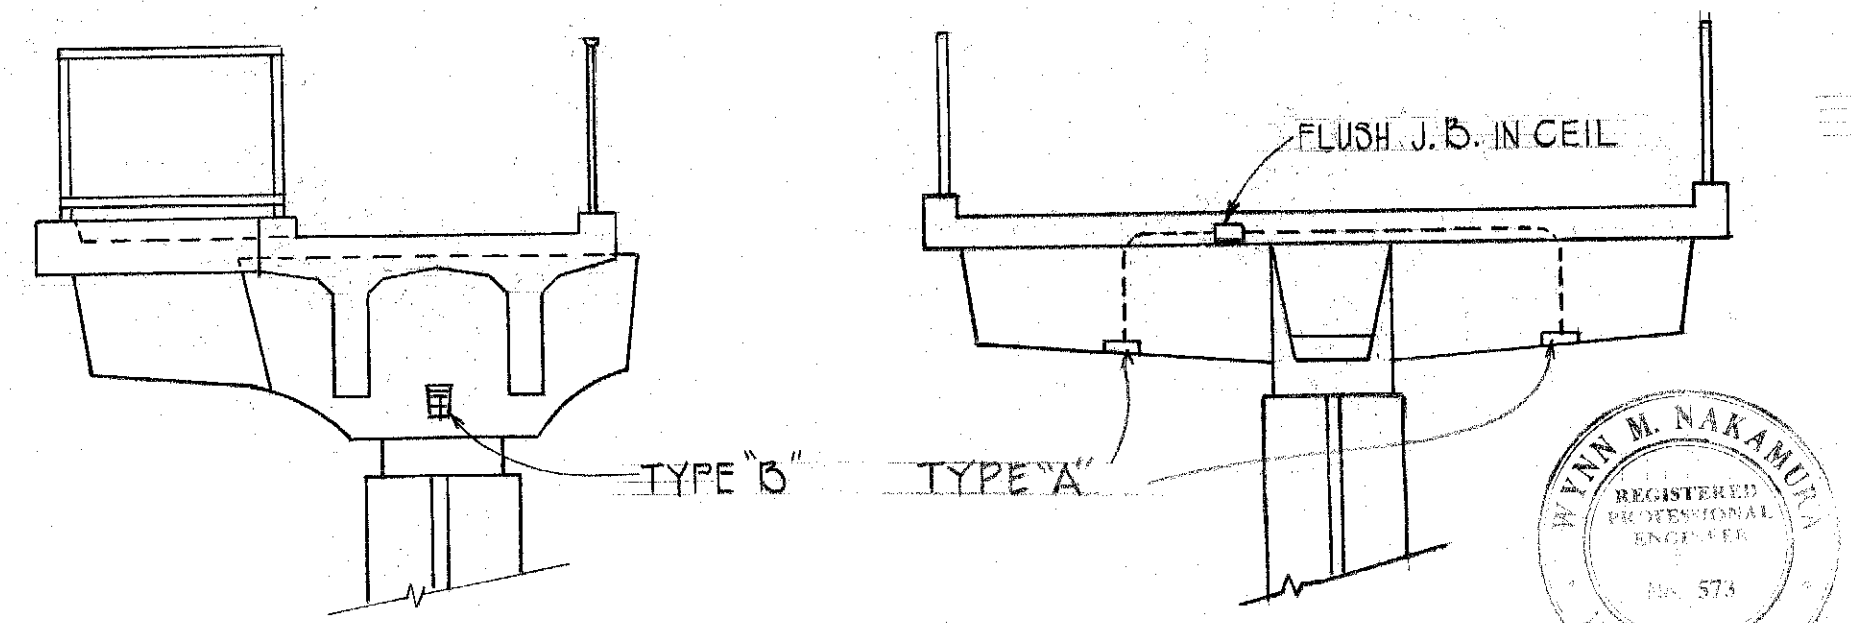

FIXTURE MOUNTING DETAILS
N.T.S.

NOTE: COAT ALL THREADED METAL PARTS WITH ANTI-SEIZURE COMPOUND. e.g. MACHINE SCREWS & FIXTURE BODY PARTS.

STATE OF HAWAII

DEPARTMENT OF TRANSPORTATION

HIGHWAYS DIVISION

ELECTRICAL MISC DETAILS

VINEYARD BOULEVARD

PEDESTRIAN OVERPASS

VICINITY OF PUA LANE, OAHU

PROJECT NO. 98A-01-70

SHEET No. 2 OF 2 SHEETS

19

DATE: _____
SURVEY PLOTTED BY: _____
DRAWN BY: _____
DESIGNED BY: _____
NOTE BOOK: _____
CHECKED BY: _____
No. _____