


FED. ROAD DIST. NO.	STATE	FED. AID PROJ. NO.	FISCAL YEAR	SHEET NO.	TOTAL SHEETS
HAWAII	HAW.				

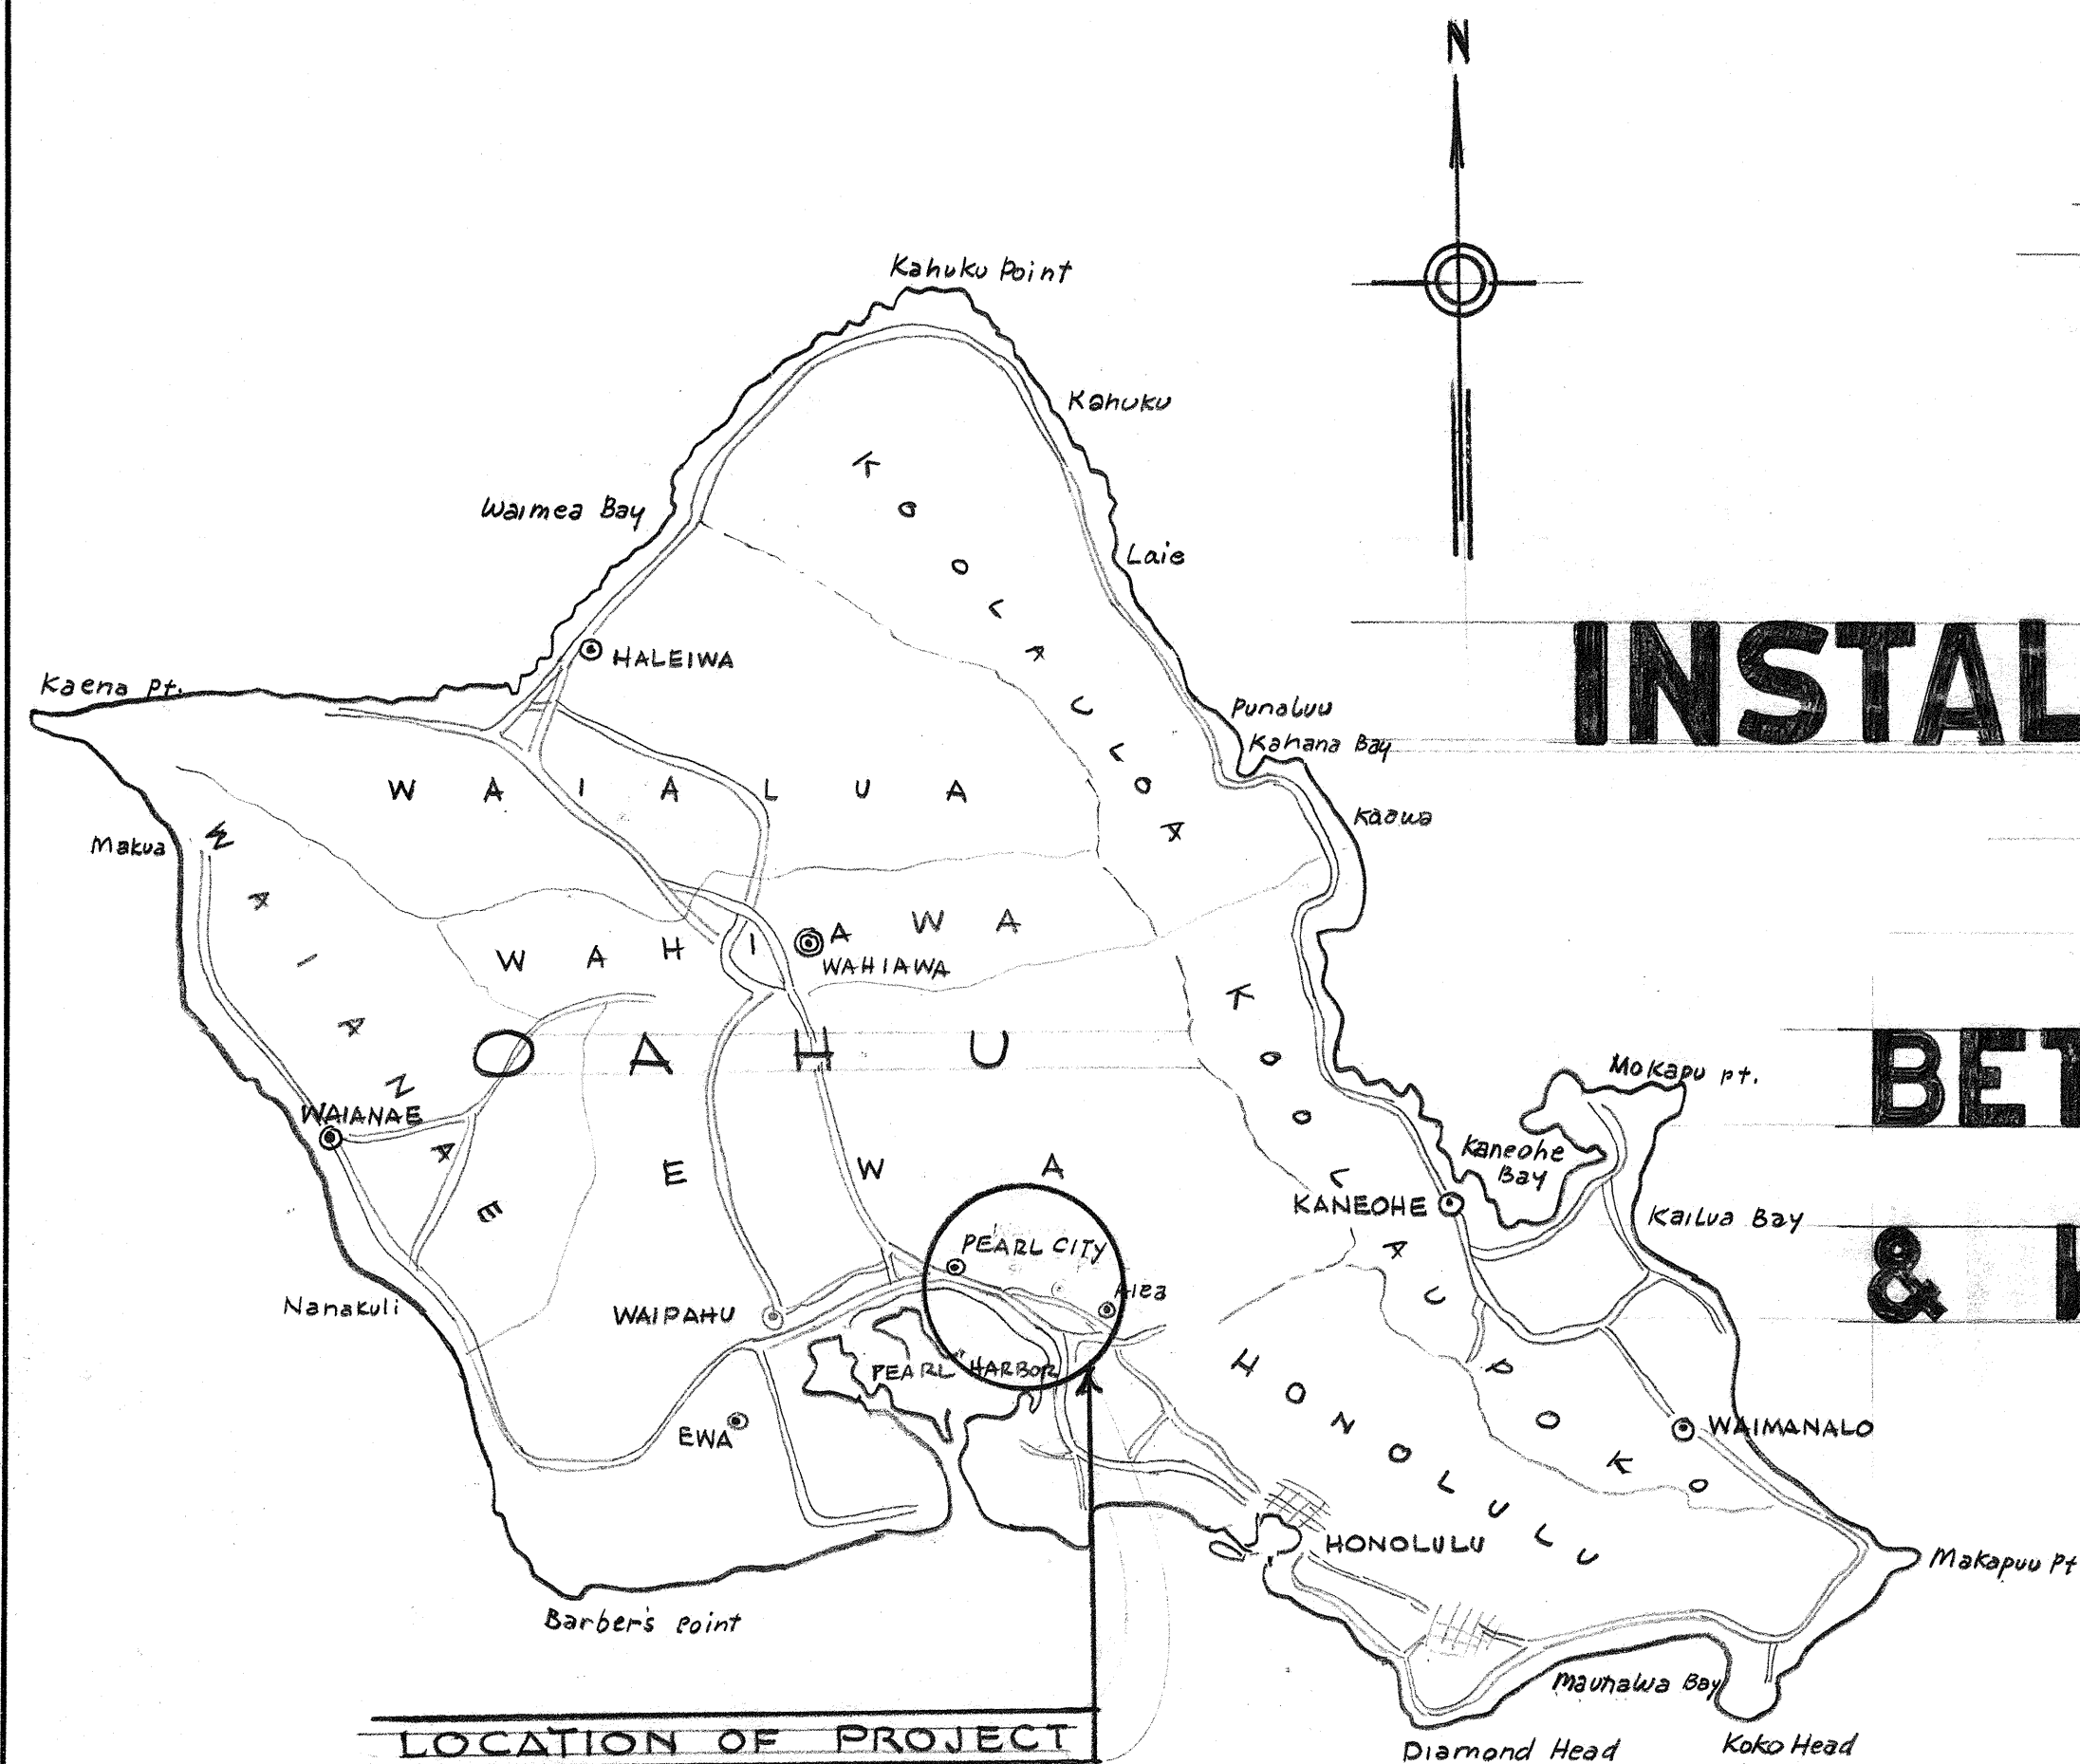

LOCATION OF PROJECT

STATE OF HAWAII
DEPARTMENT OF TRANSPORTATION
HIGHWAYS DIVISION

"AS BUILT" PLANS OF

INSTALLATION OF OVERHEAD LIGHTS

ON KAMEHAMEHA HIGHWAY

BETWEEN HONOMANU STREET, AIEA,
& WAIAWA OVERPASS, PEARL CITY,

PROJECT NO. B-90-01-62

ISLAND OF OAHU

INDEX TO DRAWINGS	
SHEET NO.	DESCRIPTION
E1	TITLE SHEET
E2-E6	HIGHWAY LIGHTING LAYOUT
E7	HIGHWAY LIGHTING LAYOUT & LEGEND
E8	DETAILS
E9	DETAILS
E10	DETAILS

NOTE:


ALL CHANGES MADE DURING CONSTRUCTION
HAVE BEEN NOTED ON THESE TRACINGS IN
RED AND CHECKED BY:

Kenich Shibata
PROJECT ENGINEER

5/22/62
DATE

APPROVED: DATE: 4/14/62

W. J. Oberhausen
DIRECTOR OF TRANSPORTATION

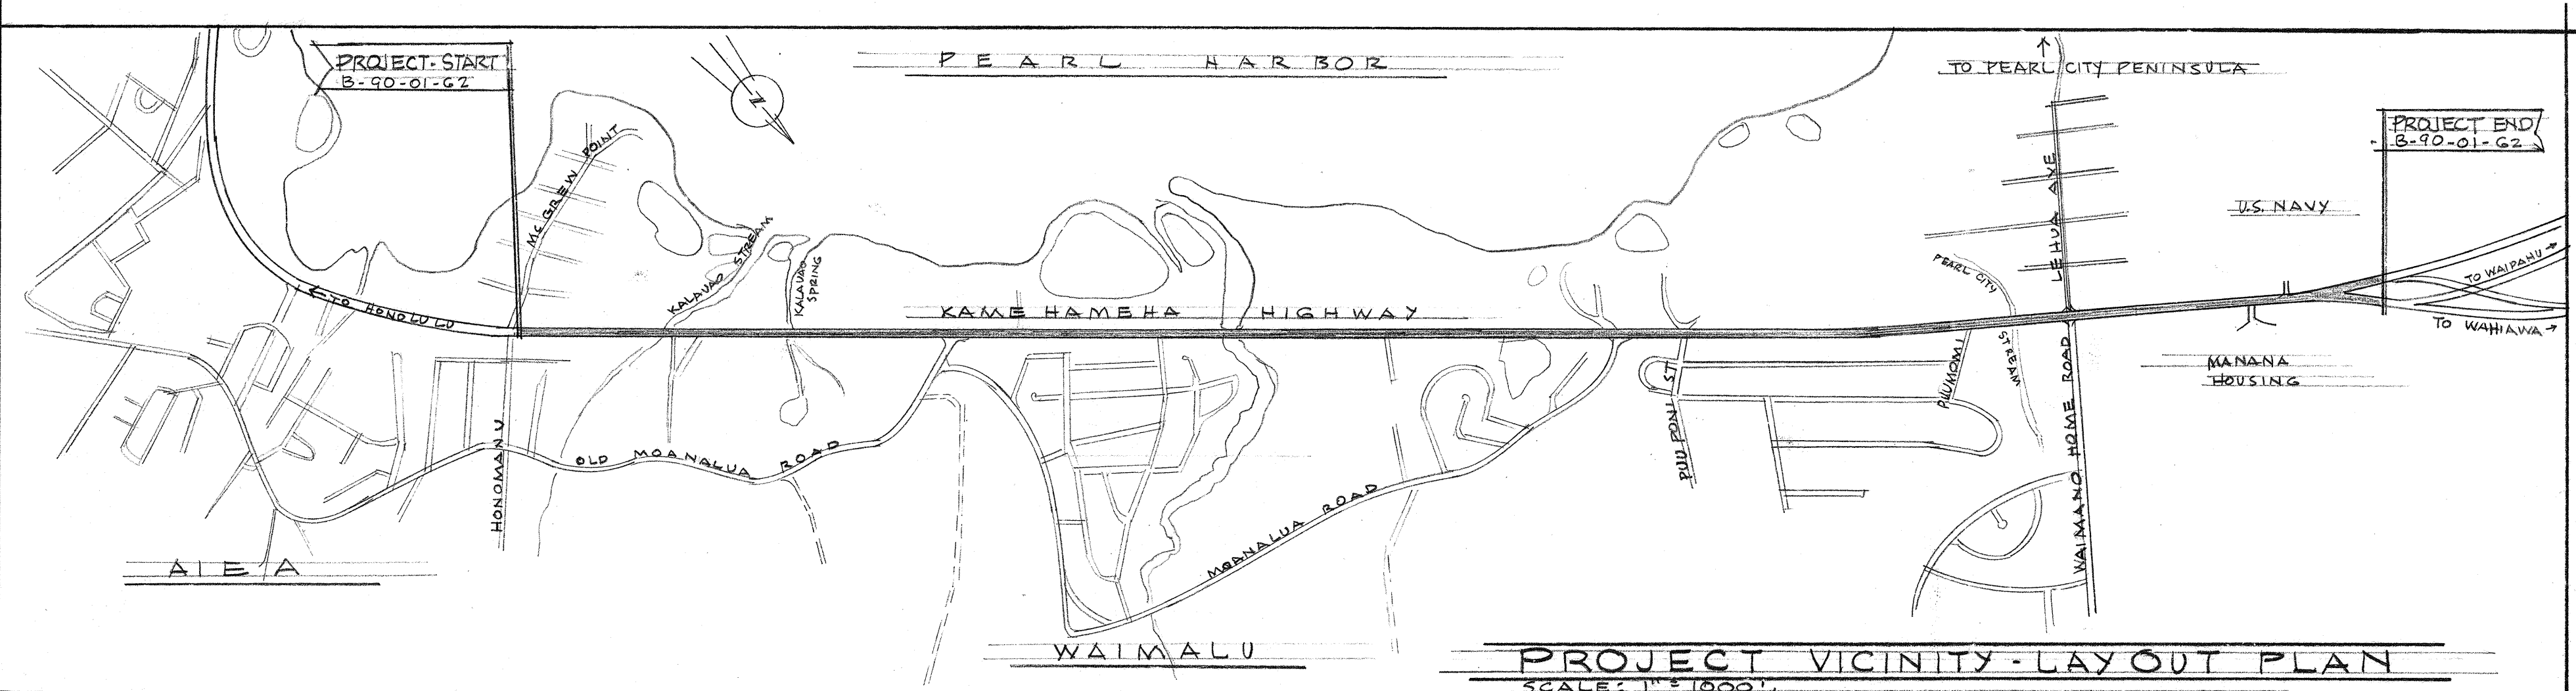

PROJECT VICINITY LAYOUT PLAN
SCALE: 1" = 1000'

PLAN PREPARED BY:
JAMES J. OBERHAUSEN
CONSULTING ENGINEER
824 FORT STREET ROOM #3
HONOLULU HAWAII

STATE OF HAWAII
DEPARTMENT OF TRANSPORTATION
HIGHWAYS DIVISION
TITLE SHEET AND LOCATION PLAN
PROJECT NO. B-90-01-62
JUNE 8, 1962
SHEET No. E1 OF 10 SHEETS

ORIGINAL PLAN	DATE
SURVEY PLOTTED BY	
DRAWN BY	
DESIGNED BY	
NOTED BY	
CHECKED BY	