


INDEX TO DRAWINGS	
SHT. NO	DESCRIPTION
1	Title Sheet
2	Layout Plan
3	Boring Plan
4-6	Typical Roadway Sections
	Plan and Profile
7	H-1 Inbound & H-1 Outbound
8	H-2 Inb. to H-1 Outb. & H-1 Inb. to H-2 Outb.
9	Ramp "D"
10	Ramp "M", Loop 5 & Temp. Connector 2
11-12	Kamehameha Highway Connector
13-14	Waipahu Street Realignment
15-17	Superelevation Diagrams
18-20	Intersection Details
21	Miscellaneous Details
22	Construction Phasing
23-33	Grading and Drainage Plans & Details
34-37	Irrigation Relocation Plans & Details
38	Traffic Detour
39-49	Traffic Signs and Pavement Markers
50-52	Guard Rails Details
53	Retaining Wall Plan & Profile
54-64	Electrical Plan & Details
65-79	Structure No. 4a & 4b
80-89	Structure No. 12
90-102	Standard Structure Details
103-123	Cross Section
124	Borrow Pit

STATE OF HAWAII
DEPARTMENT OF TRANSPORTATION
HIGHWAYS DIVISION
HONOLULU, HAWAII

"AS BUILT" PLANS FOR
CONSTRUCTION OF A PORTION OF
INTERSTATE ROUTE H-1
WAIAWA INTERCHANGE

FEDERAL AID INTERSTATE PROJECT No. I-HI-1(36):8

DISTRICT OF EWA
ISLAND OF OAHU

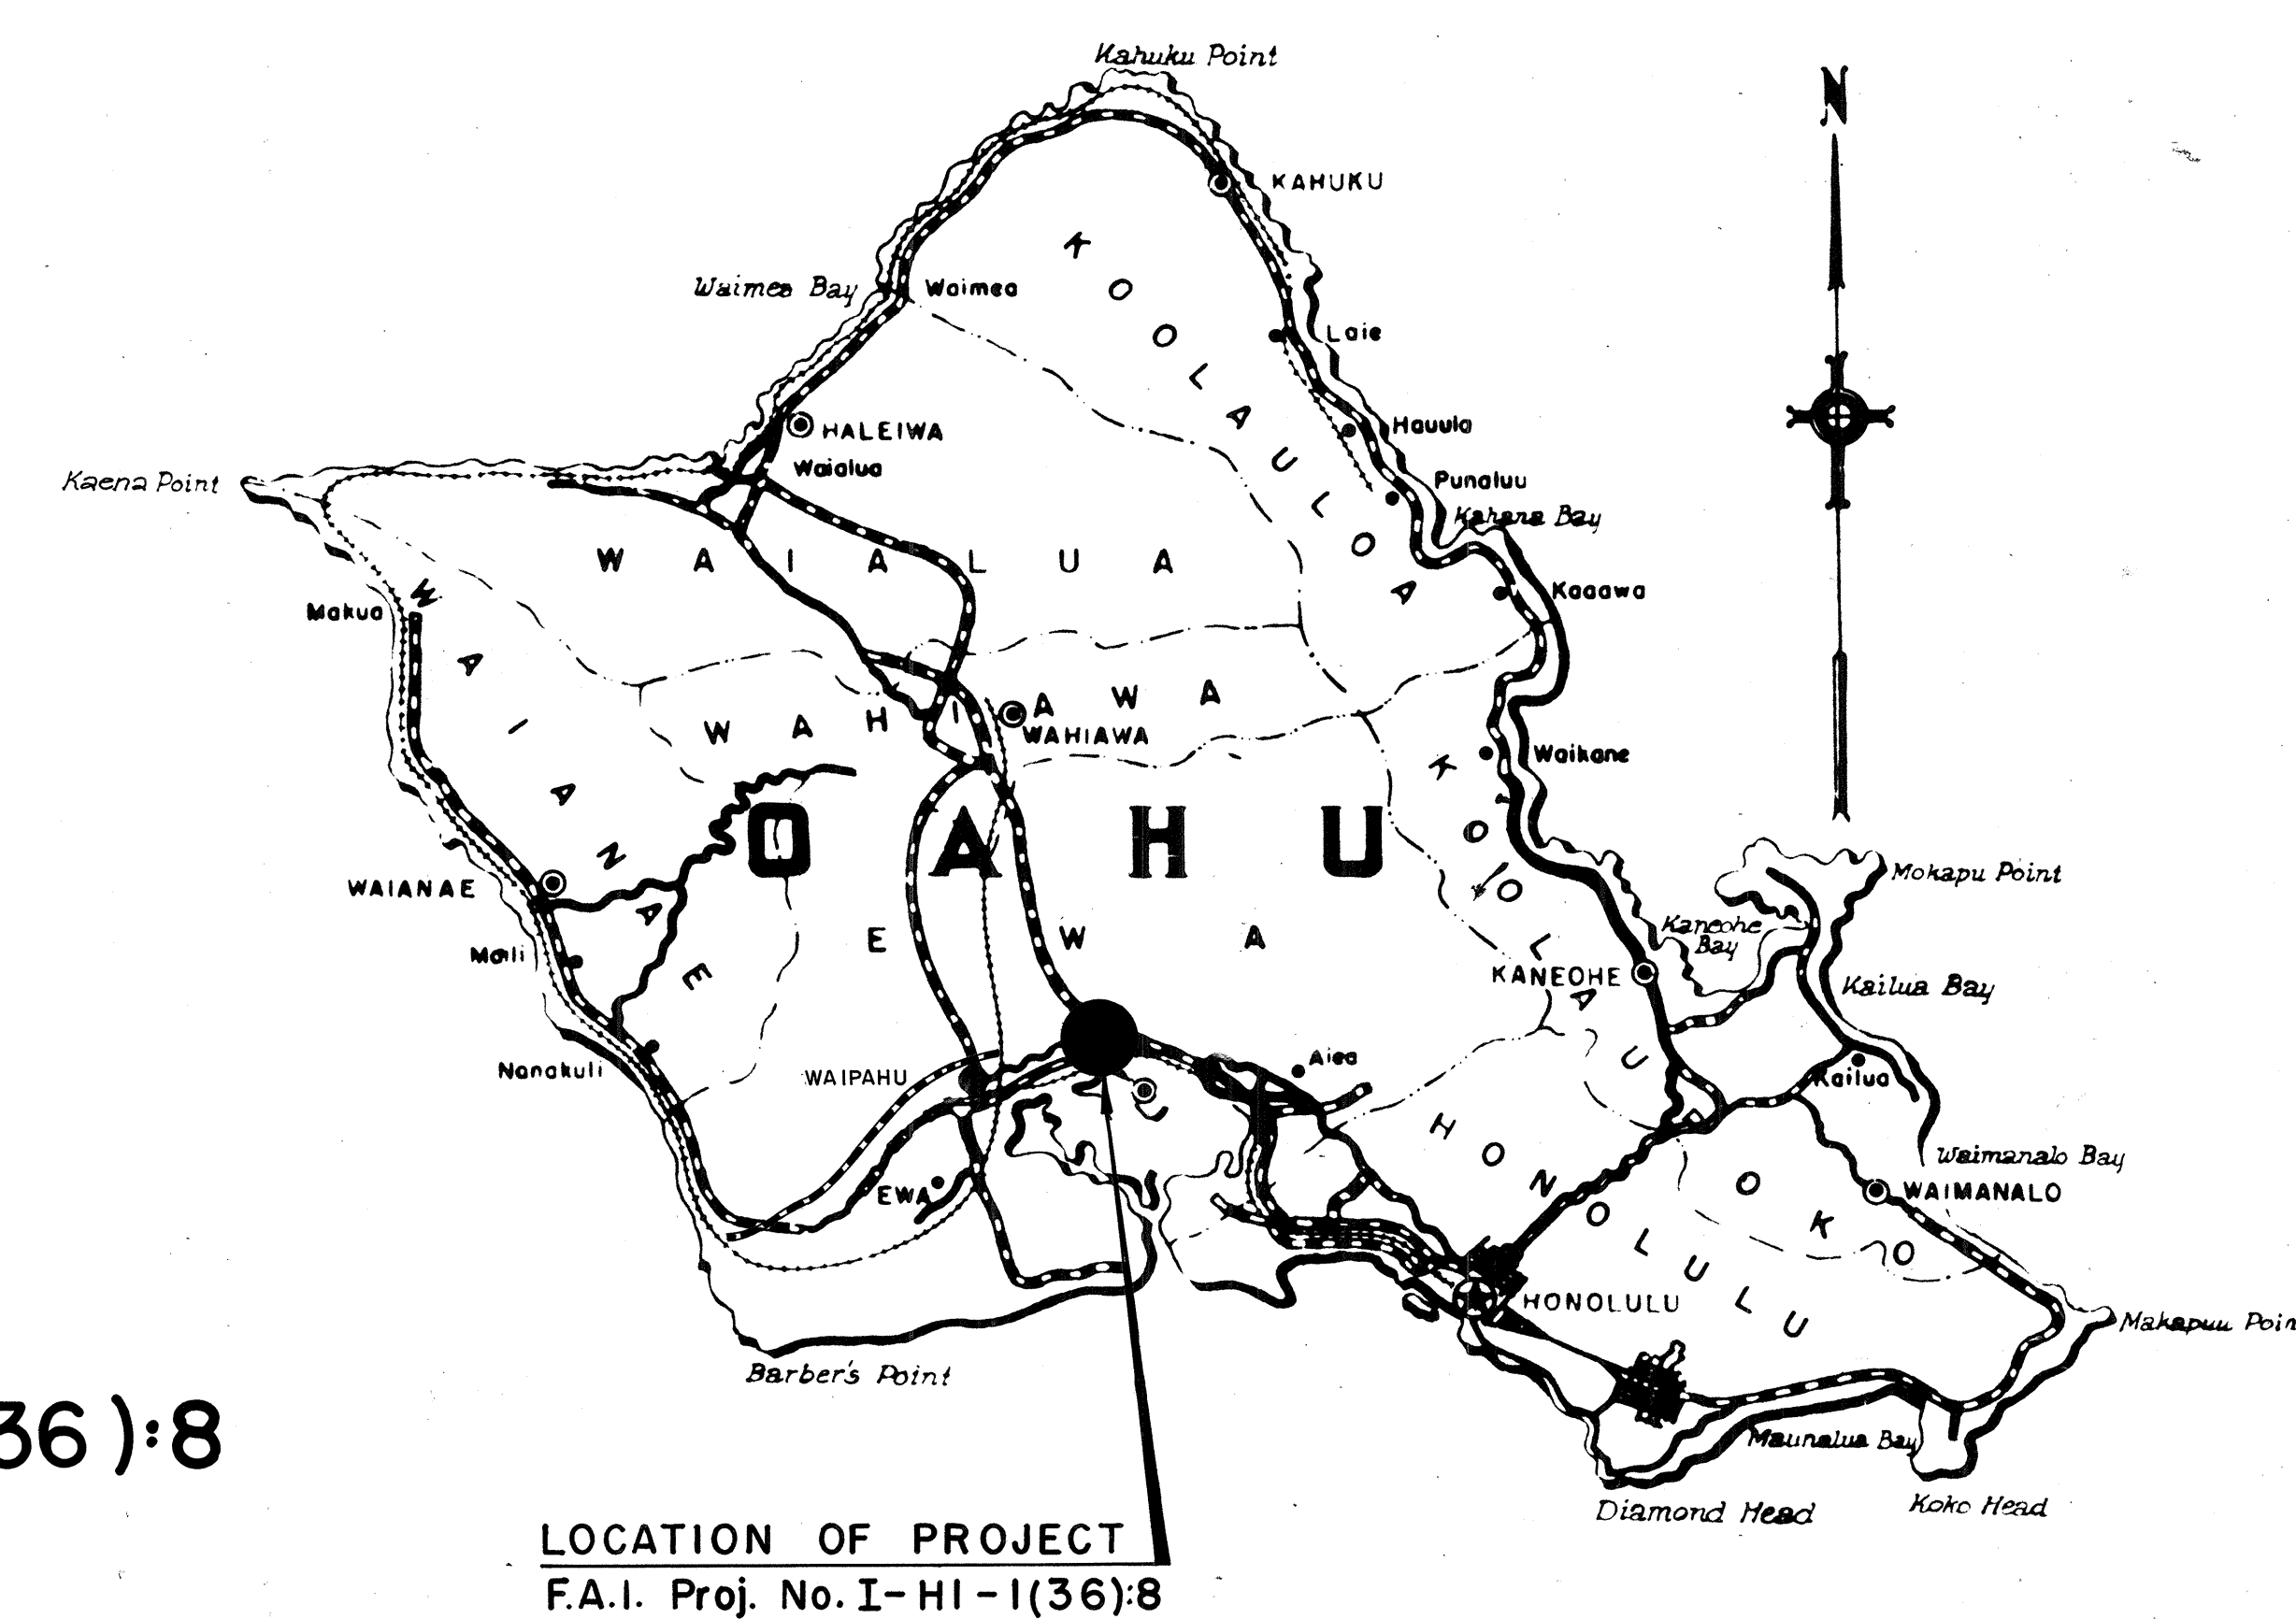

Federal Aid Projects Previously Constructed Or Under Construction

NOTE:
ALL CHANGES MADE DURING CONSTRUCTION
HAVE BEEN NOTED IN RED ON THESE TRACINGS
AND CHECKED BY:

Haruki Shibata
PROJECT ENGINEER
5-22-72
DATE

SCALES			
PLAN & PROFILE	HOR.	1" = 50'	
	VER.	1" = 5'	
DETAIL ROADWAY PLAN		1" = 20'	
CROSS SECTION	HOR.	1" = 10'	
	VER.	1" = 10'	

DESIGN CLASSIFICATION	
DESIGN ADT (1988)	56,900
DHV	10 %
D	60/40
T	3.5 %
V	70 m.p.h.

APPROVED: Date: 10/19/67...

John H. McArthur
FOR DIRECTOR OF TRANSPORTATION

DEPARTMENT OF TRANSPORTATION
BUREAU OF PUBLIC ROADS
APPROVED: *John H. McArthur* 10/31/67
DIVISION ENGINEER DATE

DATE
SURVEY PLANNED BY
DESIGNED BY
DRAWN BY
NOTE BOOK
QUANTITIES CHECKED BY
No.