



FED. ROAD DIST. NO.	STATE	FED. AID PROJ. NO.	FISCAL YEAR	SHEET NO.	TOTAL SHEETS
HAWAII	HAW.	F-099-1(2)	1968	2	10

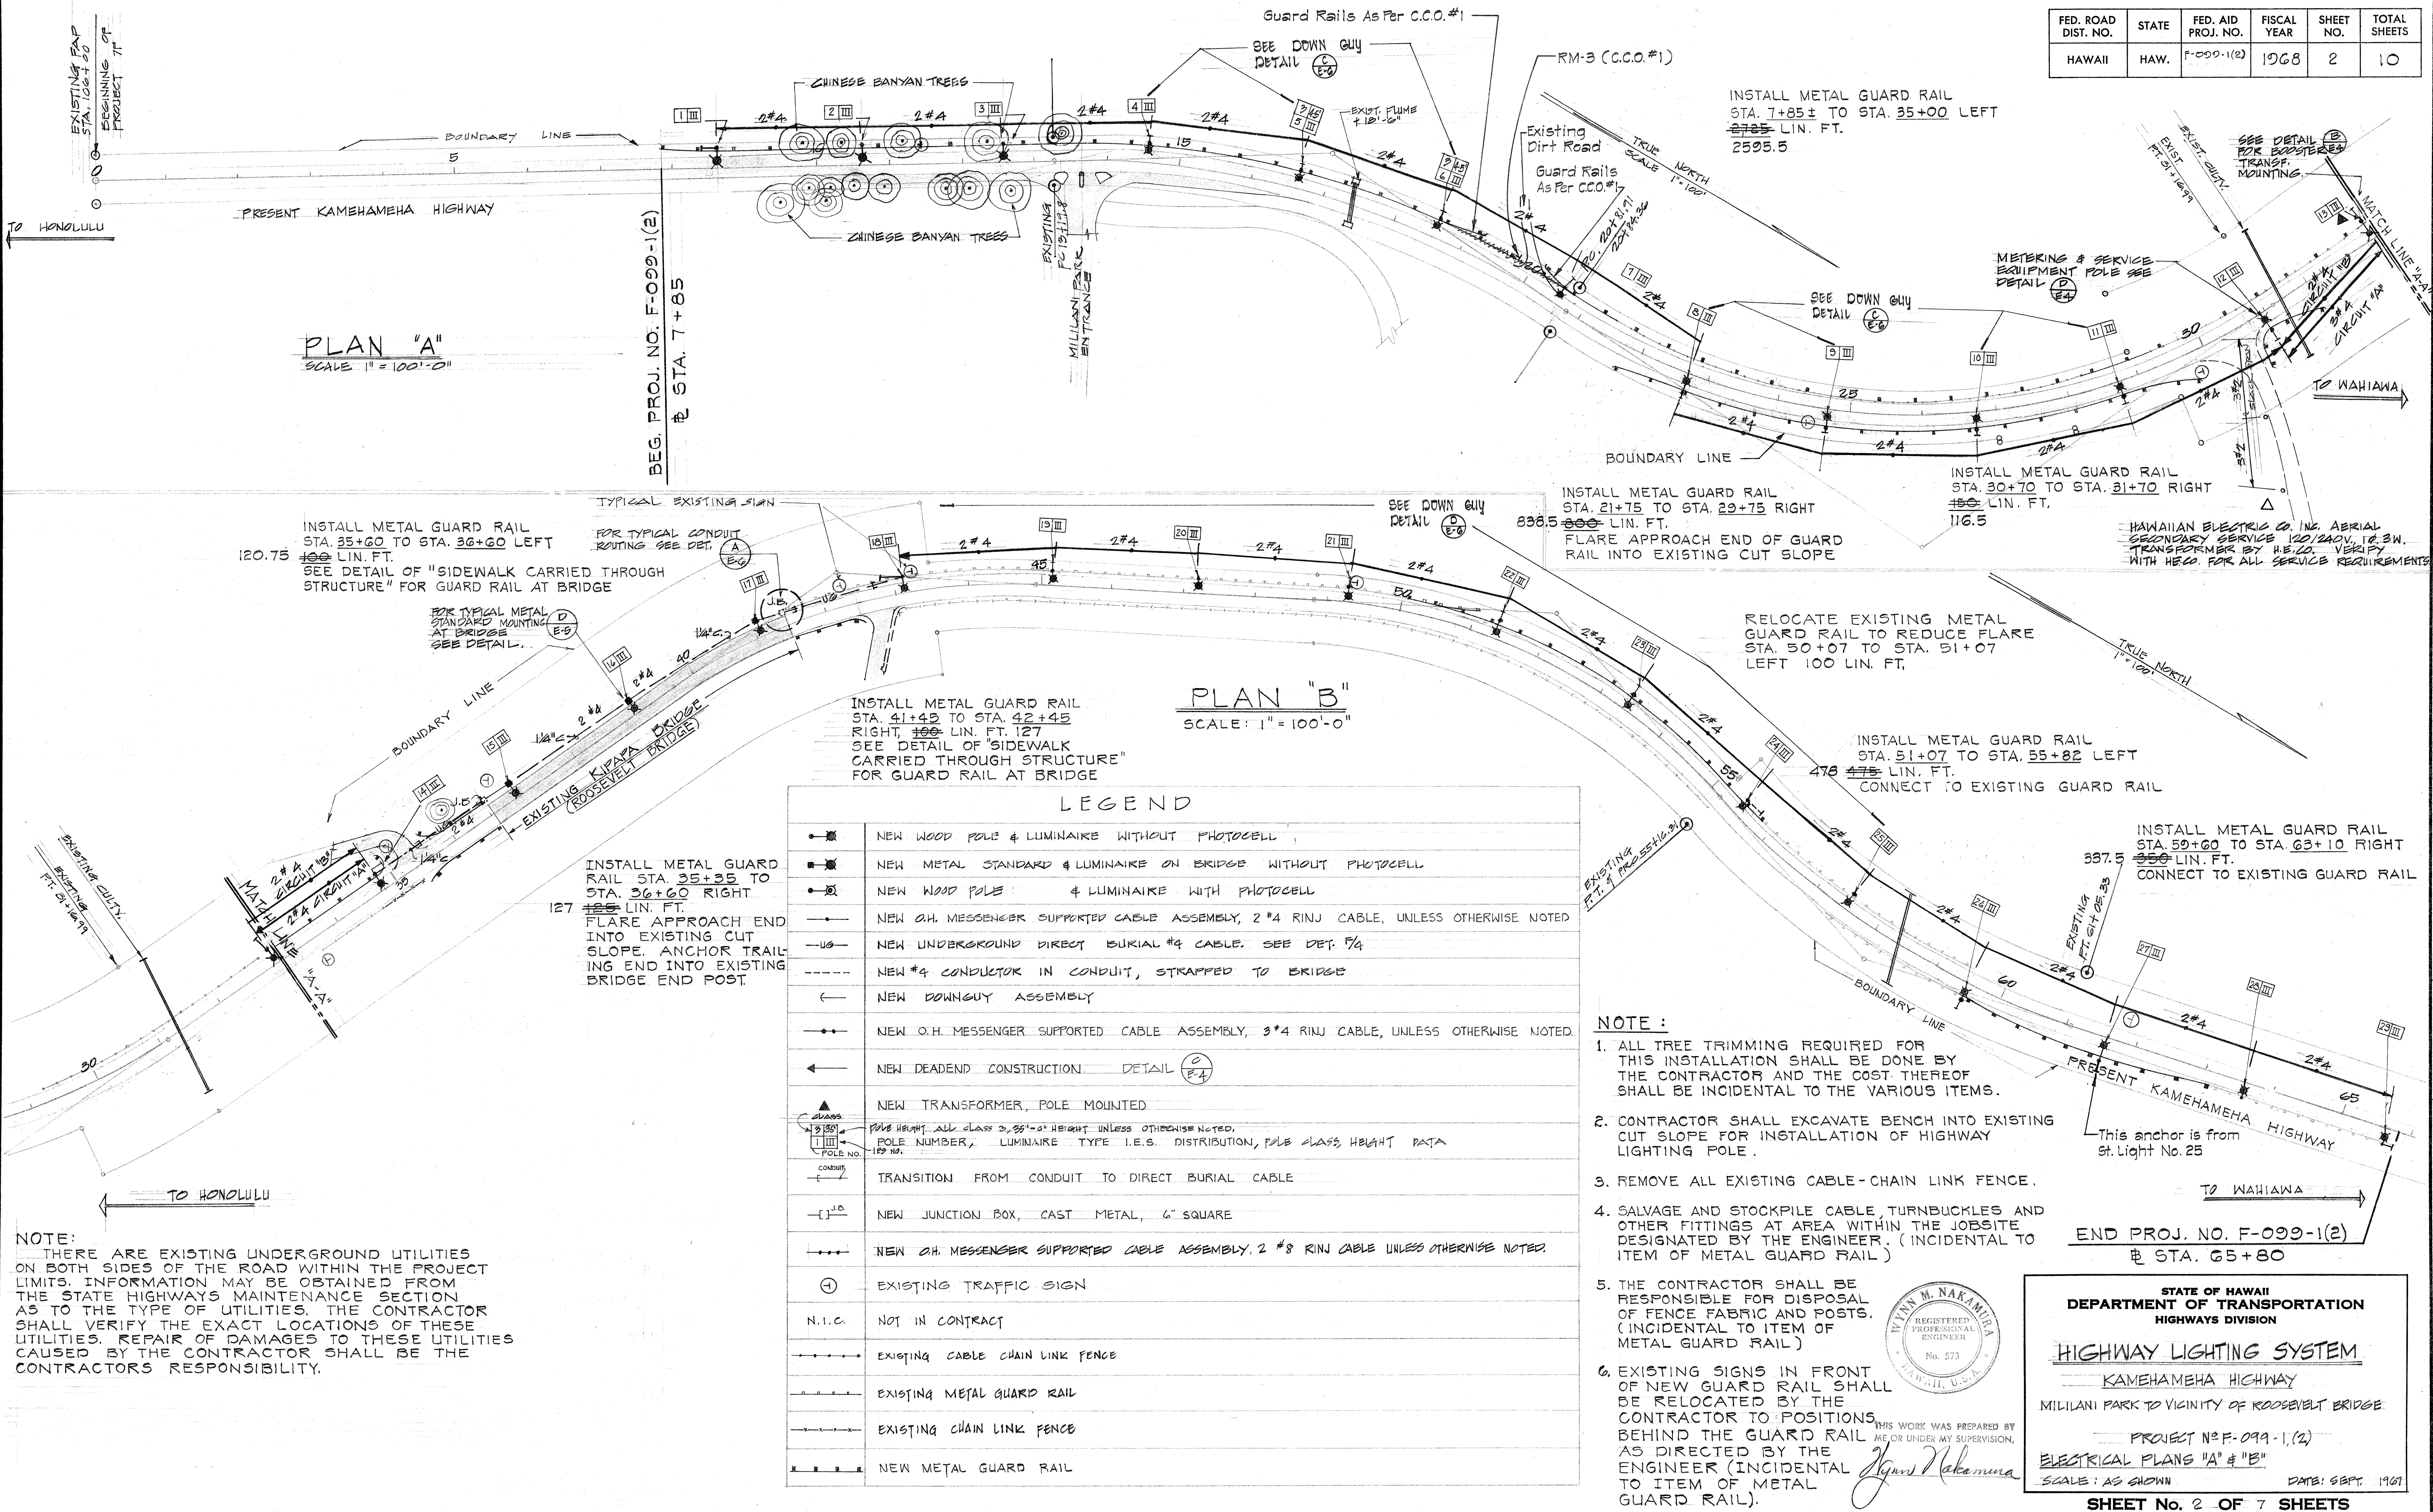


DD-Q-7

FED. ROAD DIST. NO.	STATE	FED. AID PROJ. NO.	FISCAL YEAR	SHEET NO.	TOTAL SHEETS
HAWAII	HAW.	F-000-1(2)	1968	3	10

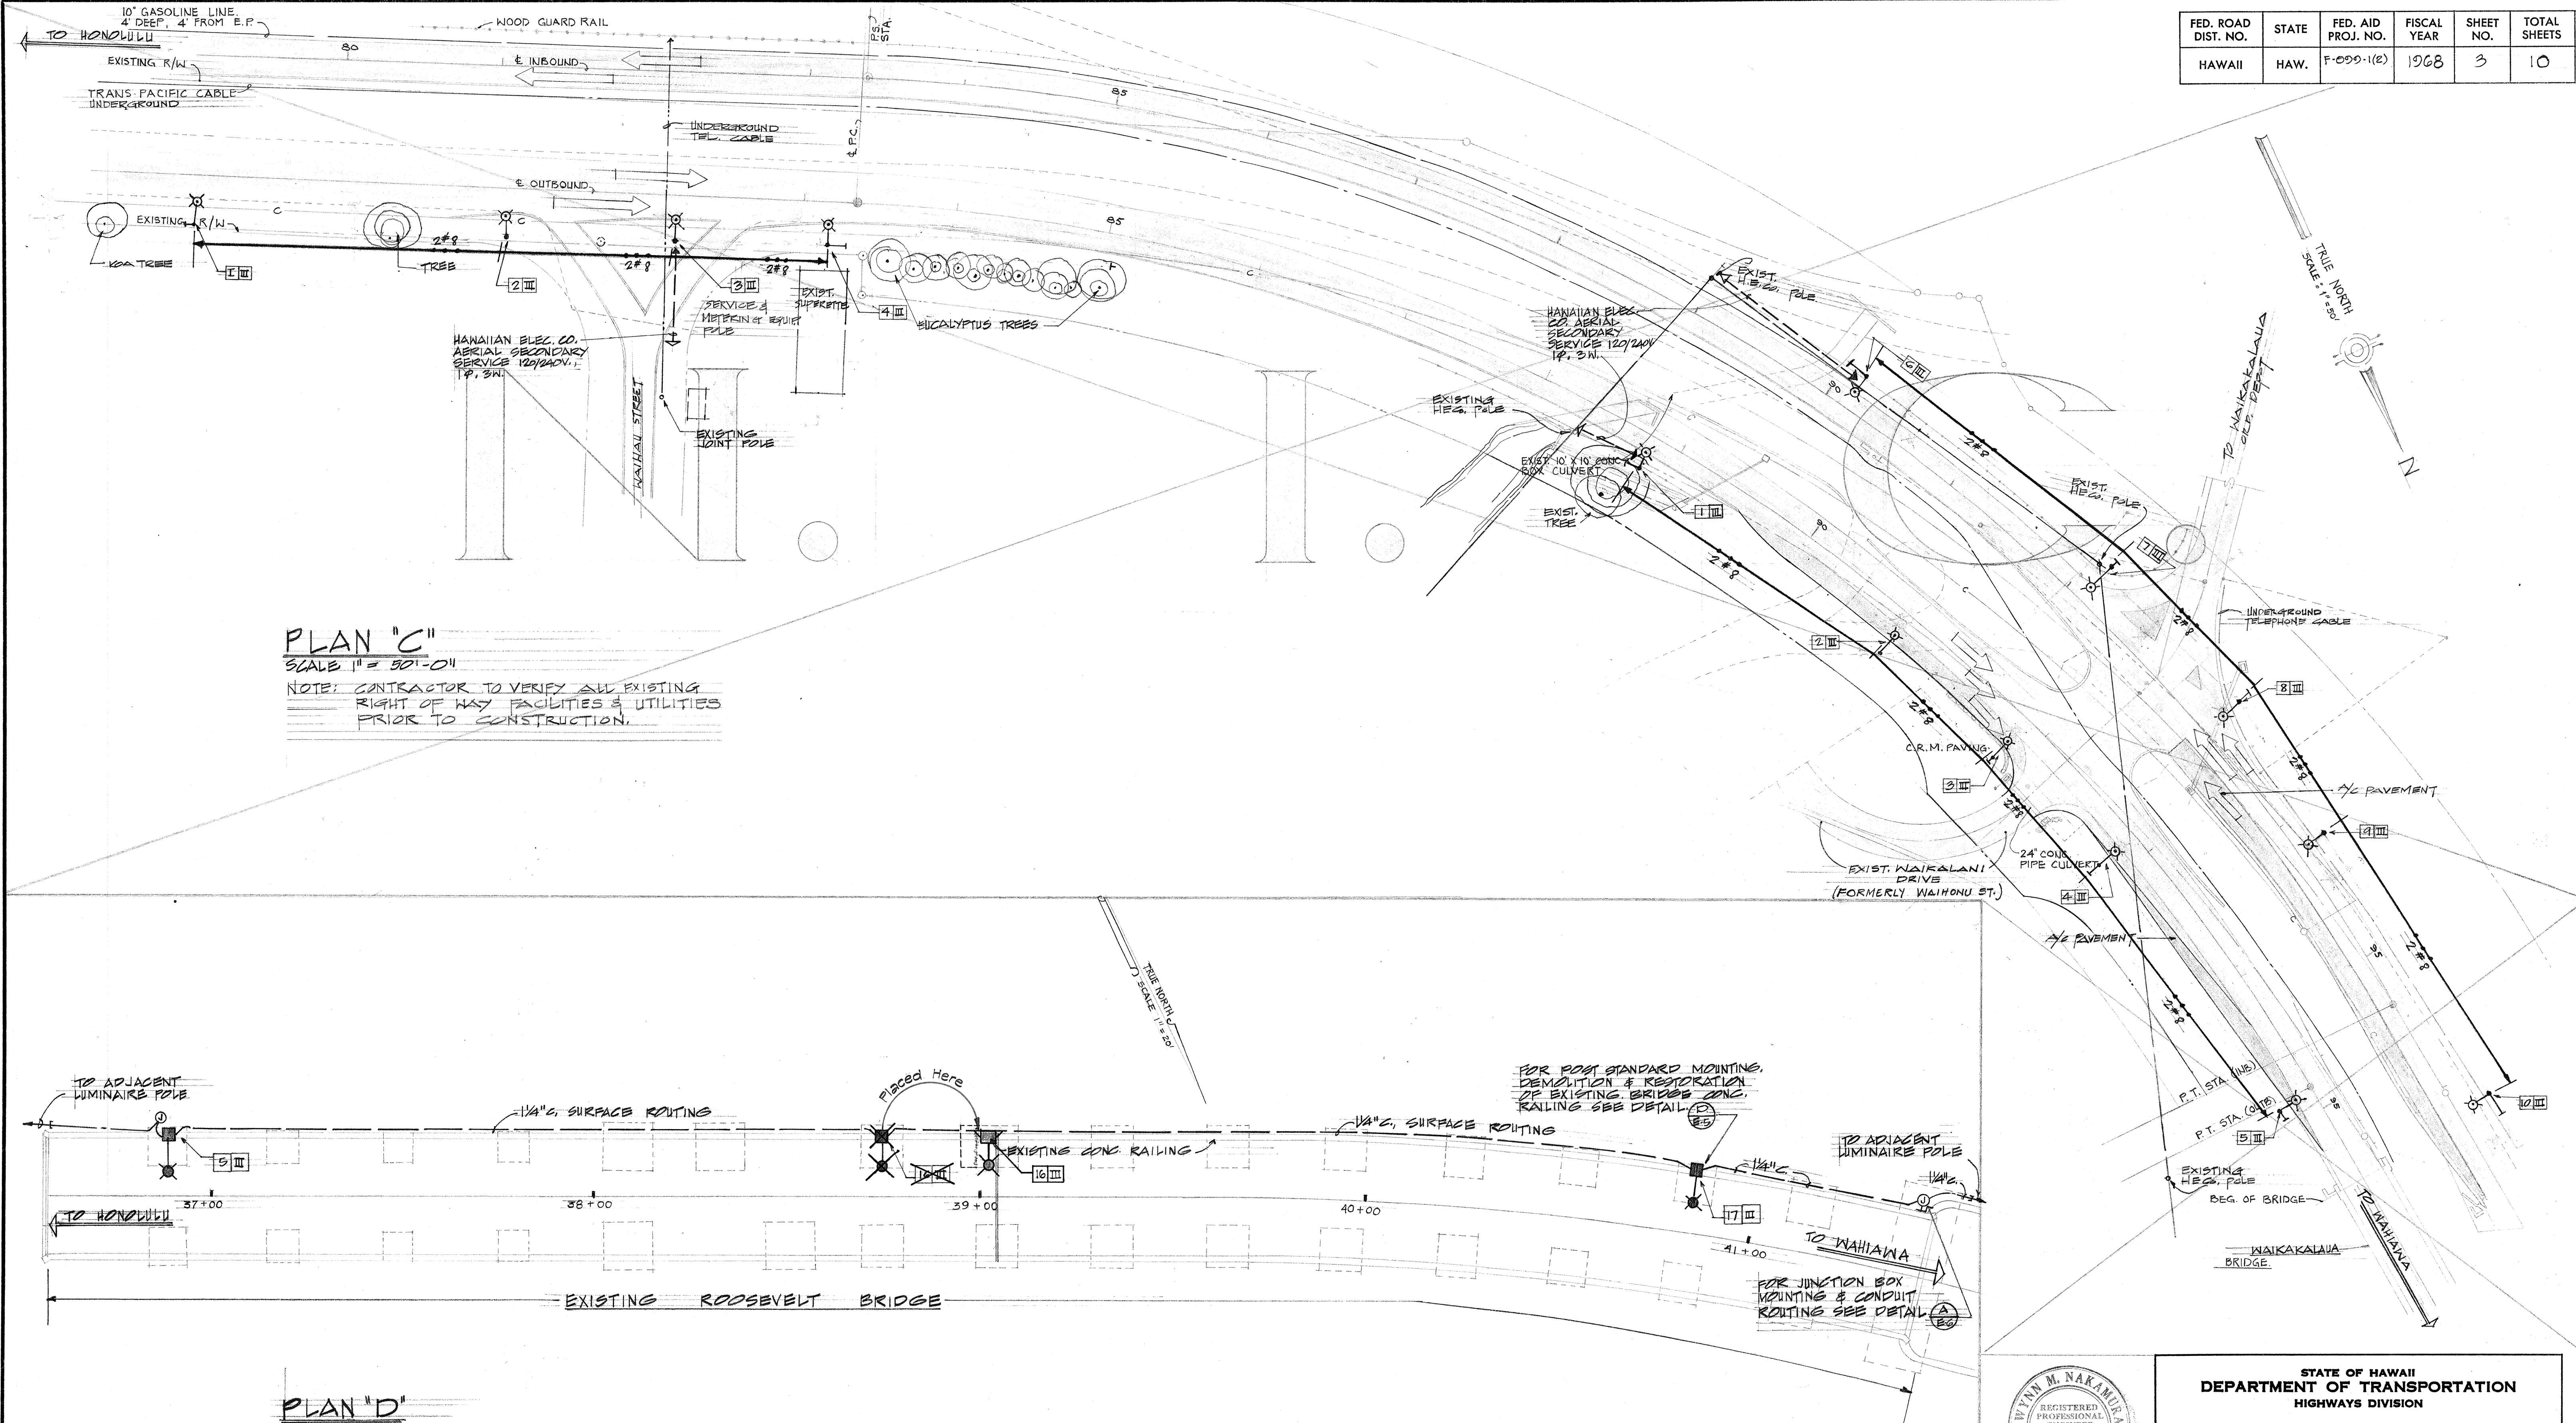

ORIGINAL PLAN	SURVEY PLOTTED BY	DATE
NOTE BOOK	DRAWN BY	DESIGNED BY
NO.	QUANTITIES BY	CHECKED BY

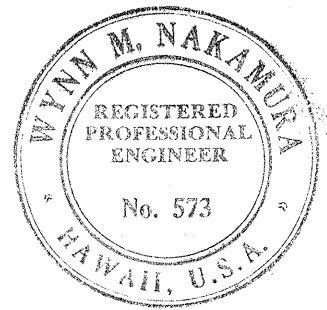

THIS WORK WAS PREPARED BY
ME OR UNDER MY SUPERVISION.

Wind M. Nakamura

STATE OF HAWAII
DEPARTMENT OF TRANSPORTATION
HIGHWAYS DIVISION

HIGHWAY LIGHTING SYSTEM

KAMEHAMEHA HIGHWAY

MILILANI PARK TO VICINITY OF ROOSEVELT BRIDGE
PROJECT NO F-000-1(2)

ELECTRICAL PLAN "D"

SCALE: AS SHOWN DATE: SEPT. 1967

SHEET No. 3 OF 7 SHEETS