


INDEX TO DRAWINGS	
SHT.NO	DESCRIPTION
1	Title Sheet
2	Layout Plan
3	Boring Plan
4	Construction Phasing
5-6	Typical Roadway Sections
	Plan and Profile
7-8	H-1 Inbound & H-1 Outbound
9	H-1 Outb. to H-2 Outb. & H-2 Inb. to H-1 Inb.
10	H-1 Inbound to H-2 Outbound
11	Ramp "B"
12	Loop #5
13	Temporary Connector #2 & BUS STOPS
14-16	Superelevation Diagrams
17-18	Intersection Details
19-19A	Miscellaneous Details
20-31	Grading and Drainage Plans & Details
32-34	Traffic Detours
35-57	Traffic Signs and Pavement Markers
58-61	Guard Rails Details
62-64	Retaining Wall Plan & Profile & Details
65	Chain Link Fence Details
66-76	Electrical Plans & Details
77-89	Structure No. 5
90-98	Structure No. 6
99-103	Structure No. 8
104-112	Standard Structure Details
113-144	Cross Sections

STATE OF HAWAII
DEPARTMENT OF TRANSPORTATION
HIGHWAYS DIVISION
HONOLULU, HAWAII
"AS BUILT"
PLANS FOR
CONSTRUCTION OF A PORTION OF
INTERSTATE ROUTE H-1
WAIWA INTERCHANGE

FEDERAL AID INTERSTATE PROJECT No. I-HI-1(69):8

DISTRICT OF EWA
ISLAND OF OAHU

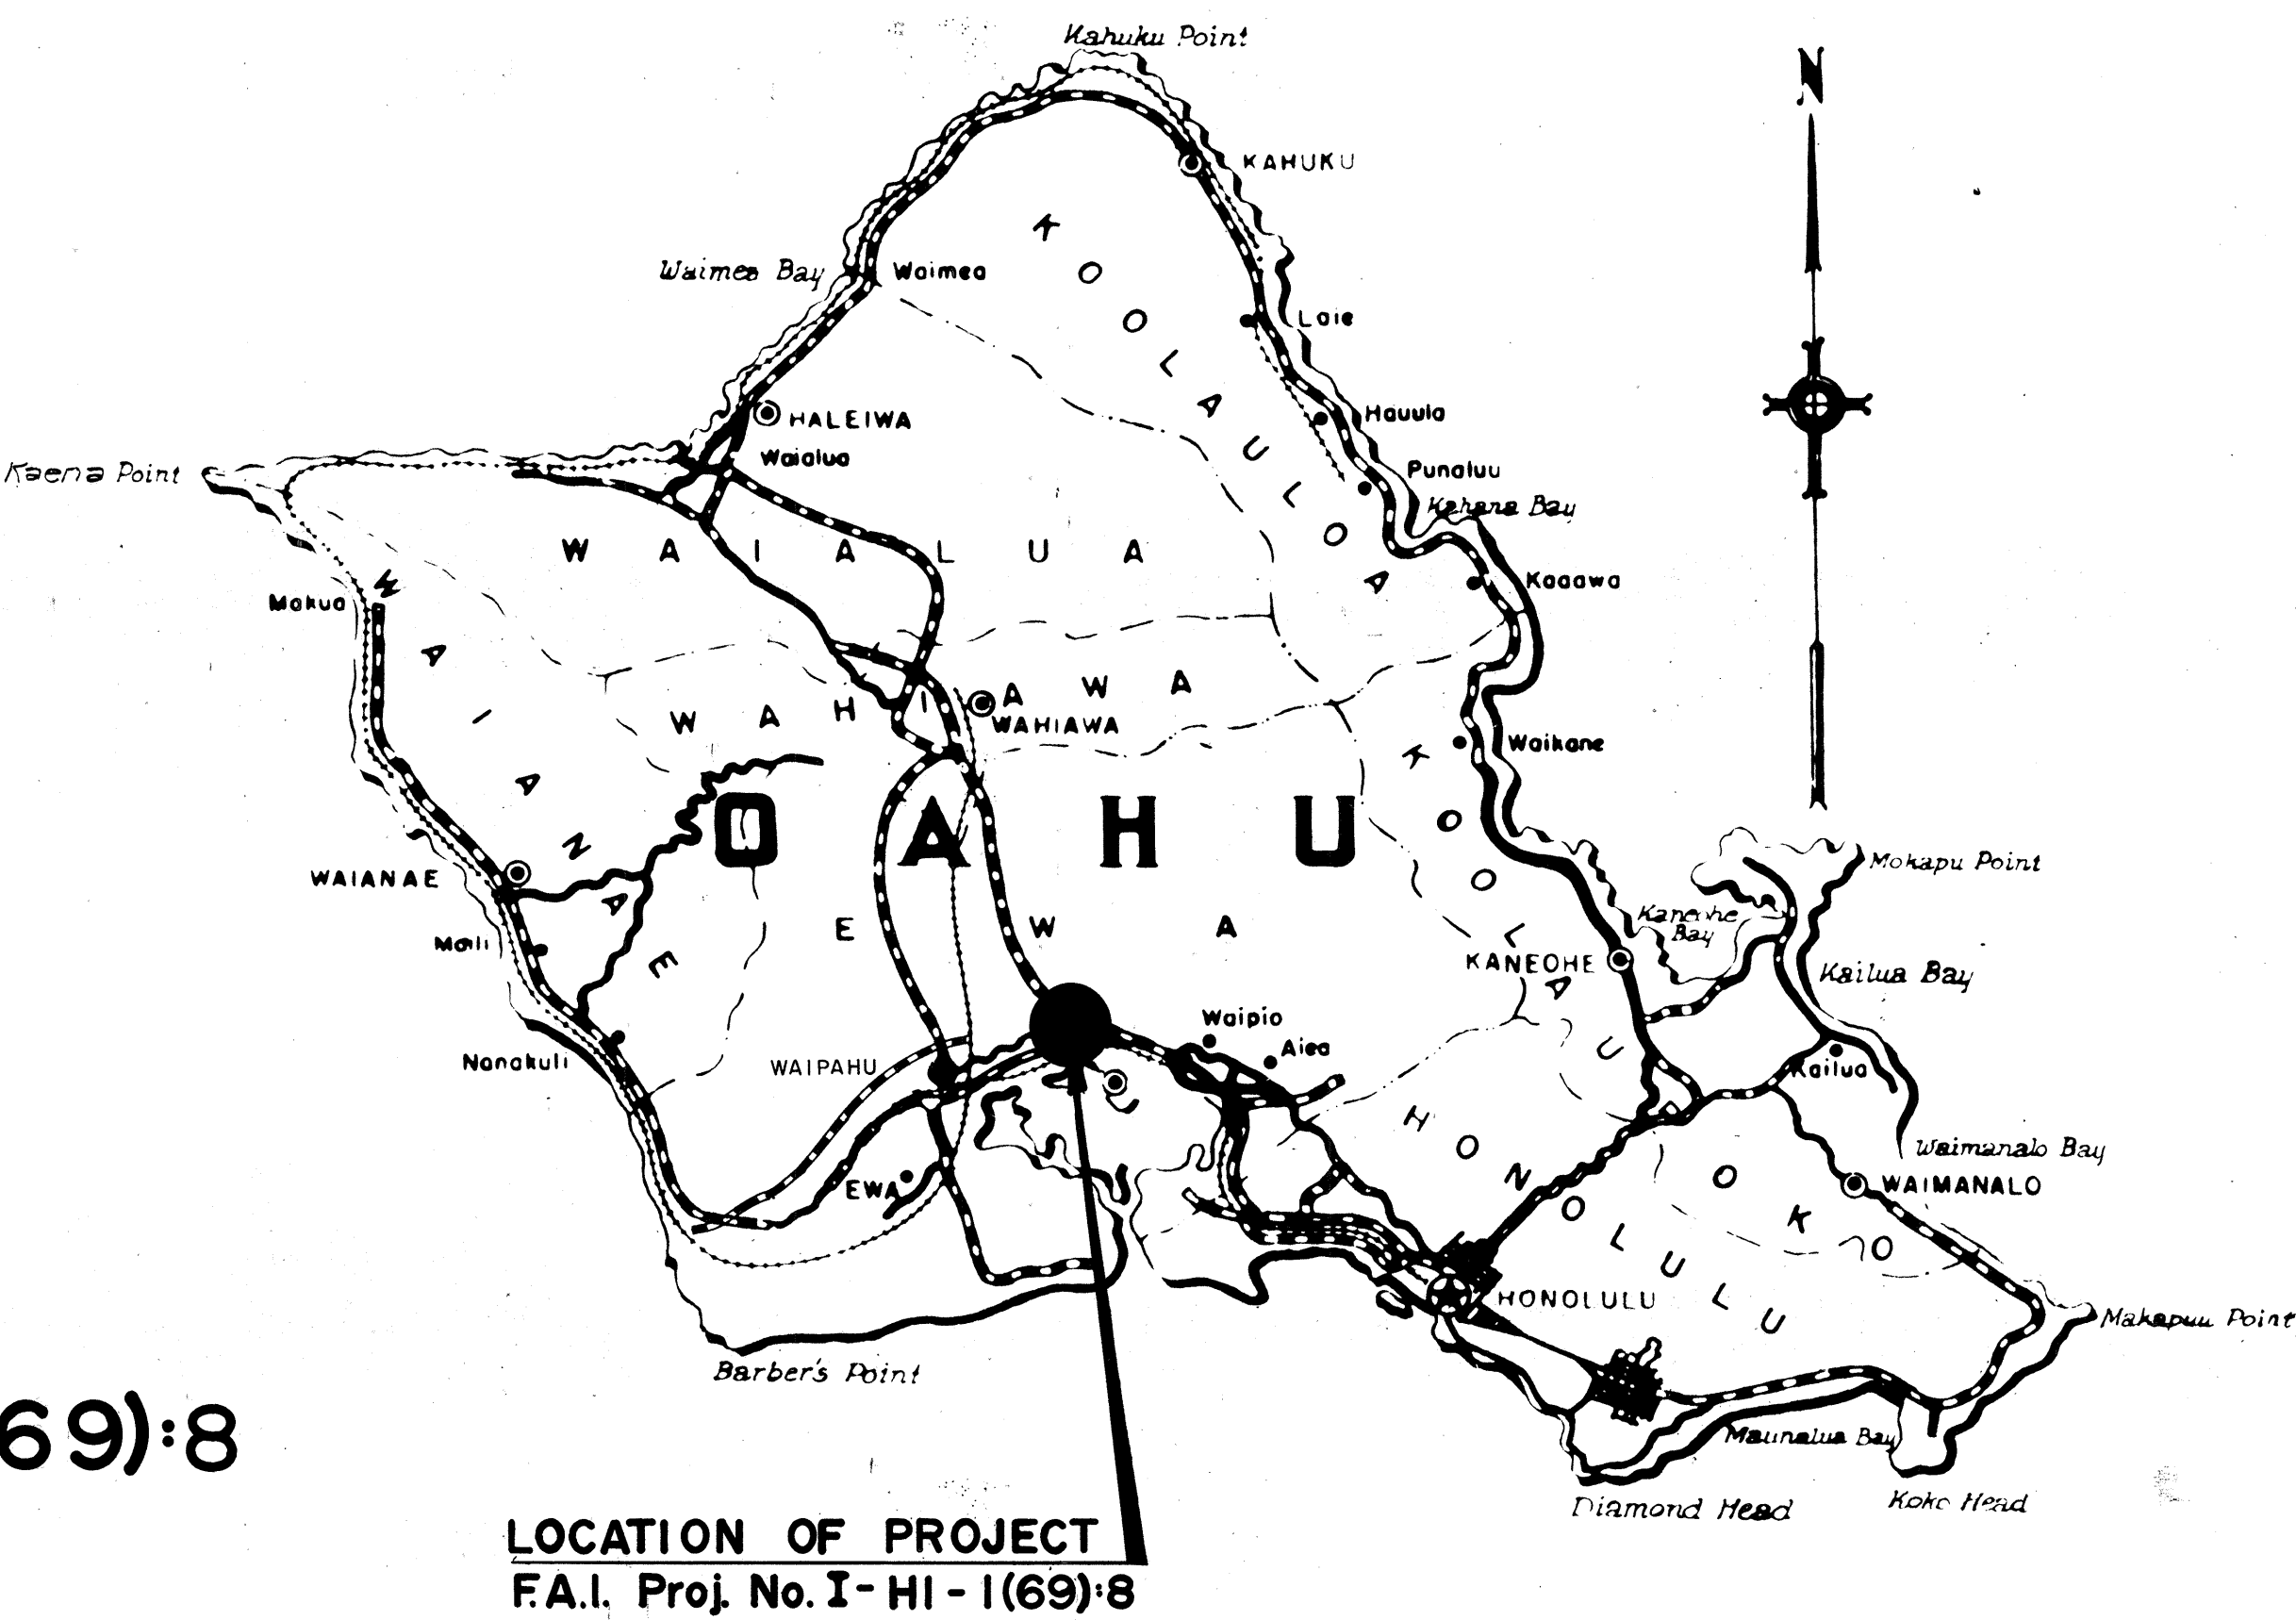

Federal Aid Projects Previously Constructed Or Under Construction

NOTE:
ALL CHANGES MADE DURING
CONSTRUCTION HAVE BEEN
NOTED IN RED ON THESE
TRACINGS AND CHECKED BY

Thomas K. Brown
DISTRICT ENGINEER
August 07, 1972
DATE

SCALES:

PLAN & PROFILE HOR. 1" = 50'
VER. 1" = 10'
DETAIL ROADWAY PLAN 1" = 20'
CROSS SECTION HOR. 1" = 10'
VER. 1" = 10'

DESIGN CLASSIFICATION

DESIGN ADT (1988)..... 42,150
DHV..... 11%
D..... 65/35
T..... 3.5 %
V..... 70 m.p.h.

APPROVED: Date: 11/26/68

E. Henry Wright
DIRECTOR OF TRANSPORTATION

DEPARTMENT OF TRANSPORTATION
BUREAU OF PUBLIC ROADS
APPROVED: *Paul D. [Signature]* 1-8-69
DIVISION ENGINEER DATE

DATE: 10/1/68
DRAWN BY: K. Wong
CHECKED BY: [Signature]
NOTED BY: [Signature]
ORIGINAL PLAN: [Signature]
NOTE BOOK: [Signature]