


FED. ROAD DIST. NO.	STATE	PROJ. NO.	FISCAL YEAR	SHEET NO.	TOTAL SHEETS
HAWAII	HAW.	99E-01-03	2004	10	12

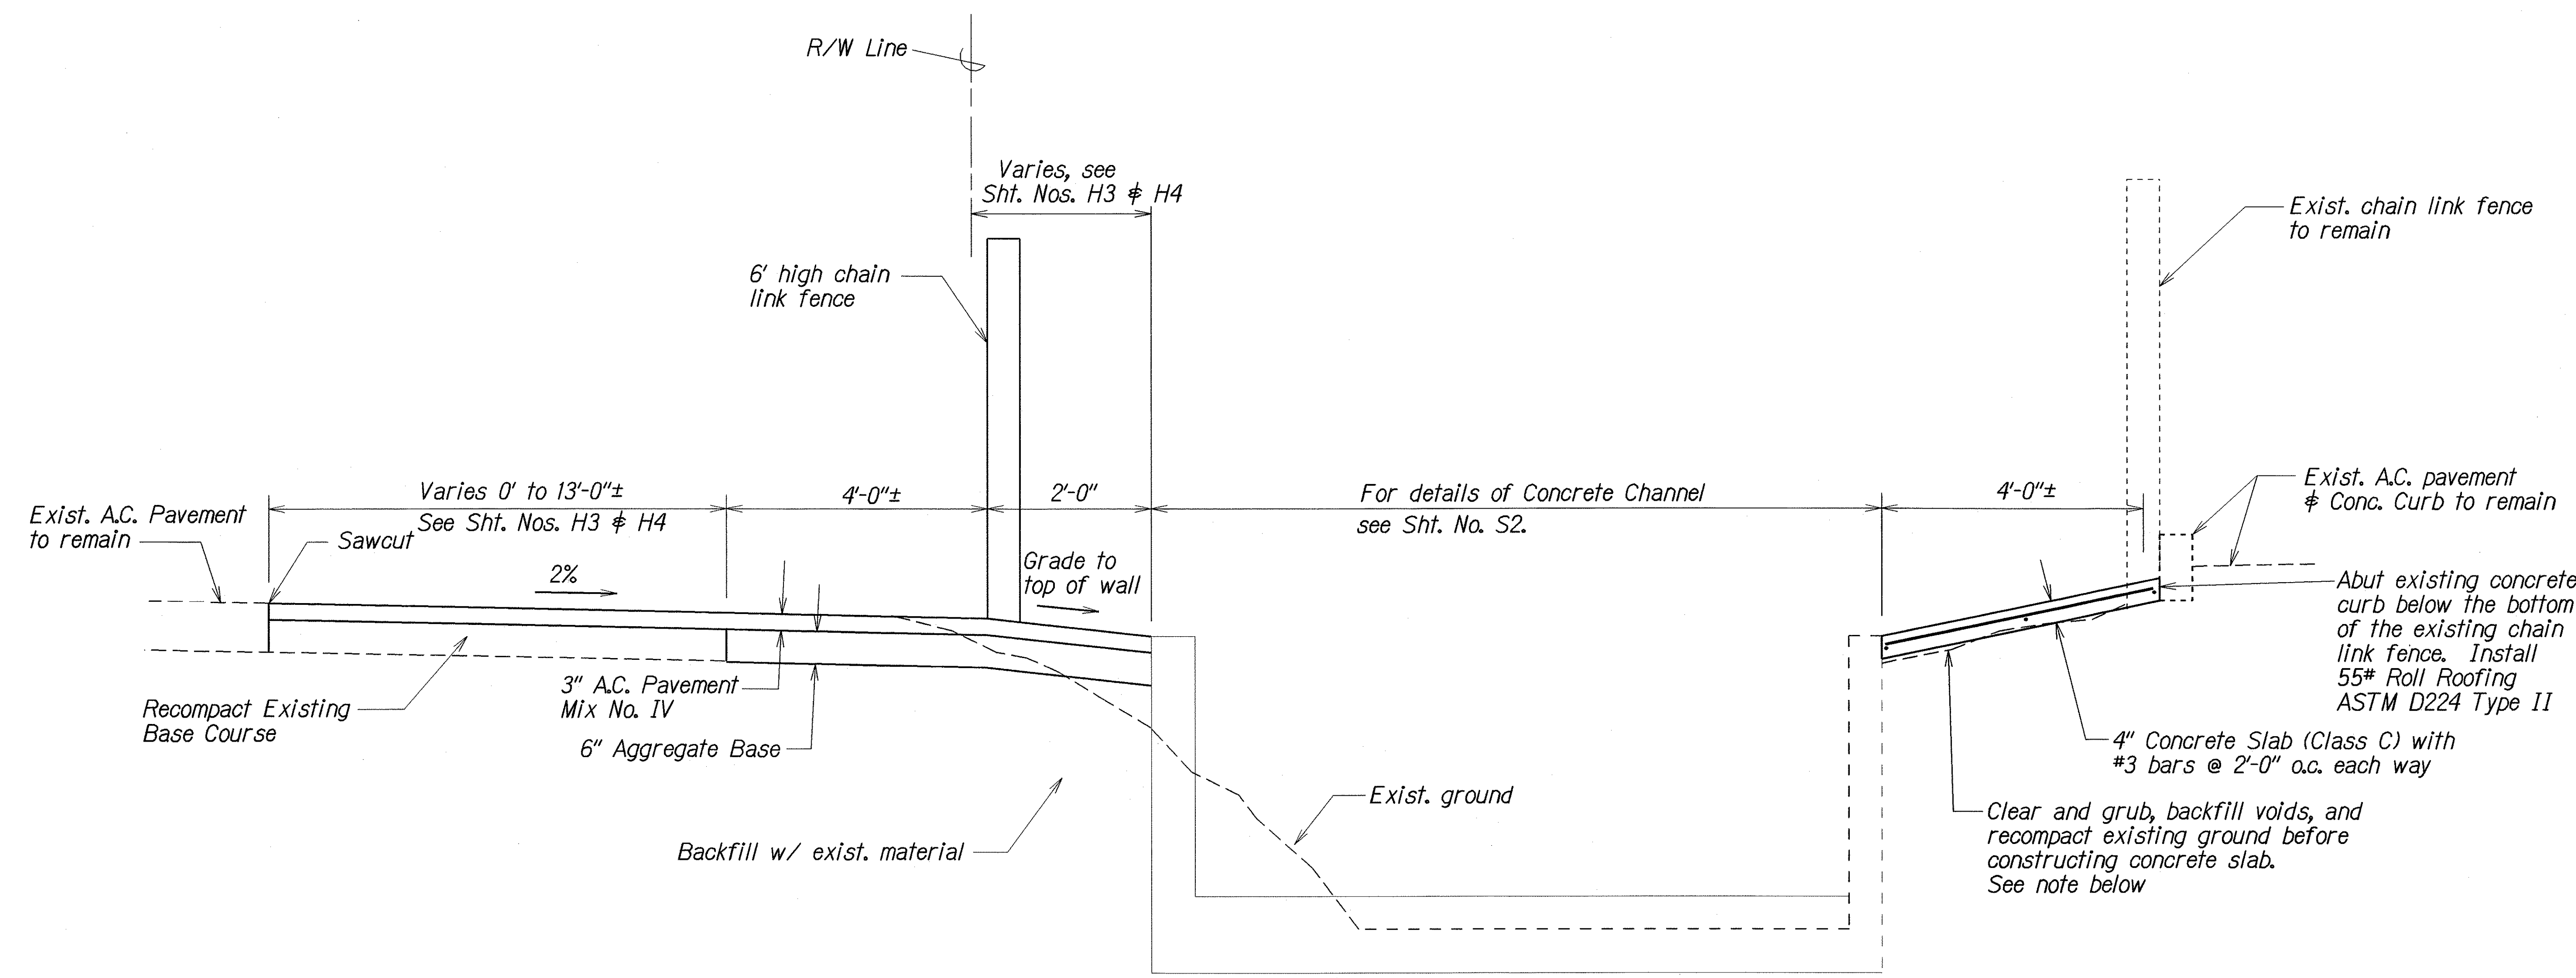

TYPICAL SECTION OF A.C. PAVEMENT AND CONCRETE SLAB

**Note:**  
Contractor shall compact soil after concrete channel has been constructed. The existing wall shall be braced against the new wall during the compaction of the soil behind the wall.

ORIGINAL PLAN	SURVEY PLOTTED BY	DATE
NOTES	DRAWN BY	12/15/03
DESIGNED BY	CHECKED BY	
APPROVED BY		

STATE OF HAWAII  
DEPARTMENT OF TRANSPORTATION  
HIGHWAYS DIVISION

**AC. PAVEMENT & CONCRETE SLAB DETAILS**  
KAMEHAMEHA HIGHWAY DRAINAGE IMPROVEMENTS  
Vicinity of Wai'au Power Plant  
Project No. 99E-01-03  
Scale: 3/4"=1'-0" Date: Aug. 2003  
SHEET No. H5 OF 5 SHEETS