


FED. ROAD DIST. NO.	STATE	PROJ. NO.	FISCAL YEAR	SHEET NO.	TOTAL SHEETS
HAWAII	HAW.	99E-01-03	2004	6	12

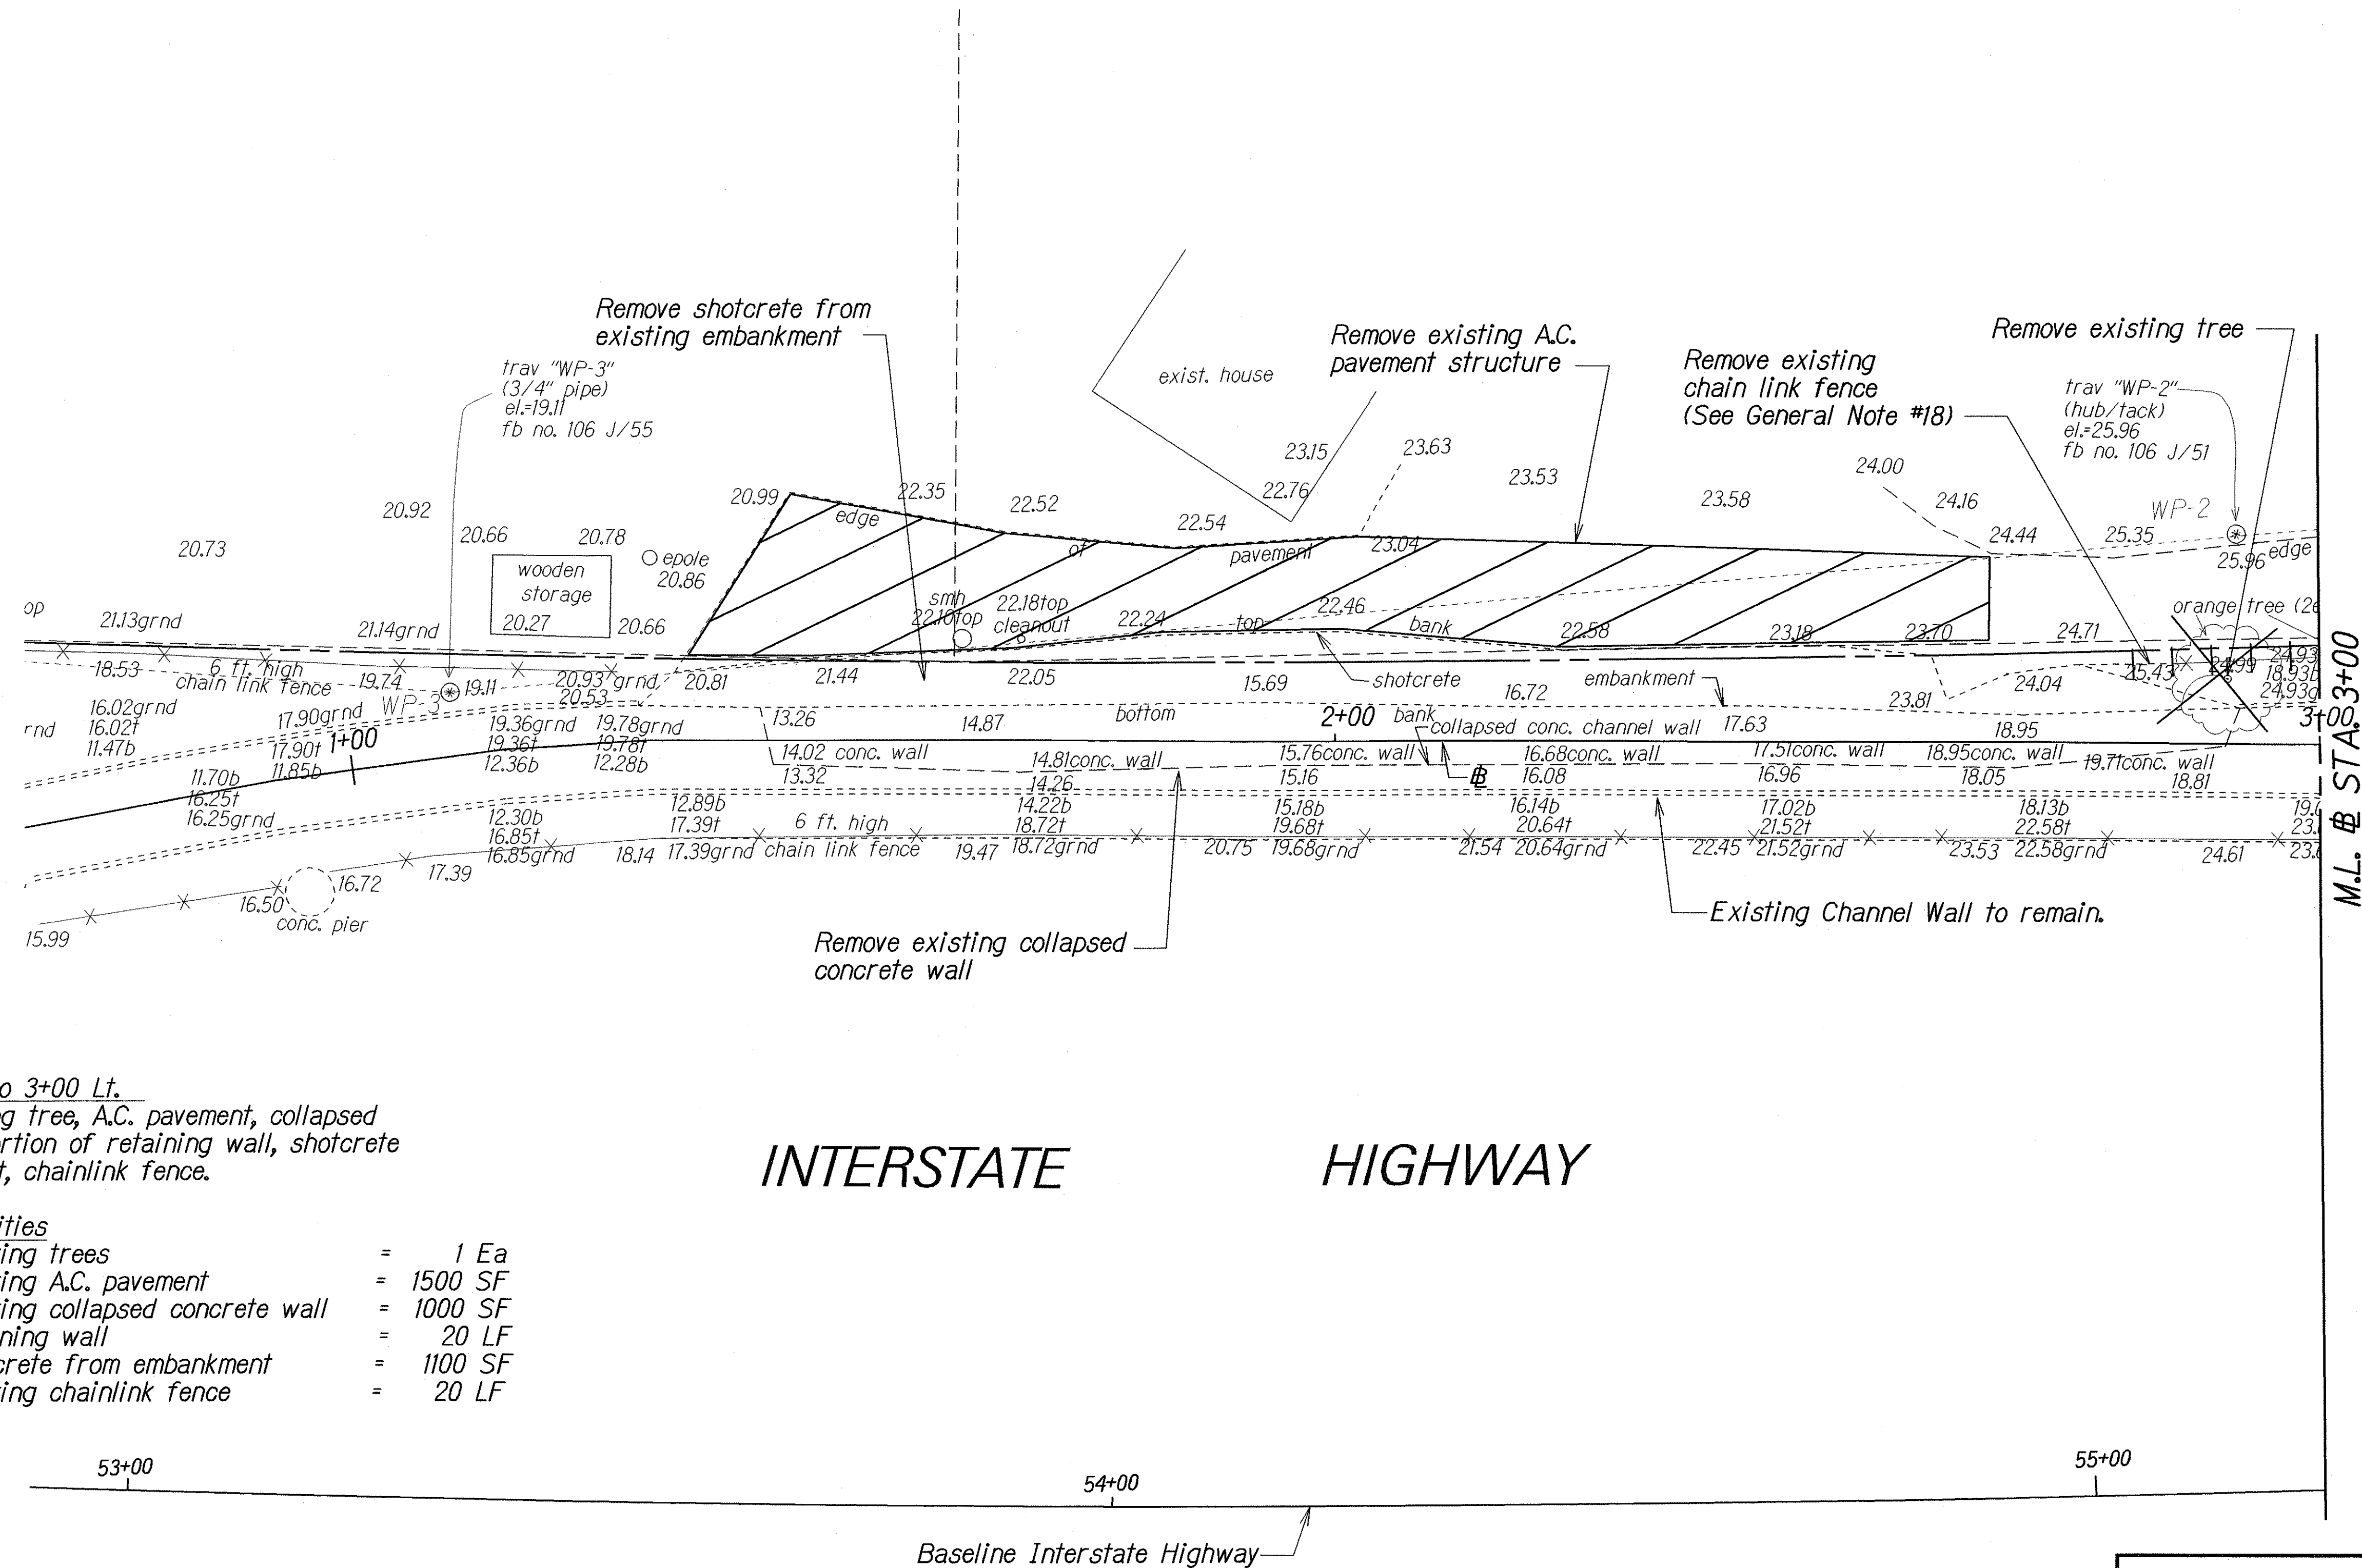

Sta. 0+81 Lt. to 3+00 Lt.

Remove: Existing tree, A.C. pavement, collapsed concrete wall, portion of retaining wall, shotcrete from embankment, chainlink fence.

Estimated Quantities

Removal of existing trees	=	1 Ea
Removal of existing A.C. pavement	=	1500 SF
Removal of existing collapsed concrete wall	=	1000 SF
Removal of retaining wall	=	20 LF
Removal of shotcrete from embankment	=	1100 SF
Removal of existing chainlink fence	=	20 LF

ORIGINAL PLAN	SURVEY PLOTTED BY	DATE
NOTE BOOK	DRAWN BY	4/10/03
CH. # 81	TRACED BY	
QUANTITIES BY		
CHECKED BY		

STATE OF HAWAII DEPARTMENT OF TRANSPORTATION HIGHWAYS DIVISION
DEMOLITION PLAN
KAMEHAMEHA HIGHWAY DRAINAGE IMPROVEMENTS
Vicinity of Wai'au Power Plant
Project No. 99E-01-03
Scale: 1"=10' Date: Aug. 2003
SHEET No. HI OF 5 SHEETS

STATE OF HAWAII
DEPARTMENT OF TRANSPORTATION
HIGHWAYS DIVISION

DEMOLITION PLAN

KAMEHAMEHA HIGHWAY DRAINAGE IMPROVEMENTS

Vicinity of Wai'au Power Plant

Project No. 99E-01-03

Scale: 1"=10' Date: Aug. 2003

SHEET No. H2 OF 5 SHEETS

