


FED. ROAD DIST. NO.	STATE	PROJ. NO.	FISCAL YEAR	SHEET NO.	TOTAL SHEETS
OAHU	HAW.	99C-01-13	2014	34	41

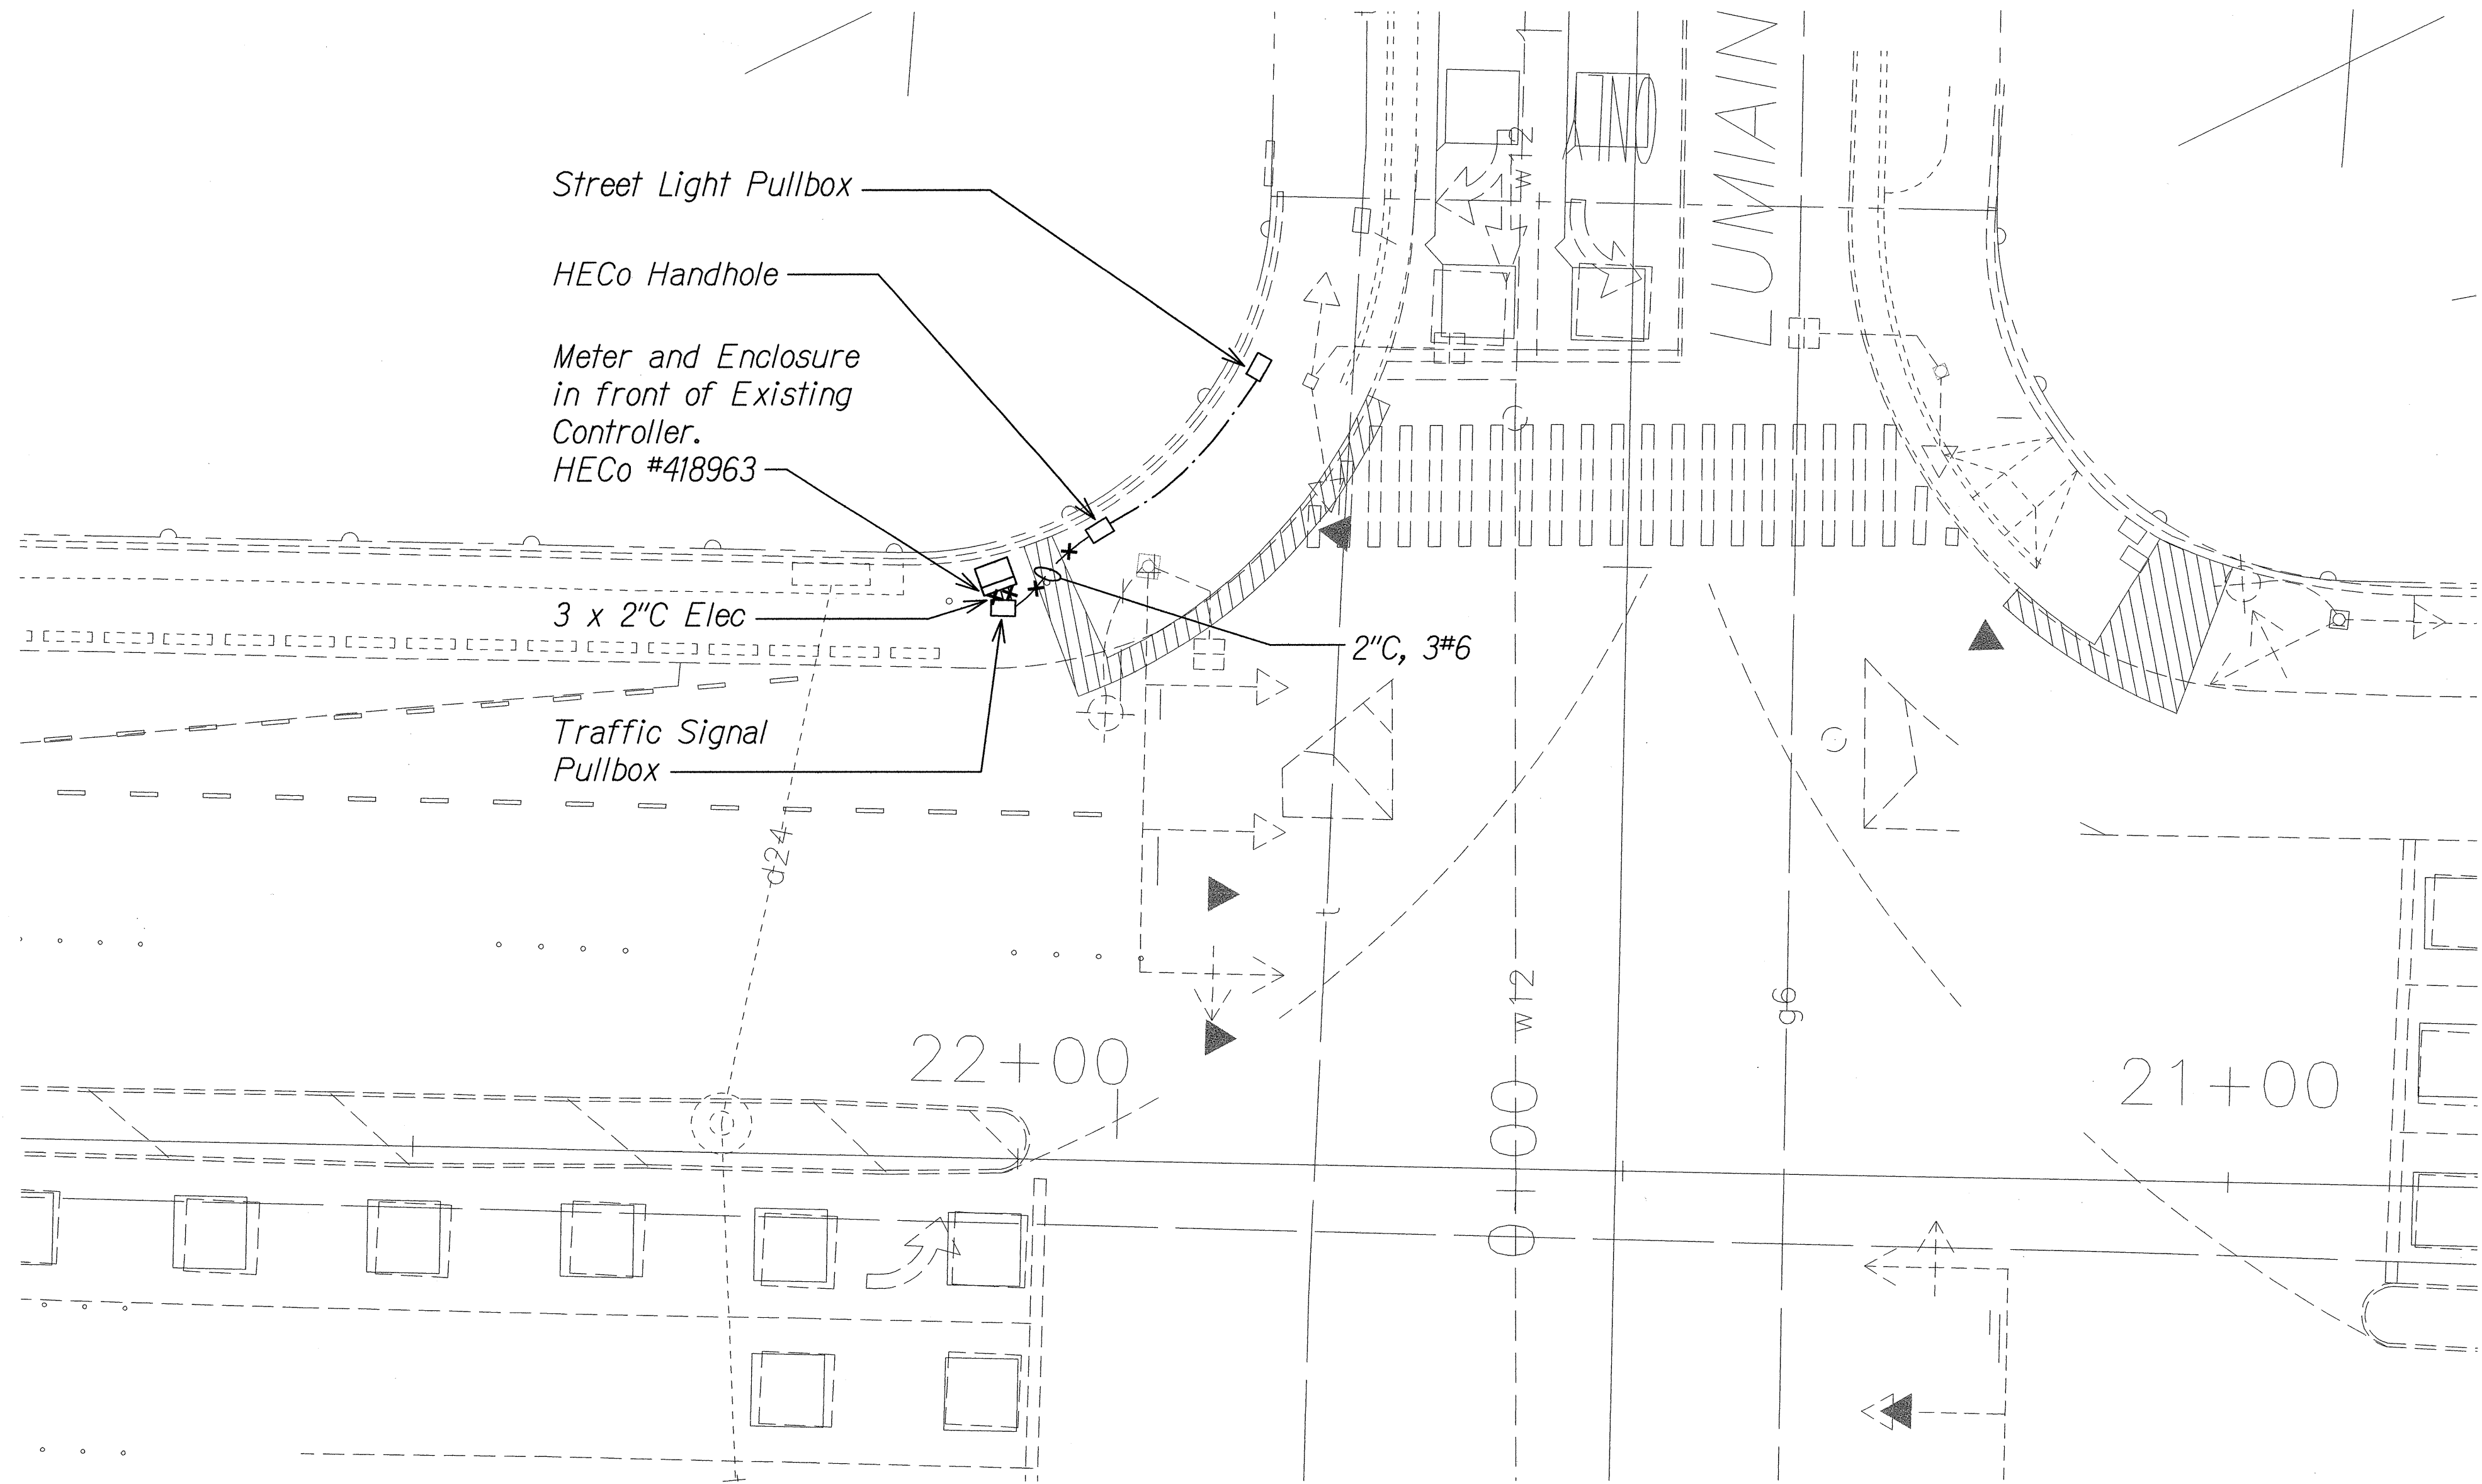



SITE ELECTRICAL DEMOLITION PLAN

SCALE: 1" = 10'-0"

NOTES:

1. ——— Light Lines Denote Existing Condition
—*—*—"X" Denotes Removal Work
2. Refer to One-Line Diagram on Sheet **E-007** for Clarification.


SURVEY PLOTTED BY	DATE
DESIGNED BY	
QUANTITIES BY	
CHECKED BY	
ORIGINAL PLAN	
NOTE BOOK	
No.	

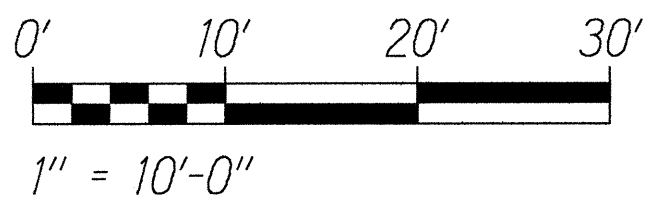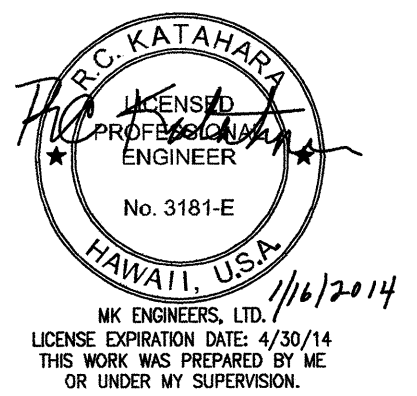

STATE OF HAWAII
DEPARTMENT OF TRANSPORTATION
HIGHWAYS DIVISION

SITE ELECTRICAL DEMOLITION PLAN
TRAFFIC OPERATIONAL IMPROVEMENTS
AT VARIOUS LOCATIONS
Vicinity of Kamehameha Highway and
Lumiaina Street
Project No. 99C-01-13
Scale: As Noted Date: Jan 2014
SHEET No. E-002 OF 9 SHEETS

FED. ROAD DIST. NO.	STATE	PROJ. NO.	FISCAL YEAR	SHEET NO.	TOTAL SHEETS
OAHU	HAW.	99C-01-13	2014	35	41

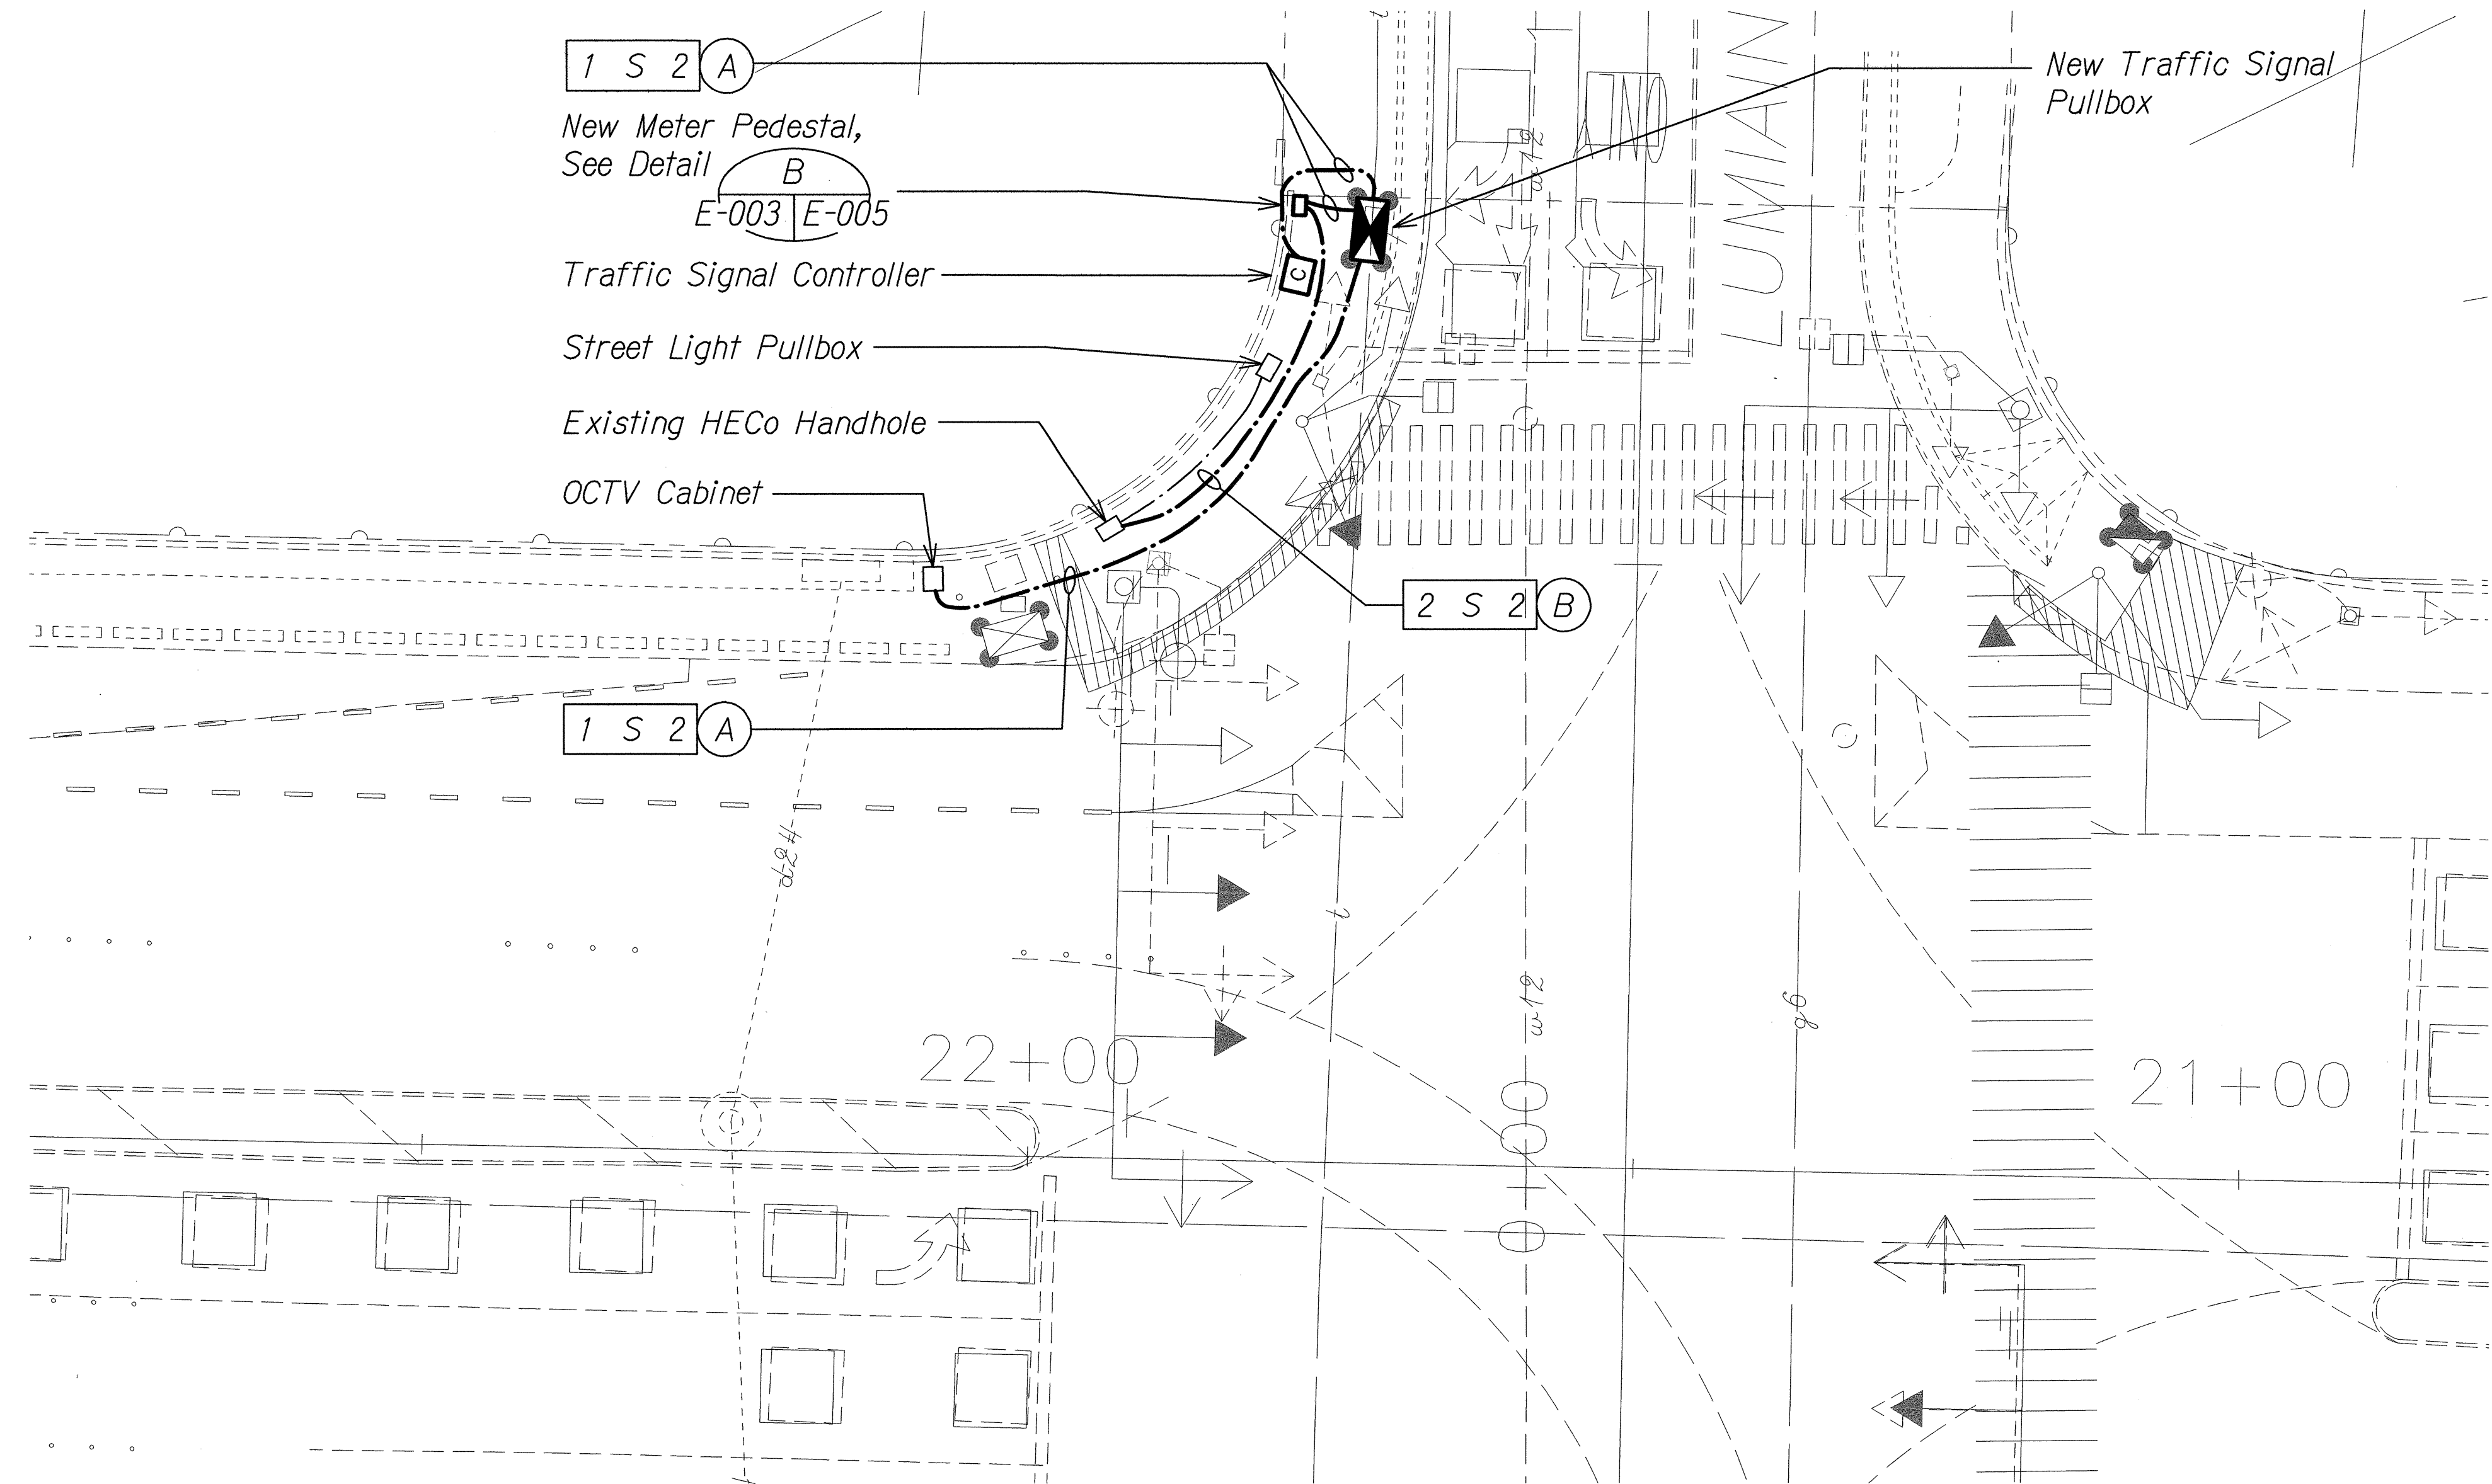



SITE ELECTRICAL PLAN

SCALE: 1" = 10'-0"

NOTES:

- Light Lines Denote Existing Condition
Bold Lines Denotes New Work
- Refer to One-Line Diagram on Sheet **E-007** for Clarification.


ORIGINAL PLAN	DATE
DESIGNED BY	
TRACED BY	
DESIGNED BY	
QUANTITIES BY	
CHECKED BY	
No.	

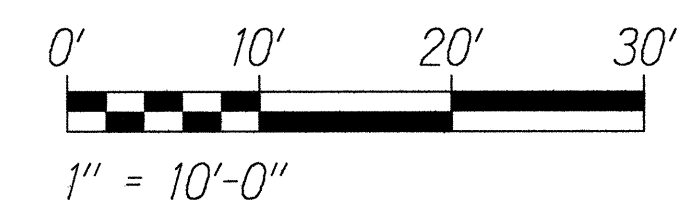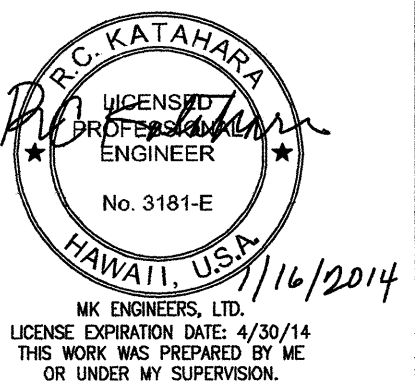

STATE OF HAWAII
DEPARTMENT OF TRANSPORTATION
HIGHWAYS DIVISION

SITE ELECTRICAL PLAN
TRAFFIC OPERATIONAL IMPROVEMENTS
AT VARIOUS LOCATIONS
Vicinity of Kamehameha Highway and
Lumiana Street
Project No. 99C-01-13
Scale: As Noted Date: Jan 2014
SHEET No. E-003 OF 9 SHEETS

FED. ROAD DIST. NO.	STATE	PROJ. NO.	FISCAL YEAR	SHEET NO.	TOTAL SHEETS
0AHU	HAW.	99C-01-13	2014	36	41

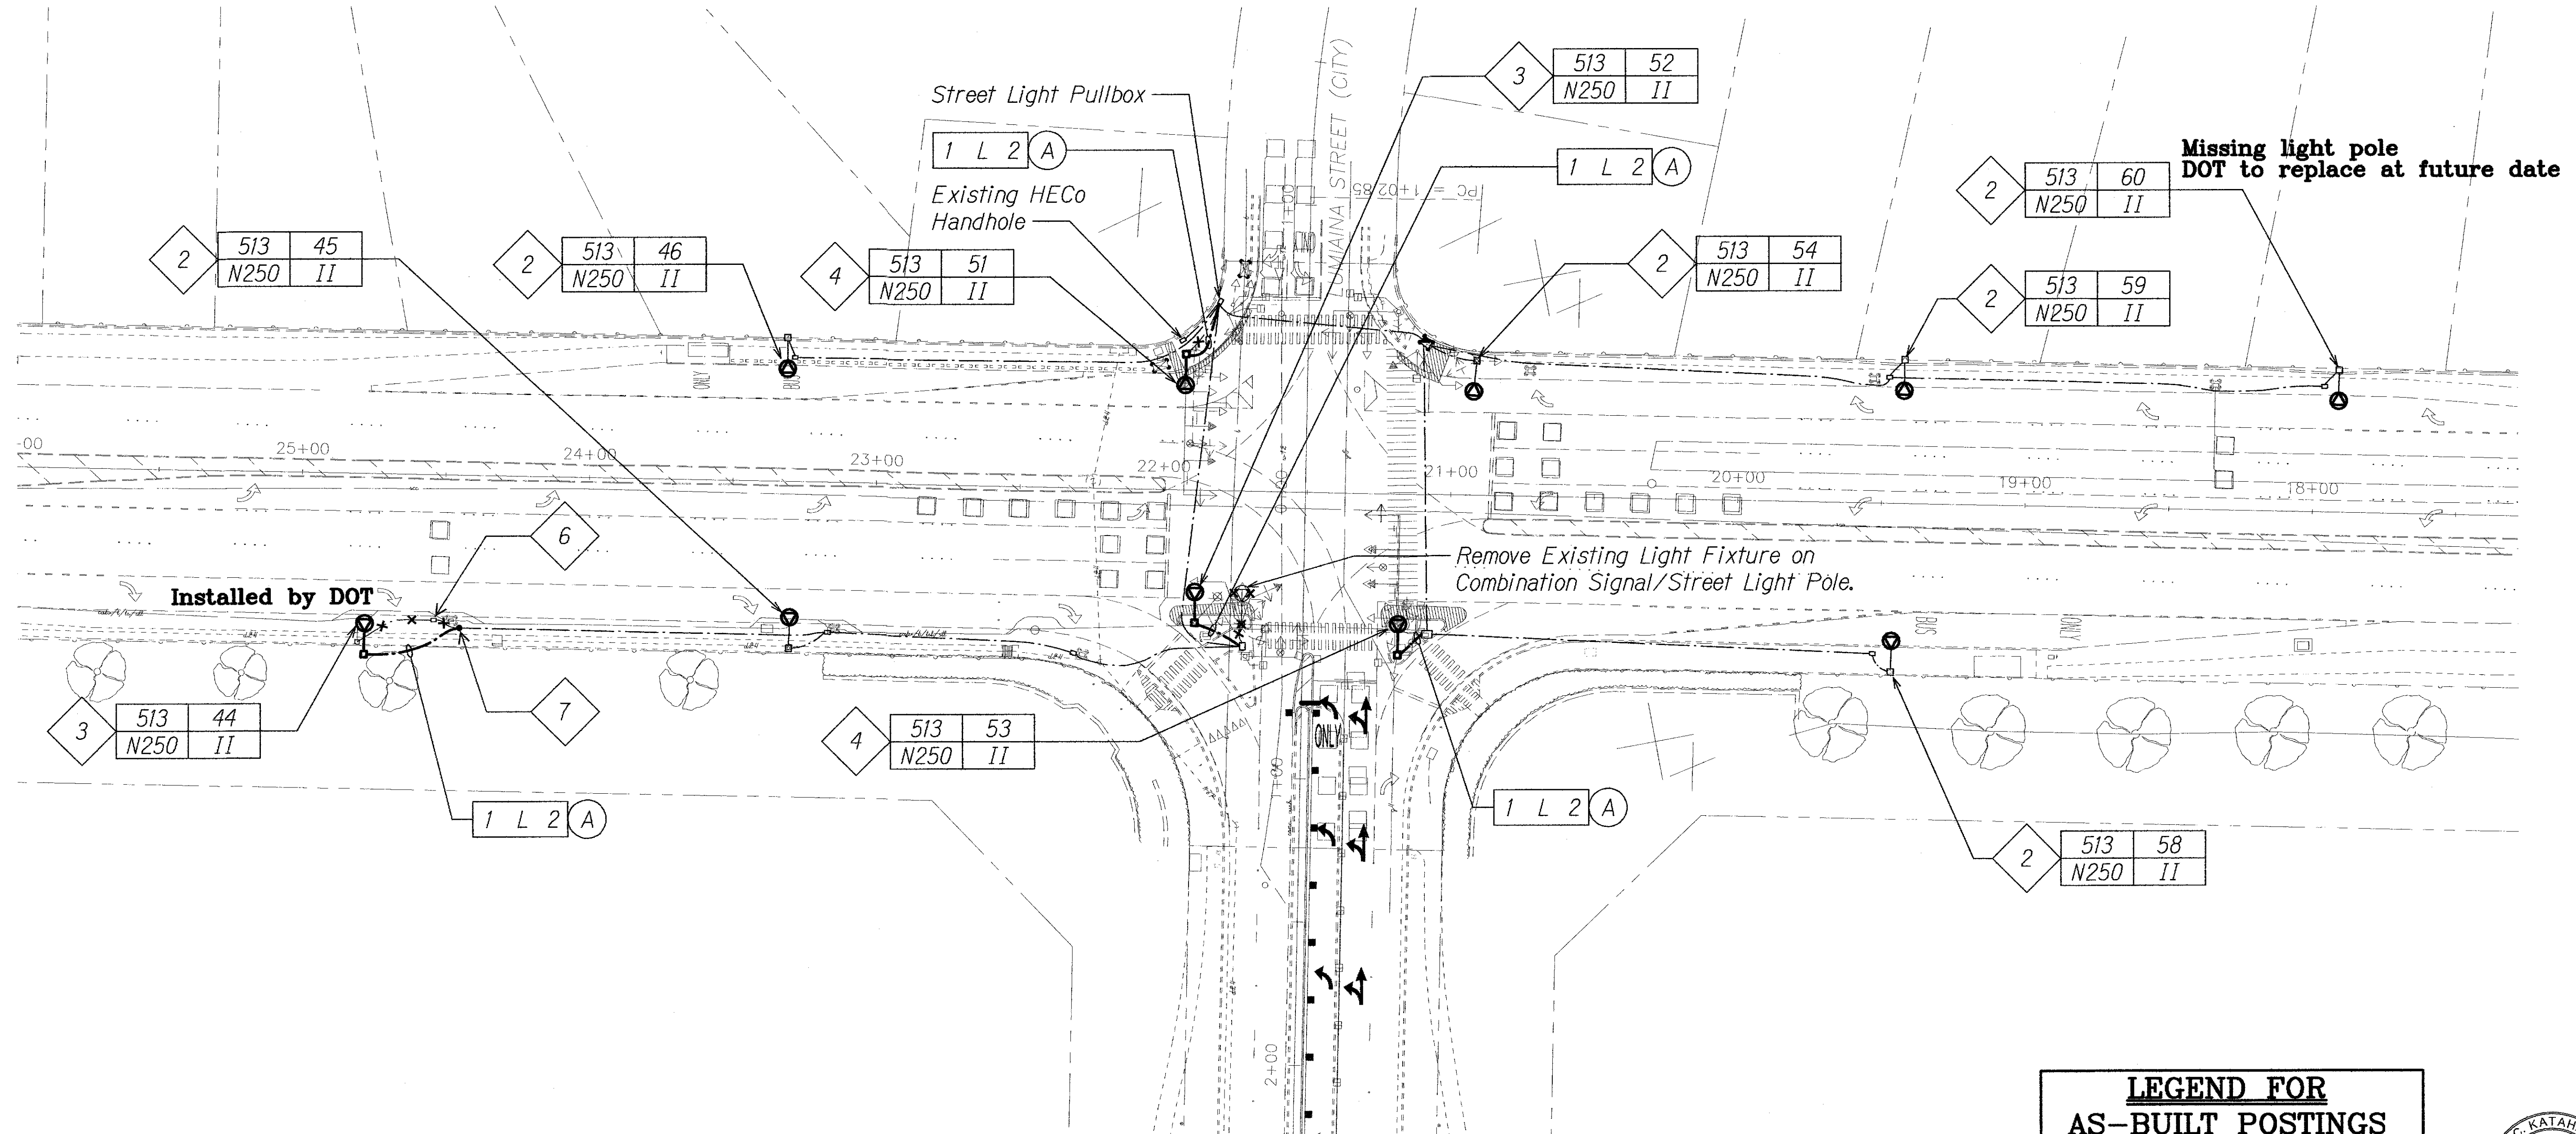

NOTES:

- Light Lines Denote Existing Condition
Bold Lines Denotes New Work
- Remove Existing Light Fixture. Provide New 250W HPS Type II Cut-Off Flat Lens on Existing Bracket Arm, and Connect to Existing Wiring.
- Provide and Install New 250W HPS Type II Cutoff Flat Lens on New Street Light Pole. See Detail ~~E-004~~ ~~E-009~~ for Street Light Standard Details. Deleted
- Remove Existing Light Fixture From Pole. Provide and Install New 250W HPS Type II Cut-Off Flat Lens on New Combination Sig/St Light Pole. Refer to State Hwy Standard Plan TE-38 for Type III Traffic Signal Pole Details.
- For Clarification of Street Light Renovations, Reference Street Light One-Line Diagram on Sheet **E-008**.

SITE LIGHTING PLAN

SCALE: 1" = 30'-0"


- ~~Demolish Exist Pullbox That is Paved Over. Deleted~~
- ~~Intercept Exist Conduit & Extend to New Light Pole. Provide New Wiring Back to Pole 45. Deleted~~
- Provide New Street Light I.D. Tag on Each Pole. Refer to **C** ~~E-004~~ **E-009** for Details.

LEGEND FOR AS-BUILT POSTINGS

~~~~~~~~~ Squiggly line for as-built deletion

~~==~~ Double line for as-built deletion


Roadway Text for as-built posting

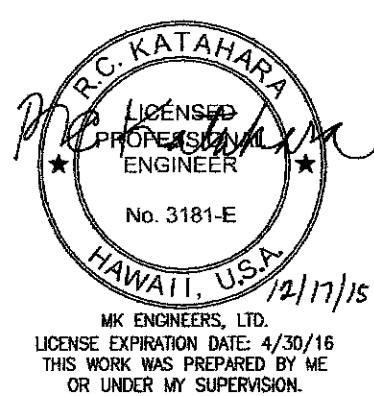

STATE OF HAWAII  
DEPARTMENT OF TRANSPORTATION  
HIGHWAYS DIVISION

**SITE LIGHTING PLAN**

TRAFFIC OPERATIONAL IMPROVEMENTS  
AT VARIOUS LOCATIONS  
Vicinity of Kamehameha Highway and  
Lumiaia Street  
Project No. 99C-01-13  
Scale: As Noted Date: Jan. 2014  
SHEET No. E-004 OF 9 SHEETS

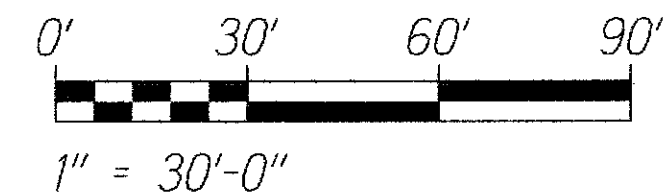

"AS-BUILT"