

FED. ROAD DIST. NO.	STATE	PROJ. NO.	FISCAL YEAR	SHEET NO.	TOTAL SHEETS
HAWAII	HAW.	99D-01-17	2022	12	35

Note:

- The Contractor shall protect all existing monitoring wells to remain.
- According to the "Eighteenth Quarterly Long-Term Monitoring and Remedial Action Operations Report Site ST02 Waiawa Booster Pump Station" dated September 2020 by NAVFAC Hawaii, petroleum contaminated hazardous groundwater has been found at the following nearby monitoring wells at the elevations listed below:

Monitoring Well No.	Groundwater Elevation
VP26-B17	13.92'
VP26-B16	14.82'
ST02-B55	12.32'

The Contractor shall take proper precaution when excavating. If contaminated or hazardous items or materials are encountered, the Contractor shall handle the material in accordance with Hawaii Standard Specifications for Road and Bridge Construction, 2005, Subsection 107.16 - Contaminated or Hazardous Items and Material; Regulated Items and Materials; Waste and Subsection 219.04 - Determination and Handling of Hazardous Waste.

- The existing drainage system shall be functional at all times. The Contractor shall furnish materials, equipment, labor, tools, and incidentals necessary to maintain flow. This work shall be considered incidental to the various contract items.
- Contractor shall perform all work in accordance with Hawaii Standard Specifications for Road and Bridge Construction, 2005, Subsection 105.10 - Construction Stakes, Lines and Grades.





THIS WORK WAS PREPARED BY ME OR UNDER MY SUPERVISION.
Russell M. Araki
 Russell M. Araki, Inc.
 d/b/a PARK ENGINEERING
 APRIL 30, 2022
 LIC. EXP. DATE

STATE OF HAWAII
DEPARTMENT OF TRANSPORTATION
HIGHWAYS DIVISION

DRAINAGE PLAN AND PROFILE

FARRINGTON HIGHWAY
Drainage Improvements
Vicinity of Leeward Community College
PROJECT NO. 99D-01-17
Scale: As Shown Date: June 2021
SHEET No. **D1** OF **D4** SHEETS

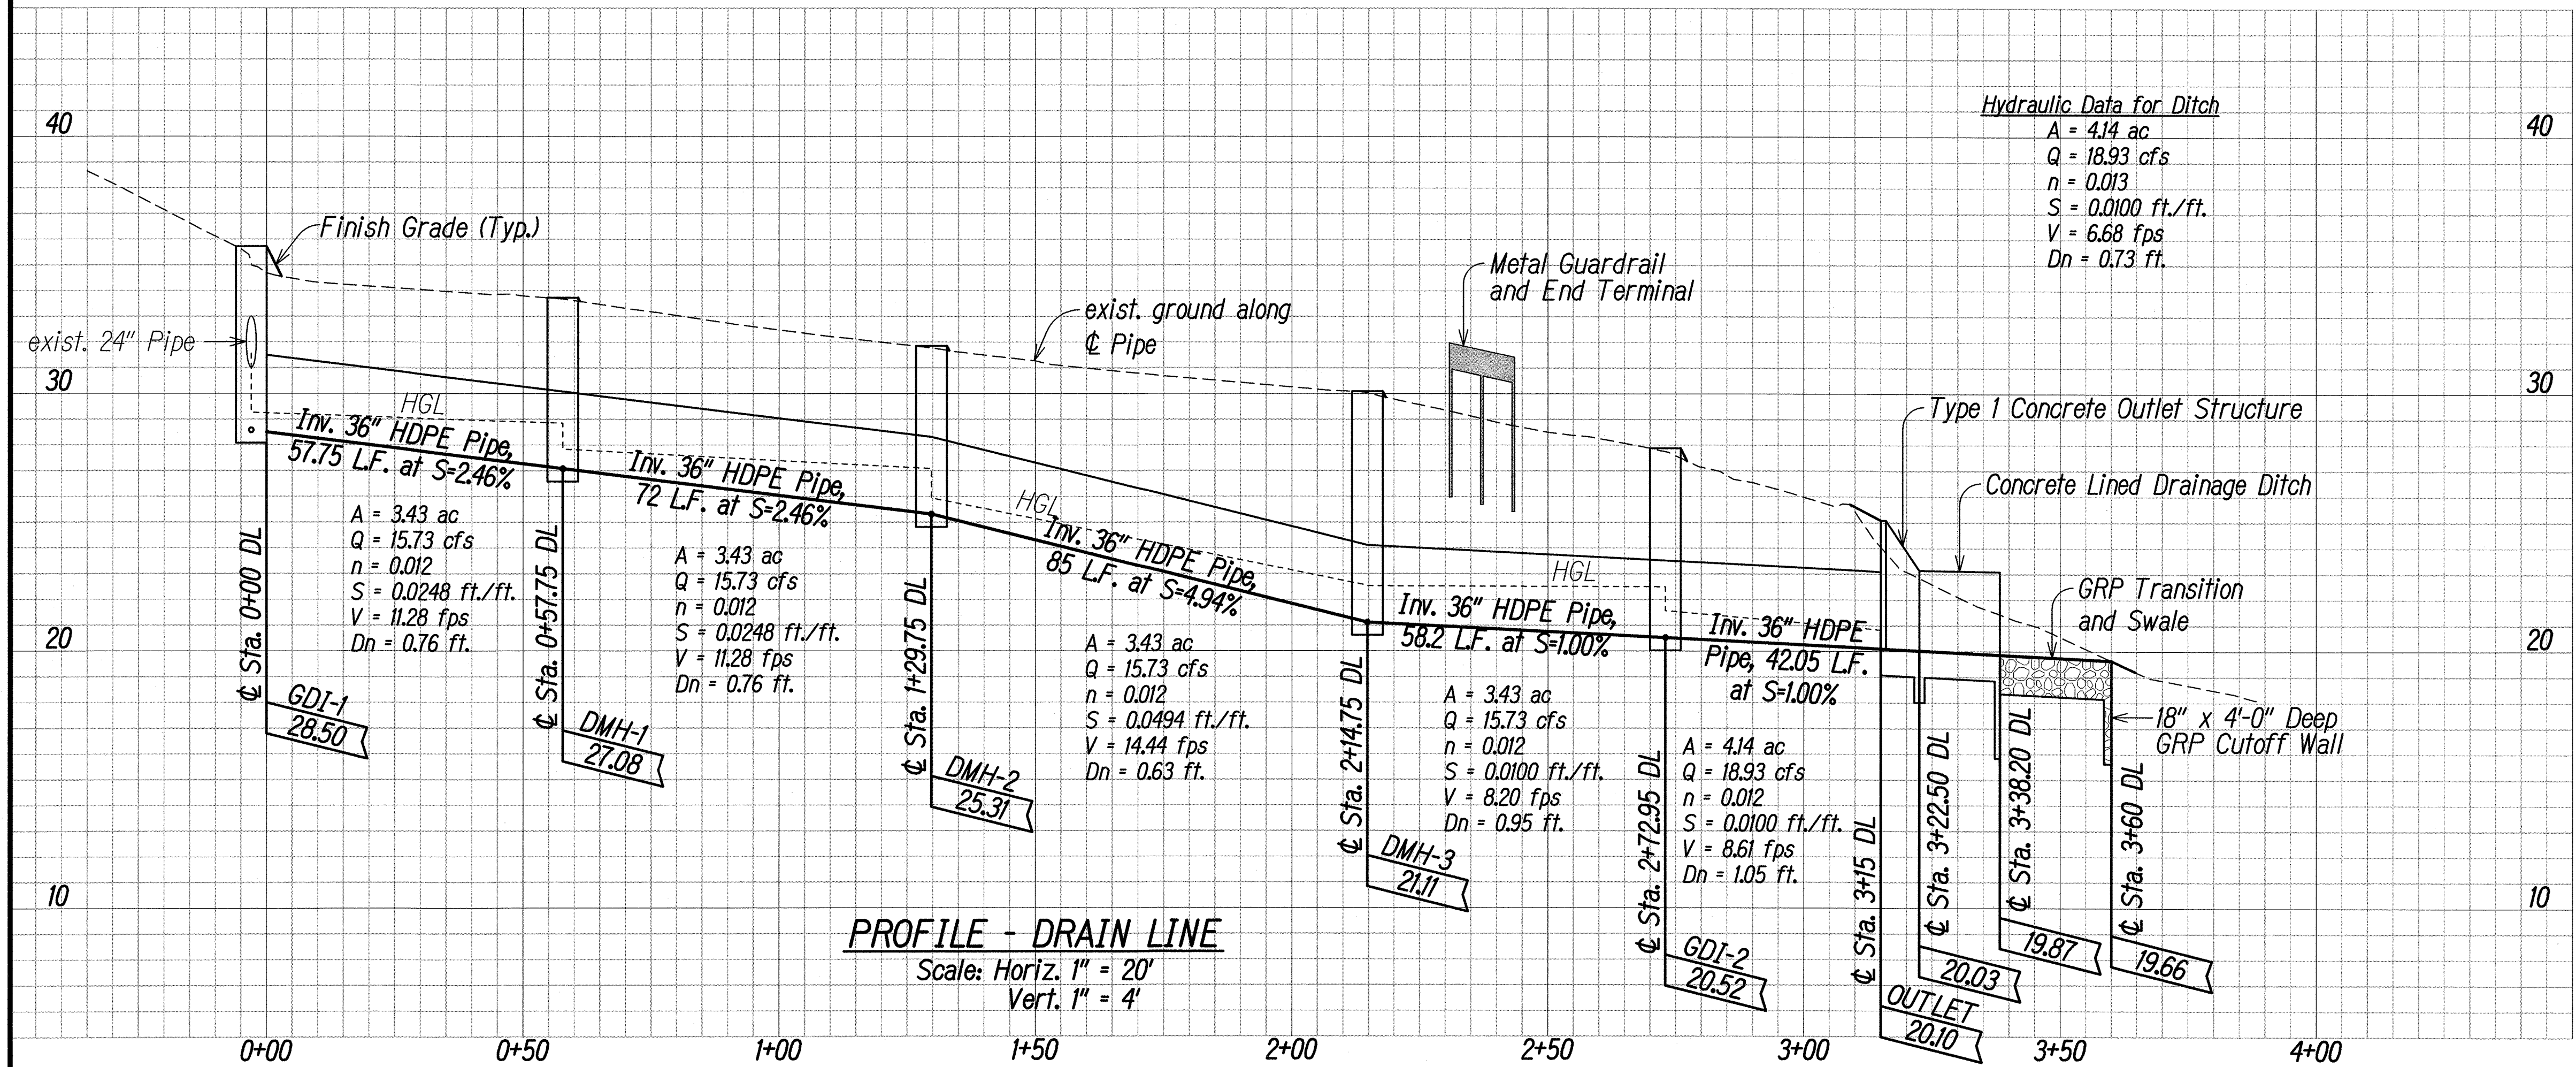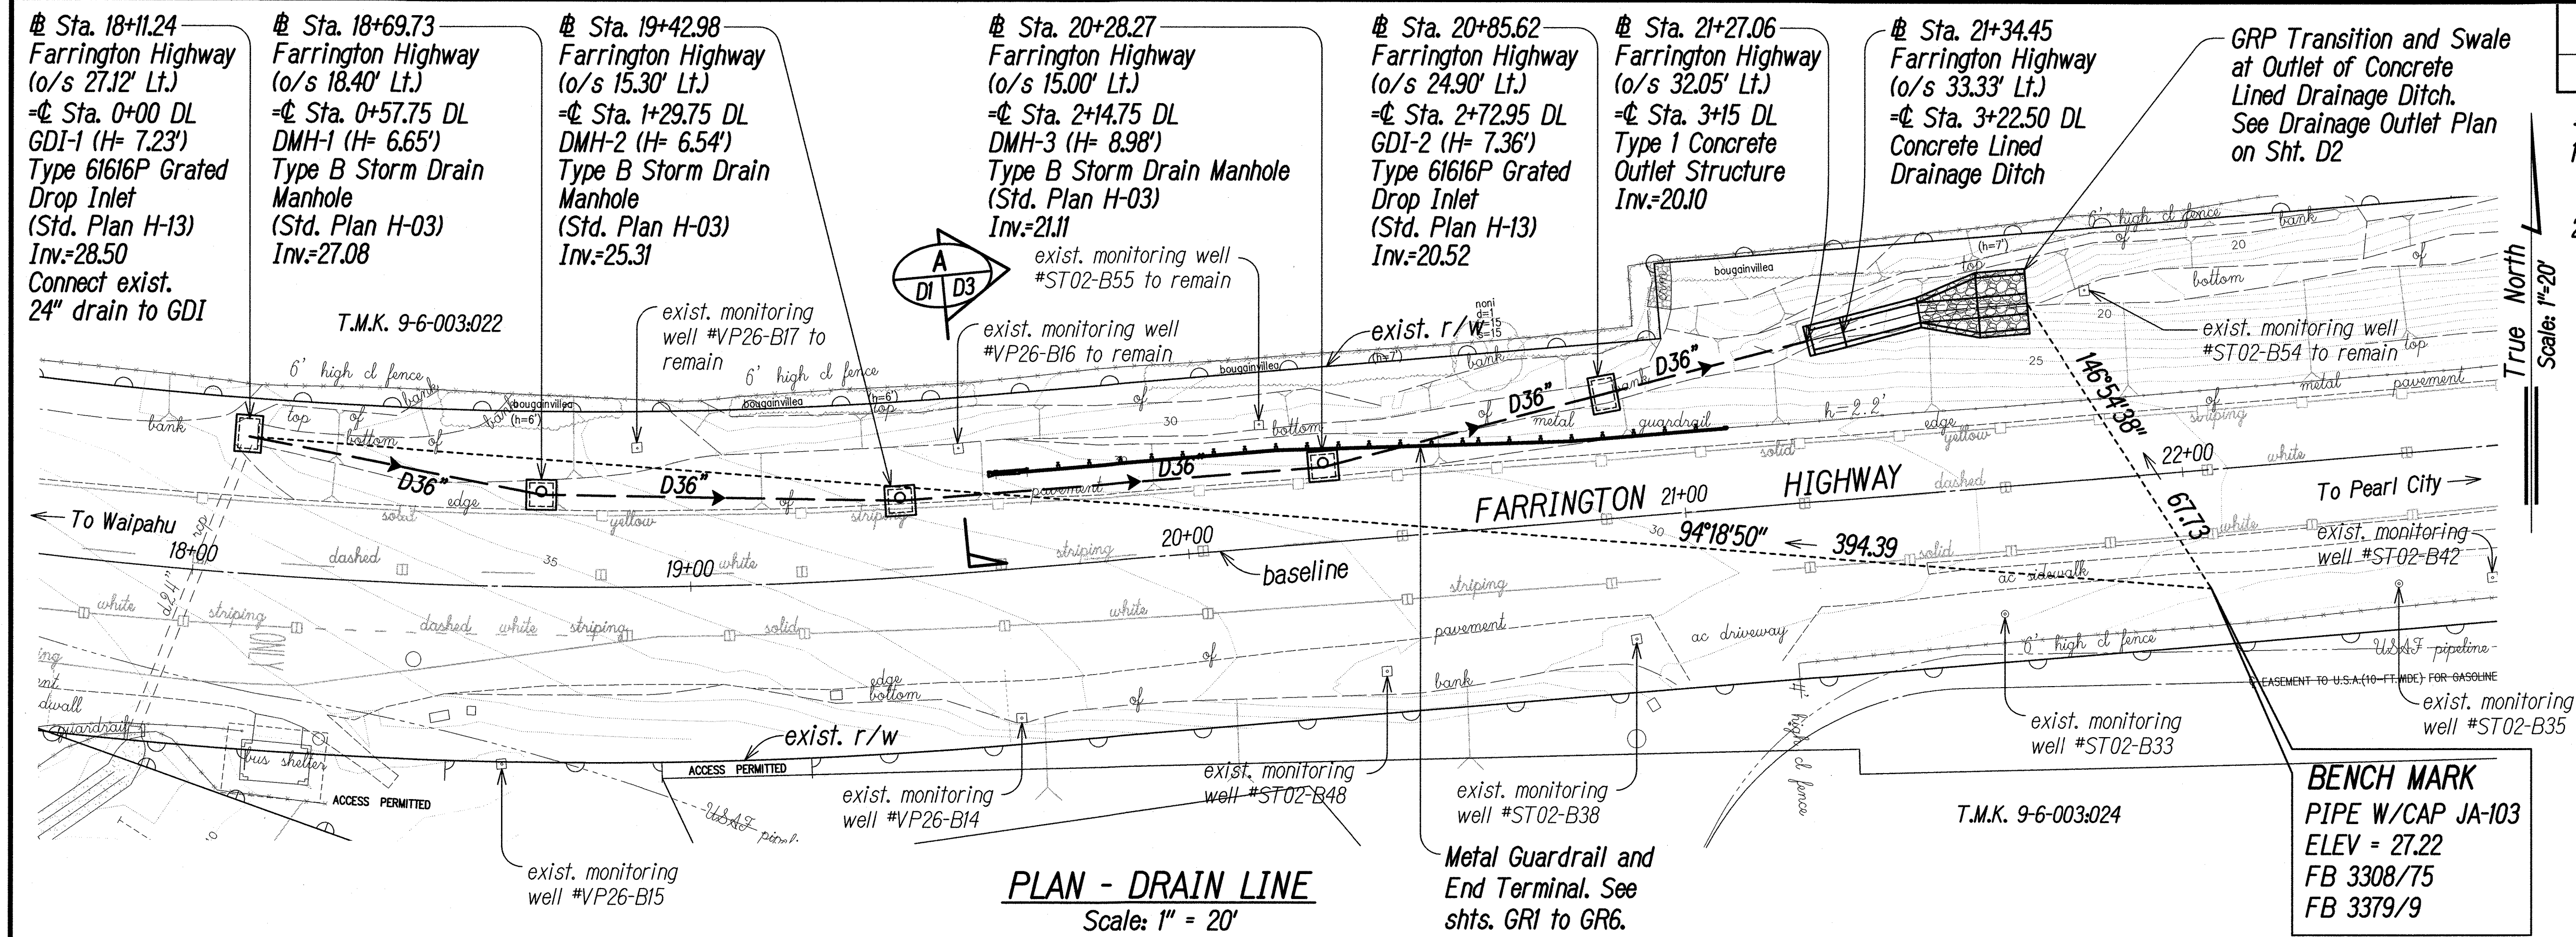

SURVEY PLOTTED BY	DATE
DRAWN BY	
DESIGNED BY	
QUANTITIES BY	
CHECKED BY	
ORIGINAL PLAN	
NOTE BOOK	
No.	