

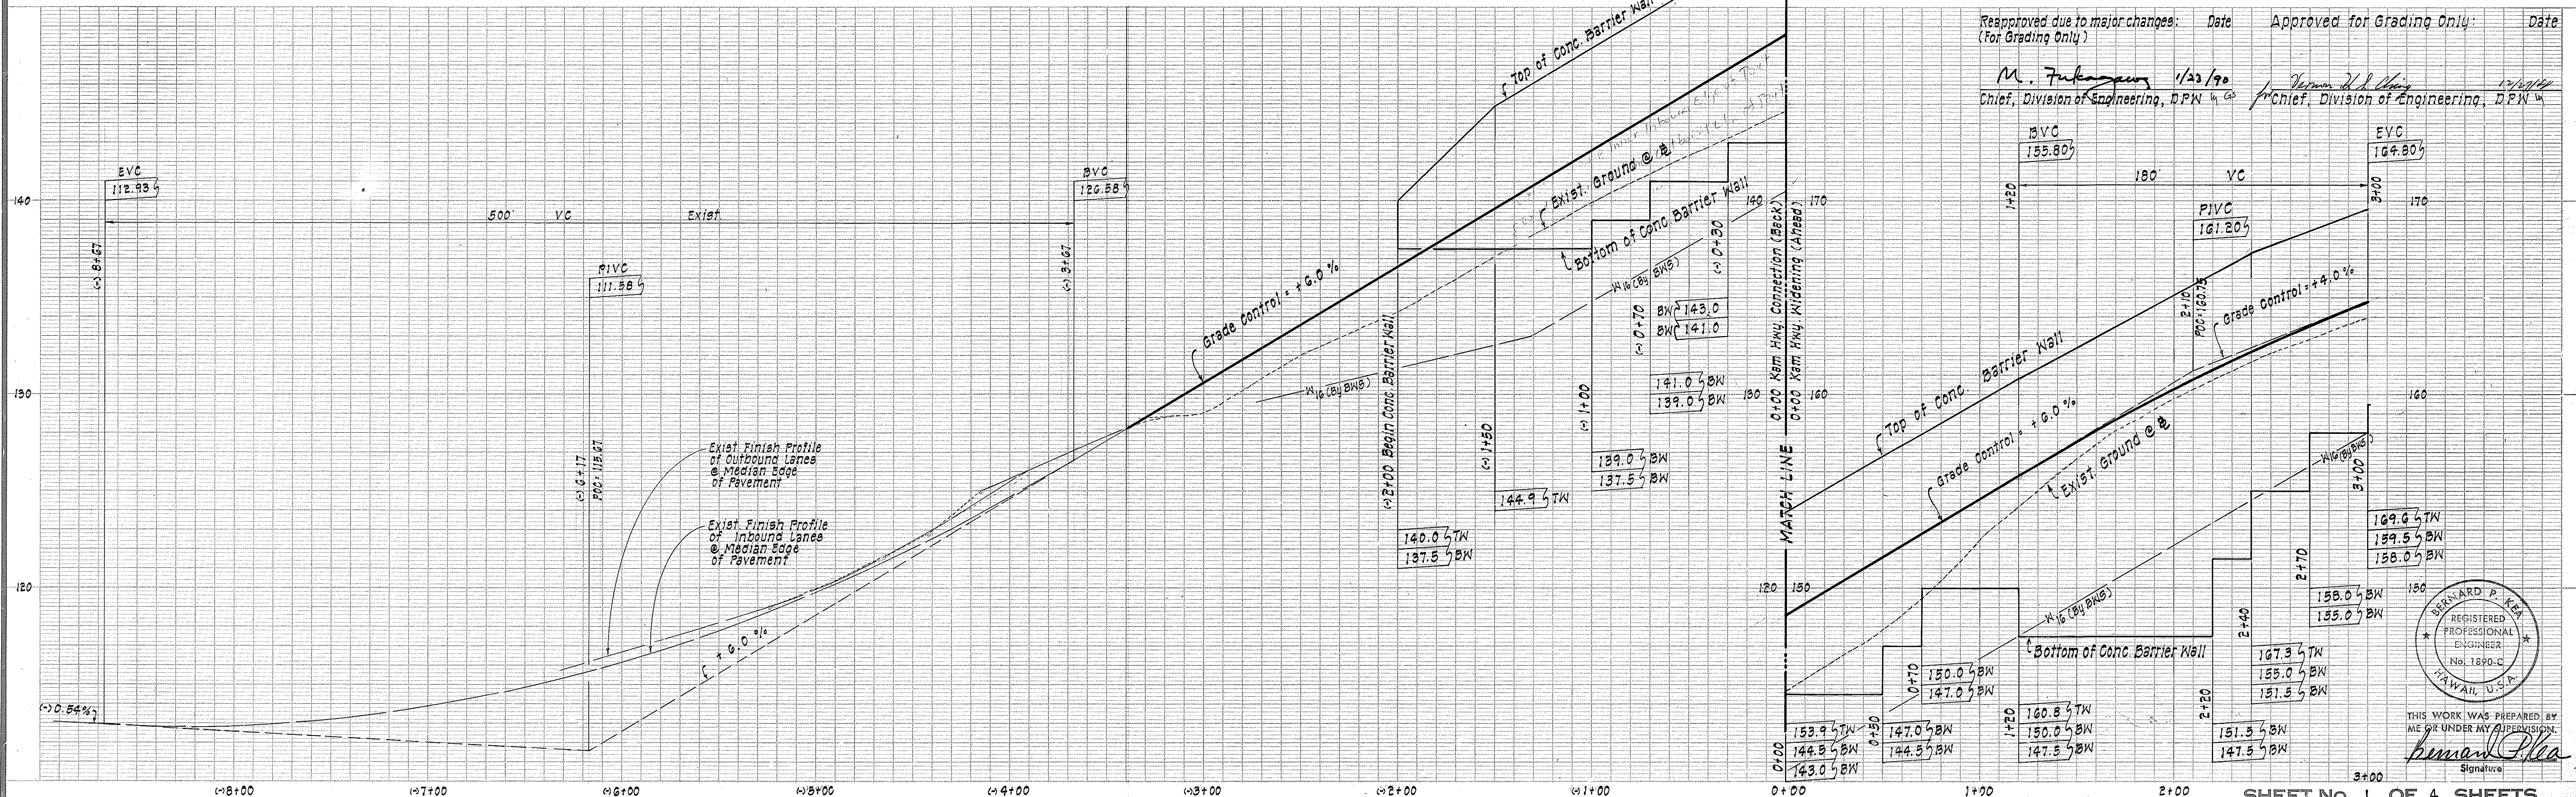


FED. ROAD DIST. NO.	STATE	PROJ. NO.	FISCAL YEAR	SHEET NO.	TOTAL SHEETS
HAWAII	HAW.	99C-01-90	1990	5	49

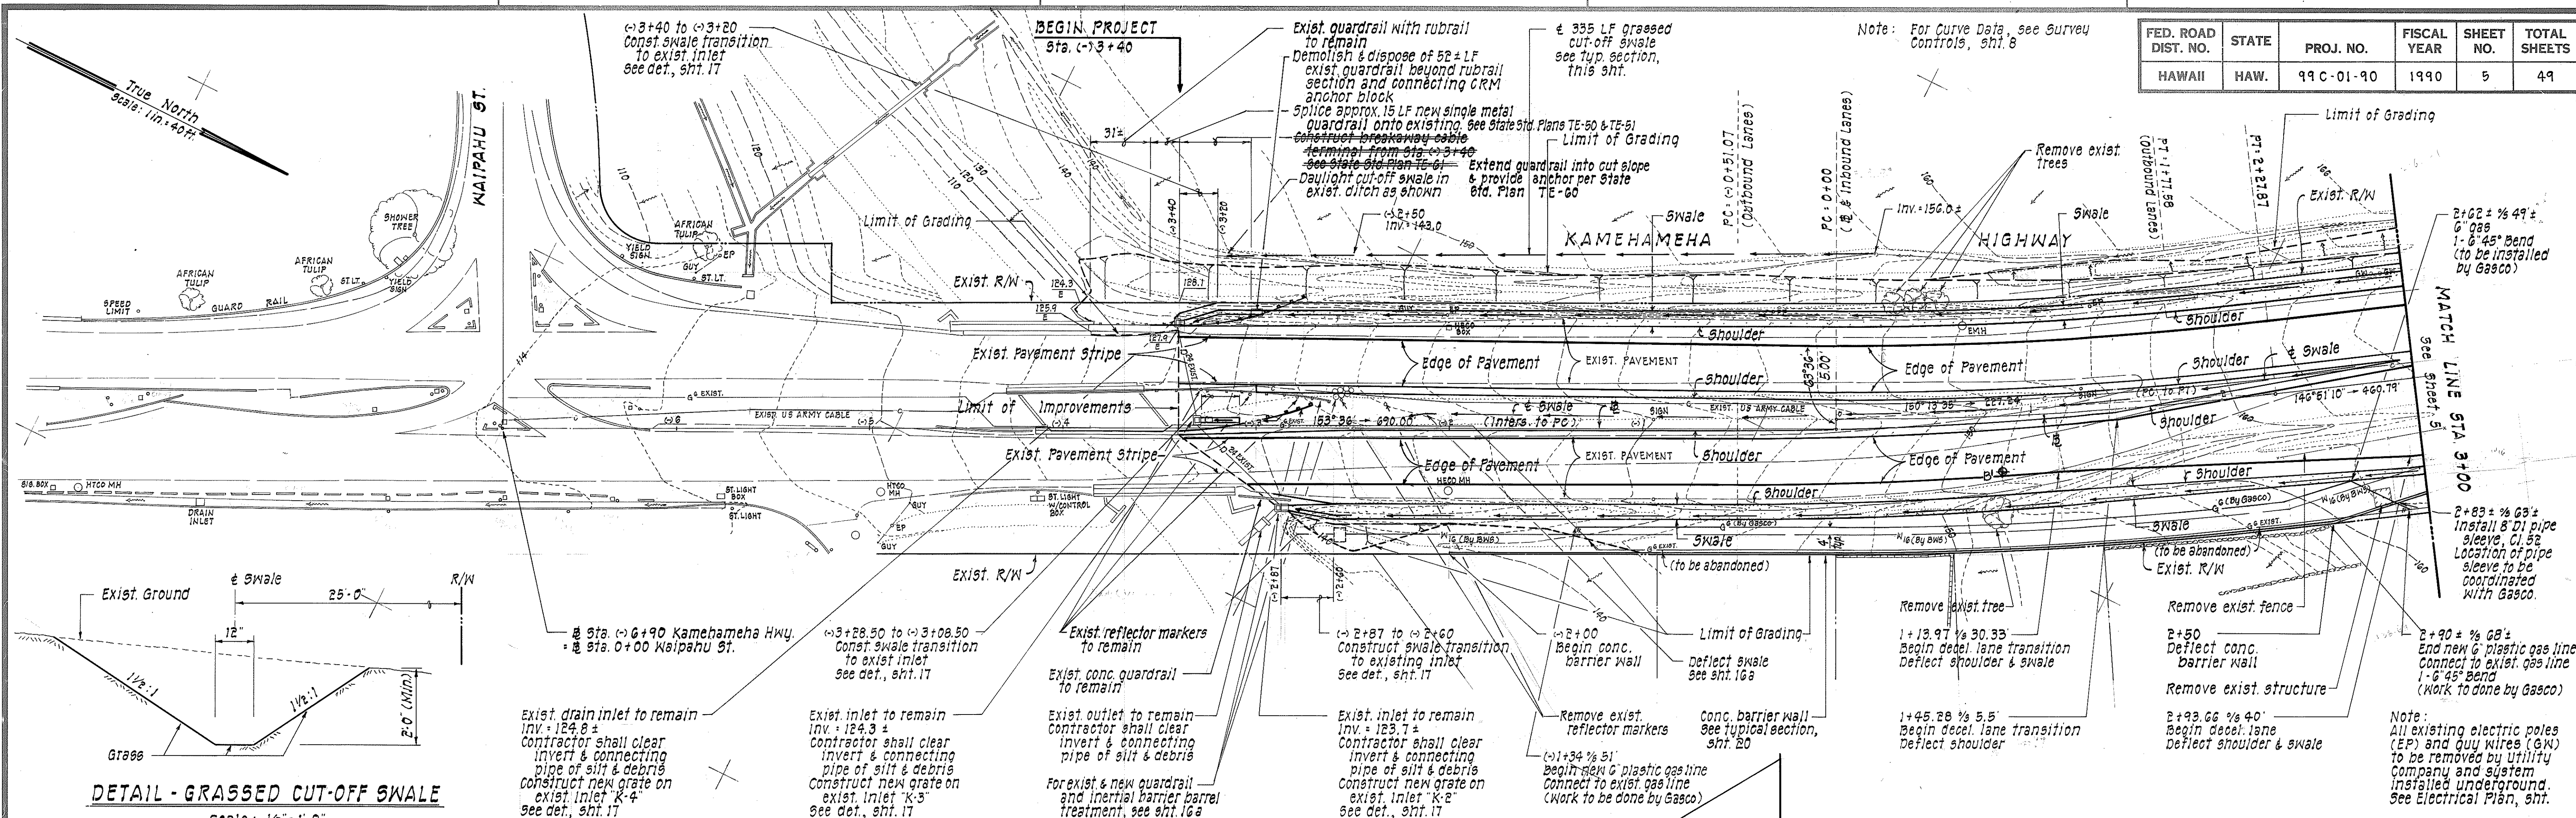

FED. ROAD DIST. NO.	STATE	PROJ. NO.	FISCAL YEAR	SHEET NO.	TOTAL SHEETS
HAWAII	HAW.	99 C-01-90	1990	6	49

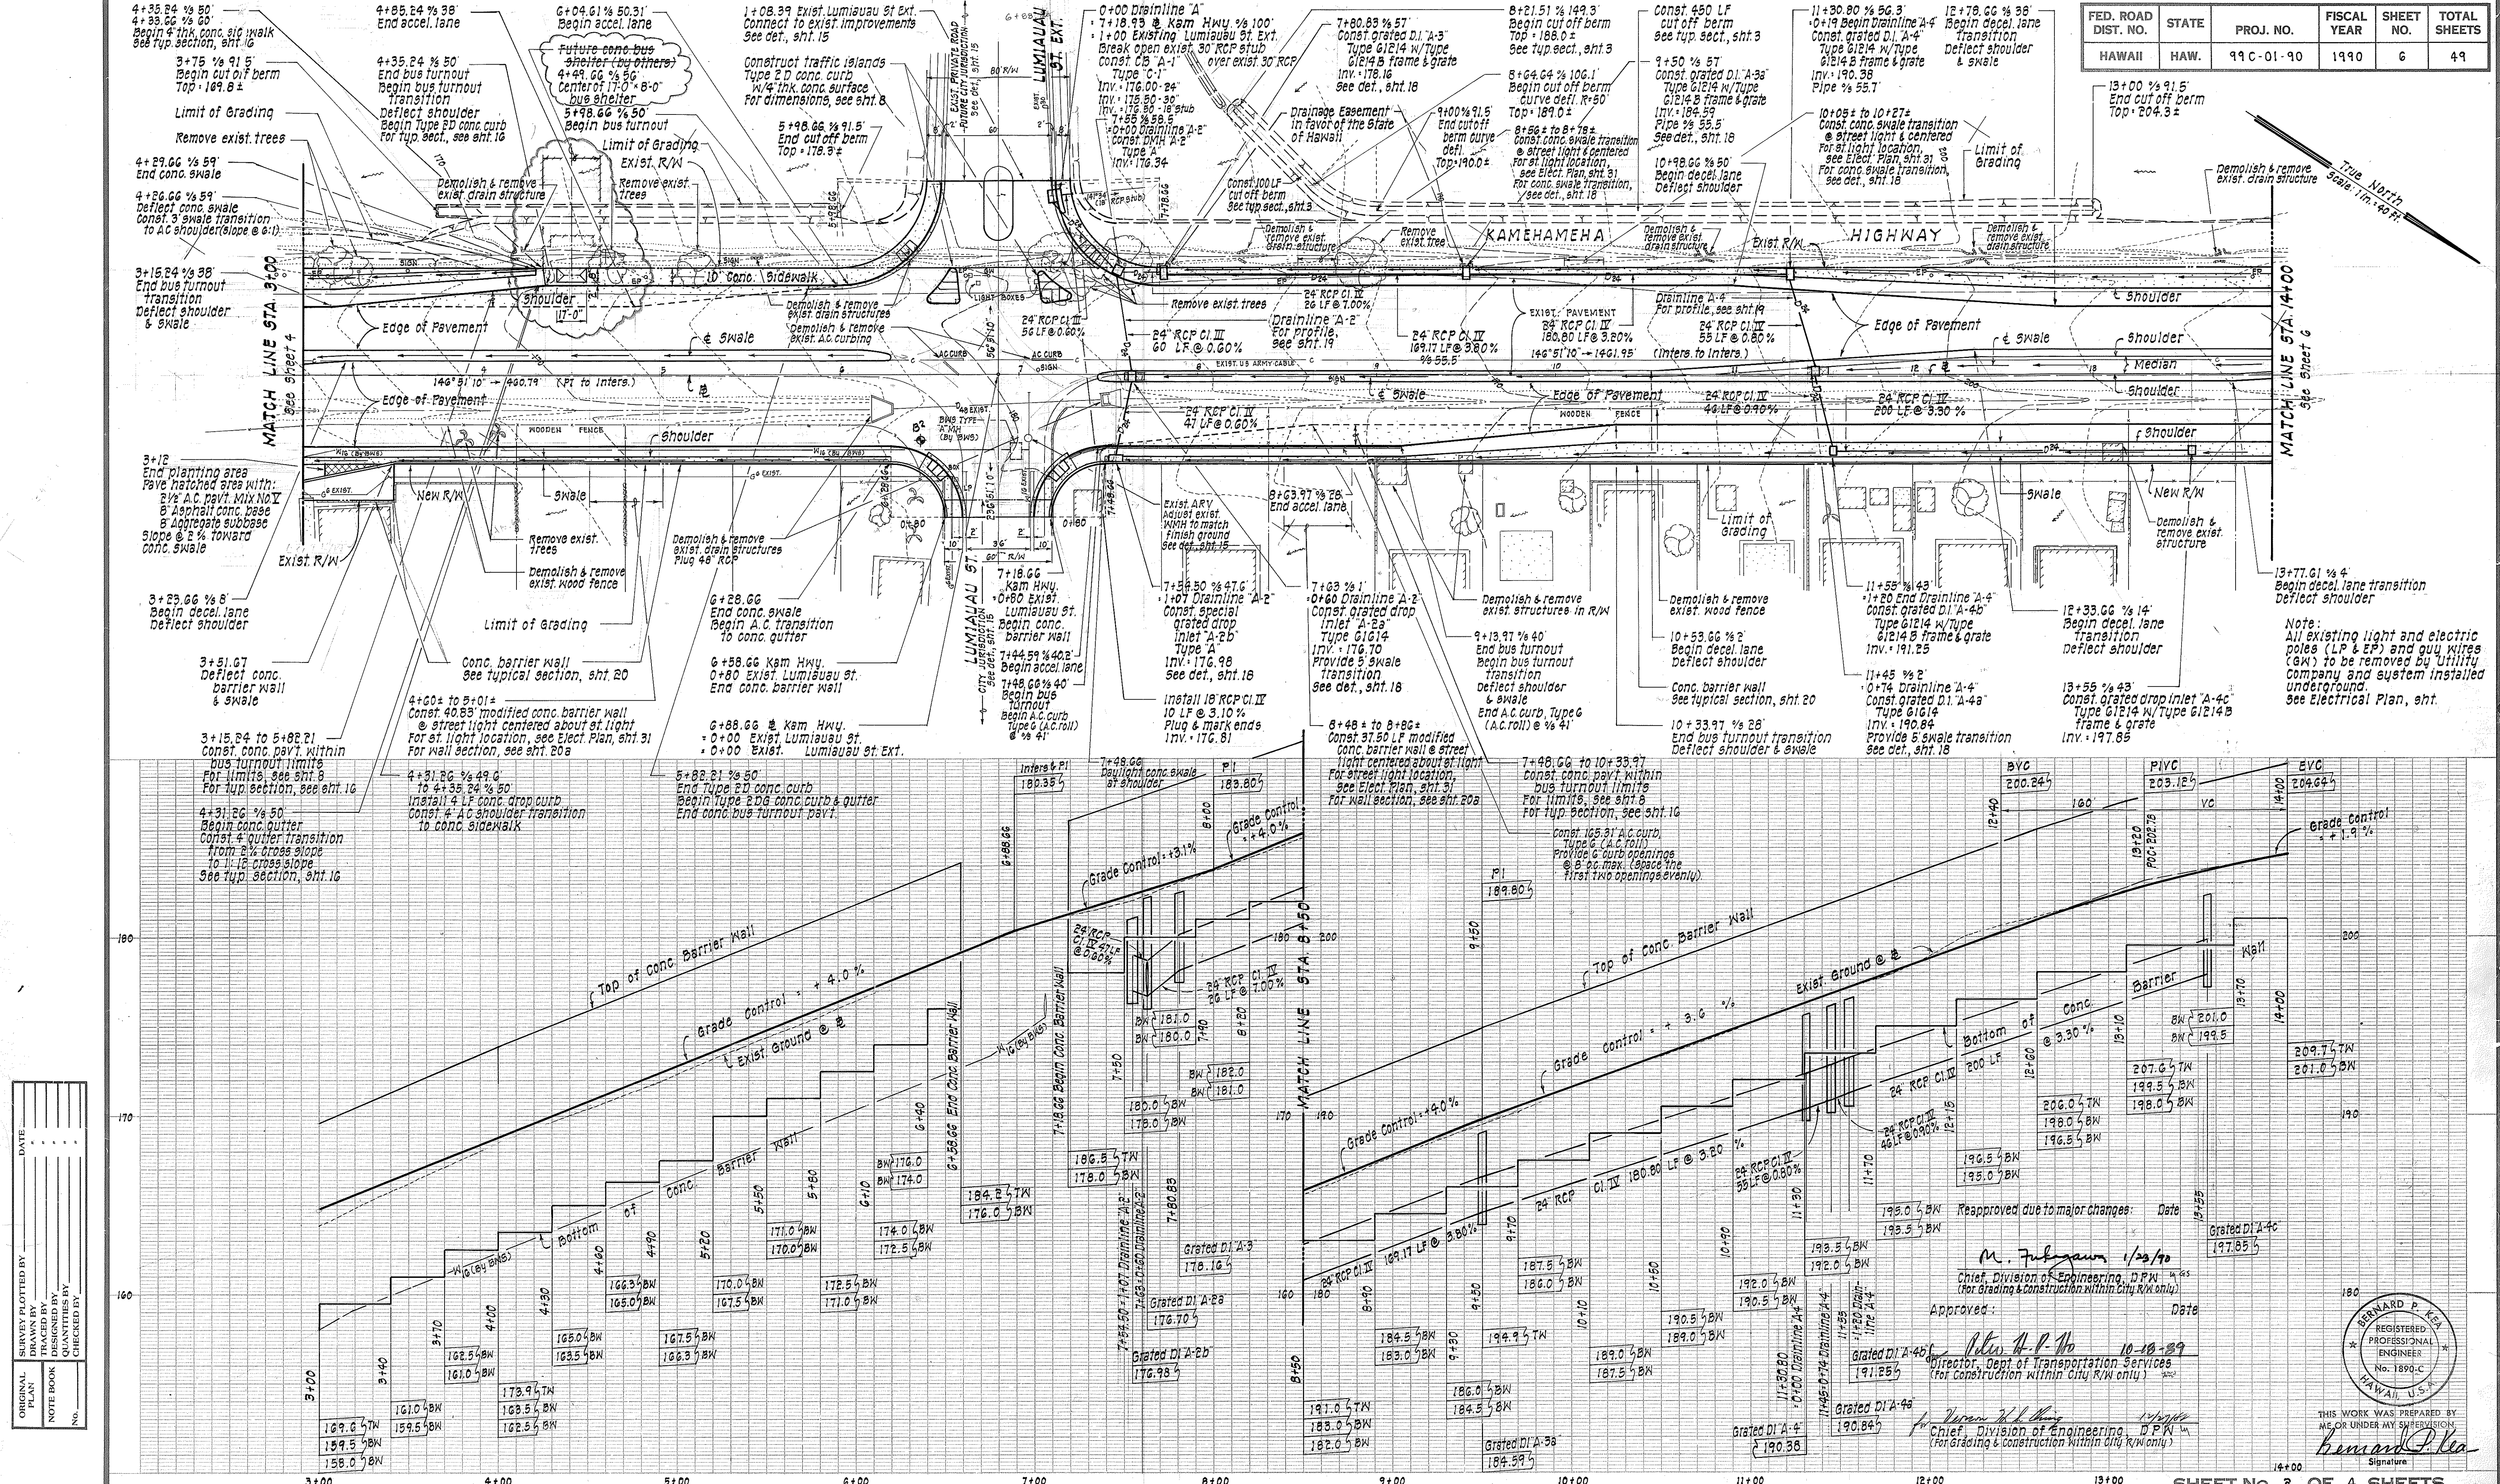


ORIGINAL PLAN	DATE
DRAWN BY	
TRACED BY	
NOTED BY	
CHECKED BY	

Approved: *M. Fubayawa* 1/25/90
 Chief, Division of Engineering, D.P.W.
 (For Grading & Construction within City R/W only)


Approved: *John A. P. No* 10-18-89
 Director, Dept. of Transportation Services
 (For Construction within City R/W only)

Approved: *John A. P. No* 10-18-89
 Chief, Division of Engineering, D.P.W.
 (For Grading & Construction within City R/W only)

Signature: *Bernard P. Koa*


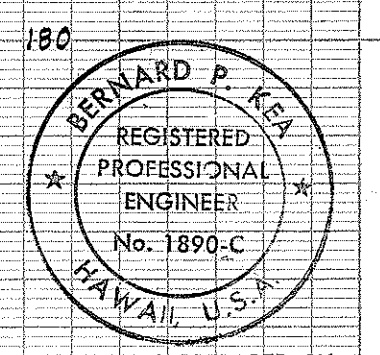


FED. ROAD DIST. NO.	STATE	PROJ. NO.	FISCAL YEAR	SHEET NO.	TOTAL SHEETS
HAWAII	HAW.	99 C-01-90	1990	8	49

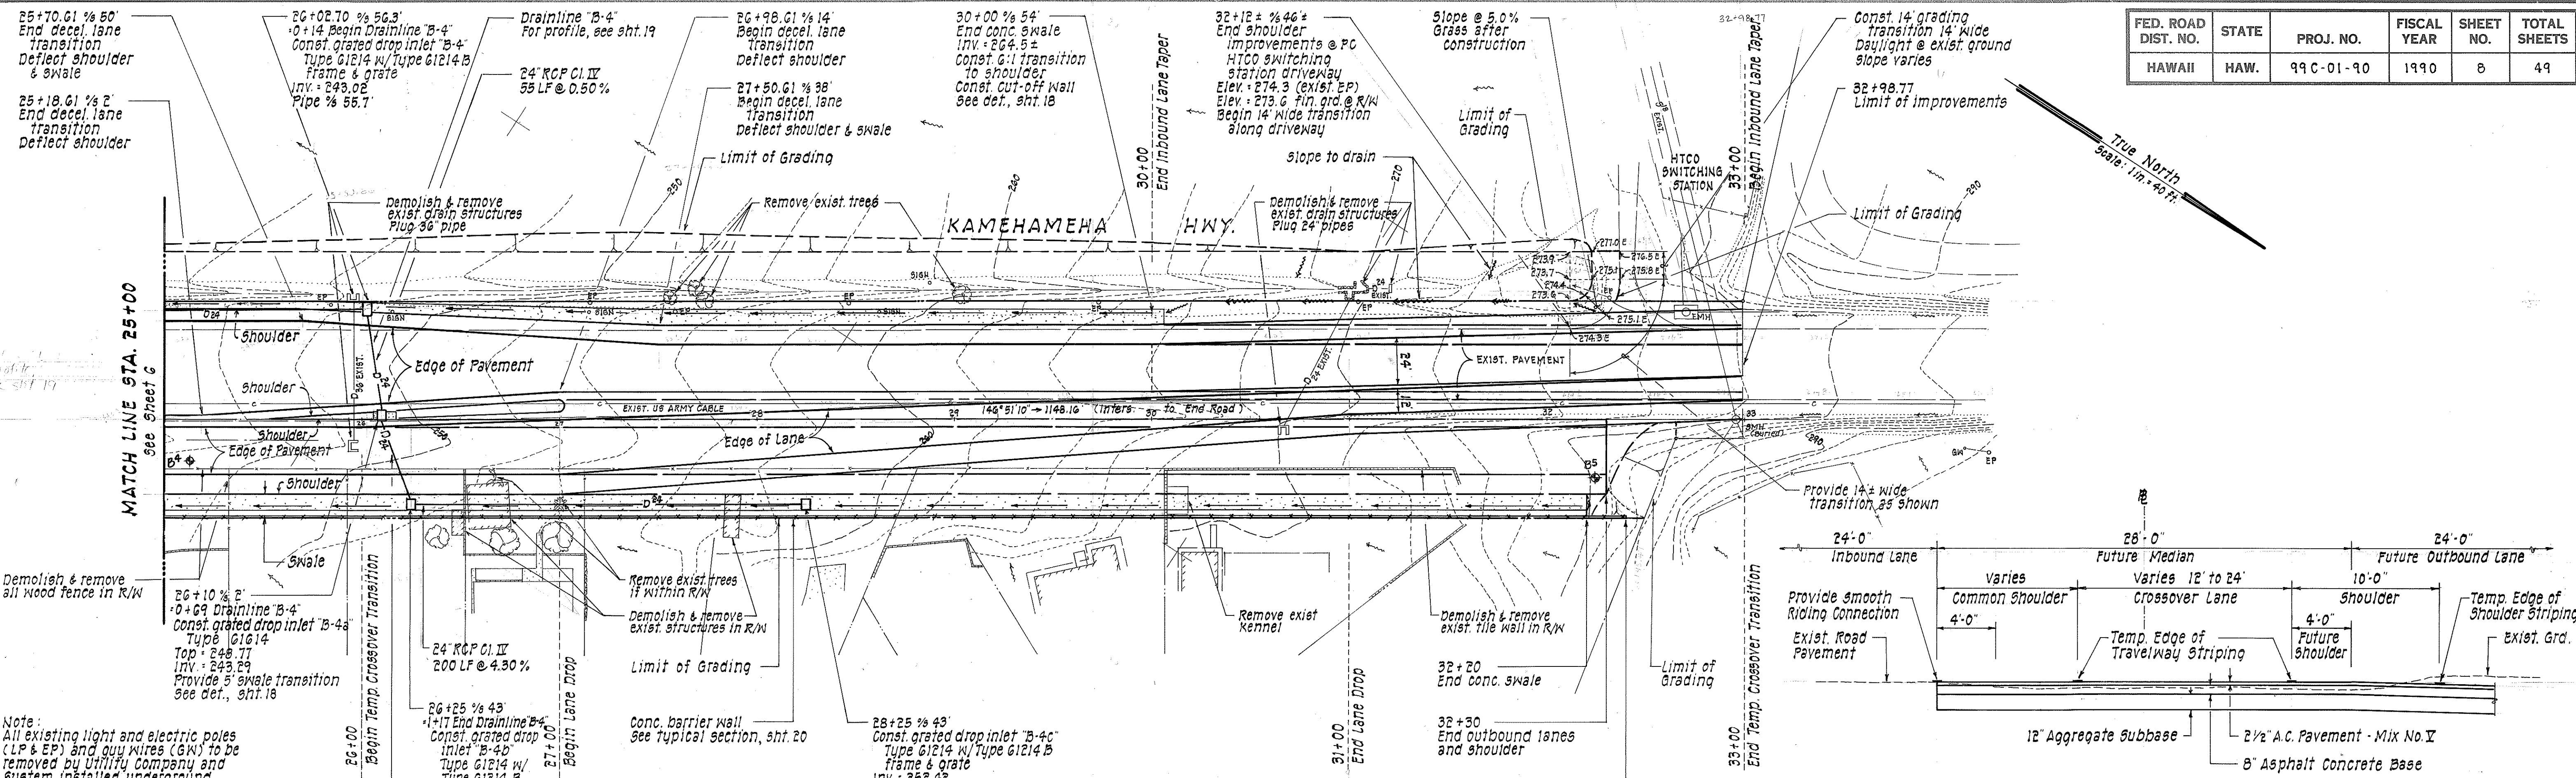

Note:
All existing light and electric poles (LP & EP) and guy wires (GW) to be removed by Utility Company and system installed underground. See Electrical Plan, sht.


TEMP. ROAD SECTION AT CROSSOVER LANE
(Sta. 26+00 TO 32+45.49)
Scale: 3/16" = 1'-0"

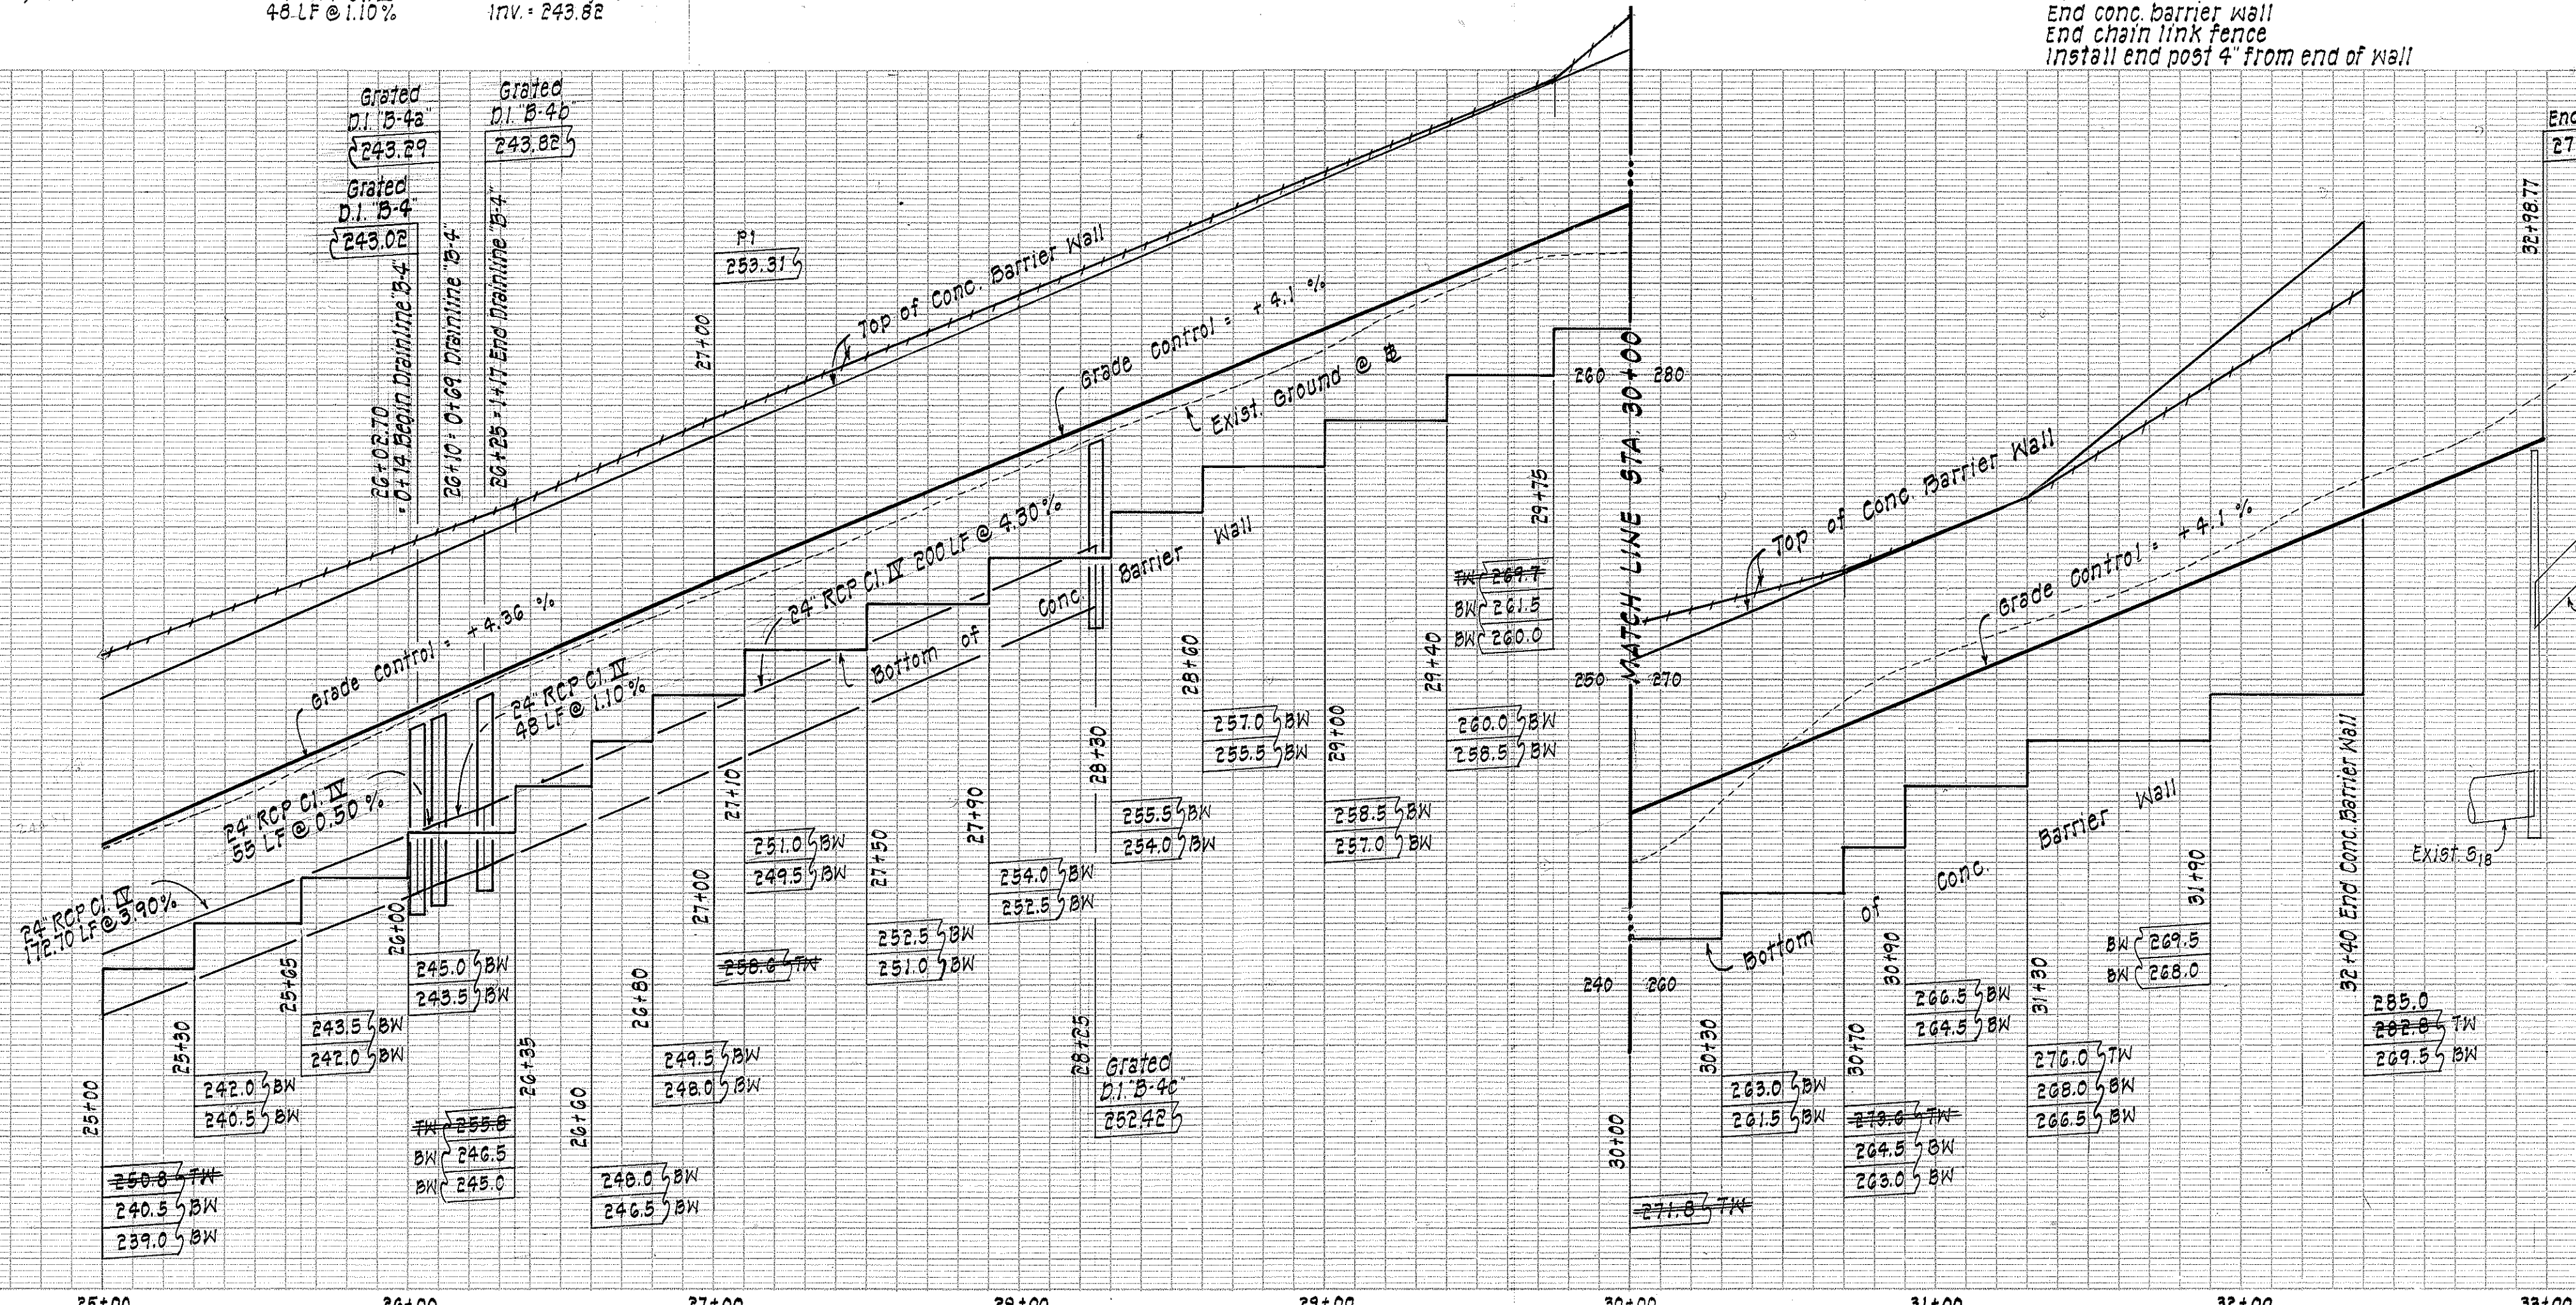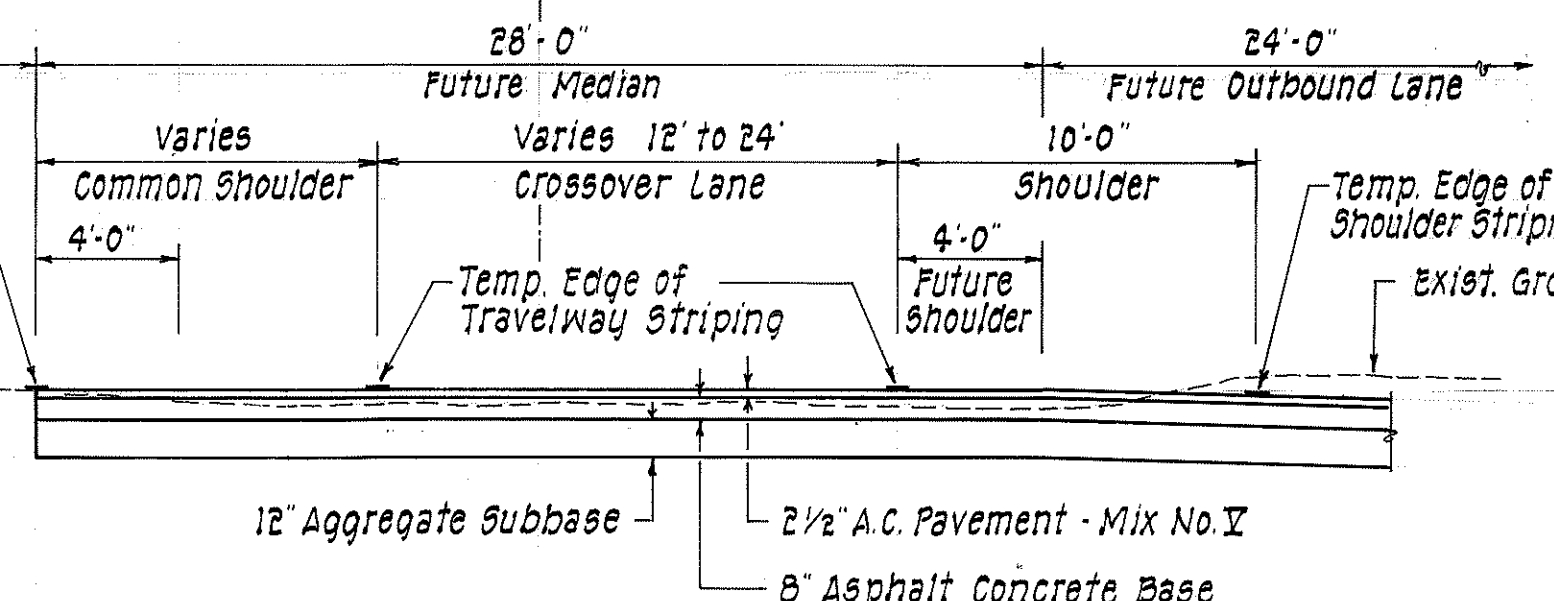

Approved for Grading Only: _____ Date _____
for *Vernon K. Ching*
Chief, Division of Engineering, D.P.W.

Reapproved due to major changes: _____ Date _____
(For Grading Only)

M. Fukunaga 1/22/90
Chief, Division of Engineering, D.P.W.

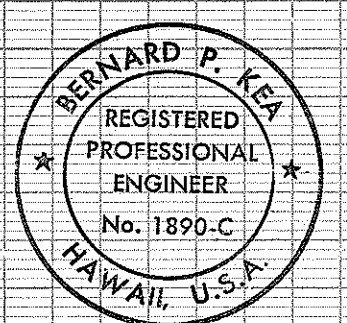

THIS WORK WAS PREPARED BY ME OR UNDER MY SUPERVISION
Bernard P. Kea
Signature