



FED. ROAD DIST. NO.	STATE	FED. AID PROJ. NO.	FISCAL YEAR	SHEET NO.	TOTAL SHEETS
HAWAII	HAW.	99C-01-92	1992	4	10

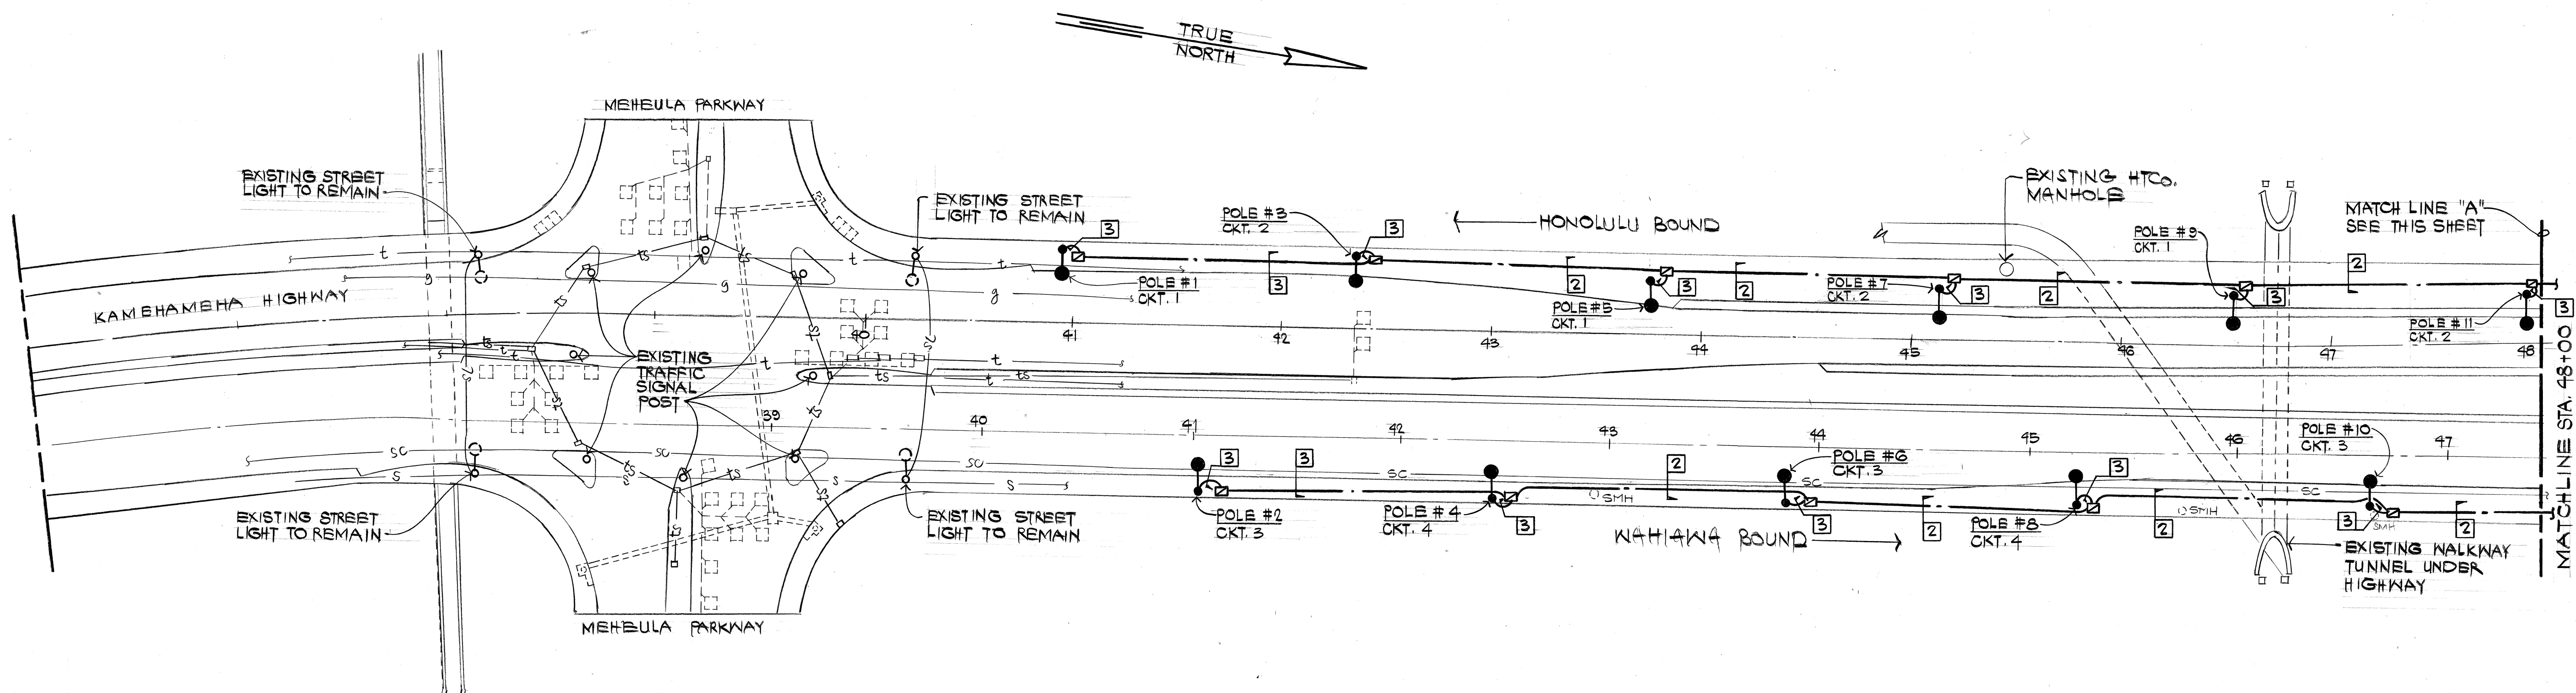


ELECTRICAL SITE PLAN #1
SCALE: 1" = 40'-0"

NOTES:
① PATCH ALL PAVEMENT, SIDEWALKS, CURBS, ETC. DAMAGED BY INSTALLATION OF NEW HIGHWAY LIGHTING SYSTEM TO MATCH EXISTING CONDITIONS.

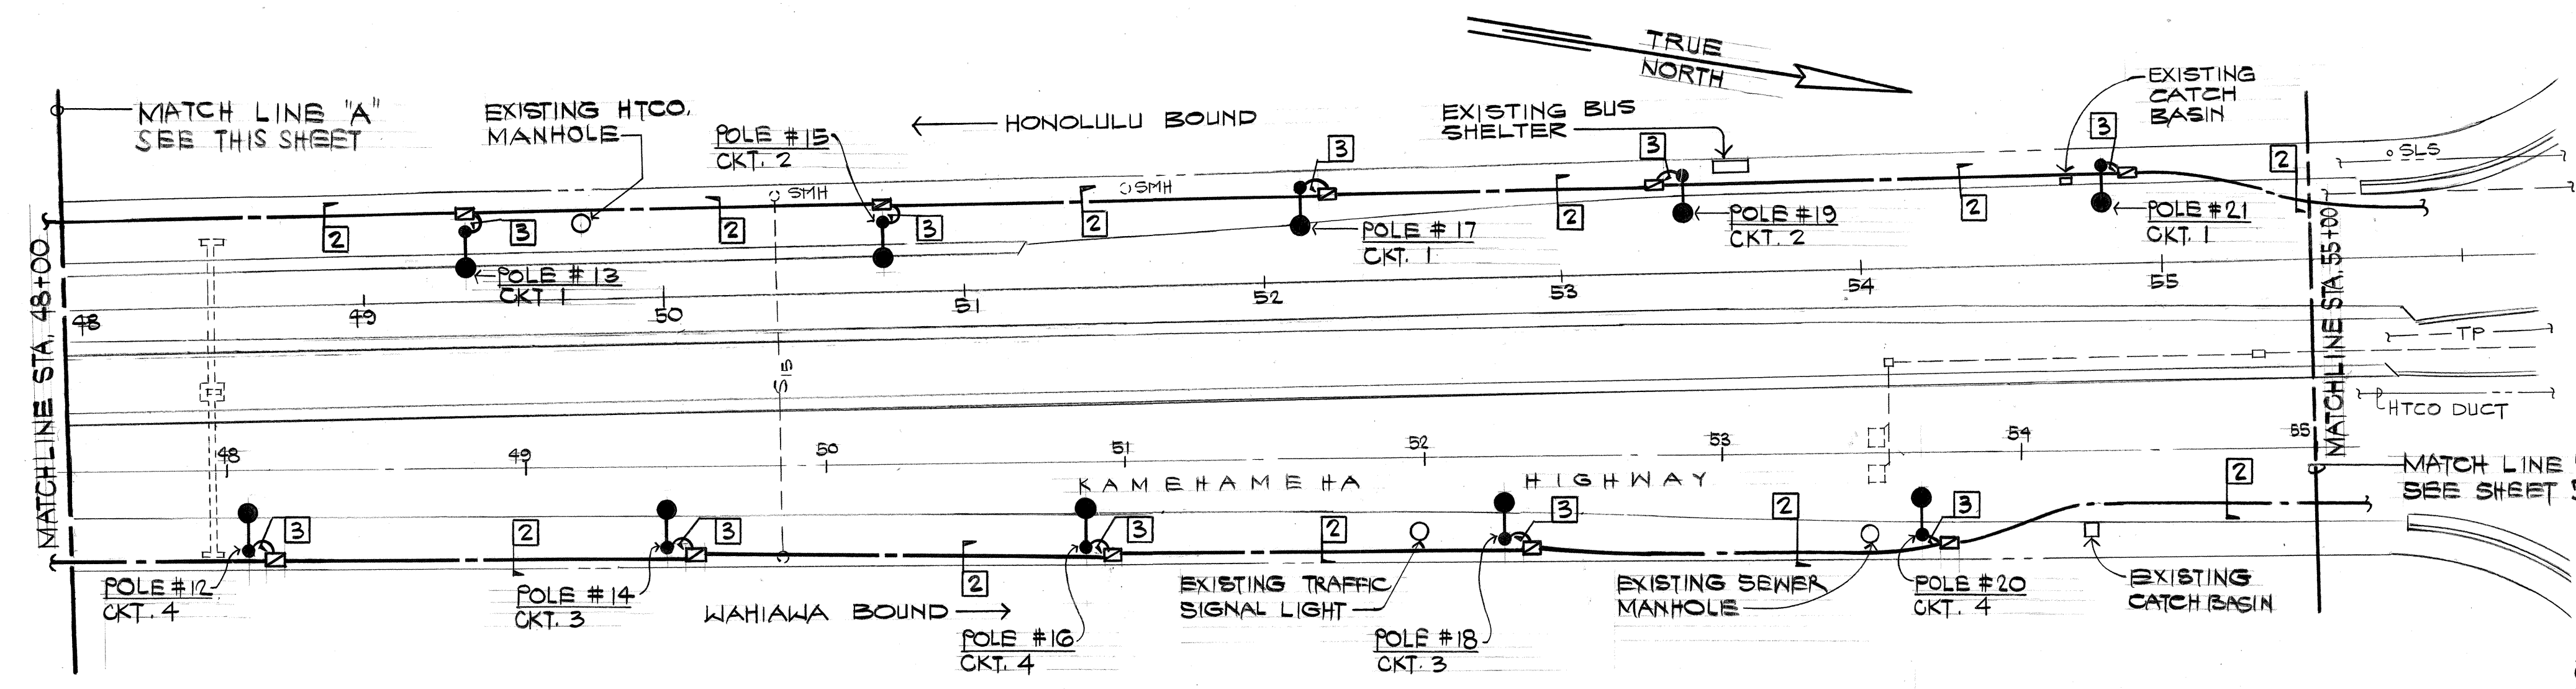

ELECTRICAL SITE PLAN #2
SCALE: 1" = 40'-0"

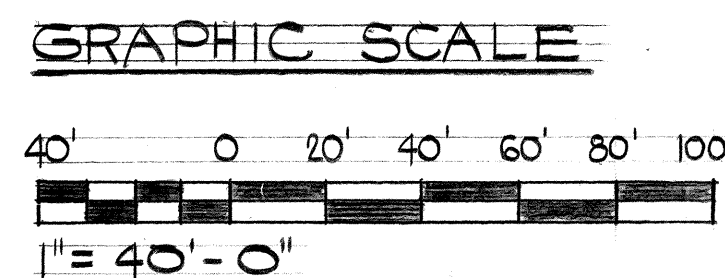

This work was prepared by me or under my supervision
ECS INC.
By *Lennox K. Nishimura*
Its PROJECT ENGINEER
Date DEC. 9, 1991

STATE OF HAWAII
DEPARTMENT OF TRANSPORTATION
HIGHWAYS DIVISION

ELECTRICAL SITE PLANS #1 & #2


KAMEHAMEHA HIGHWAY - INSTALLATION OF HIGHWAY LIGHTS
MEHEULA PARKWAY TO KIPAPA STREET
PROJECT NO. 99C-01-92

SCALE: 1" = 40'-0" DATE:

SHEET No. 4 OF 10 SHEETS


SURVEY PLOTTED BY	DATE
DESIGNED BY	
QUANTITIES BY	
CHECKED BY	
ORIGINAL PLAN	
NOTE BOOK	
No.	

FED. ROAD DIST. NO.	STATE	FED. AID PROJ. NO.	FISCAL YEAR	SHEET NO.	TOTAL SHEETS
HAWAII	HAW.	99C-01-92	1992	5	10

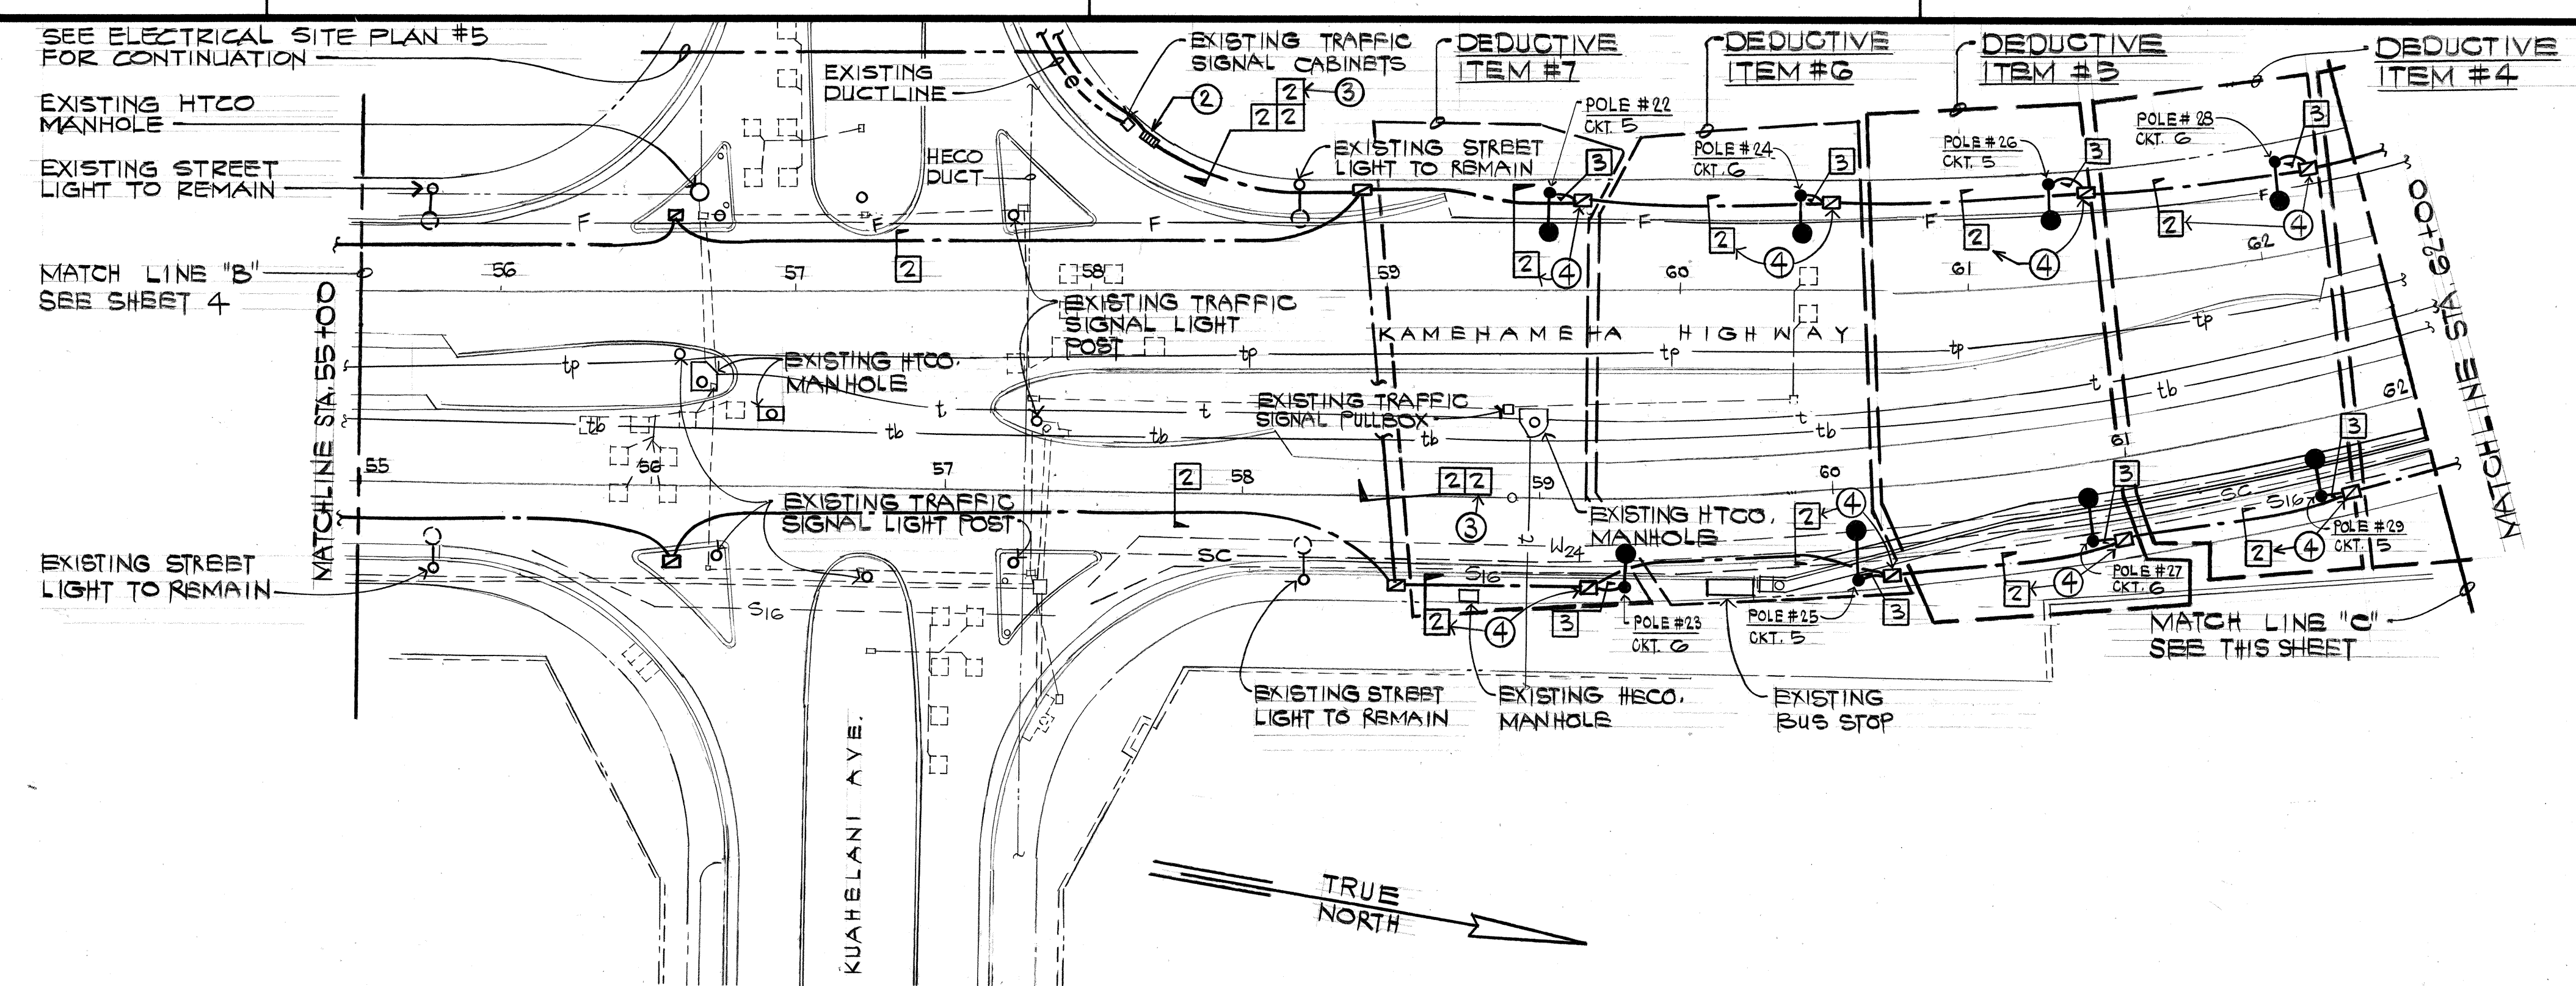


ELECTRICAL SITE PLAN #3
SCALE: 1" = 40'-0"



- NOTES:**
- ① PATCH ALL PAVEMENT, SIDEWALKS, CURBS, ETC. DAMAGED BY INSTALLATION OF NEW HIGHWAY LIGHTING SYSTEM TO MATCH EXISTING CONDITIONS.
 - ② NEW ELECTRICAL SERVICE EQUIPMENT SEE 
 - ③ SHOULD ALL 7 DEDUCTIVE ITEMS BE ELIMINATED FROM THE PROJECT, THE PLANNED 2" PVC DUCTLINE FOR CIRCUITS #5 & #6 SHALL BE INSTALLED WITH PULLSTRING ONLY.
 - ④ ALL UNUSED CIRCUIT CONDUCTORS SHALL BE HOT CAPPED IN THE INDICATED HANDHOLE.

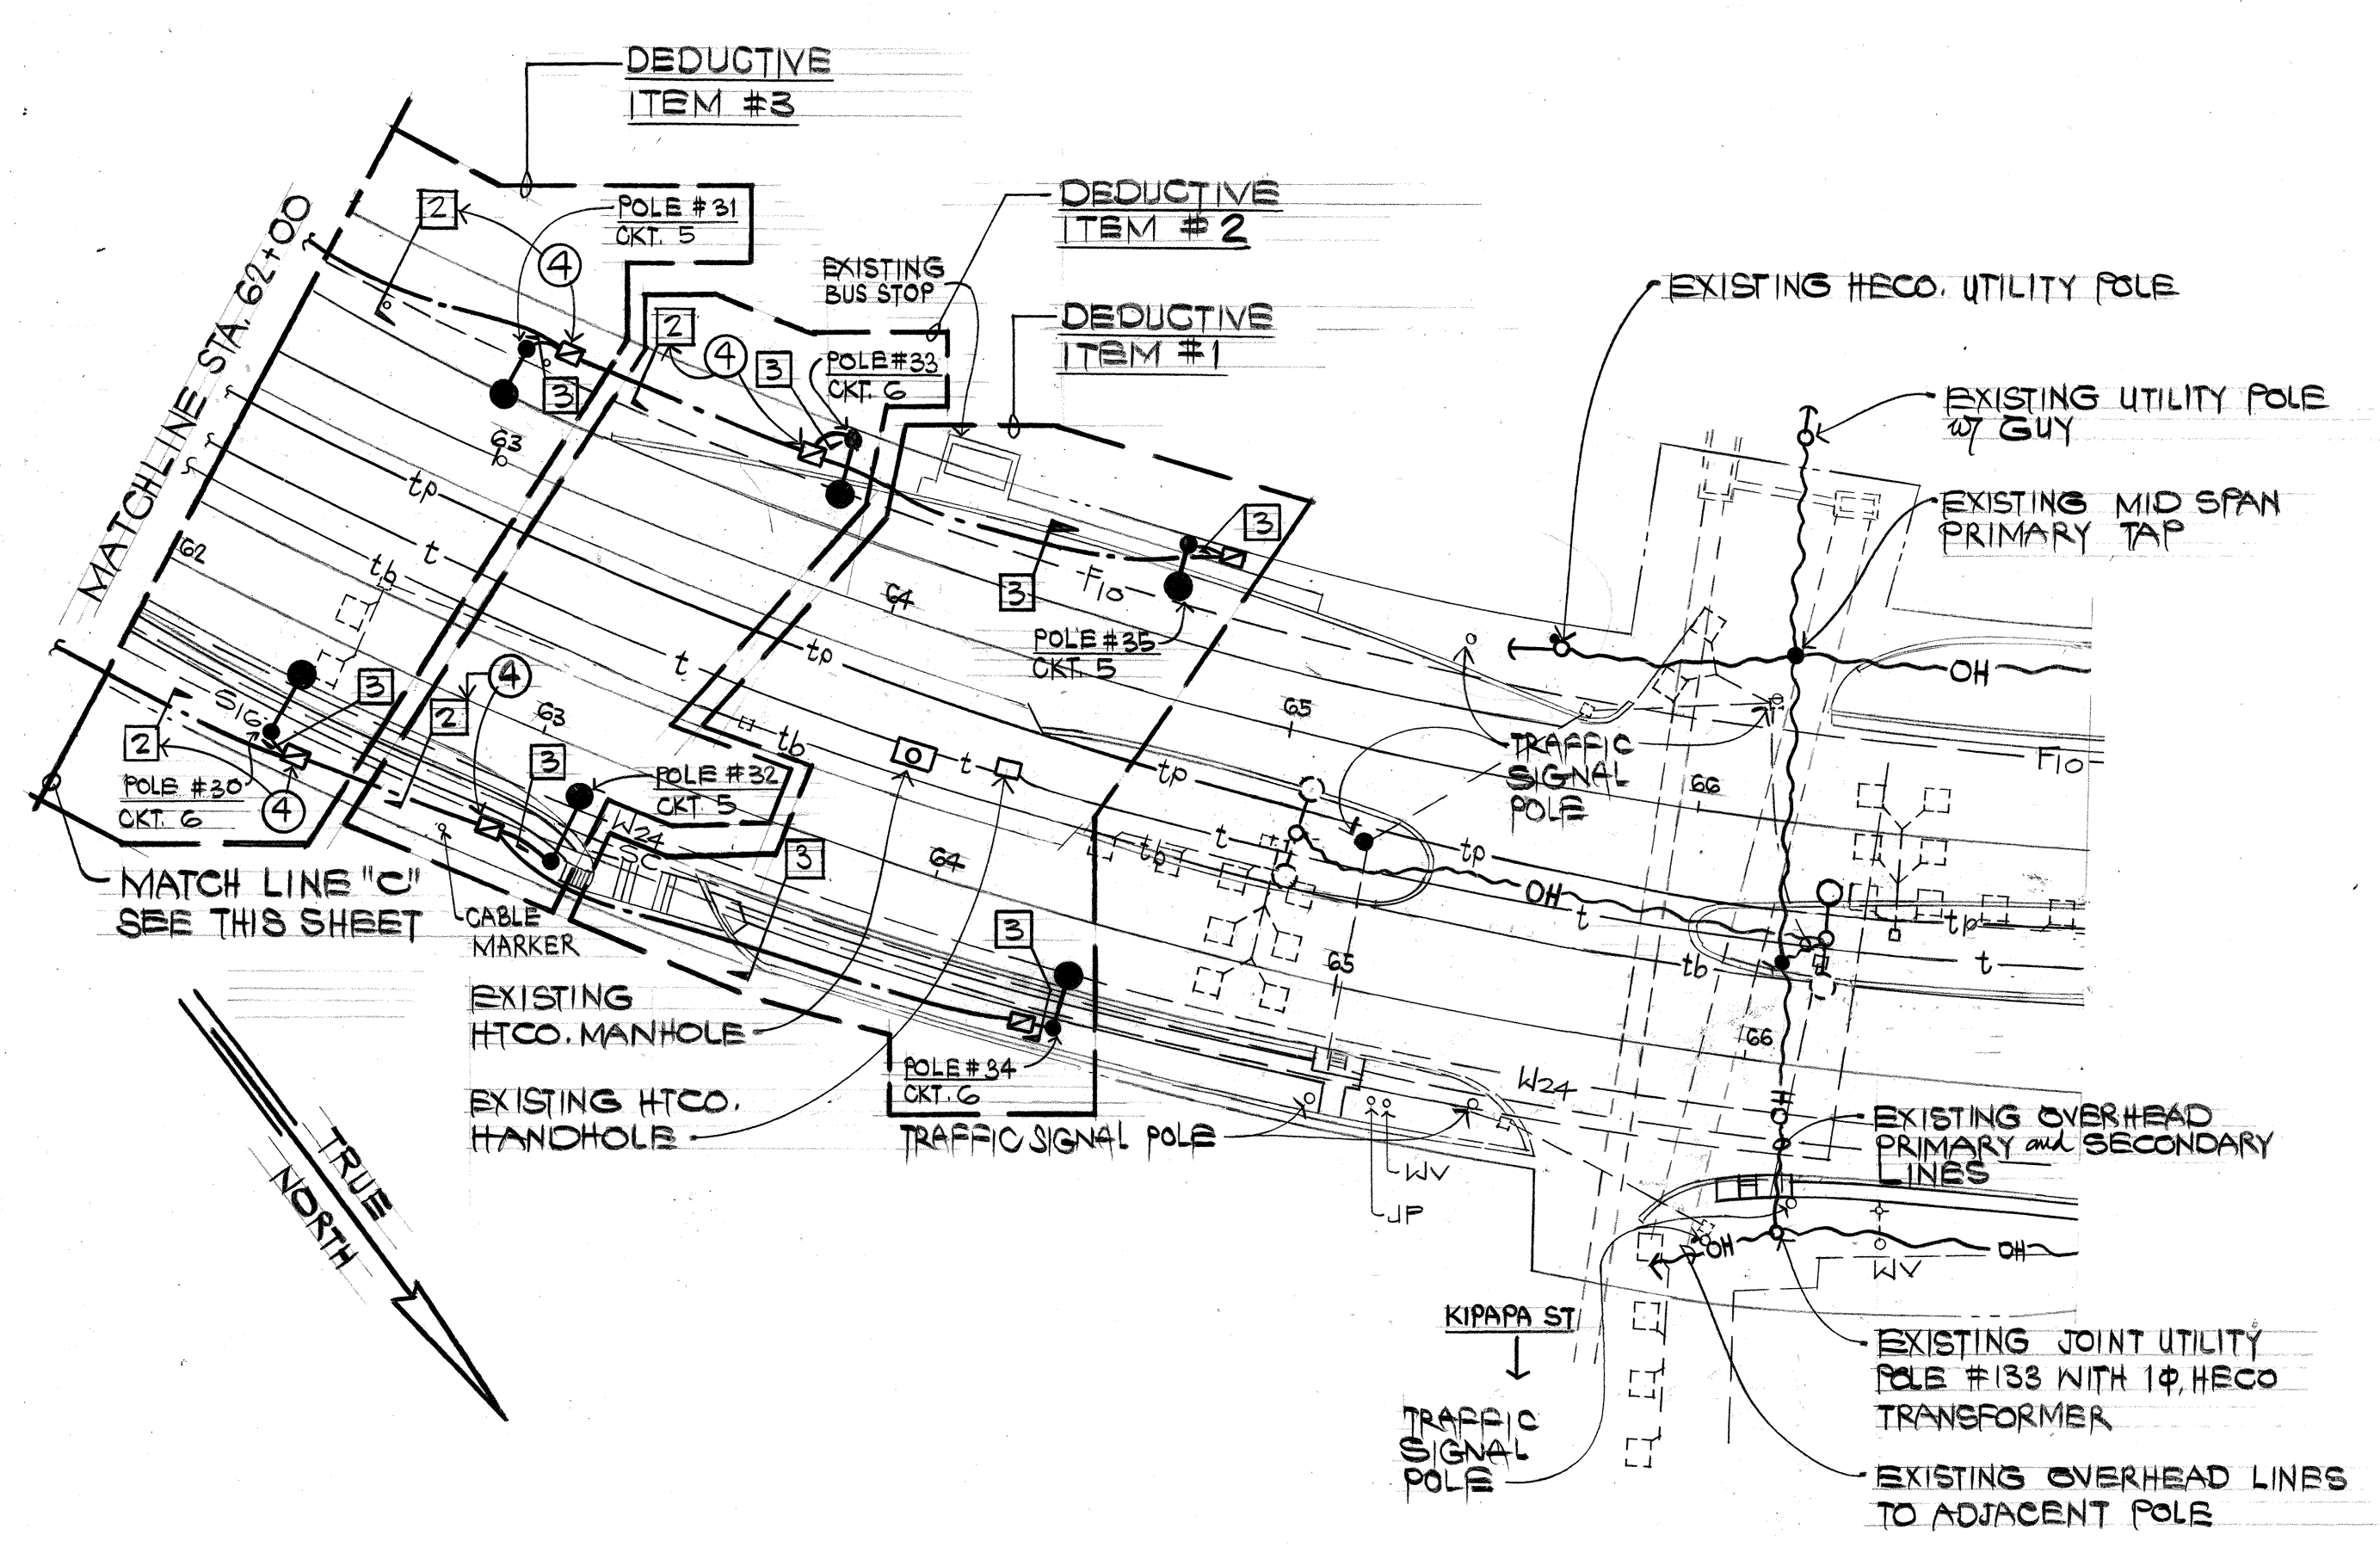

ELECTRICAL SITE PLAN #4
SCALE: 1" = 40'-0"

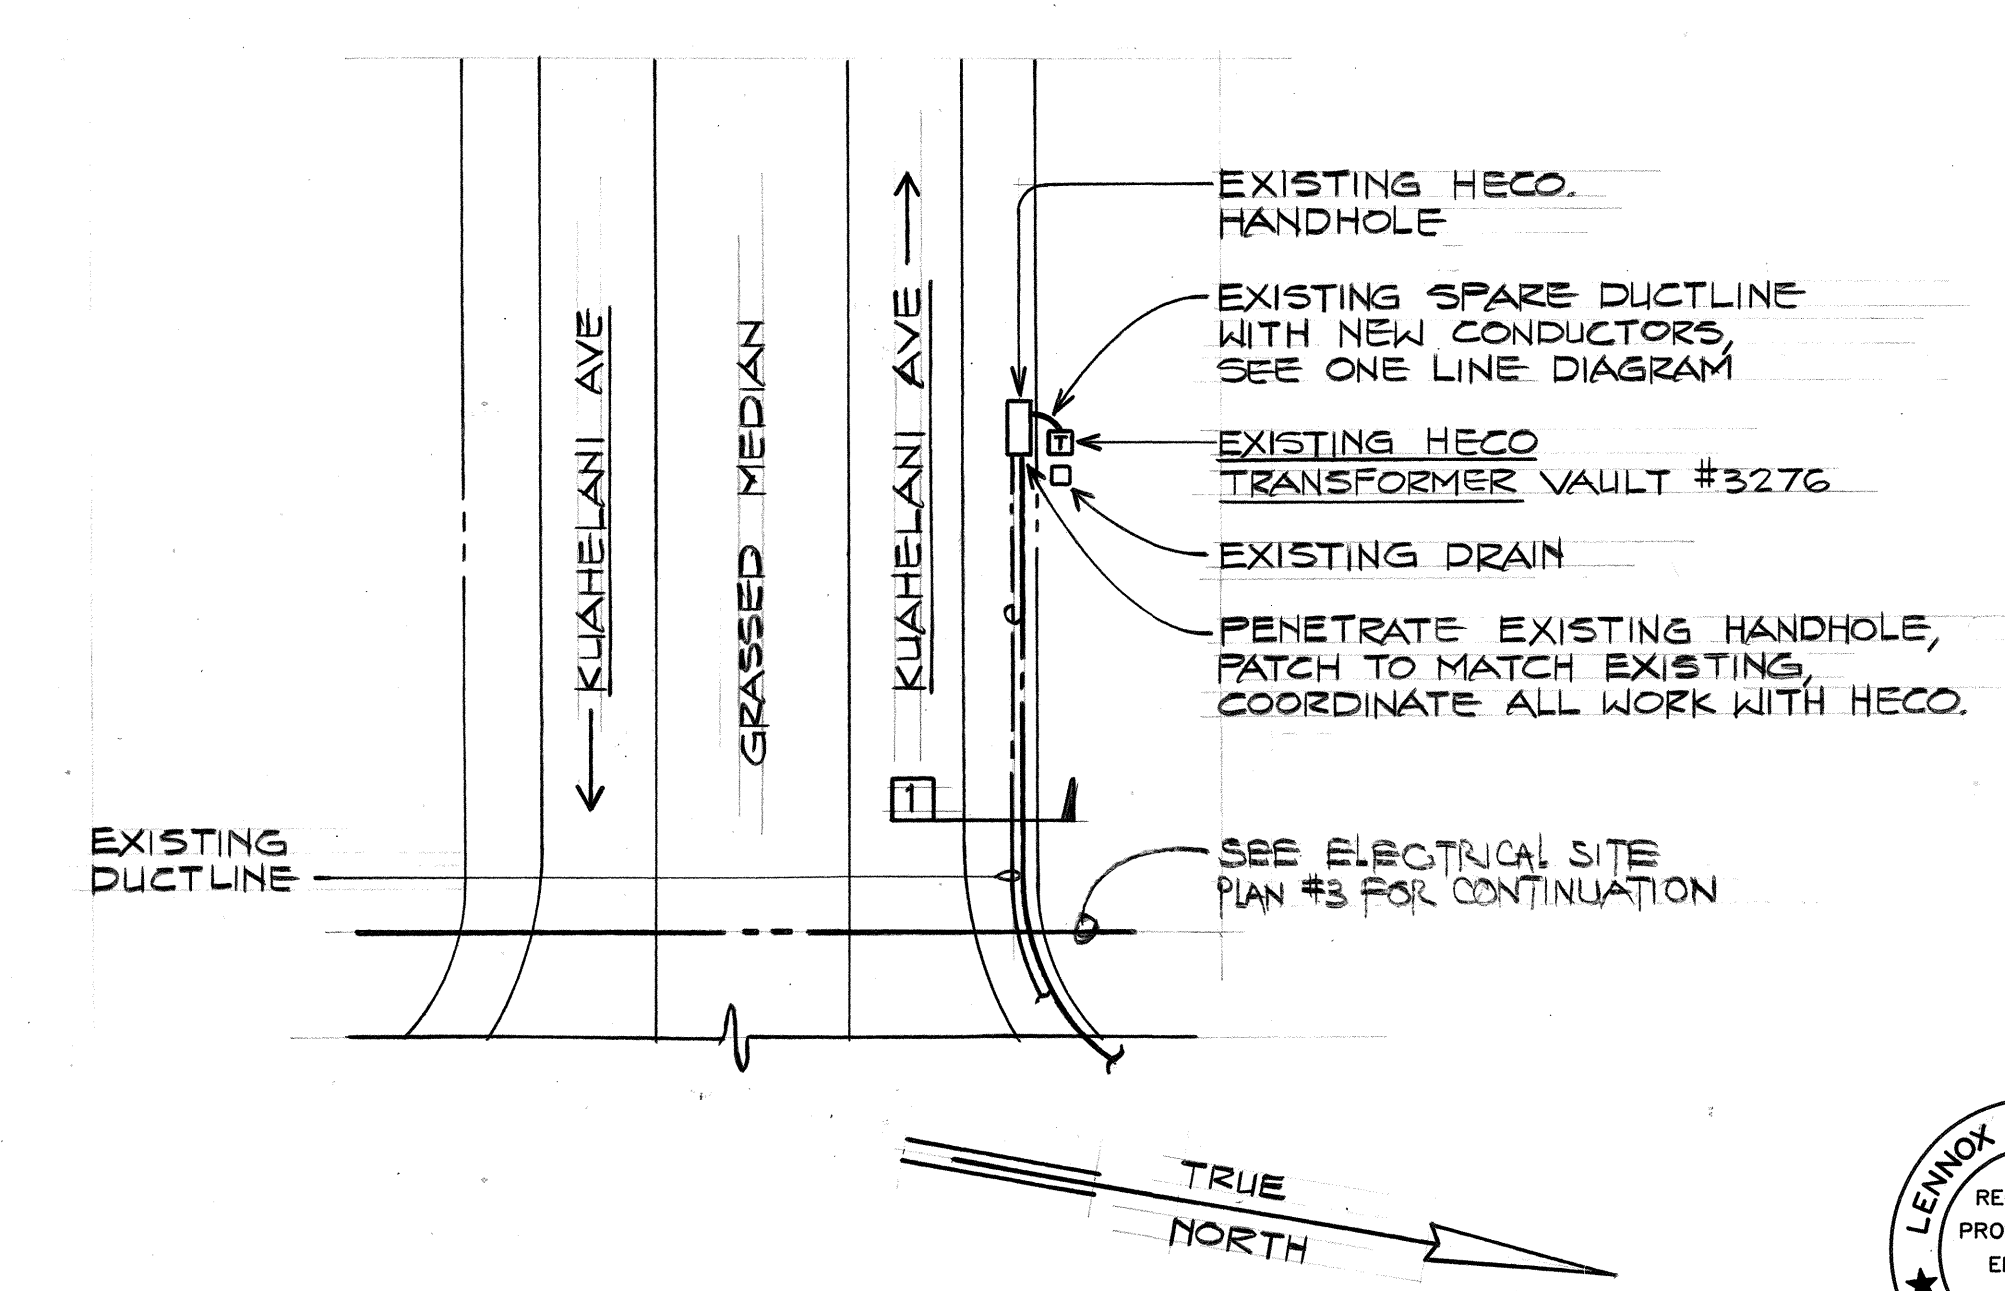

ELECTRICAL SITE PLAN #5
SCALE: 1" = 40'-0"

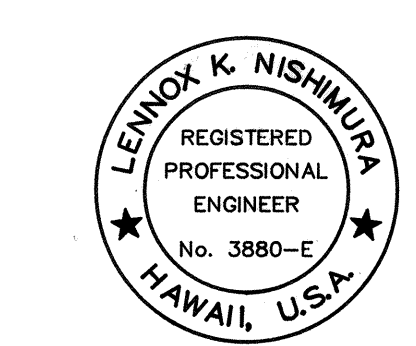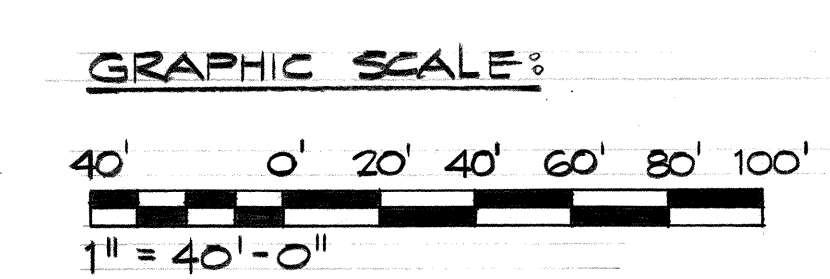

This work was prepared by me or under my supervision
ECS INC.
By *Lennox K. Nishimura*
Its PROJECT ENGINEER
Date DEC. 9, 1991

STATE OF HAWAII
DEPARTMENT OF TRANSPORTATION
HIGHWAYS DIVISION

ELECTRICAL SITE PLANS #3, #4, & #5

KAMEHAMEHA HIGHWAY - INSTALLATION OF HIGHWAY LIGHTS
MEHEULA PARKWAY TO KIPAPA STREET
PROJECT NO. 99C-01-92

SCALE: 1" = 40'-0" DATE:

SHEET No. 5 OF 10 SHEETS

SURVEY PLOTTED BY	DATE
DESIGNED BY	
NOTED BY	
CHECKED BY	
ORIGINAL PLAN	
NO.	