

INDEX TO DRAWINGS	
SHEET NO.	DESCRIPTION
1	TITLE SHEET
2	GENERAL NOTES
3	ELECTRICAL SYMBOL LIST, ONE-LINE DIAGRAM, GENERAL NOTES
4	ELECTRICAL SITE PLANS #1 & #2
5	ELECTRICAL SITE PLANS #3, #4, & #5
6	LIGHT STANDARD SCHEDULE, PANEL SCHEDULE
7	MISCELLANEOUS DETAILS
8	STREET LIGHT POLE DETAILS
9	SLIP BASE DETAILS
10	ELECTRICAL SERVICE EQUIPMENT ENCLOSURE

STATE OF HAWAII
DEPARTMENT OF TRANSPORTATION
HIGHWAYS DIVISION
HONOLULU, HAWAII

PLANS FOR


KAMEHAMEHA HIGHWAY

INSTALLATION OF HIGHWAY LIGHTS


MEHEULA PARKWAY TO KIPAPA STREET

PROJECT NO. 99C-01-92

FED. ROAD DIST. NO.	STATE	PROJ. NO.	FISCAL YEAR	SHEET NO.	TOTAL SHEETS
HAWAII	HAW.	99C-01-92	1992	1	10

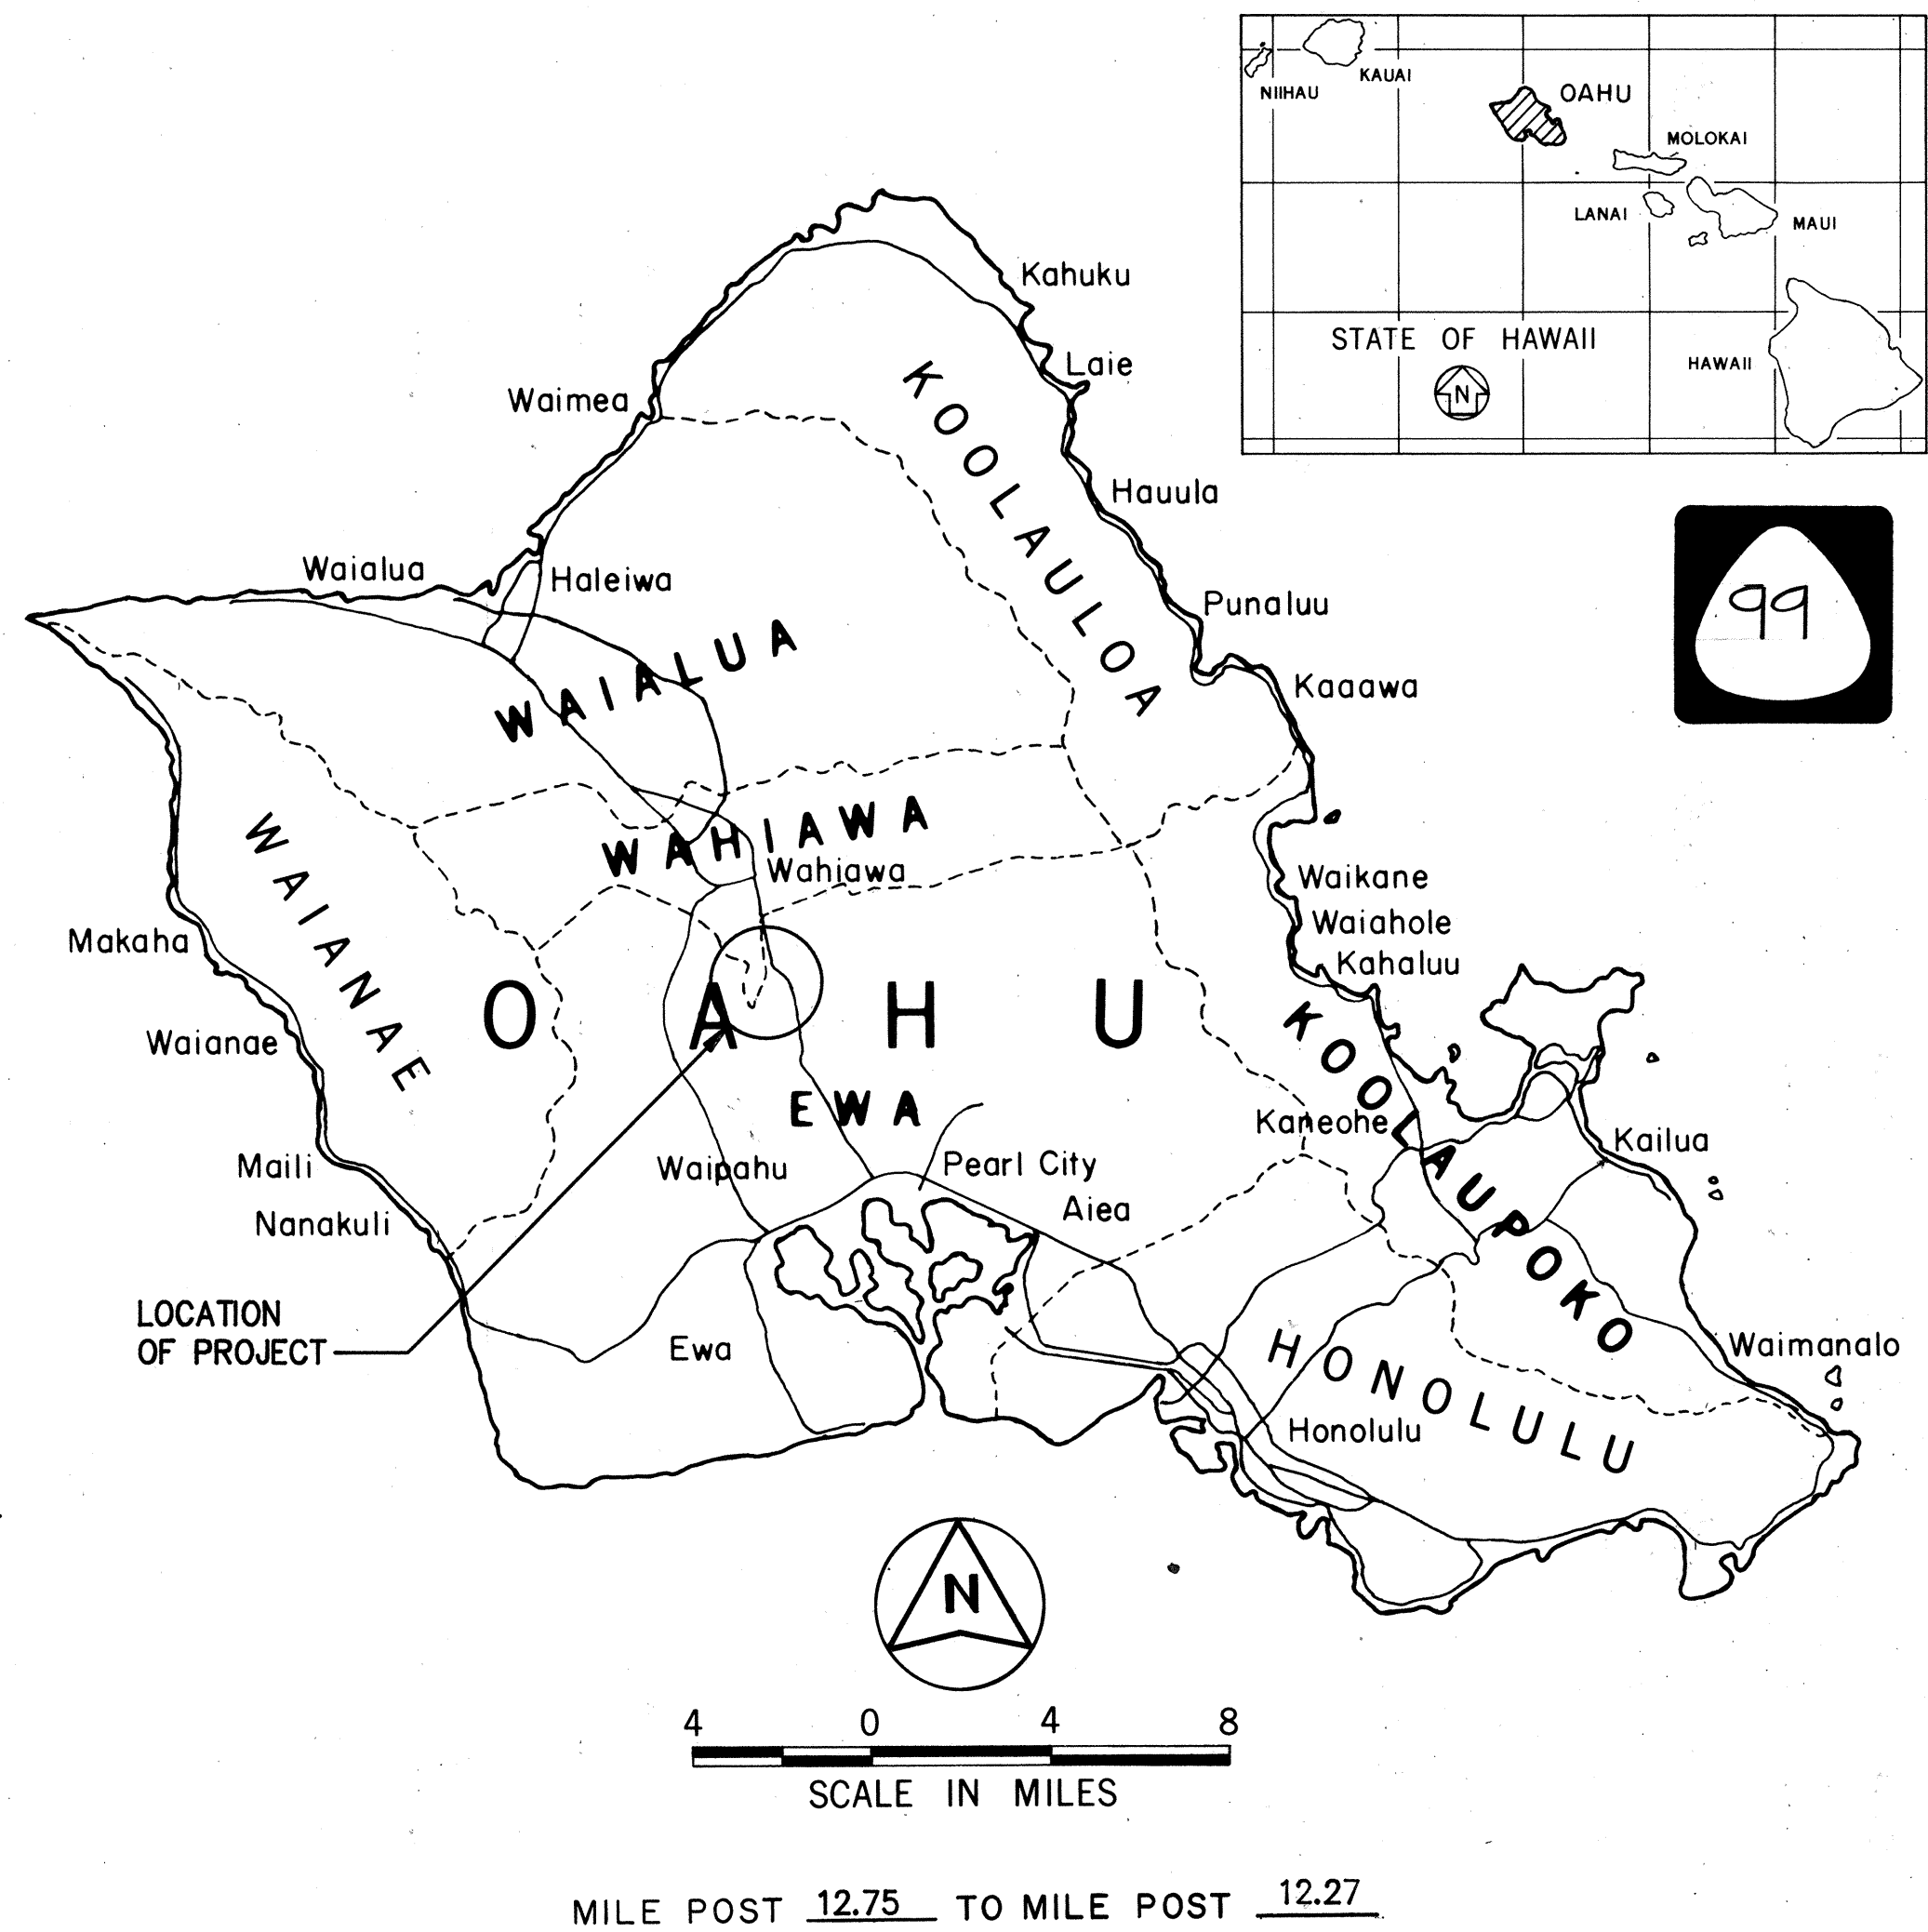

DISTRICT OF EWA
ISLAND OF OAHU

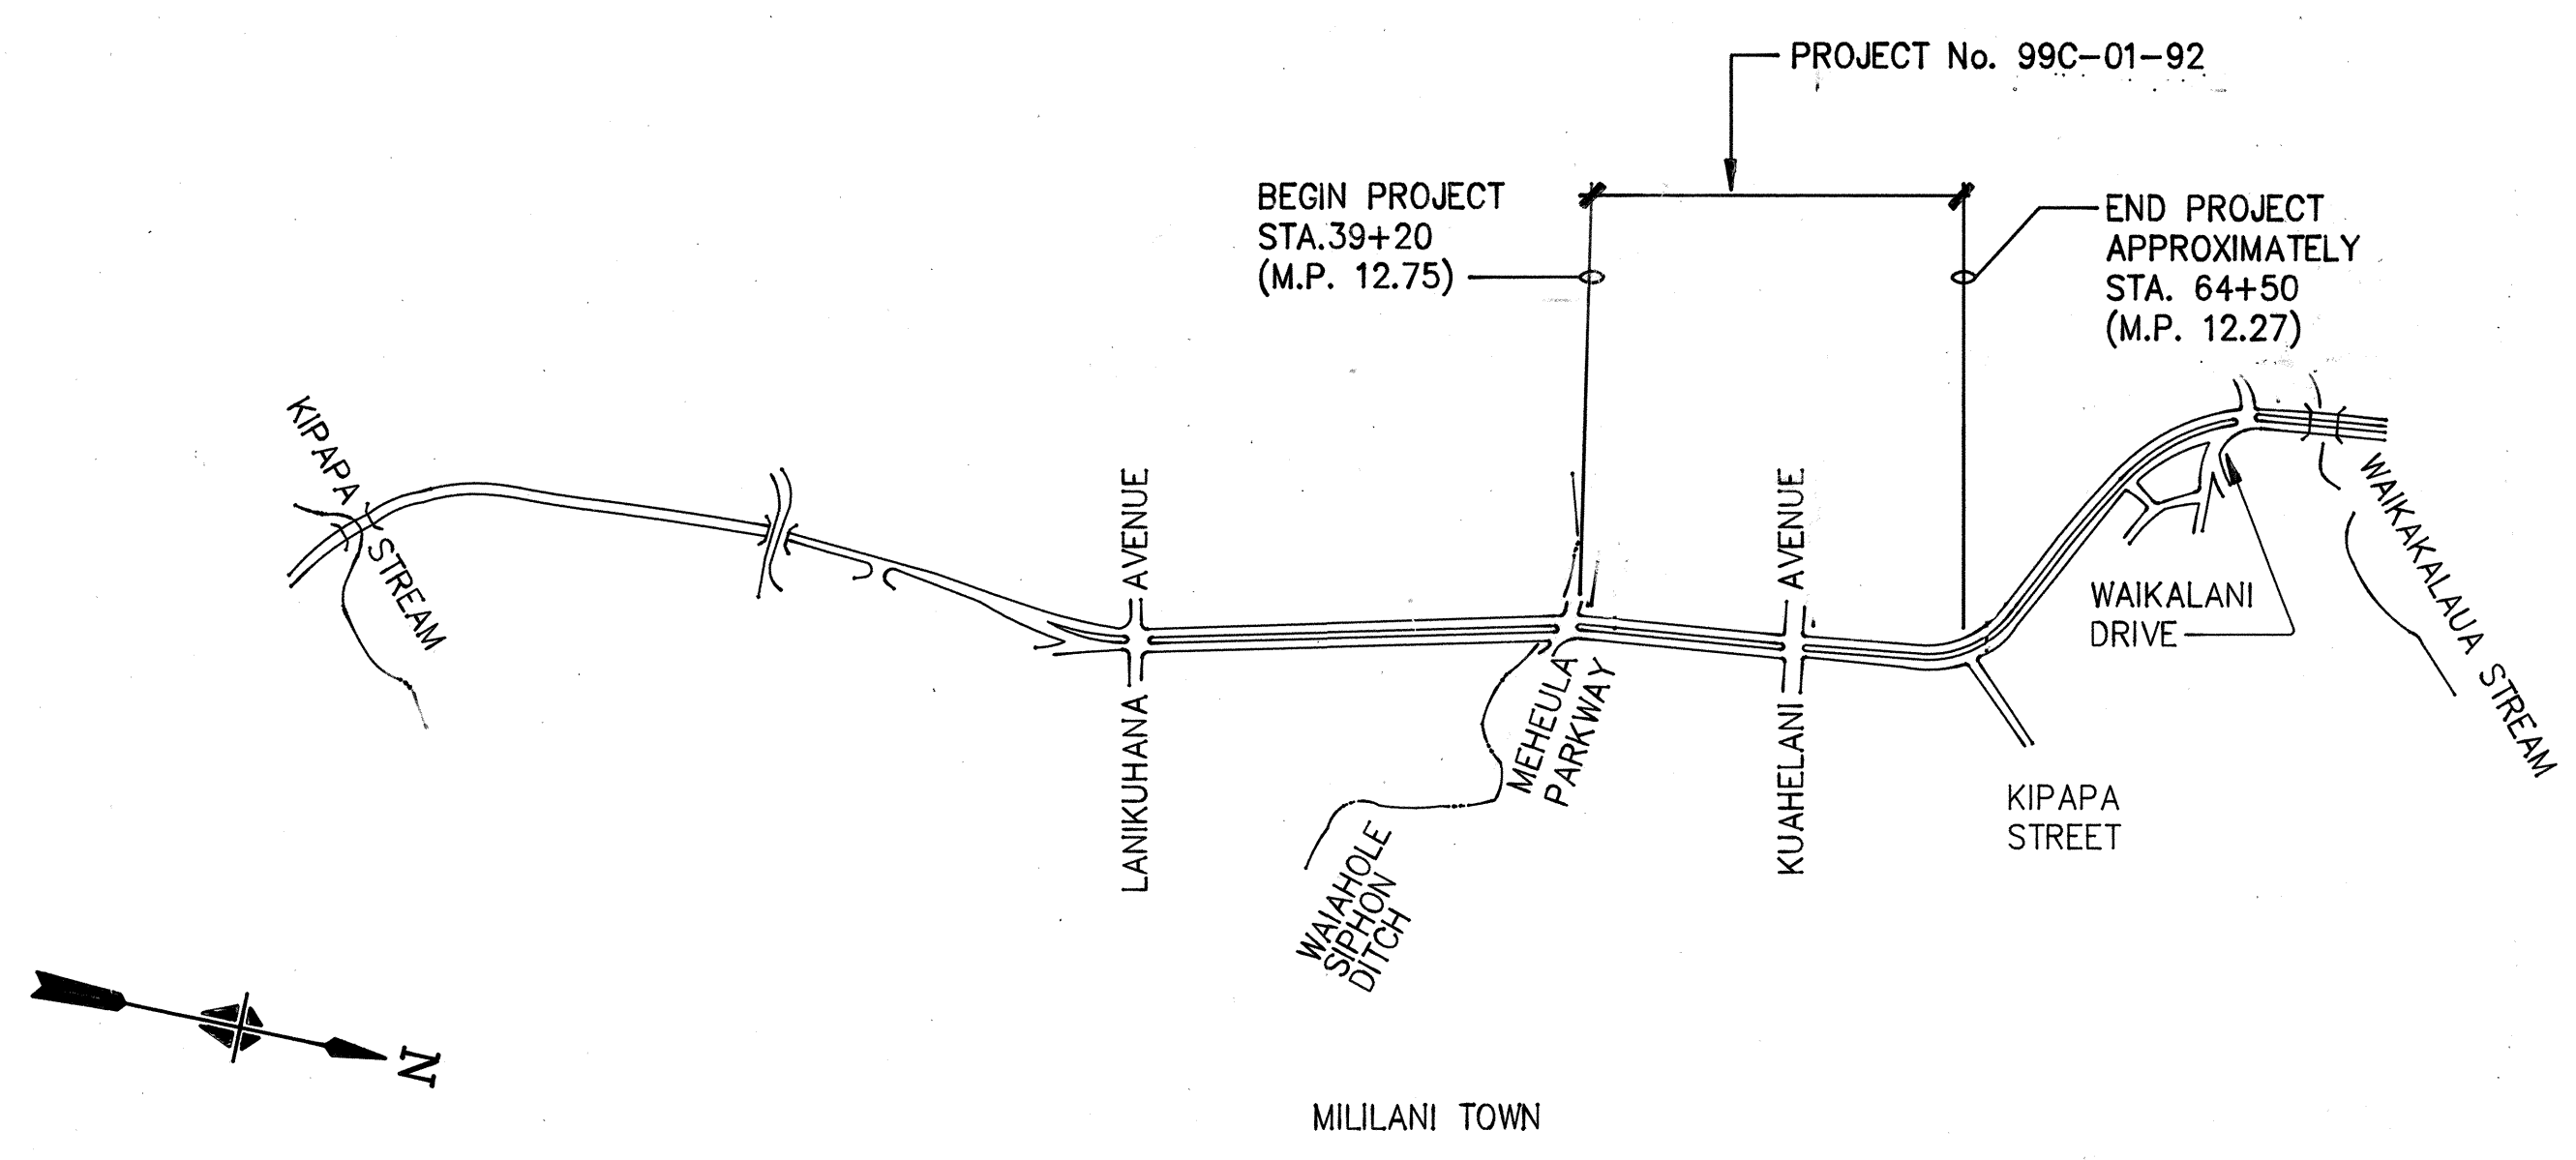

LOCATION MAP
NOT TO SCALE
(LENGTH OF PROJECT: APPROX. 0.5 MILES)

DESIGNED BY
HERBERT T. TAO
P. S. & E. BY
587-2124
PHONE
DATE
DECEMBER 9, 1991

DEPARTMENT OF TRANSPORTATION
STATE OF HAWAII
APPROVED:
DIR. OF TRANSPORTATION
DATE
12/17/91