

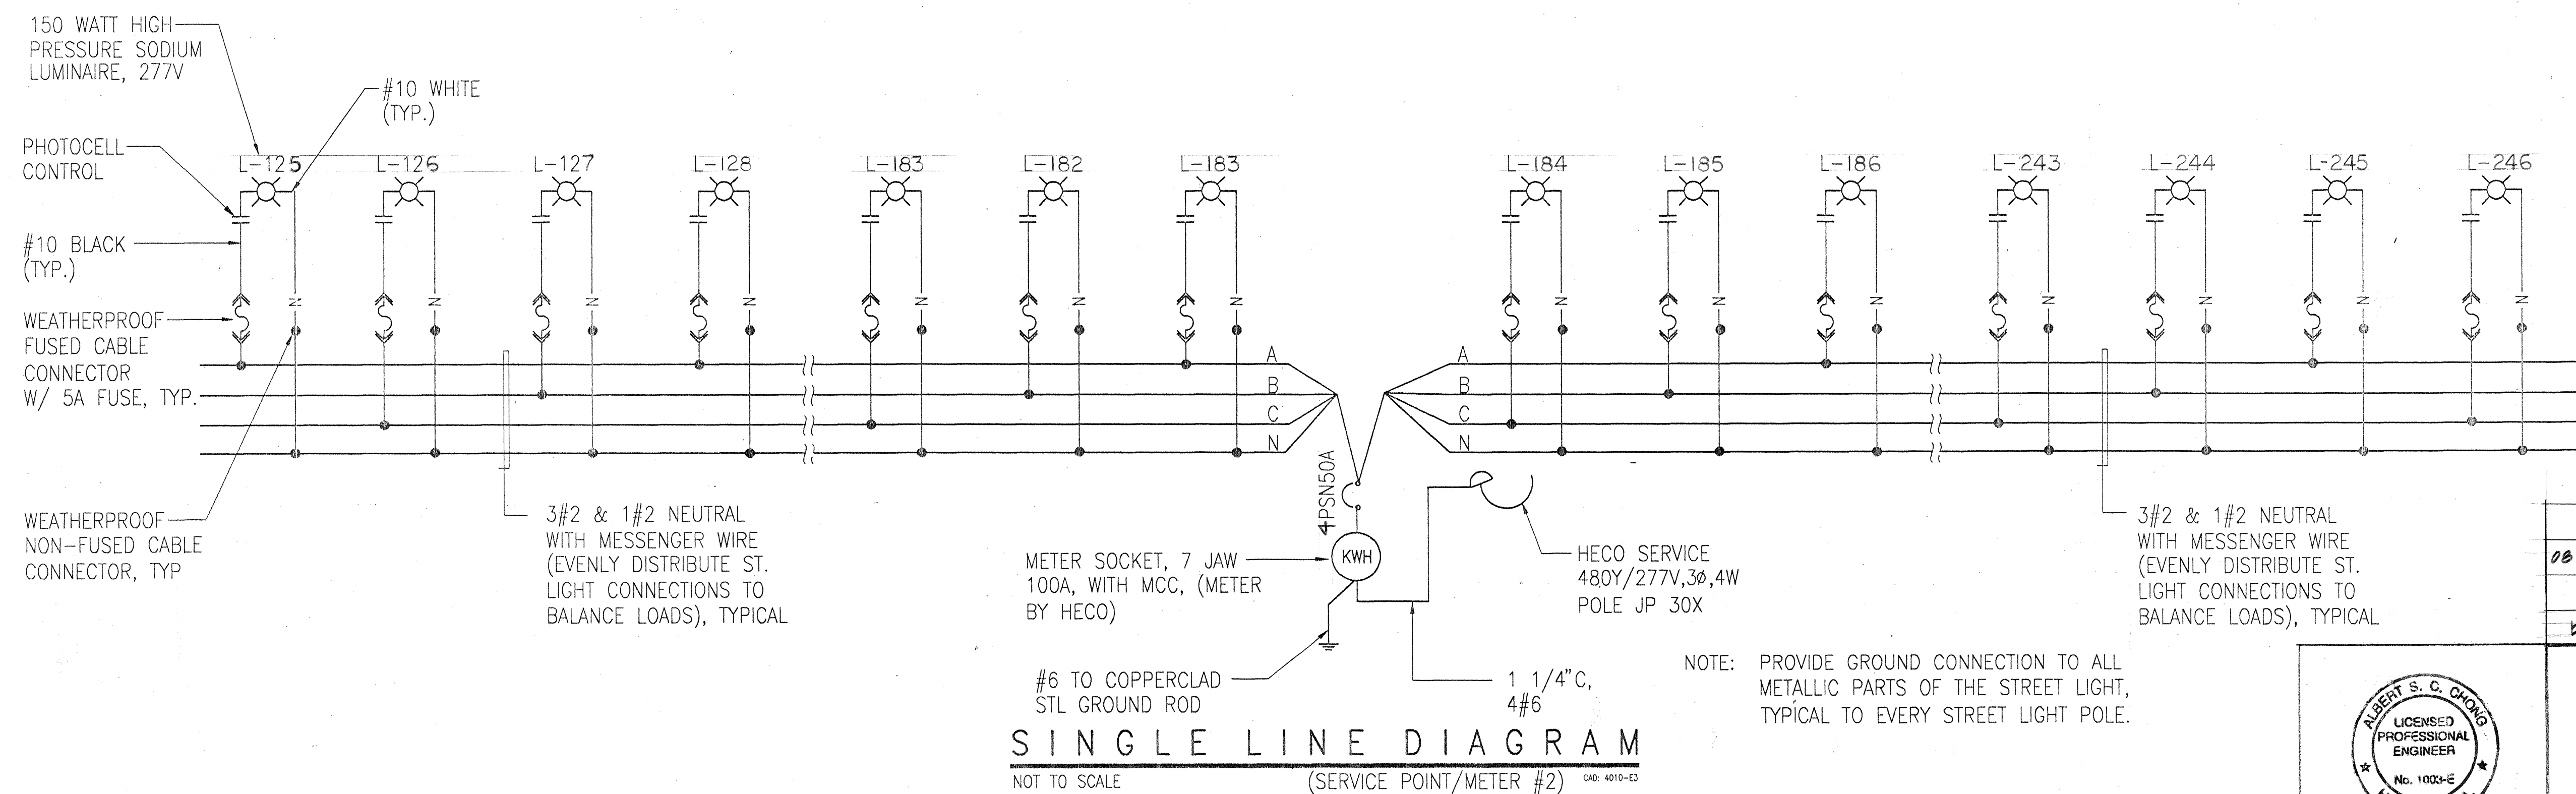


FED. ROAD DIST. NO.	STATE	FED. AID PROJ. NO.	FISCAL YEAR	SHEET NO.	TOTAL SHEETS
HAWAII	HAW.	99A-02-94	1996	14	16

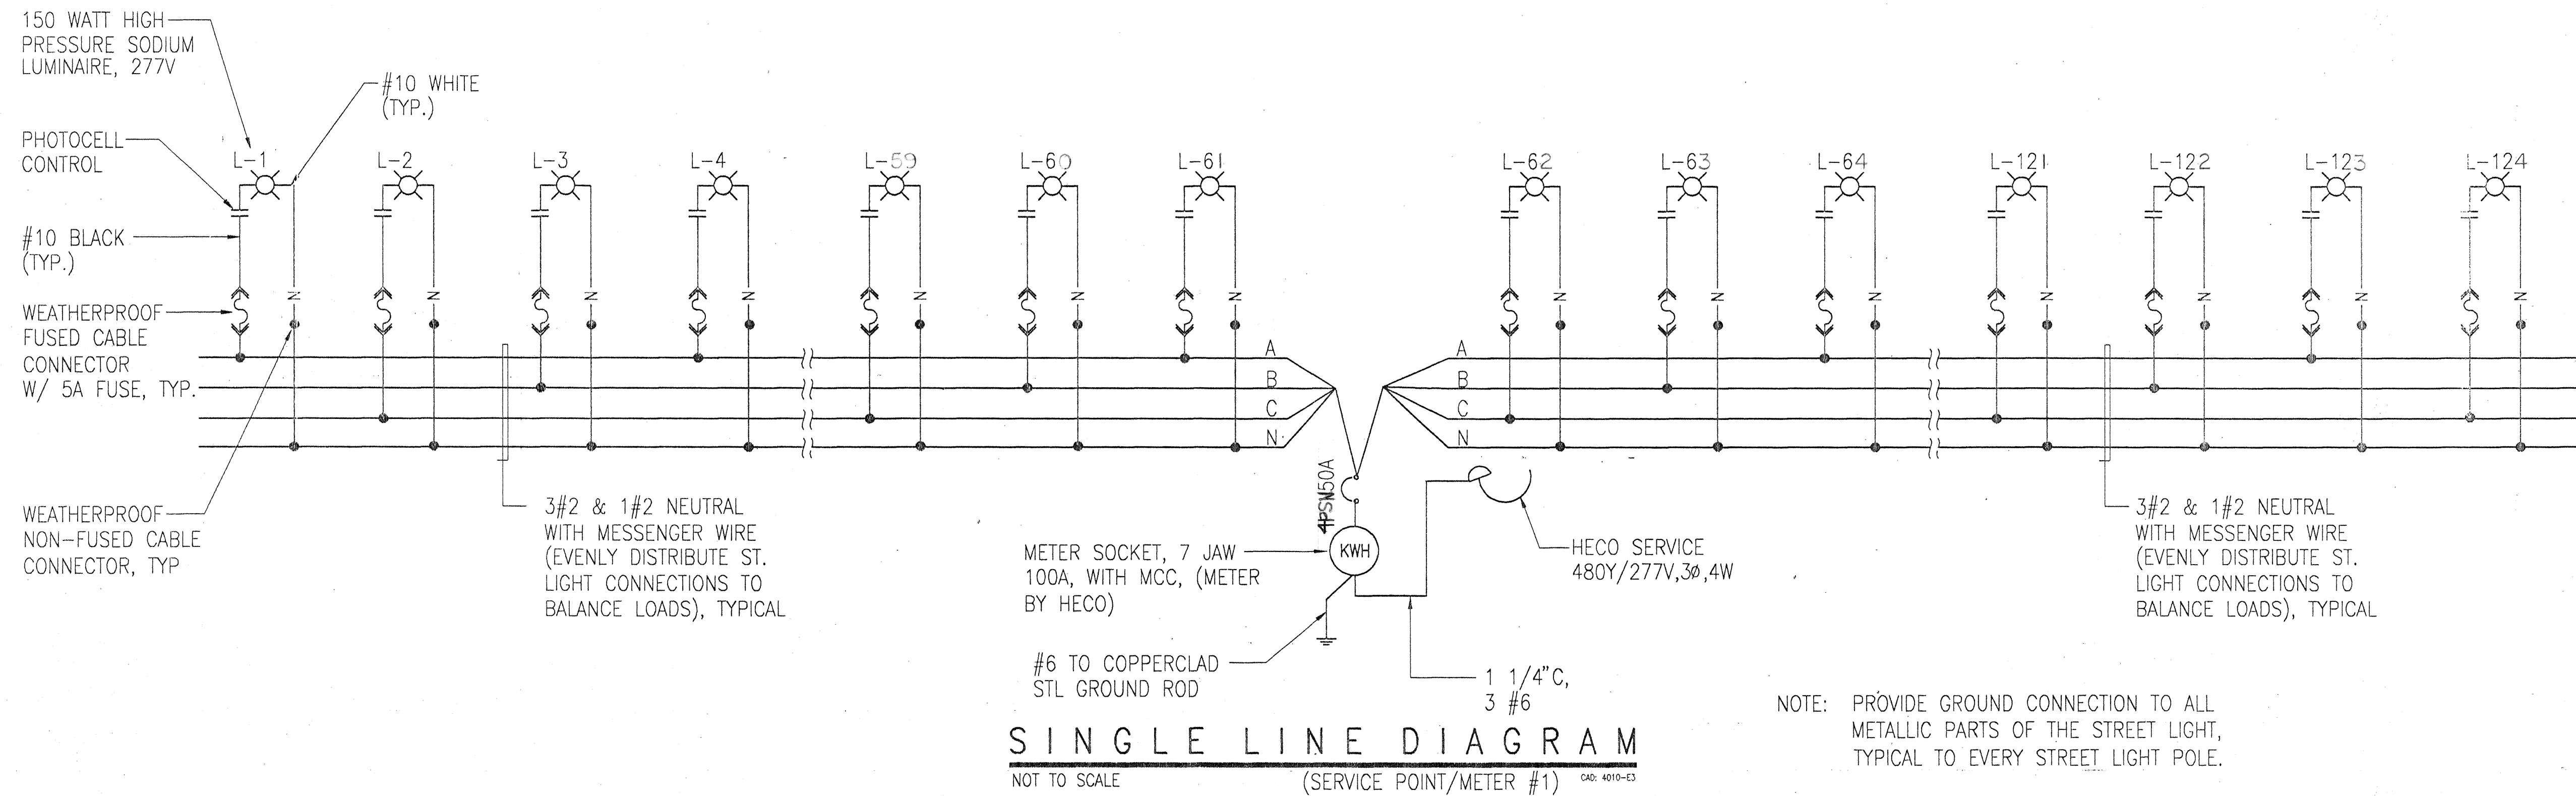

DATE
SURVEY PLOTTED BY
DRAWN BY
DESIGNED BY
QUANTITIES BY
CHECKED BY
ORIGINAL PLAN
NOTE BOOK
NO.

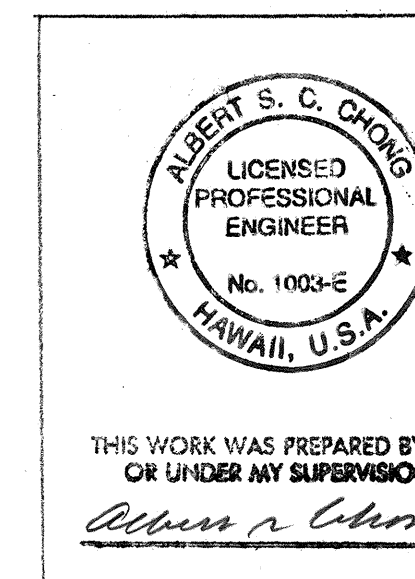

06-12-97	REVISED STREET LIGHTS
	NUMBERING
DATE	REVISION
STATE OF HAWAII DEPARTMENT OF TRANSPORTATION HIGHWAYS DIVISION	
SINGLE LINE DIAGRAM KAMEHAMEHA HIGHWAY STREET LIGHTS WEED JUNCTION TO POAMOHU BRIDGE PROJ. NO. 99A-02-94	
DISTRICT OF WAIALUA, ISLAND OF OAHU	
SCALE: AS NOTED	DATE: MAY 3, '96
SHEET No. 14 OF 16 SHEETS	


FED. ROAD DIST. NO.	STATE	FED. AID PROJ. NO.	FISCAL YEAR	SHEET NO.	TOTAL SHEETS
HAWAII	HAW.	99A-02-94	1996	15	16

LEGEND:


A = METER NUMBER
B = LIGHT NUMBER (NOTE: FOR NUMBER SEE PLAN)
C = LAMP DATA, 150W
D = REFRACTOR DATA TYPE NO. III MEDIUM CUTOFF

NOTES:


1. TAG - MAKE FROM PLASTIC SHEET (GRAVOFLEX/3 PLY) LAMINATED BLACK-WHITE-BLACK
2. MOUNTING HEIGHT OF TAG = 6'-0" FROM FINISH GRADE
3. LETTERS - NO. 5 REDUCTION, 1/5, STENCILLED
4. ATTACHED TO WOOD POLE WITH NO. 7 4D STAINLESS STEEL NAILS

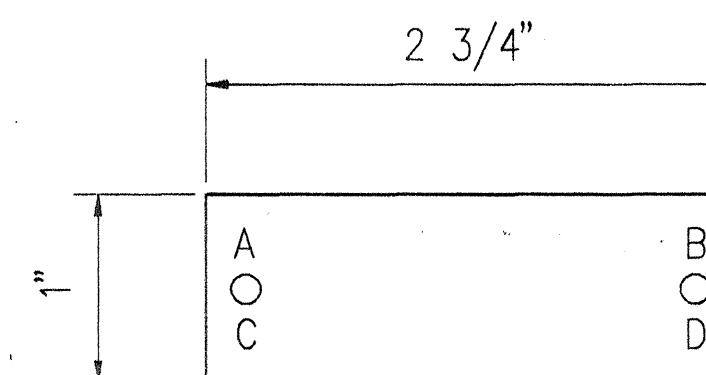

2 IDENTIFICATION TAG DETAIL
NOT TO SCALE CAD: 4010-E4

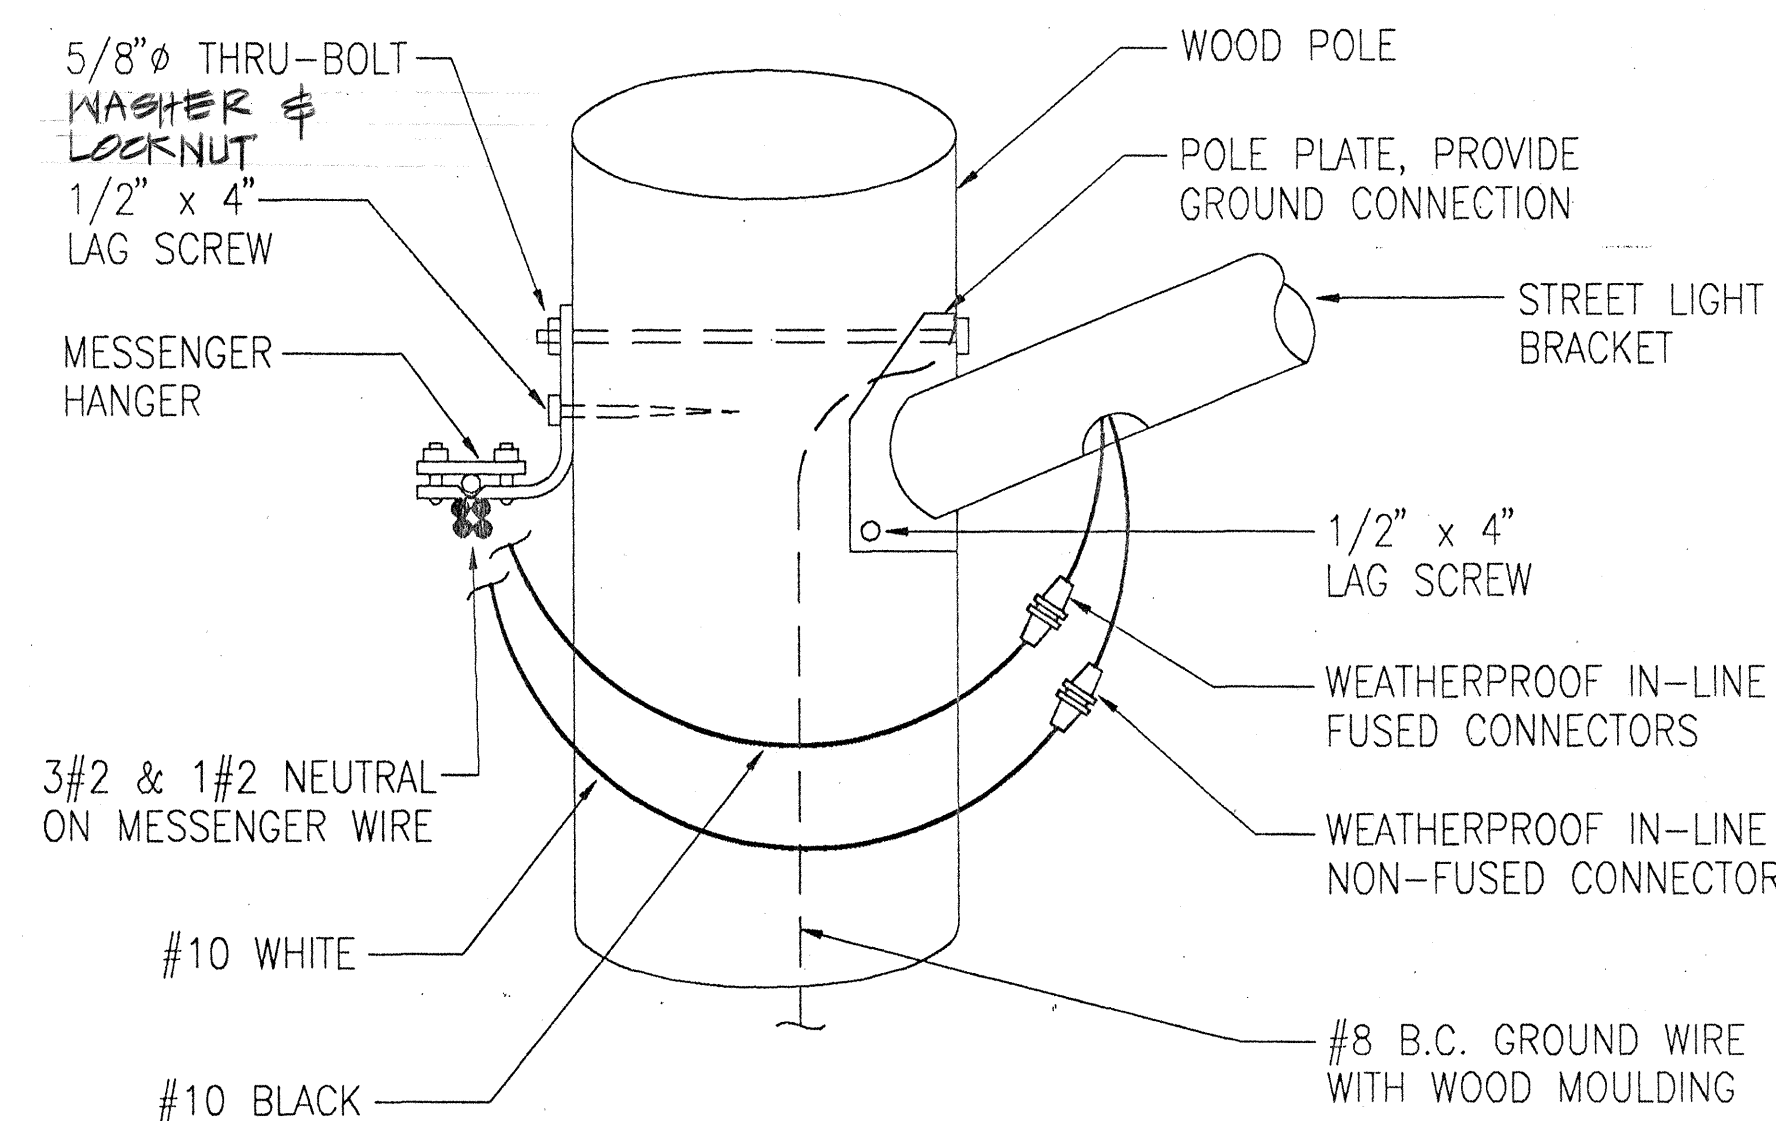

3 DETAIL
NOT TO SCALE CAD: 4010-E4

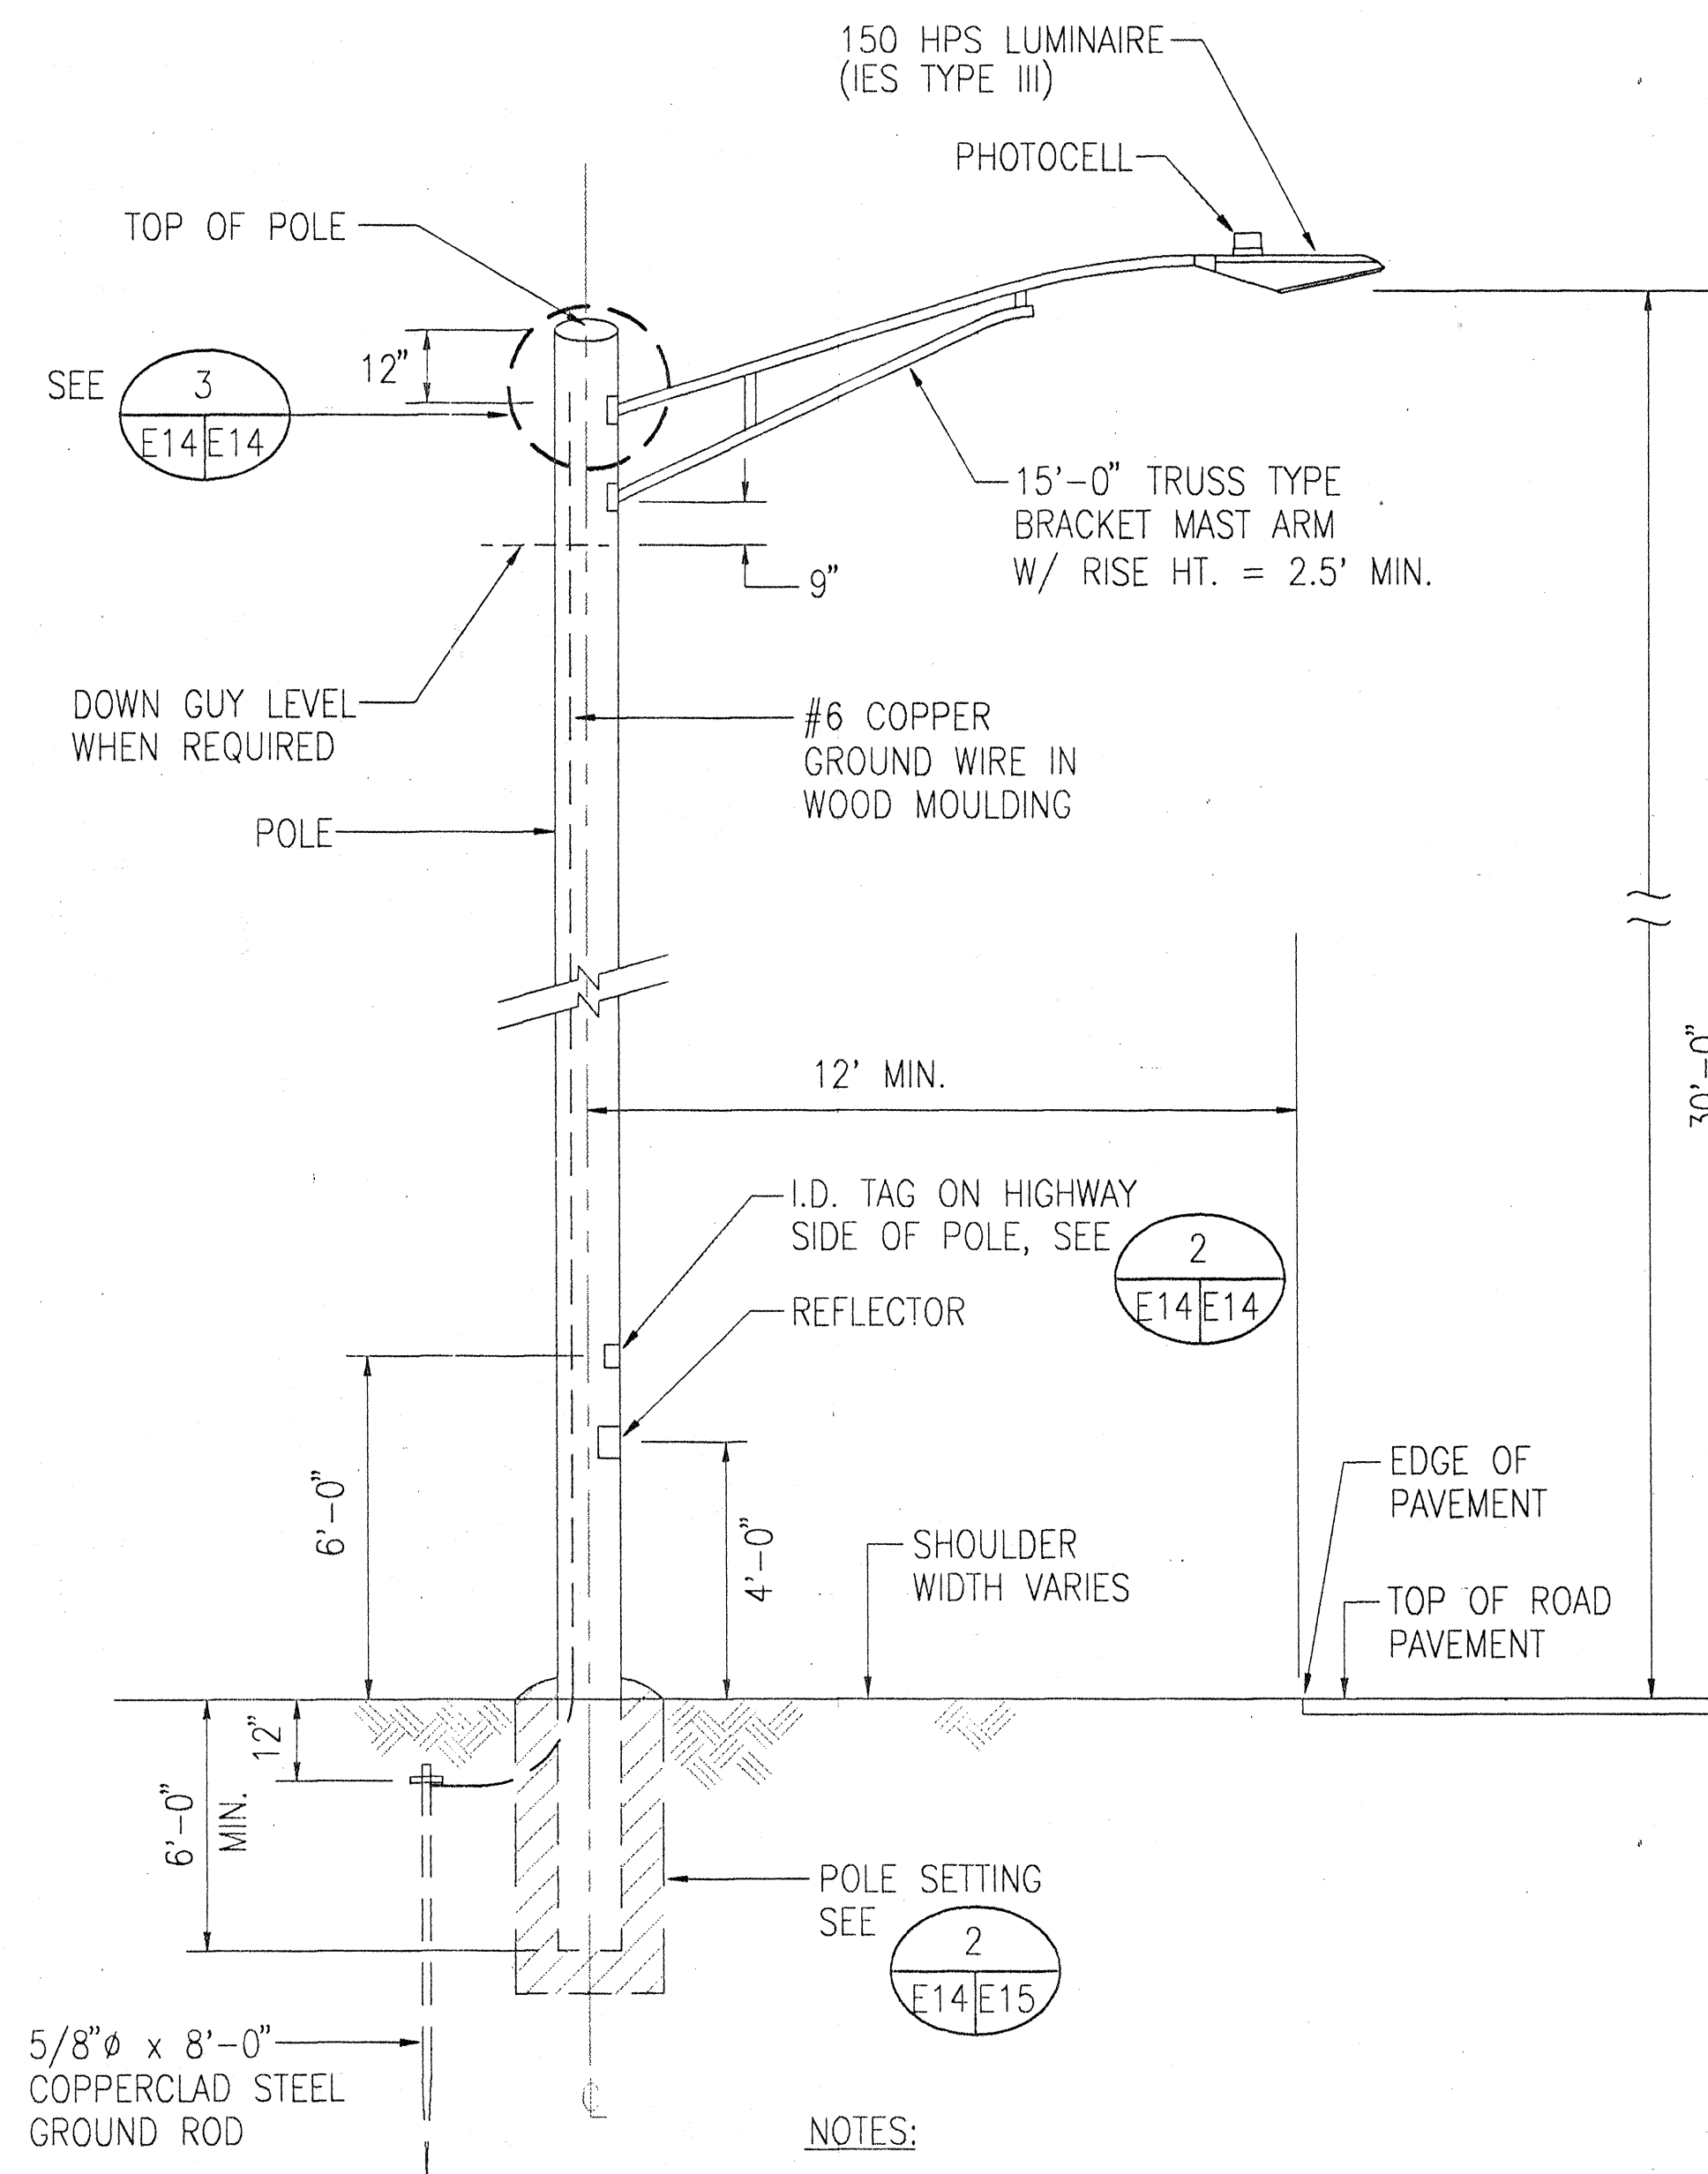

NOTES:

1. NEW POLE MOUNTING, SHOWN, FOR MOUNTING ON EXIST POLE, SIMILAR
2. ALL NEW POLES - 40' CLASS 3 UNLESS OTHERWISE NOTED BY THE SYMBOL - [35], 35 = 35' CLASS 3 POLE, [45], 45 = 45' CLASS 3 POLE, ETC.

1 TYPICAL WOOD POLE ELEVATION
NOT TO SCALE CAD: 4010-E4

SURVEY PLOTTED BY	DATE
DRAWN BY	
DESIGNED BY	
QUANTITIES BY	
CHECKED BY	
ORIGINAL PLAN	
NOTE BOOK	
No.	

THIS WORK WAS PREPARED BY ME OR UNDER MY SUPERVISION

Albert S. C. Chong

STATE OF HAWAII
DEPARTMENT OF TRANSPORTATION
HIGHWAYS DIVISION

POLE DETAILS

KAMEHAMEHA HIGHWAY STREET LIGHTS
WEED JUNCTION TO POAMOHU BRIDGE
PROJ. NO. 99A-02-94

DISTRICT OF WAIALUA, ISLAND OF OAHU
SCALE: AS NOTED DATE: MAY 3, 1996

