


INDEX TO DRAWINGS	
SHEET NO.	DESCRIPTION
1	TITLE SHEET
2	ELECTRICAL SITE PLAN I& ELECTRICAL SYMBOLS
3	ELECTRICAL SITE PLAN II
4	ELECTRICAL SITE PLAN III
5	ELECTRICAL SITE PLAN IV
6	ELECTRICAL SITE PLAN V
7	ELECTRICAL SITE PLAN VI
8	ELECTRICAL SITE PLAN VII
9	ELECTRICAL SITE PLAN VIII
10	ELECTRICAL SITE PLAN IX
11	ELECTRICAL SITE PLAN X
12	ELECTRICAL SITE PLAN XI
13	ELECTRICAL SITE PLAN XII
14	SINGLE LINE DIAGRAM
15	POLE DETAILS
16	POLE DETAILS




STATE OF HAWAII
DEPARTMENT OF TRANSPORTATION
HIGHWAYS DIVISION
HONOLULU, HAWAII

"AS-BUILT"

PLANS FOR
KAMEHAMEHA HIGHWAY STREET LIGHTS
WEED JUNCTION TO POAMOHO BRIDGE
PROJECT NO. 99A-02-94
DISTRICT OF WAIALUA
ISLAND OF OAHU

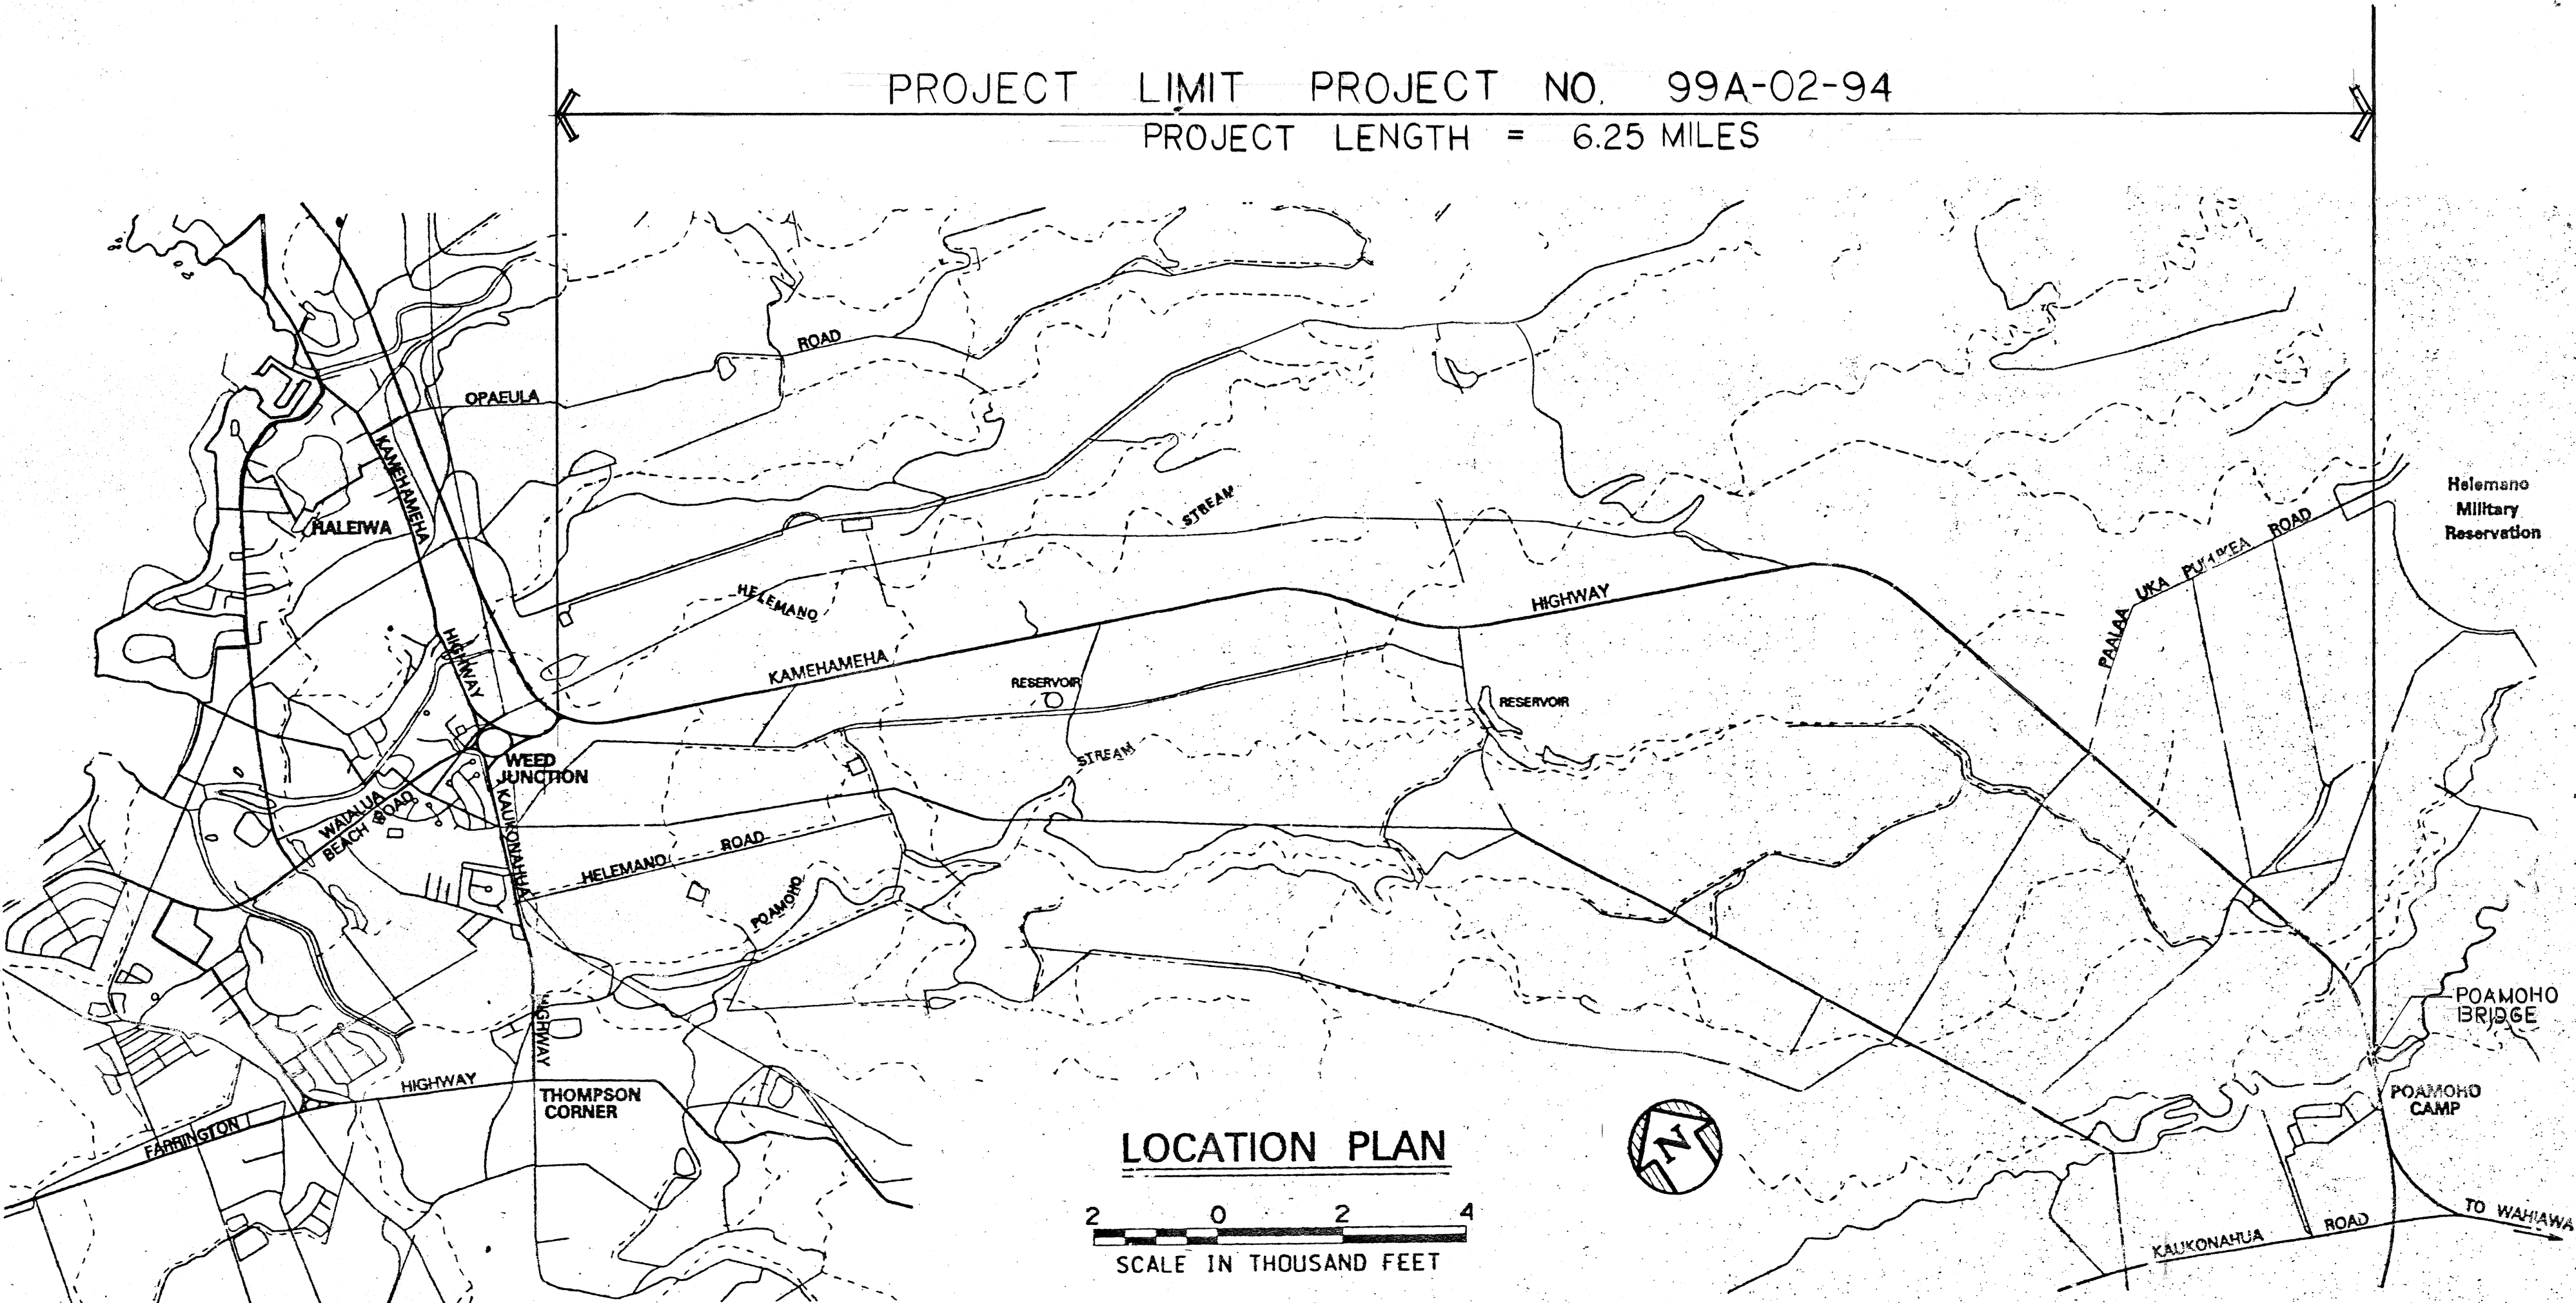

FED. ROAD DIST. NO.	STATE	PROJ. NO.	FISCAL YEAR	SHEET NO.	TOTAL SHEETS
HAWAII	HAW.	99A-02-94	1996	1	16

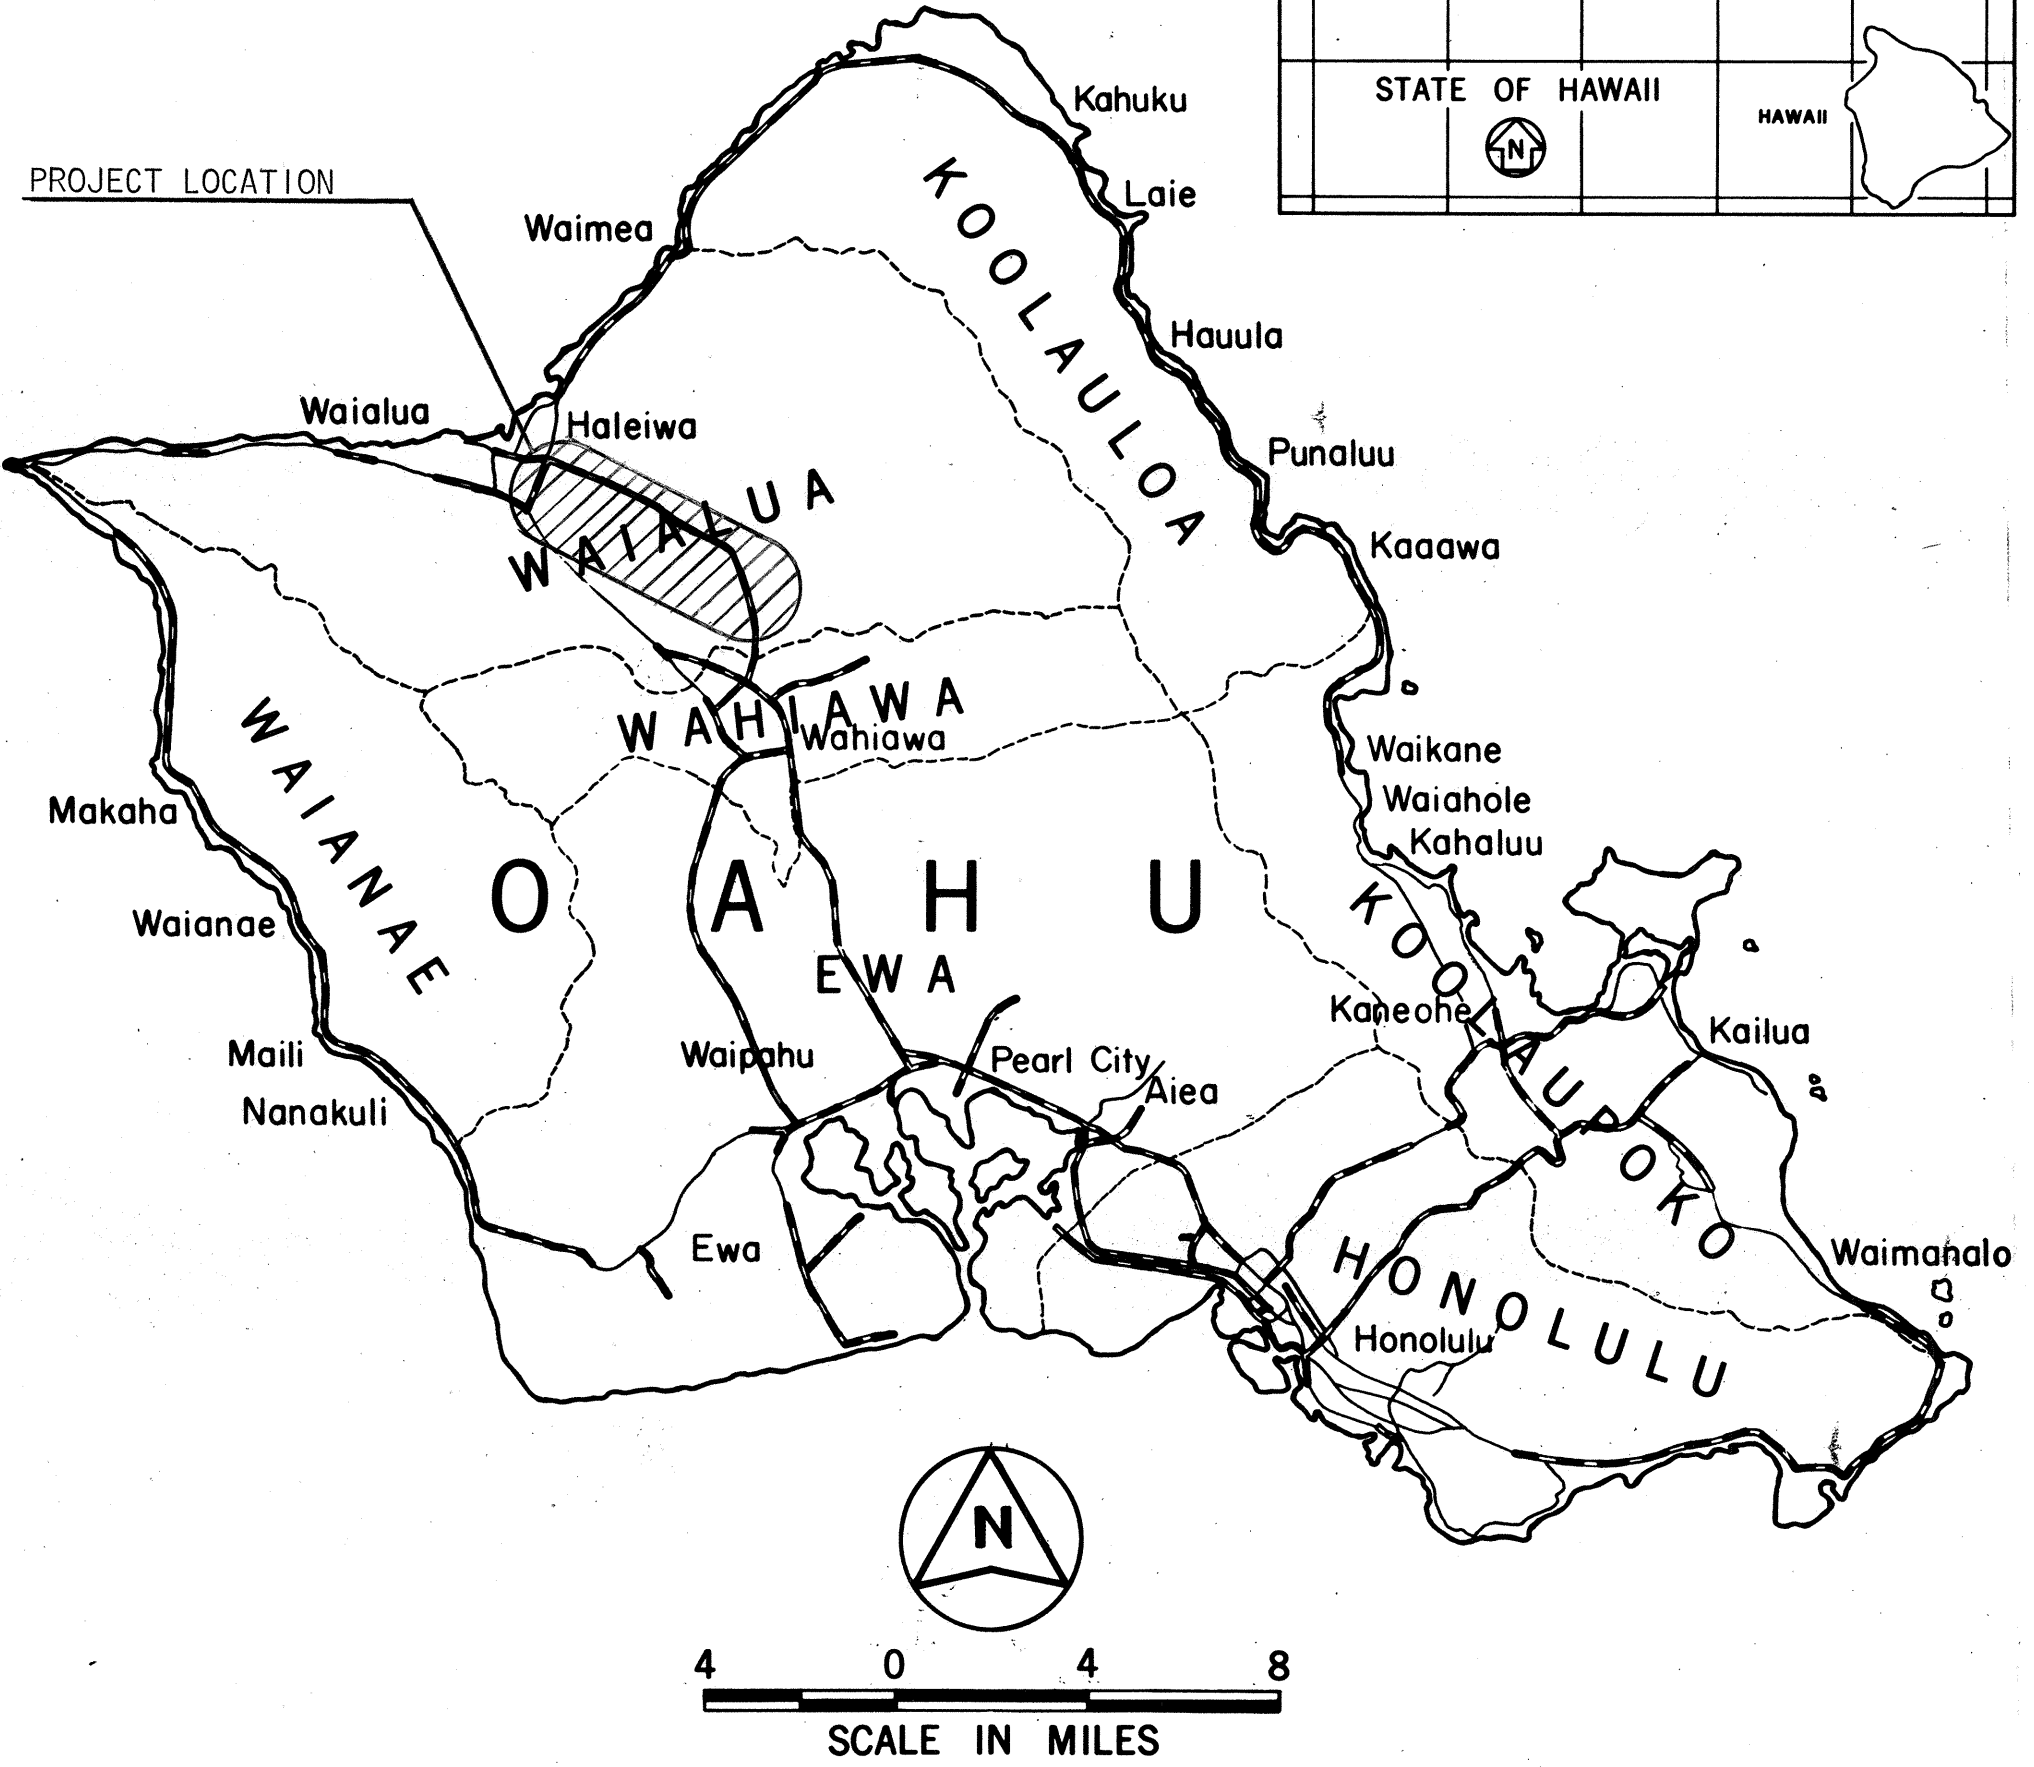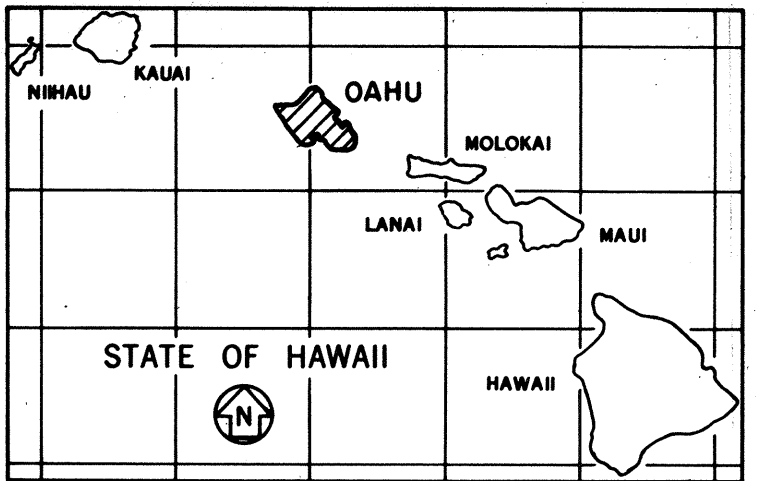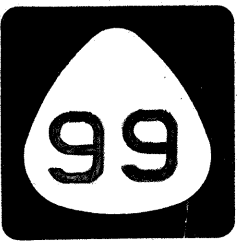

FEDERAL AID PROJECTS PREVIOUSLY CONSTRUCTED
OR UNDER CONSTRUCTION
MILE POST 0.00 TO MILE POST 6.25

CHANGES MADE DURING CONSTRUCTION HAVE BEEN
INCORPORATED ON THESE PLANS EXCEPT CHANGES
IN THE ORIGINAL THEORETICAL QUANTITIES. FOR
ACTUAL QUANTITIES, REFER TO PROJECT LEDGER
AND/OR COMPUTATION BOOK.

RESIDENT ENGINEER DATE

DEPARTMENT OF TRANSPORTATION
STATE OF HAWAII
APPROVED:
DIR. OF TRANSPORTATION DATE

ALBERT CHONG ASSOC., INC. DESIGNED BY
HERBERT TAO P. S. & E. BY
587-2124 PHONE
5-3-96 DATE