



FED. ROAD DIST. NO.	STATE	FED. AID PROJ. NO.	FISCAL YEAR	SHEET NO.	TOTAL SHEETS
HAWAII	HAW.	DE-0200(803)	2000	63	79

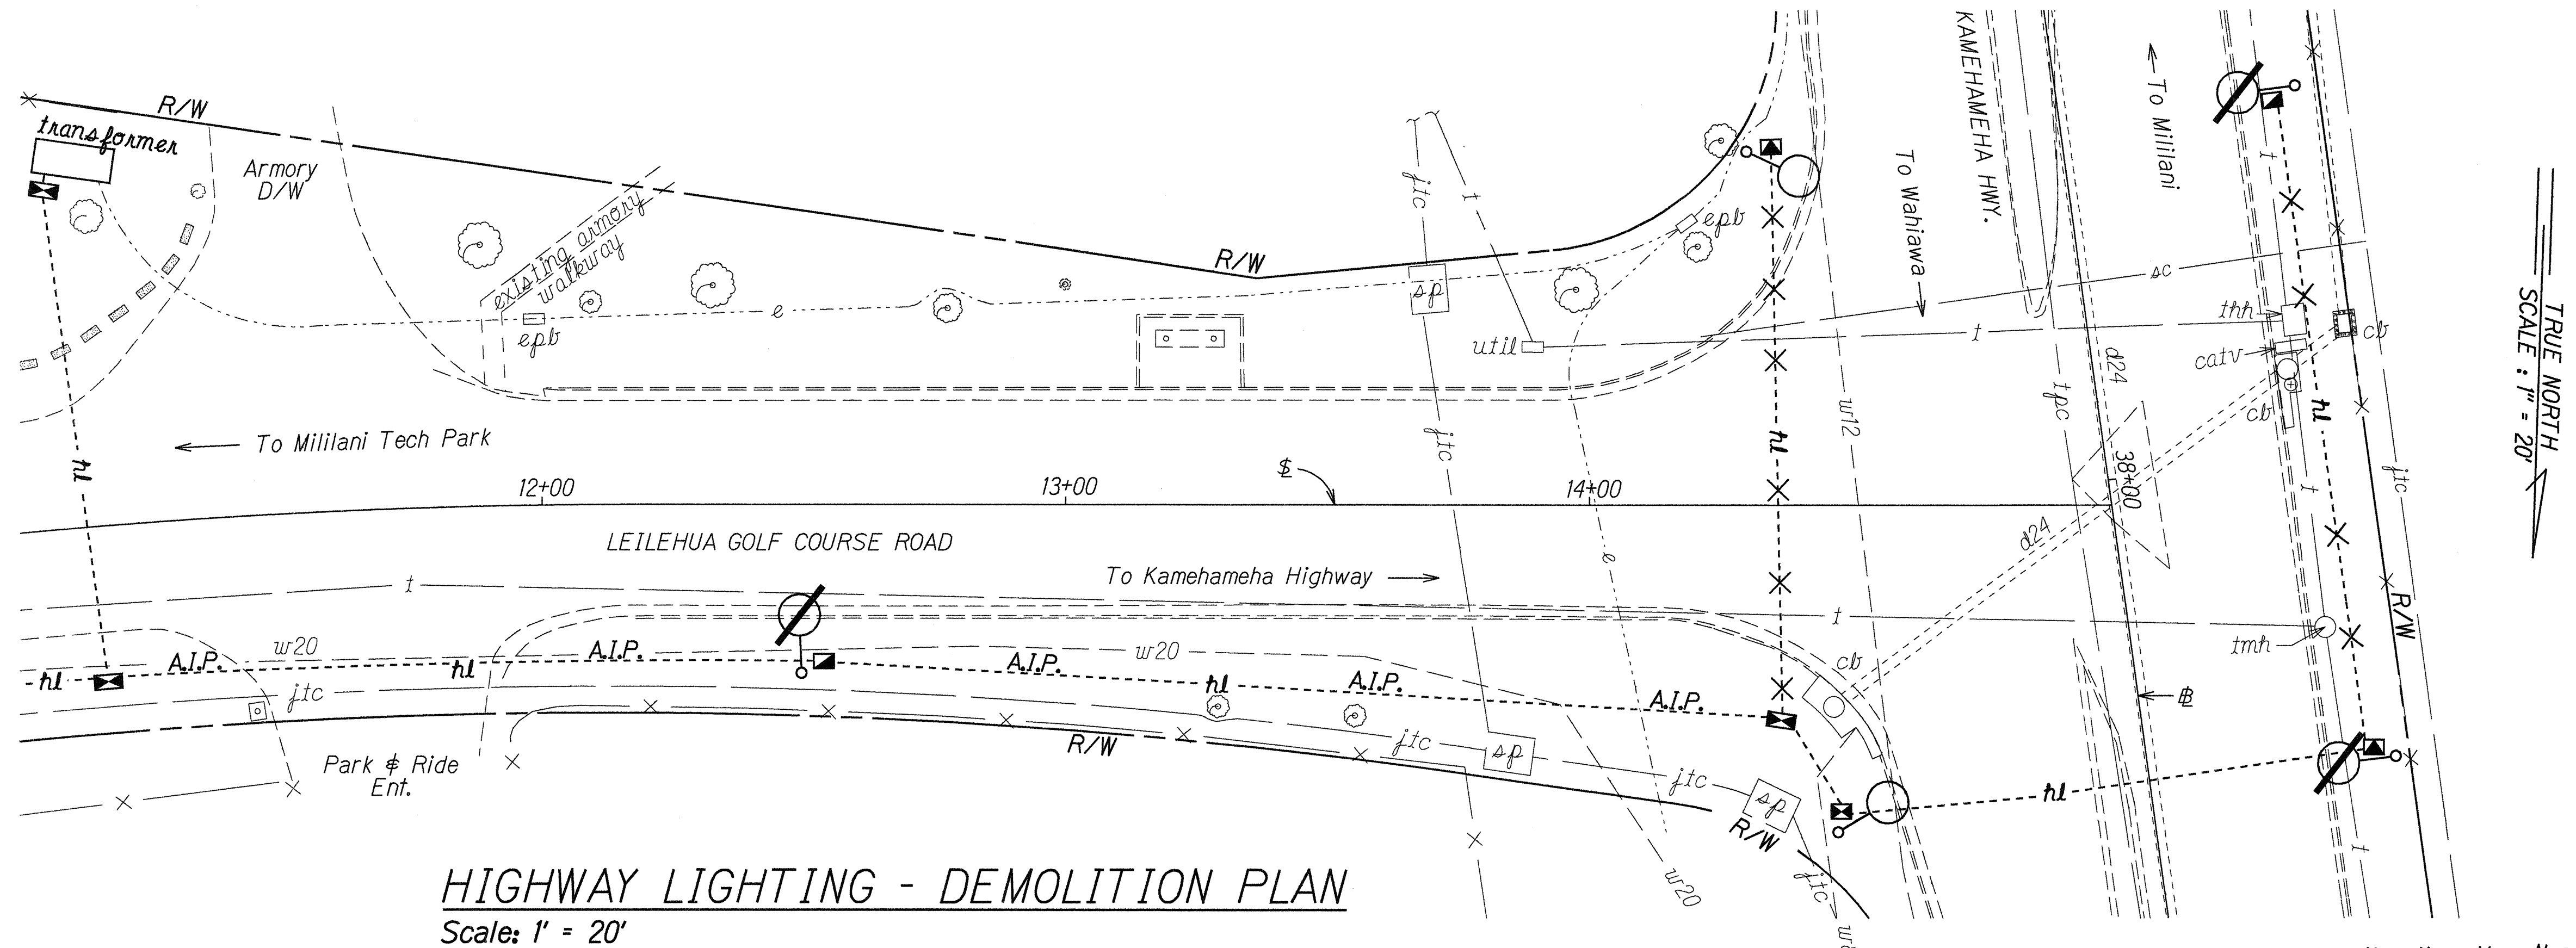

HIGHWAY LIGHTING - DEMOLITION PLAN
Scale: 1" = 20'

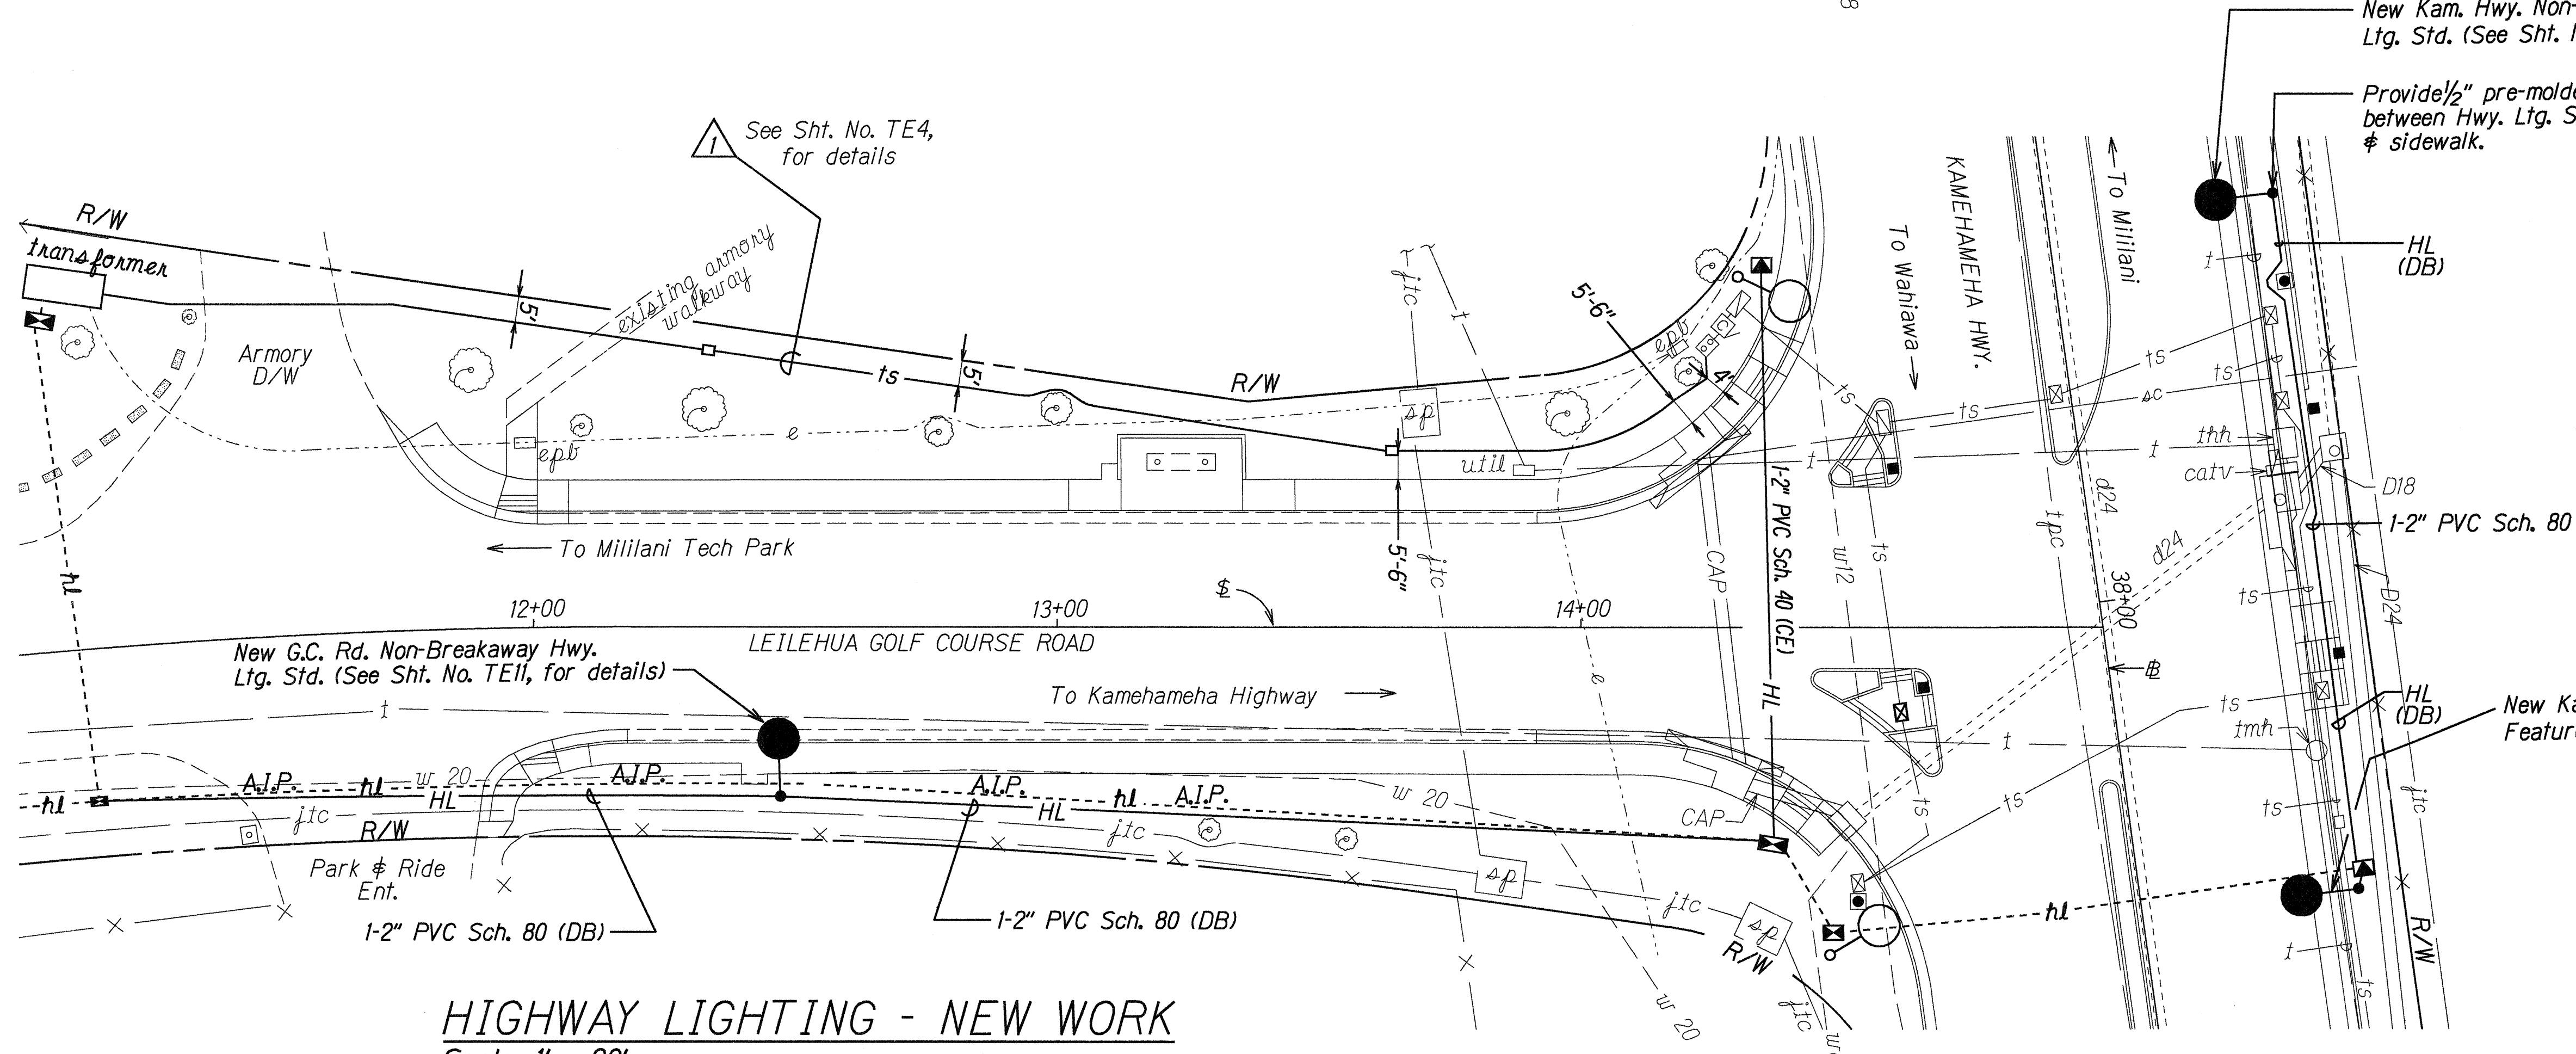

HIGHWAY LIGHTING - NEW WORK
Scale: 1" = 20'

DATE: 4/28/00	SURVEY PLOTTED BY: JMC/LS
TRACED BY: JMC/LS	NOTED BY: JMC/LS
CHECKED BY: JMC/LS	QUANTITIES BY: JMC/LS
ORIGINAL PLAN	NOTE BOOK
	10/1/00
	10/1/00

STATE OF HAWAII
DEPARTMENT OF TRANSPORTATION
HIGHWAYS DIVISION

HIGHWAY LIGHTING PLAN
KAMEHAMEHA HIGHWAY
Intersection Improvements at
Leilehua Golf Course Road
Fed. Aid Project No. DE-0200(803)

Scale: 1" = 20'
Date: Apr. 28, 2000
SHEET No. TE5 OF 13 SHEETS