



INDEX TO DRAWINGS	
SHEET NO.	DESCRIPTION
1	TITLE SHEET
2	STANDARD PLANS SUMMARY
3	GENERAL NOTES AND LEGEND
① 4-6	TYPICAL SECTIONS
7-8	ROADWAY PLAN
9	INTERSECTION DETAIL
10	GRADING PLAN
11	COLD PLANING PLAN
12	DRAINAGE SUMMARY
13	DRAINAGE PLAN
14-16	DRAINAGE PROFILE
17-25	DRAINAGE DETAIL
② 26-40	UTILITY ADJUSTMENTS
41	CURB RAMP NOTES & TYPICALS
42-46	CURB RAMP DETAILS
47	BUS SHELTER DETAILS
③ 48	TRAFFIC CONTROL PLAN NOTES & LEGEND
49-53	TRAFFIC CONTROL PLAN
54	TRAFFIC SUMMARIES
55	PAVEMENT MARKING LEGEND, DETAILS & NOTES
56	PAVEMENT MARKING & SIGNING PLAN
57-58	SIGN DETAILS
59-60	TRAFFIC SIGNAL & HWY. LTG. NOTES AND LEGEND
61-62	TRAFFIC SIGNAL PLAN
63	HIGHWAY LIGHTING PLAN
64-71	TRAFFIC SIGNAL & HIGHWAY LIGHTING DETAILS
72-79	ROADWAY CROSS-SECTIONS

Plan Sht. Nos. ① 4S-1 & 4S-2, ② C.O.35S-1 and ③ 48S-1 are supplemental to this project.
TOTAL SHEET COUNT after "AS-BUILT" posting is 83 Sheets.



May 18, 2000
DATE
692-7685
PHONE
Jan Higaki
P.S. & E. BY
HWY-TS
DESIGNED BY

STATE OF HAWAII
DEPARTMENT OF TRANSPORTATION
HIGHWAYS DIVISION
HONOLULU, HAWAII
"AS-BUILT"
PLANS FOR
KAMEHAMEHA HIGHWAY
INTERSECTION IMPROVEMENTS AT
LEILEHUA GOLF COURSE ROAD
FEDERAL AID PROJECT NO. DE-0200(803)

DISTRICT OF WAHIAWA
ISLAND OF OAHU

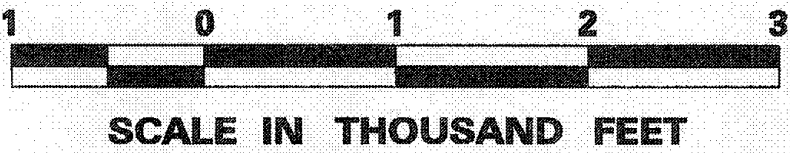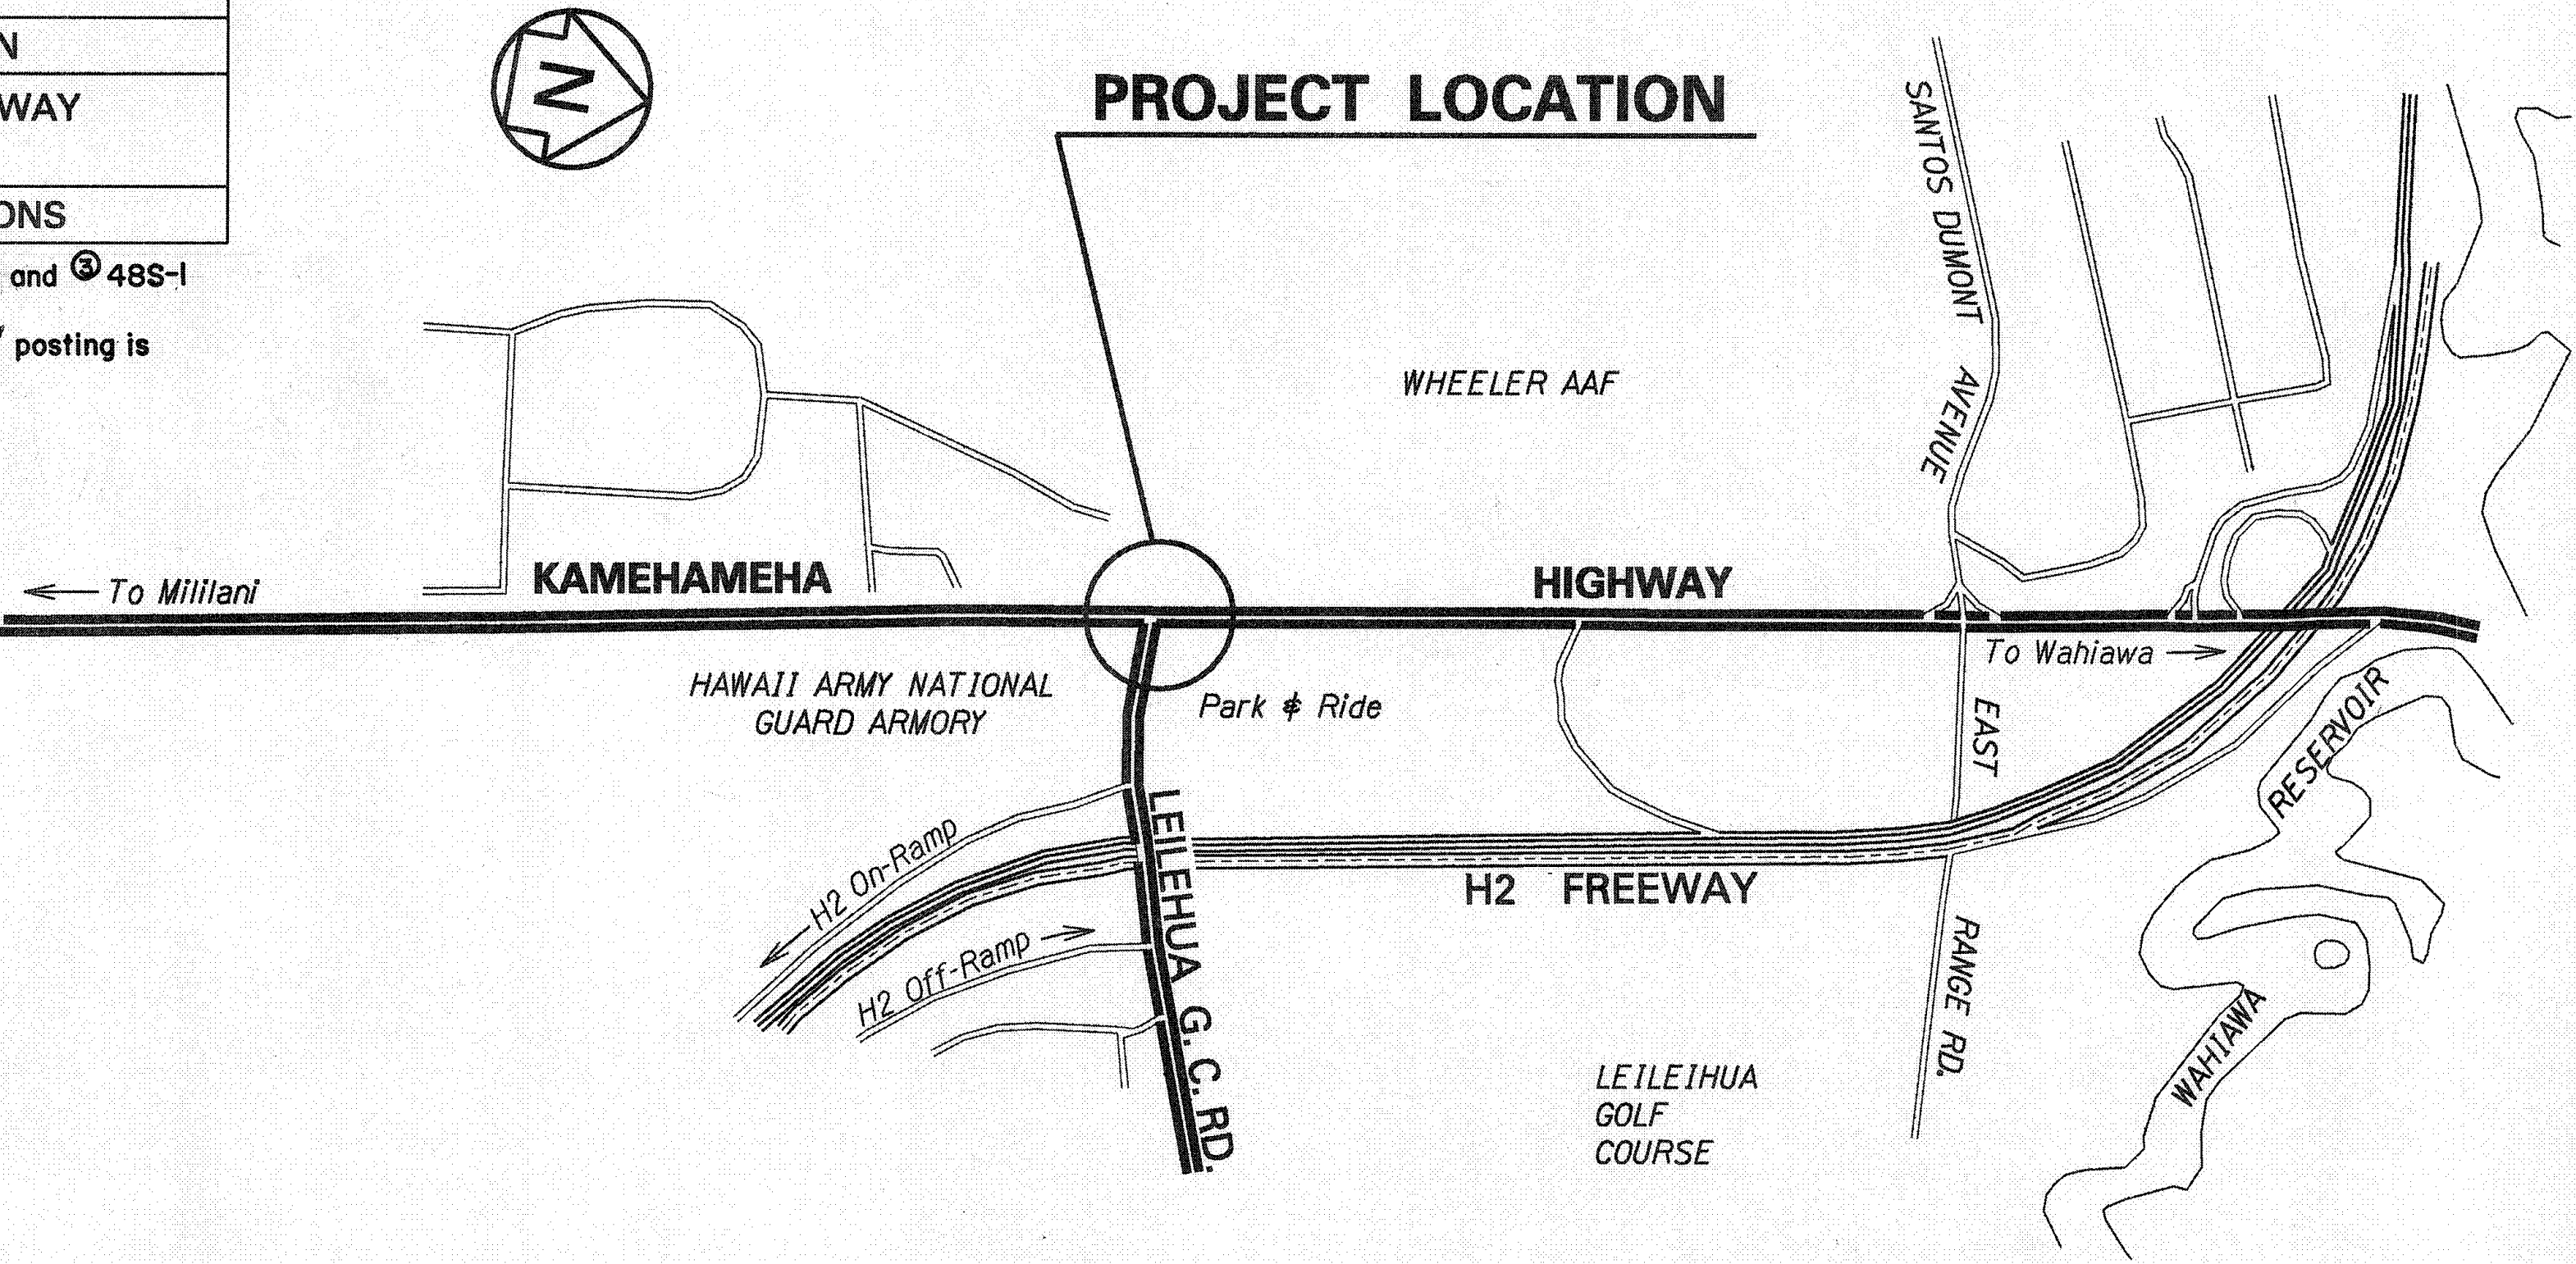

FED. ROAD DIST. NO.	STATE	FED. AID PROJ. NO.	FISCAL YEAR	SHEET NO.	TOTAL SHEETS
HAWAII	HAW.	DE-0200(803)	2000	1	79

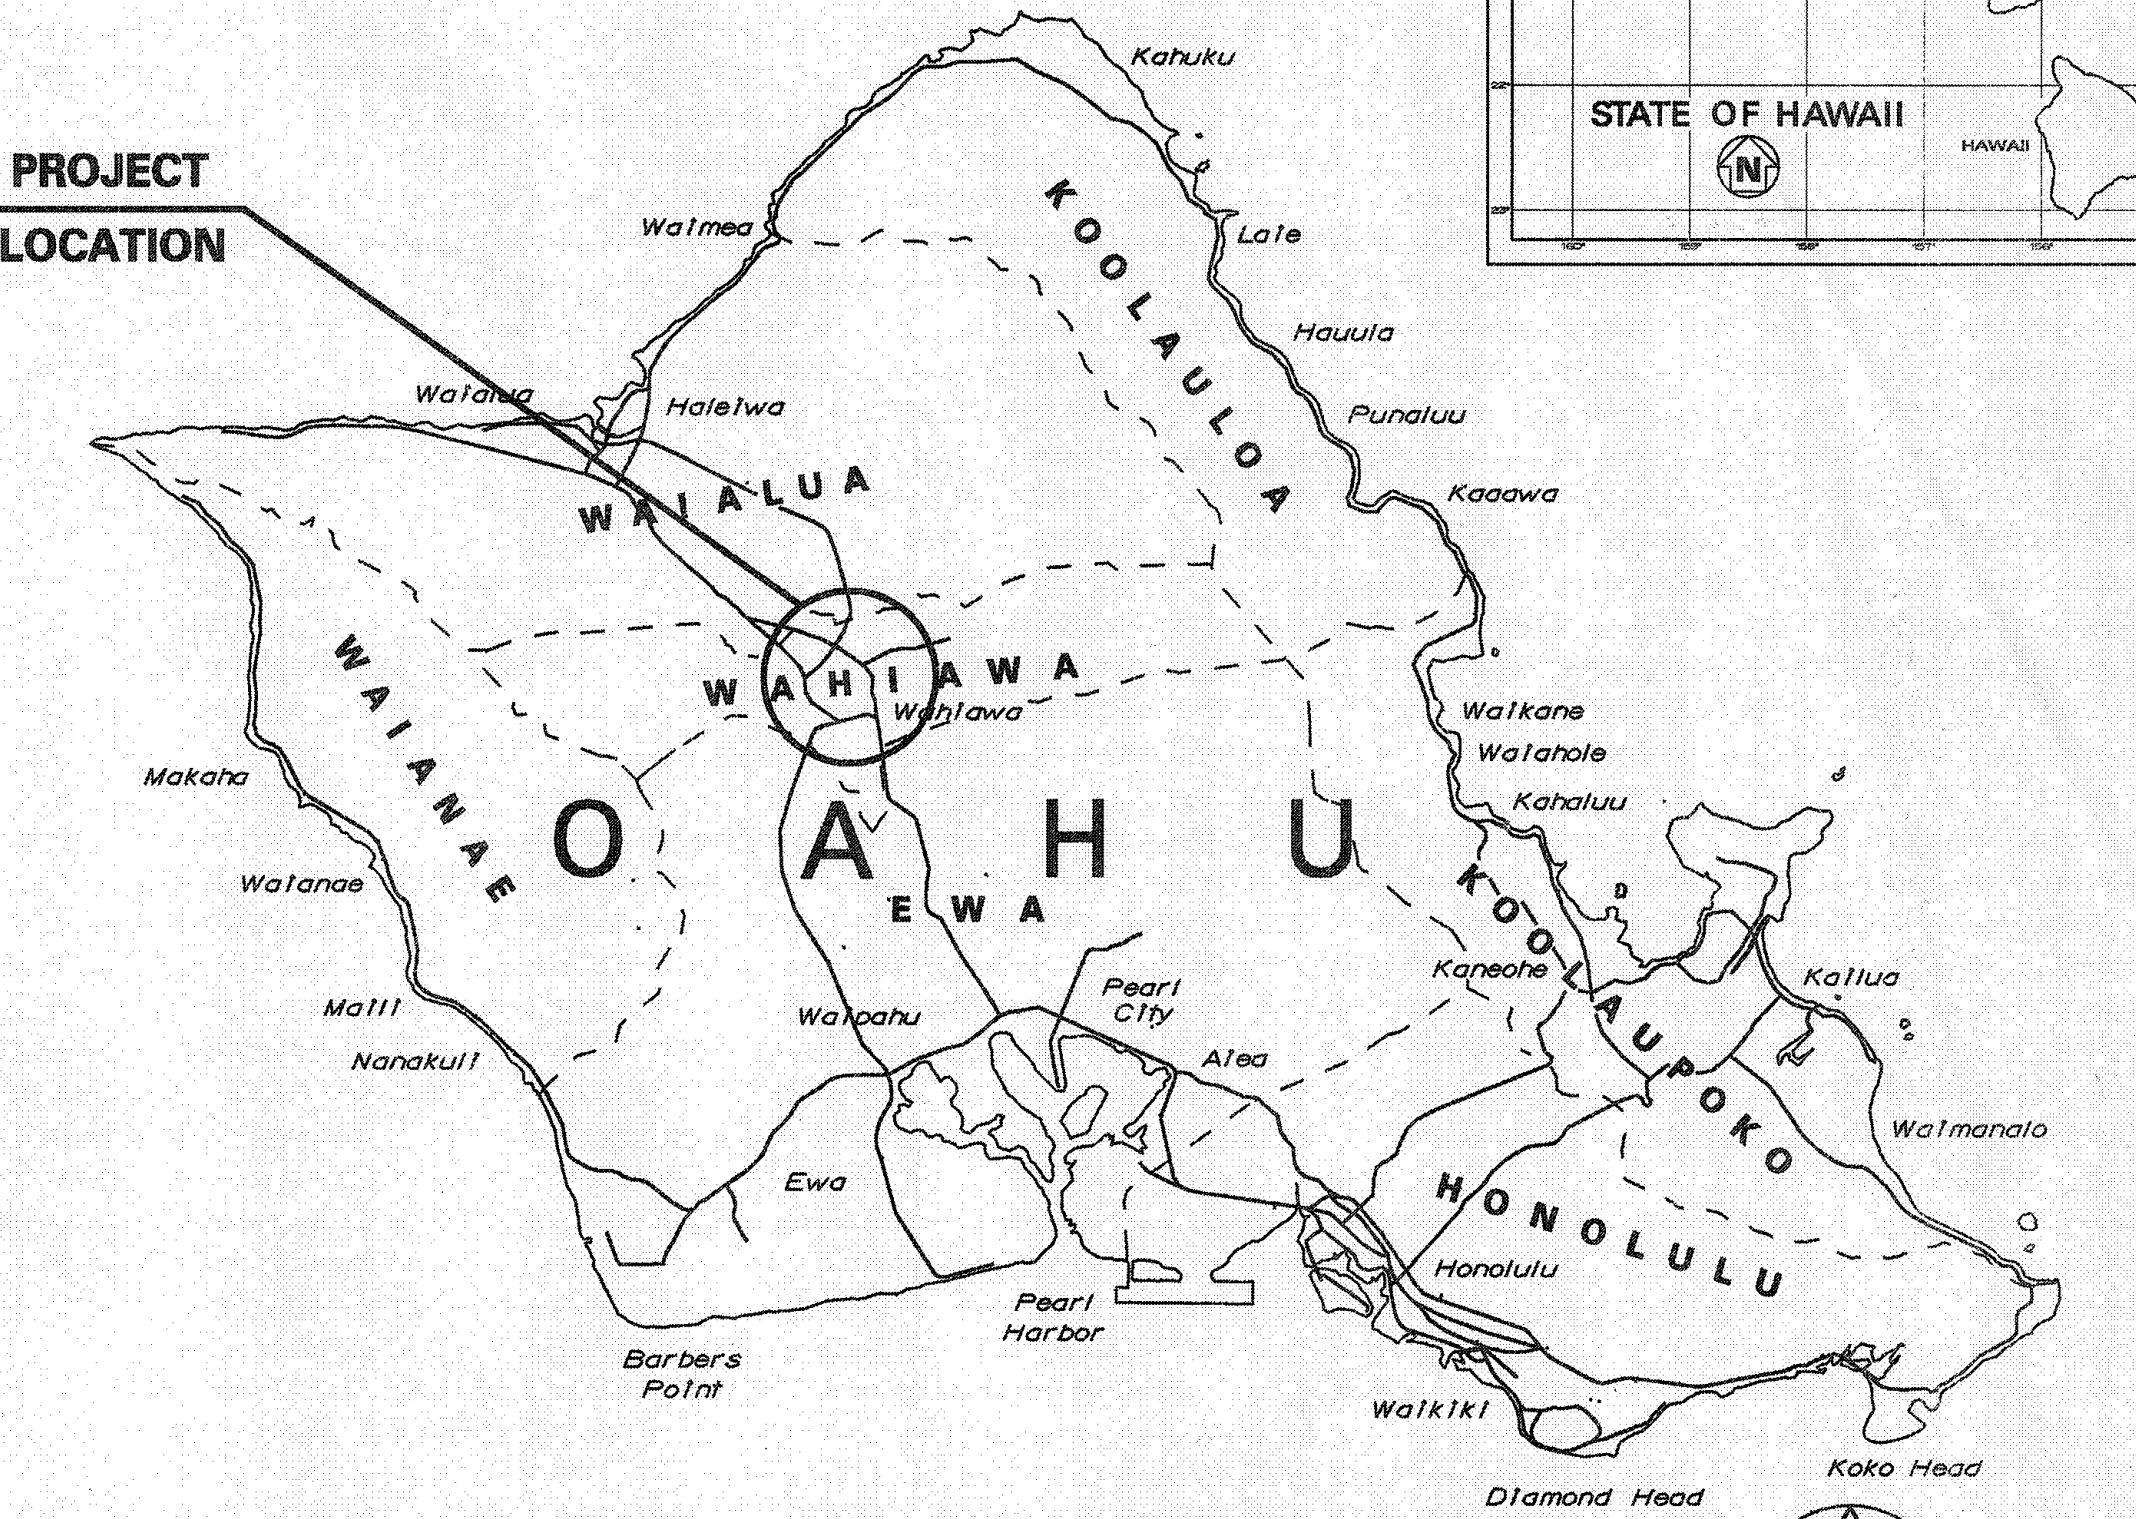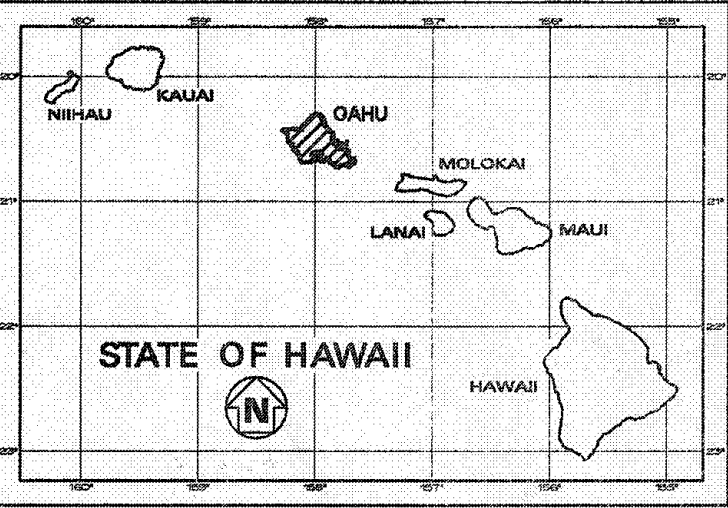

SCALE IN MILES

MILE POST 10.24 TO MILE POST 10.62

CHANGES MADE DURING CONSTRUCTION HAVE BEEN NOTED ON THESE PLANS AND CHECKED BY:

[Signature]
RESIDENT ENGINEER

4/21/03
DATE

DEPARTMENT OF TRANSPORTATION STATE OF HAWAII	
APPROVED:	
<i>[Signature]</i>	5/23/00
DIR. OF TRANSPORTATION	DATE