

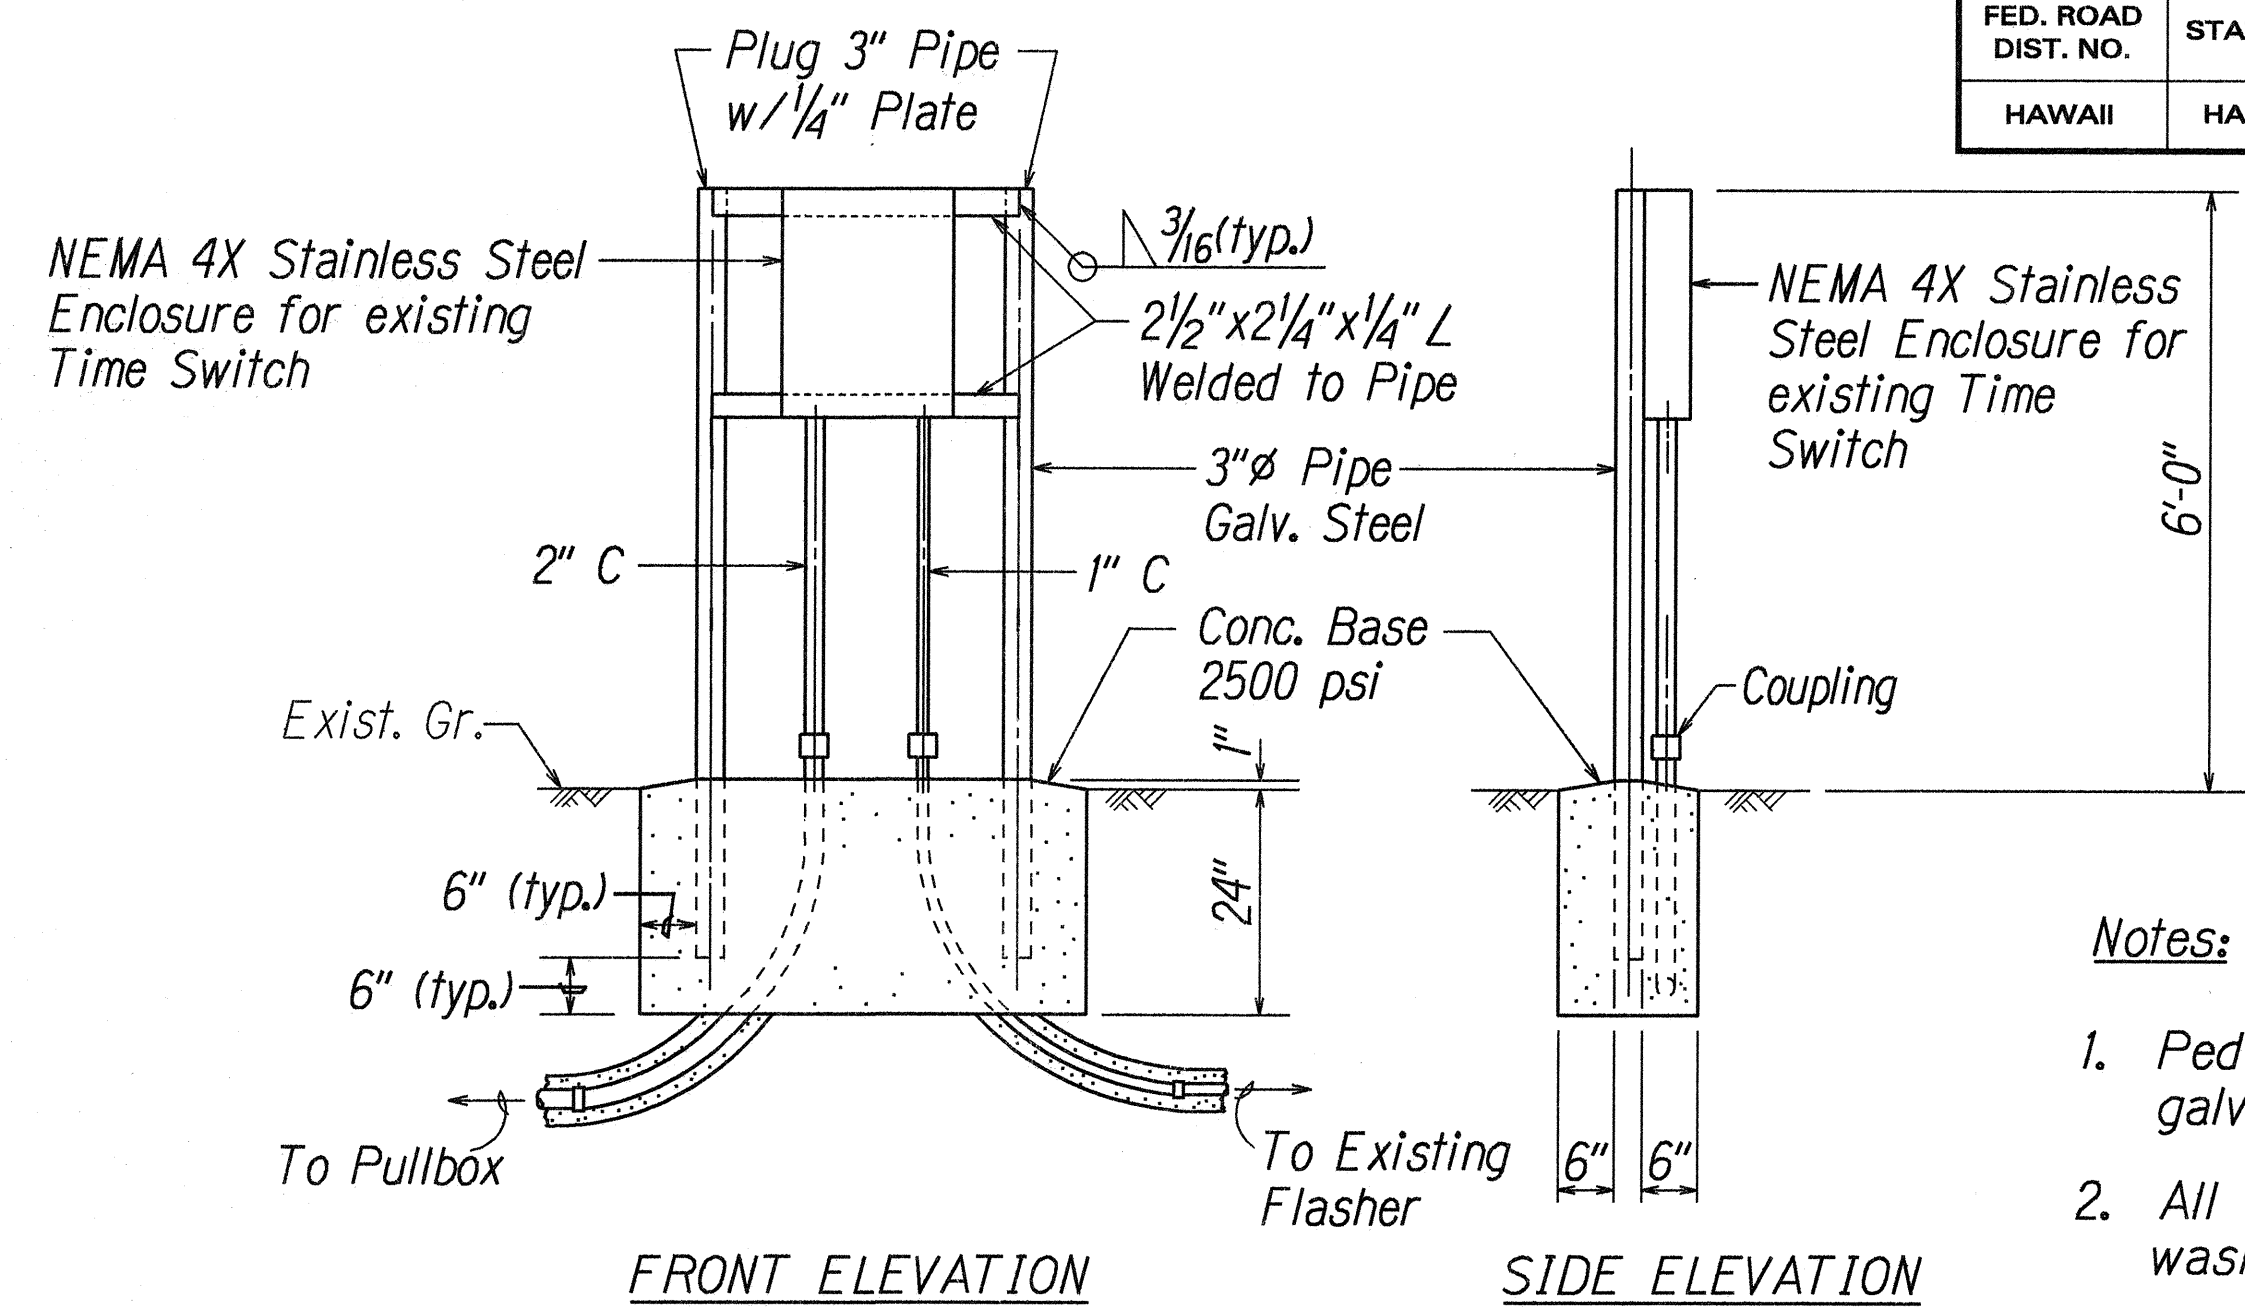



FED. ROAD DIST. NO.	STATE	FED. AID PROJ. NO.	FISCAL YEAR	SHEET NO.	TOTAL SHEETS
HAWAII	HAW.	STP-710(1)	1998	13	16

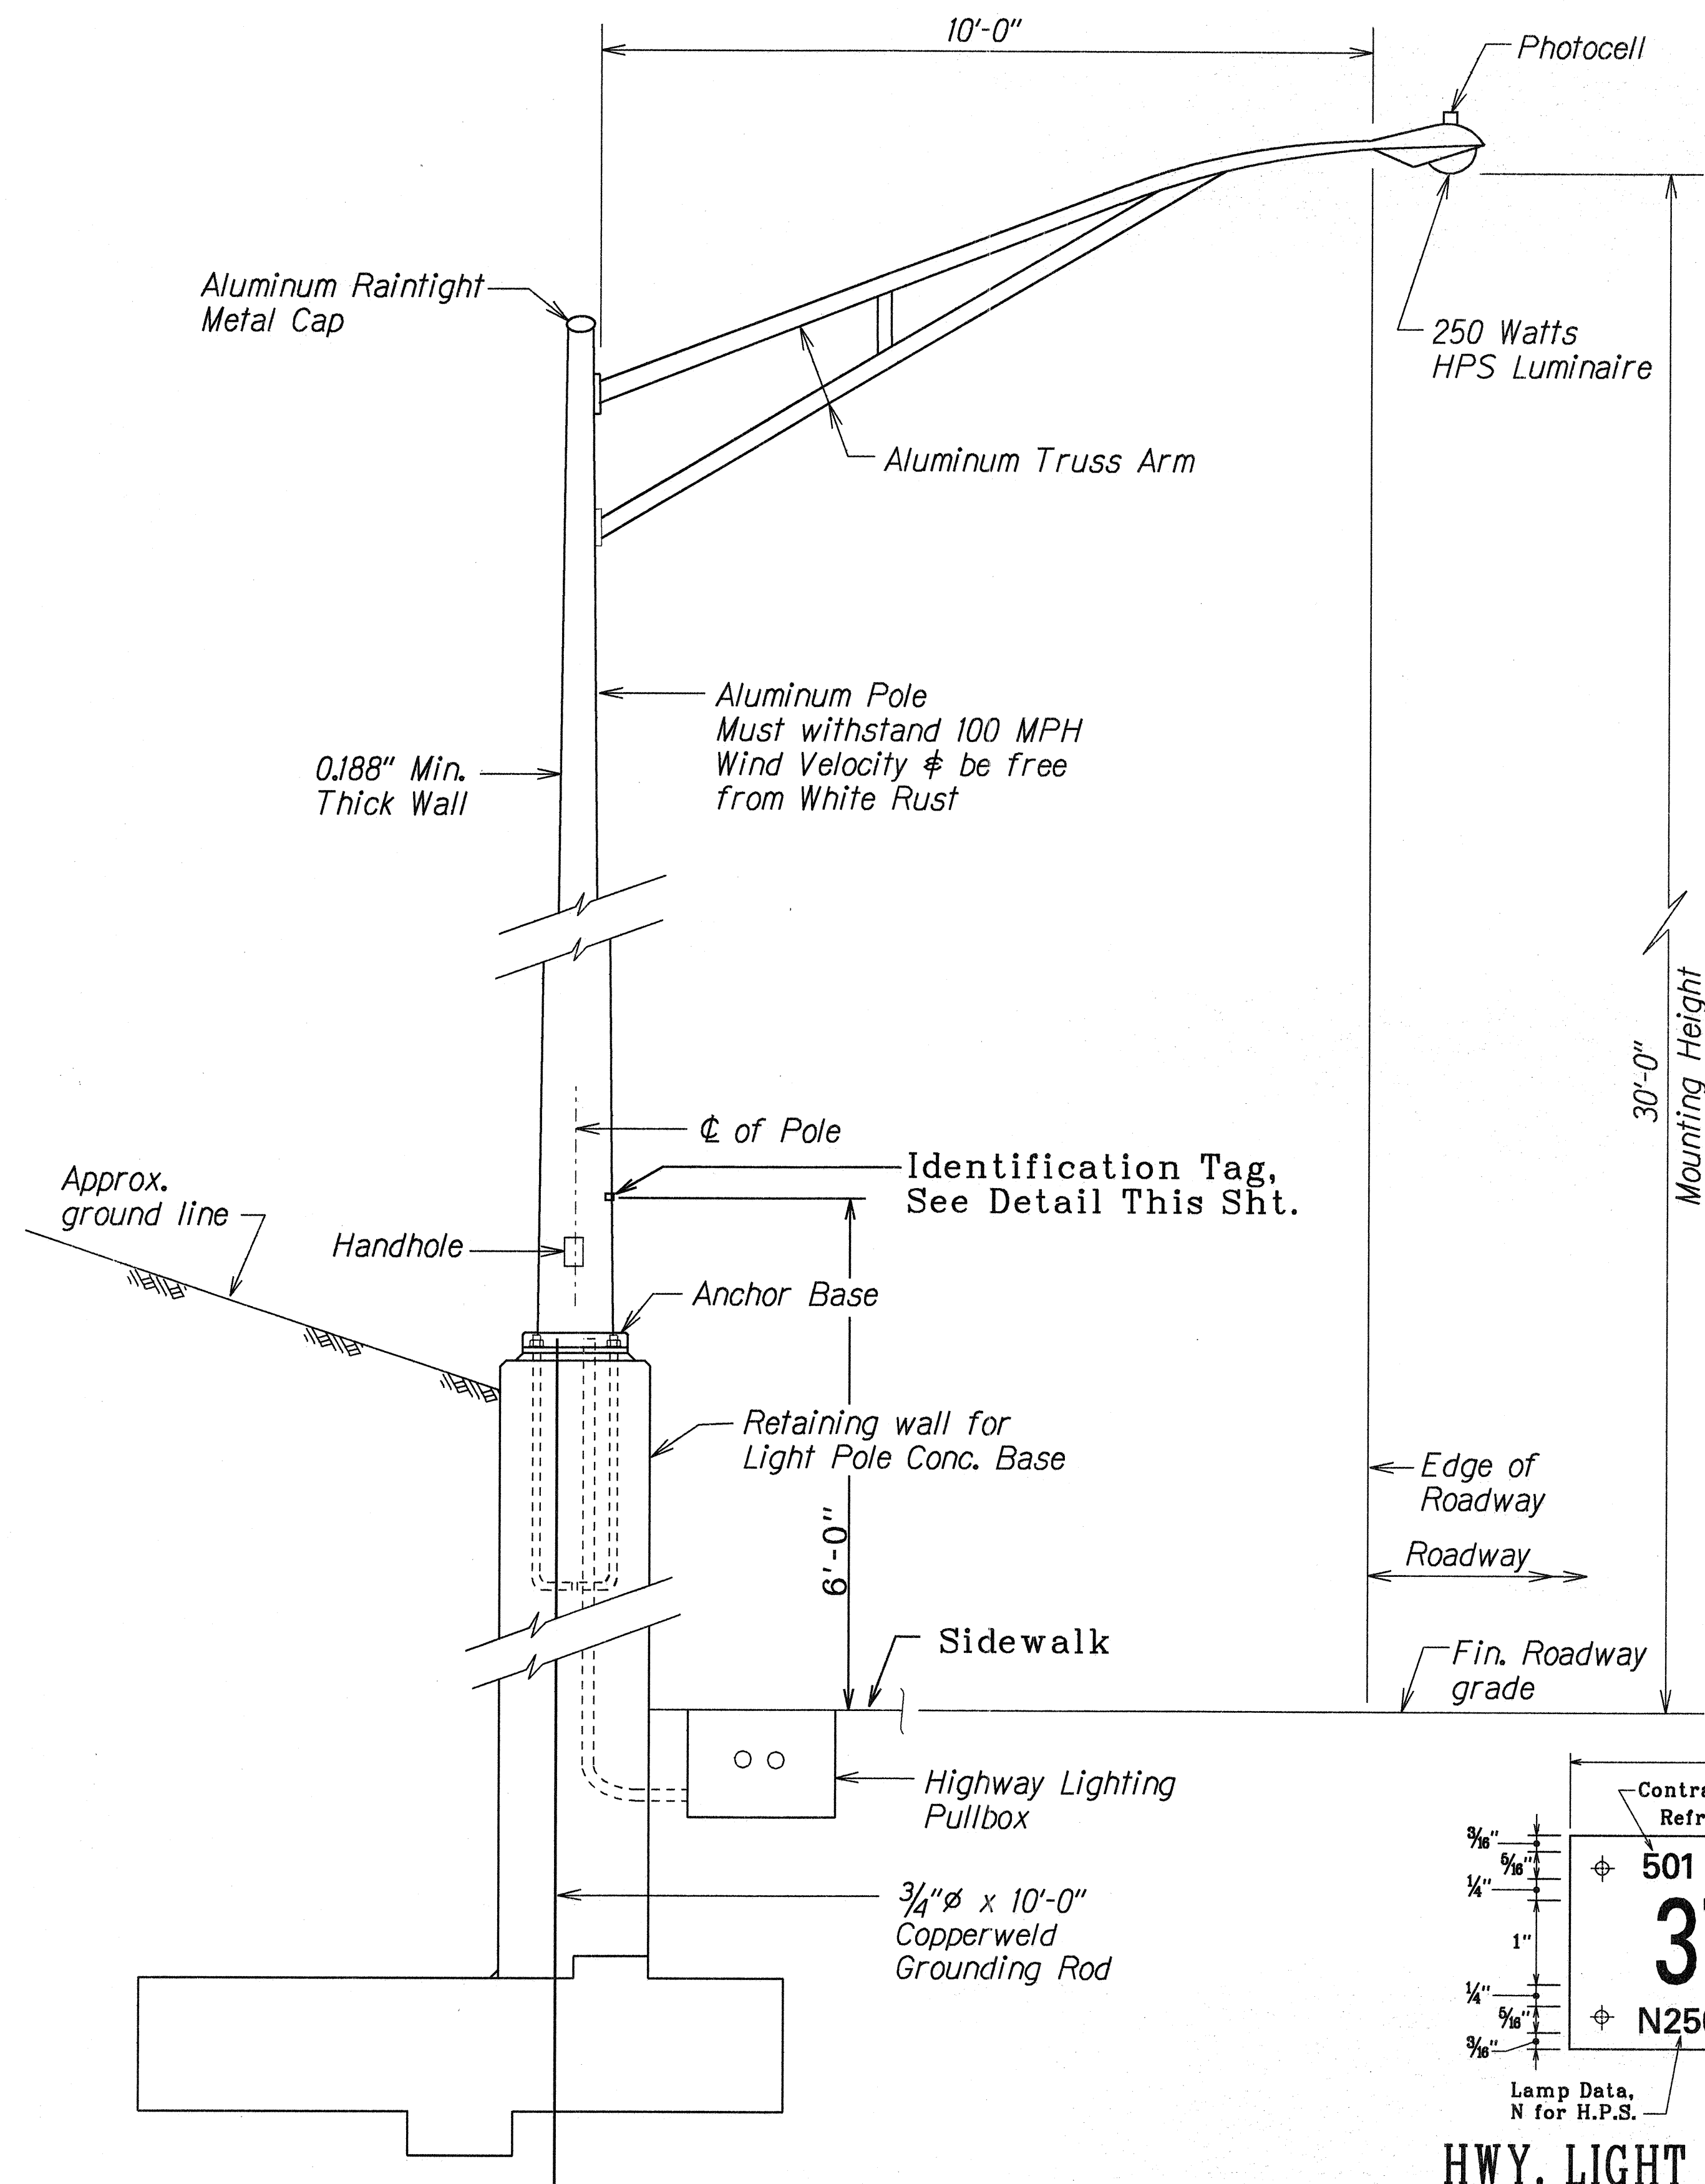

PEDESTAL MOUNTING DETAIL
Not to Scale

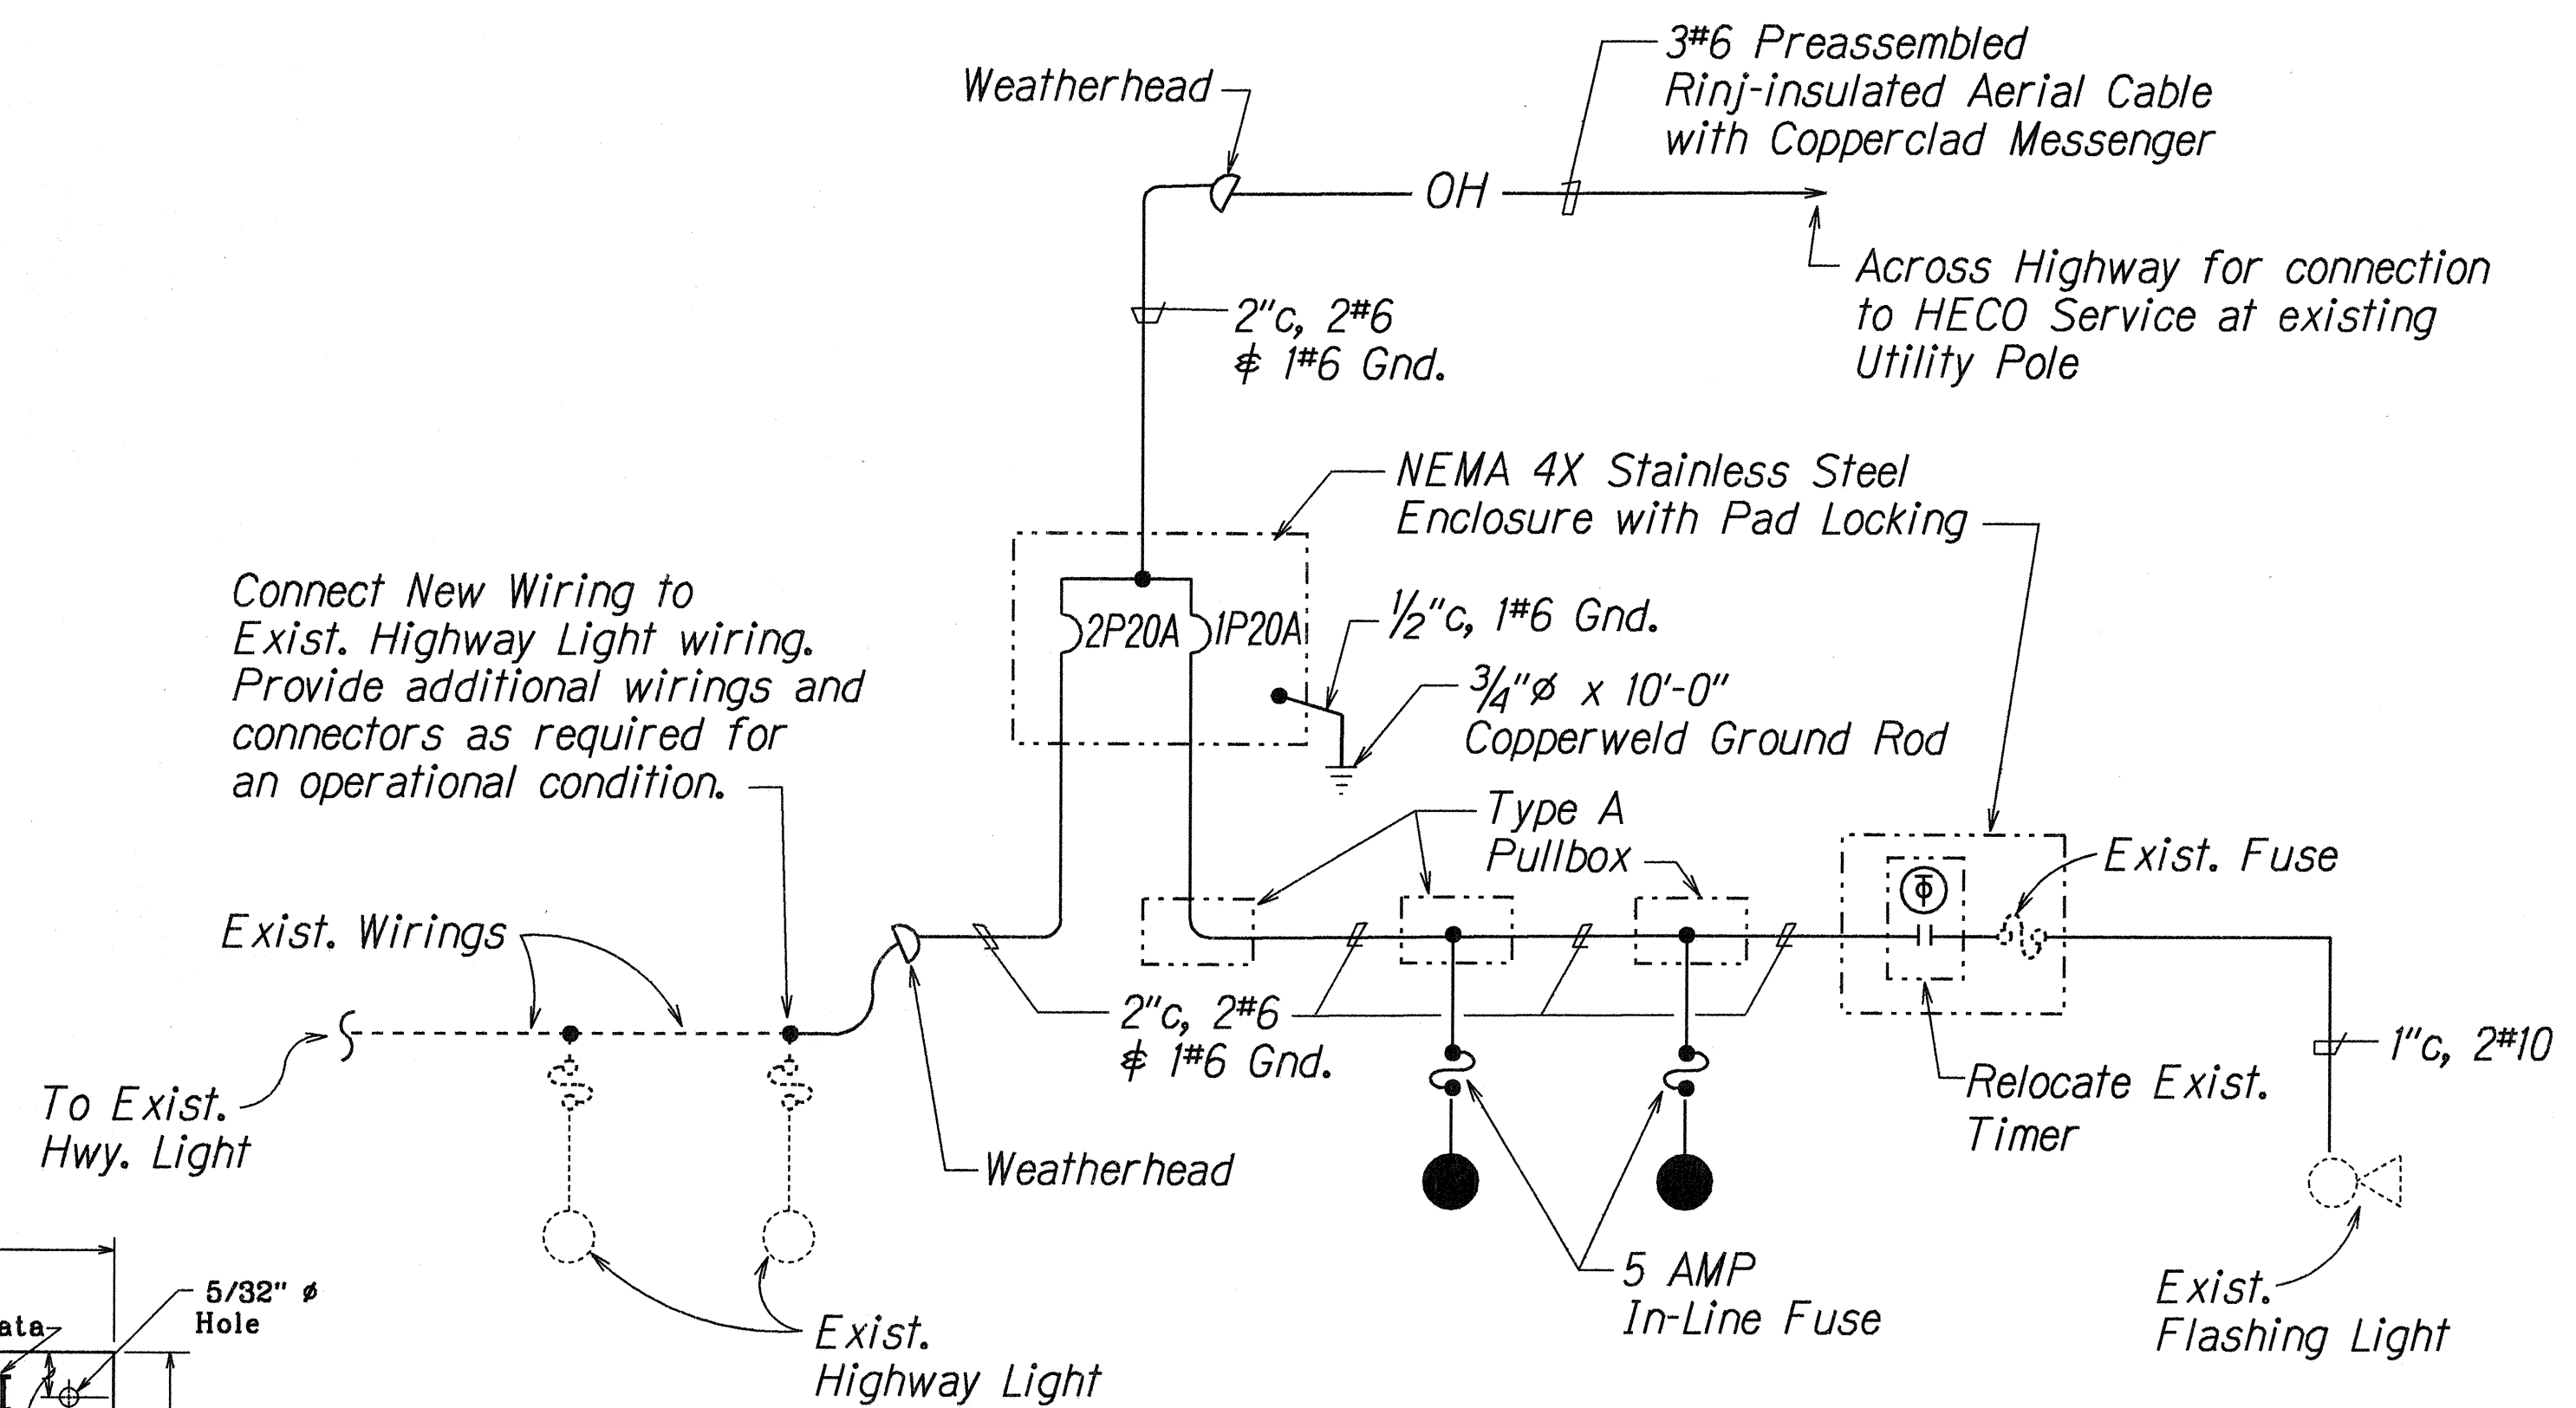

ONE LINE DIAGRAM
Not to Scale

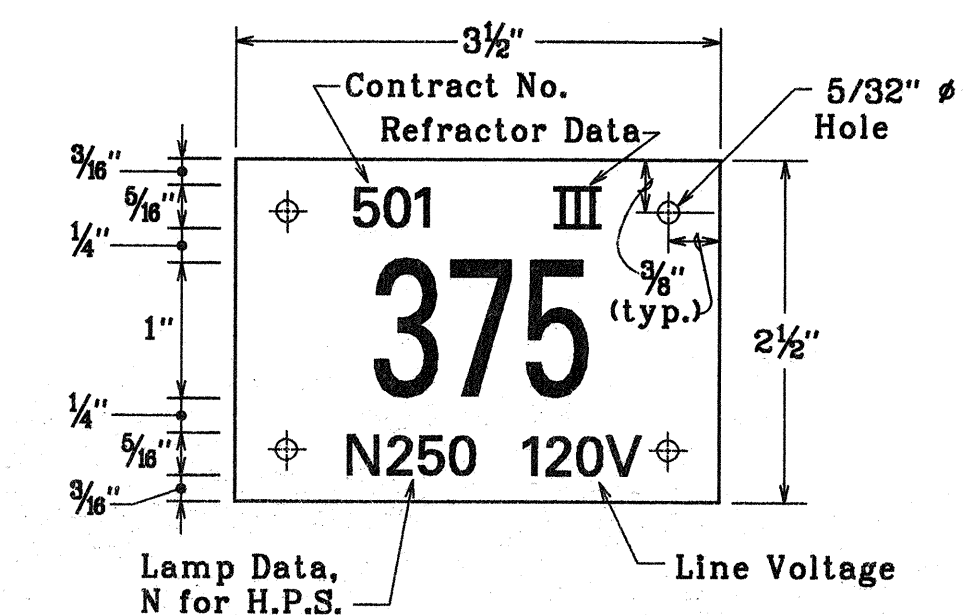

HWY. LIGHT I.D. TAG DETAIL
Not to Scale

LEGEND FOR AS-BUILT POSTINGS	
	Squiggly line for as-built deletion
	Double line for as-built deletion
Roadway	Text for as-built posting

STATE OF HAWAII
DEPARTMENT OF TRANSPORTATION
HIGHWAYS DIVISION

MISCELLANEOUS ELECTRICAL DETAILS

FARRINGTON HWY. RETAINING WALL
Vicinity of Awanui St. to
Waipio Pt. Access Rd.
F.A. Proj. No. STP-710(1)

Not to Scale Date: April 1998

SHEET No. T2 OF 3 SHEETS

ORIGINAL PLAN	DATE
SURVEY PLOTTED BY	3/22/98
DRAWN BY	G. A. Kelly / Victor C.
DESIGNED BY	G. A. Kelly / Victor C.
CHECKED BY	N. J. J. J.
NOTES	
1. All fastening bolts, nuts & washer shall be stainless steel.	
2. Pedestal shall be hot-dipped galvanized after fabrication.	

TYPICAL LIGHT STANDARD INSTALLATION ON RETAINING WALL
Not to Scale

