


INDEX TO DRAWINGS	
SHEET NO.	DESCRIPTION
1	TITLE SHEET
2	STANDARD PLANS SUMMARY
3	GENERAL NOTES AND LEGEND
4 - 5	UTILITY NOTES
6	TYPICAL SECTIONS
7 - 13	CURB RAMP DETAILS
14	ROADWAY PLAN
15	INTERSECTION DETAIL
16	DRAINAGE PLAN
17	DRAINAGE PROFILE
18	DRAINAGE DETAILS
19	PAVEMENT MARKING LEGEND, DETAILS AND NOTES
20	PAVEMENT MARKING & SIGNING PLAN
21	TRAFFIC SIGNAL LEGEND AND NOTES
22	TRAFFIC SIGNAL PLAN
23	PEDESTRIAN PUSH BUTTON DETAILS
24	PULL BOX AND COVER DETAILS
25	TRAFFIC SIGNAL DETAILS
26	LOOP DETECTOR DETAILS
27	SYMBOLS AND ONE-LINE DIAGRAM
28	ELECTRICAL DEMOLITION PLAN
29	NEW ELECTRICAL PLAN
30	ELECTRICAL DETAILS
31 - 32	CROSS SECTIONS

HWY-DD
DESIGNED BY
K. TATSUGUCHI
P. S. & E. BY
692-7578
PHONE
APRIL, 2000
DATE


STATE OF HAWAII
DEPARTMENT OF TRANSPORTATION
HIGHWAYS DIVISION
HONOLULU, HAWAII
"AS-BUILT"
PLANS FOR
FARRINGTON HIGHWAY
INTERSECTION IMPROVEMENTS AT LEOKU STREET
PROJECT NO. 7101A-02-99

DISTRICT OF EWA
ISLAND OF OAHU


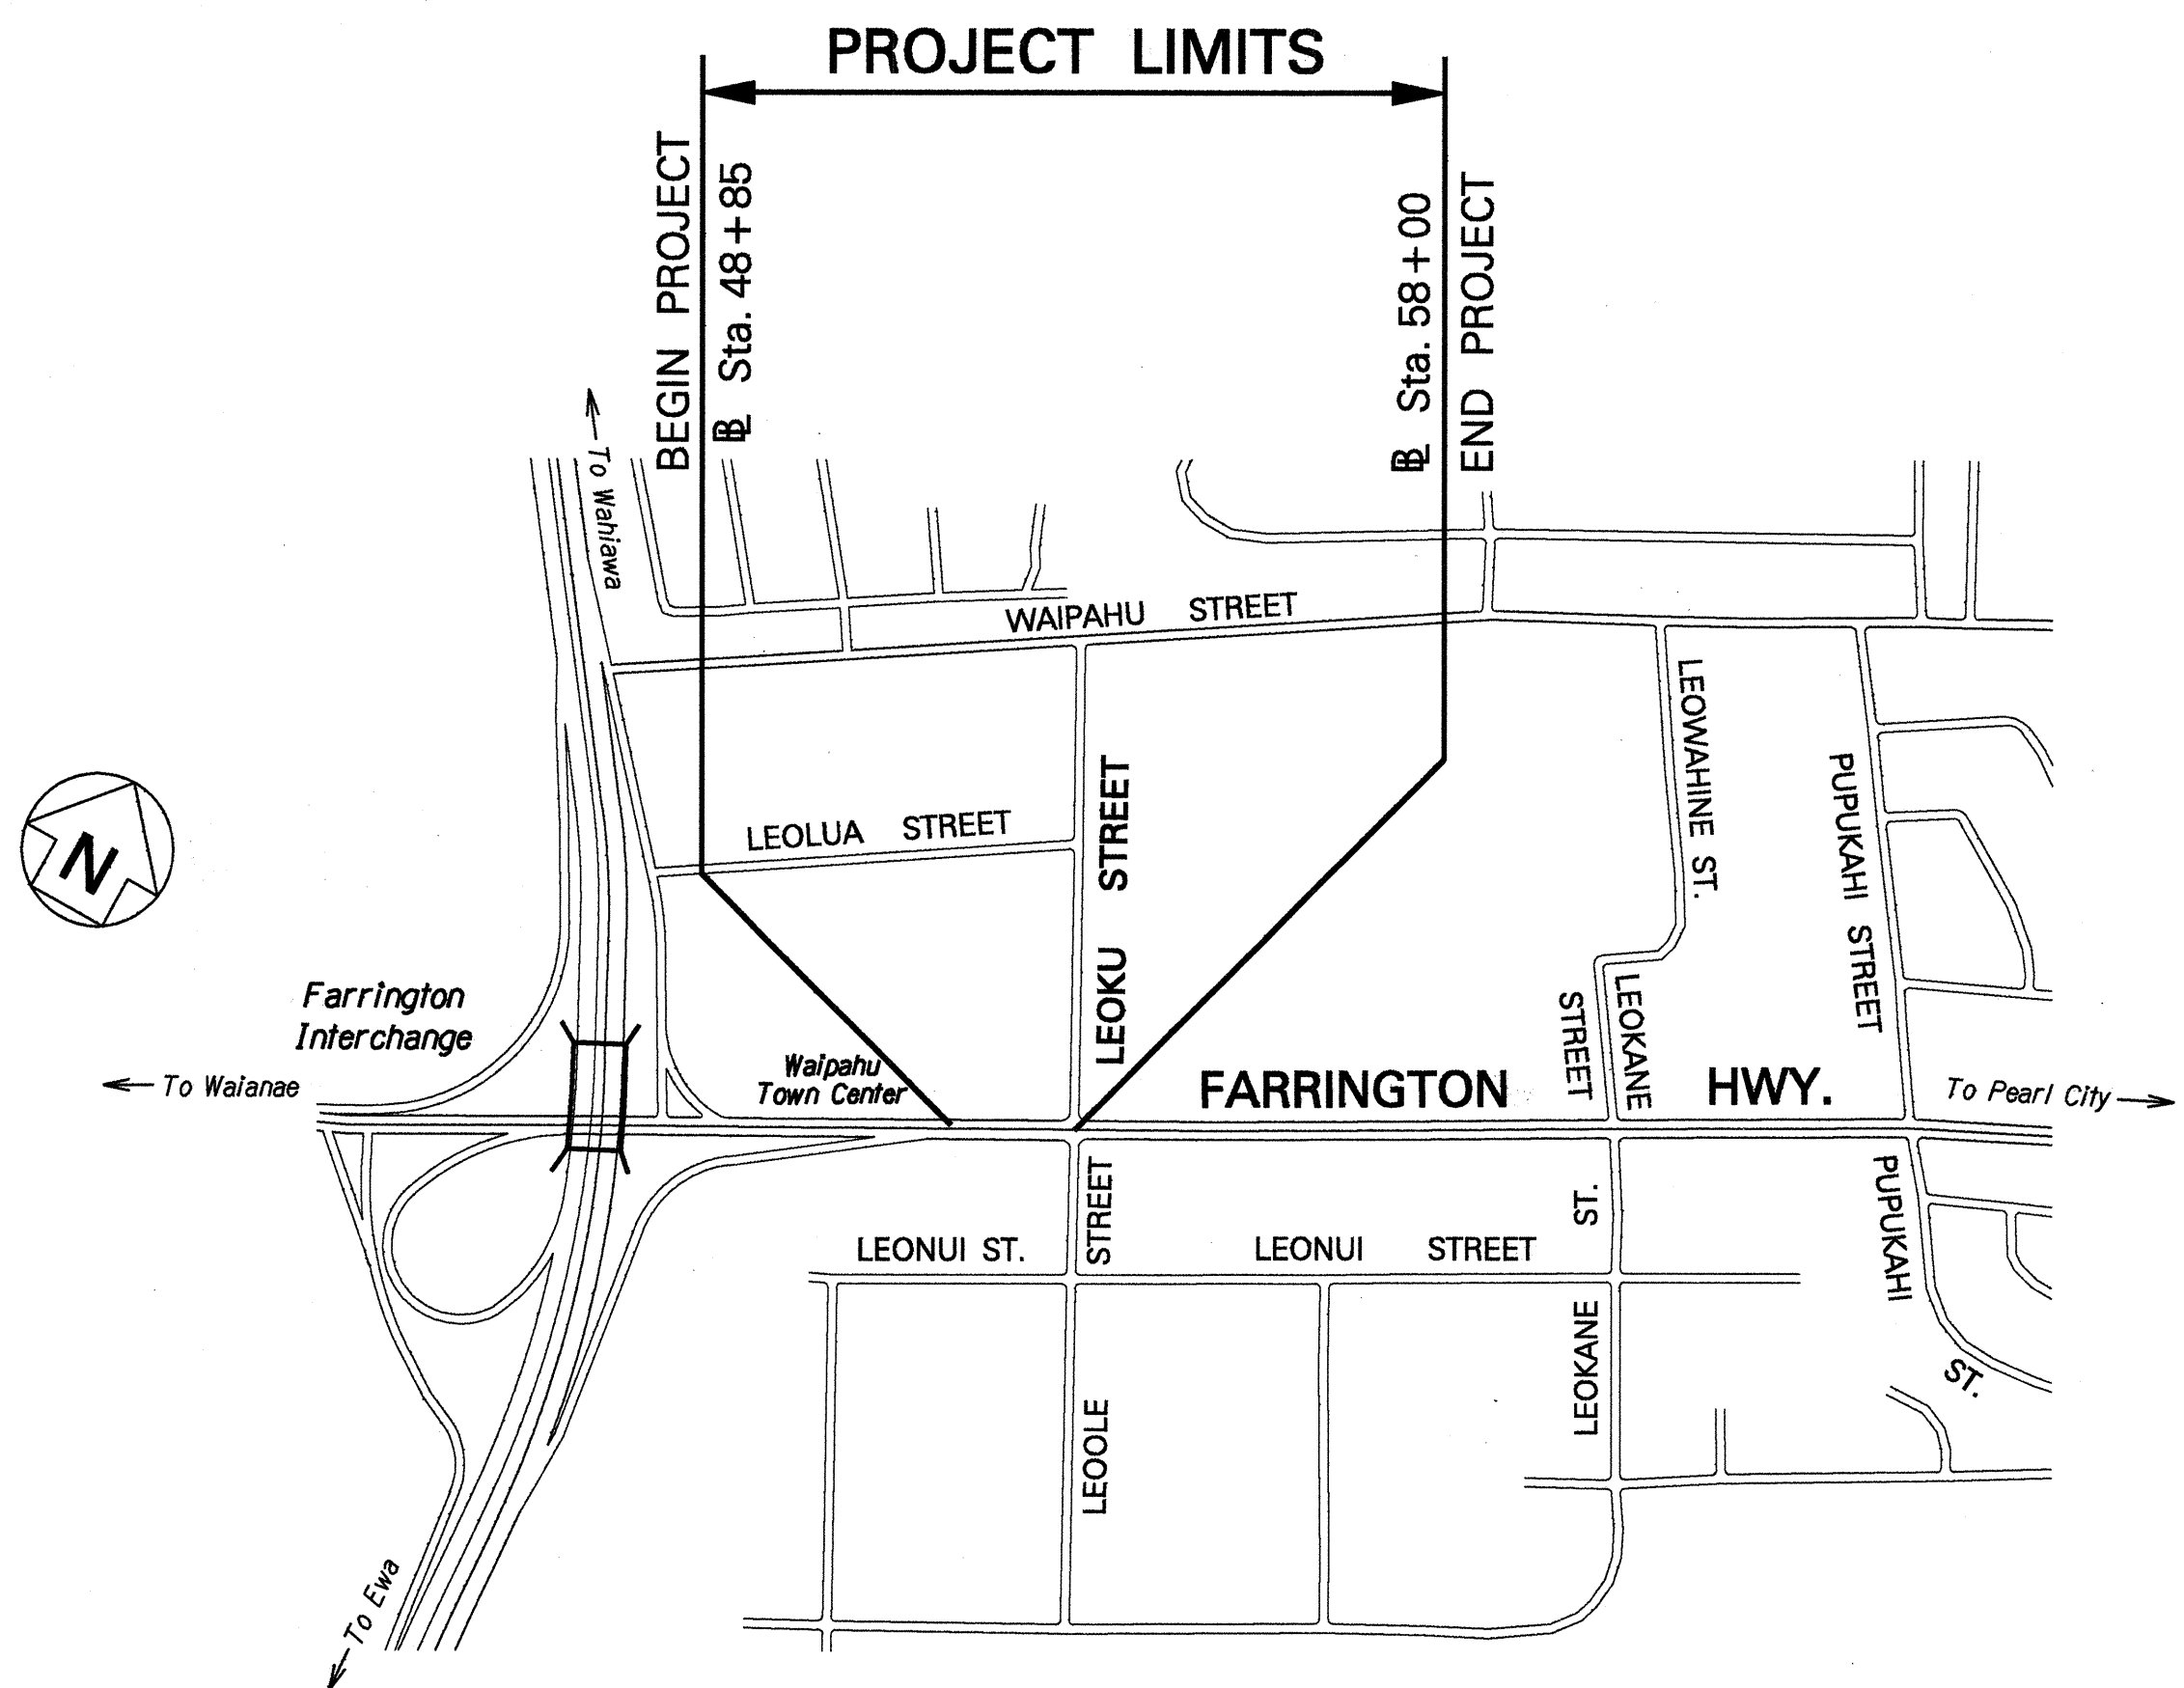


LAYOUT PLAN


NET LENGTH OF PROJECT.....0.16 MILES

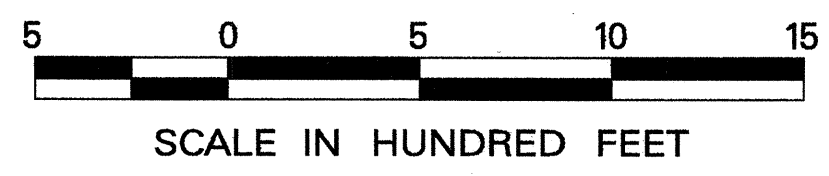

FED. ROAD DIST. NO.	STATE	PROJ. NO.	FISCAL YEAR	SHEET NO.	TOTAL SHEETS
HAWAII	HAW.	7101A-02-99	2000	1	32

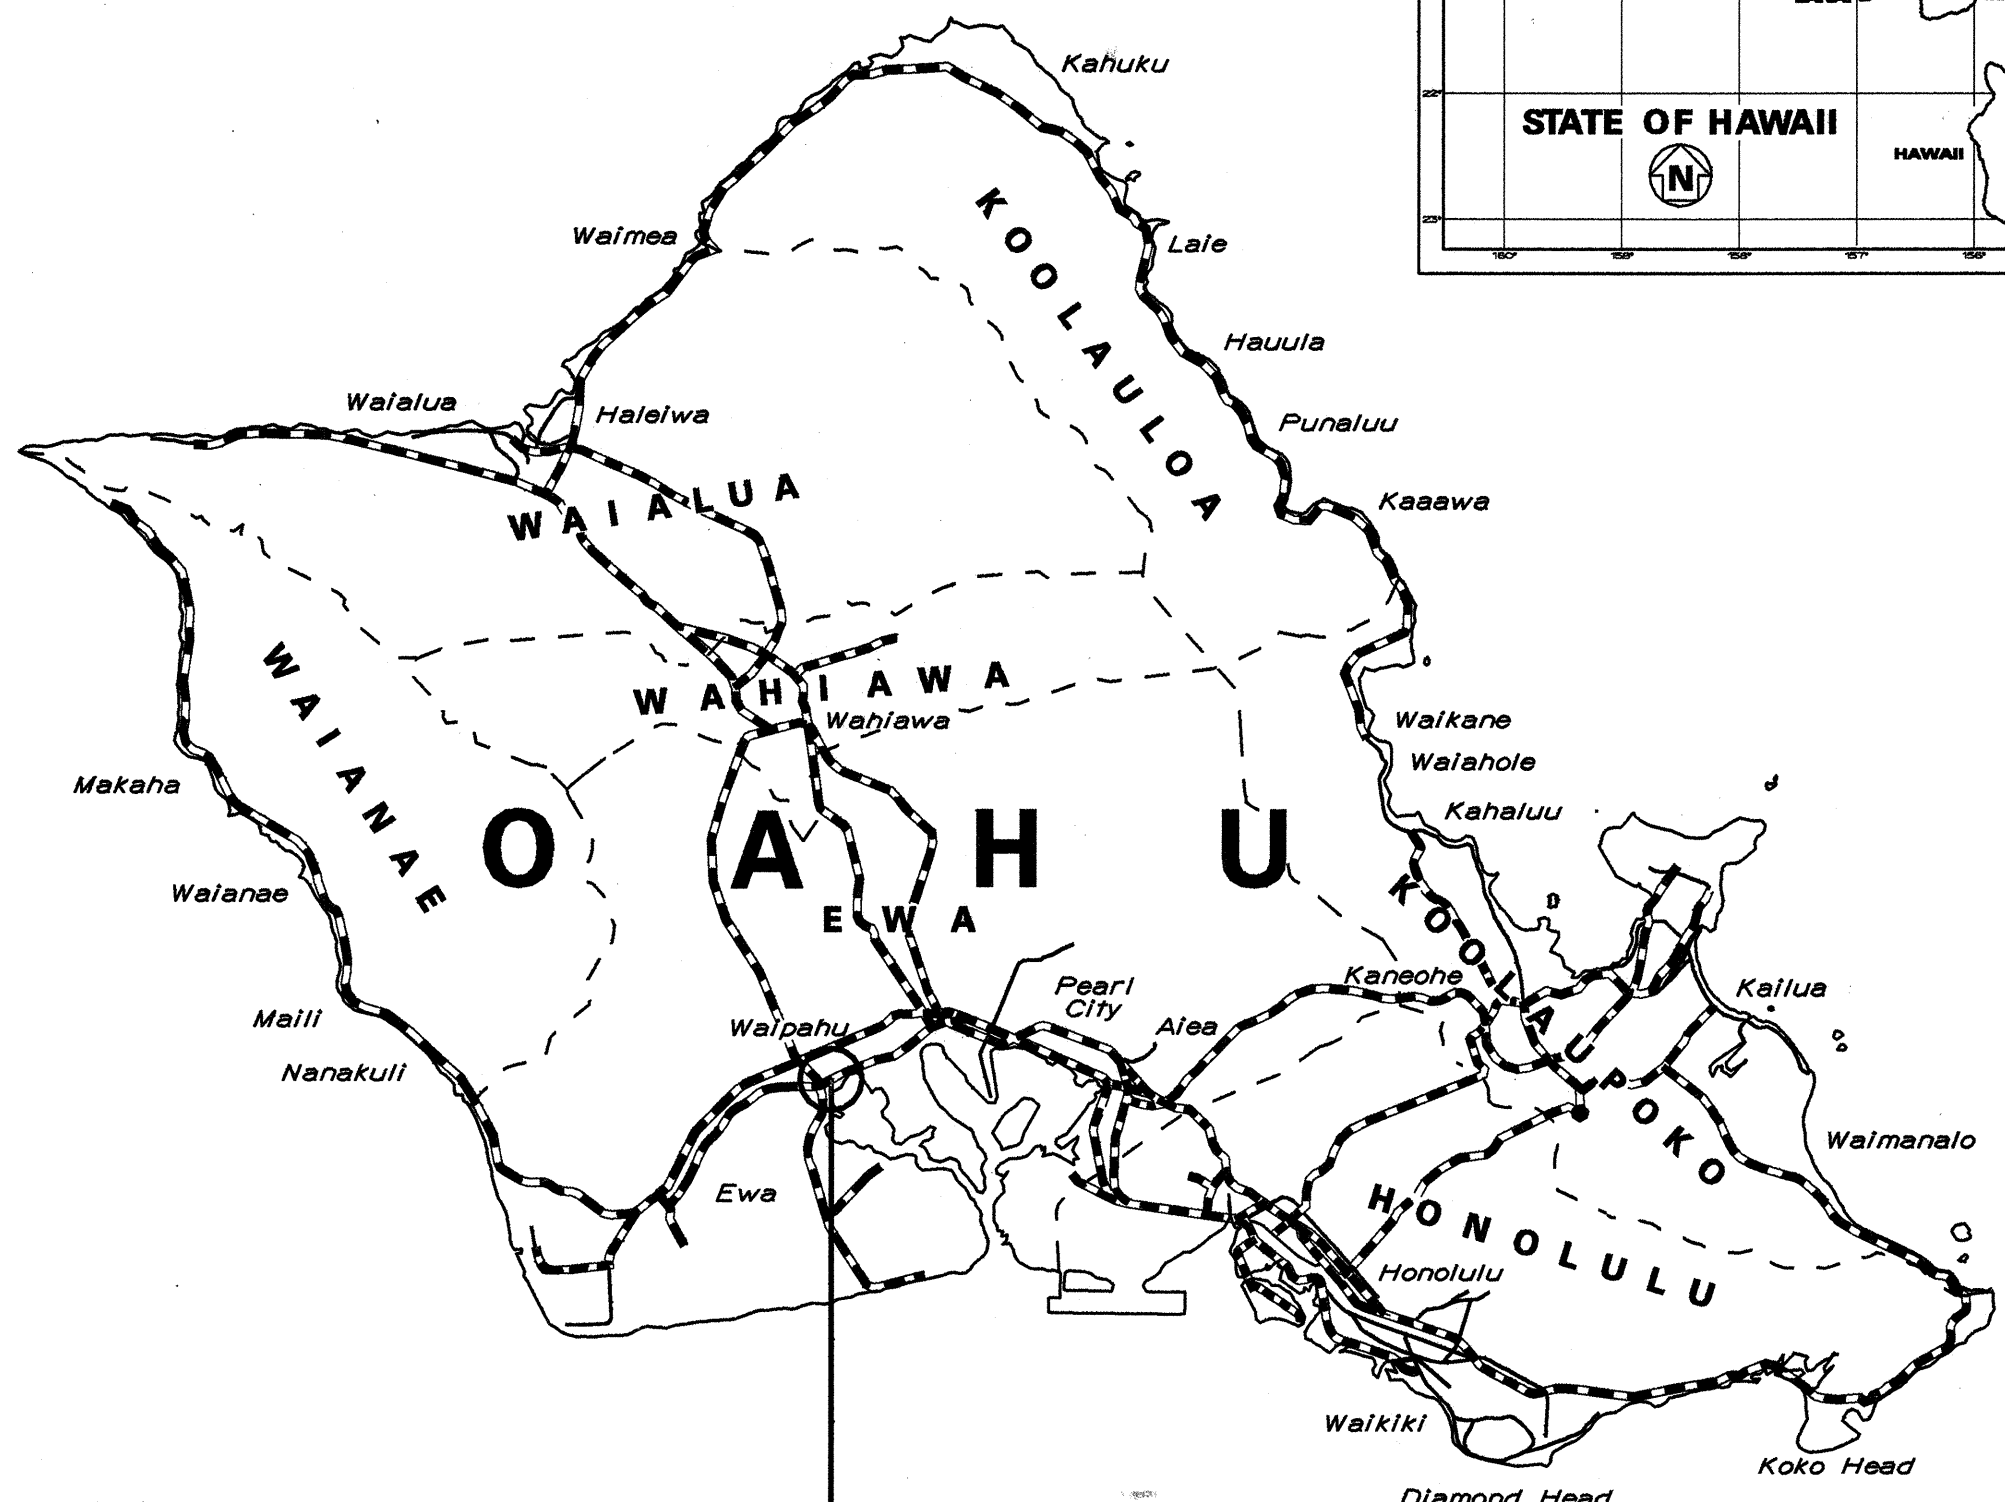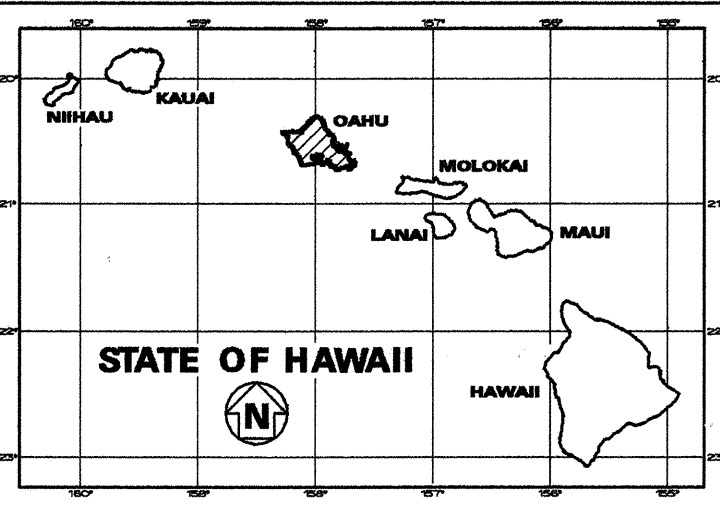

LOCATION OF PROJECT

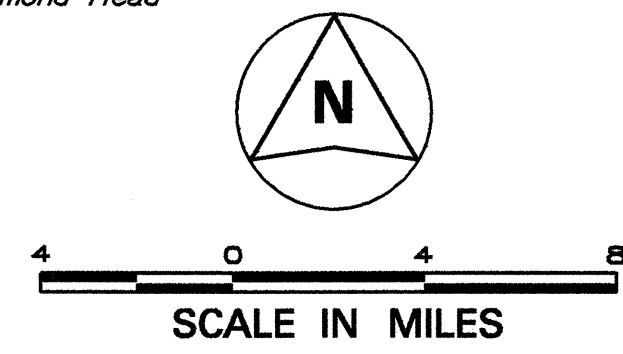

----- FEDERAL AID PROJECTS PREVIOUSLY CONSTRUCTED OR UNDER CONSTRUCTION

MILE POST 0.09 TO MILE POST 0.25

CHANGES MADE DURING CONSTRUCTION HAVE BEEN INCORPORATED ON THESE PLANS EXCEPT CHANGES IN THE ORIGINAL THEORETICAL QUANTITIES. FOR ACTUAL QUANTITIES, REFER TO PROJECT LEDGER AND/OR COMPUTATION BOOK.

[Signature]
RESIDENT ENGINEER
12/10/02
DATE

DEPARTMENT OF TRANSPORTATION
STATE OF HAWAII
APPROVED:
[Signature]
DIR. OF TRANSPORTATION
5/15/00
DATE