

INDEX TO DRAWINGS	
SHEET NO.	DESCRIPTION
1	TITLE SHEET
2	STANDARD PLANS SUMMARY
3-21	CONSTRUCTION NOTES
21-28	GENERAL PLANS
29-32	TYPICAL SECTIONS
33-42	DEMOLITION PLANS
43-50	ESCP PLANS
51-69	ROADWAY PLANS
70-86	INTERSECTION AND MEDIAN PLANS
87-104	GRADING AND DRAINAGE PLANS
105-115	BASIN PLANS
116-168	UTILITY AND DRAIN PLAN AND PROFILES
169-181	WATERLINE CONNECTION AND TEMPORARY BY-PASS PLANS
182-183	DIRECTIONAL DRILLING PLANS
184-203	CURB RAMP LAYOUT & GRADING PLANS
204-222	UTILITY AND ROADWAY DETAILS
223-234	SIGNING AND MARKING PLANS
235-251	CROSS SECTIONS
	NOT USED
300-335	BORING PLAN AND LOGS
	NOT USED
340-544	STRUCTURAL PLANS
	NOT USED
575-724	ELECTRICAL PLANS
	NOT USED
750-767	TRAFFIC CONTROL PLANS

STATE OF HAWAII
DEPARTMENT OF TRANSPORTATION
HIGHWAYS DIVISION
HONOLULU, HAWAII

FARRINGTON HIGHWAY WIDENING
KAPOLEI GOLF COURSE ROAD TO
FORT WEAVER ROAD



PROJECT NO. 7101A-01-20

DISTRICT OF EWA
ISLAND OF OAHU

TMK: 9-1-016: 004, 007, 008, 179, 182, 183, 220, 221;
9-1-017: 043, 070, 097, 099, 172; 9-1-018: 006, 007, 008, 009, 012, 013, 014, 015, 016, 018;
9-1-081: 006, 022

APRIL 21, 2022

FED. ROAD DIST. NO.	STATE	PROJ. NO.	FISCAL YEAR	SHEET NO.	TOTAL SHEETS
HAWAII	HAW.	7101A-01-20	2021	1	767

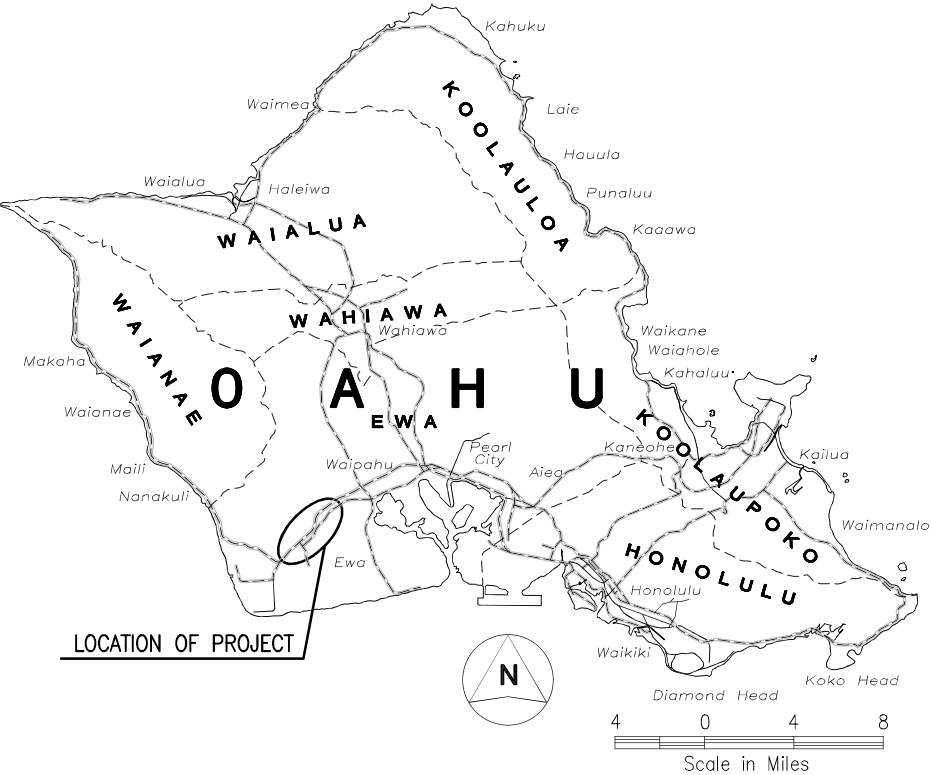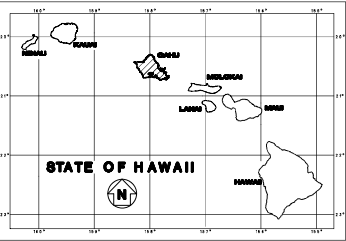



FEDERAL AID PROJECTS PREVIOUSLY CONSTRUCTED OR UNDER CONSTRUCTION

DESIGN DESIGNATION

DESIGN ADT (2040)	17,100
DHV	1,710
K	10.0
D (DESIGN)	75/25
T (DESIGN)	5.5%
T 24	5.0%
V	30 MPH (WEST OF KUALAKAI PKWY.) 30 MPH (EAST OF KUALAKAI PKWY.)

 
DEPARTMENT OF TRANSPORTATION
STATE OF HAWAII

APPROVED:  Apr 18, 2022
DIR. OF TRANSPORTATION DATE

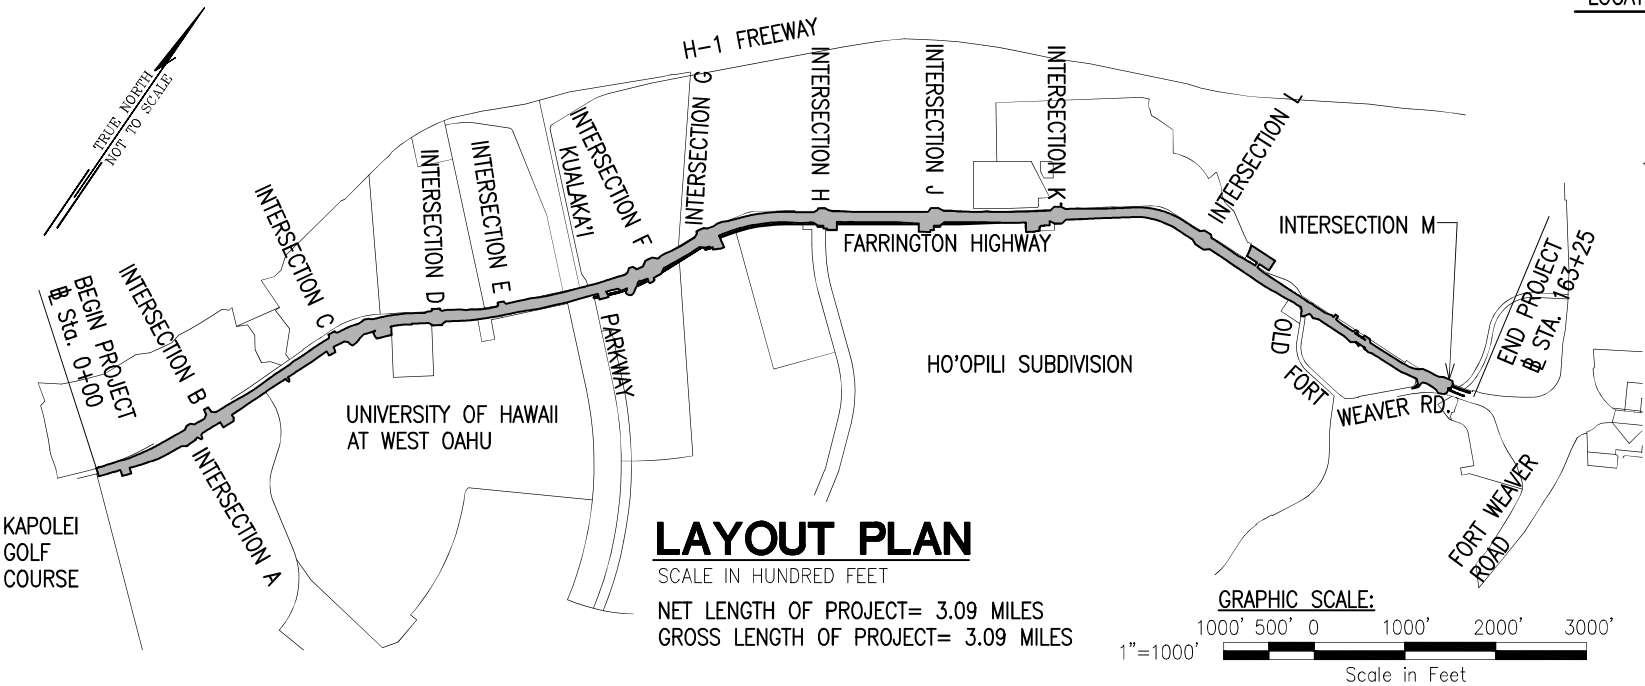

LAYOUT PLAN

 SCALE IN HUNDRED FEET
NET LENGTH OF PROJECT= 3.09 MILES
GROSS LENGTH OF PROJECT= 3.09 MILES



SURVEY PLOTTED BY	DATE
DRAWN BY	REV
TRACED BY	WC
QUANTITIES BY	
CHECKED BY	
ORIGINAL PLAN	No.

R.M. TOWILL CORP. HWY-DD APRIL 2022
DESIGNED BY 692-8431 PHONE DATE
MANAGED BY