
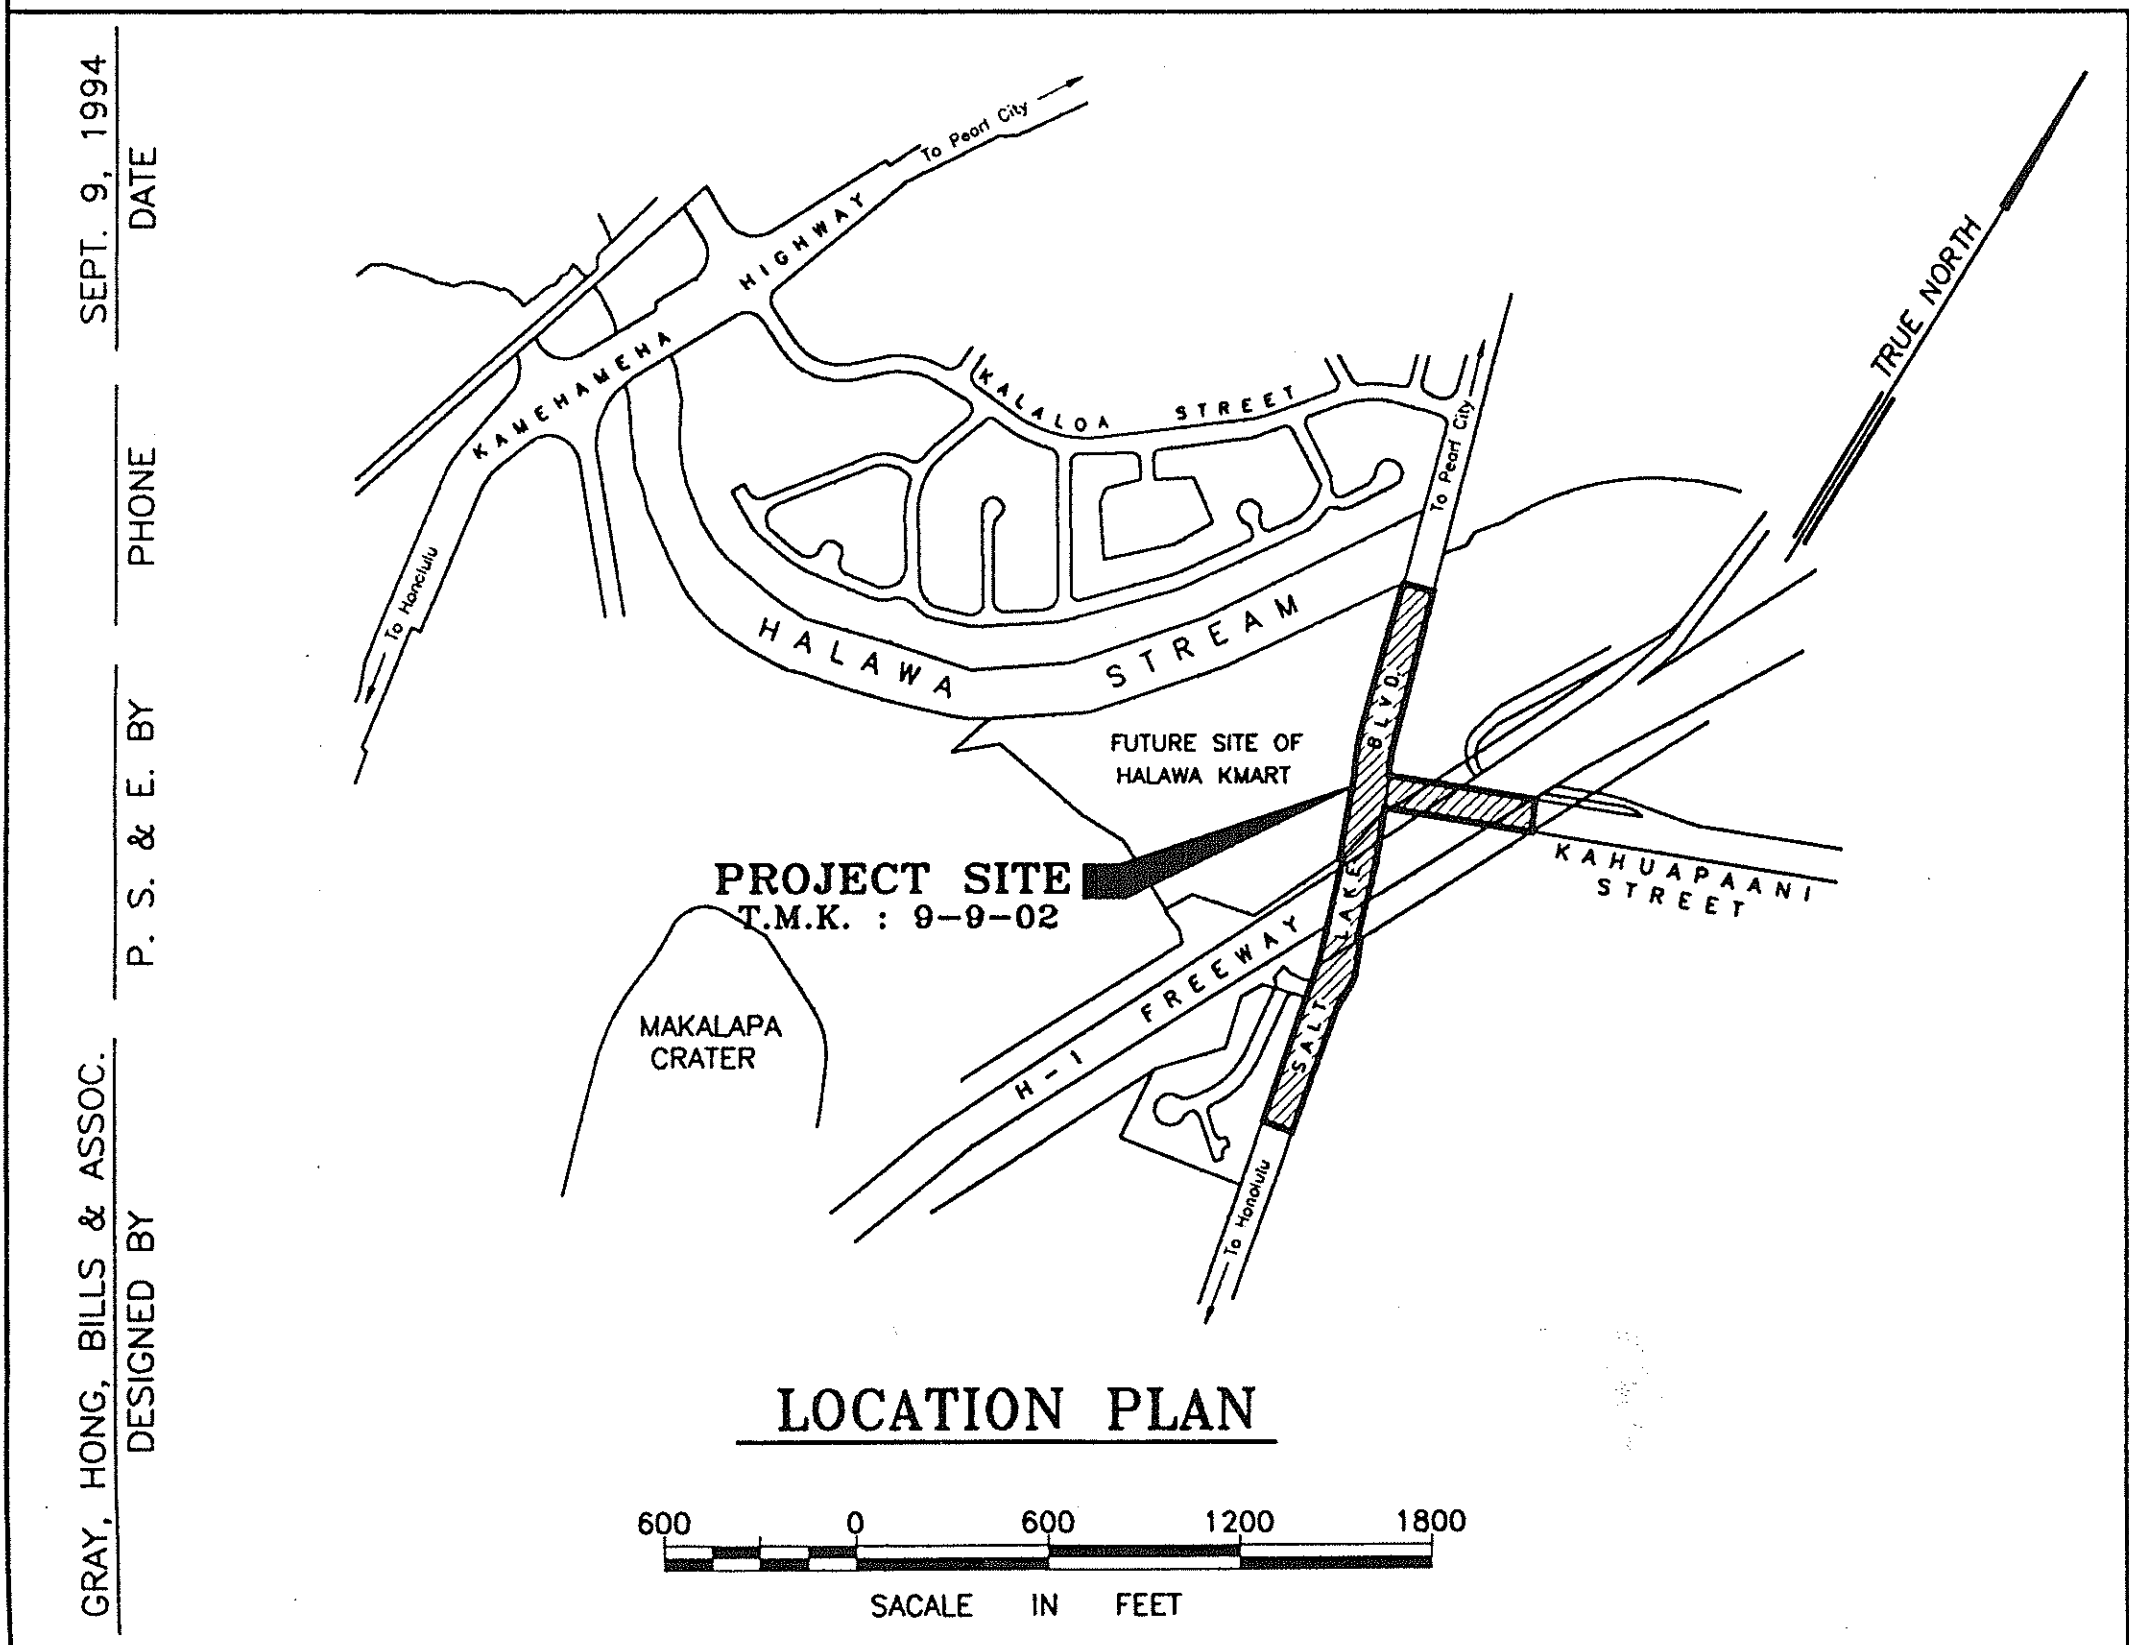


PLOTTING
COLORS: PEN
1 2 3 4 5 6 7 8 9 10 11 12 13 14 15
SCALE: 1=40

INDEX TO DRAWINGS	
SHEET NO.	DESCRIPTION
1.	TITLE SHEET
2.	EXISTING CONDITIONS
3.	GENERAL PLAN
4.	GENERAL NOTES & TYPICAL SECTIONS
5.	PLAN & PROFILE - STA. 22+00 TO STA. 34+00 SALT LAKE BLVD.
6.	PLAN & PROFILE - STA. 34+00 TO STA. 39+00 SALT LAKE BLVD. PLAN & PROFILE - STA. 61+00 TO STA. 64+61.53 KAHUAPAANI STREET
7.	STRIPING PLAN
8.	TRAFFIC CONTROL PLAN
9.	MISCELLANEOUS DETAILS - 1
10.	MISCELLANEOUS DETAILS - 2
11.	TRAFFIC SIGNAL SYSTEM - GENERAL NOTES
12.	TRAFFIC SIGNAL SYSTEM - INTERCONNECT PLAN
13.	TRAFFIC SIGNAL SYSTEM - DEMOLITION & REMOVAL PLAN
14.	TRAFFIC SIGNAL SYSTEM - TRAFFIC SIGNAL PLAN
15.	TRAFFIC SIGNAL SYSTEM - MISCELLANEOUS DETAILS
16.	TRAFFIC SIGNAL SYSTEM - TRENCH DETAILS
17.	TRAFFIC SIGNAL SYSTEM - SENSOR LOOP DETAILS
18.	REVISIONS TO TRAFFIC SIGNAL SYSTEM
19.	SITE ELECTRICAL PLAN, LOCATION PLAN, SYMBOLS & STREET LIGHT DUCT SECTION
20.	STREET LIGHT DETAILS & DUCT SECTIONS

STATE OF HAWAII
DEPARTMENT OF TRANSPORTATION
HIGHWAYS DIVISION
HONOLULU, HAWAII
" AS - BUILT "
PLANS FOR
**KAHUAPAANI STREET IMPROVEMENTS
AT SALT LAKE BOULEVARD**
PROJECT NO. 7241A-01-94
DISTRICT OF EWA
ISLAND OF OAHU

FED. ROAD DIST. NO.	STATE	PROJ. NO.	FISCAL YEAR	SHEET NO.	TOTAL SHEETS
HAWAII	HAW.	7241A-01-94	1995	1	20

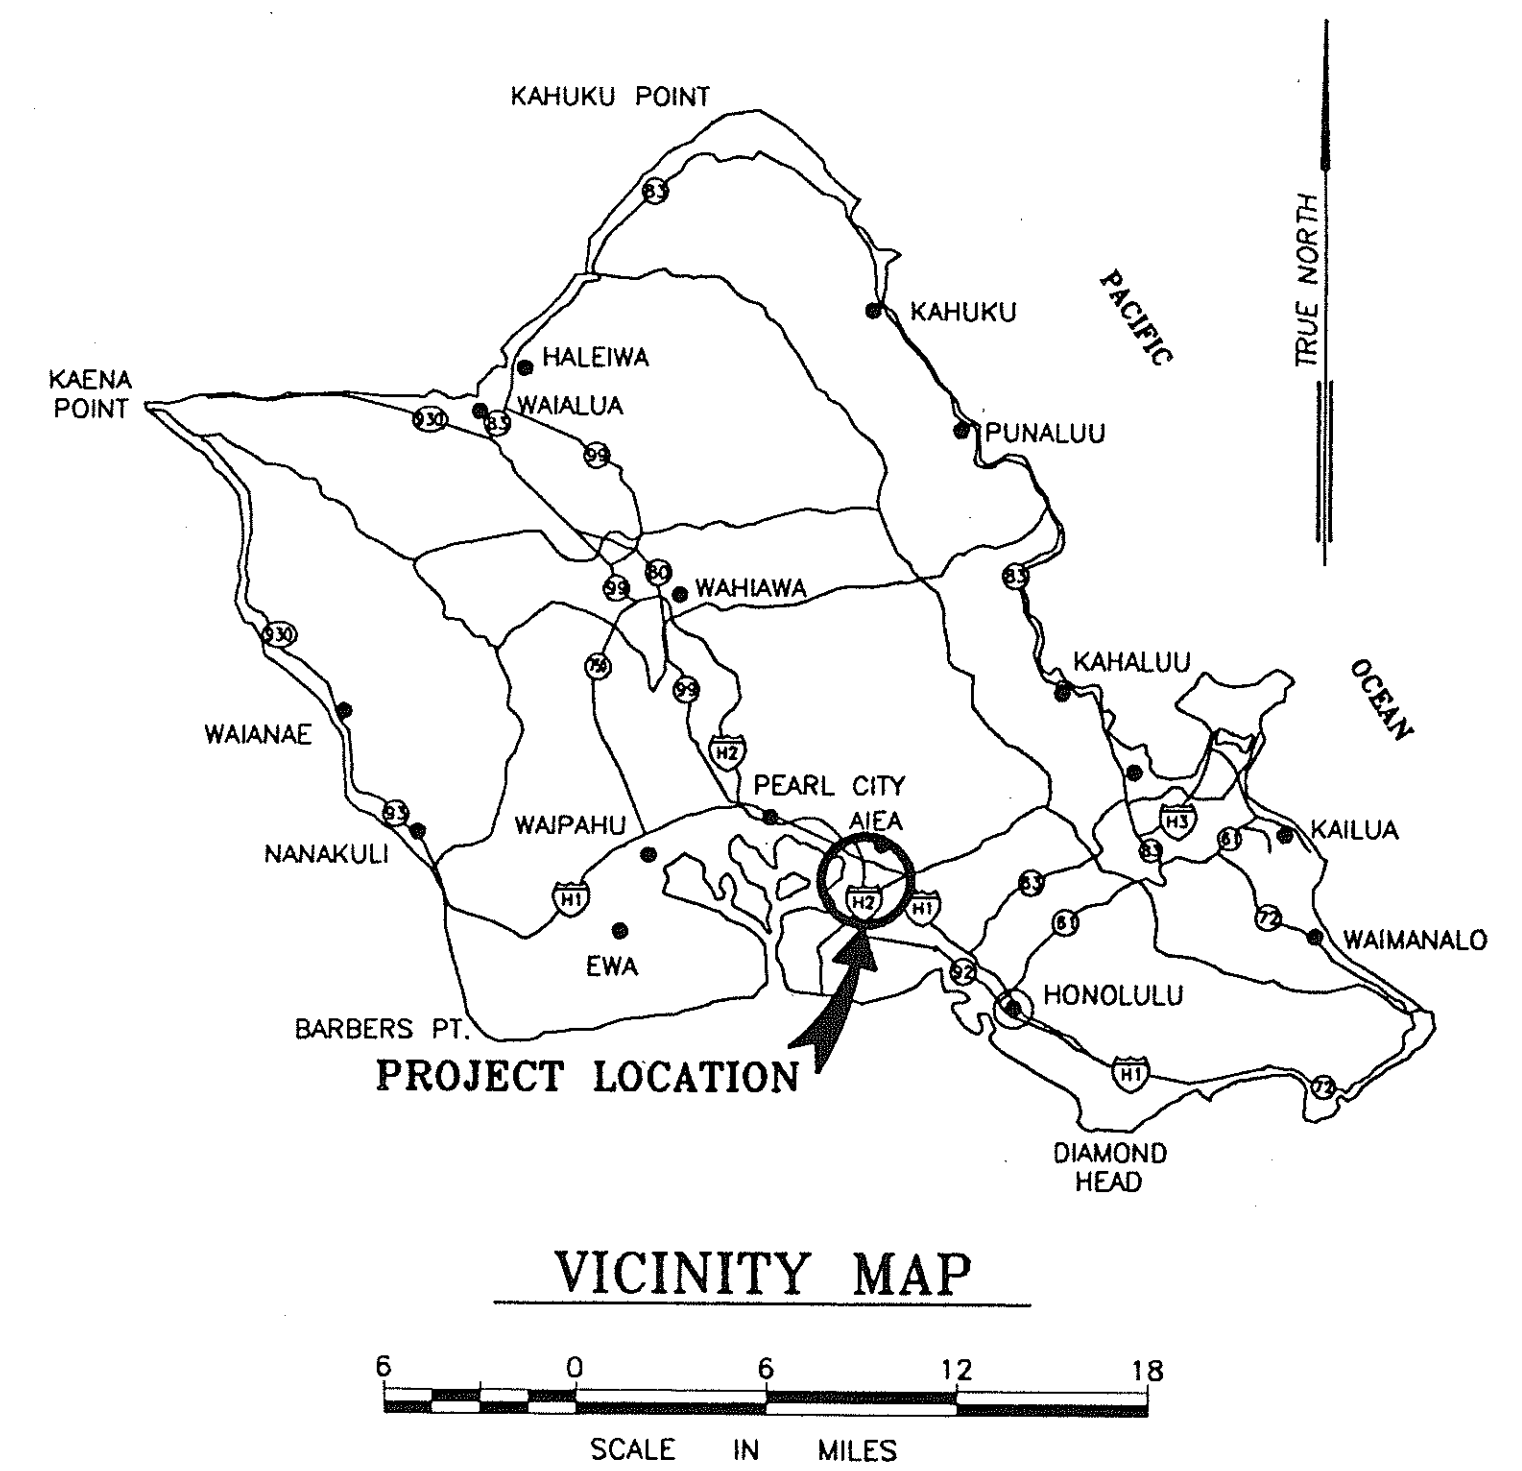

APPROVED:

Stefing H. Monahan
CHIEF, HIGHWAYS DIVISION
STATE DEPARTMENT OF TRANSPORTATION (APPROVAL GRANTED
FOR WORK WITHIN STATE RIGHT-OF-WAY ONLY. ID NO. 0-93-40,
LETTER OF APPROVAL NO. HWY-CM 2-0944,
DATED 12 APRIL 1994.)
12 Apr 94
DATE

[Signature]
DIRECTOR & CHIEF ENGINEER
DEPARTMENT OF PUBLIC WORKS
10/29/93
DATE

[Signature]
DIRECTOR, DEPT. OF TRANSPORTATION SERVICES
(FOR CONSTRUCTION WITHIN CITY R.O.W. ONLY)
3/14/94
DATE

PROJECT TITLE: KMART
CAD DWG. NO. 232841LE
DATE: AUGUST 19, 1993

SEPT. 9, 1994
DATE
PHONE
P. S. & E. BY
DESIGNED BY
GRAY, HONG, BILLS & ASSOC.