

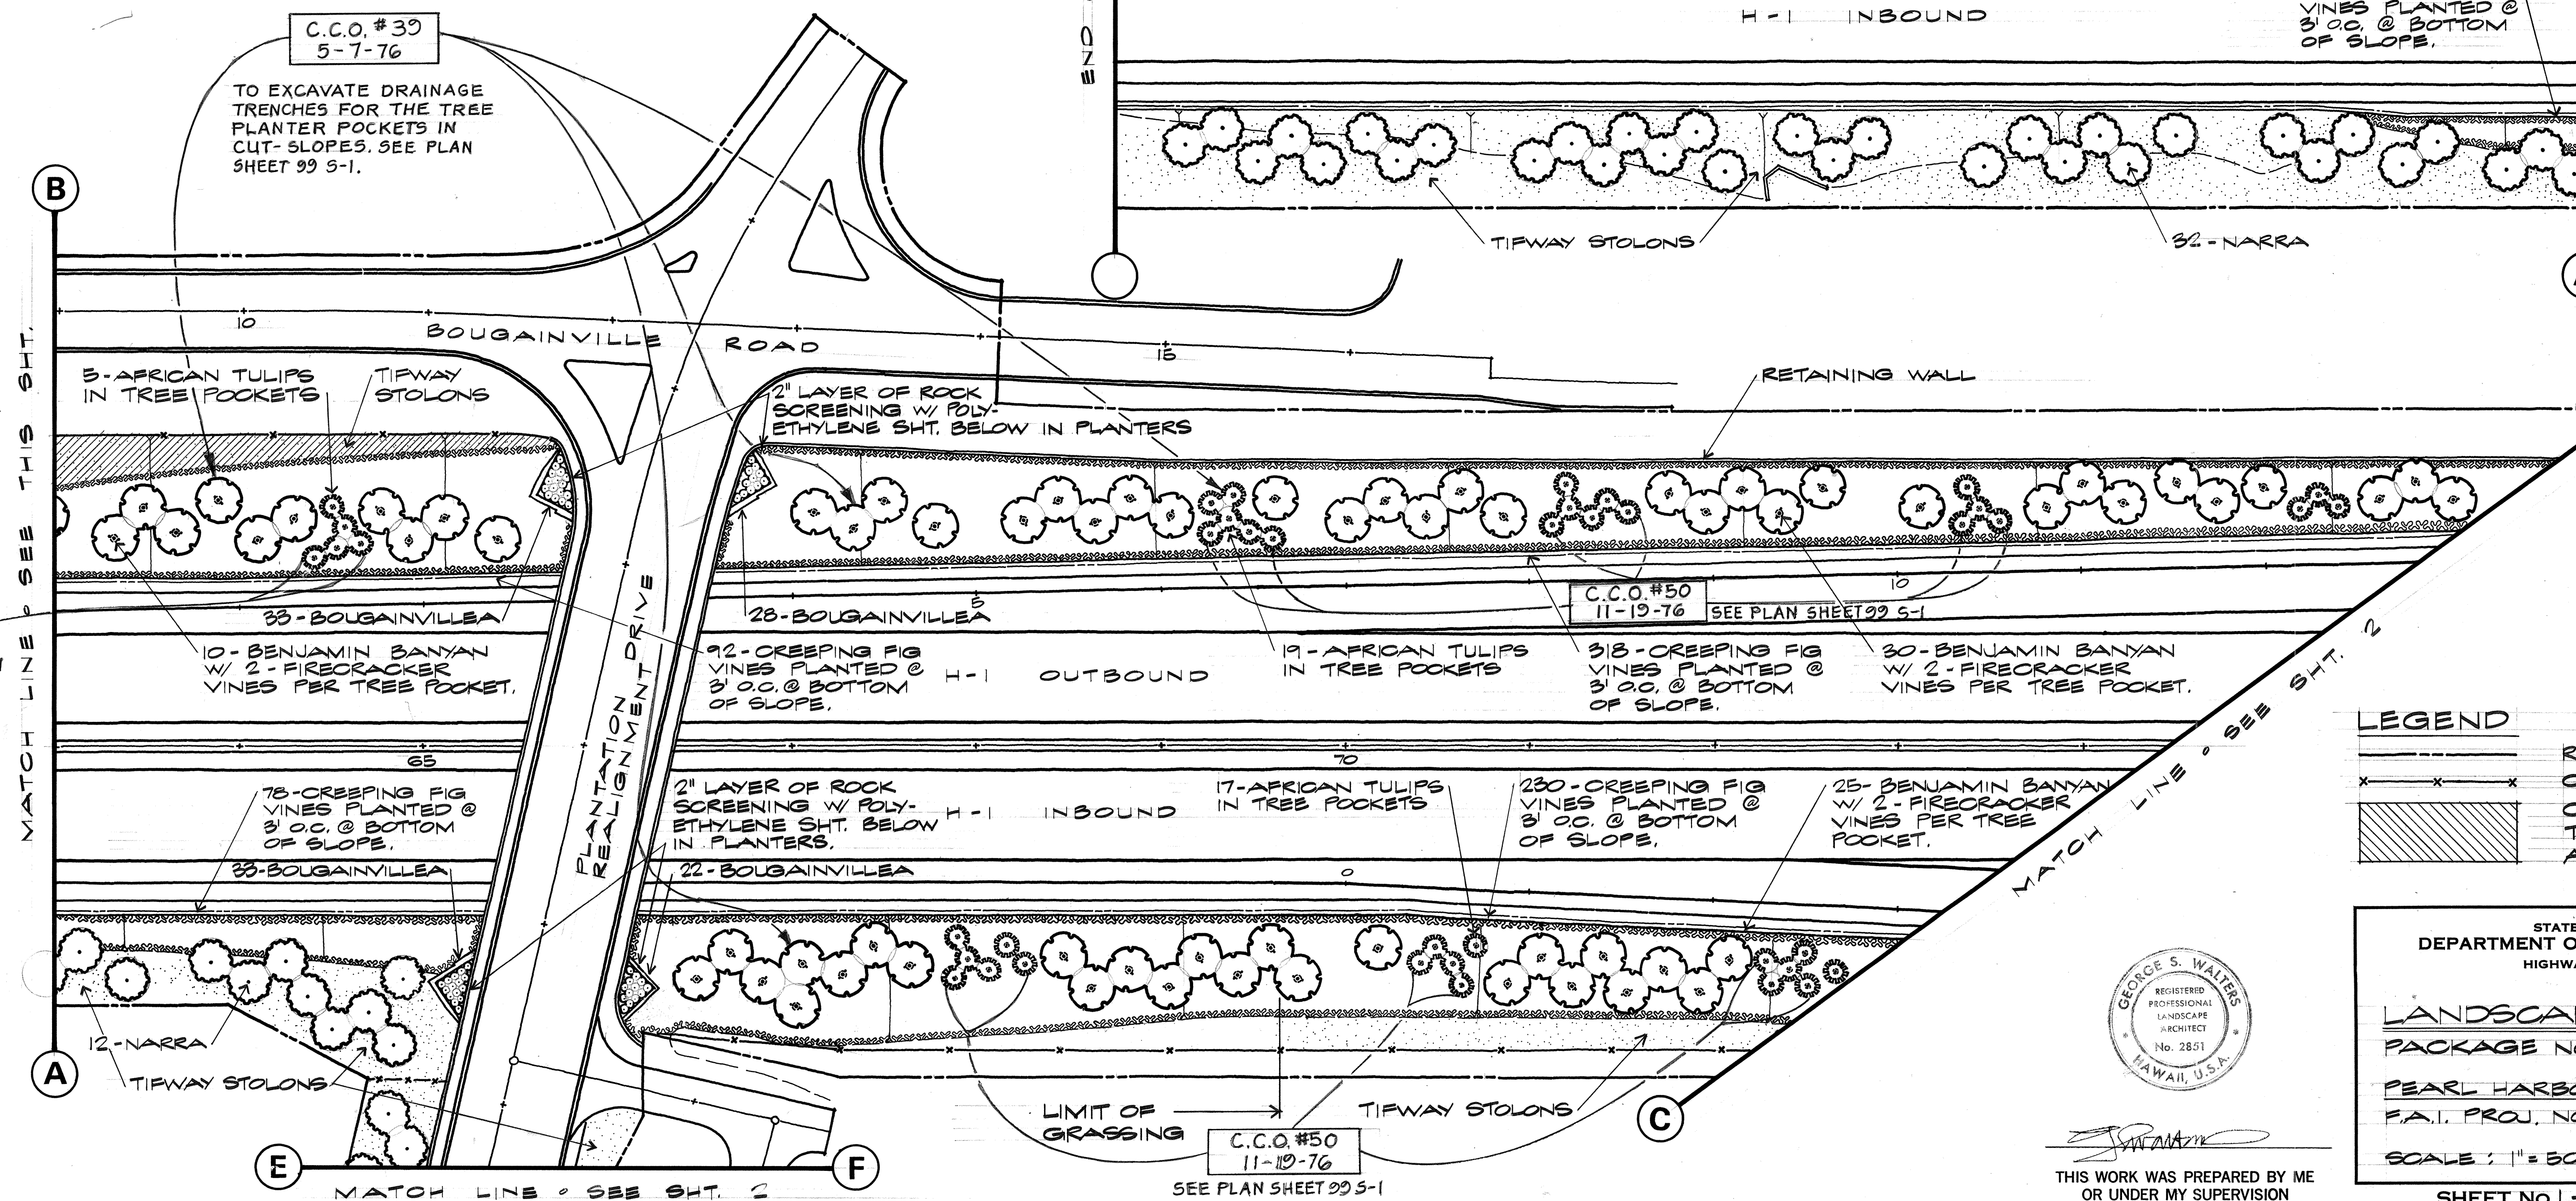
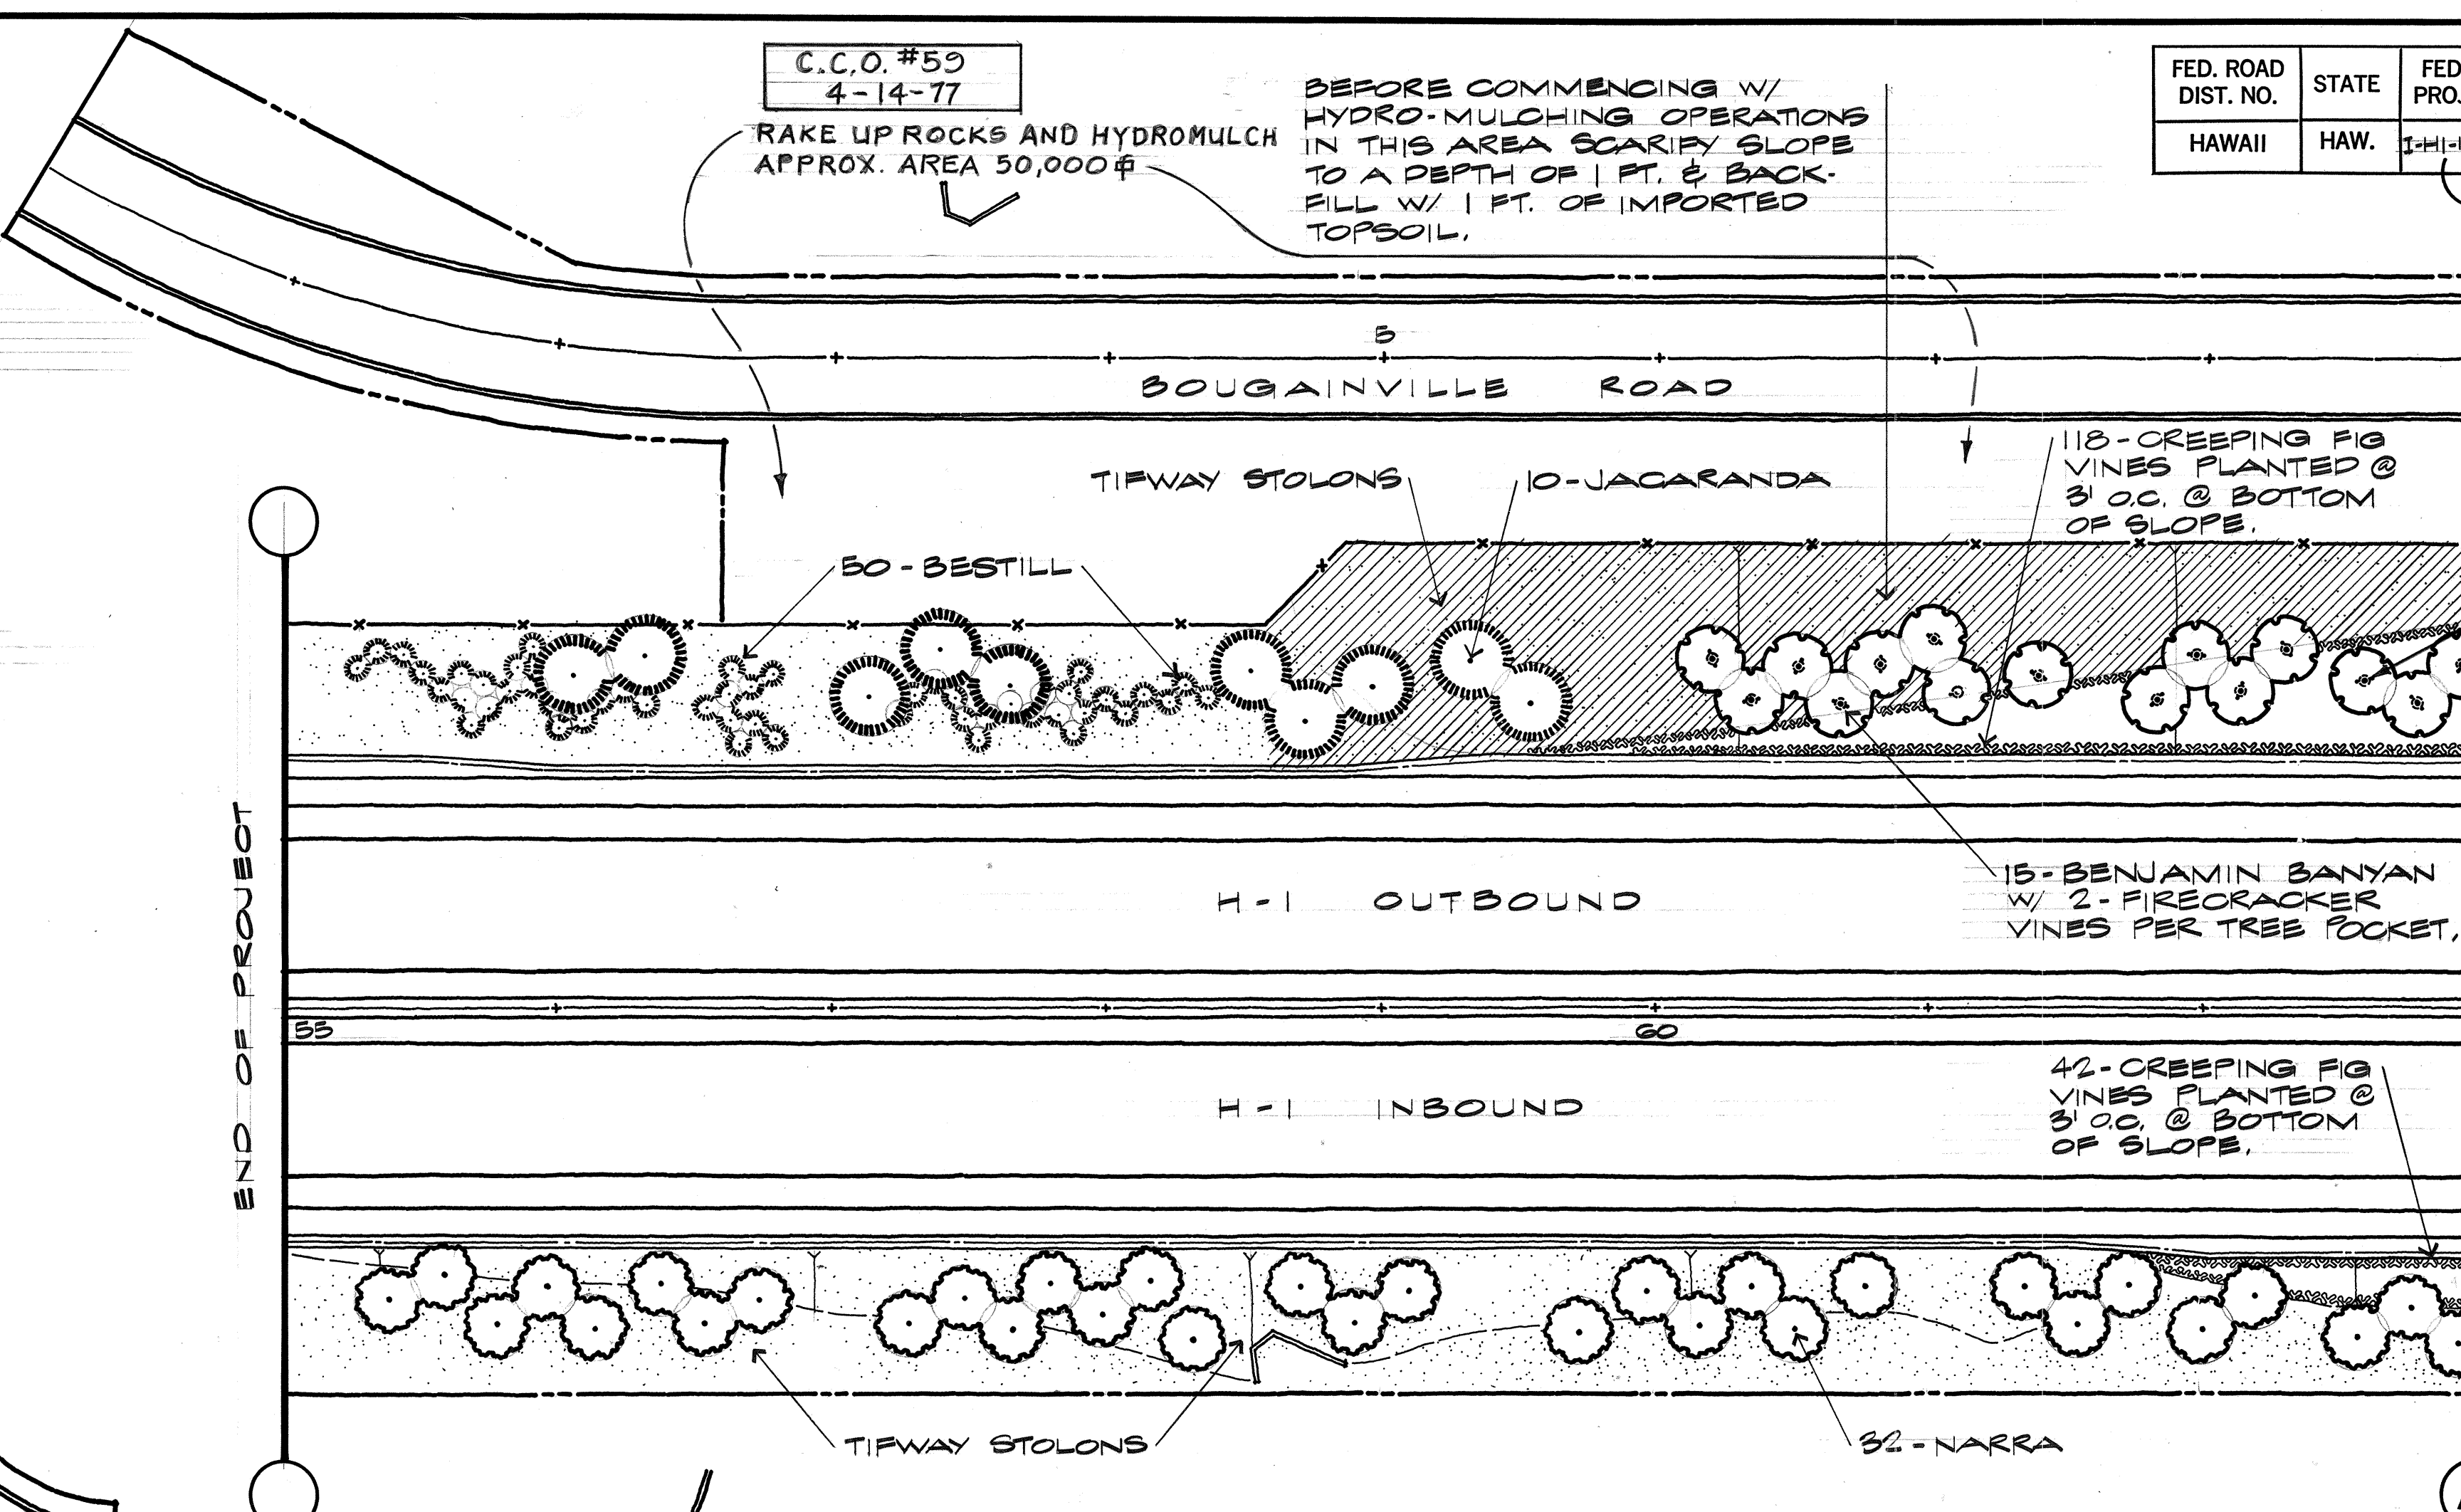


FED. ROAD DIST. NO.	STATE	FED. AID PROJ. NO.	FISCAL YEAR	SHEET NO.	TOTAL SHEETS
HAWAII	HAW.	I-H-1-(111):14	1974	98	234

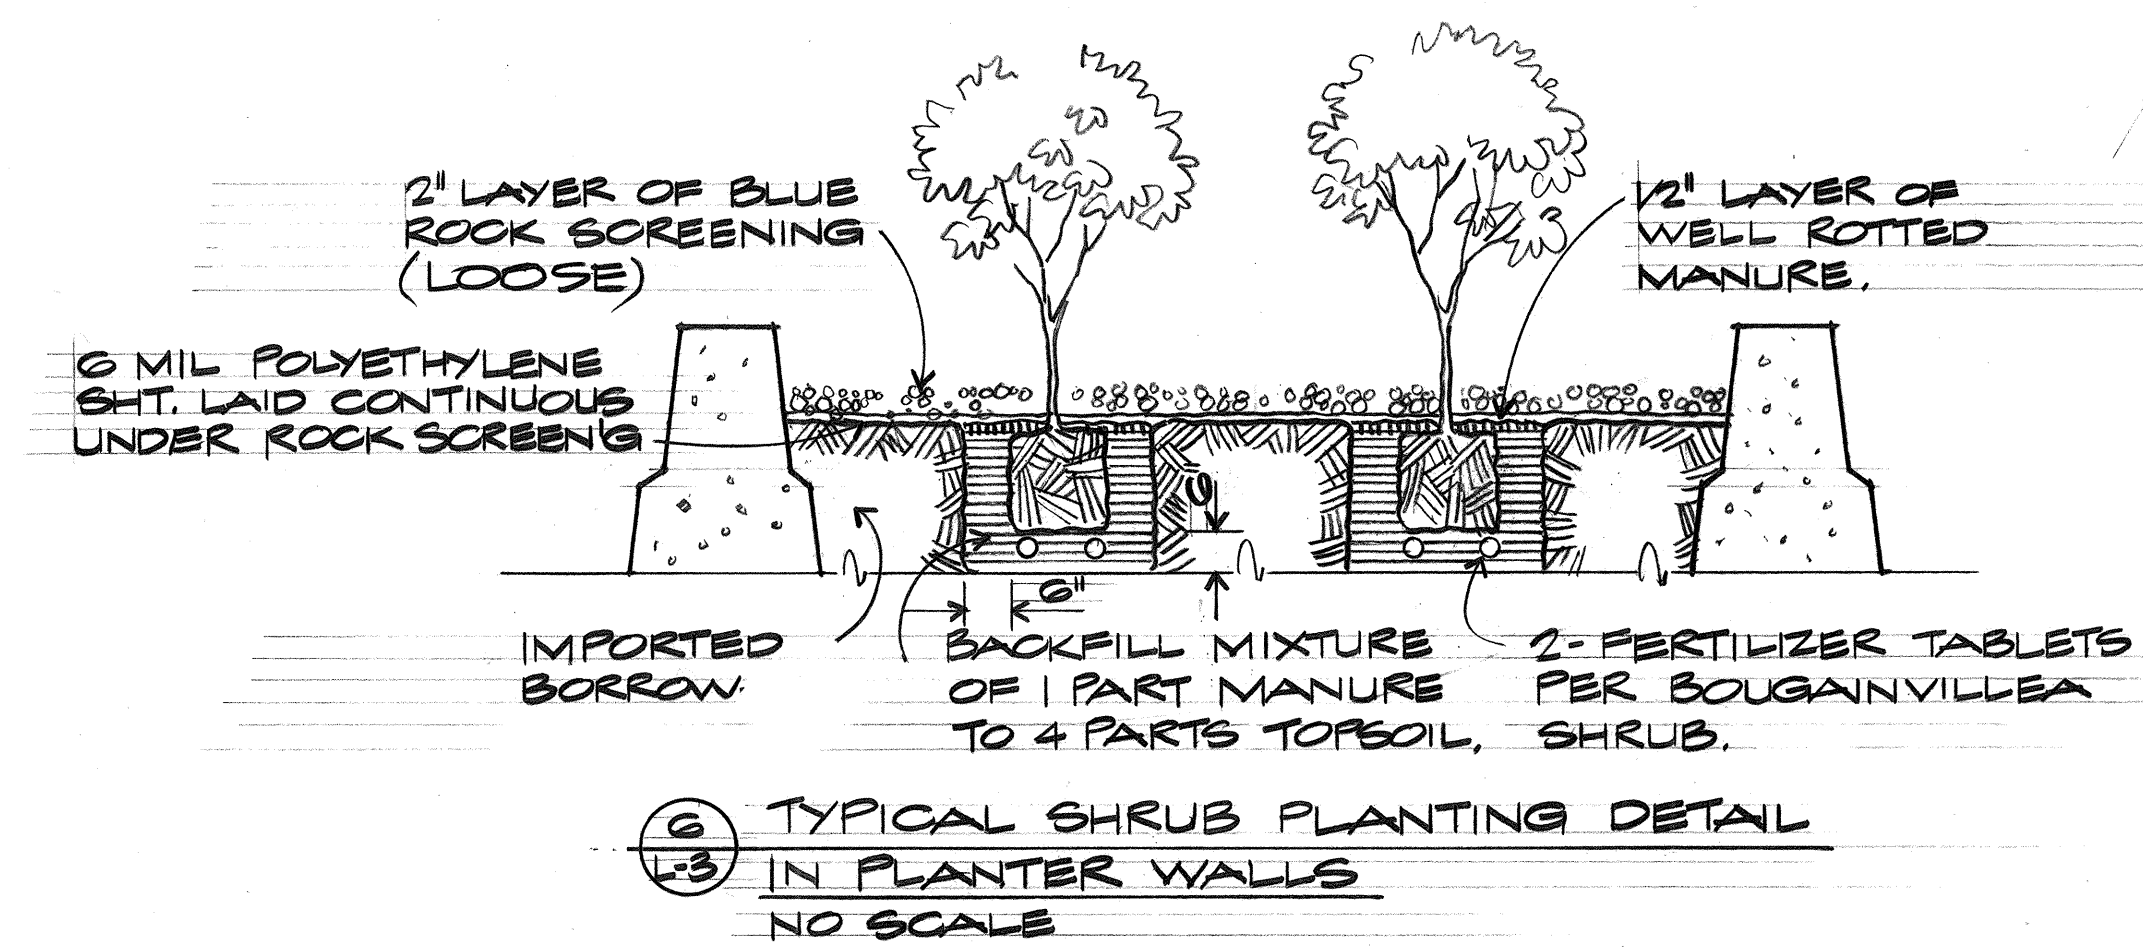

LEGEND

---	RIGHT-OF-WAY
---	CONTROL ACCESS
---	CUT SLOPE AREAS TO BE SCARIFIED AND FILLED.

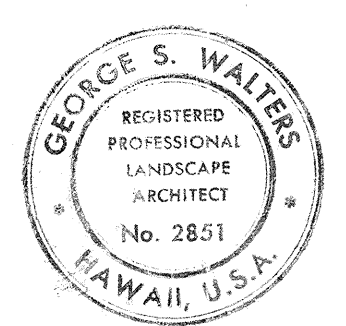


STATE OF HAWAII
 DEPARTMENT OF TRANSPORTATION
 HIGHWAYS DIVISION

LANDSCAPE PLAN
 PACKAGE NO. 2
 PEARL HARBOR INTERCHANGE
 F.A.T. PROJ. NO. I-H-1-(111):14
 SCALE: 1" = 30' DATE: DEC. 14, 1973
 SHEET NO. 1 OF 13 SHEETS

THIS WORK WAS PREPARED BY ME OR UNDER MY SUPERVISION

ORIGINAL PLAN	DATE
SURVEY PLOTTED BY	
DRAWN BY	
DESIGNED BY	
QUANTITIES BY	
CHECKED BY	

FED. ROAD DIST. NO.	STATE	FED. AID PROJ. NO.	FISCAL YEAR	SHEET NO.	TOTAL SHEETS
HAWAII	HAW.	I-HI-1(111)14	1974	99	234

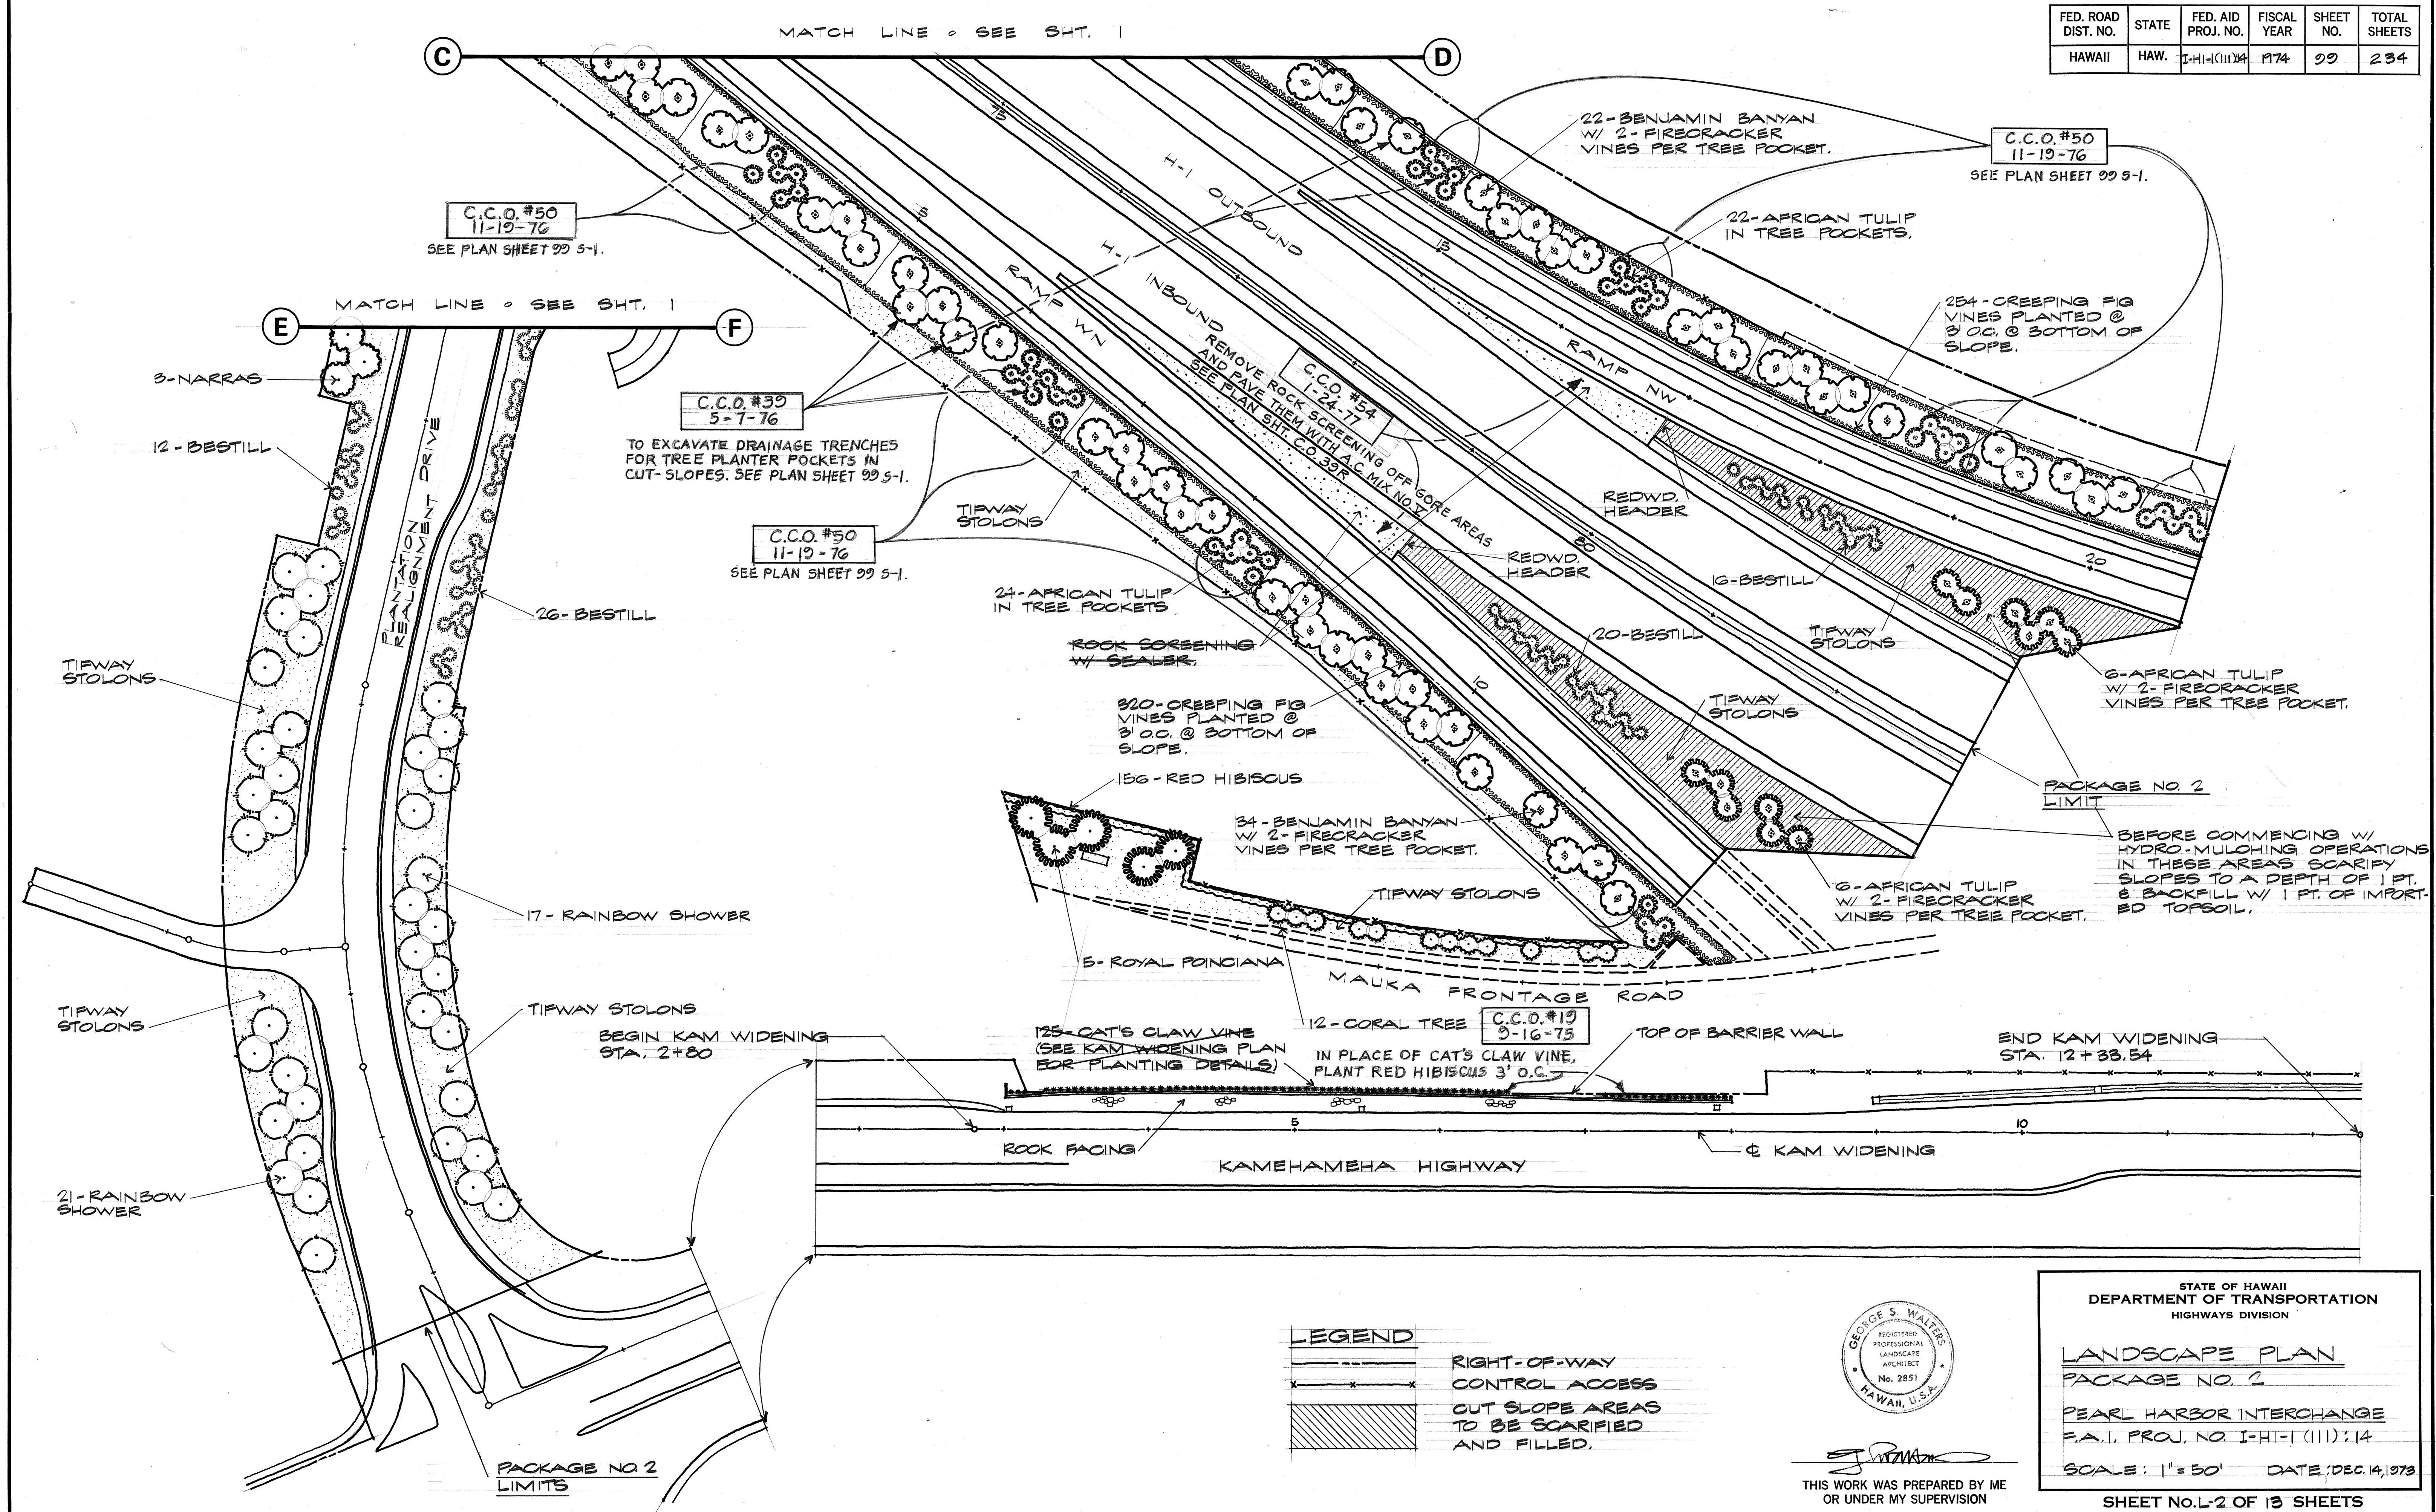

ORIGINAL	SURVEY PLATTED BY	DATE
PLAN	DRAWN BY	" "
NOTE BOOK	DESIGNED BY	" "
QUANTITIES BY	CHECKED BY	" "
No.		

STATE OF HAWAII
DEPARTMENT OF TRANSPORTATION
HIGHWAYS DIVISION

LANDSCAPE PLAN
PACKAGE NO. 2

PEARL HARBOR INTERCHANGE
F.A.I. PROJ. NO. I-HI-1(111)14


SCALE: 1" = 30' DATE: DEC. 14, 1973

SHEET NO. L-2 OF 13 SHEETS

GEORGE S. WALTERS
REGISTERED PROFESSIONAL
LANDSCAPE ARCHITECT
No. 2851
HAWAII, U.S.A.


THIS WORK WAS PREPARED BY ME
OR UNDER MY SUPERVISION

FED. ROAD DIST. NO.	STATE	FED. AID PROJ. NO.	FISCAL YEAR	SHEET NO.	TOTAL SHEETS
HAWAII	HAW.	I-HI-1(III)-44	1974	995-1	234

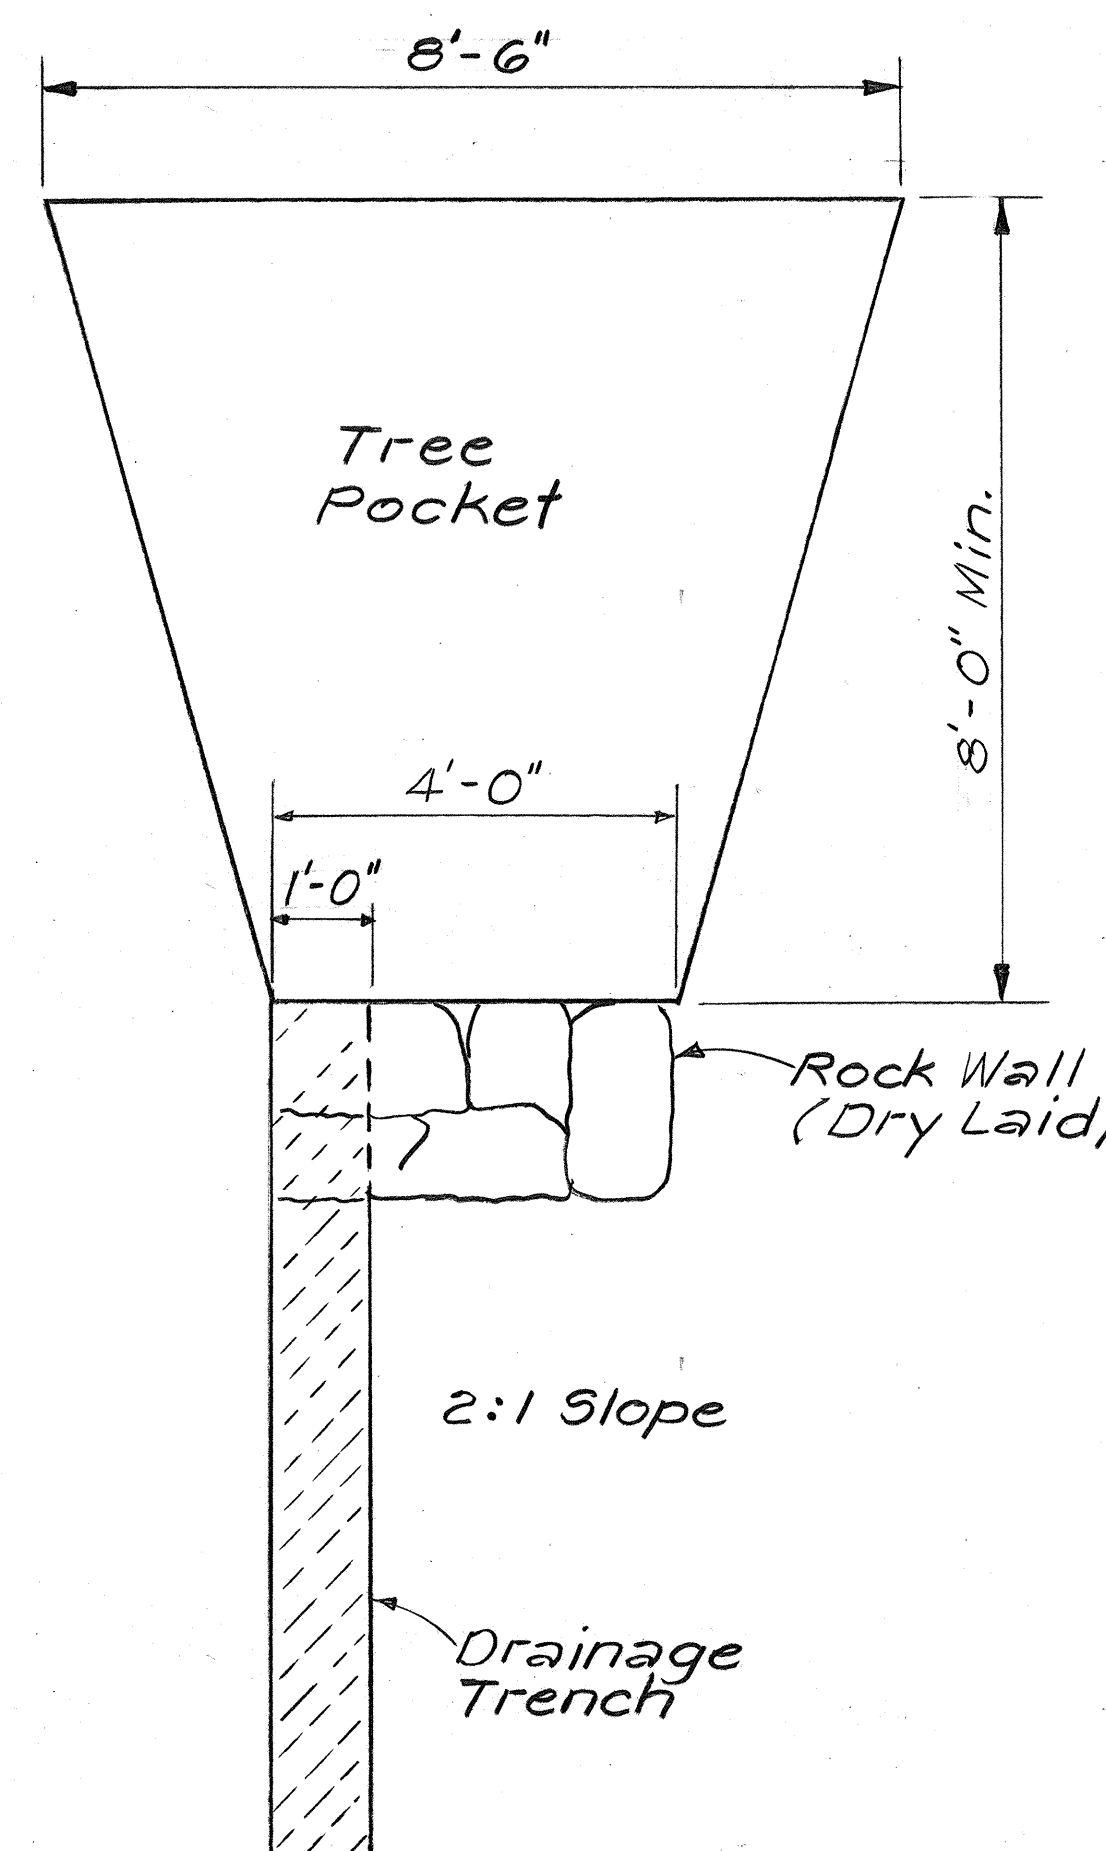

NOTE:
Minimum plan view
tree pocket area =
50 square feet.

PLAN
Not to Scale

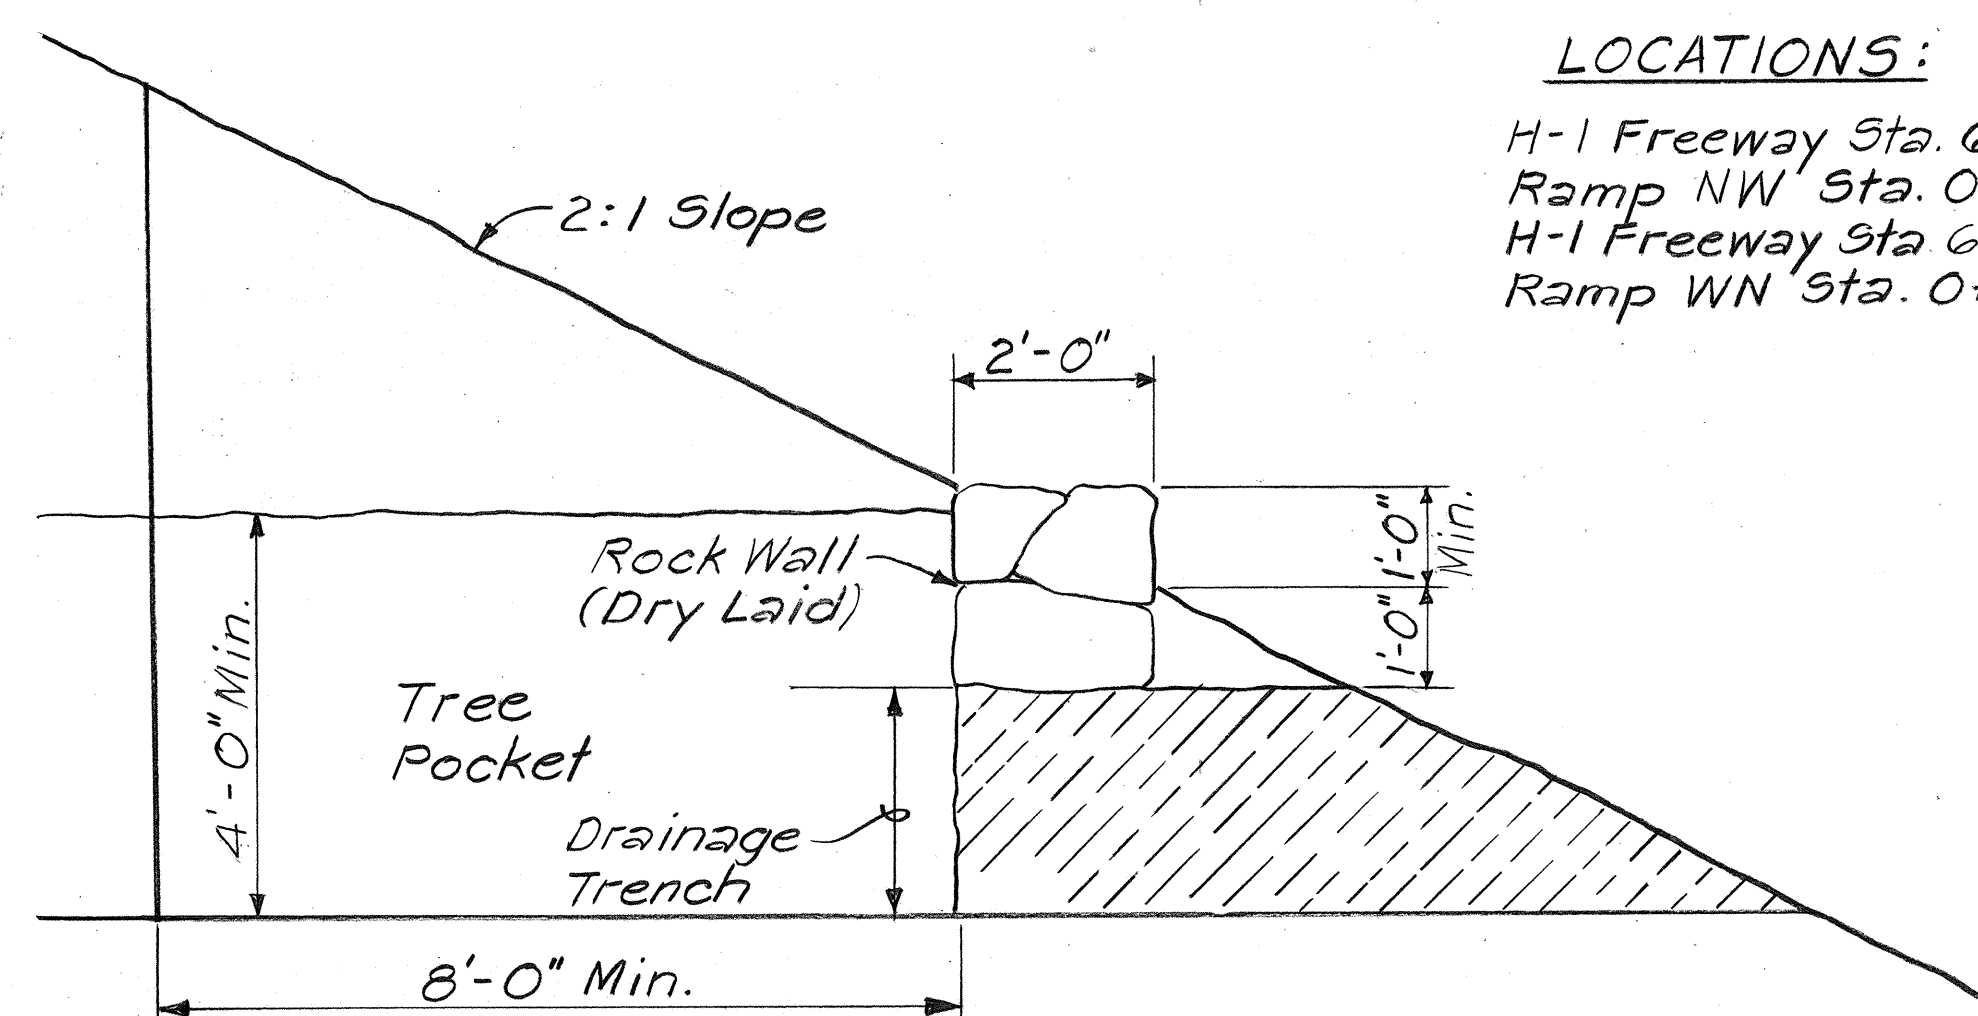

ELEVATION
Not to Scale

TREE POCKET IN TUFF-CUT SLOPE

LOCATIONS:


H-1 Freeway Sta. 61+00 to 64+00 %s Lt.
Ramp NW Sta. 0+00 to 20+70 %s Lt.
H-1 Freeway Sta. 66+50 to 70+00 %s Rt.
Ramp WN Sta. 0+00 to 12+00 %s Rt.

C.C.O. #39
5-7-76

See Plan Sheets 98 & 99

LOCATIONS:

H-1 Freeway Sta. 67+80 to 68+30 Rt.
Ramp NW Sta. 1+30 to 20+70 Lt.
Ramp WN Sta. 0+30 to 12+00 Rt.

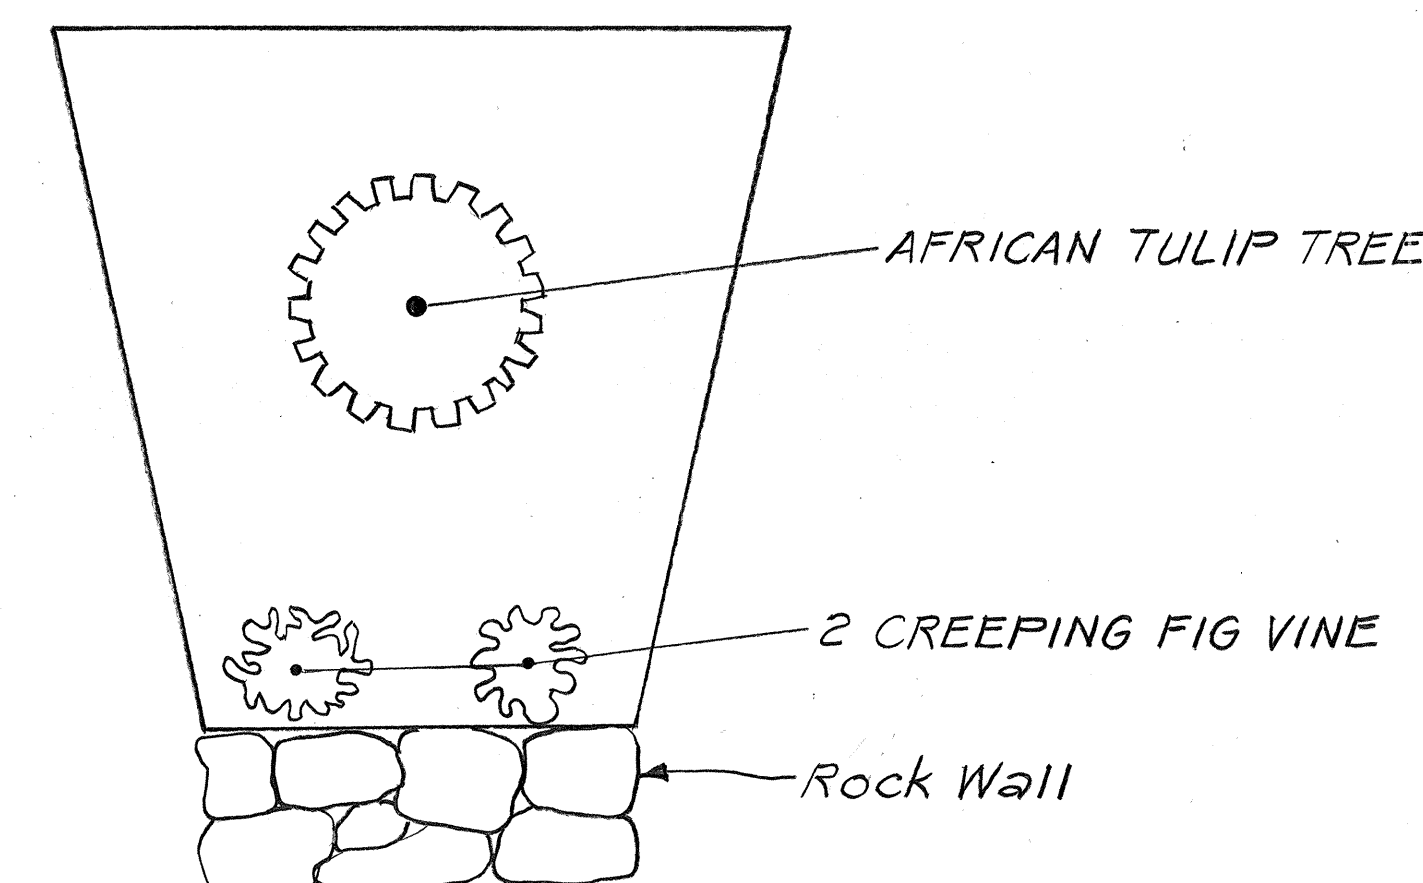

PLAN
Not to Scale

TREE POCKET IN TUFF-CUT SLOPE

C.C.O. #50
11-19-76

To Plant Additional Creeping Fig
Vines (2 in each Tree Pocket) in
Tree Pocket Containing African
Tulip Tree. See Plan Sheets 98 & 99.

THIS TRACING PREPARED
DURING "AS-BUILT" POSTING

STATE OF HAWAII
DEPARTMENT OF TRANSPORTATION
LAND TRANSPORTATION FACILITIES DIVISION

LANDSCAPE DETAILS


PEARL HARBOR INTERCHANGE
F.A.I. PROJ. NO. I-HI-1(III)-14

Not to Scale Dec., 1977
SHEET No. OF SHEETS

99 S - 1

ORIGINAL	SURVEY PLOTTED BY	DATE
PLAN	DRAWN BY	
NOTE BOOK	DESIGNED BY	
No.	QUANTITIES BY	
	CHECKED BY	

FED. ROAD DIST. NO.	STATE	FED. AID PROJ. NO.	FISCAL YEAR	SHEET NO.	TOTAL SHEETS
HAWAII	HAW.	I-HI-1(111)	1974	100	234

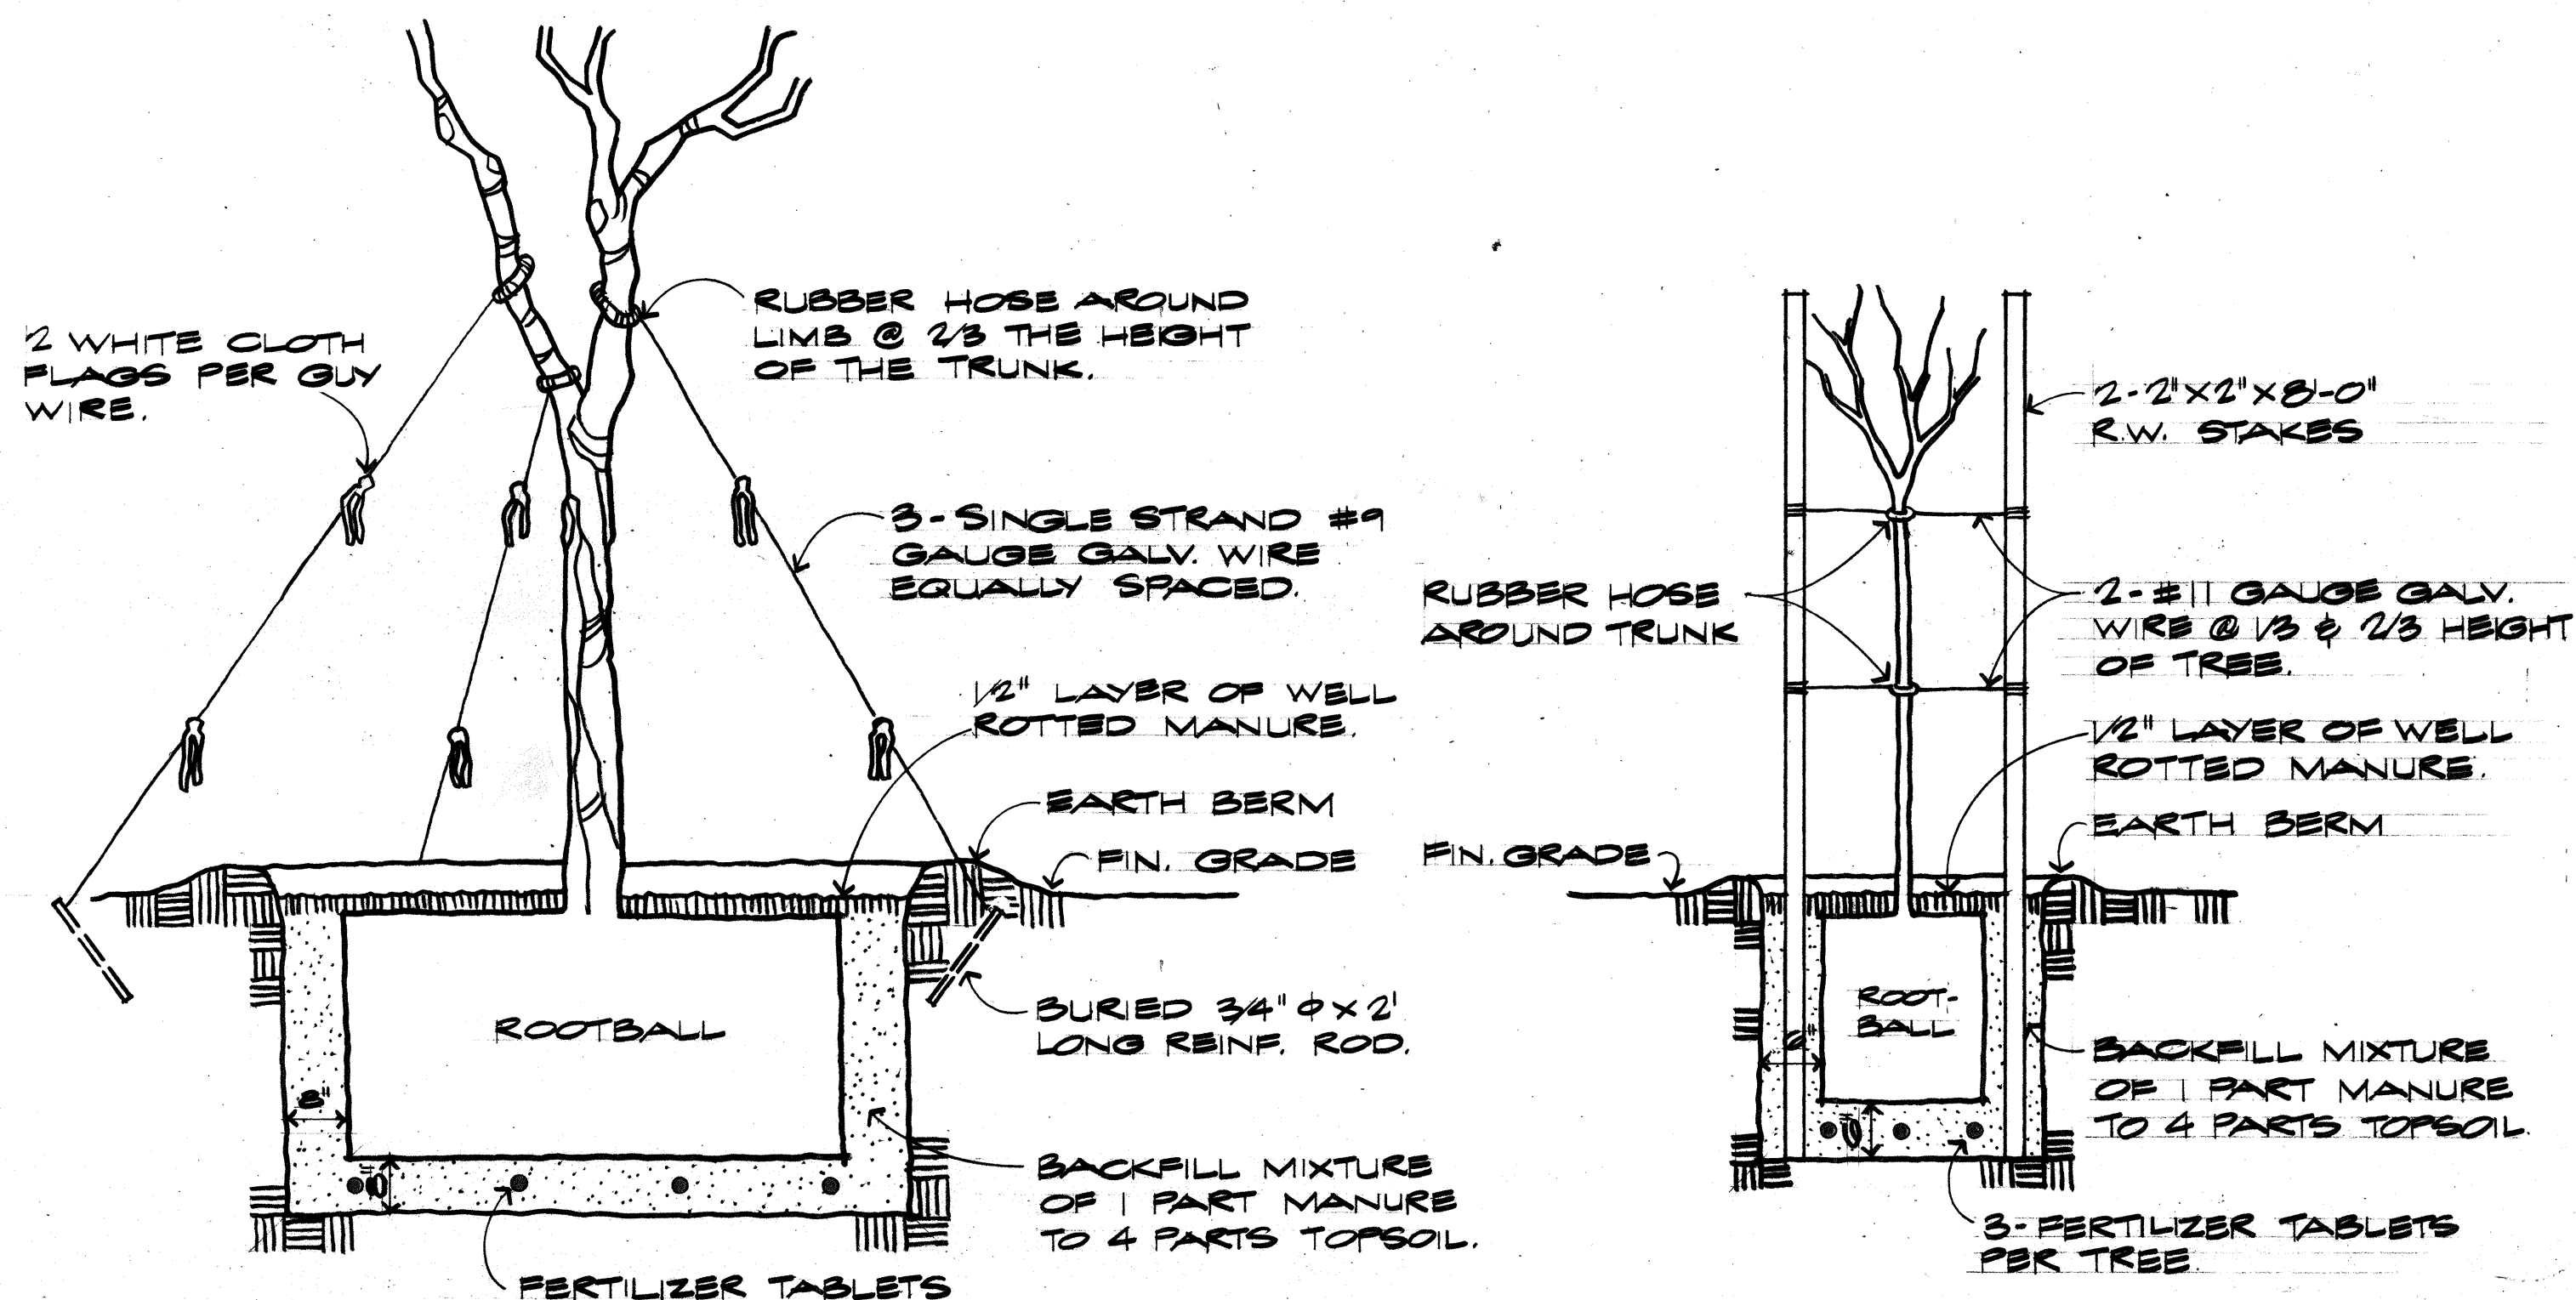


1 TYPICAL STAKING DETAIL
FOR 25 G.C. TREES
NO SCALE

2 TYPICAL STAKING DETAIL
FOR 10 G.C. TREES
NO SCALE

PLANT LIST				
SYMBOL	QUANTITY	BOTANIC AND COMMON NAME	SIZE AND CONDITION	
TREES	38	CASSIA JAVANICA X FISTULA (RAINBOW SHOWER)	25 G.C., 10' HIGH, 6" SPD, 4" CAL.	
	5	DELONIX REGIA (ROYAL POINCIANA)	25 G.C., 10' HIGH, 5" SPD, 5" CAL.	
	12	ERTHRINA CRISTA-GALLI (CORAL)	25 G.C., 8' HIGH, 5" SPD, 5" CAL.	
	136	FICUS BENJAMINA (BENJAMIN BANYAN)	25 G.C., 12' HIGH, 6" SPD, 5" CAL.	
	10	JACARANDA ACUTIFOLIA (JACARANDA)	25 G.C., 10' HIGH, 5" SPD, 4" CAL.	
	45	PTEROCARPUS INDICUS (NARRA)	25 G.C., 12' HIGH, 6" SPD, 4" CAL.	
	99	SPATHODEA CAMPANULATA (AFRICAN TULIP)	25 G.C., 12' HIGH, 4" SPD, 3" CAL.	
SHRUBS	124	THEVETIA NERIFOLIA (BESTILL)	10 G.C., 6' HIGH, 2" SPD, 1 1/2" CAL.	
	153	BOUGAINVILLEA SPECTABILIS VAR. MISS MANILA	5 G.C., 2' HIGH, 2" SPD, @ 3'-0" O.C.	
GRD COVER	136	HIBISCUS ROSA-SINENSIS (RED HIBISCUS)	5 G.C., 3' HIGH, 2" SPD, @ 3'-0" O.C.	
	1452	FICUS PUMILA (CREEPING FIG)	1 G.C., 2' LONG RUNNERS @ 3'-0" O.C.	
	296	PYROSTEGIA IGNEA (FIRECRACKER VINE)	1 G.C., 2' LONG RUNNERS	
LAWN	125	POXANTHA UNGUIS-CATI (CAT'S CLAW VINE)	1 G.C., 2' LONG RUNNERS @ 4'-0" O.C.	
	230,000 S.F. (APPROX)	CYNODON DACTYLON VAR. TIPTON 419 (TIFFWAY)	STOLONS, HYDRO-MULCHED	

NOTES TO THE CONTRACTOR:

- PRIOR TO EXCAVATION, ALL TREE PLANTING LOCATIONS SHALL BE STAKED-OUT BY THE CONTRACTOR FOR APPROVAL BY THE ENGINEER.
- MINIMUM CLEARANCE FROM EDGE OF PAVEMENT LINE SHALL BE 30 FEET FOR TREES AND 15 FEET FOR SHRUBS IN RELATIVELY FLAT TERRAIN. PLANTINGS MAY BE CLOSER THAN THE CLEARANCES MENTIONED ABOVE WHERE THERE ARE SLOPES, BARRIERS, OR DEFLECTORS. DEVIATIONS FROM THIS REQUIREMENT SHALL BE APPROVED BY THE ENGINEER.
- MINIMUM CLEARANCE FROM UNDERGROUND DRAINAGE, UTILITY STRUCTURES, AND WATER MAINS SHALL BE 6 FT. FOR TREES (MEASURED TO TRUNK).
- USE FERTILIZER TABLETS WITH A 20-10-5 ANALYSIS IN ALL PLANTING POCKETS AT THE FOLLOWING RATES:
5 G.C. STOCK 2 TABLETS
10 G.C. STOCK 3 TABLETS
25 G.C. STOCK 1 TABLET/1/2" OF CALIPER
1 G.C. STOCK 1 TABLET
- ALL CUT AREAS INDICATED TO BE HYDRO-MULCHED WITH TIFFWAY STOLONS SHALL BE SCARIFIED TO A DEPTH OF ONE FOOT AND BACKFILLED WITH ONE FOOT OF IMPORTED TOPSOIL. SCARIFICATION OF SLOPES (TOTAL AREA: 63,140 S.F.) SHALL BE CONSIDERED INCIDENTAL TO HYDRO-MULCHING OPERATIONS.
- FILL SLOPES AND ALL OTHER PLANTING AREAS SHALL BE COVERED WITH A 6" LAYER OF TOPSOIL AND HYDRO-MULCHED WITH TIFFWAY AS INDICATED ON THE PLANS AS THE WORK PROGRESSES, UNLESS OTHERWISE DIRECTED BY THE ENGINEER. IN NO CASE SHALL EXPOSED SURFACE BE GREATER THAN 15 FEET IN HEIGHT. NOTE THAT THE HYDRO-MULCHED EROSION CONTROL PLANTING WILL ALSO BE THE FINAL PLANTING.
- FOR SPACINGS BETWEEN TREE POCKETS ON CUT SLOPES REFER TO SPRINKLER PLANS - SHEET L-6 AND L-7.

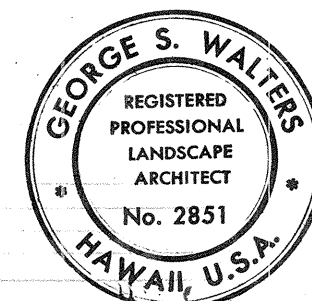

STATE OF HAWAII
DEPARTMENT OF TRANSPORTATION
HIGHWAYS DIVISION


LANDSCAPE DETAILS
PACKAGE NO. 2

PEARL HARBOR INTERCHANGE
F.A.I. PROJ. NO. I-HI-1 (111) : 14

SCALE : NONE DATE : DEC. 14, 1973

SHEET NO. L-3 OF 13 SHEETS

THIS WORK WAS PREPARED BY ME
OR UNDER MY SUPERVISION

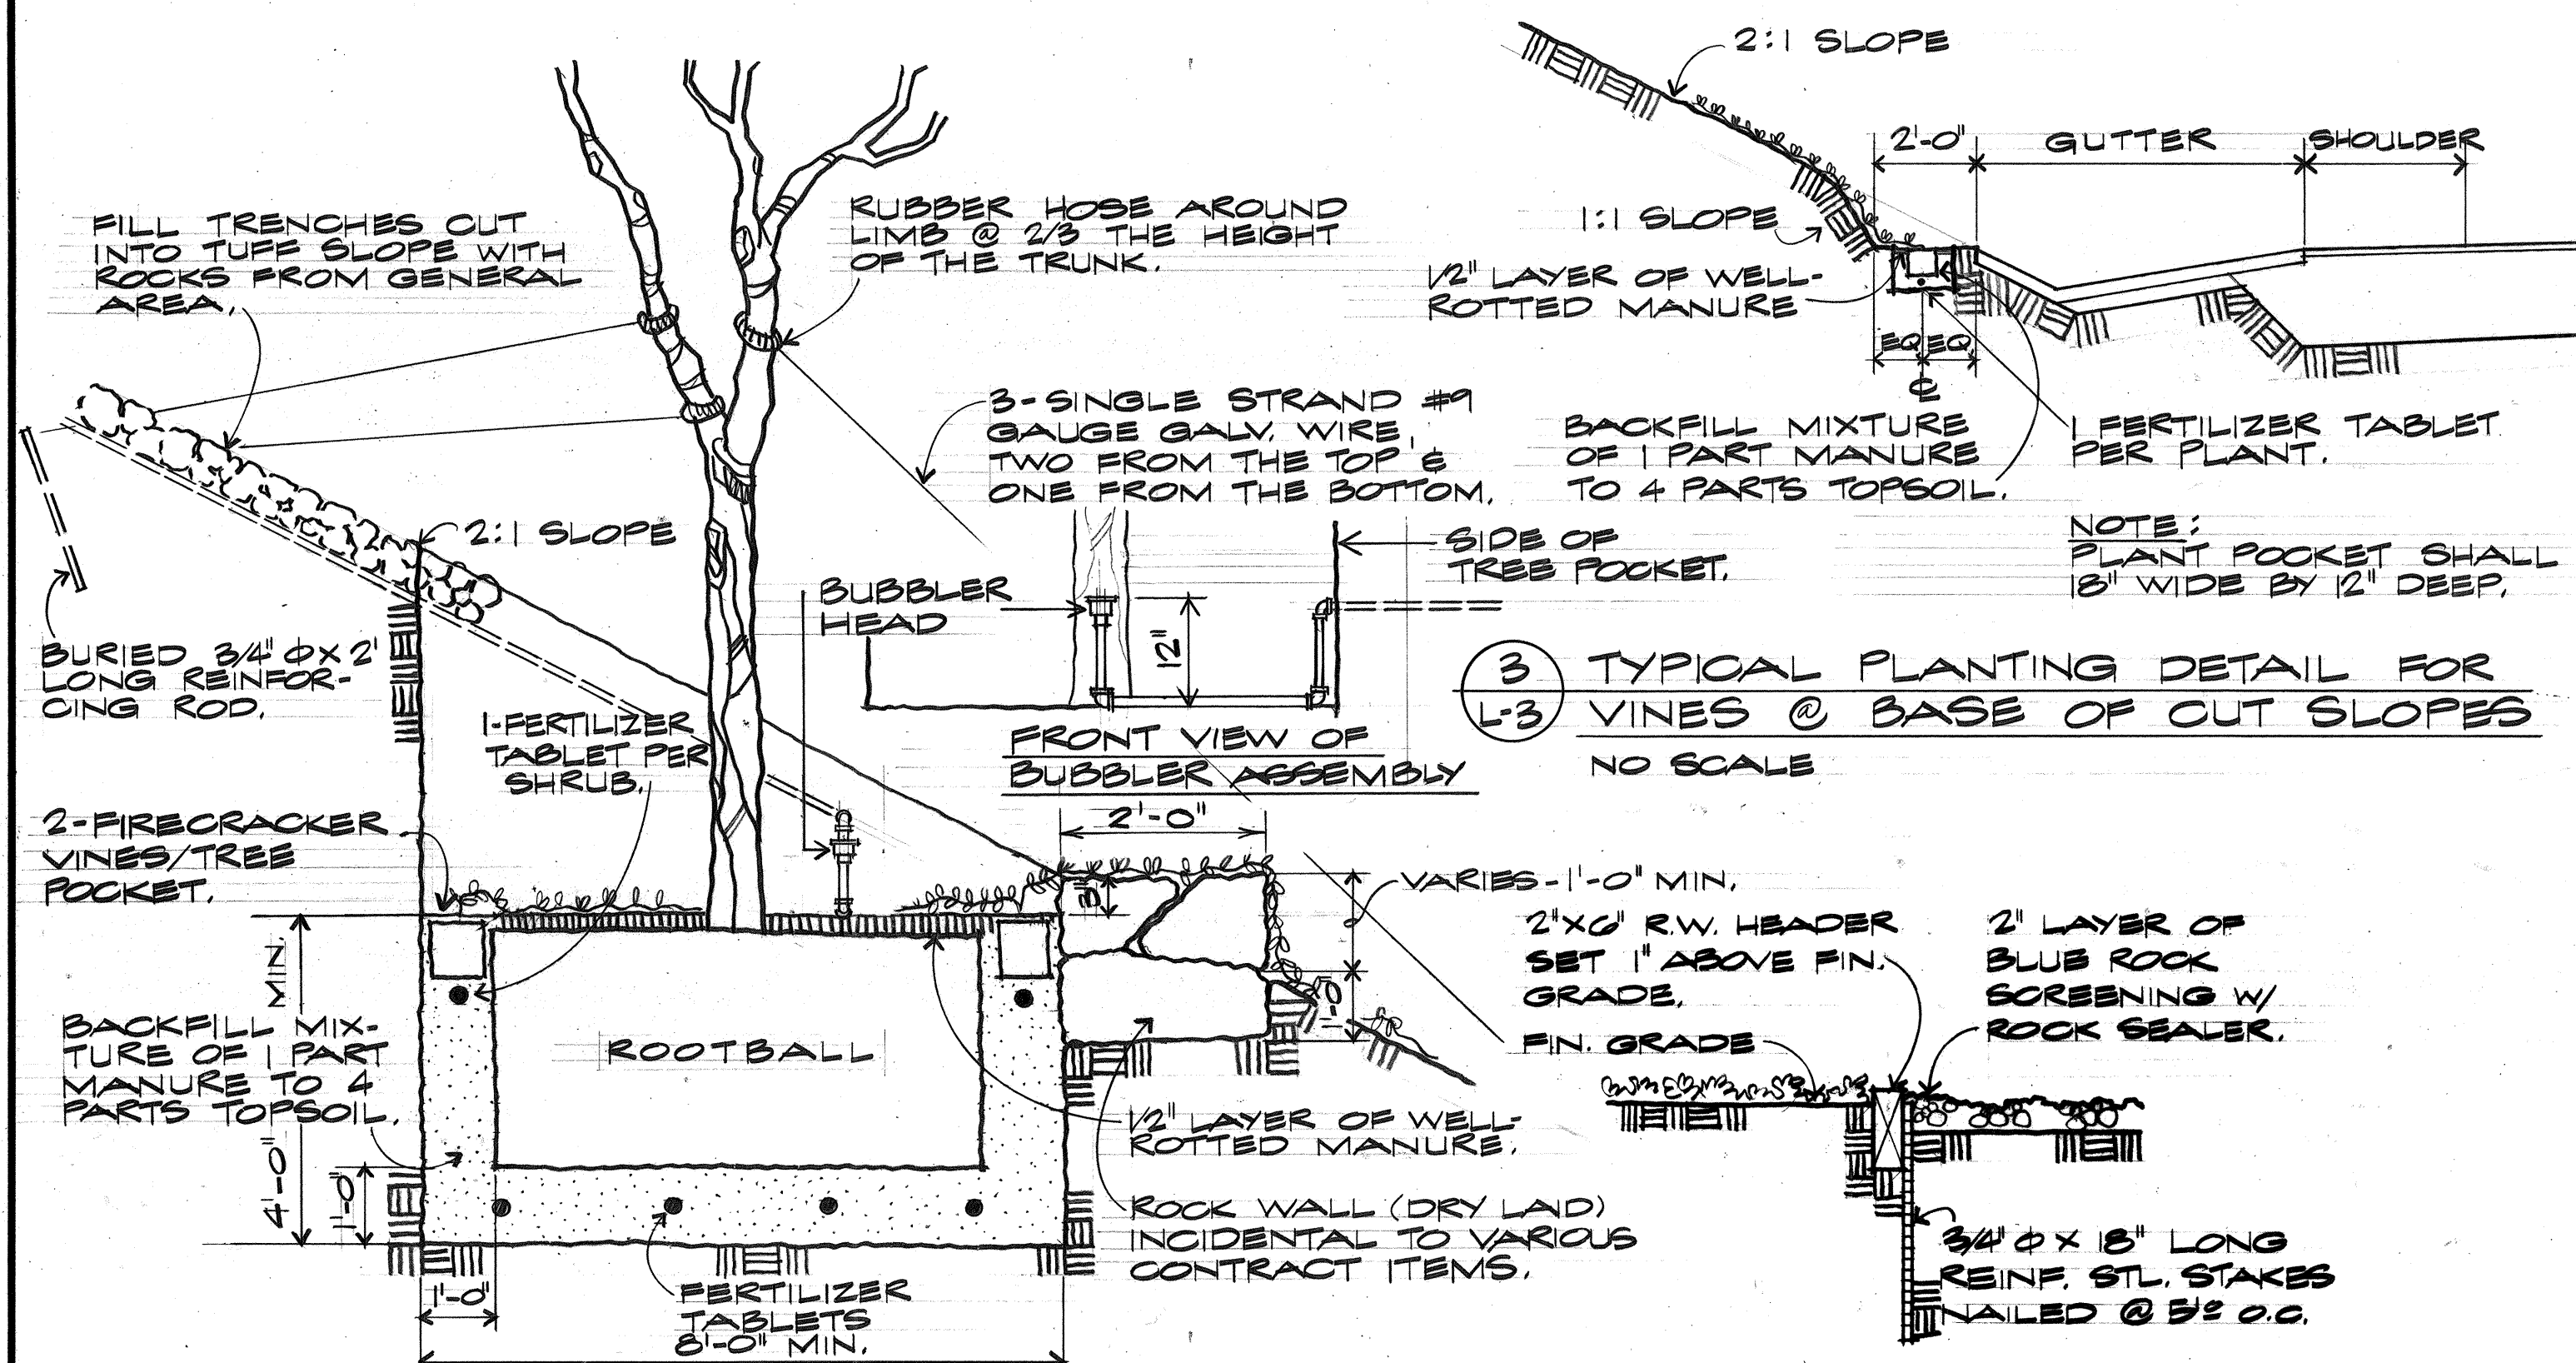

4 TYPICAL STAKING DETAIL FOR TREE
POCKETS IN TUFF-OUT SLOPES
NO SCALE

5 REDWOOD HEADER DETAIL
NO SCALE

6 TYPICAL SHRUB PLANTING DETAIL
IN PLANTER WALLS
(SEE SHEET L-1 FOR DETAIL)

DATE	_____
ORIGINAL PLAN	_____
DRAWN BY	_____
DESIGNED BY	_____
NOTED BY	_____
CHECKED BY	_____